


INDEX TO DRAWINGS	
SHEET NO.	DESCRIPTION
1	TITLE SHEET
2-4	BORING PLAN
5	CONSTRUCTION PHASING
6-7	TYPICAL SECTION
8-15	PLAN AND PROFILE
16-17	SUPERELEVATION DIAGRAMS
18-20	INTERSECTION DETAILS
21-37	STANDARD DETAILS
38-40	GRADING AND DRAINAGE PLAN
41-43	DRAINAGE PROFILE
44-47	DRAINAGE SUMMARY
48-66	DRAINAGE DETAILS
67-70	CIVIL UTILITY RELOCATION PLANS
71-72	CIVIL UTILITY RELOCATION PROFILE
73-74	CIVIL UTILITY RELOCATION DETAILS
75	TRAFFIC DETOUR
76-78	SIGNING AND PAVEMENT MARKING PLAN
79-80	TRAFFIC SIGNAL SYSTEM
81-83	PANEL AND FRAME LAYOUT
84-97	SIGNING DETAILS
98-100	LANDSCAPE PLANS
101-114	SPRINKLER SYSTEM
115-118	UTILITY RELOCATION PLAN
119-122	ELECTRICAL PLAN
123-154	ELECTRICAL DETAIL
155-171	STRUCTURE NO. 1
172-188	STRUCTURE DETAILS
189-190	RETAINING WALL NO. 9 PLAN AND PROFILE
191-192	RETAINING WALL DETAILS
193	INDEX TO CROSS SECTIONS
194-211	CROSS SECTIONS
212-234	PLANS FOR AREA "Z"

SUPPLEMENTARY SHEETS TO THIS PROJECT ARE SHEET NOS
(d) C.O. 12 S-1 & C.O. 15 S-1
(e) C.O. 23 S-1
(f) 55 S-1 & 55 S-2

DD-B-2-4
SLTH, INC. 12/21/73
548-582
DESIGNED BY P. S. & E. BY
DATE
PHONE
BY

TOTAL SHEET COUNT AFTER
"AS-BUILT" POSTINGS: 253 SHEETS

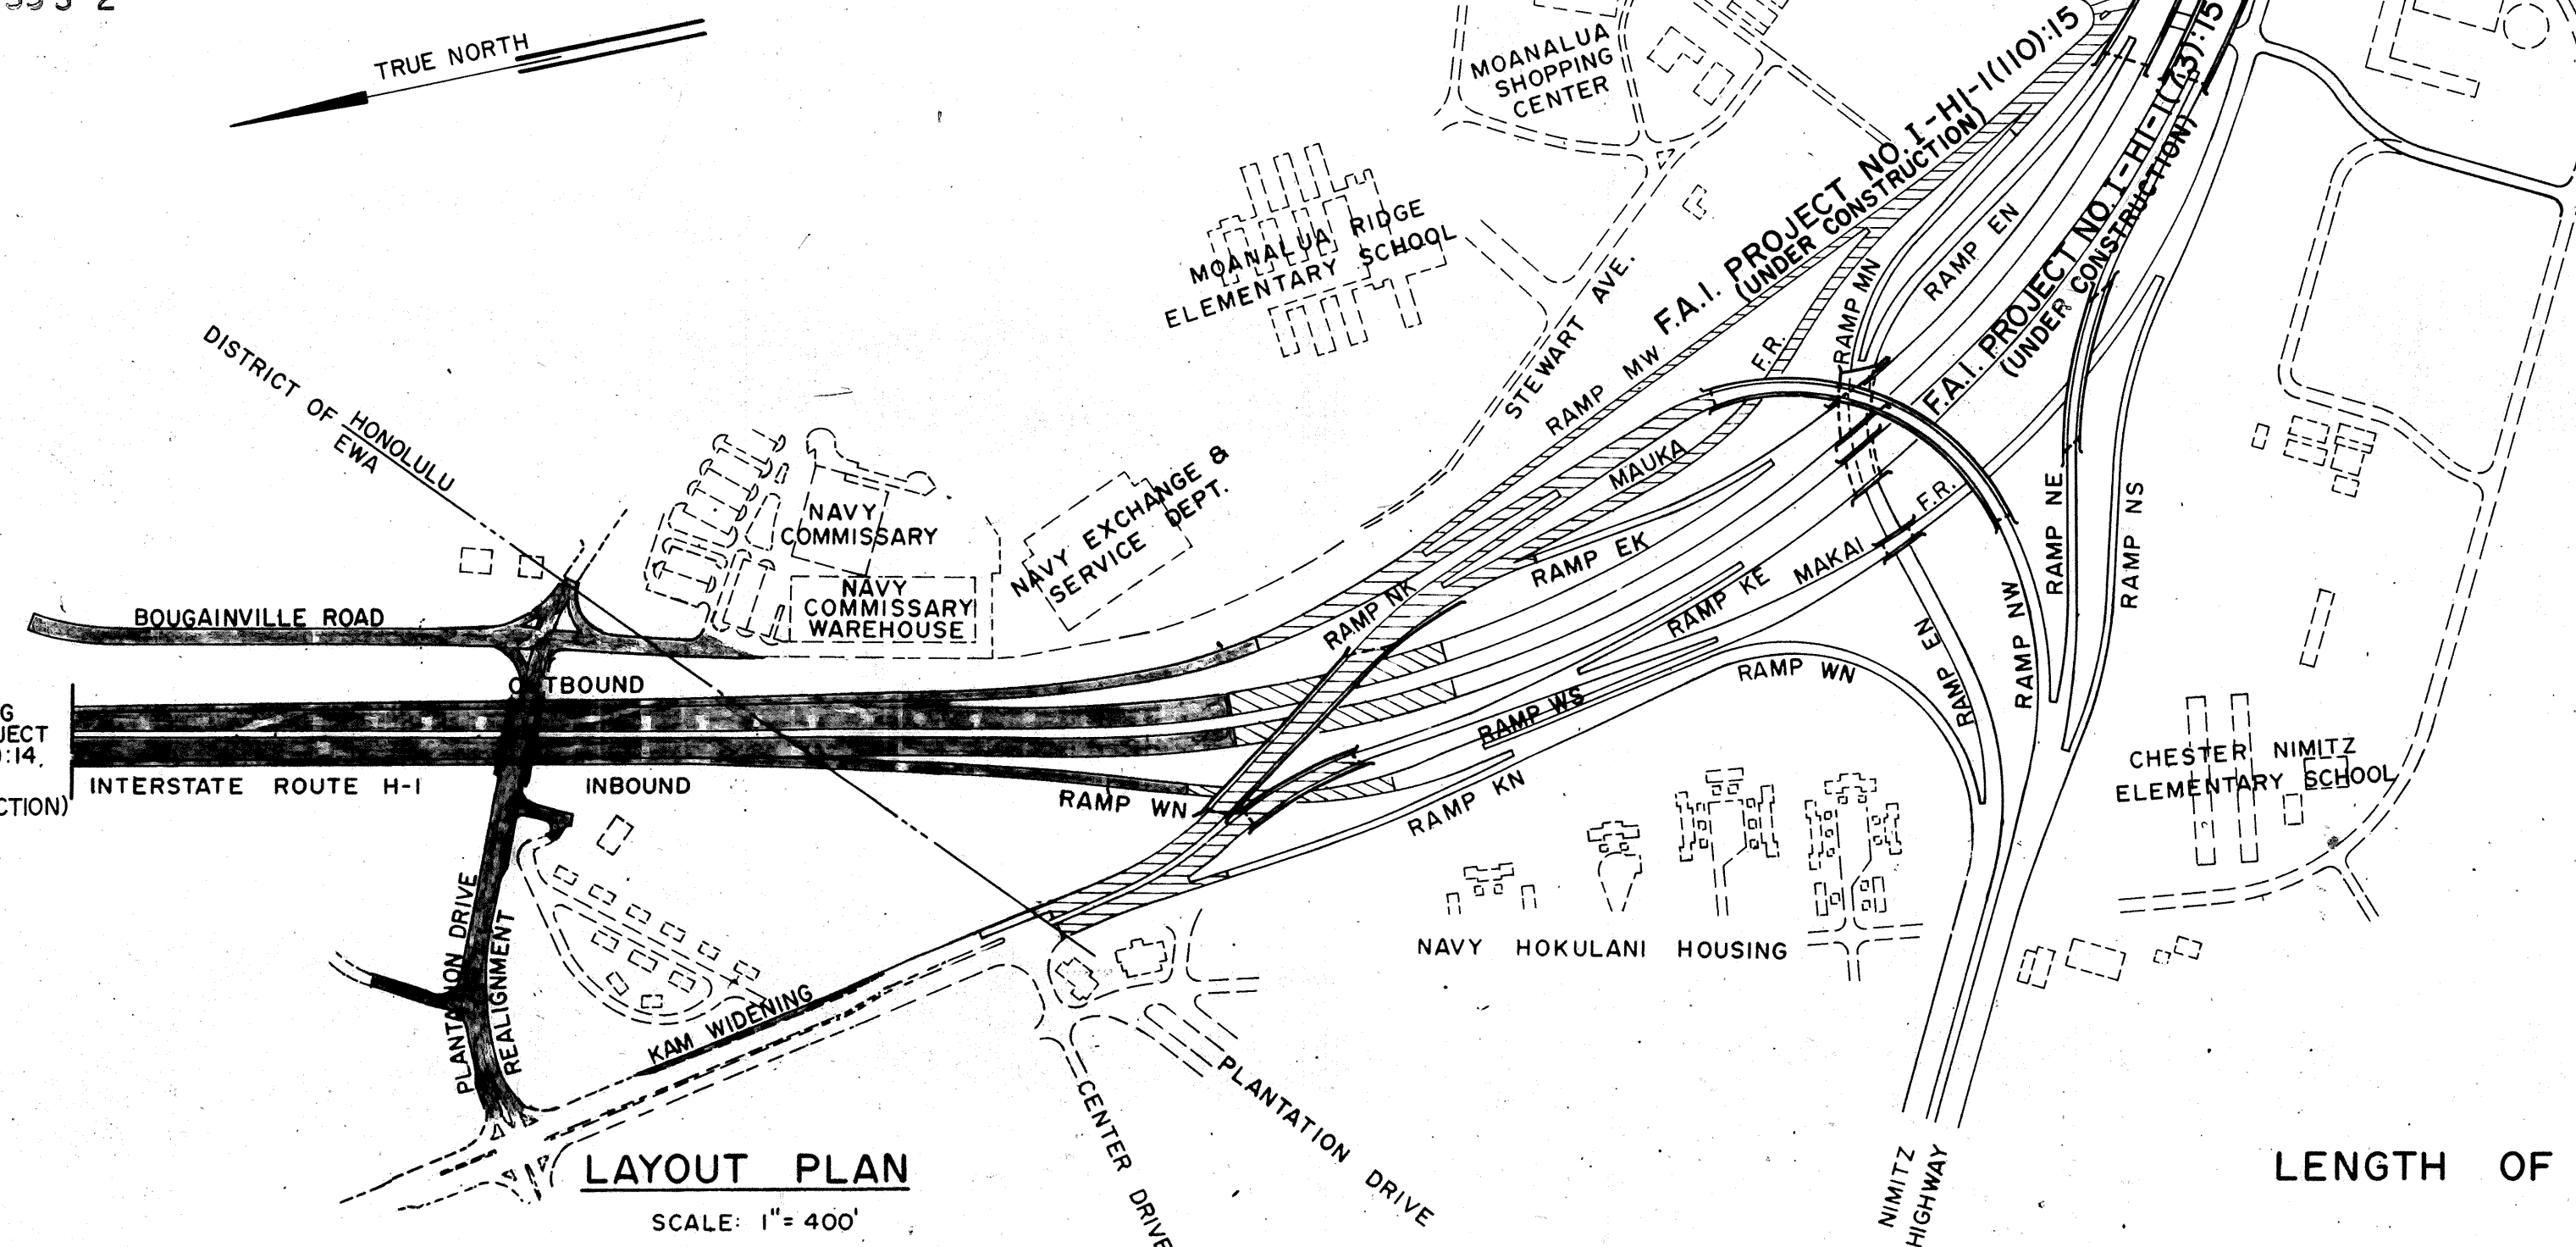


LAYOUT PLAN
SCALE: 1" = 400'

LENGTH OF PROJECT 0.53 MILE

STATE OF HAWAII
DEPARTMENT OF TRANSPORTATION
HIGHWAYS DIVISION
HONOLULU, HAWAII
"AS BUILT"
PLANS FOR
CONSTRUCTION OF A PORTION OF
INTERSTATE ROUTE H-1
PEARL HARBOR INTERCHANGE

FEDERAL AID INTERSTATE PROJECT NO. I-HI-I(III):14

DISTRICTS OF EWA & HONOLULU
ISLAND OF OAHU

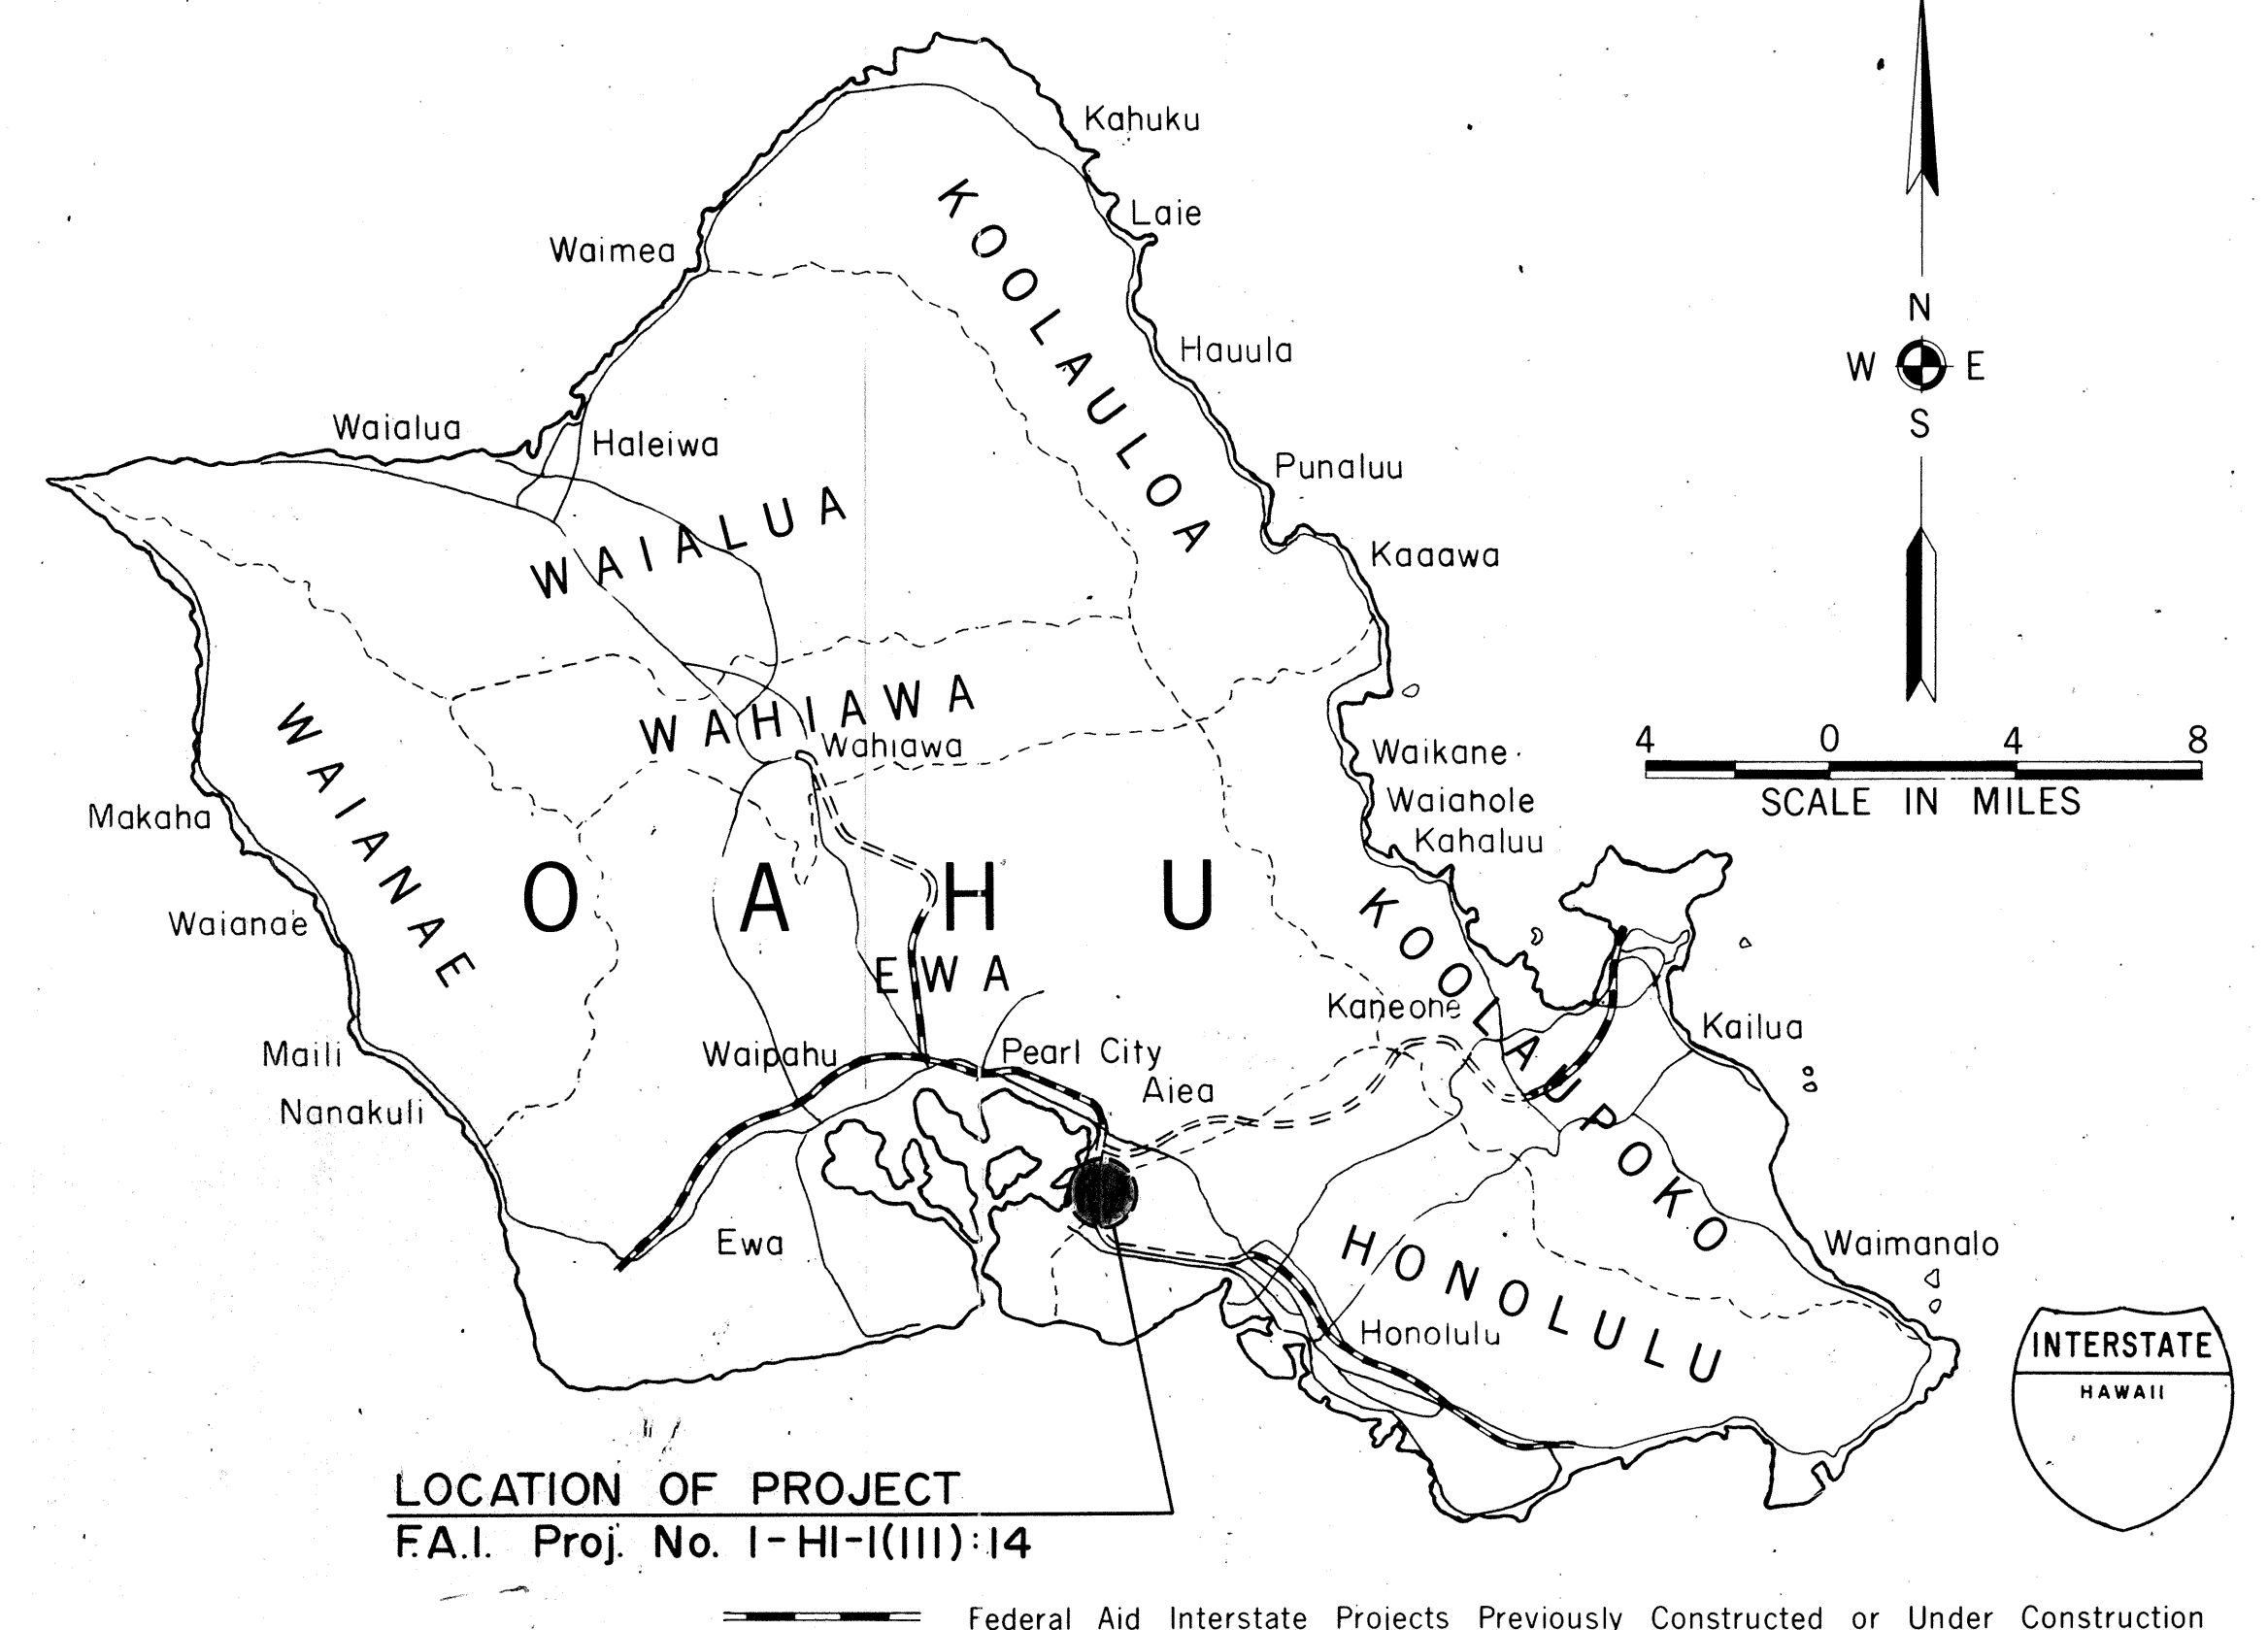

SCALES:

PLANS	HOR.	1" = 50'
PROFILES	HOR.	1" = 50'
	VER.	1" = 10'
DETAIL ROADWAY PLANS	HOR.	1" = 20'
CROSS SECTIONS	HOR.	1" = 10'
	VER.	1" = 10'
CROSS SECTIONS	HOR.	1" = 20'
	VER.	1" = 20'

NOTE:

ALL CHANGES MADE DURING CONSTRUCTION HAVE BEEN INCORPORATED ON THESE PLANS IN RED EXCEPT CHANGES IN THE ORIGINAL THEORETICAL QUANTITIES. FOR ACTUAL QUANTITIES, REFER TO PROJECT LEDGER AND/OR COMPUTATION BOOK.

PROJECT ENGINEER
6/25/80
DATE

DEPARTMENT OF TRANSPORTATION
FEDERAL HIGHWAY ADMINISTRATION
APPROVED:
DIVISION ENGINEER
DATE

DESIGN DESIGNATION

CURRENT ADT (1973)	32,800
DESIGN ADT (1994)	74,200
DHV	8,220
D	80/20
T	5 %
V	60 MPH
CONTROL OF ACCESS	FULL

DEPARTMENT OF TRANSPORTATION
STATE OF HAWAII
APPROVED:
FOR DIR. OF TRANSPORTATION
DATE