
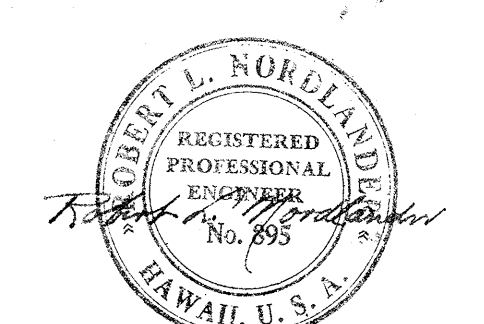


FED. ROAD DIST. NO.	STATE	FED. AID PROJ. NO.	FISCAL YEAR	SHEET NO.	TOTAL SHEETS
15-0720(3)	HAWAII	UNIT 3	1960	62	79
BU-072-1(2)		UNIT 4	1960	90	118
BU-065-1(1)		UNIT 5	1960	84	115

ORIGINAL PLAN	DATE	DESIGNED BY	TRACED BY	QUANTITIES BY	CHECKED BY	NOTED BY
	3.27	W. Collins	W. Collins	W. Collins	W. Collins	W. Collins
	3.27					
	3.27					
	3.27					

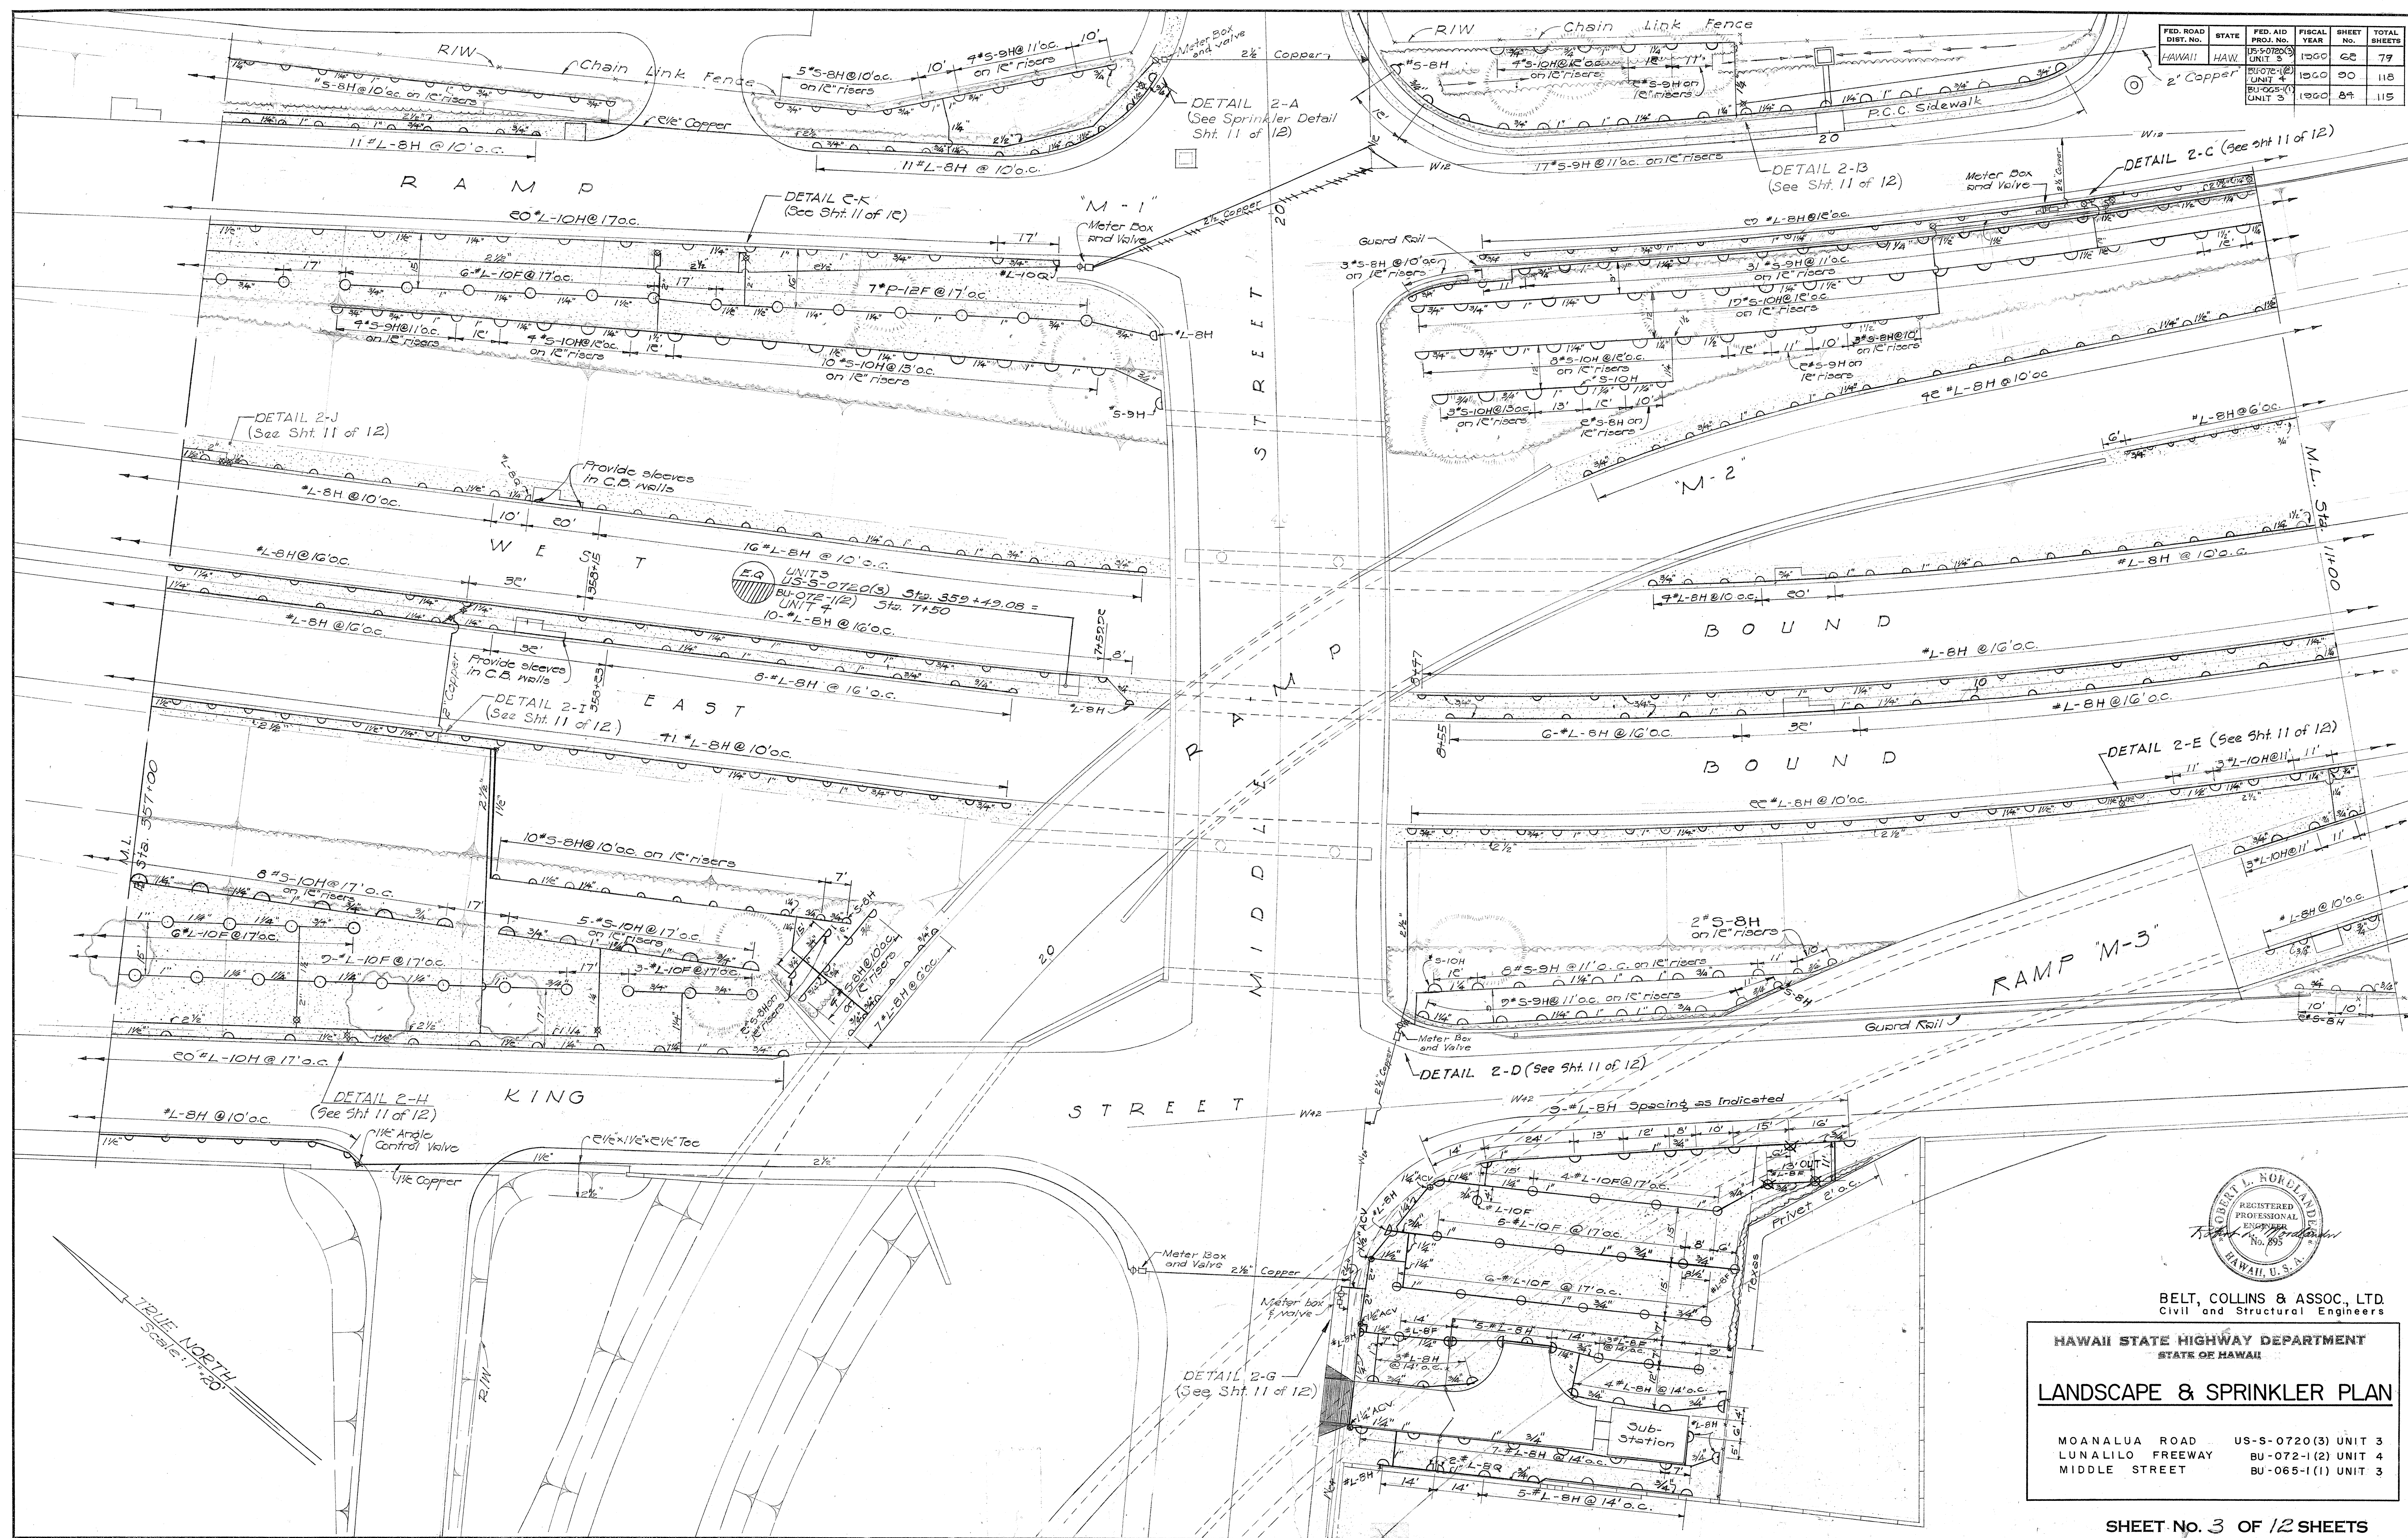

BELT, COLLINS & ASSOC., LTD.
Civil and Structural Engineers

HAWAII STATE HIGHWAY DEPARTMENT
STATE OF HAWAII


LANDSCAPE & SPRINKLER PLAN

MOANALUA ROAD US-S-0720(3) UNIT 3
LUNALILO FREEWAY BU-072-1(2) UNIT 4
MIDDLE STREET BU-065-1(1) UNIT 5

SHEET No. 3 OF 12 SHEETS

\$526.62 \$174.90 \$161.84 130

FED. ROAD DIST. NO.	STATE	FED. AID PROJ. NO.	FISCAL YEAR	SHEET NO.	TOTAL SHEETS
100	HAWAII	BU-072-1(2)	1960	91	118
		BU-065-1(1)	1960	85	115

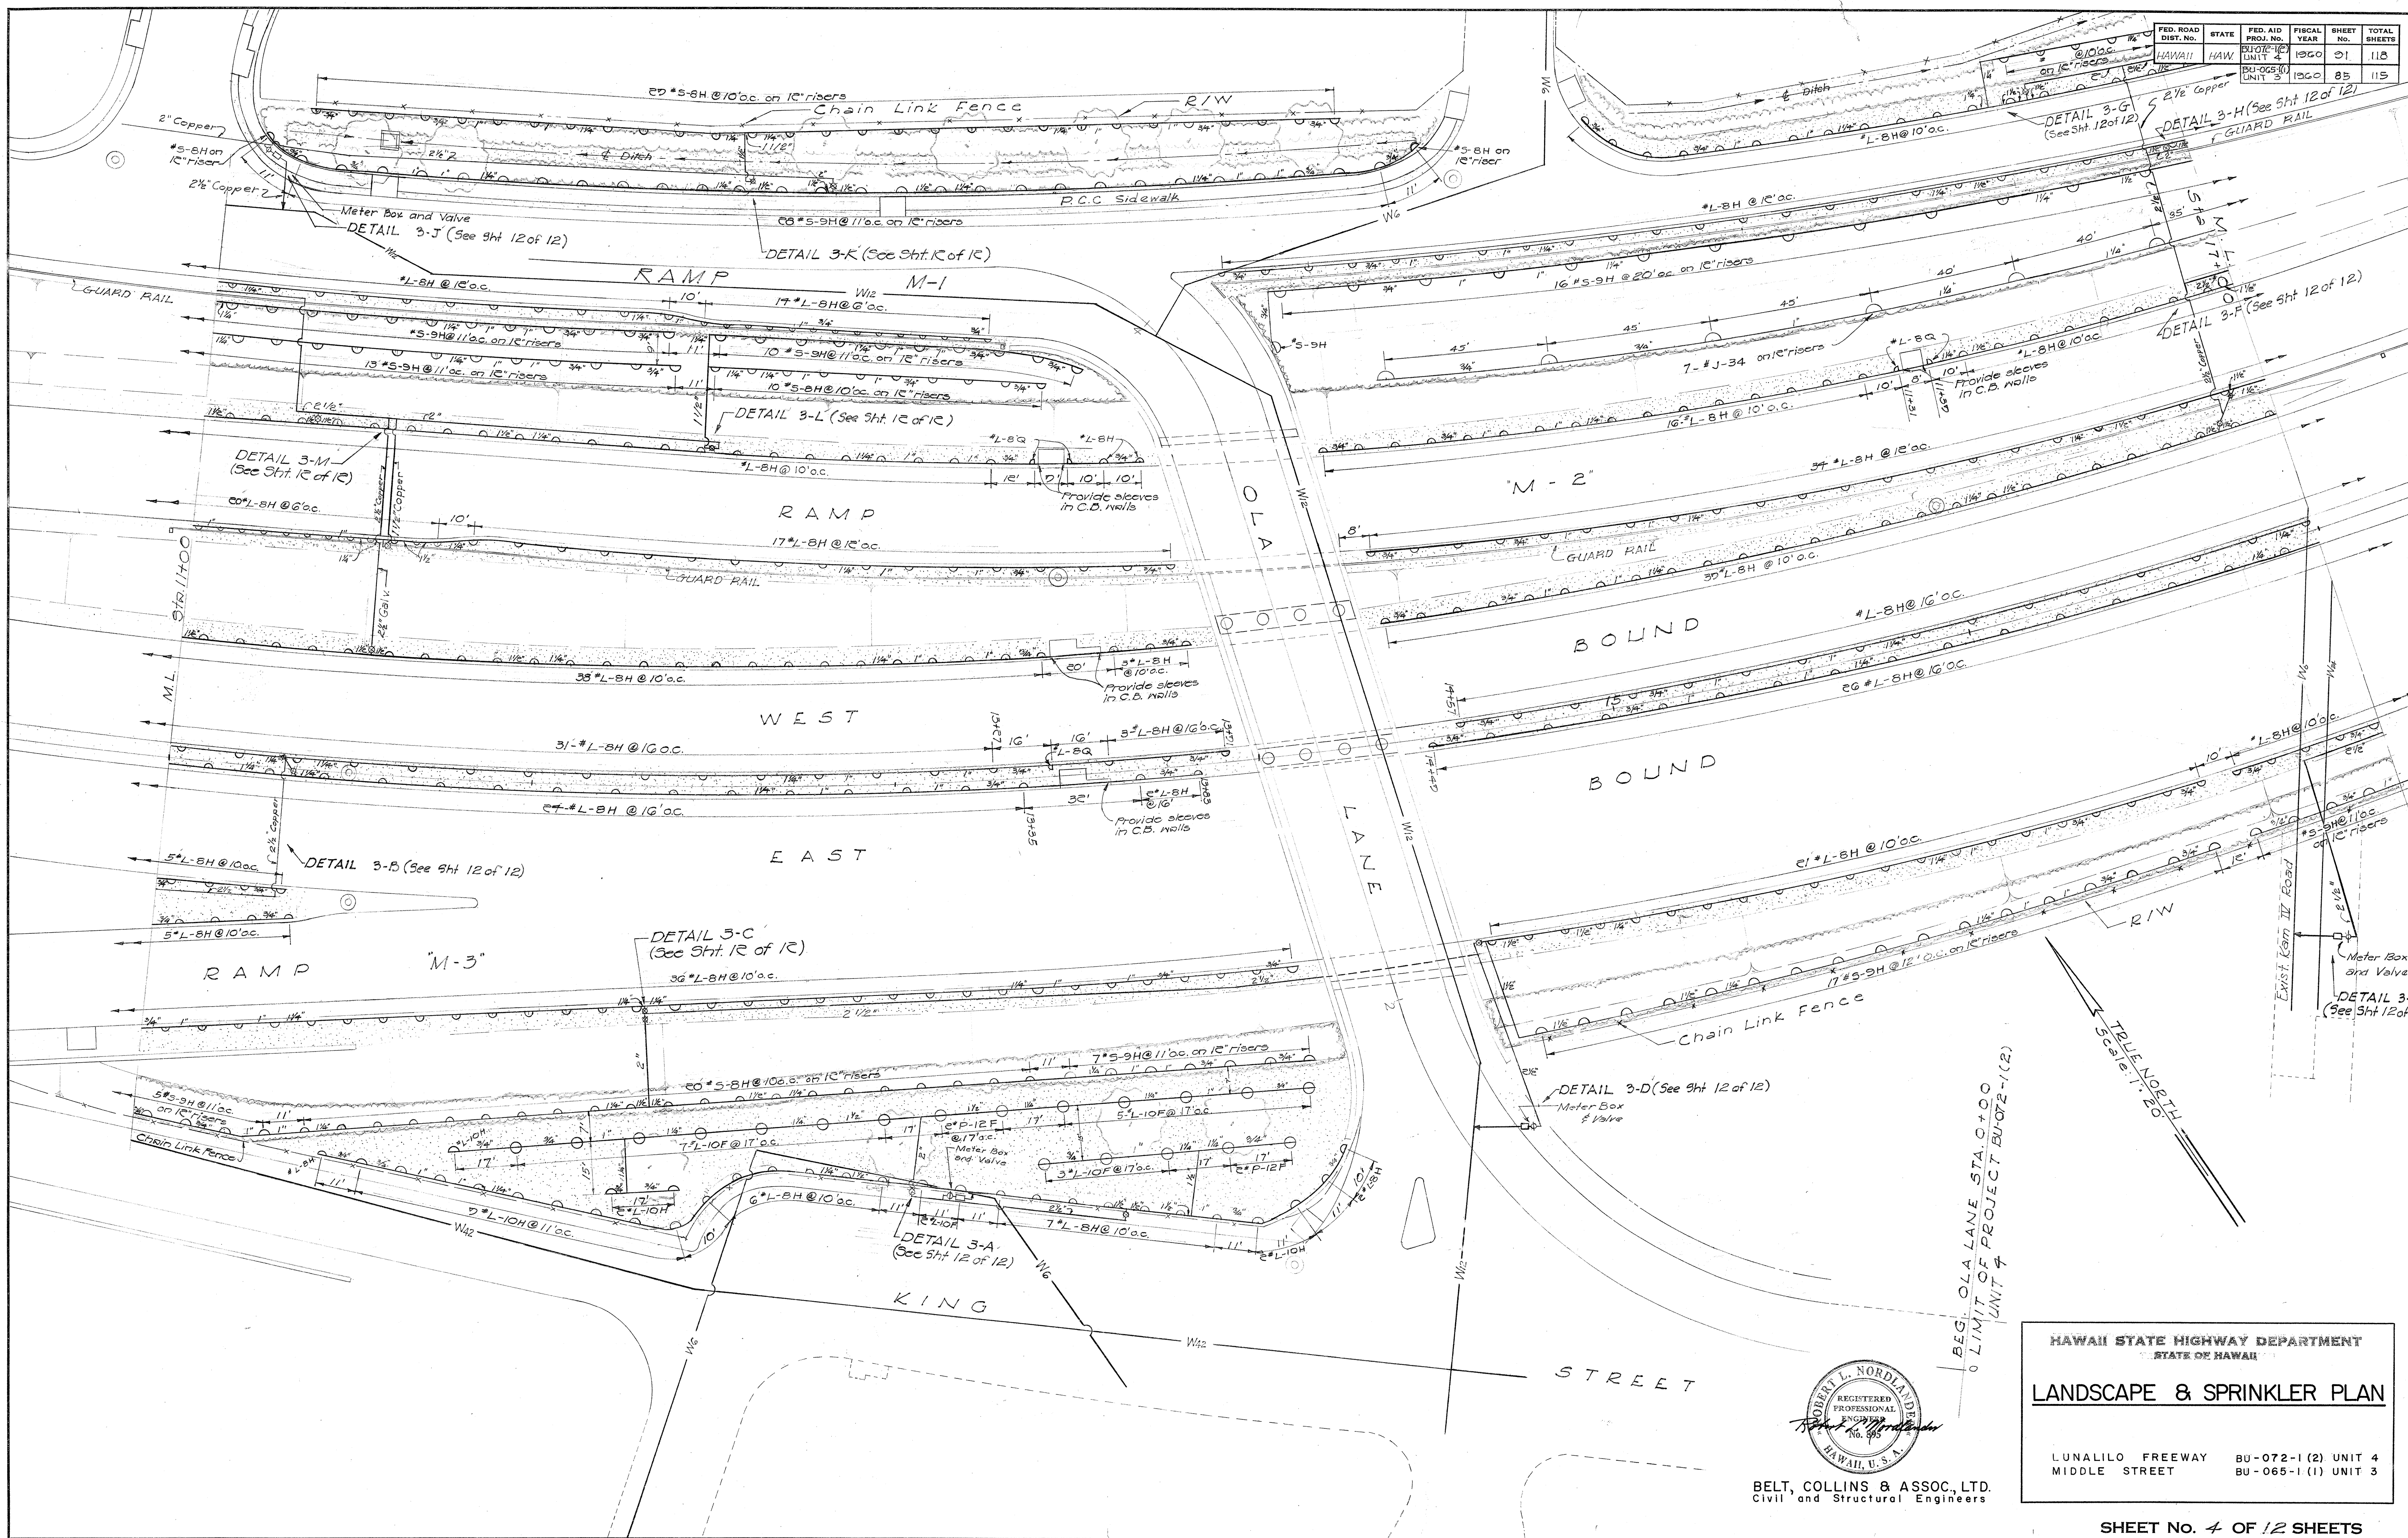

SURVEY PLOTTED BY	DATE
DRAWN BY	5-57
TRACED BY	5-57
QUANTITIES CHECKED BY	5-57
CHECKED BY	5-57



BELT, COLLINS & ASSOC., LTD.
Civil and Structural Engineers

HAWAII STATE HIGHWAY DEPARTMENT
STATE OF HAWAII


LANDSCAPE & SPRINKLER PLAN

LUNALILO FREEWAY BU-072-1(2) UNIT 4
MIDDLE STREET BU-065-1(1) UNIT 3


SHEET NO. 4 OF 12 SHEETS

\$174.91 \$161.85 131

FED. ROAD DIST. NO.	STATE	FED. AID PROJ. NO.	FISCAL YEAR	SHEET NO.	TOTAL SHEETS
HAWAII	HAW.	BU-072-1(2)	1960	92	118
		BU-065-1(1)	1960	86	115

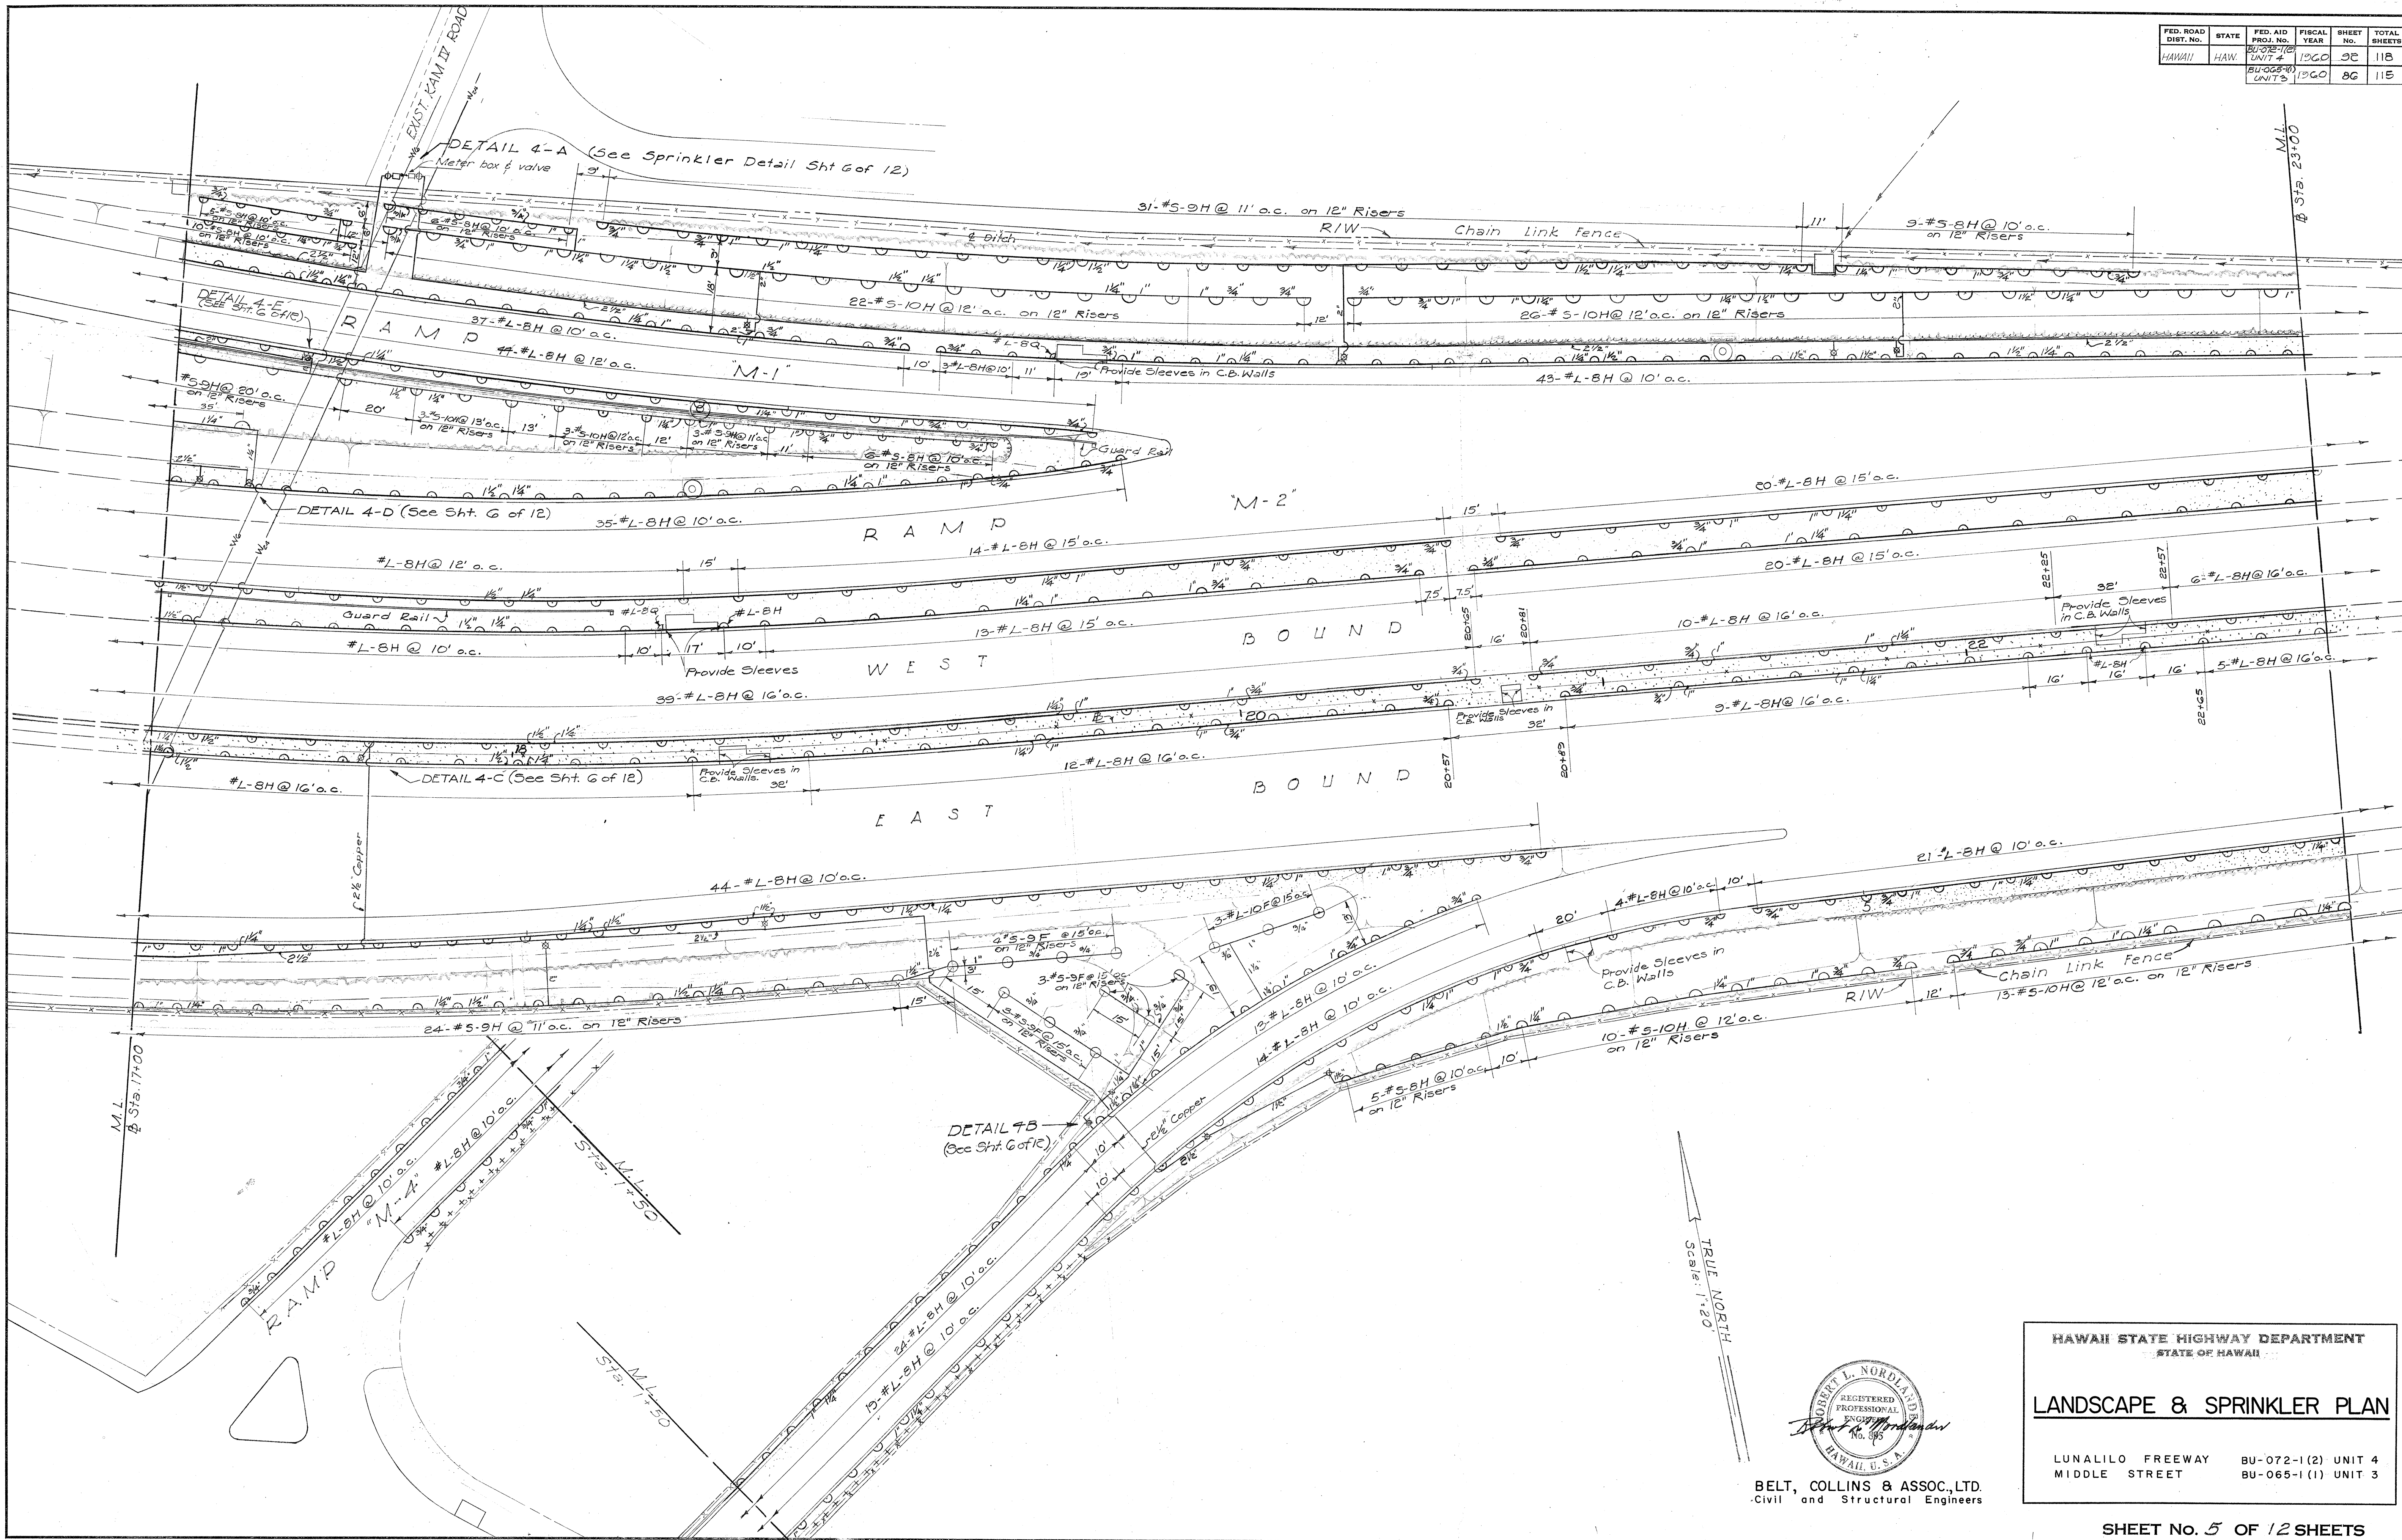

DESIGNED BY	DATE
TRACED BY	
QUANTITIES BY	
CHECKED BY	
ORIGINAL PLAN	
NOTE BOOK	
No.	

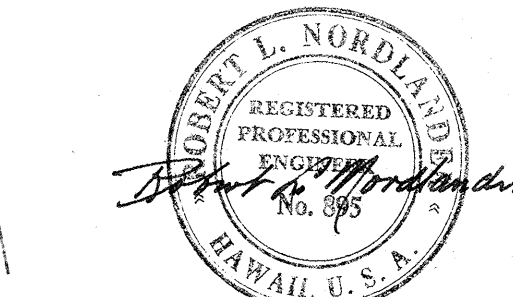

BELT, COLLINS & ASSOC., LTD.
Civil and Structural Engineers

HAWAII STATE HIGHWAY DEPARTMENT
STATE OF HAWAII

LANDSCAPE & SPRINKLER PLAN


LUNALILO FREEWAY
MIDDLE STREET

BU-072-1(2) UNIT 4
BU-065-1(1) UNIT 3


SHEET No. 5 OF 12 SHEETS

8174.92 8161.86 132

FED. ROAD DIST. NO.	STATE	FED. AID PROJ. NO.	FISCAL YEAR	SHEET NO.	TOTAL SHEETS
HAWAII	HAW.	BU-072-1(2)	1960	93	118
		UNIT 4			
		BU-065-1(1)	1960	87	115

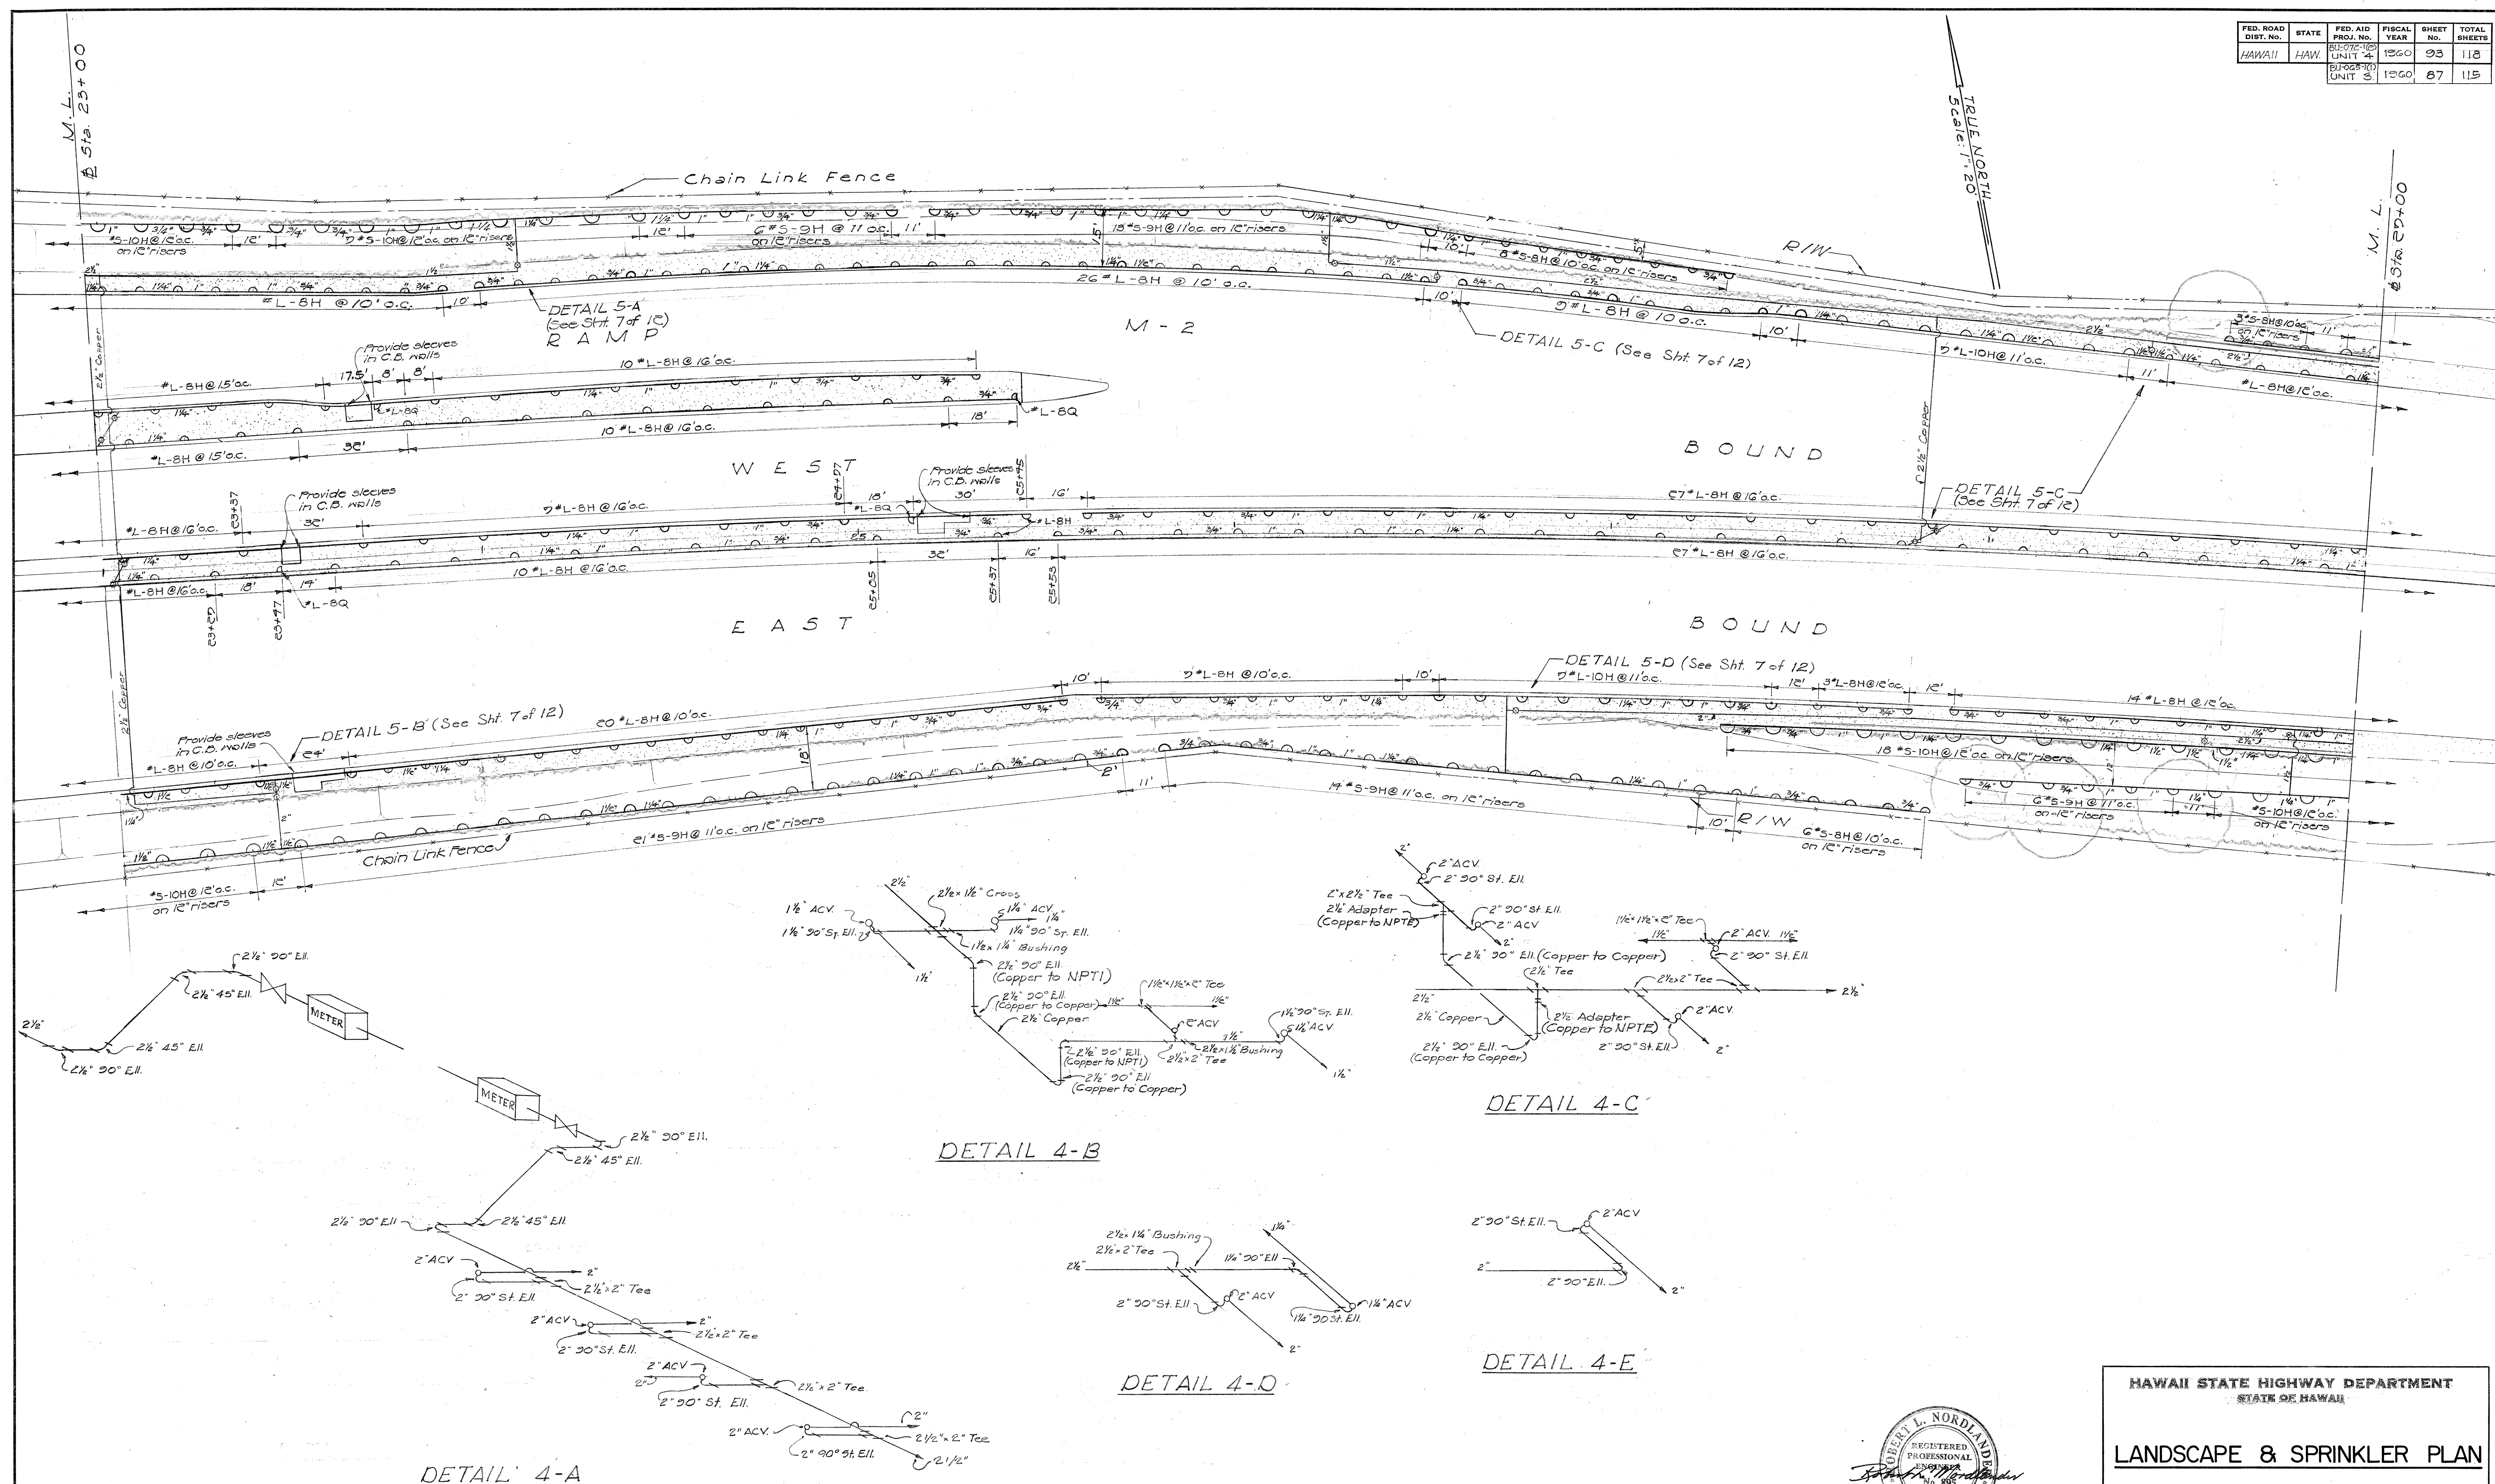

DATE	DESIGNED BY	TRACED BY	QUANTITIES BY	CHECKED BY
8-27	P. Wanda	P. Wanda	P. Wanda	P. Wanda
8-27				
8-27				
8-27				

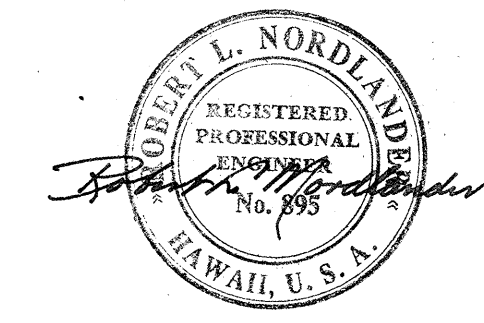

BELT, COLLINS & ASSOC. LTD.
Civil and Structural Engineers


HAWAII STATE HIGHWAY DEPARTMENT
STATE OF HAWAII

LANDSCAPE & SPRINKLER PLAN

LUNALILO FREEWAY BU-072-1(2) UNIT 4
MIDDLE STREET BU-065-1(1) UNIT 3


SHEET NO. 6 OF 12 SHEETS

FED. ROAD DIST. No.	STATE	FED. AID PROJ. No.	FISCAL YEAR	SHEET No.	TOT SHE
HAWAII	HAW.	BU-072-1(2) UNIT 4	1960	94	112
		BU-065-1(1) UNIT 2	1960	88	111

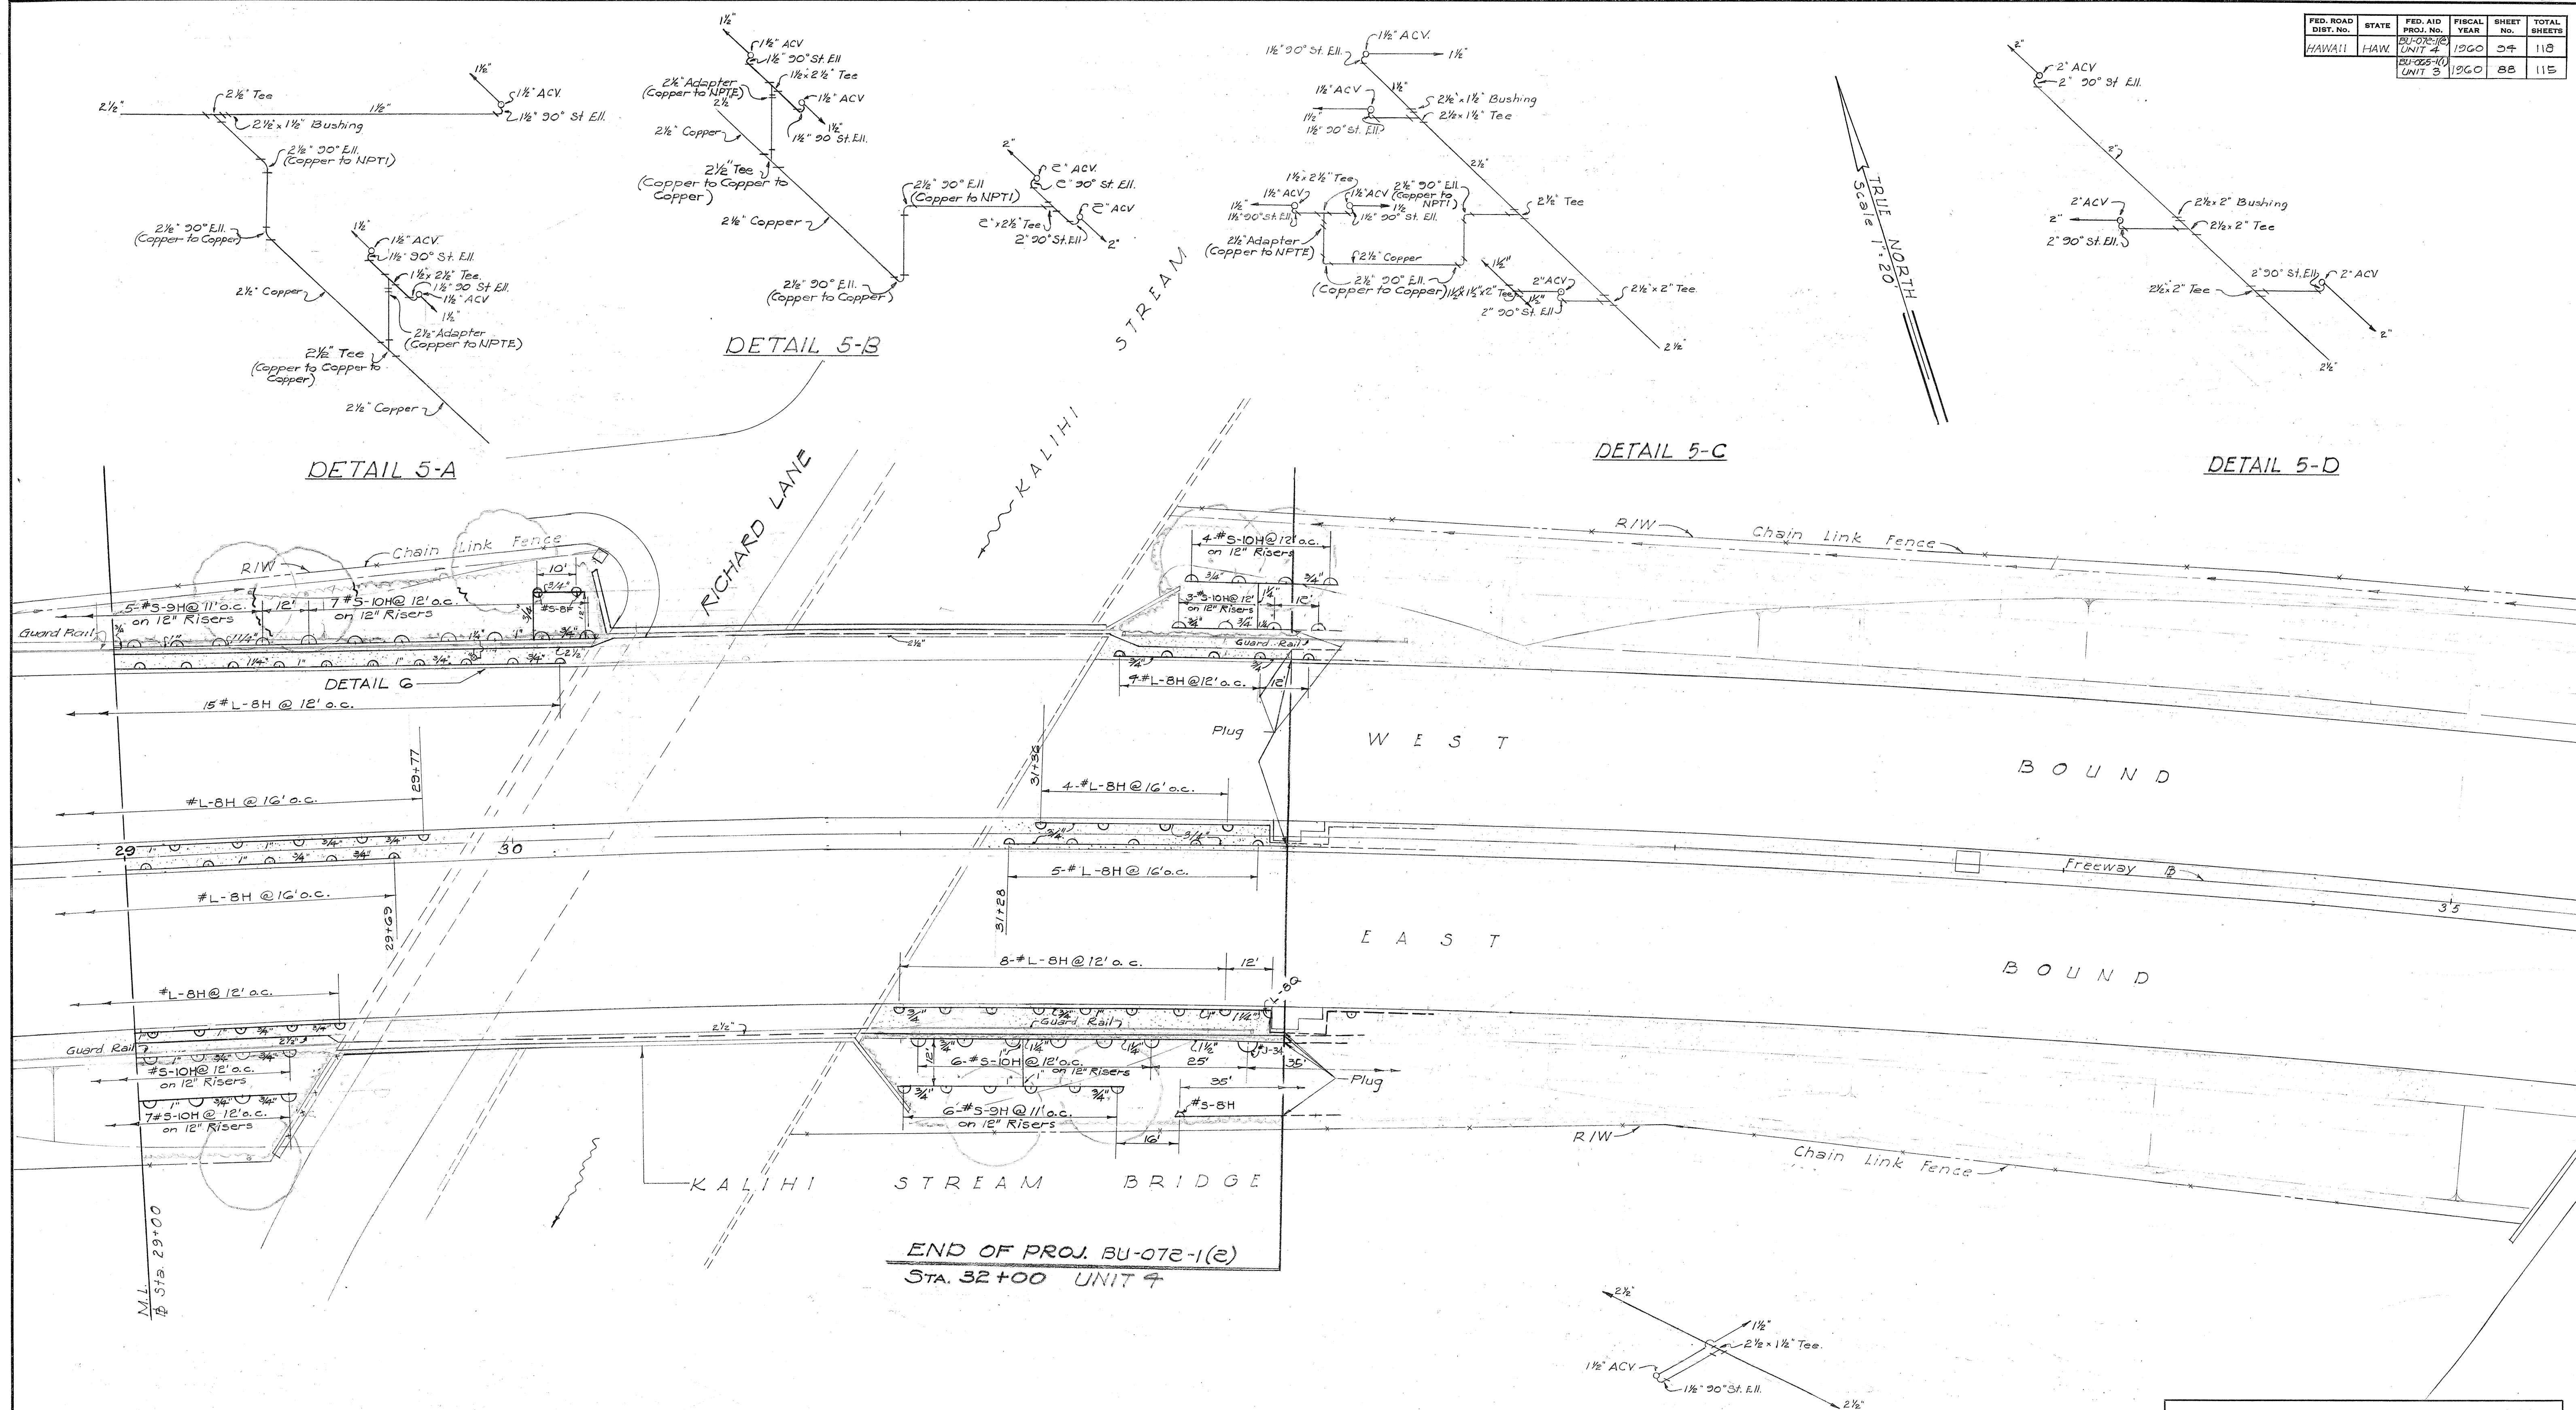

ORIGINAL	SURVEY PLOTTED BY	DATE
PLAN	DRAWN BY <i>P. Hirsch</i>	" 3-57
	DESIGNED BY <i>C. Malmgren</i>	" 3-57
NOTE BOOK	TRACED BY	" 3-57
	QUANTITIES BY <i>Hirsch</i>	" 3-57
No.	QUANTITIES CHECKED BY	" 3-57
	CHECKED BY <i>B. Trauch</i>	" 3-57

DETAIL 6

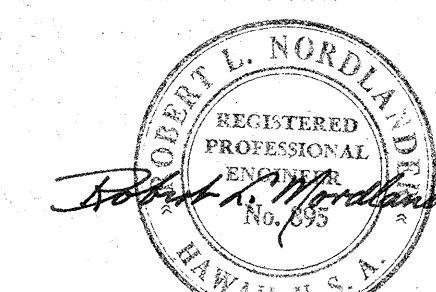

BELT, COLLINS & ASSOC., LTD
Civil and Structural Engineers

HAWAII STATE HIGHWAY DEPARTMENT
STATE OF HAWAII

LANDSCAPE & SPRINKLER PLAN

LUNALILO FREEWAY BU-072-1 (2) UNIT 4
MIDDLE STREET BU-065-1 (1) UNIT 3


SHEET No. 7 OF 12 SHEETS

\$174.94


\$161.55

134


FED. ROAD DIST. No.	STATE	FED. AID PROJ. No.	FISCAL YEAR	SHEET No.	TOTAL SHEETS
HAWAII	HAW.	BU-065-1(1) UNIT 3	1960	87	115

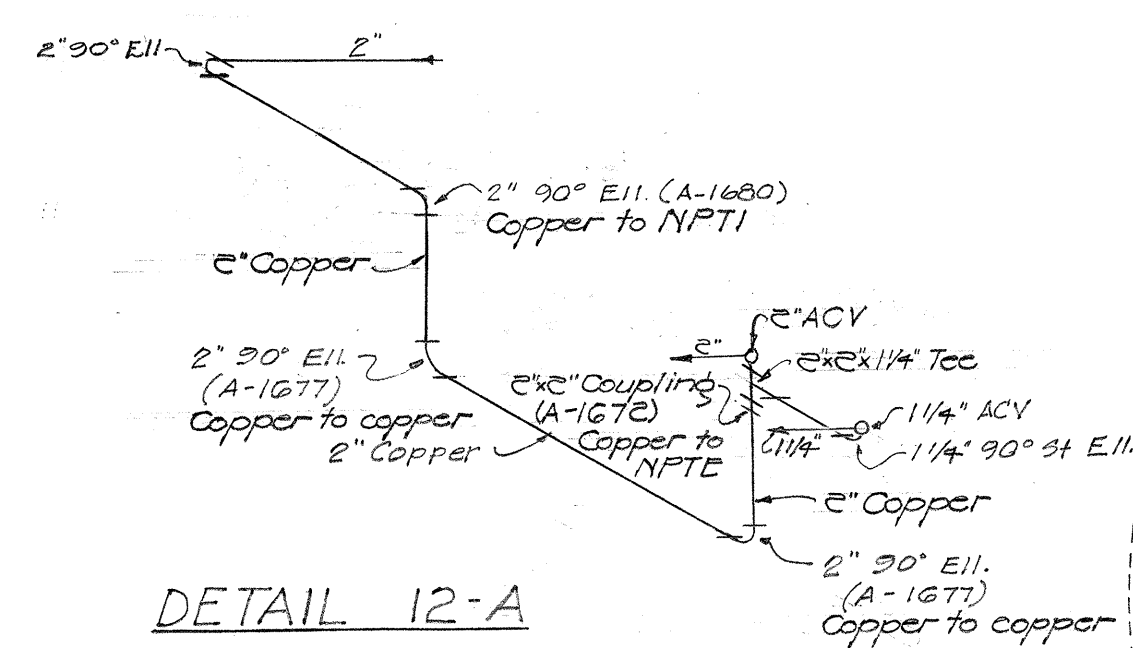

DETAIL 12-A

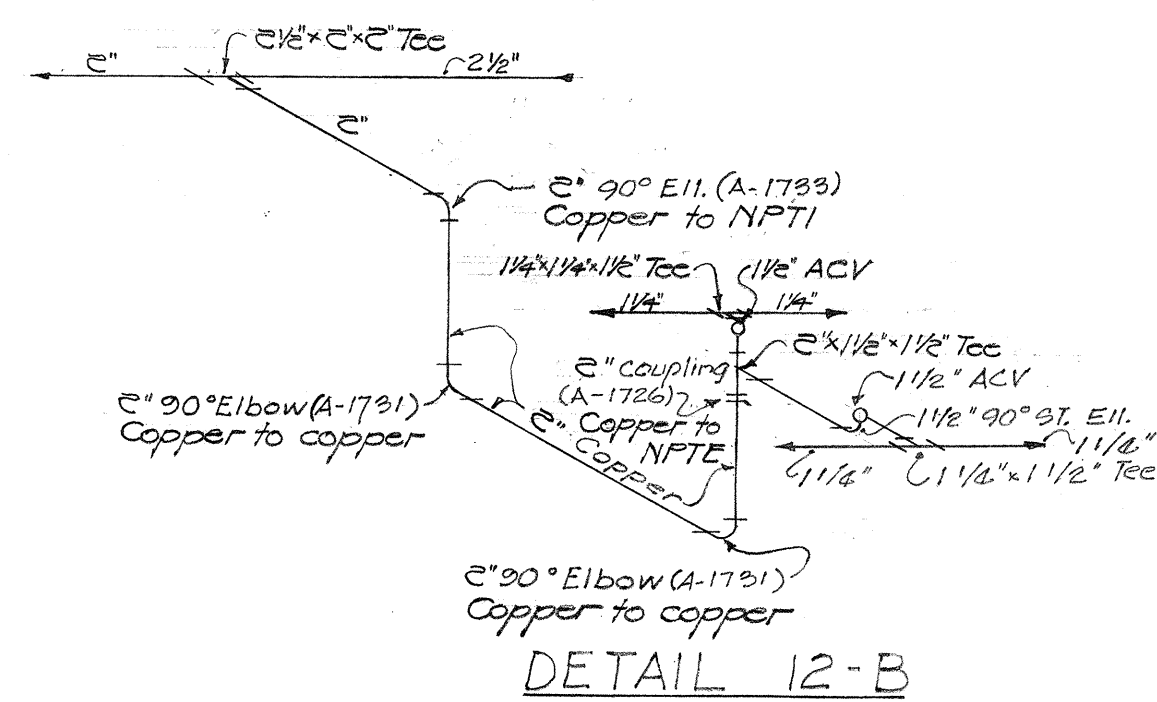

DETAIL 12-E

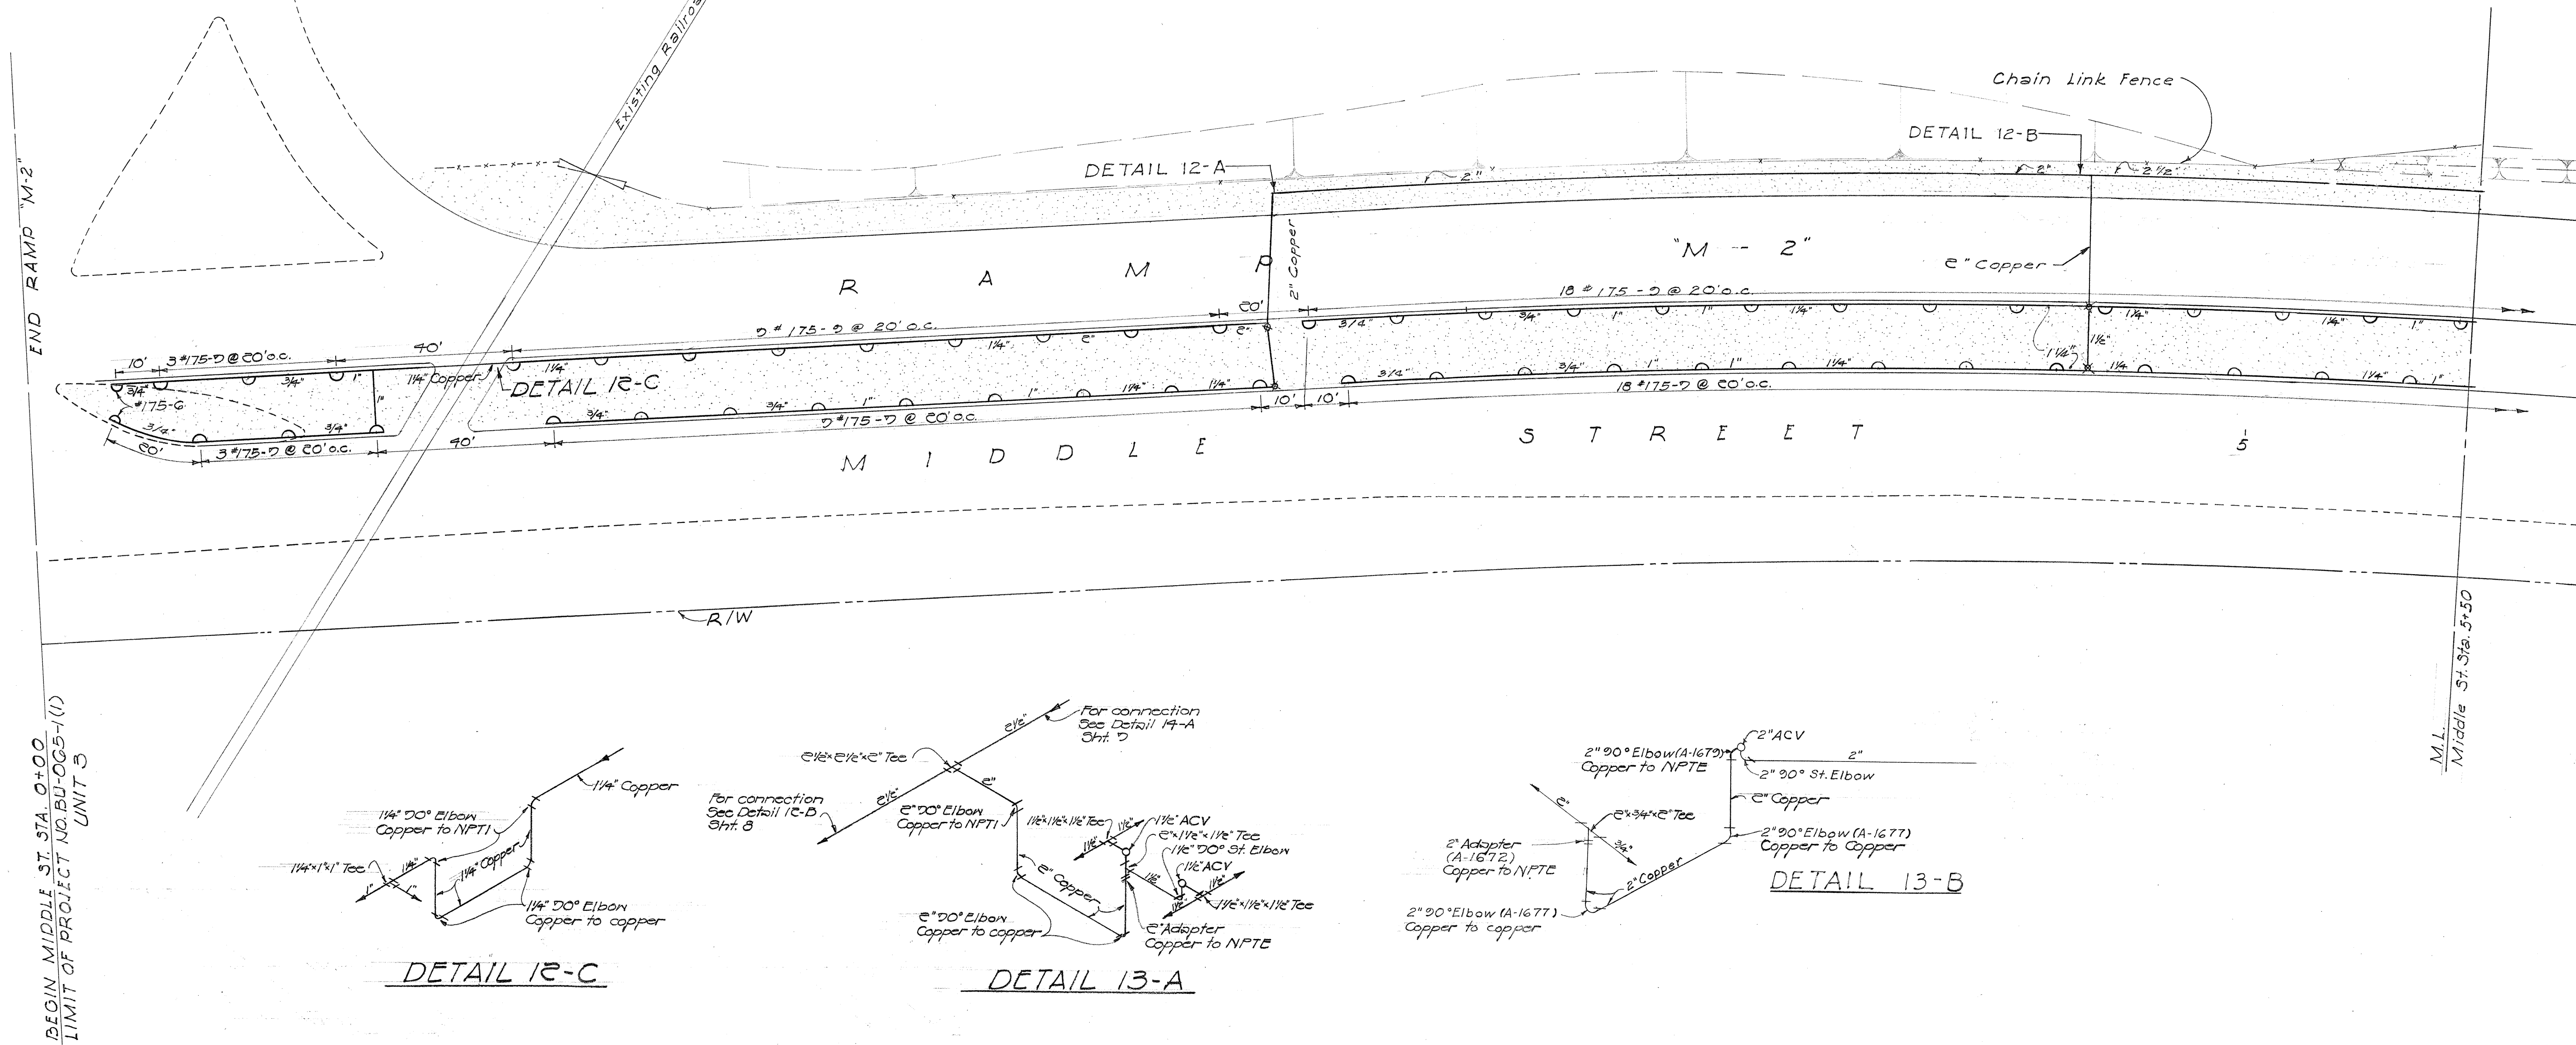


DETAIL 12-C

DETAIL 13-A

DETAIL 13-B

ORIGINAL	SURVEY PLOTTED BY	DATE
PLAN	DESIGNED BY	"
	DRAWN BY	"
	TRACED BY	"
NOTE BOOK	QUANTITIES BY	"
	QUANTITIES CHECKED BY	"
No.	CHECKED BY	"
		"

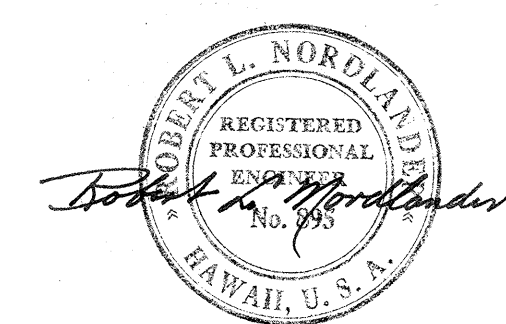

BELT, COLLINS & ASSOC., LTD.
Civil and Structural Engineers

HAWAII STATE HIGHWAY DEPARTMENT
STATE OF HAWAII

LANDSCAPE & SPRINKLER PLAN


MIDDLE STREET BU-065-1(1) UNIT 3

SHEET No. 8 OF 12 SHEETS

\$161.89



135

ORIGINAL PLAN	SURVEY PLOTTED BY	DATE
	DESIGNED BY <i>L. Lind</i>	" 3-57
	DRAWN BY <i>R. Edwards</i>	" 3-57
	TRACED BY	"
	QUANTITIES BY <i>D. Chung</i>	" 3-57
	QUANTITIES CHECKED BY	"
	CHECKED BY <i>B. Bayashi</i>	" 3-57

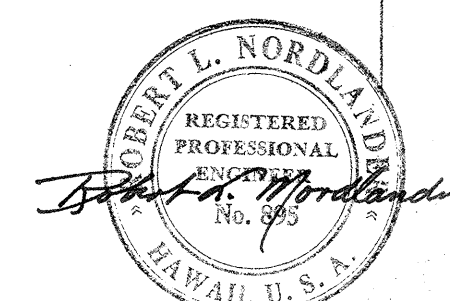

130

FED. ROAD DIST. NO.	STATE	FED. AID PROJ. NO.	FISCAL YEAR	SHEET NO.	TOTAL SHEETS
HAWAII	HAW.	US-50702(3) UNIT 3	1960	63	79
		BU-074(4) UNIT 4	1960	95	118
		BU-065(1) UNIT 3	1960	91	115

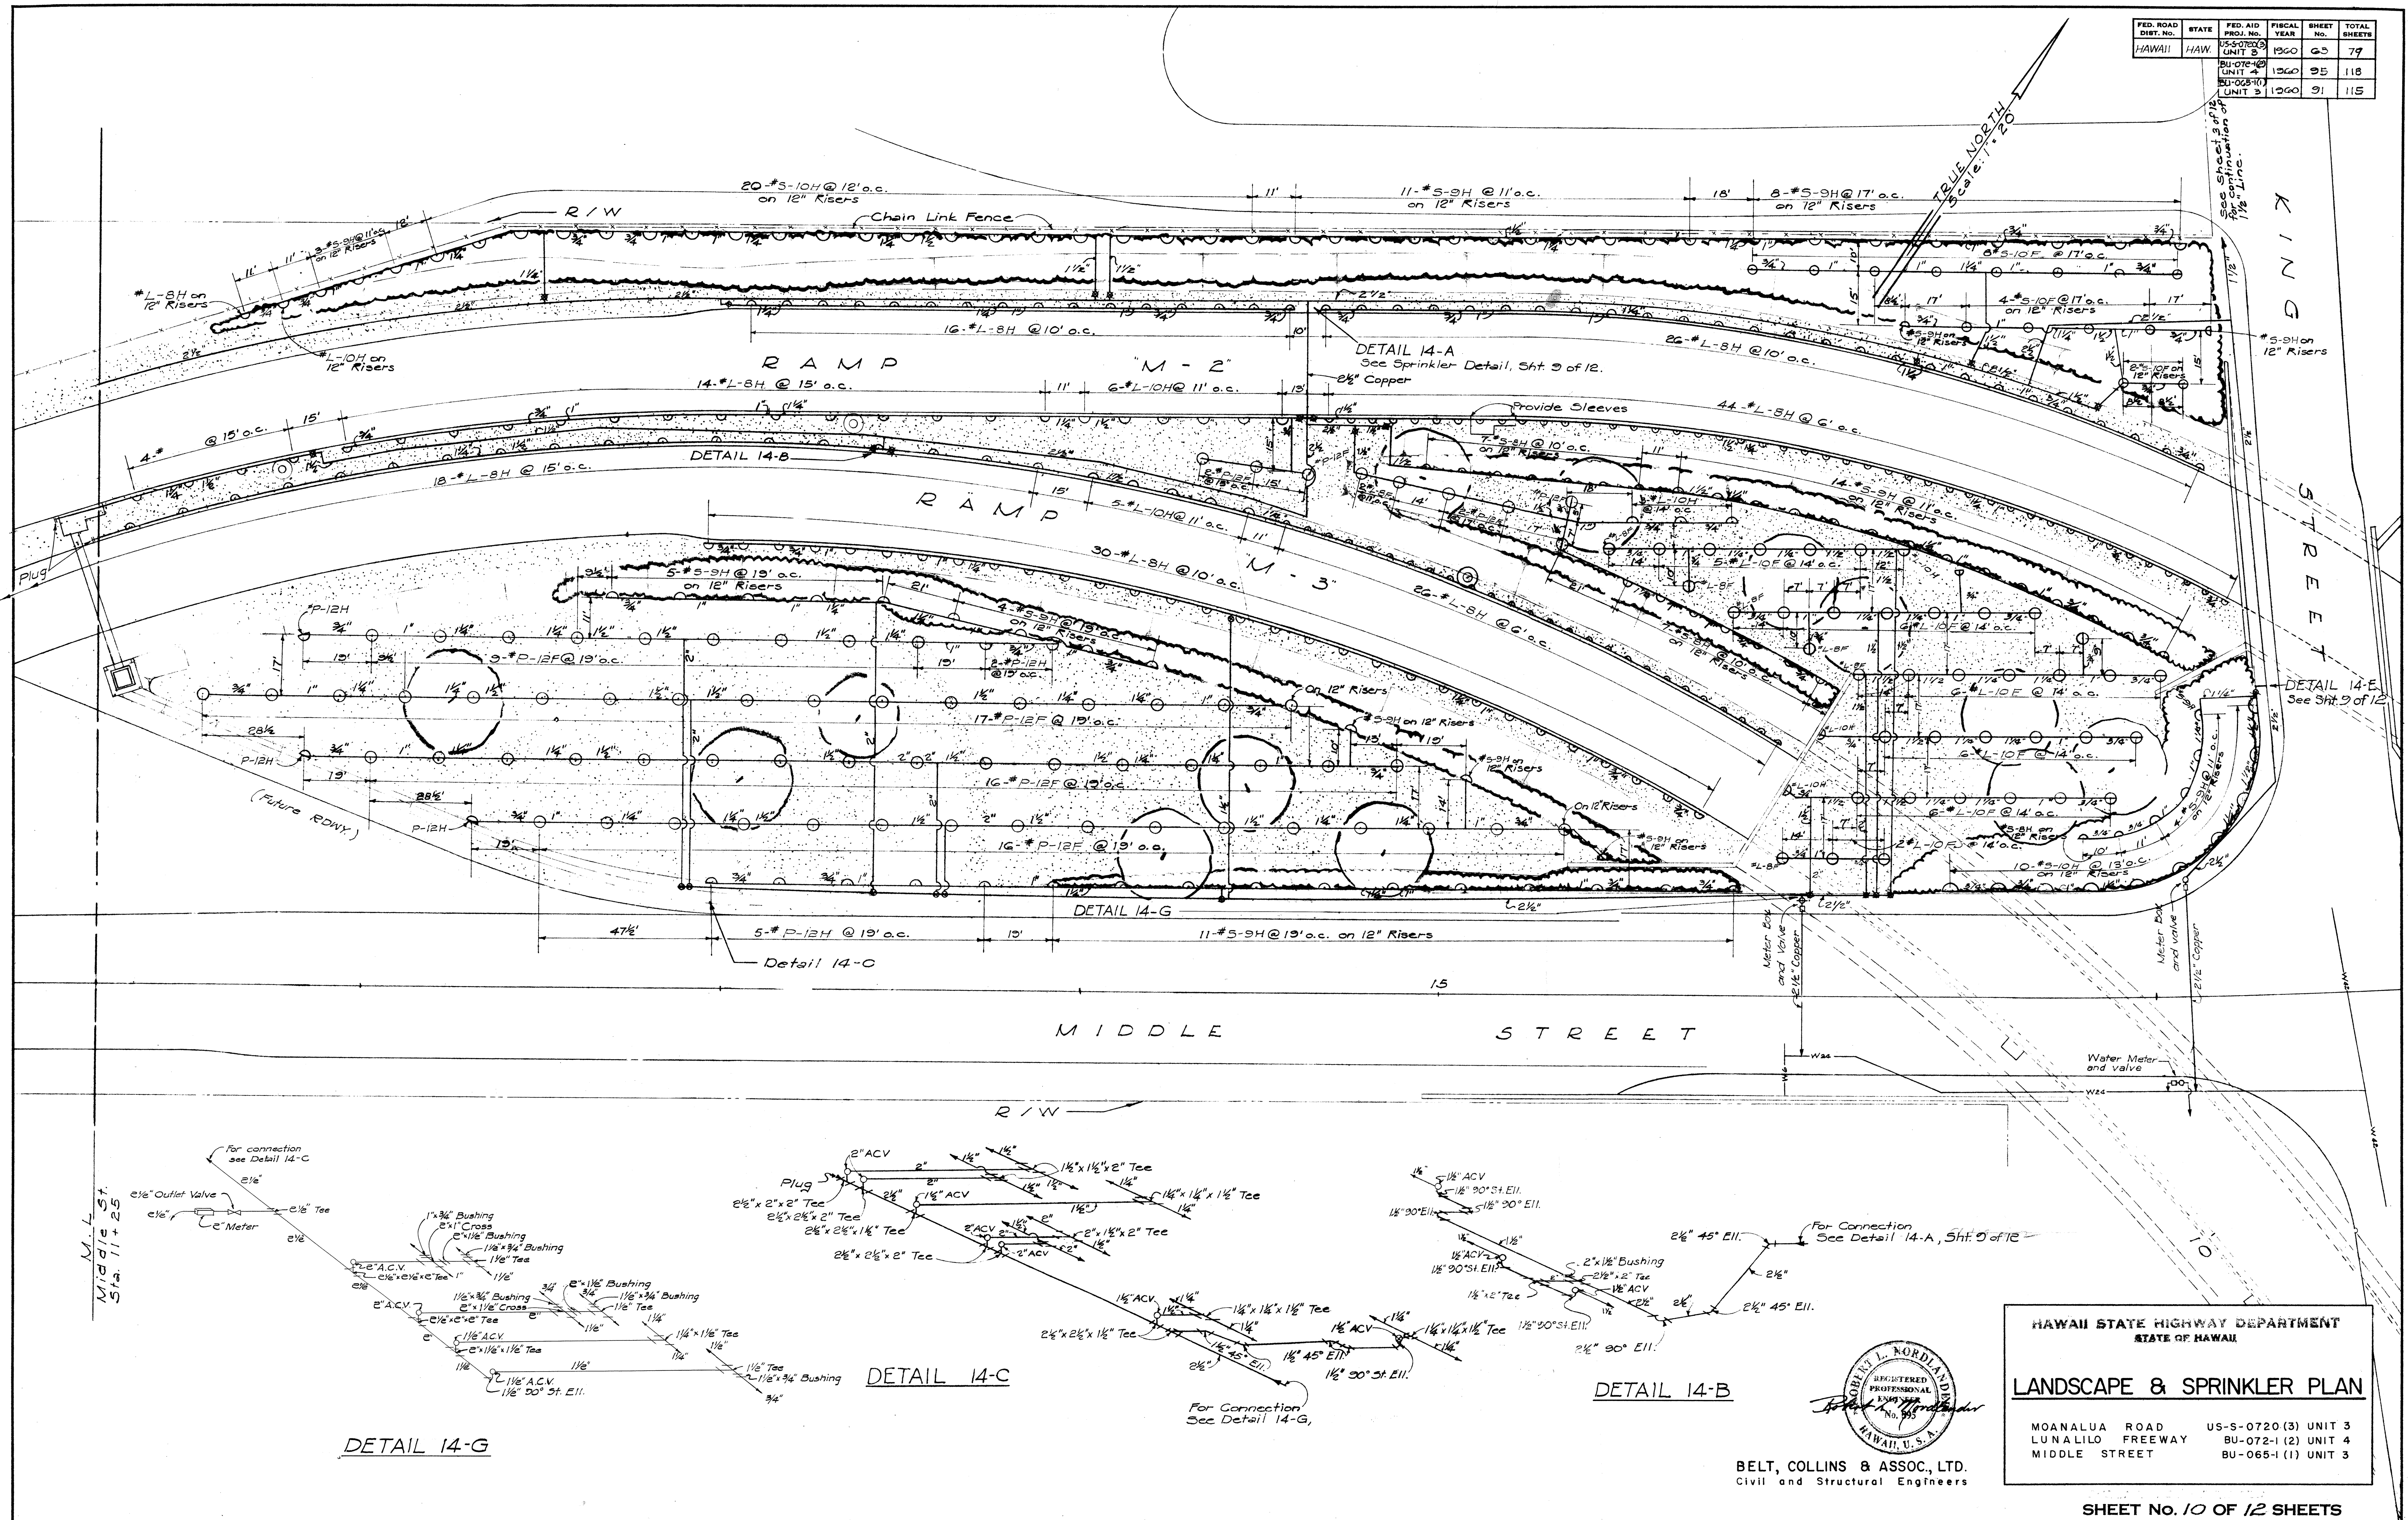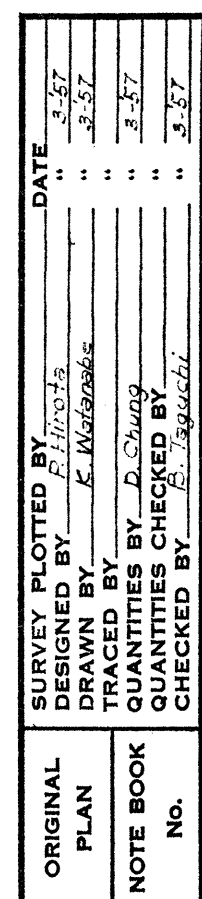

HAWAII STATE HIGHWAY DEPARTMENT
STATE OF HAWAII

LANDSCAPE & SPRINKLER PLAN


MOANALUA ROAD	US-S-0720 (3) UNIT 3
LUNALILO FREEWAY	BU-072-1 (2) UNIT 4
MIDDLE STREET	BU-065-1 (1) UNIT 3

BELT, COLLINS & ASSOC., LTD.
Civil and Structural Engineers

SHEET No. 10 OF 12 SHEETS


\$526.63 \$174.95 \$161.91 137

FED. ROAD DIST. NO.	STATE	FED. AID PROJ. NO.	FISCAL YEAR	SHEET NO.	TOTAL SHEETS
HAWAII	HAW.	US-0720(3)	1960	64	79
		UNIT 3			
		UNIT 4	1960	90	115
		UNIT 5	1960	90	115

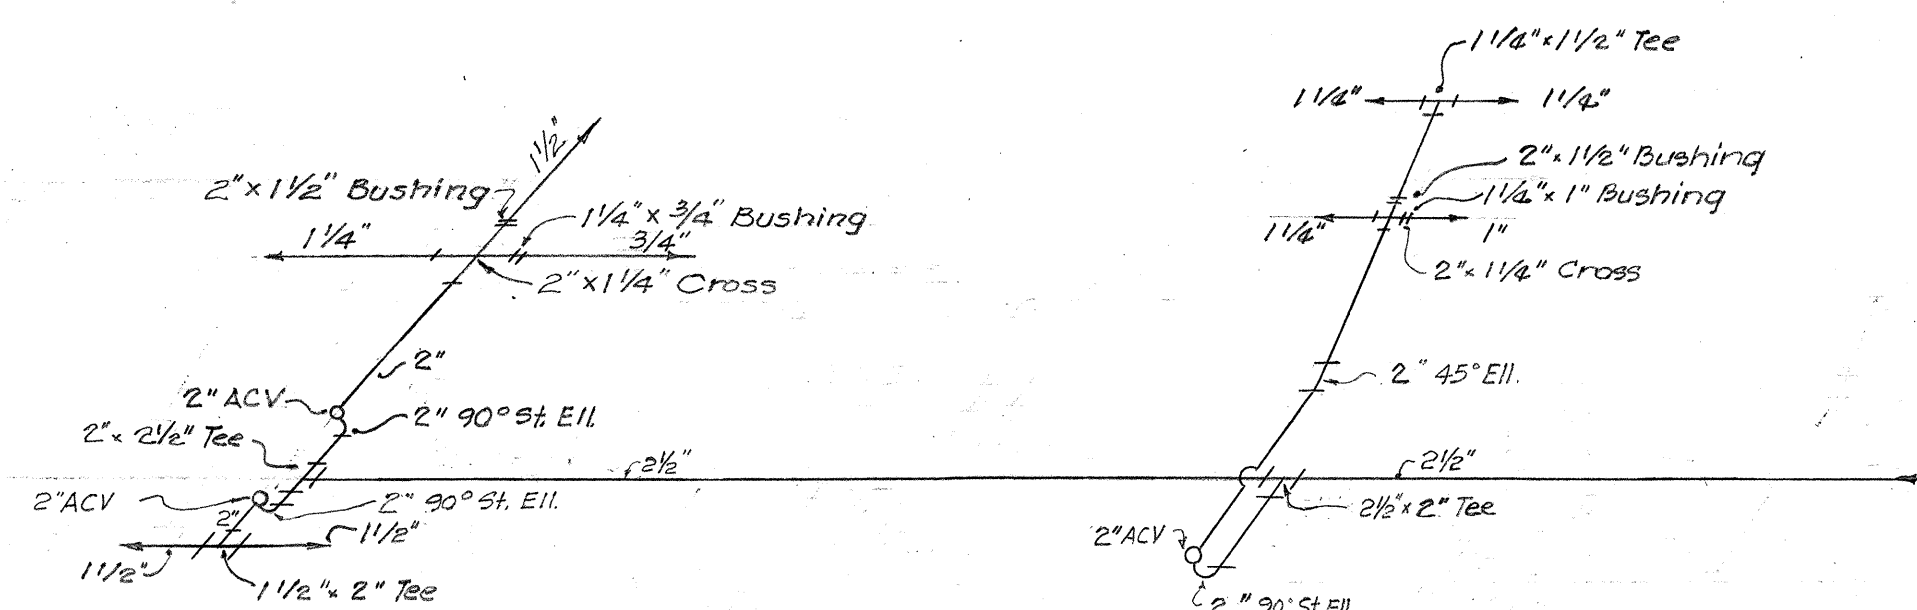


DETAIL 1-A


DETAIL 1-B

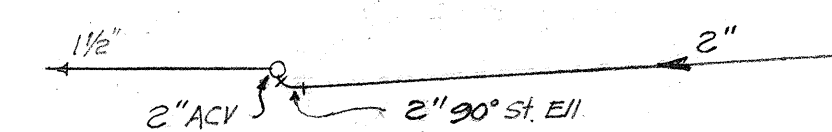


DETAIL 1-C

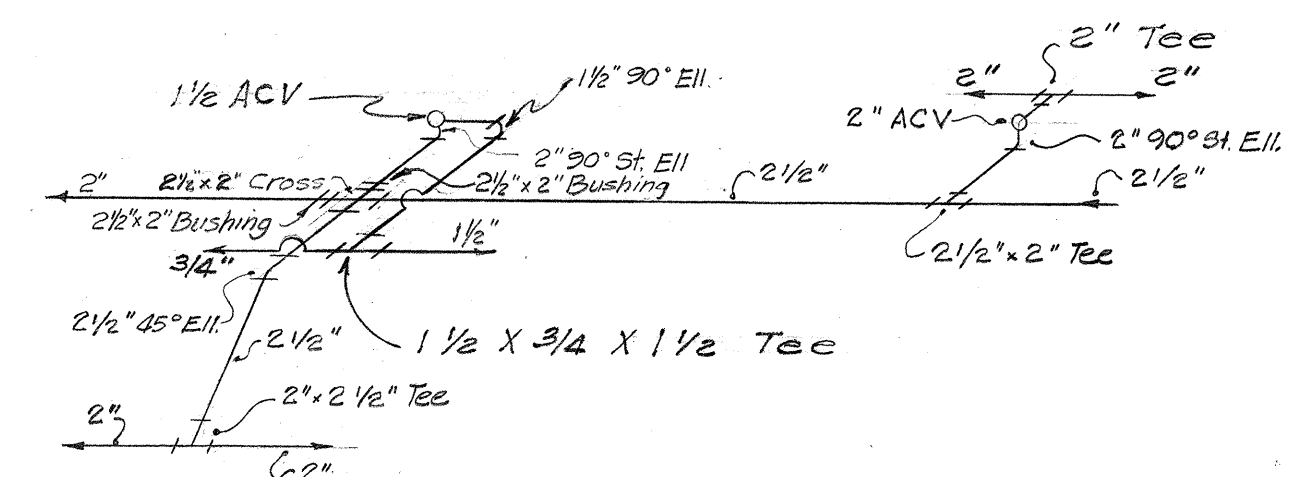


DETAIL 1-D

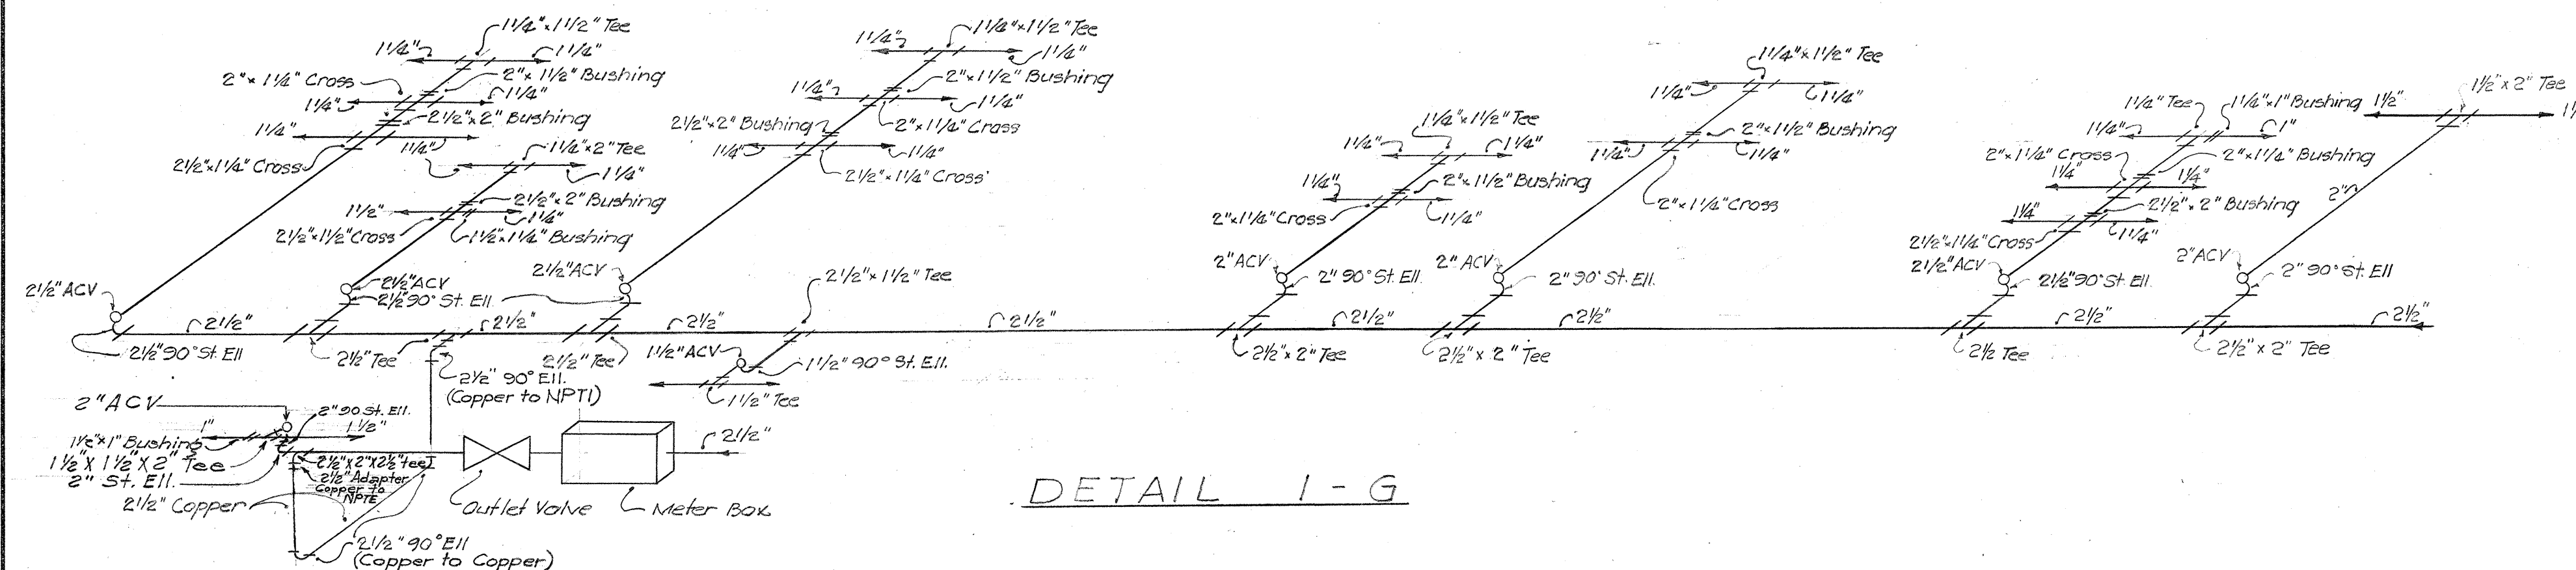


DETAIL 1-G

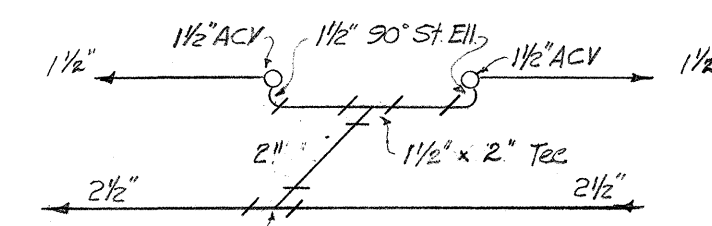


DETAIL 1-E

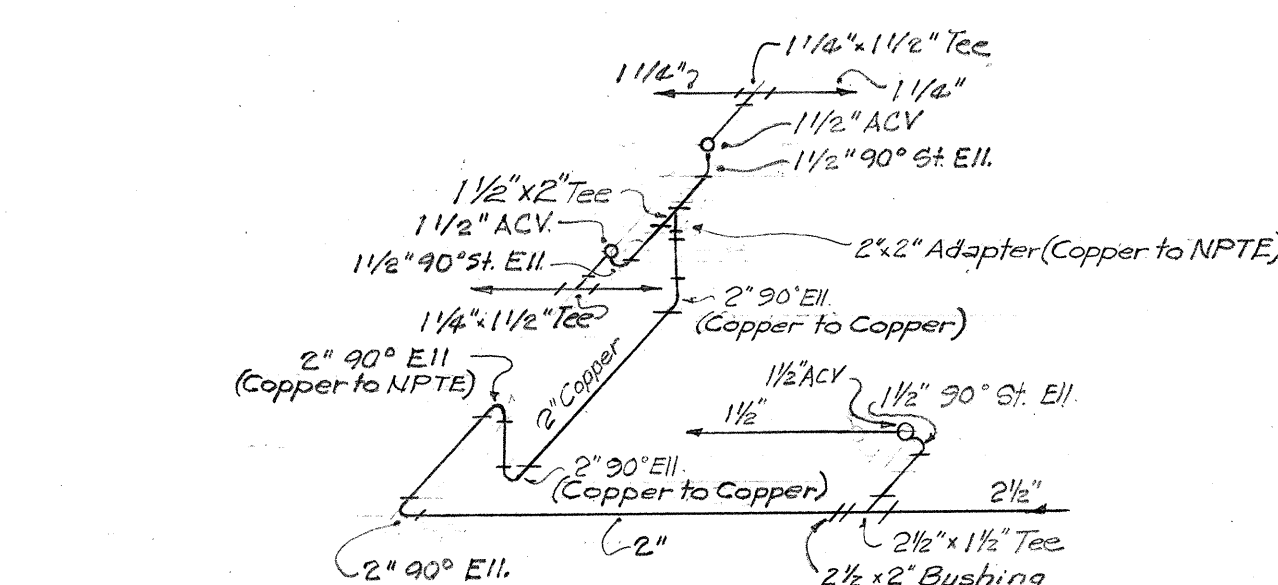


DETAIL 1-F

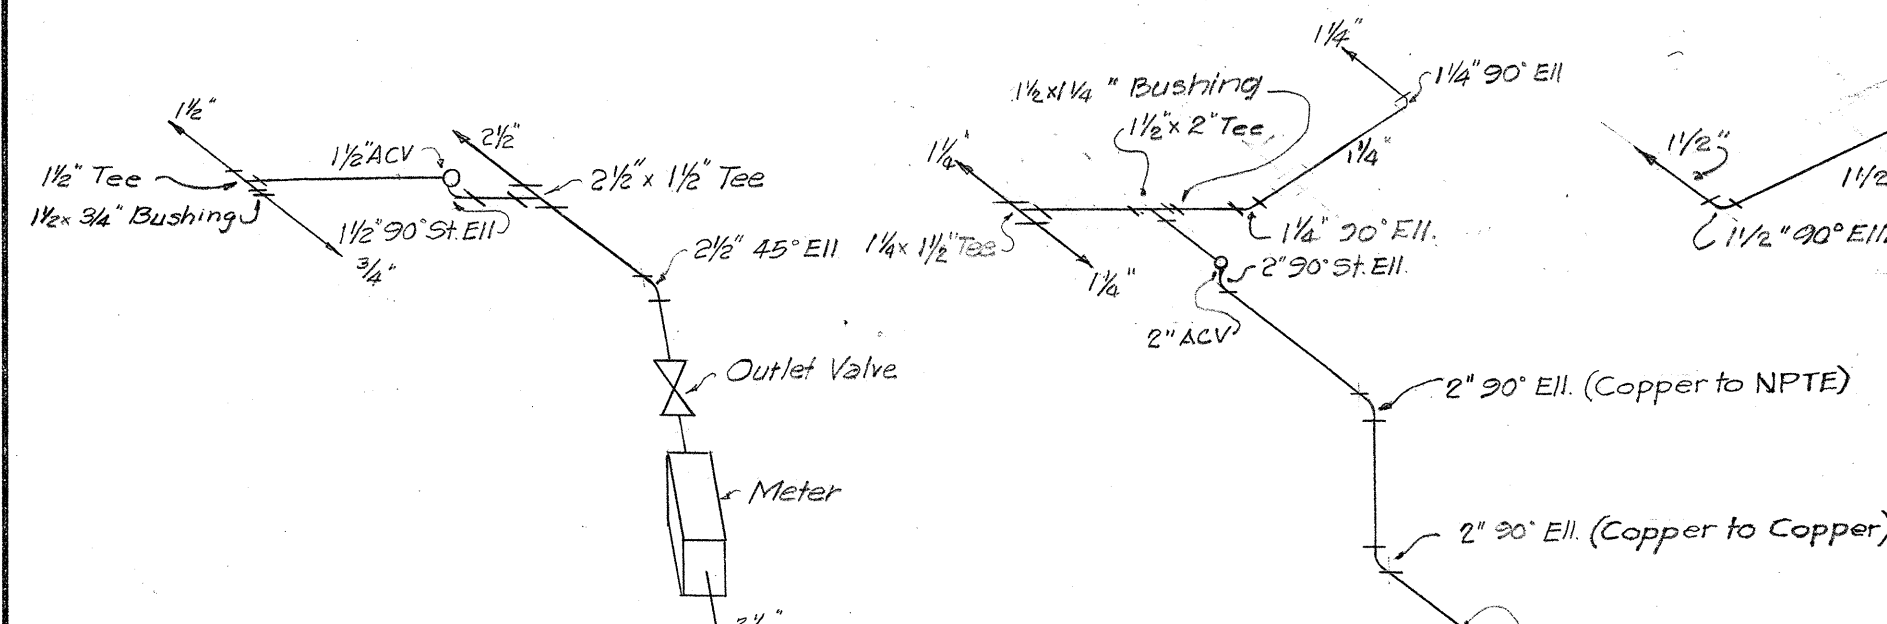


DETAIL 2-A

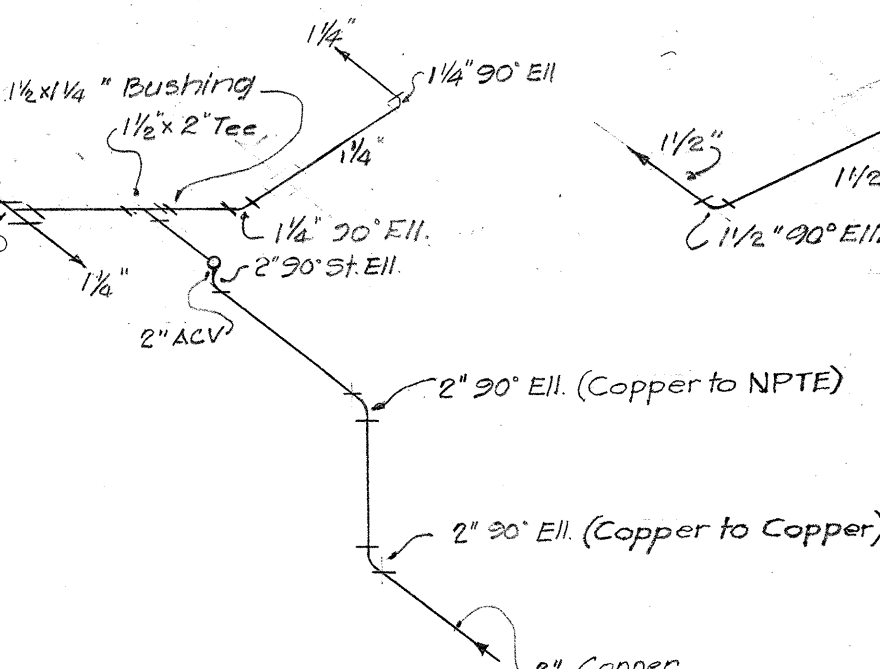


DETAIL 2-B

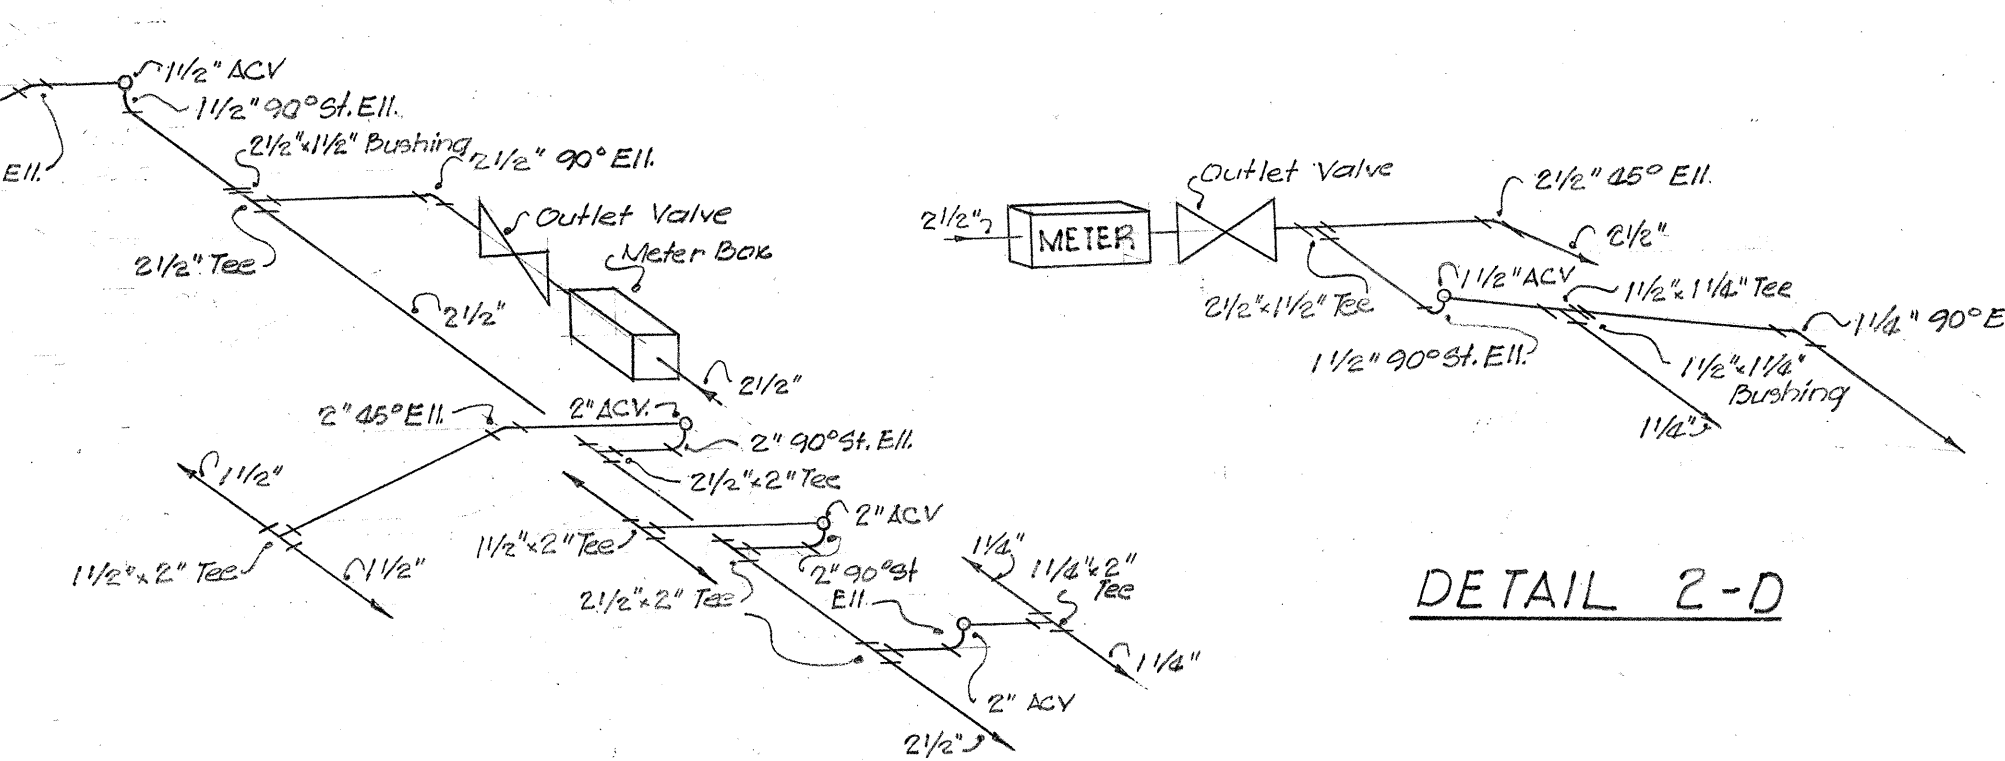


DETAIL 2-D

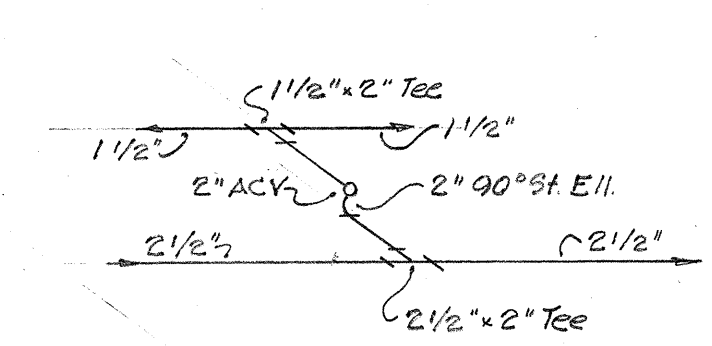


DETAIL 2-E

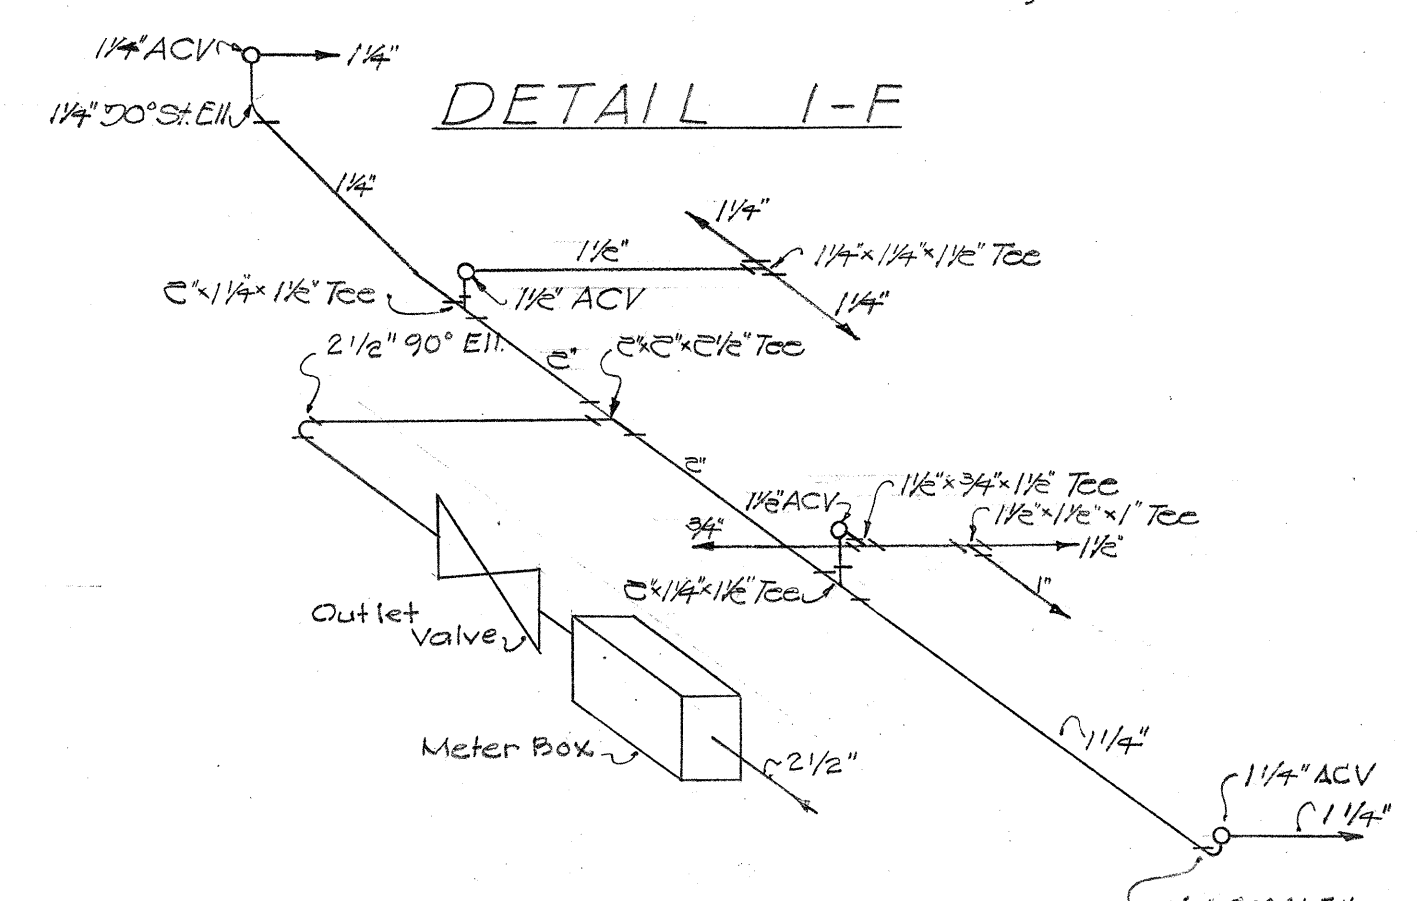


DETAIL 2-G

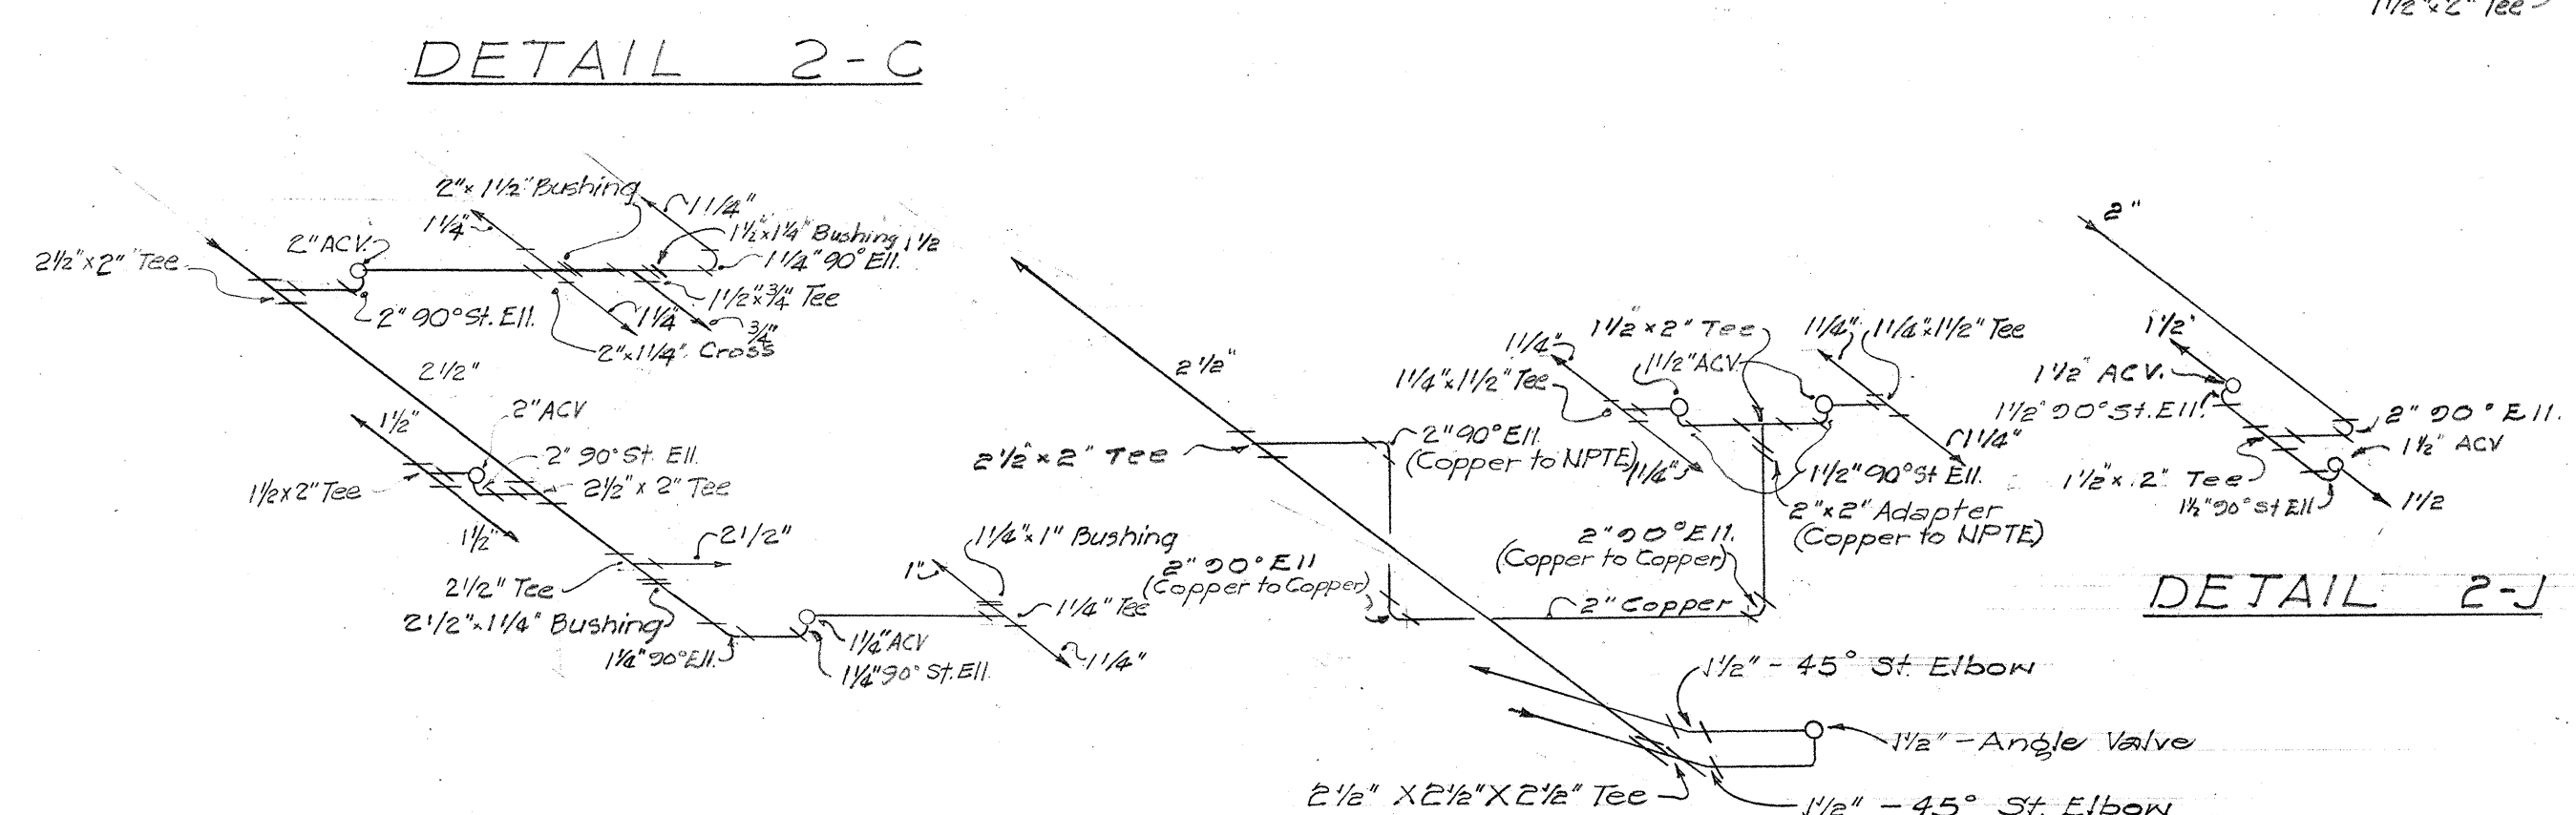

DETAIL 2-H

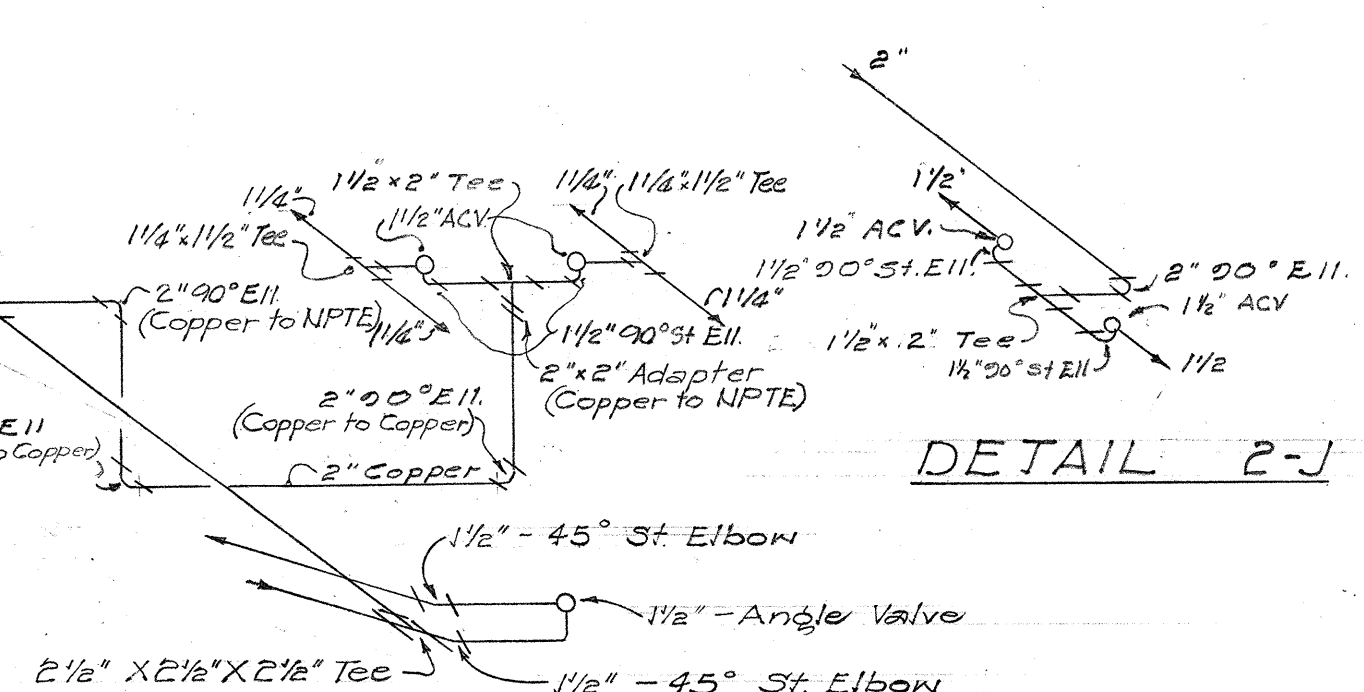


DETAIL 2-I

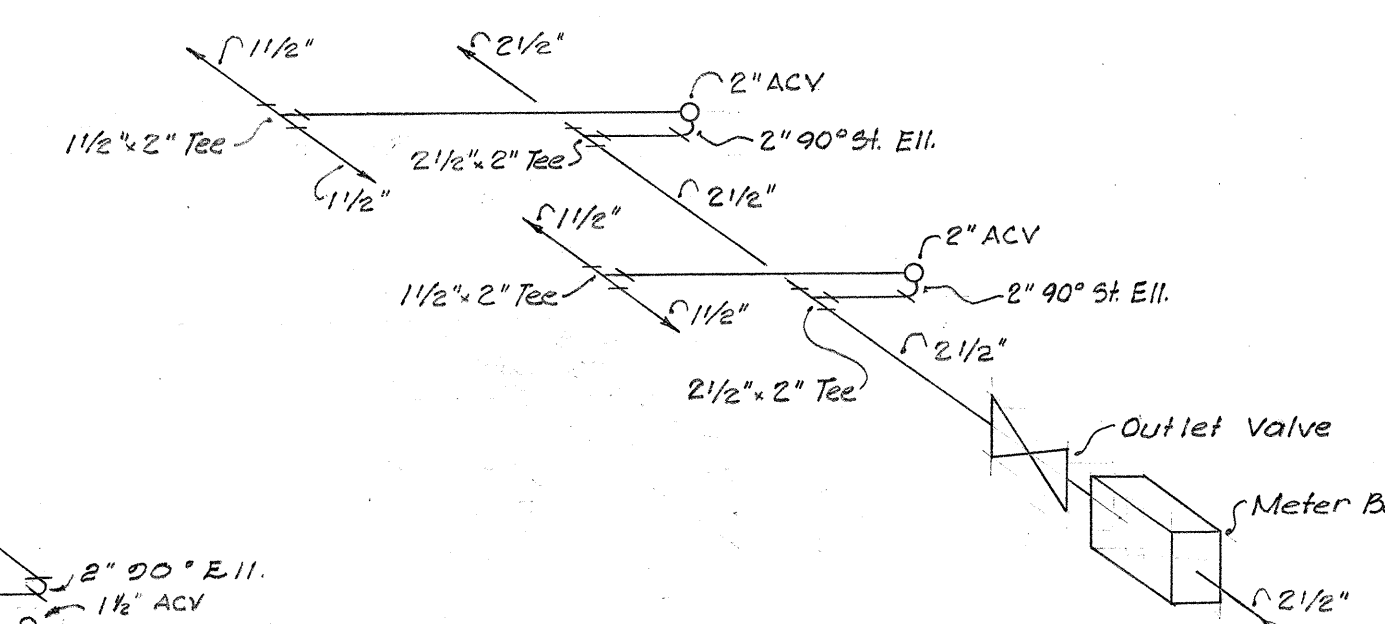

DETAIL 2-K

DETAIL 2-J

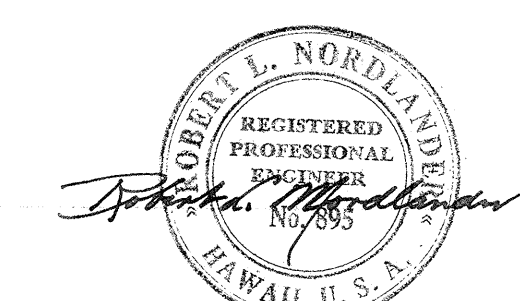

BELT, COLLINS & ASSOC., LTD.
Civil and Structural Engineers

HAWAII STATE HIGHWAY DEPARTMENT
STATE OF HAWAII

LANDSCAPE & SPRINKLER PLAN

MOANALUA ROAD US-S-0720 (3) UNIT 3
MIDDLE STREET BU-072-1 (2) UNIT 4
LUNALILOU FREEWAY BU-065-1 (1) UNIT 3

SHEET No. 11 OF 12 SHEETS

526.64


8174.96

8161.92


138

DESIGNED BY	DATE
DRAWN BY	
CHECKED BY	
QUANTITIES CHECKED BY	
NOTE BOOK	
No.	


FED. ROAD DIST. NO.	STATE	FED. AID PROJ. NO.	FISCAL YEAR	SHEET NO.	TOTAL SHEETS
HAWAII	HAW.	US-5-078C(3) UNIT 3	1960	65	79
		BU-07E-1E UNIT 4	1960	97	118
		BU-065-1(1) UNIT 3	1960	93	115

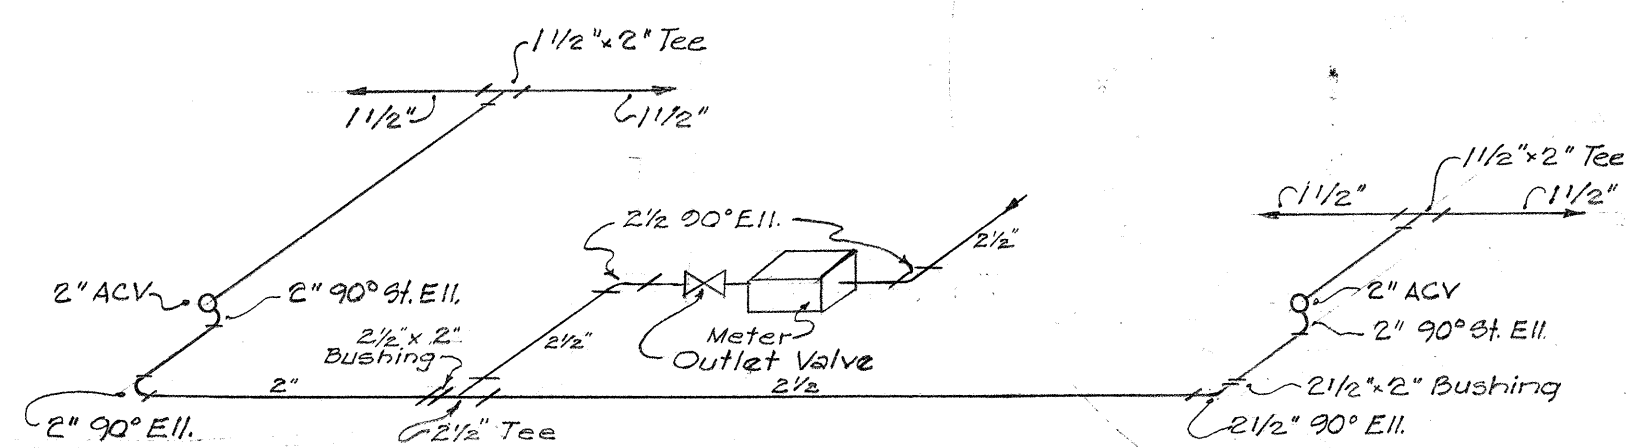


DETAIL 3-A

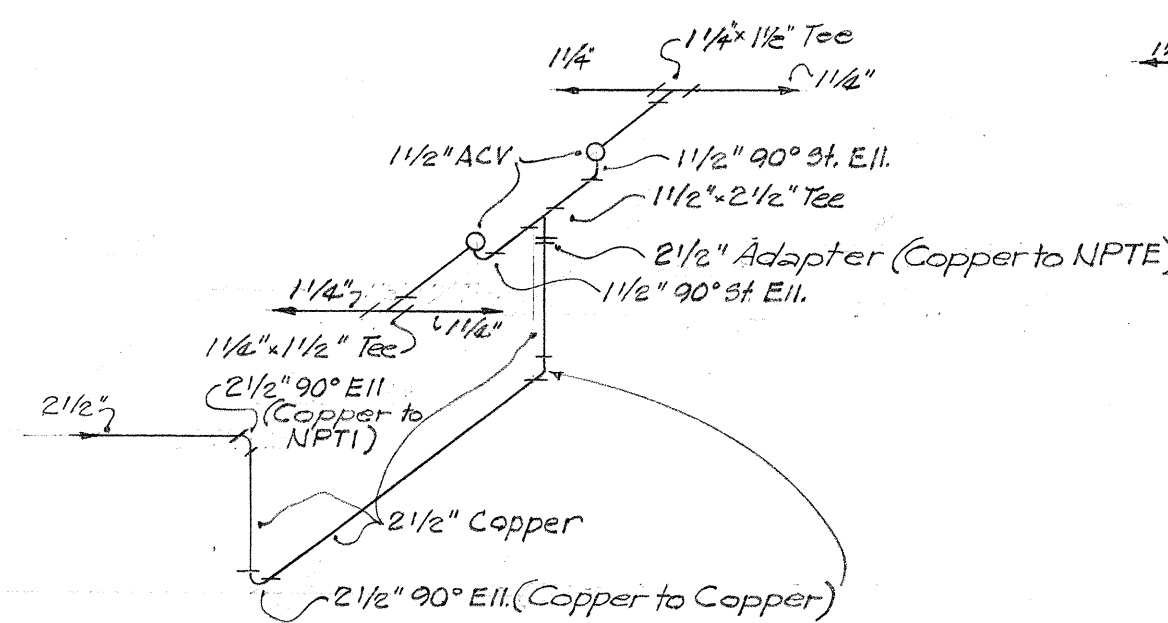


DETAIL 3-B

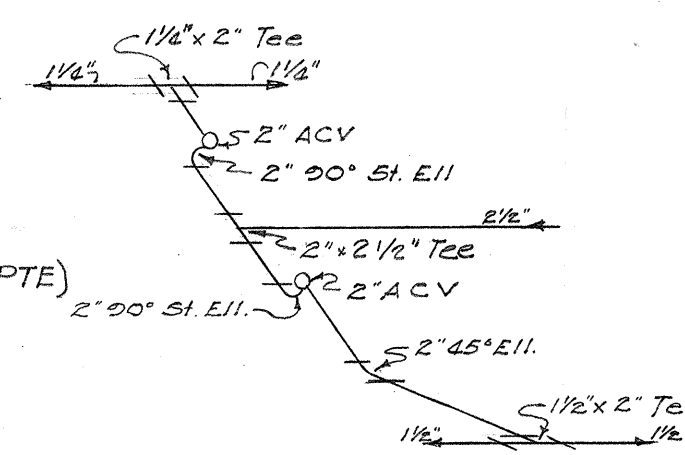


DETAIL 3-C

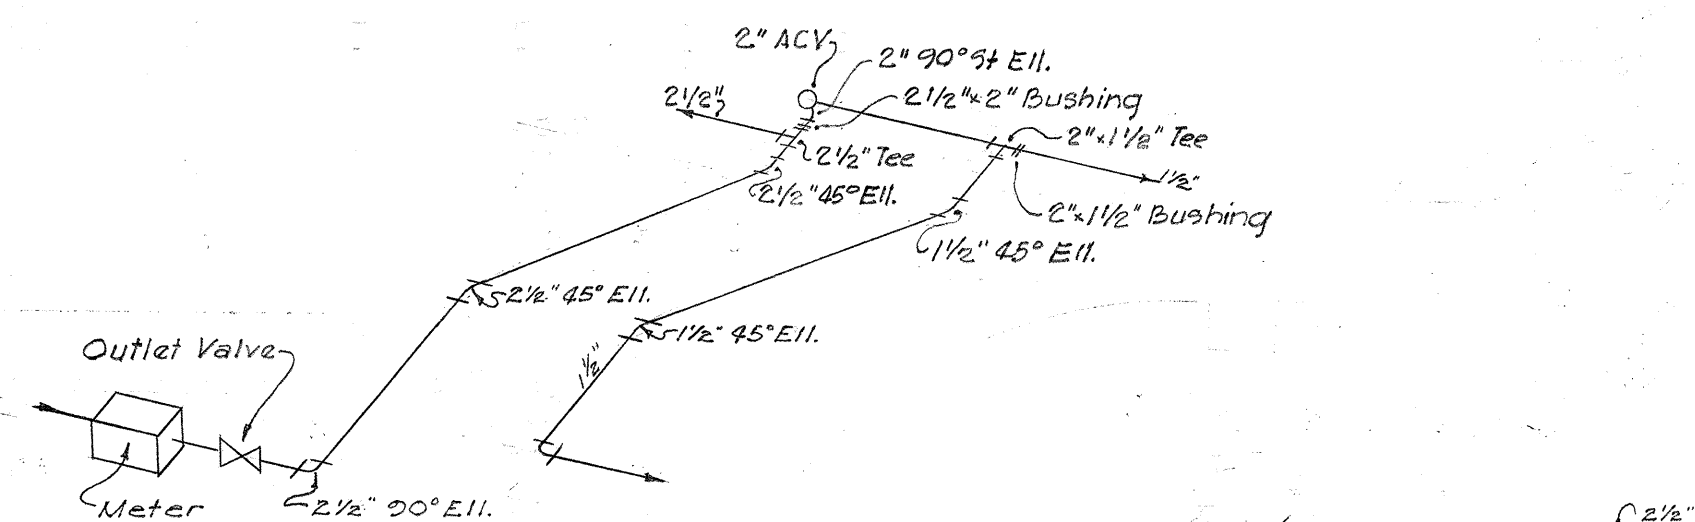


DETAIL 3-D

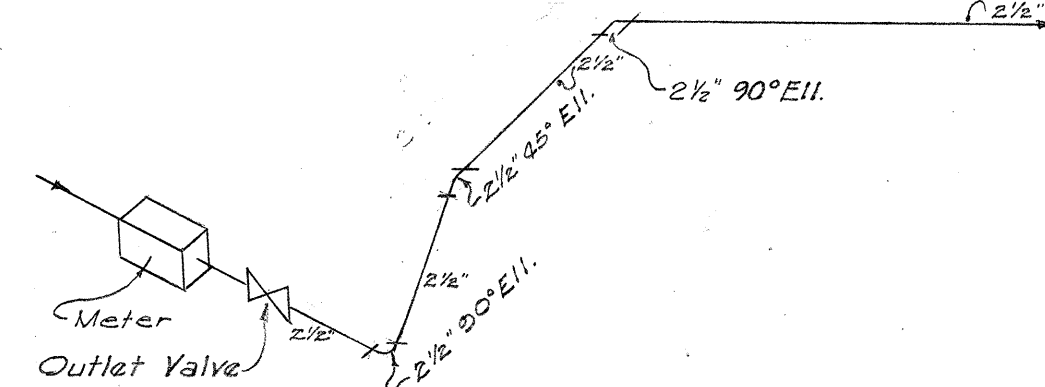



DETAIL 3-E

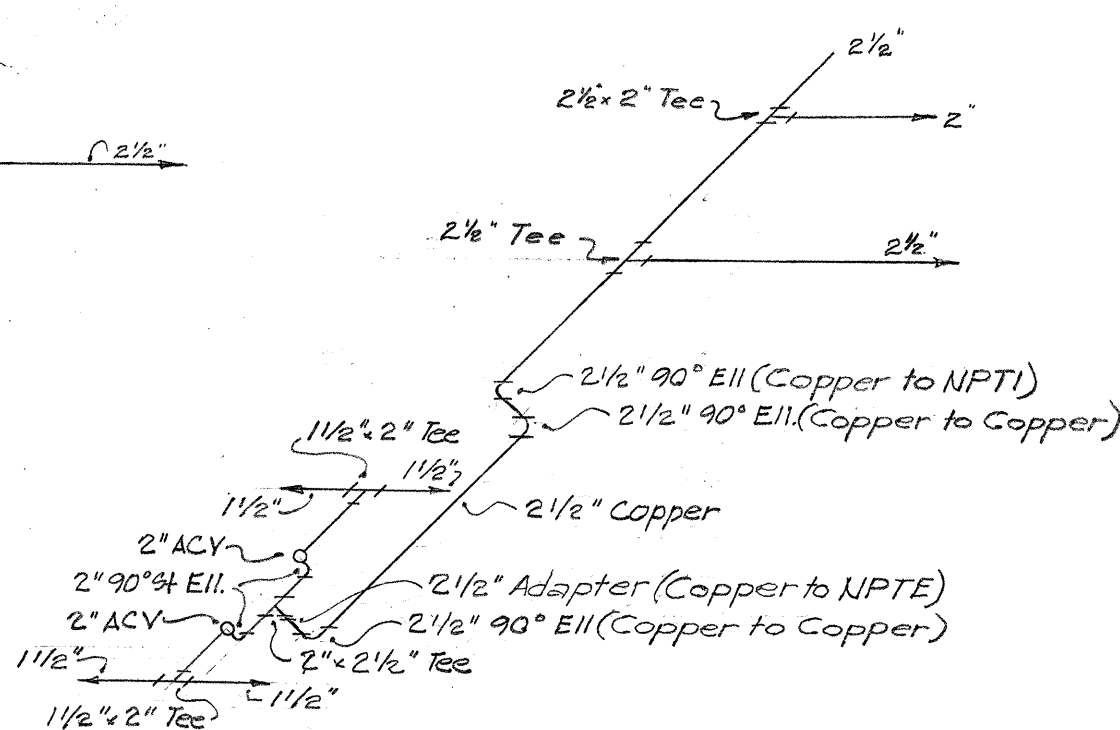


DETAIL 3-F

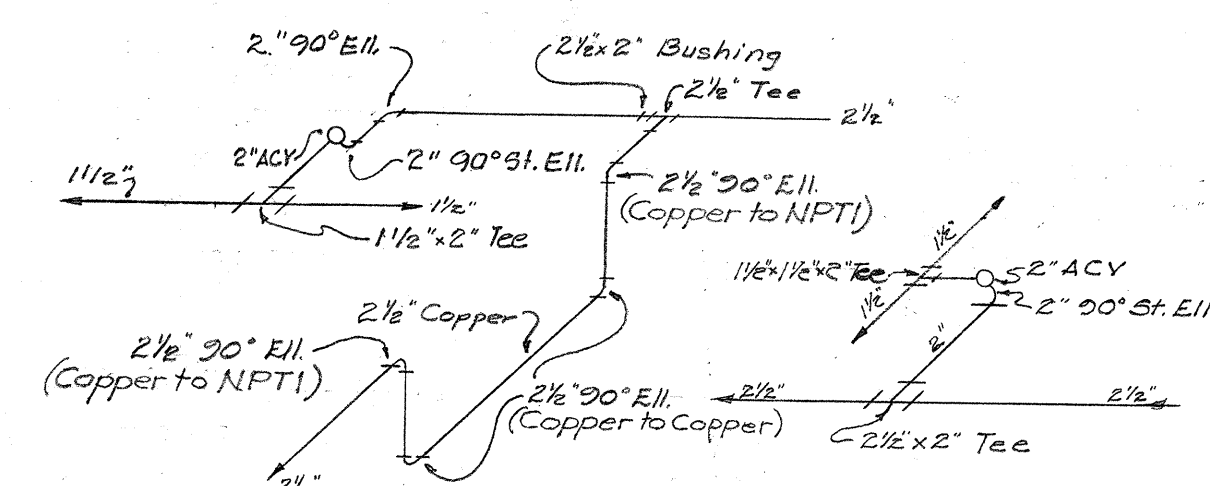


DETAIL 3-G

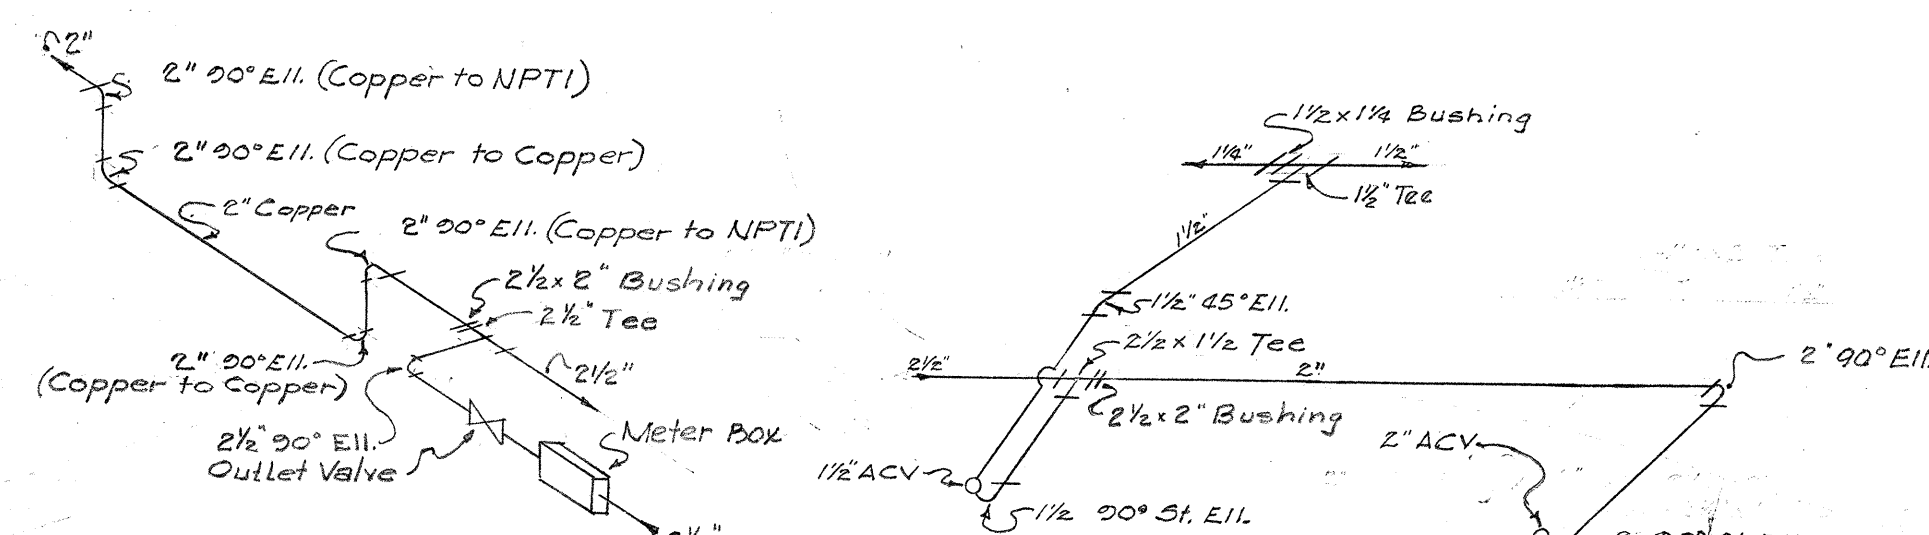 


DETAIL 3-J

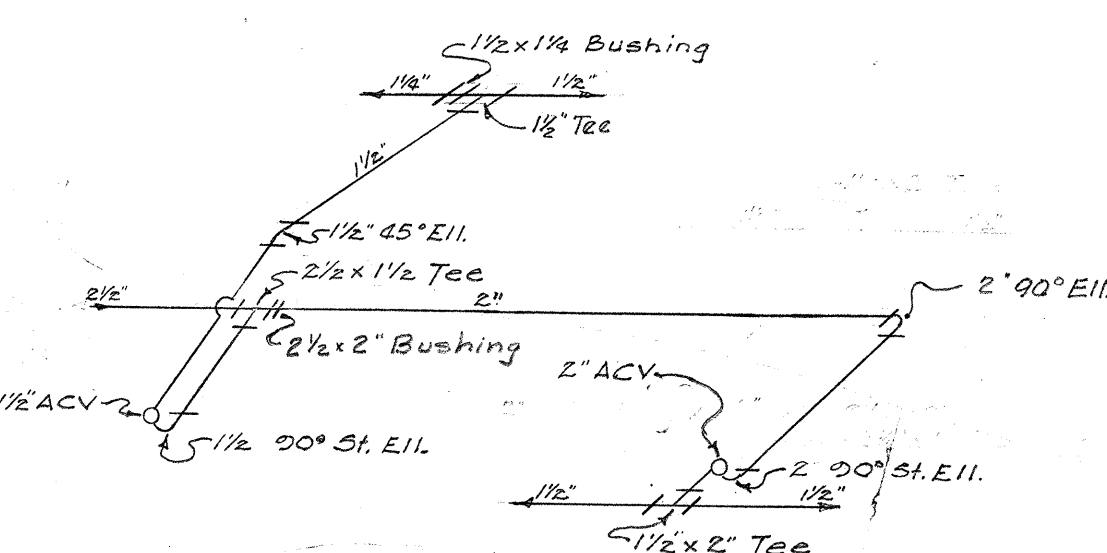

DETAIL 3-K

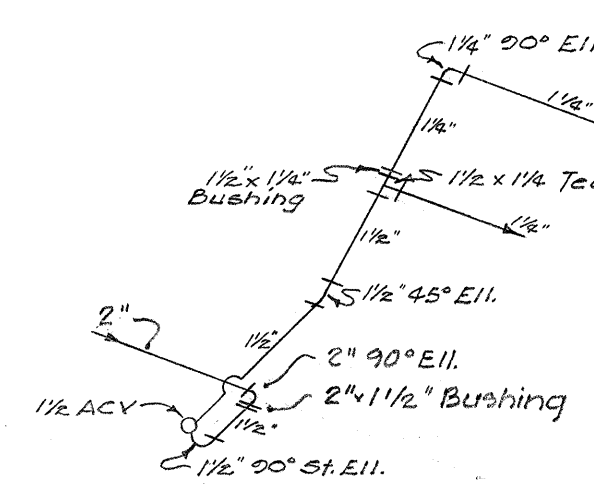

DETAIL 3-L

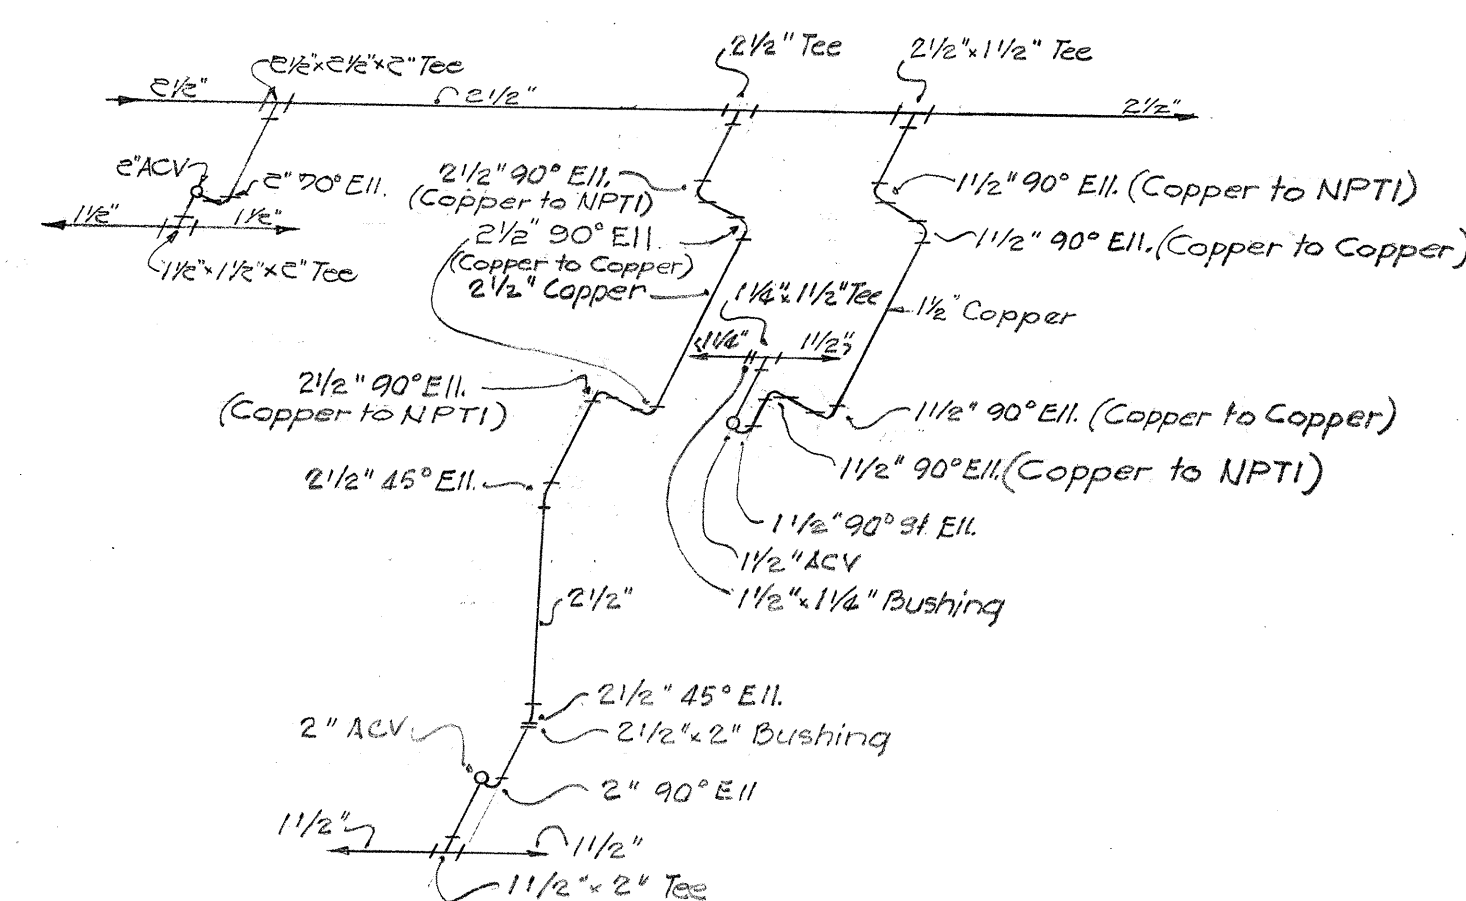

DETAIL 3-M



BELT, COLLINS & ASSOC., LTD.
Civil and Structural Engineers

HAWAII STATE HIGHWAY DEPARTMENT
STATE OF HAWAII

LANDSCAPE & SPRINKLER PLAN

MOANALUA ROAD	US-S-0720 (3) UNIT 3
LUNALILO FREEWAY	BU-072-1 (2) UNIT 4
MIDDLE STREET	BU-065-L (1) UNIT 3

SHEET No. 12 OF 12 SHEETS