



LEGEND

- Two Luminaires on double Bracket Standard. (Numeral indicates Circuit M-1)
- One Luminaire on one metal post with Bracket length as noted. (Numeral indicates Circuit M-2)
- Luminaire with 200 Watt H5H Mercury Vapor Light Source.
- Luminaire with 400 Watt H1LS Mercury Vapor Light Source.
- Luminaire with 400 Watt H1LS Mercury Vapor Light Source.
- Luminaire with 100 Watt lamp, 6 foot long fluorescent light Source
- 8 AMP cable in 3 inch Asbestos Cement Conduit Type 1. See detail for Conduit sizes in structures. 12-14-16-18-20-24-30-36-14004-1

FED. ROAD DIST. NO.	STATE	FED. AID PROJ. NO.	FISCAL YEAR	SHEET NO.	TOTAL SHEETS
HAWAII	HAW.	BU-072-1(1)	1960	76	118
		BU-072-1(2)	1960	74	115

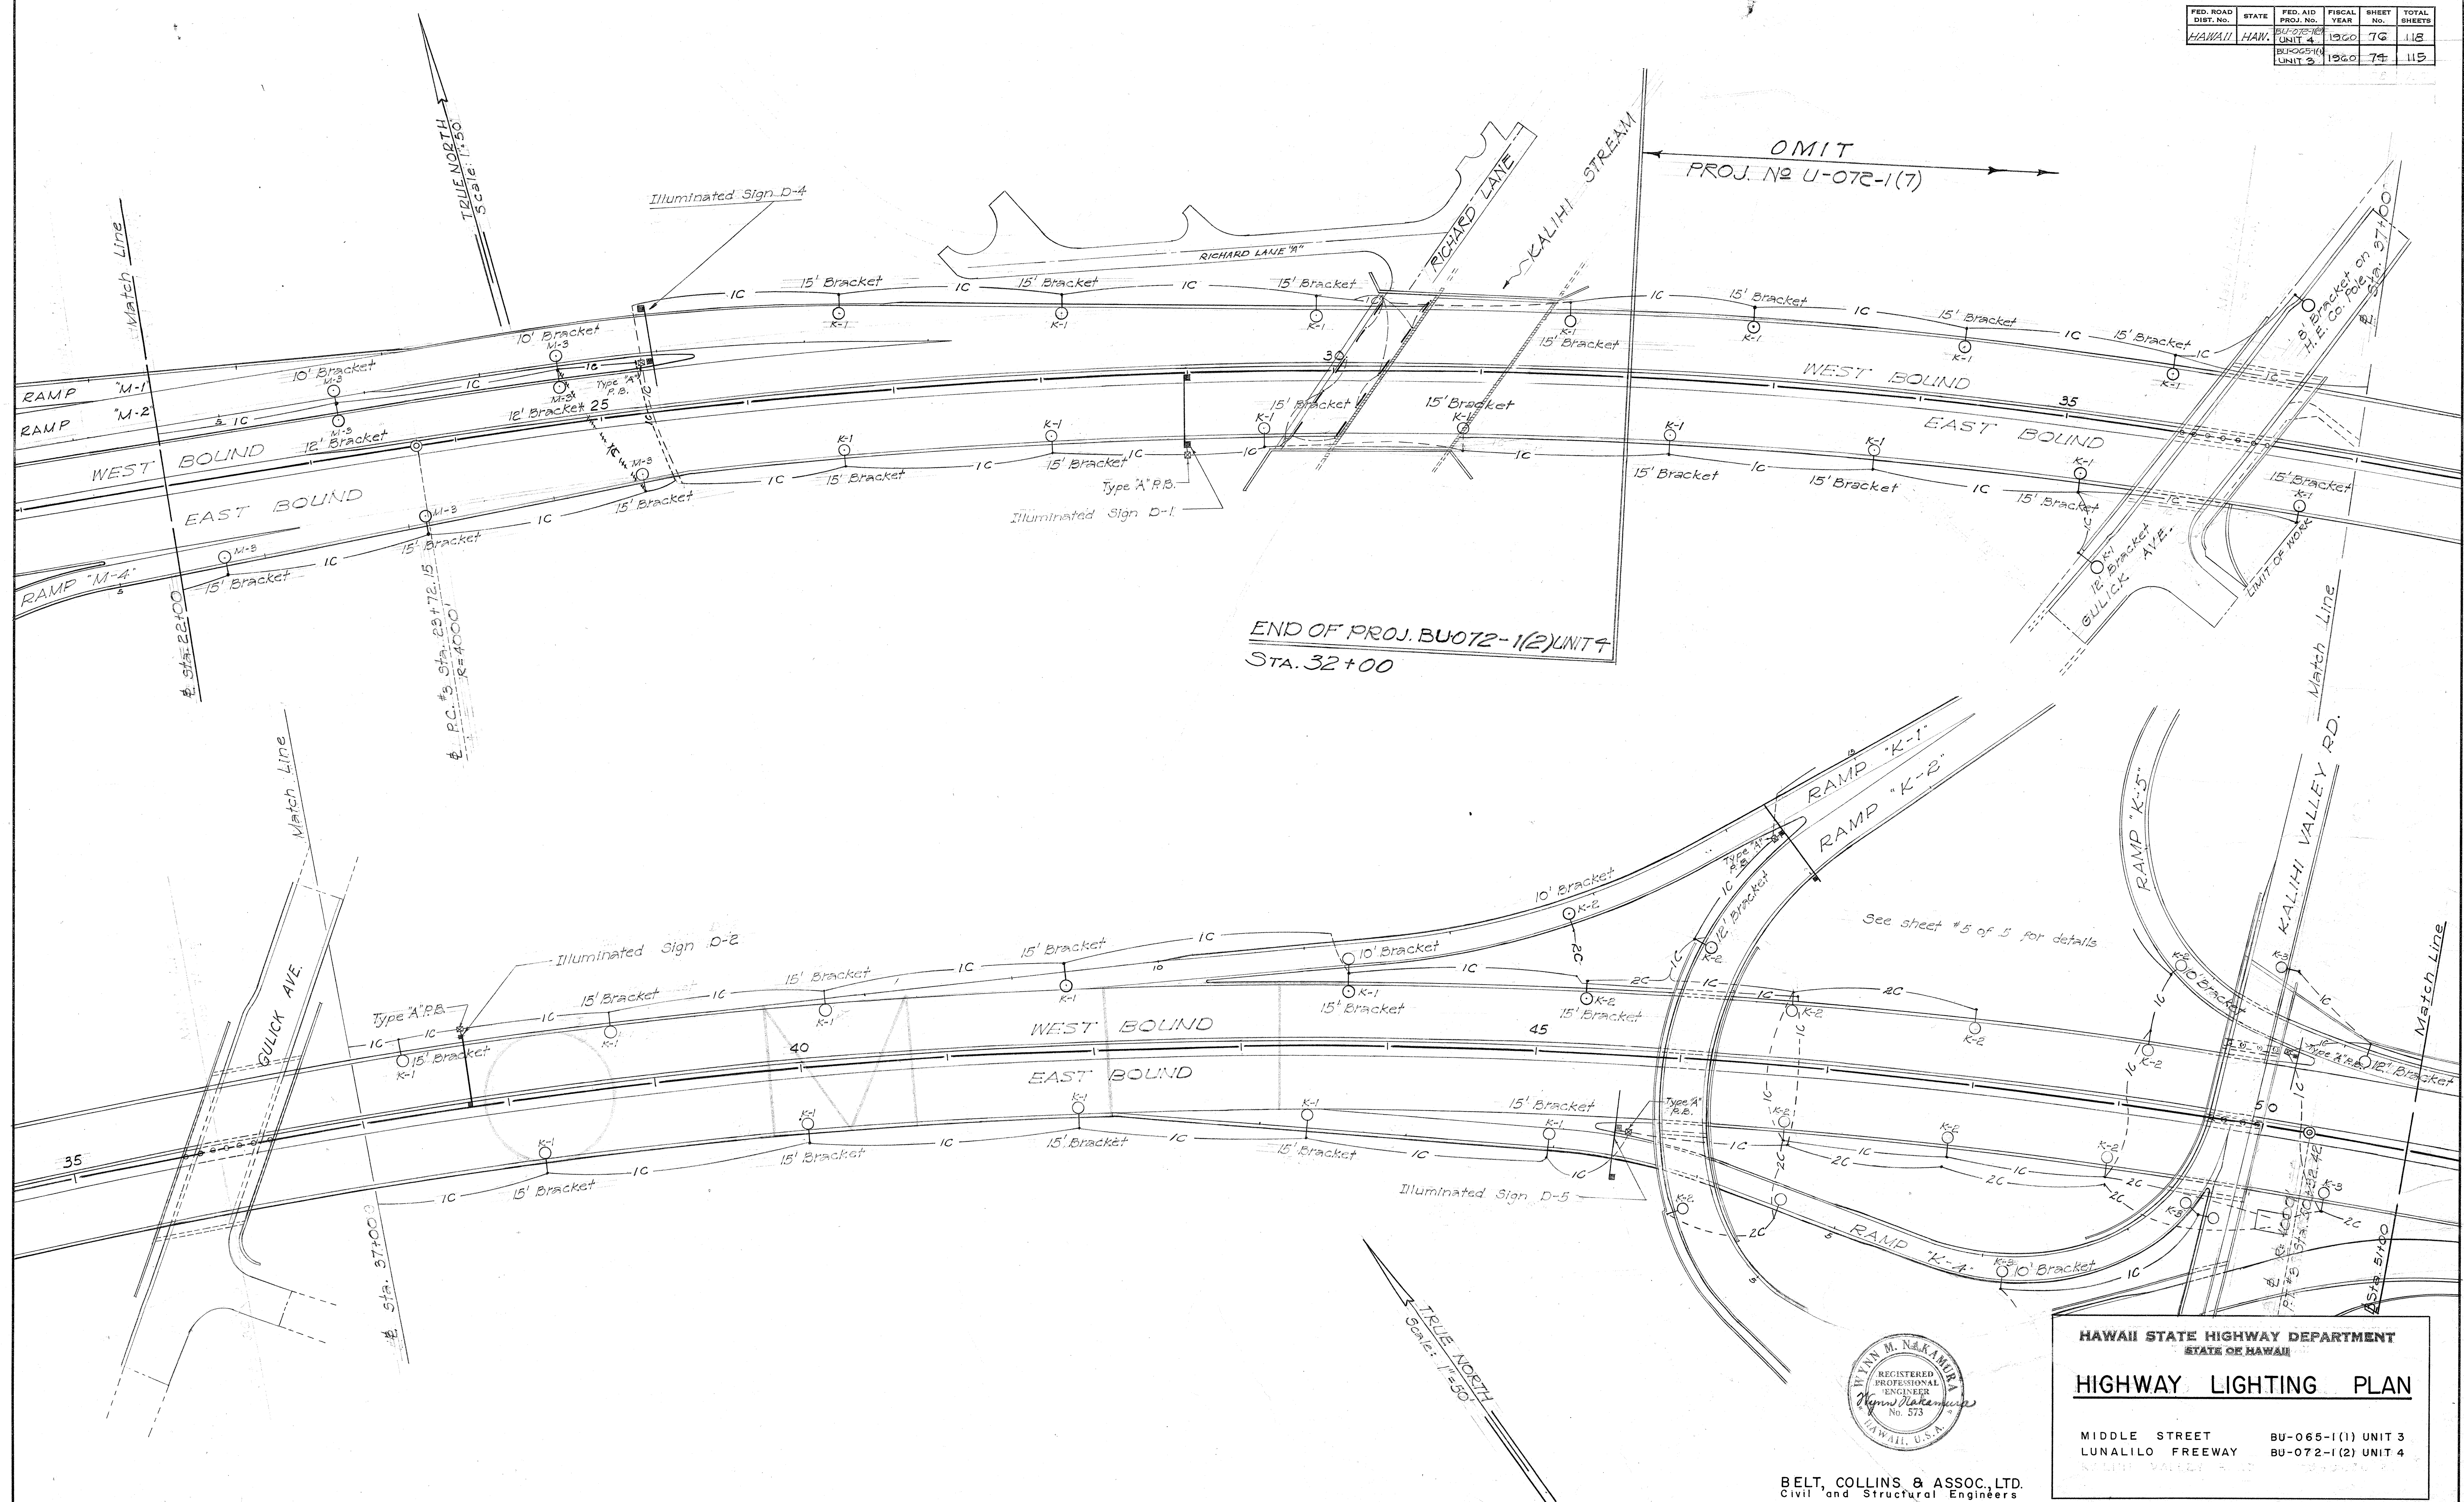

SURVEY PLOTTED BY	DATE
DESIGNED BY	
TRACED BY	
QUANTITIES BY	
CHECKED BY	
NOTE BOOK No.	

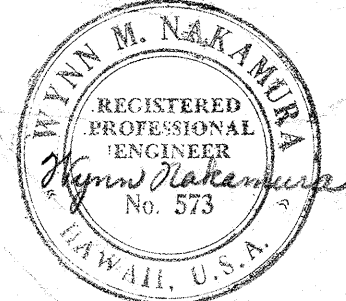

BELT, COLLINS & ASSOC., LTD.
Civil and Structural Engineers

HAWAII STATE HIGHWAY DEPARTMENT
STATE OF HAWAII


HIGHWAY LIGHTING PLAN

MIDDLE STREET BU-065-1(1) UNIT 3
LUNALILO FREEWAY BU-072-1(2) UNIT 4

SHEET No. 2 OF 3 SHEETS

\$174.76 \$161.74 119

FED. ROAD DIST. NO.	STATE	FED. AID PROJ. NO.	FISCAL YEAR	SHEET NO.	TOTAL SHEETS
HAWAII	HAWAII	BU-065-1(1)	1960	77	115
		BU-065-1(2)	1960	75	115

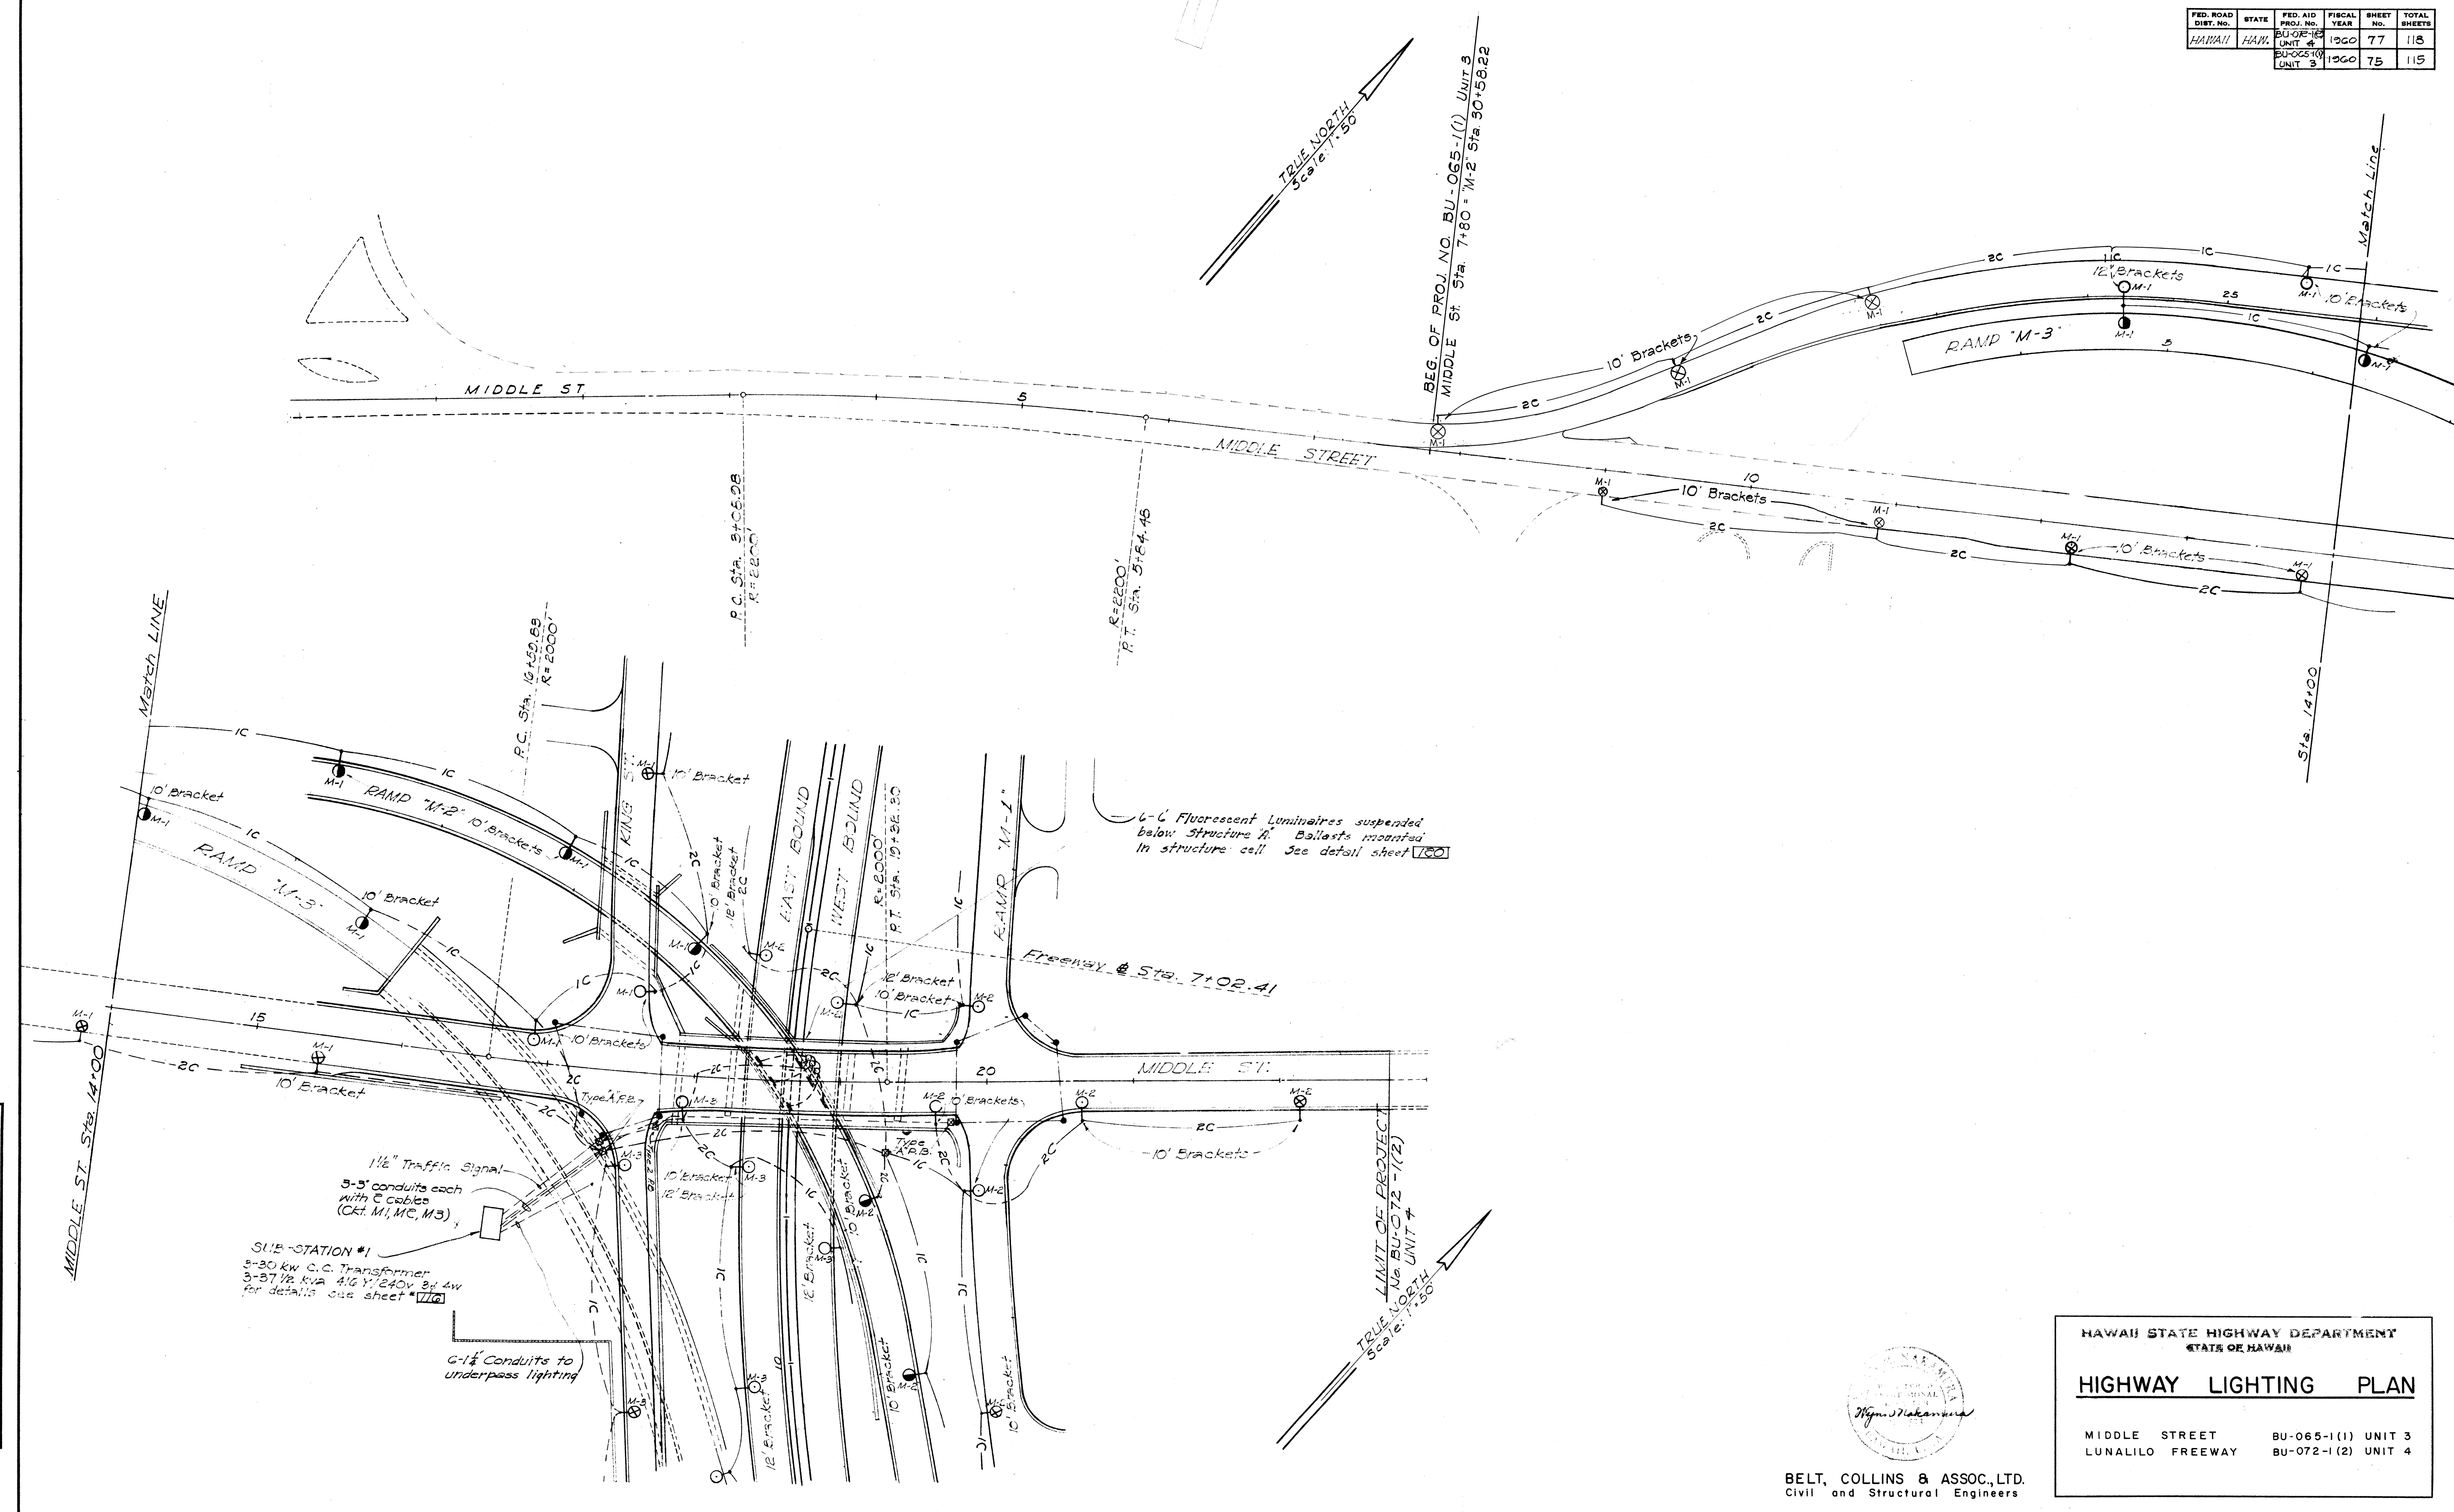

SURVEY PLOTTED BY	DATE
DESIGNED BY	8-57
DRAWN BY	8-57
NOTE BOOK	
QUANTITIES CHECKED BY	
CHECKED BY	

BELT, COLLINS & ASSOC., LTD.
Civil and Structural Engineers




HAWAII STATE HIGHWAY DEPARTMENT
STATE OF HAWAII

HIGHWAY LIGHTING PLAN

MIDDLE STREET BU-065-1(1) UNIT 3
LUNALILO FREEWAY BU-072-1(2) UNIT 4


SHEET NO. 3 OF 3 SHEETS

FED. ROAD DIST. NO.	STATE	FED. AID PROJ. NO.	FISCAL YEAR	SHEET NO.	TOTAL SHEETS
HAWAII	HAW.	US-0720(3)	1960	53	79
		BU-072-1(2)	1960	81	118
		BU-065-1(1)	1960	76	115

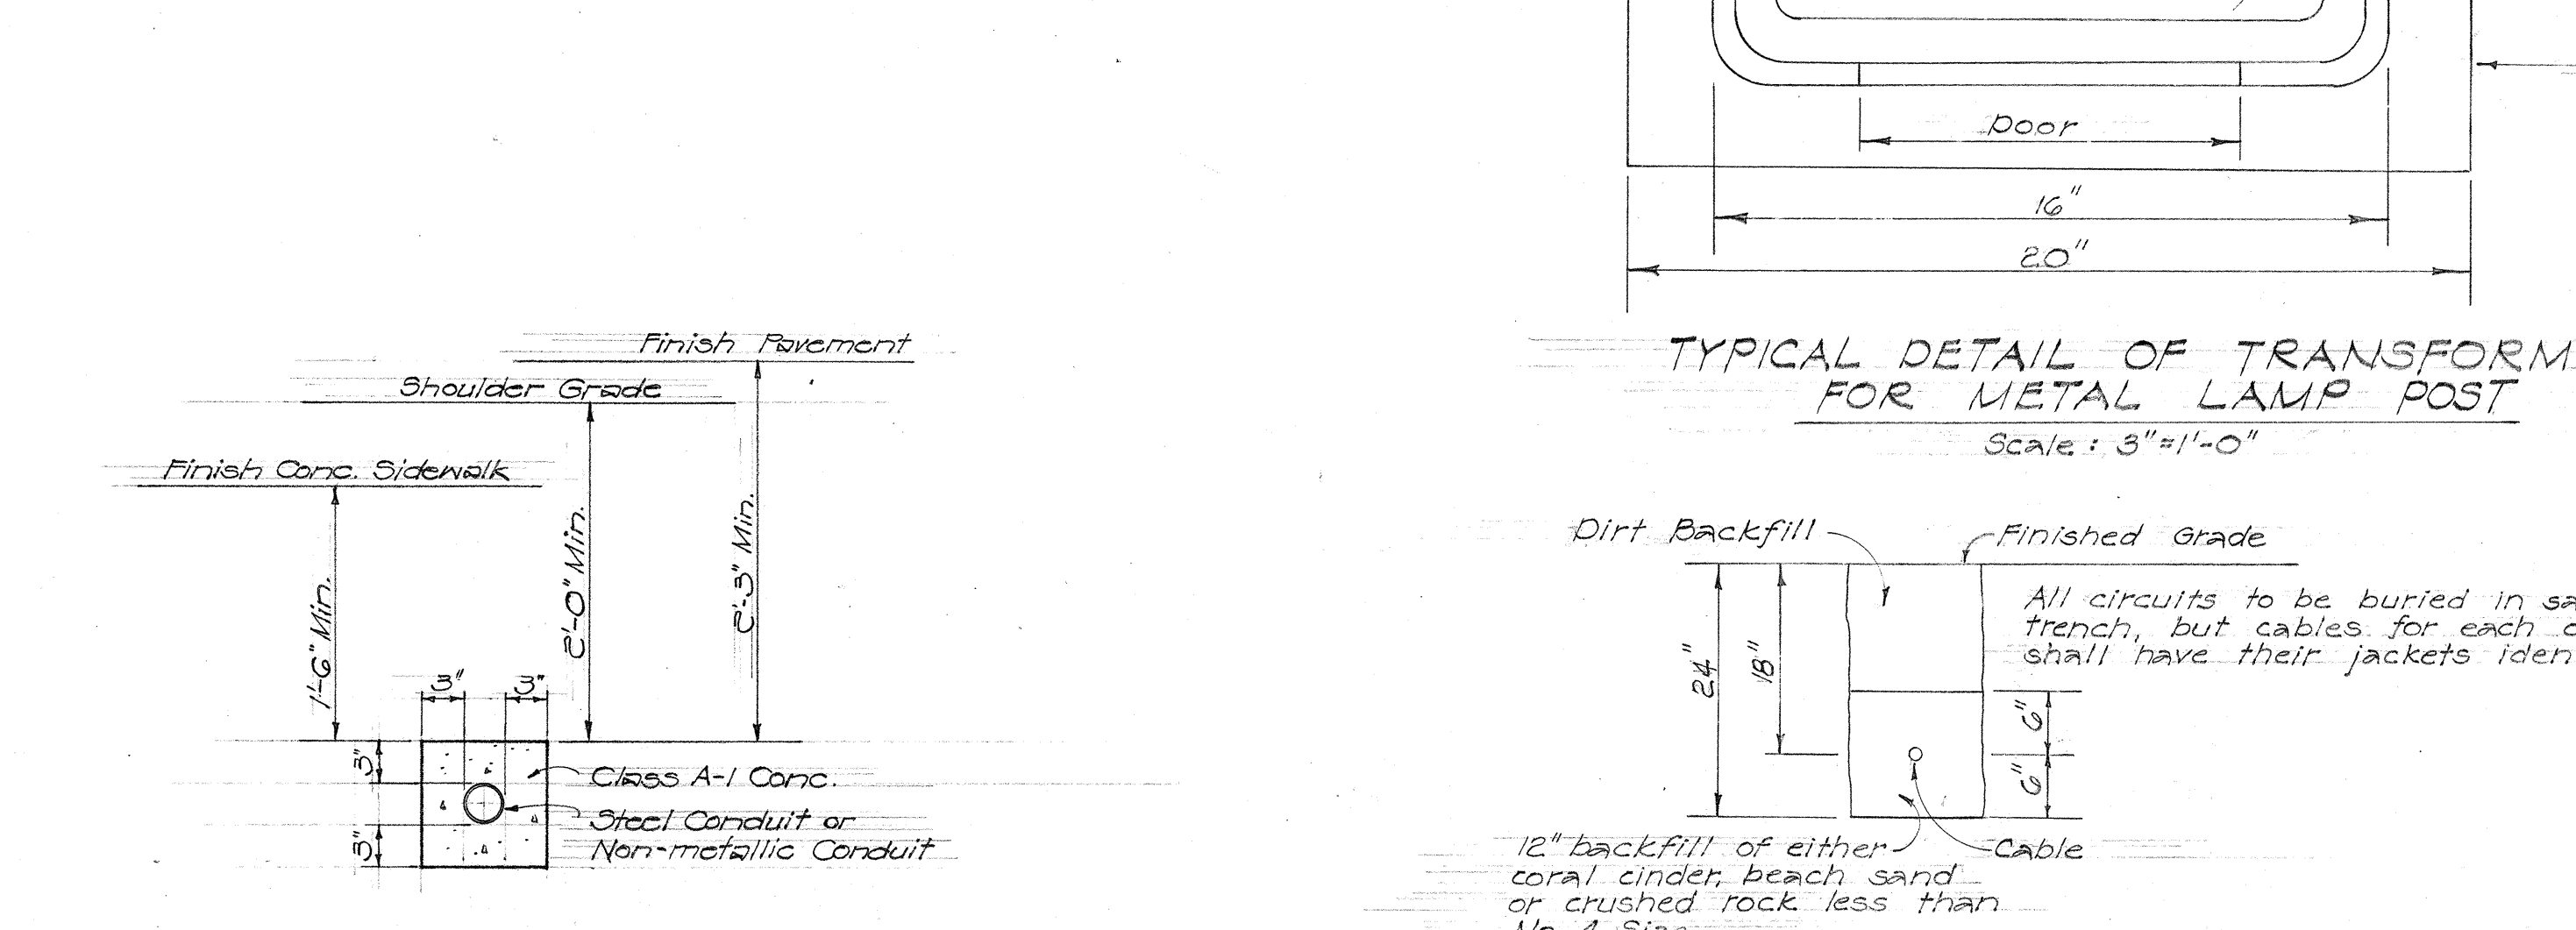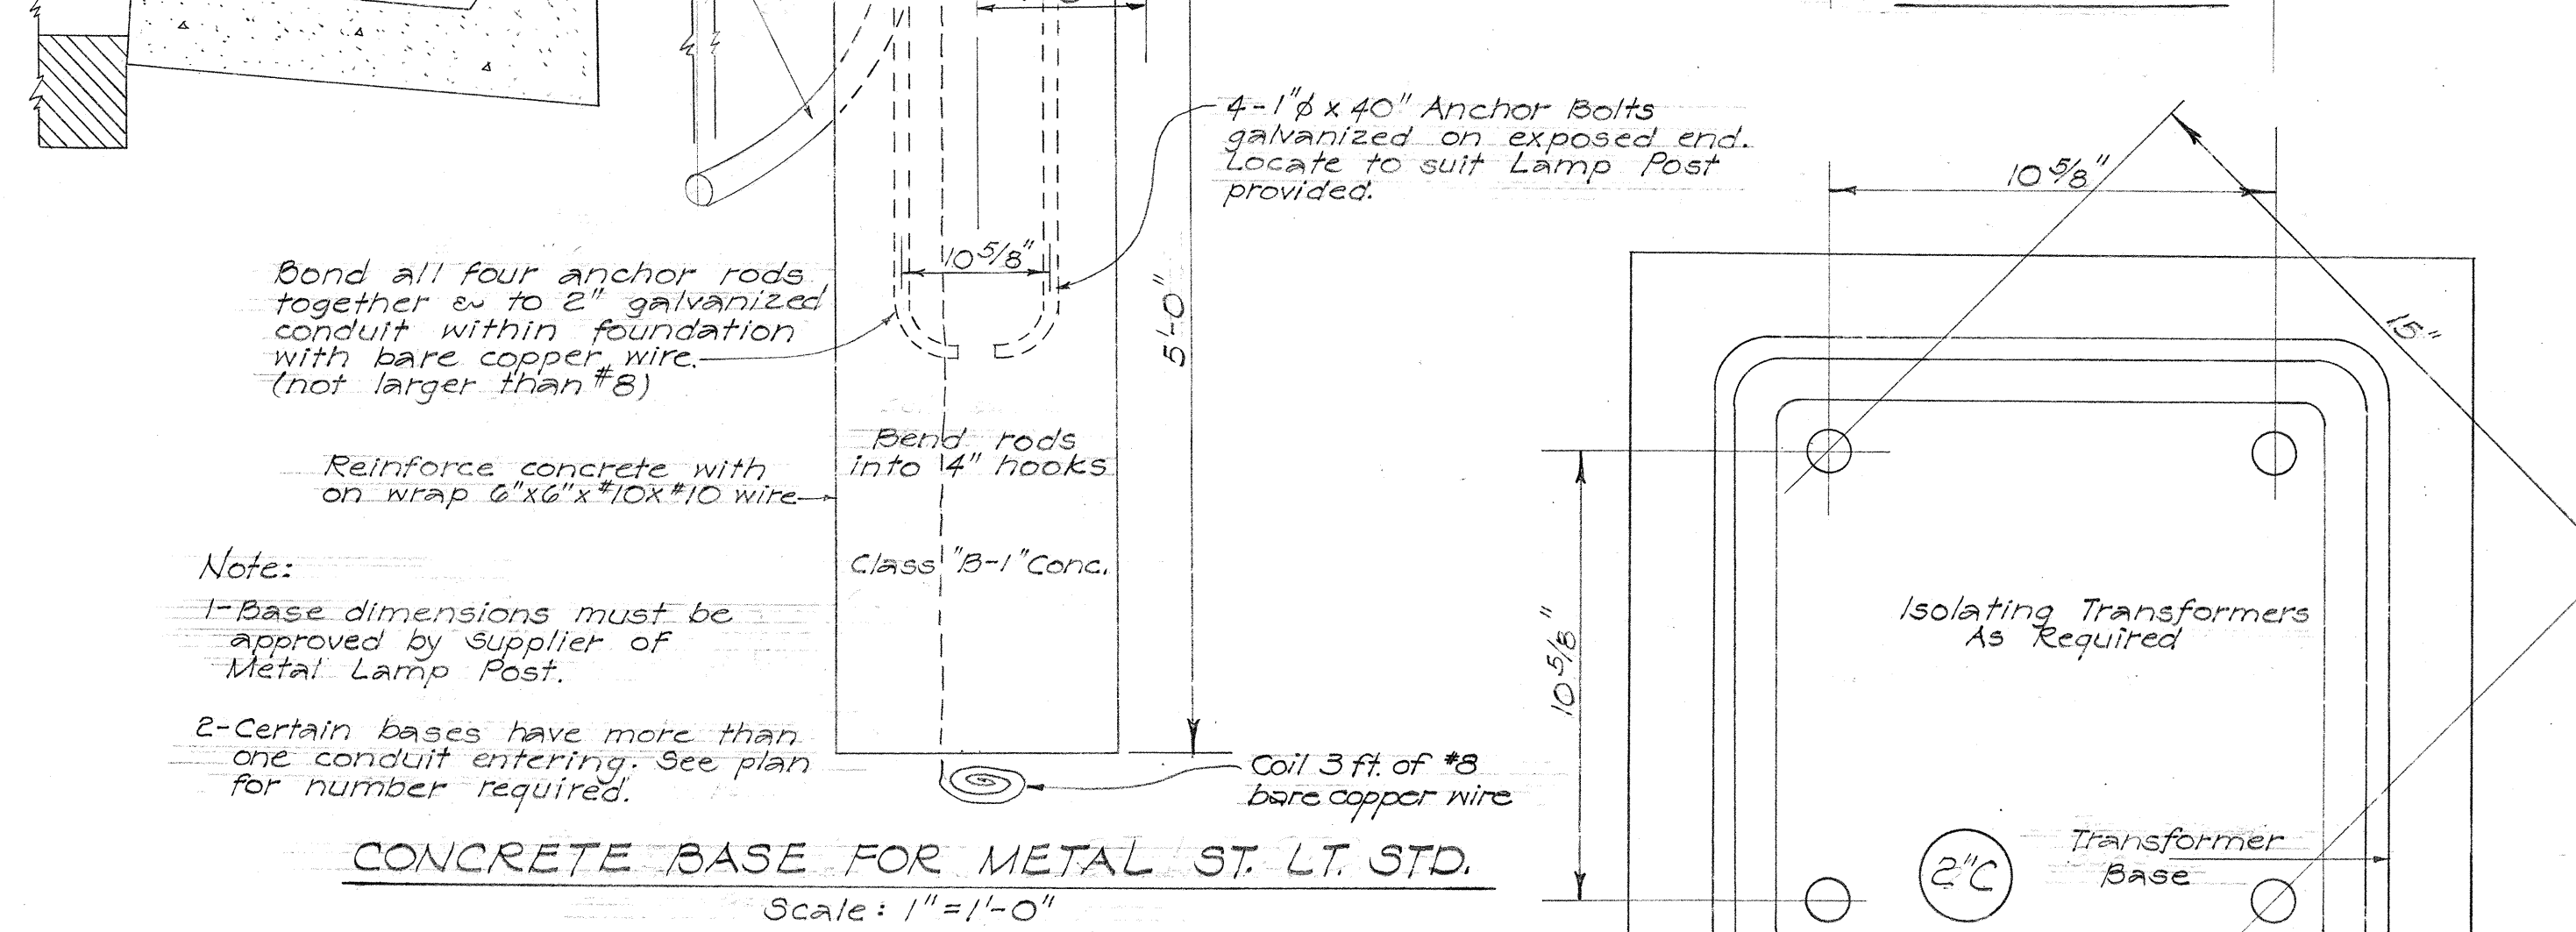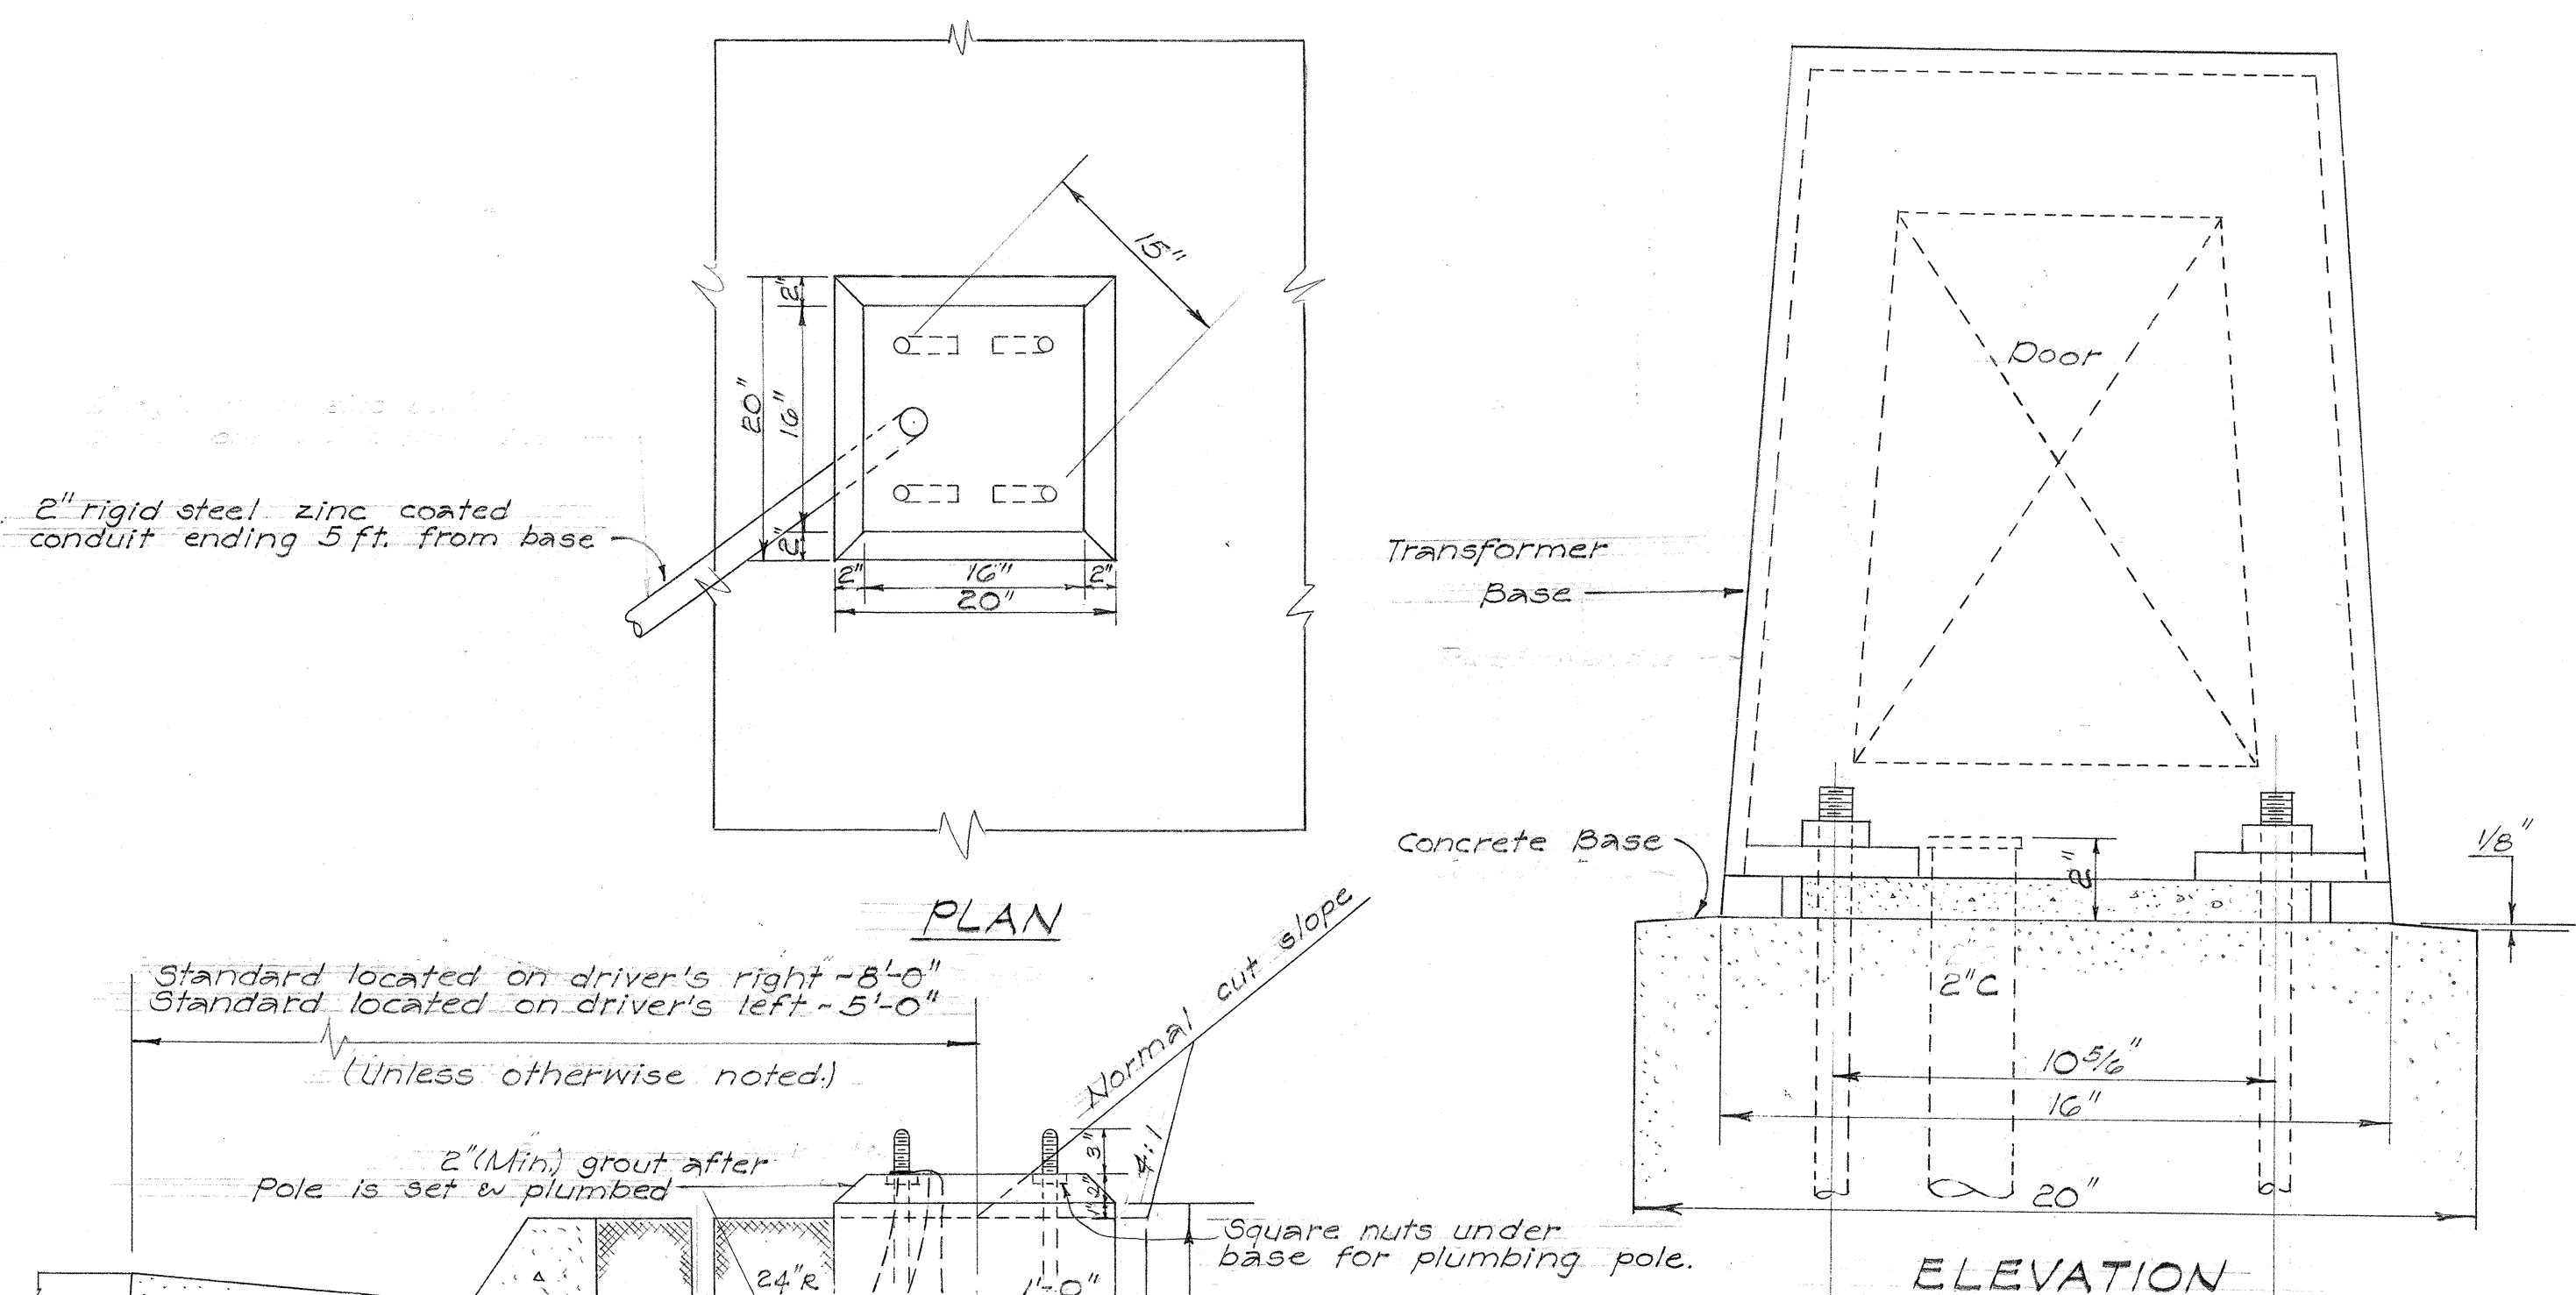


TYPICAL DETAIL OF CONDUITS ENCASED IN CONCRETE JACKET
Scale: 1"=1'-0"


DETAIL OF BACKFILL FOR DIRECTLY BURIED CABLES
Scale: 3/4"=1'-0"

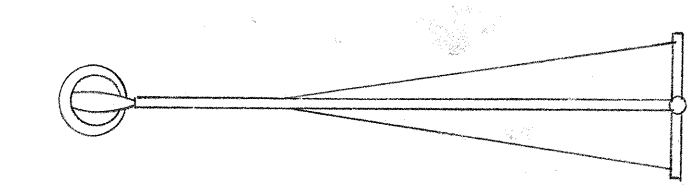


PLAN

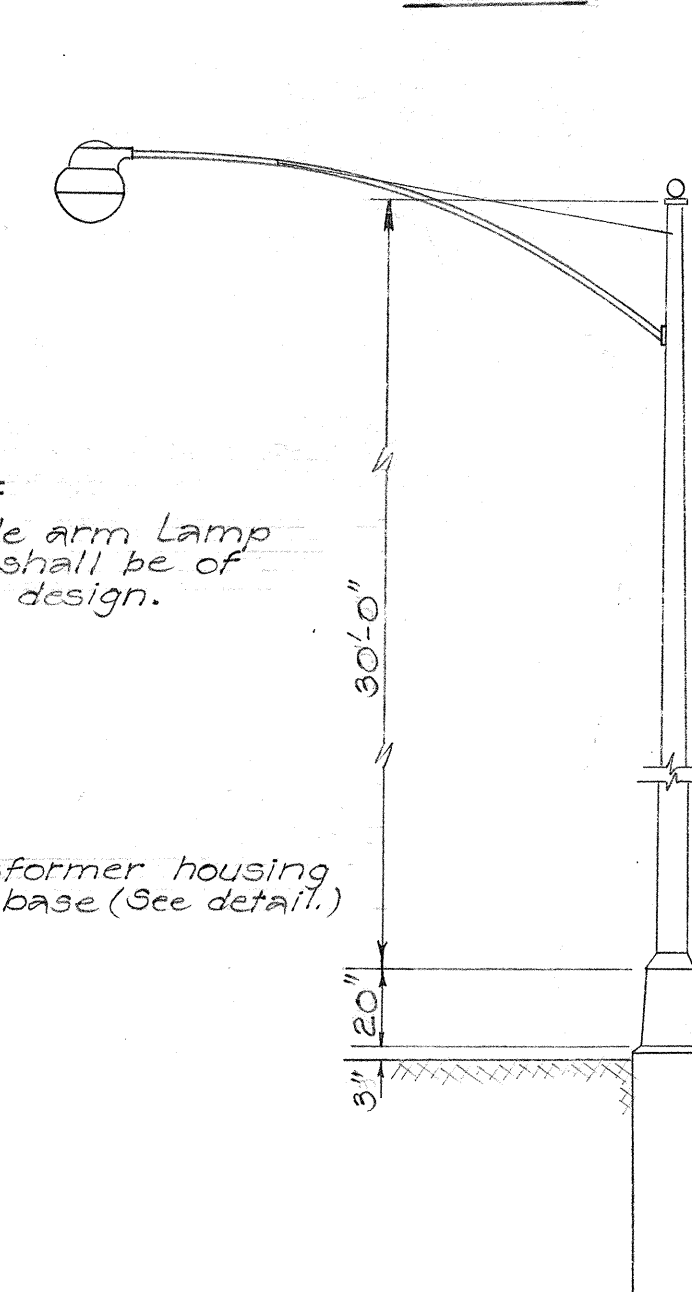


TYPICAL SINGLE ARM METAL LAMP POST
Scale: 1/4"=1'-0"

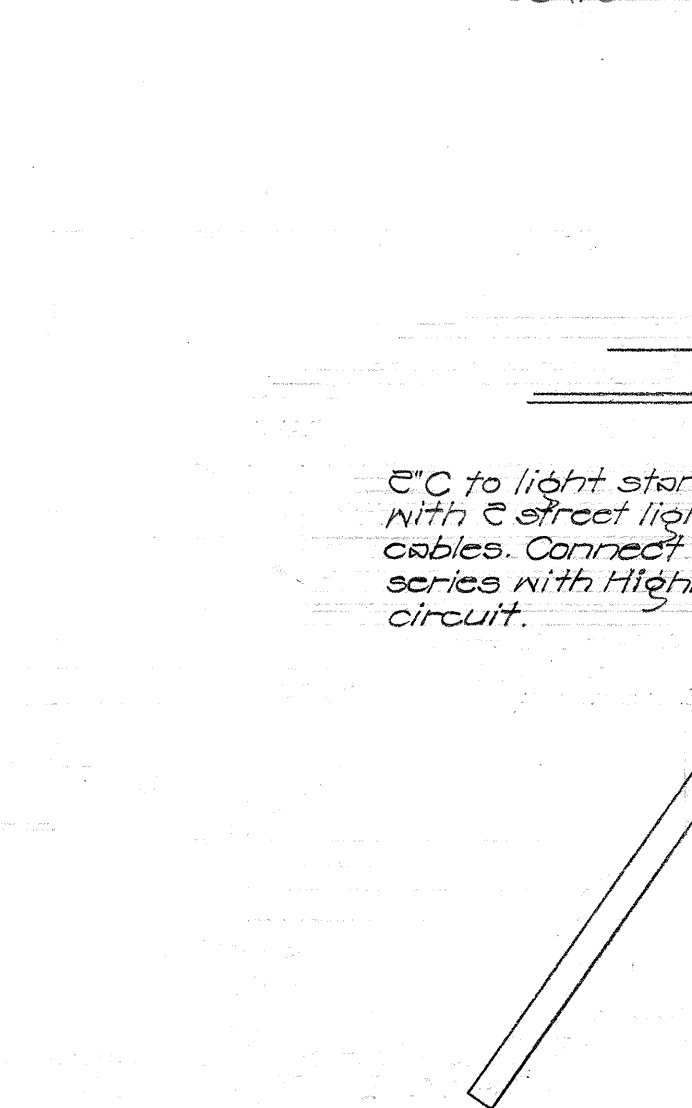


LIGHTING LAYOUT KALIHI STREAM BRIDGE
Scale: 1"=10'

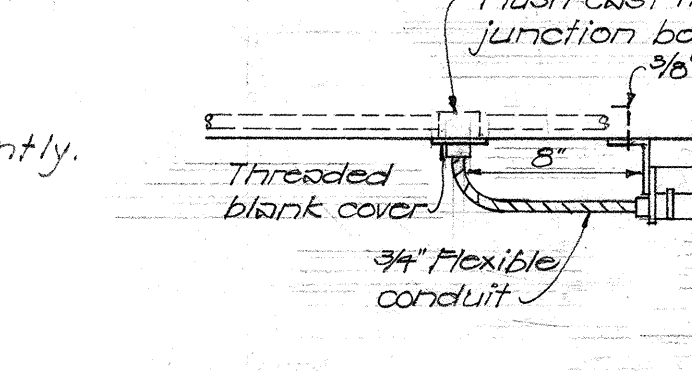

LONGITUDINAL SECTION
Scale: 1"=10'

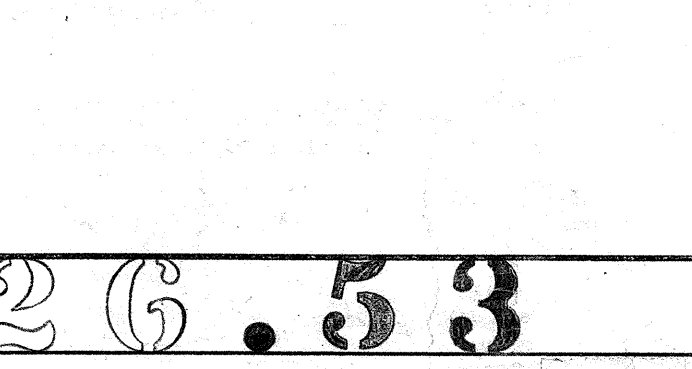

FIXTURE MOUNTING DETAIL
Not to scale

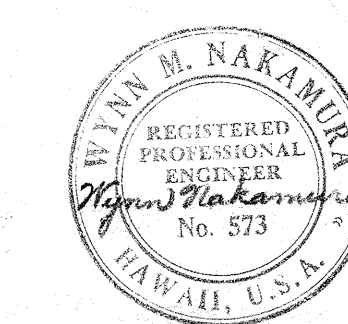

HAWAII STATE HIGHWAY DEPARTMENT
STATE OF HAWAII
ELECTRICAL DETAILS
LIGHTING ON KALIHI STREAM BRIDGE
MOANALUA ROAD US-5-0720(3) UNIT 3
LUNALILO FREEWAY BU-072-1(2) UNIT 4
MIDDLE STREET BU-065-1(1) UNIT 5

BELT, COLLINS & ASSOC., LTD.
Civil and Structural Engineers

SHEET NO. 4 OF 6 SHEETS


\$526.53

\$174.51


\$161.76

115

FED. ROAD DIST. NO.	STATE	FED. AID PROJ. NO.	FISCAL YEAR	SHEET NO.	TOTAL SHEETS
HAWAII	HAW.	US-5-0720(3) UNIT 3	1960	54	79
		BU-072-1(E) UNIT 4	1960	86	118
		BU-065-1(K) UNIT 2	1960	77	115

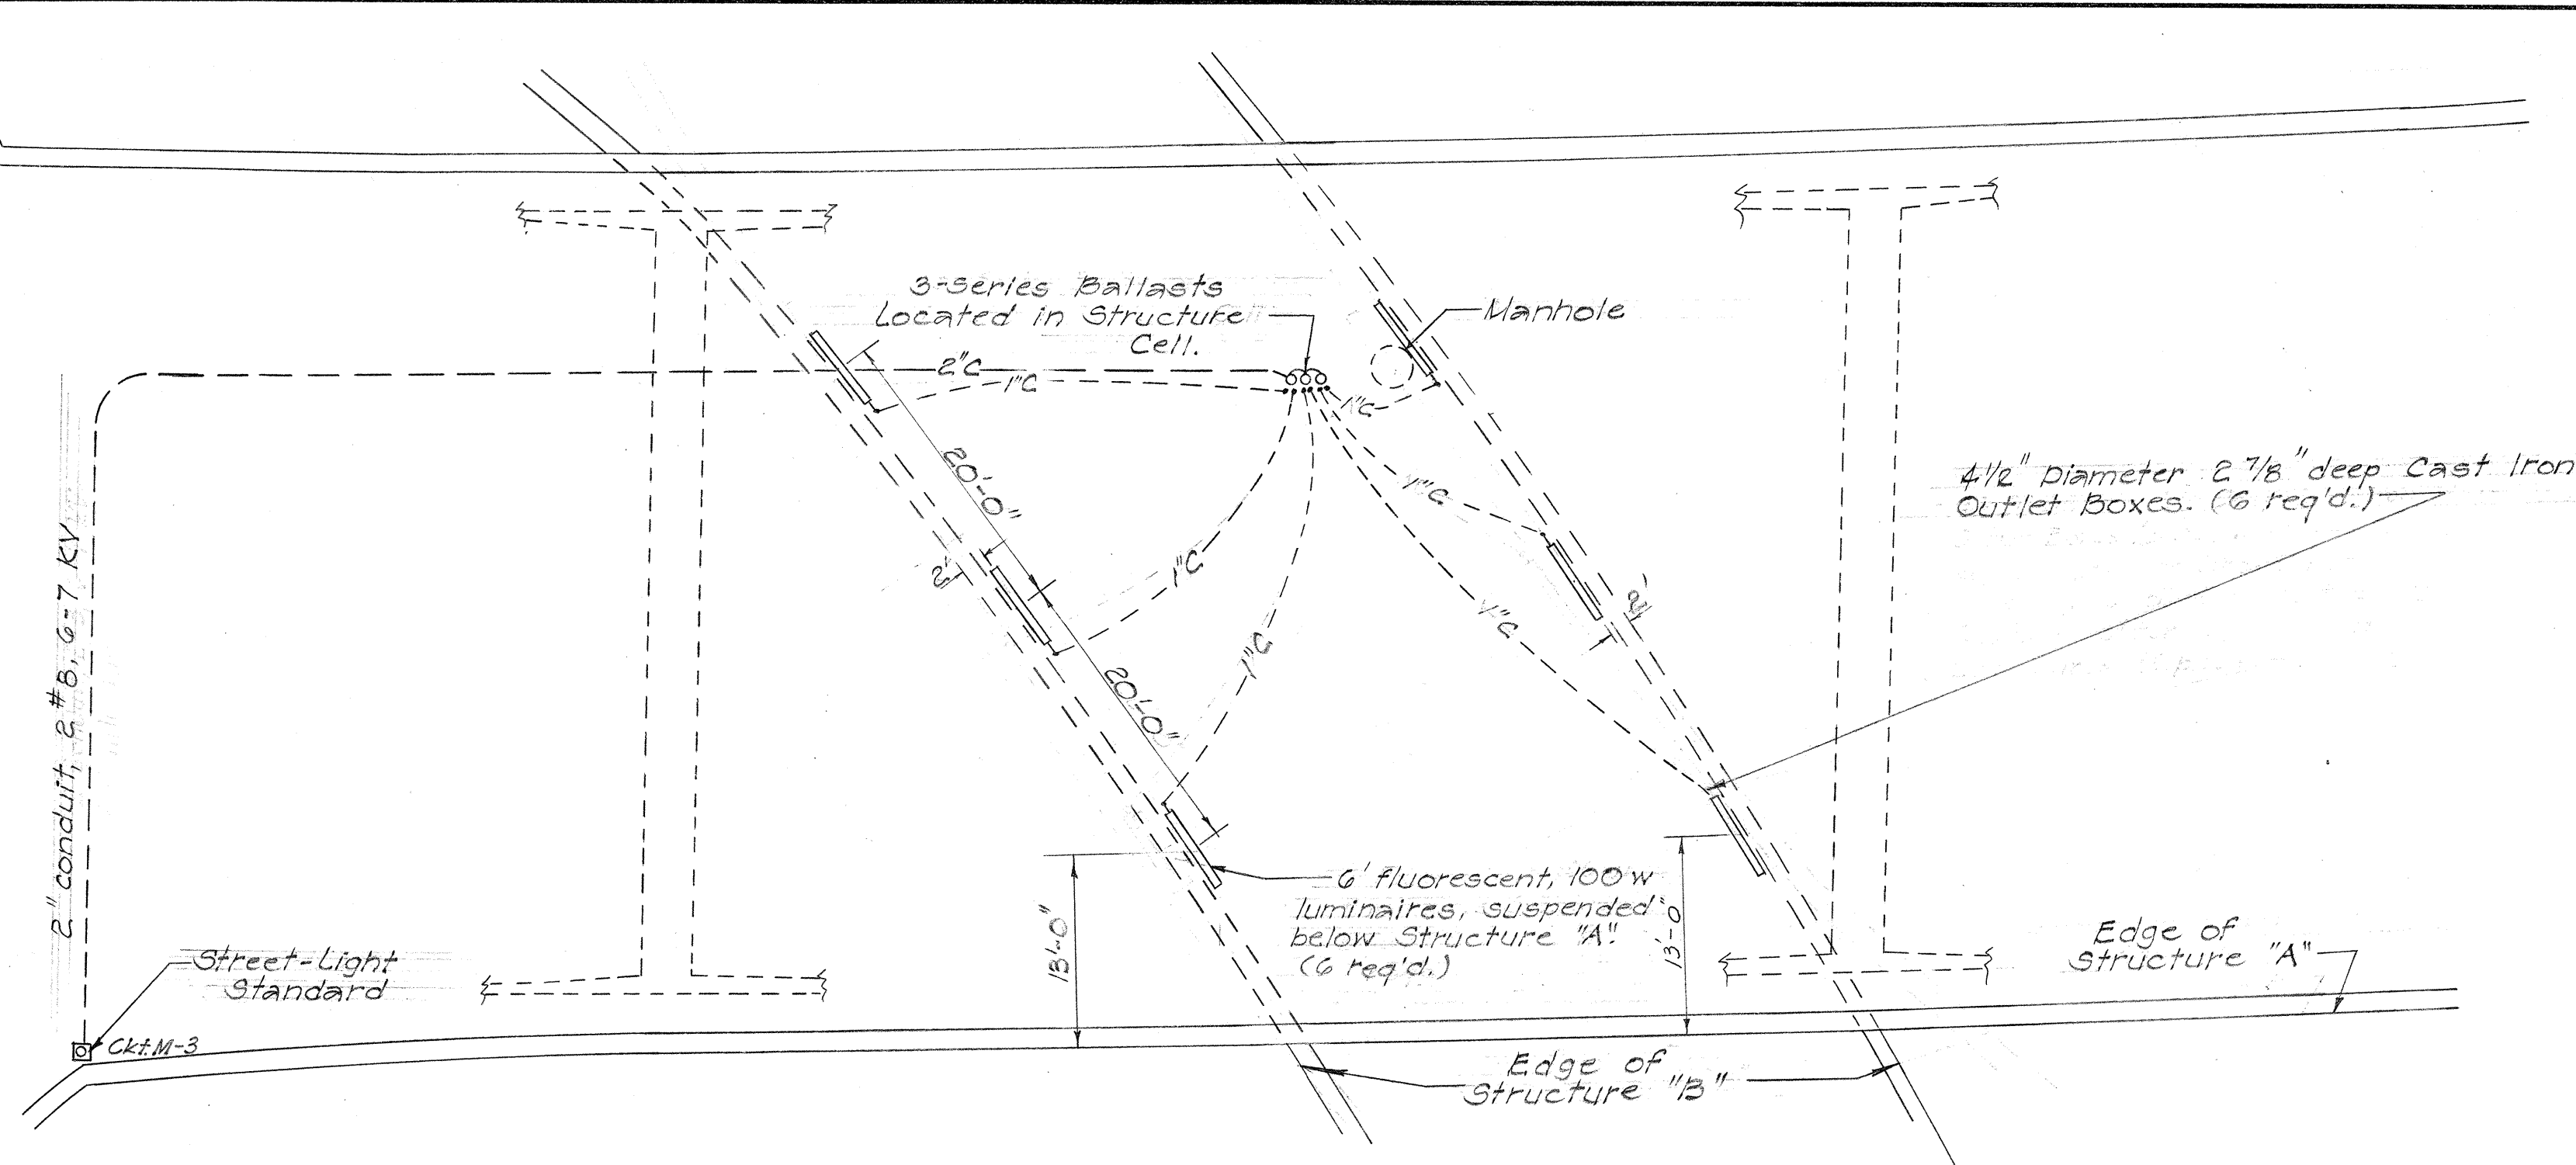


PLAN
FLUORESCENT LUMINAIRES AT STRUCTURE "A"
Scale: 1"=10'

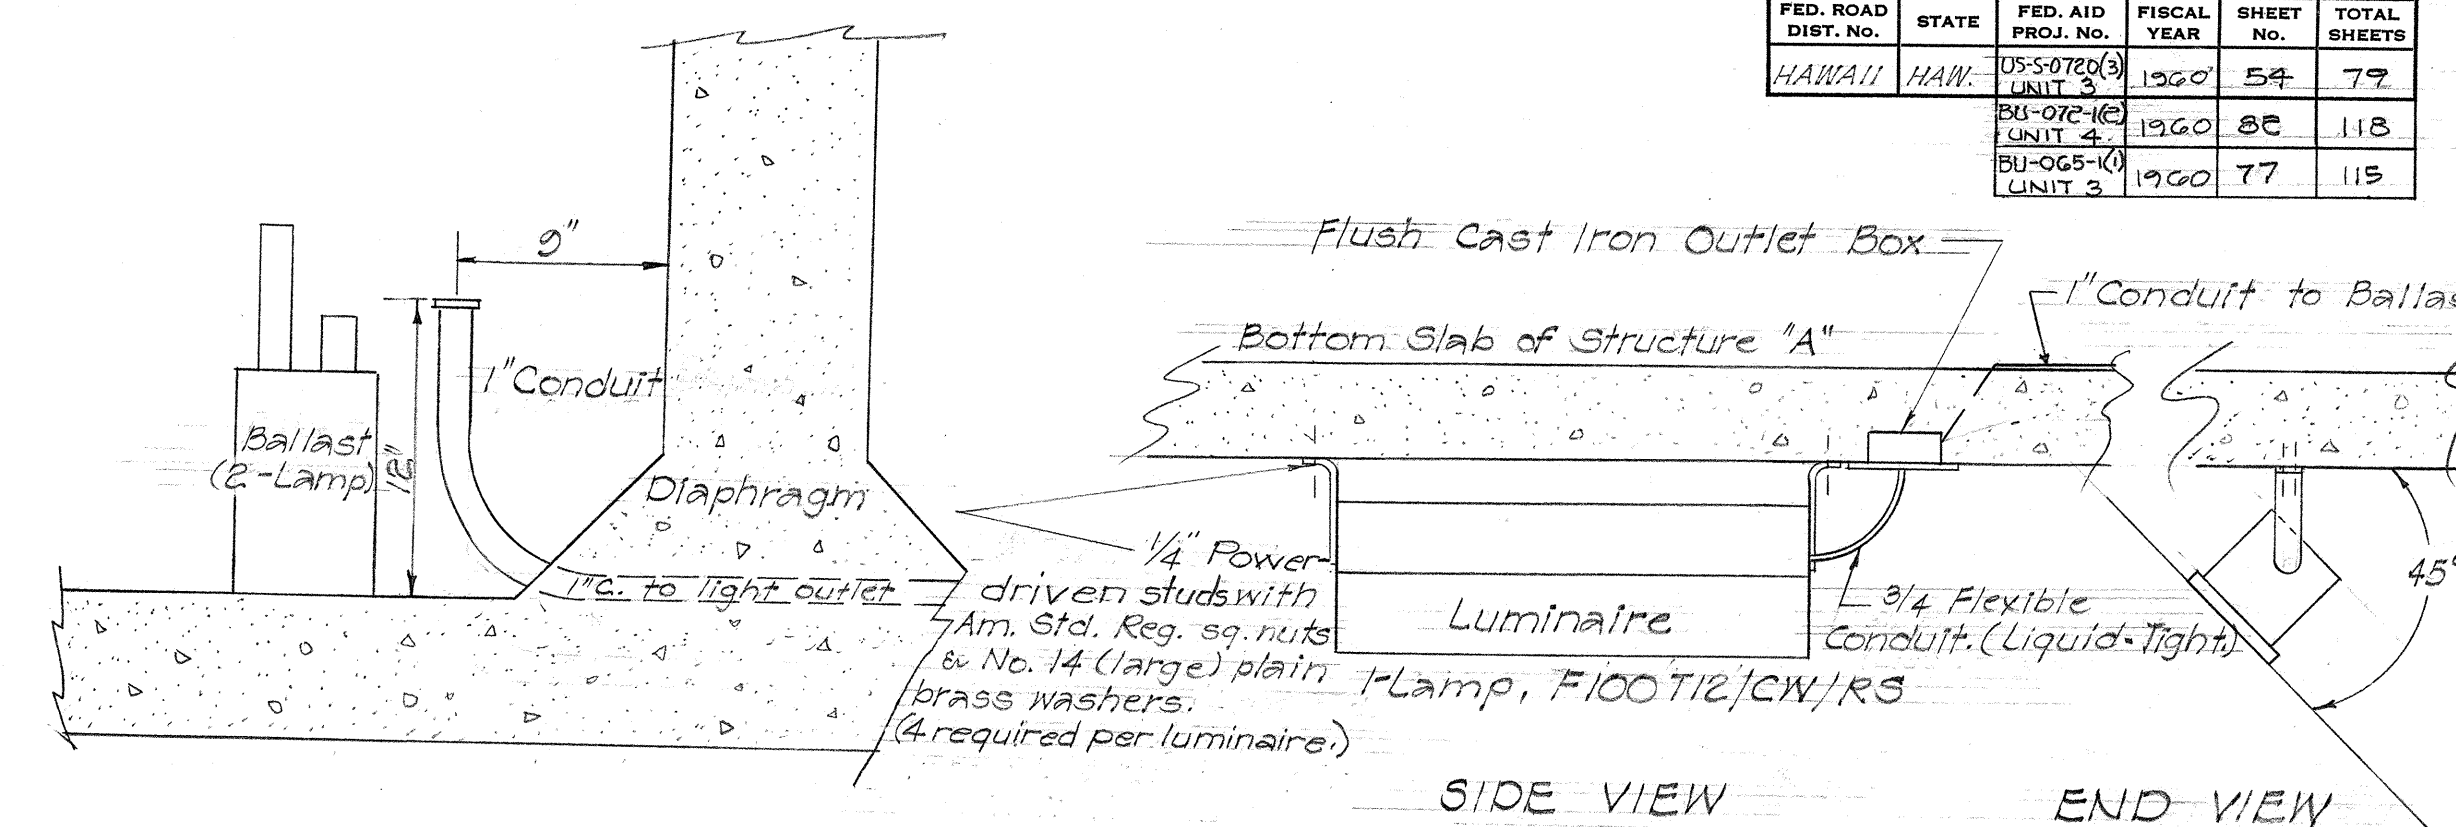


DETAIL OF BALLAST
IN STRUCTURE CELL

DETAIL OF FLUORESCENT
LUMINAIRE AT STRUCTURE "A"
Scale: $\frac{1}{8}" = 1'-0"$

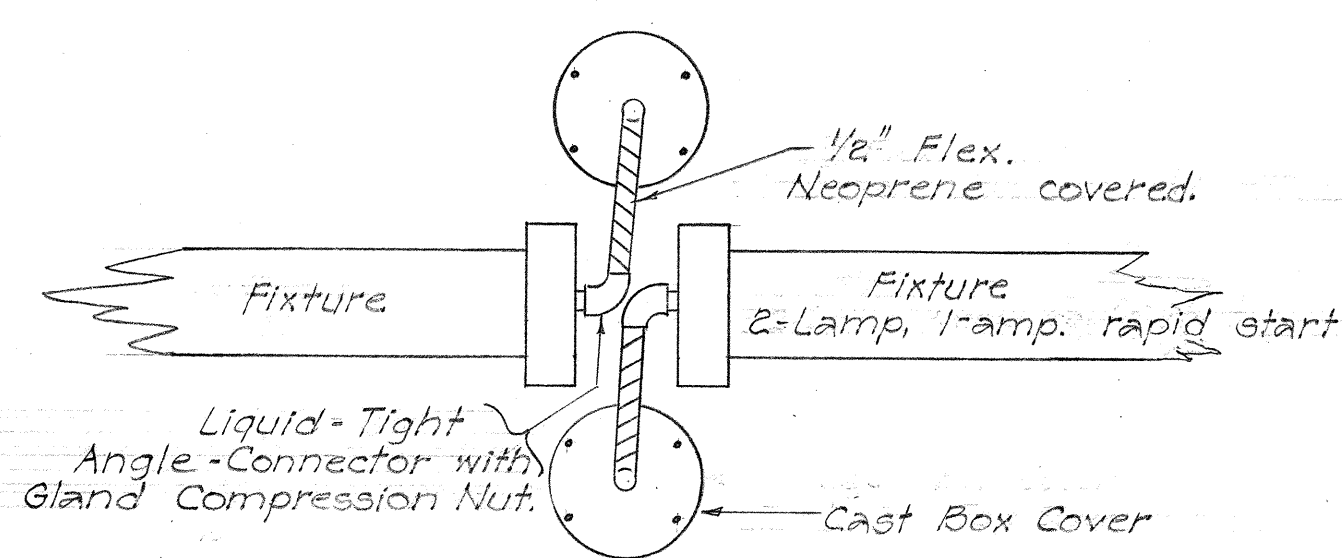


DETAIL OF FIXTURE CONNECTION TO OUTLET BOXES
No Scale

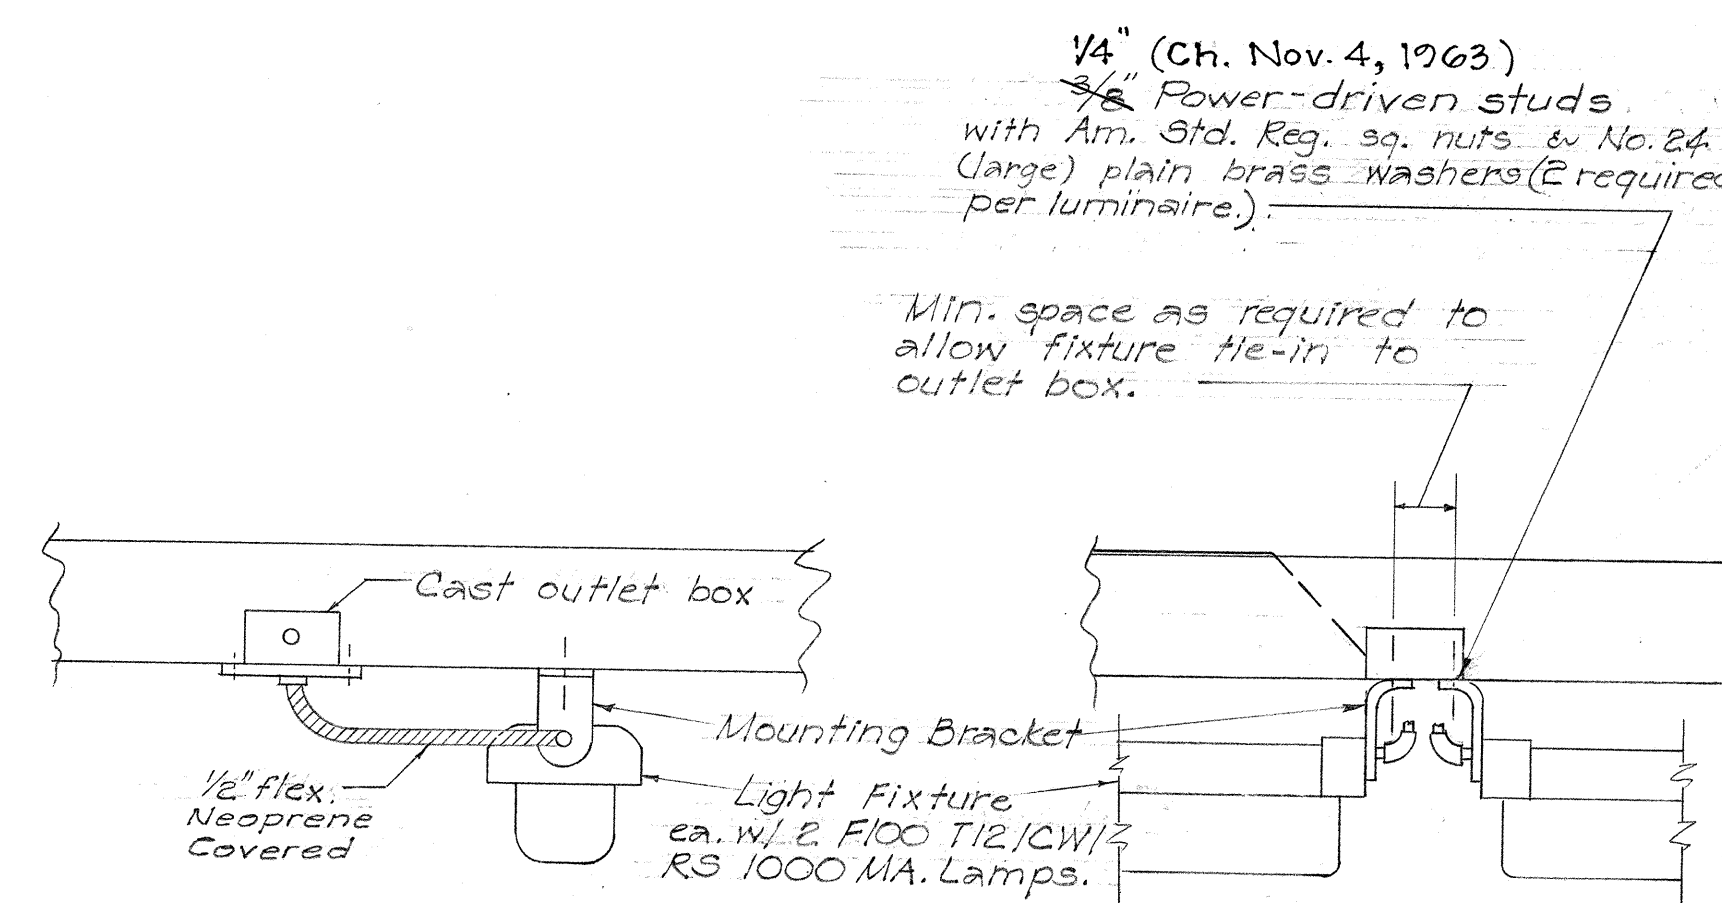

END VIEW
No Scale


SIDE VIEW
No Scale

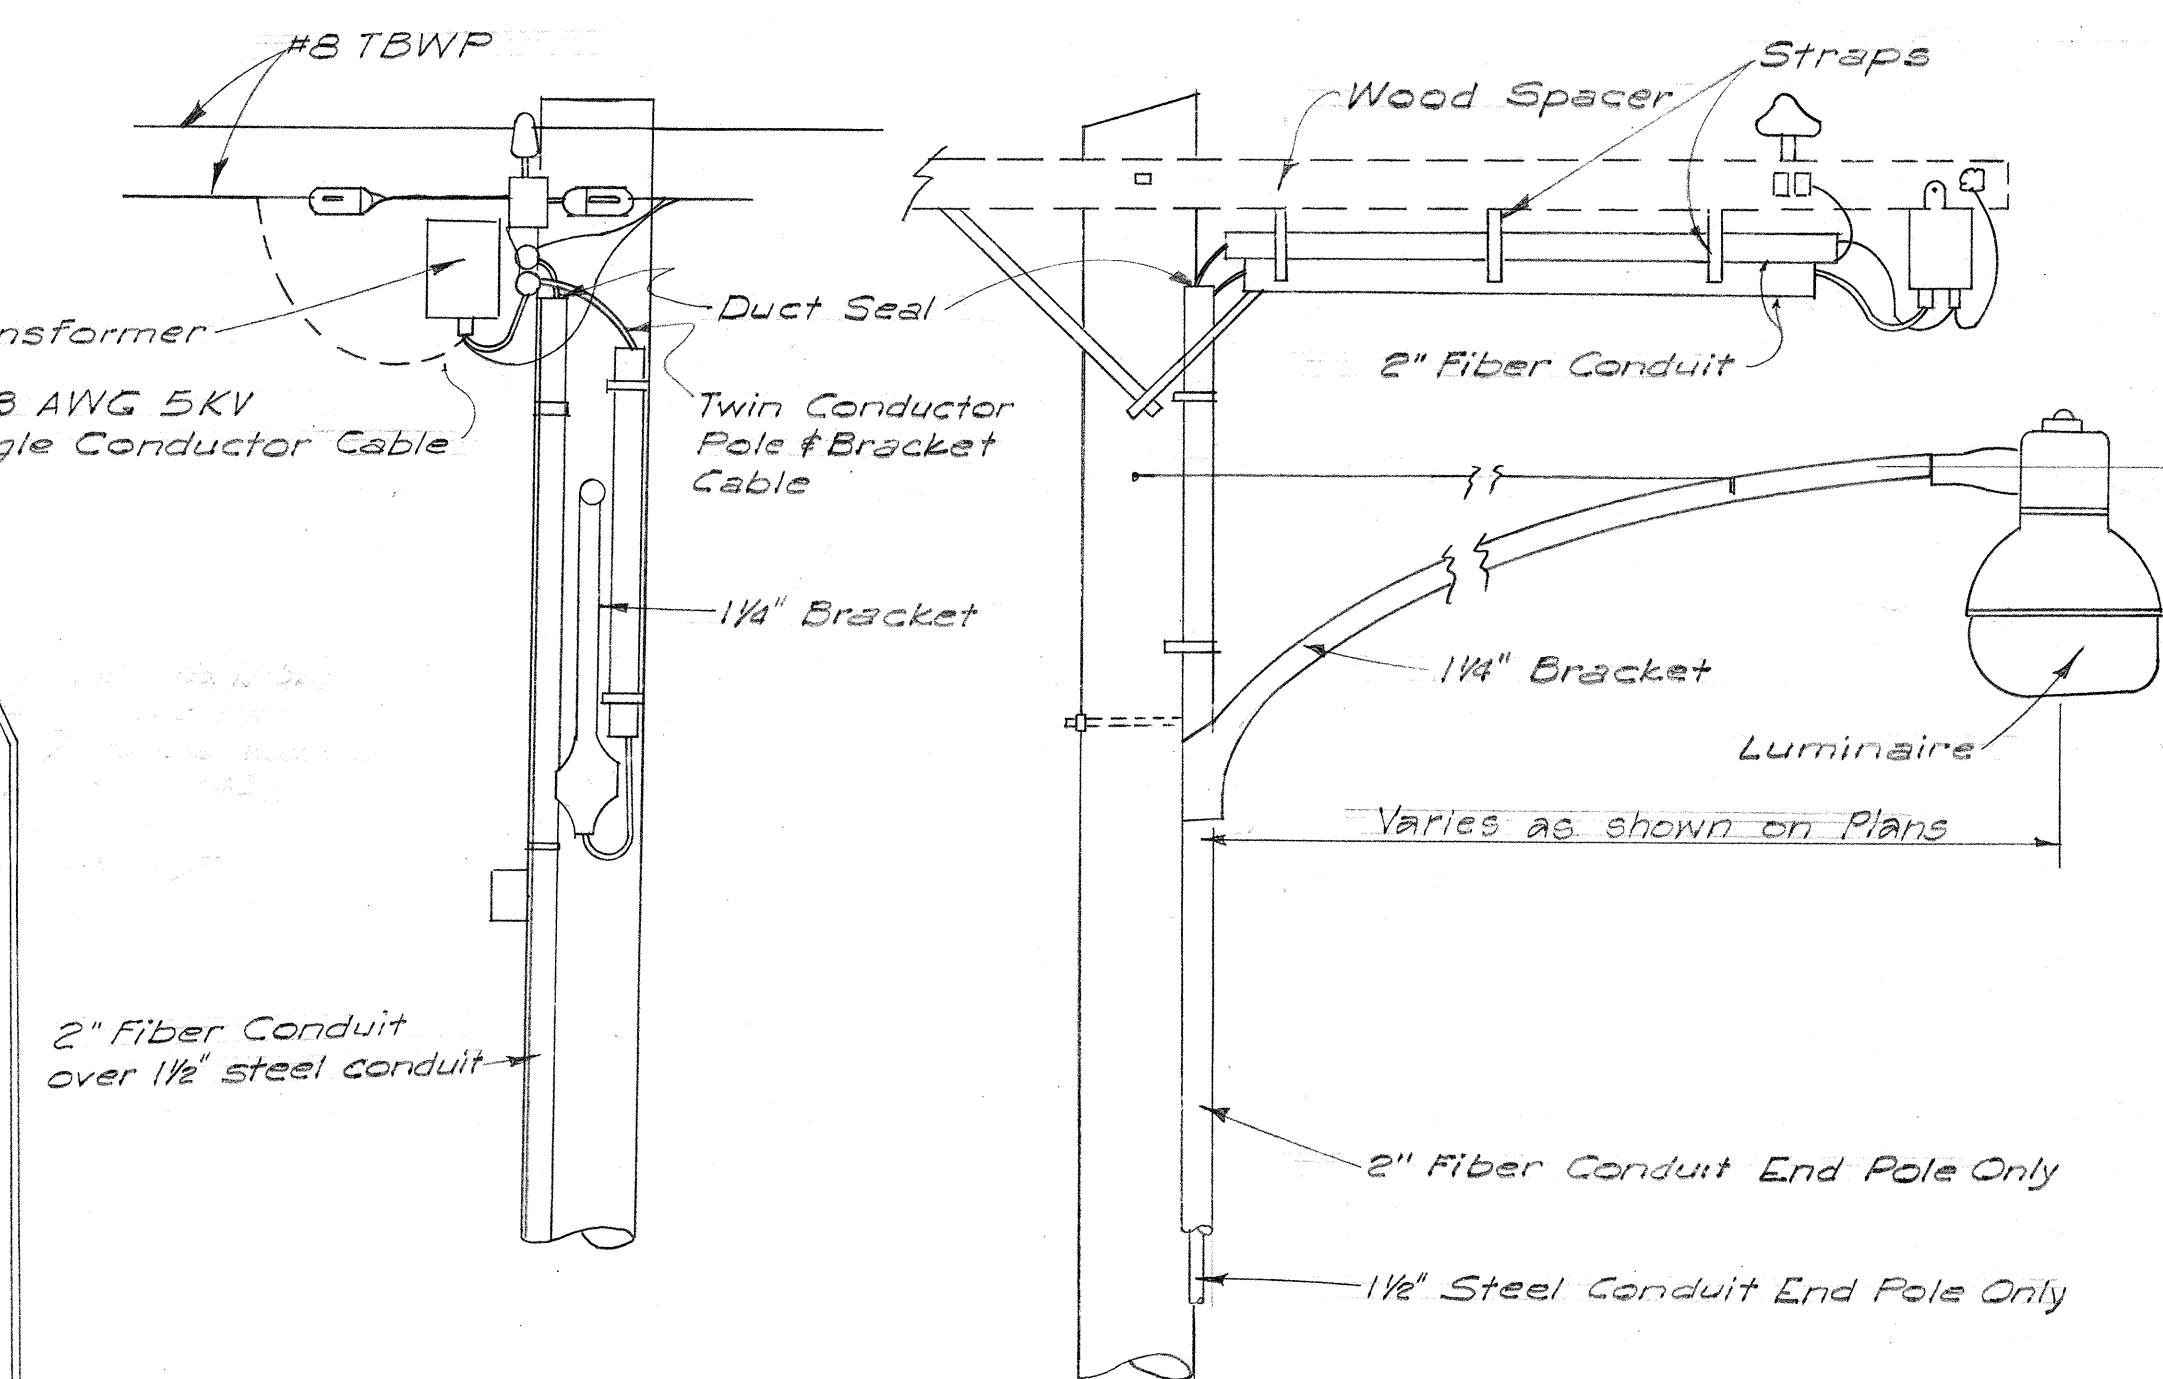

FRONT ELEVATION SIDE ELEVATION

MOUNTING DETAIL OF LUMINAIRE
BRACKET ON UTILITY POLE


NOTE: Pole Top Isolating Transformers Shall Be Used Where Lamp Posts are Mounted on Wing Walls of Structure "A"

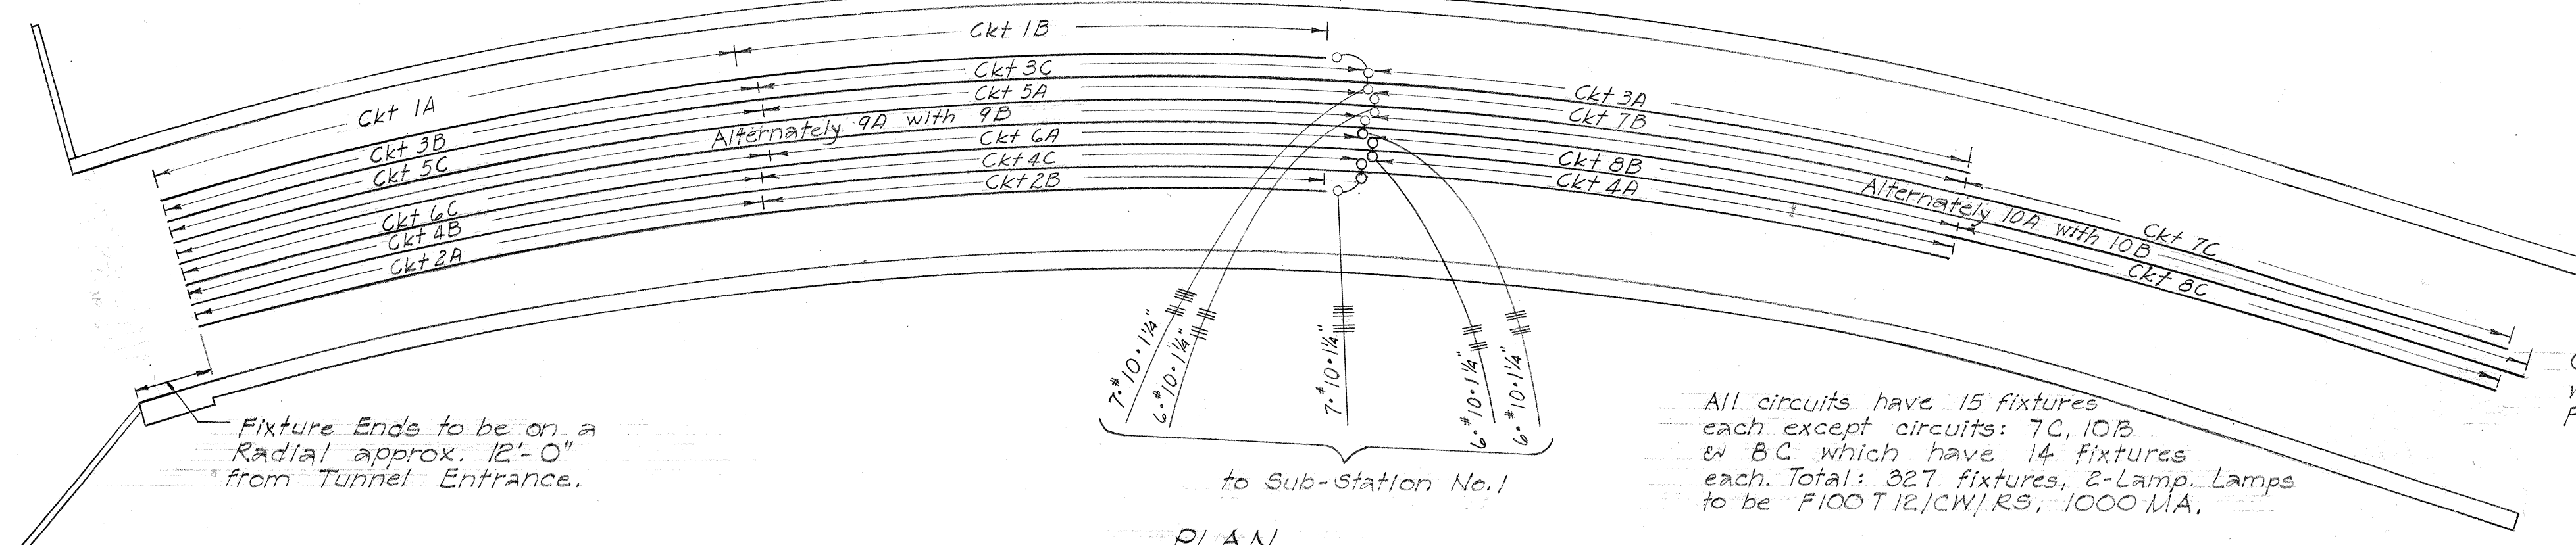

PLAN
LIGHTING LAYOUT ~ STRUCTURE "C-D"
Scale: 1" = 20'

All circuits have 15 fixtures each except circuits: 7C, 10B & 8C which have 14 fixtures each. Total: 327 fixtures, 2-Lamp. Lamps to be F100T12/CW/RS, 1000 MA.

Center Row to Coincide
with $\frac{1}{2}$ of Road Bed.
Fixture Rows to be 3'-0" o.c.

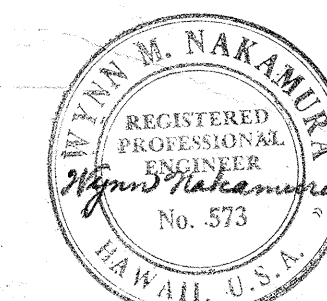

HAWAII STATE HIGHWAY DEPARTMENT
STATE OF HAWAII

ELECTRICAL DETAILS

LIGHTING LAYOUT ON STRUCTURES

MIDDLE STREET BU-065-1(1) UNIT 3
LUNALILO FREEWAY BU-072-1(2) UNIT 4
MOANALUA ROAD US-S-0720(3) UNIT 3

SHEET No. 5 OF 6 SHEETS

§ 526.54

\$ 174.82

SHEET NO. 3 OF 6

S 1 G 1

120