



FED. ROAD DIST. NO.	STATE	FED. AID PROJ. NO.	FISCAL YEAR	SHEET NO.	TOTAL SHEETS
HAWAII	HAW.	STP-8930(2)	2007	257	331

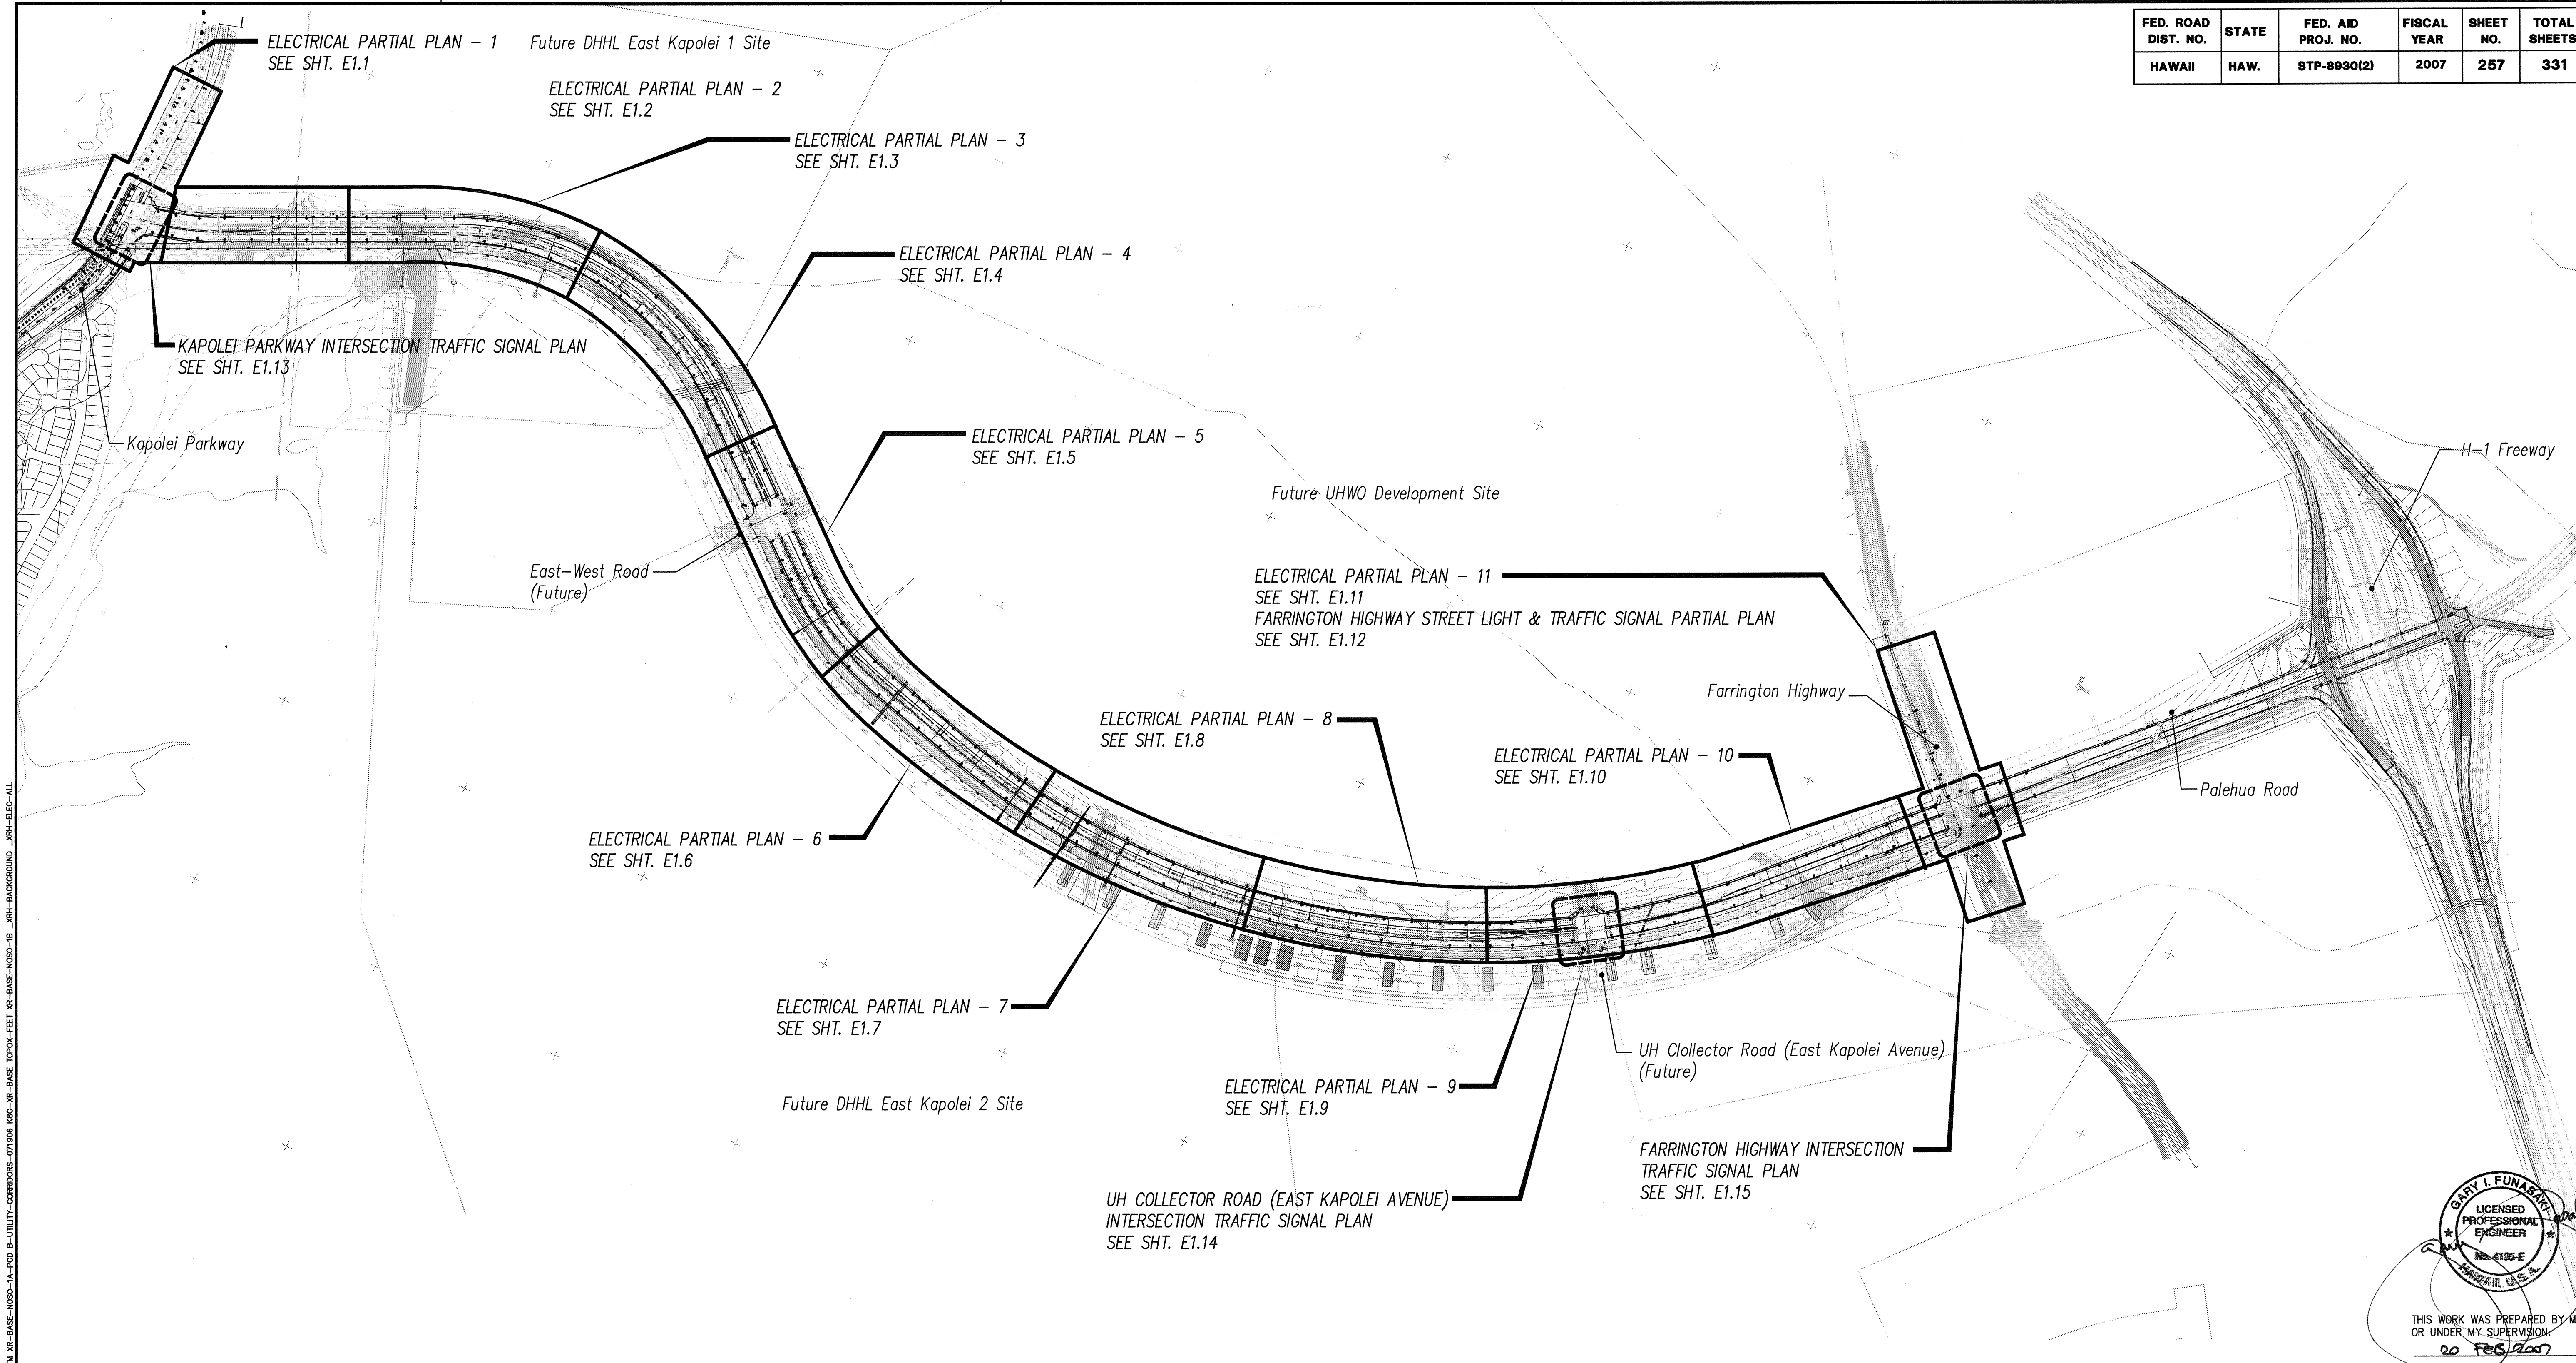


DESIGNED BY	DATE
DRAWN BY	
CHECKED BY	
NOTED BY	
QUANTITIES BY	
DATE	


APPROVED BY:	
HAWAIIAN ELECTRIC COMPANY, INC.	DATE
HAWAIIAN TELCOM	DATE
OCEANIC TIME WARNER CABLE	DATE
SANDWICH ISLES COMMUNICATIONS, INC.	DATE

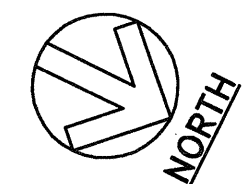

ELECTRICAL SITE PLAN
SCALE: 1"=400'

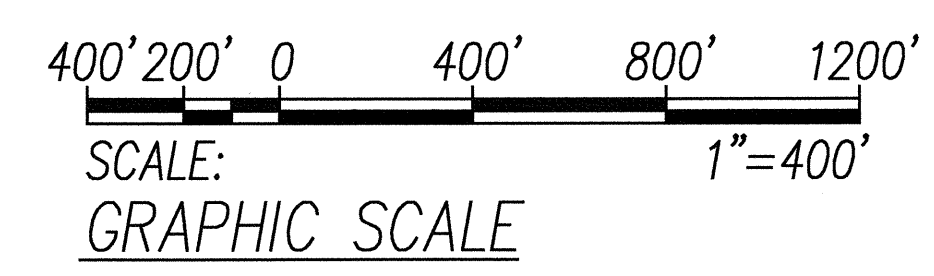

DATE	REVISION

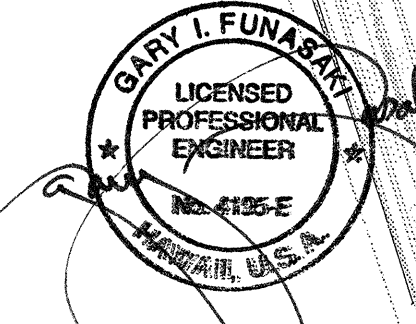
 THIS WORK WAS PREPARED BY ME OR UNDER MY SUPERVISION.
 20 Feb 2007

STATE OF HAWAII
 DEPARTMENT OF TRANSPORTATION
 HIGHWAYS DIVISION
ELECTRICAL SITE PLAN
 North-South Road
 Phase 1B
 F.A.I. Proj. No. STP-8930(2)

Scale: AS NOTED
 Date: Feb 21, 2007
SHEET No. E01 OF 82 SHEETS