


FED. ROAD DIST. NO.	STATE	FED. AID PROJ. NO.	FISCAL YEAR	SHEET NO.	TOTAL SHEETS
HAWAII	HAW.	STP-8930(2)	2007	310	331

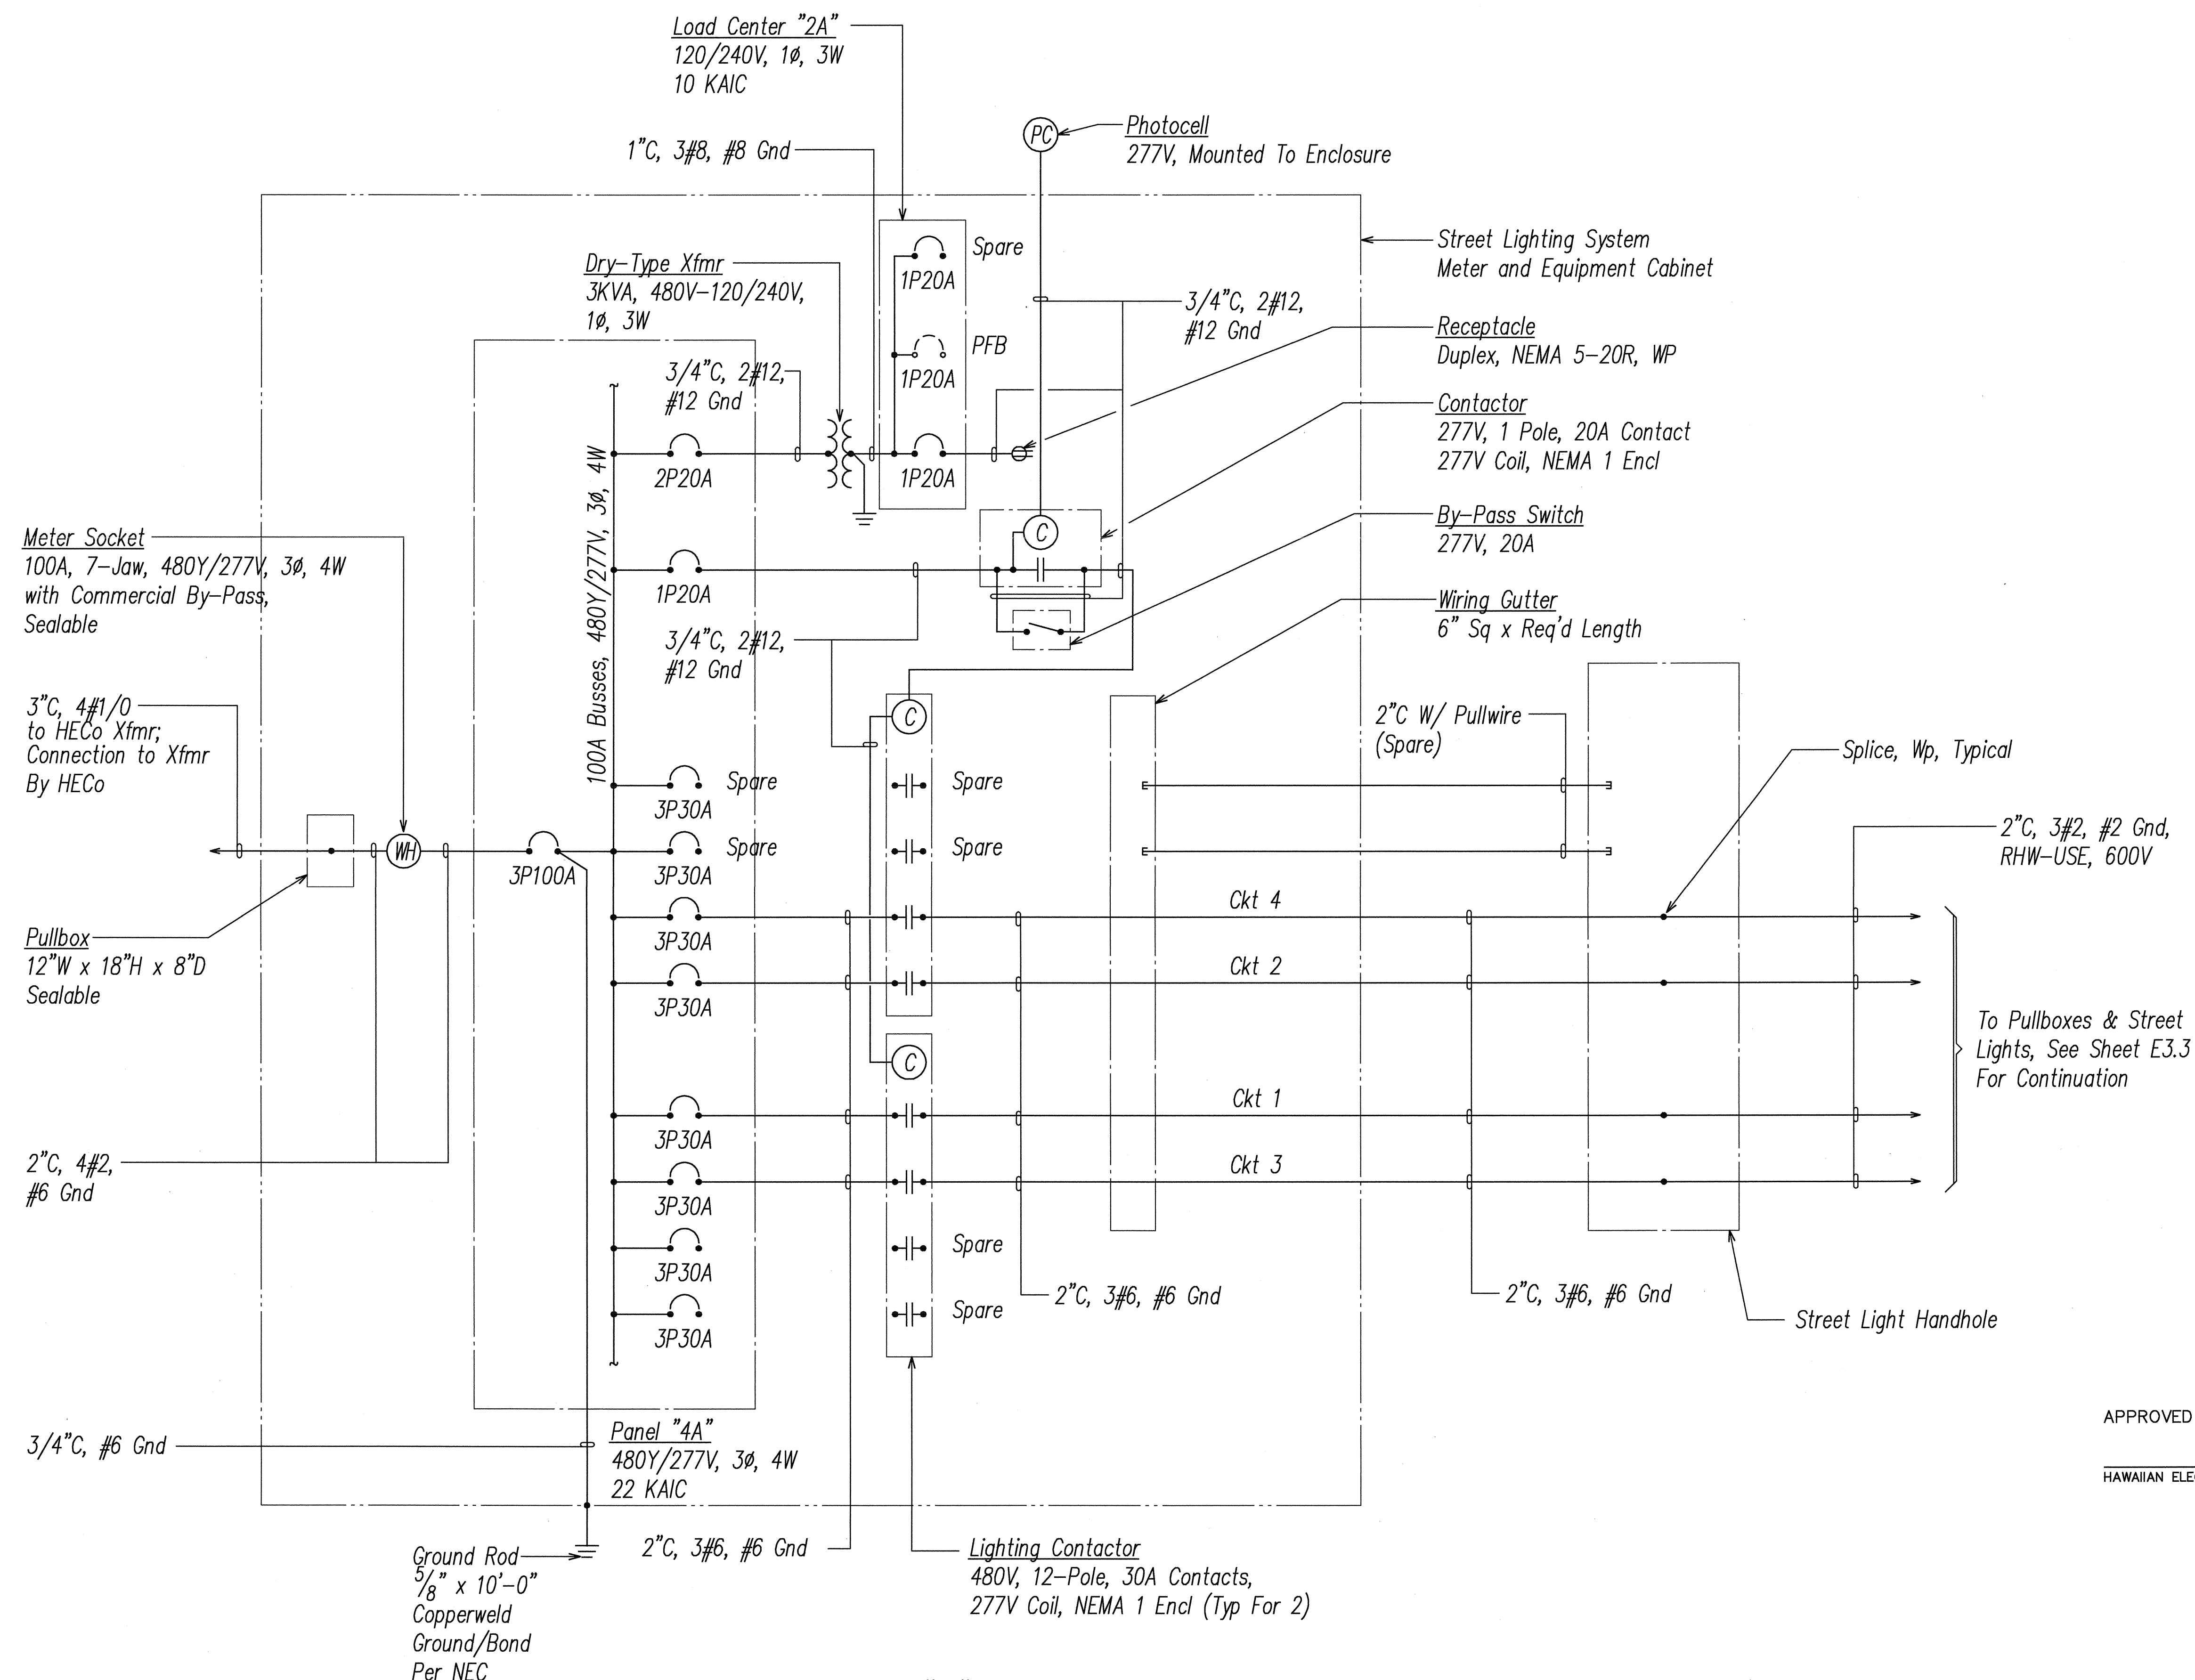


STREET LIGHTING SYSTEM "A" ONE-LINE DIAGRAM

APPROVED BY:

HAWAIIAN ELECTRIC COMPANY, INC.

DATE

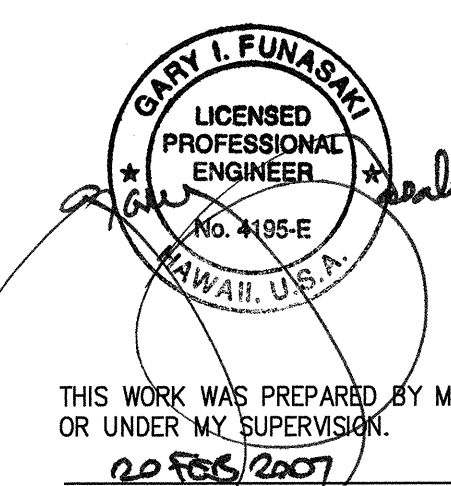

THIS WORK WAS PREPARED BY ME OR UNDER MY SUPERVISION.
20 FEB 2007

STATE OF HAWAII
DEPARTMENT OF TRANSPORTATION
HIGHWAYS DIVISION
STREET LIGHTING SYSTEM "A"
ONE-LINE DIAGRAM
North-South Road
Phase 1B
F.A.I. Proj. No. STP-8930(2)

Scale: AS NOTED Date: Feb 21, 2007


SHEET No. E3.1 OF 62 SHEETS

DATE	REVISION

DESIGNED BY	
DRAWN BY	
CHECKED BY	
NOTED BY	
DATE	

USE ONE OF THE FOLLOWING FOR THE PROJECT: 1. STP-8930(2) 2. STP-8930(1) 3. STP-8930(3) 4. STP-8930(4) 5. STP-8930(5) 6. STP-8930(61) 62. STP-8930(62)

FED. ROAD DIST. NO.	STATE	FED. AID PROJ. NO.	FISCAL YEAR	SHEET NO.	TOTAL SHEETS
HAWAII	HAW.	STP-8930(2)	2007	311	331

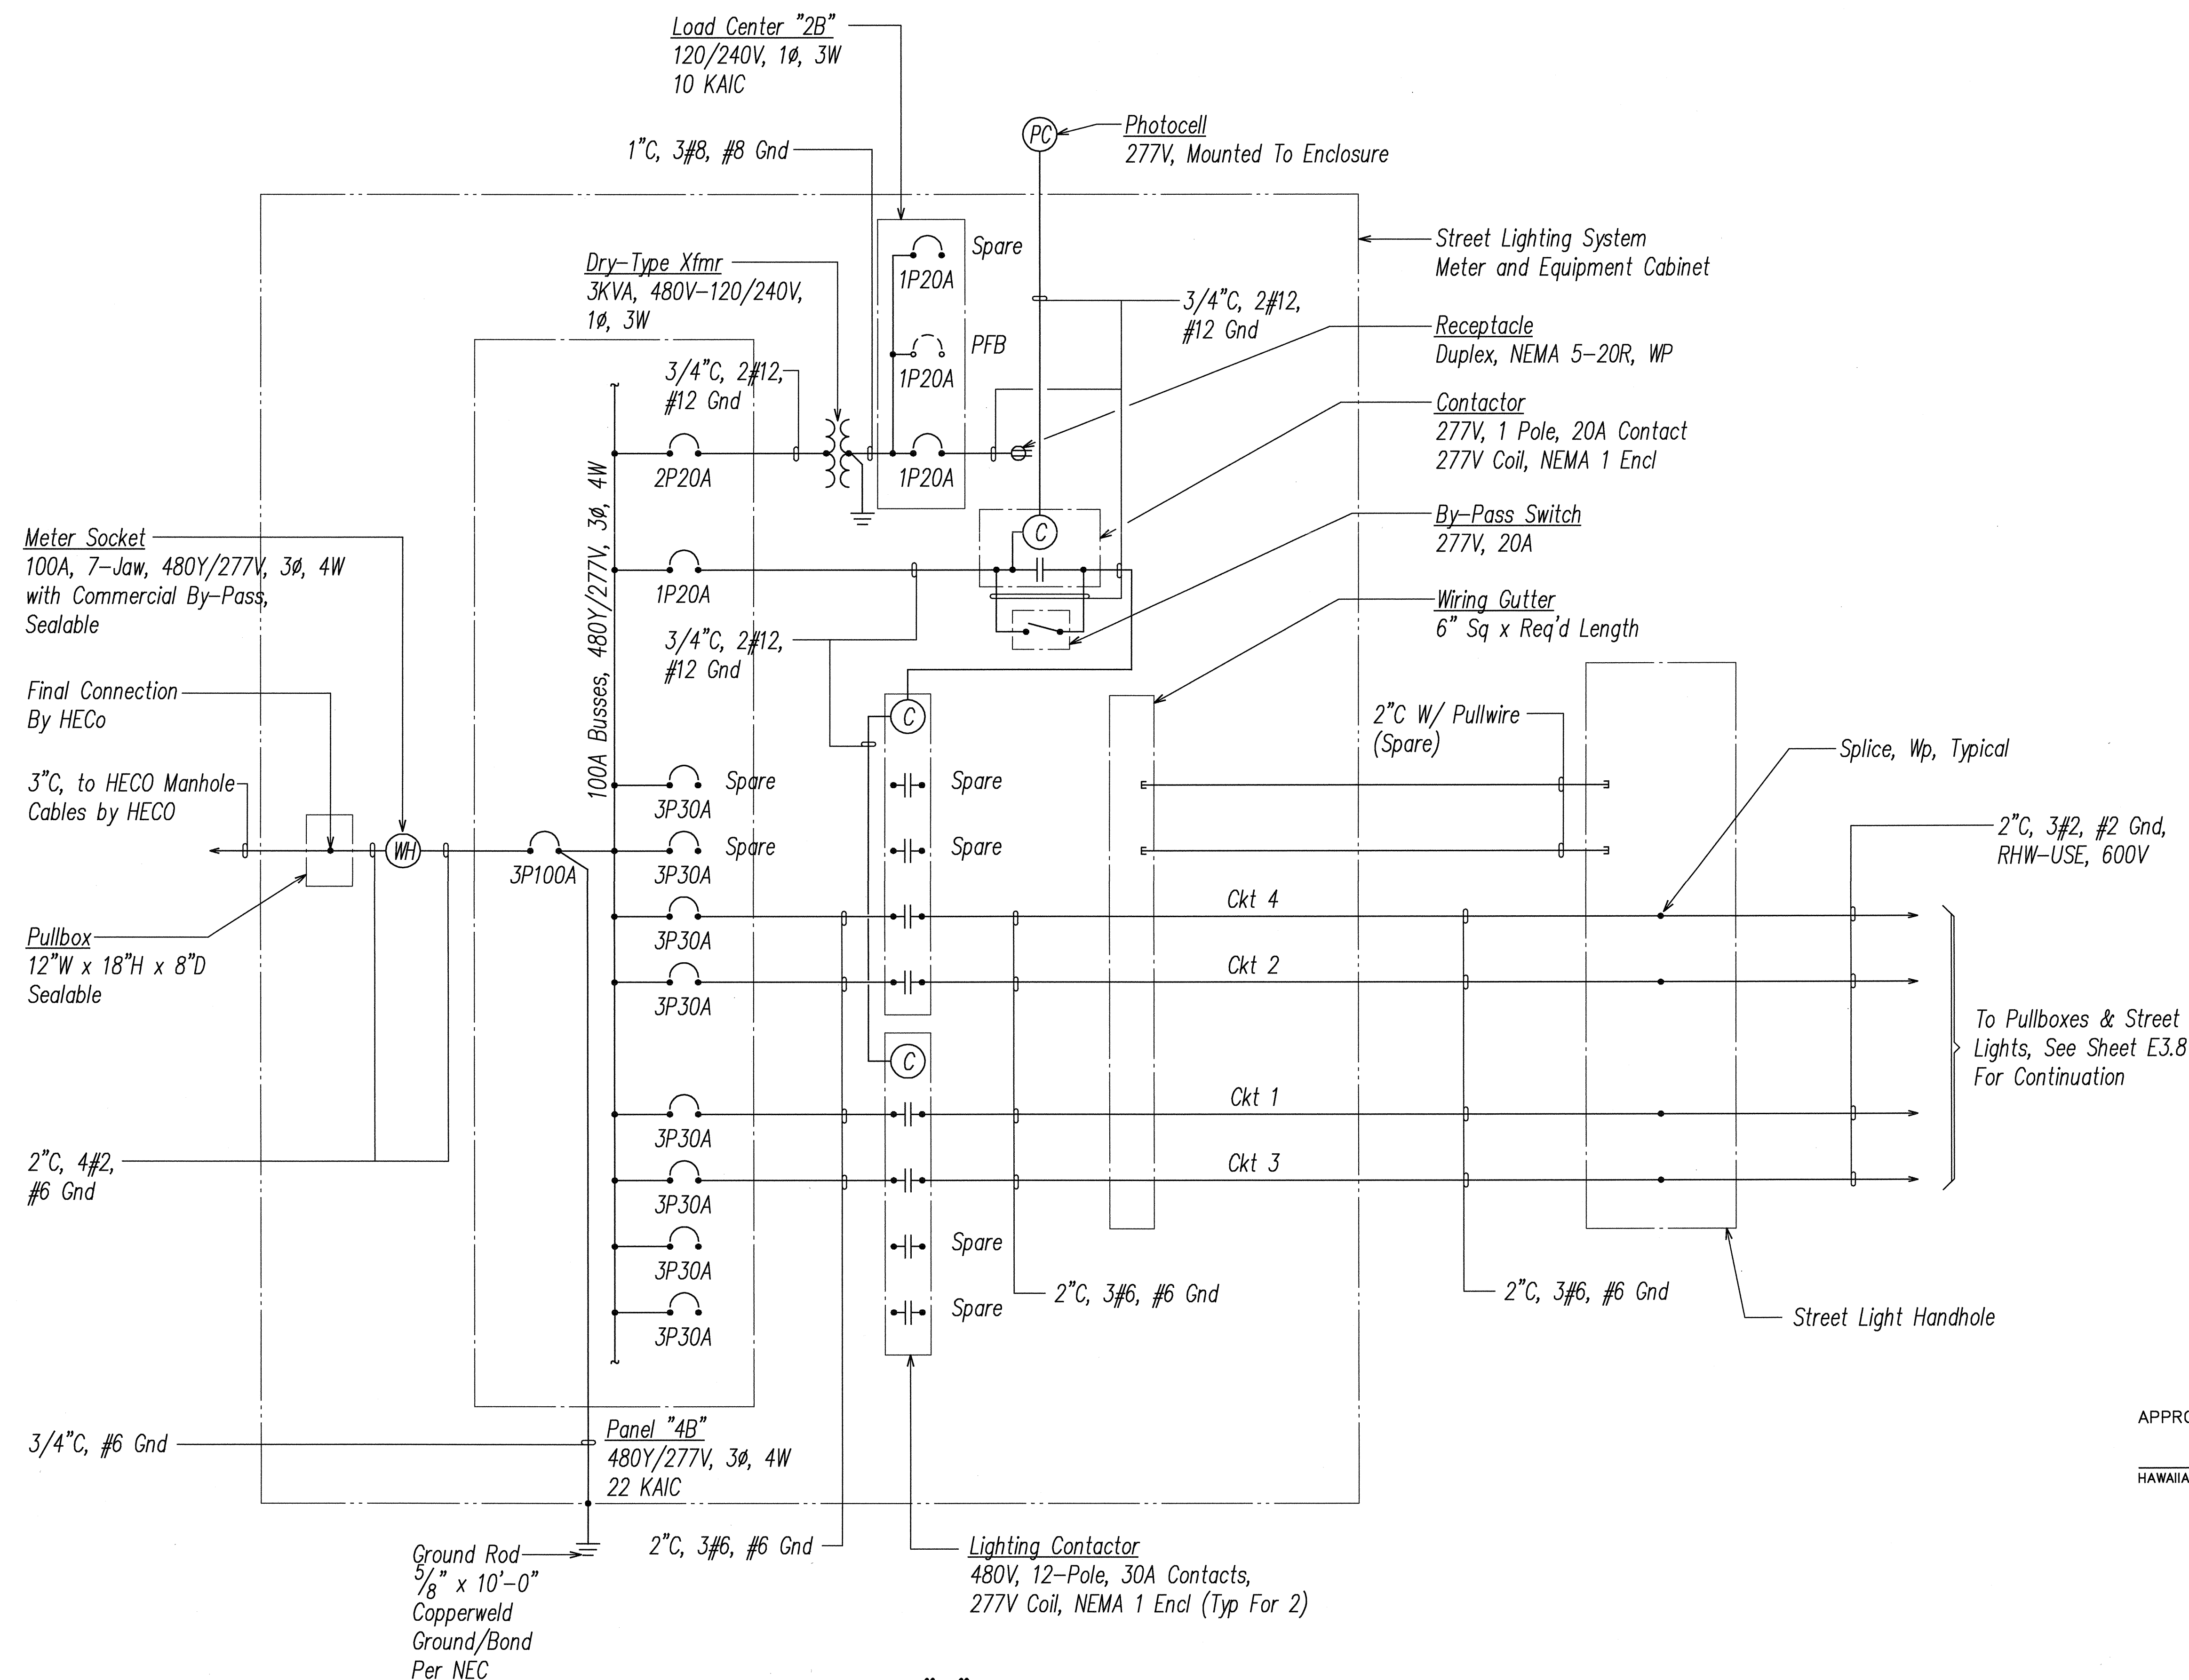

STREET LIGHTING SYSTEM "B" ONE-LINE DIAGRAM

APPROVED BY:
HAWAIIAN ELECTRIC COMPANY, INC.

DATE: 02 FEB 2007
THIS WORK WAS PREPARED BY ME OR UNDER MY SUPERVISION.

STATE OF HAWAII
DEPARTMENT OF TRANSPORTATION
HIGHWAYS DIVISION
STREET LIGHTING SYSTEM "B"
ONE-LINE DIAGRAM
North-South Road
Phase 1B
F.A.I. Proj. No. STP-8930(2)

Scale: AS NOTED Date: Feb 21, 2007

SHEET No. E3.2 OF 62 SHEETS

DATE	REVISION

DATE	
SURVEY PLOTTED BY	
ORIGINAL PLAN	
DRAWN BY	
TRACED BY	
DESIGNED BY	
QUANTITY BY	
CHECKED BY	
NO.	

LAST SAVE: 09/09/2007 09:24:18 AM
FILE: C:\Users\jgarcia\Documents\STP-8930(2) E3.2.dwg
PLOT: 02/21/2007 09:24:18 AM