





2 ATCT UPPER FLOOR - FIRE ALARM PLAN
1/8" = 1'-0"

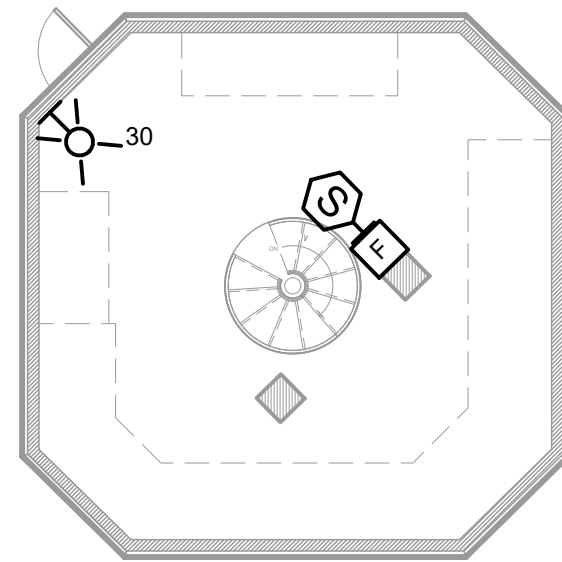


3 ATCT - FIRE ALARM PLAN
1/8" = 1'-0"

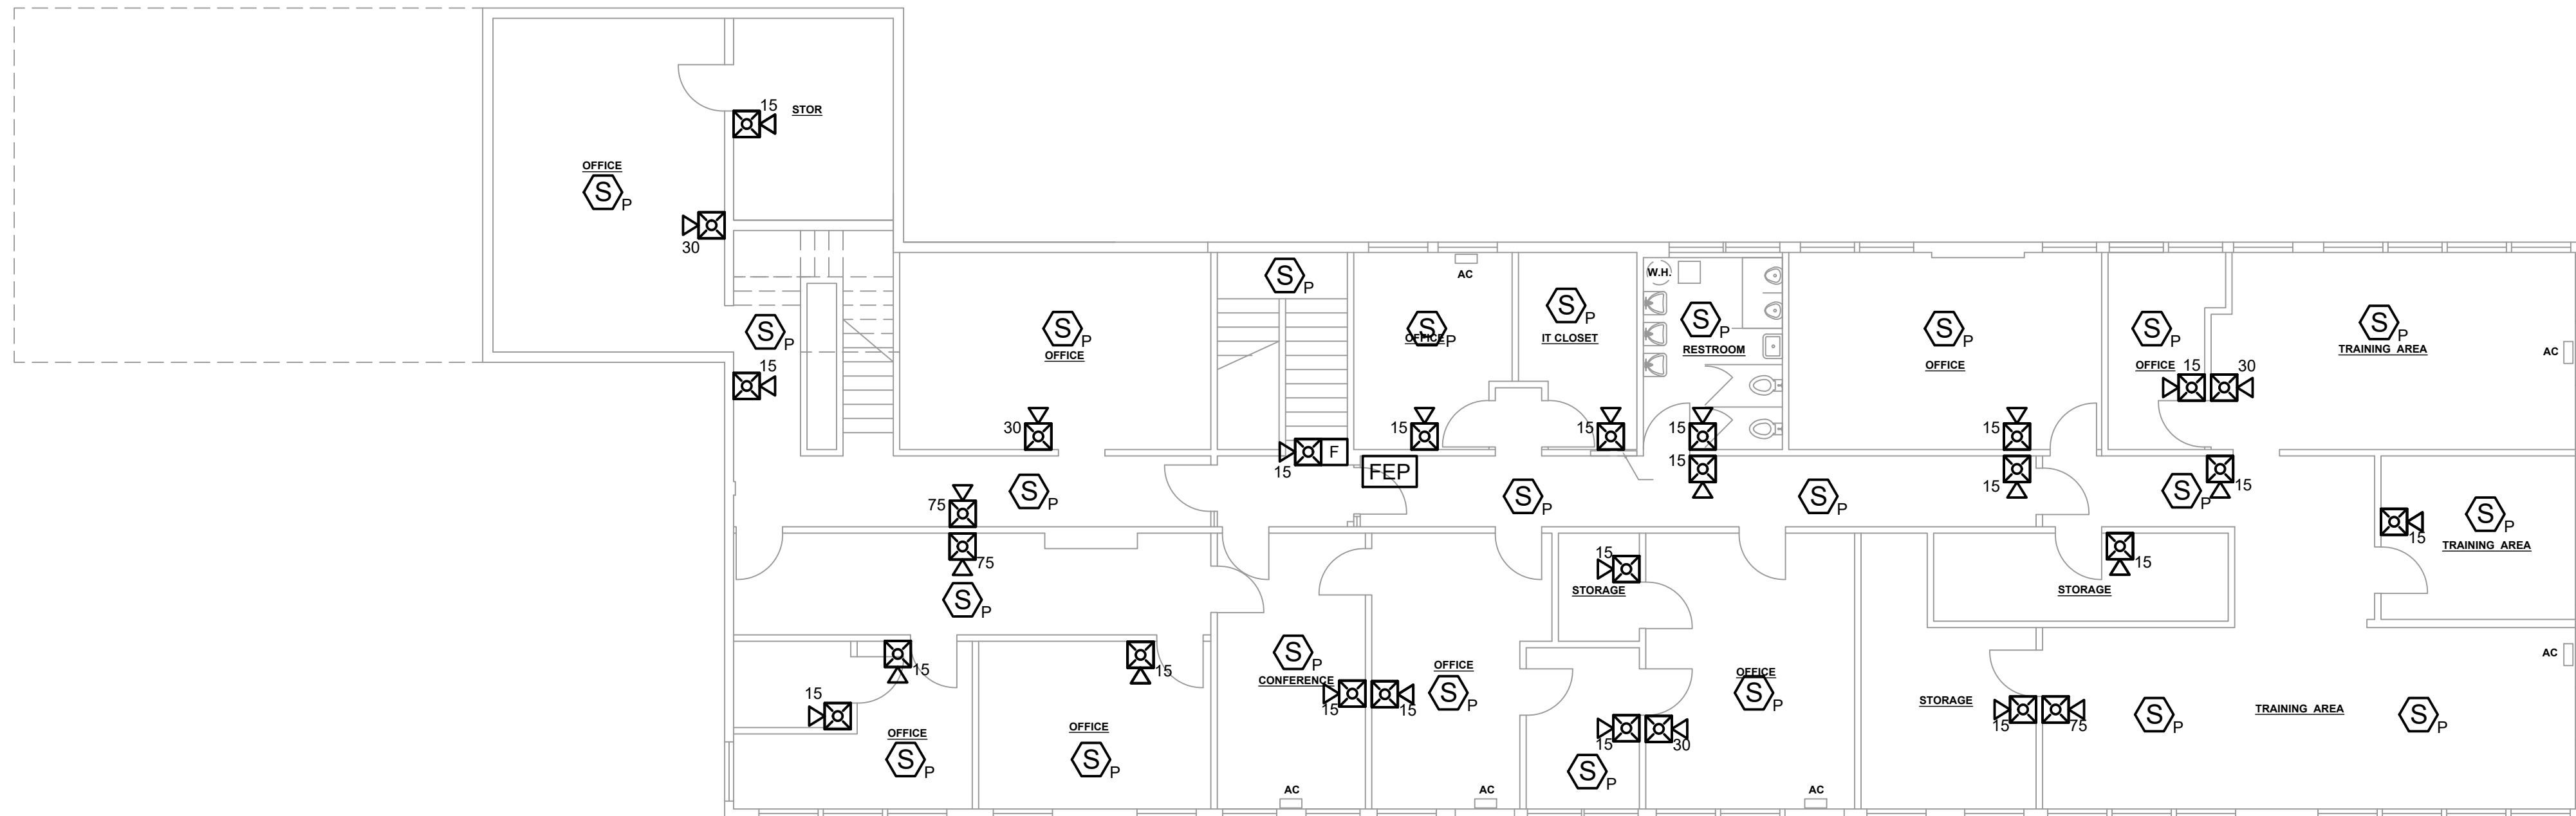

1 ATCT SECOND FLOOR - FIRE ALARM PLAN
1/8" = 1'-0"

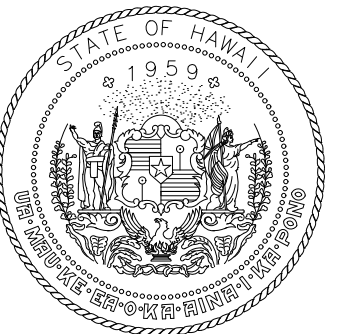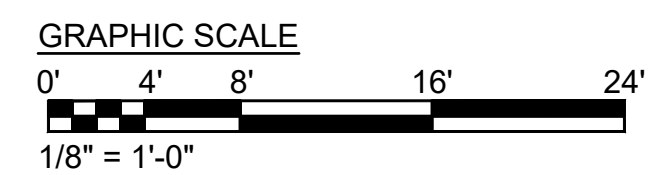

Airports Division
DEPARTMENT OF TRANSPORTATION
STATE OF HAWAII

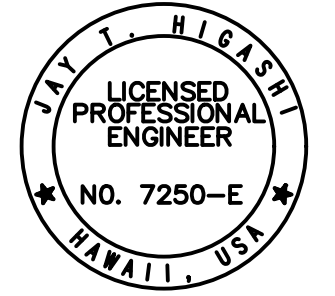

4/30/2022
Expiration Date of the License

Jay T. Higashi

DSGN.	DRWN.	CHKD.	APPD.
JH/KC	KC	JH	-

KEY PLAN / NOTES:

NO.	DATE	REVISIONS
-----	------	-----------

FINAL
SUBMITTAL

09/30/22
DATE

PROJECT TITLE :

AIR TRAFFIC CONTROL
TOWER REPAIRS

AT
KALAELOA AIRPORT
BARBERS POINT, OAHU, HAWAII

PROJECT NO.:

AO5024-03

SHEET TITLE:

ATCT SECOND AND
UPPER FLOOR - FIRE
ALARM PLAN

DATE :	DWG. NO.
09/30/22	FA102
SHEET :	
18 OF 24 SHEETS	