

Airports Division  
DEPARTMENT OF TRANSPORTATION  
STATE OF HAWAII



04/30/24

License Expiration Date

This work was prepared by me or under my supervision.

DSGN.	DRWN.	CHKD.	APPD.
JY	JM	JY	-

NO.	DATE	REVISIONS
-----	------	-----------

## FINAL SUBMITTAL

09/30/22  
DATE

PROJECT TITLE :

**AIR TRAFFIC CONTROL  
TOWER REPAIRS**

AT  
KALAELOA AIRPORT  
BARBERS POINT, OAHU, HAWAII


PROJECT NO.:

**AO5024-03**

SHEET TITLE:

**CONTROL TOWER  
ELECTRICAL PLAN -  
NEW WORK**

DATE :	DWG. NO.
09/30/22	<b>E100</b>
SHEET :	
22 OF 49 SHEETS	

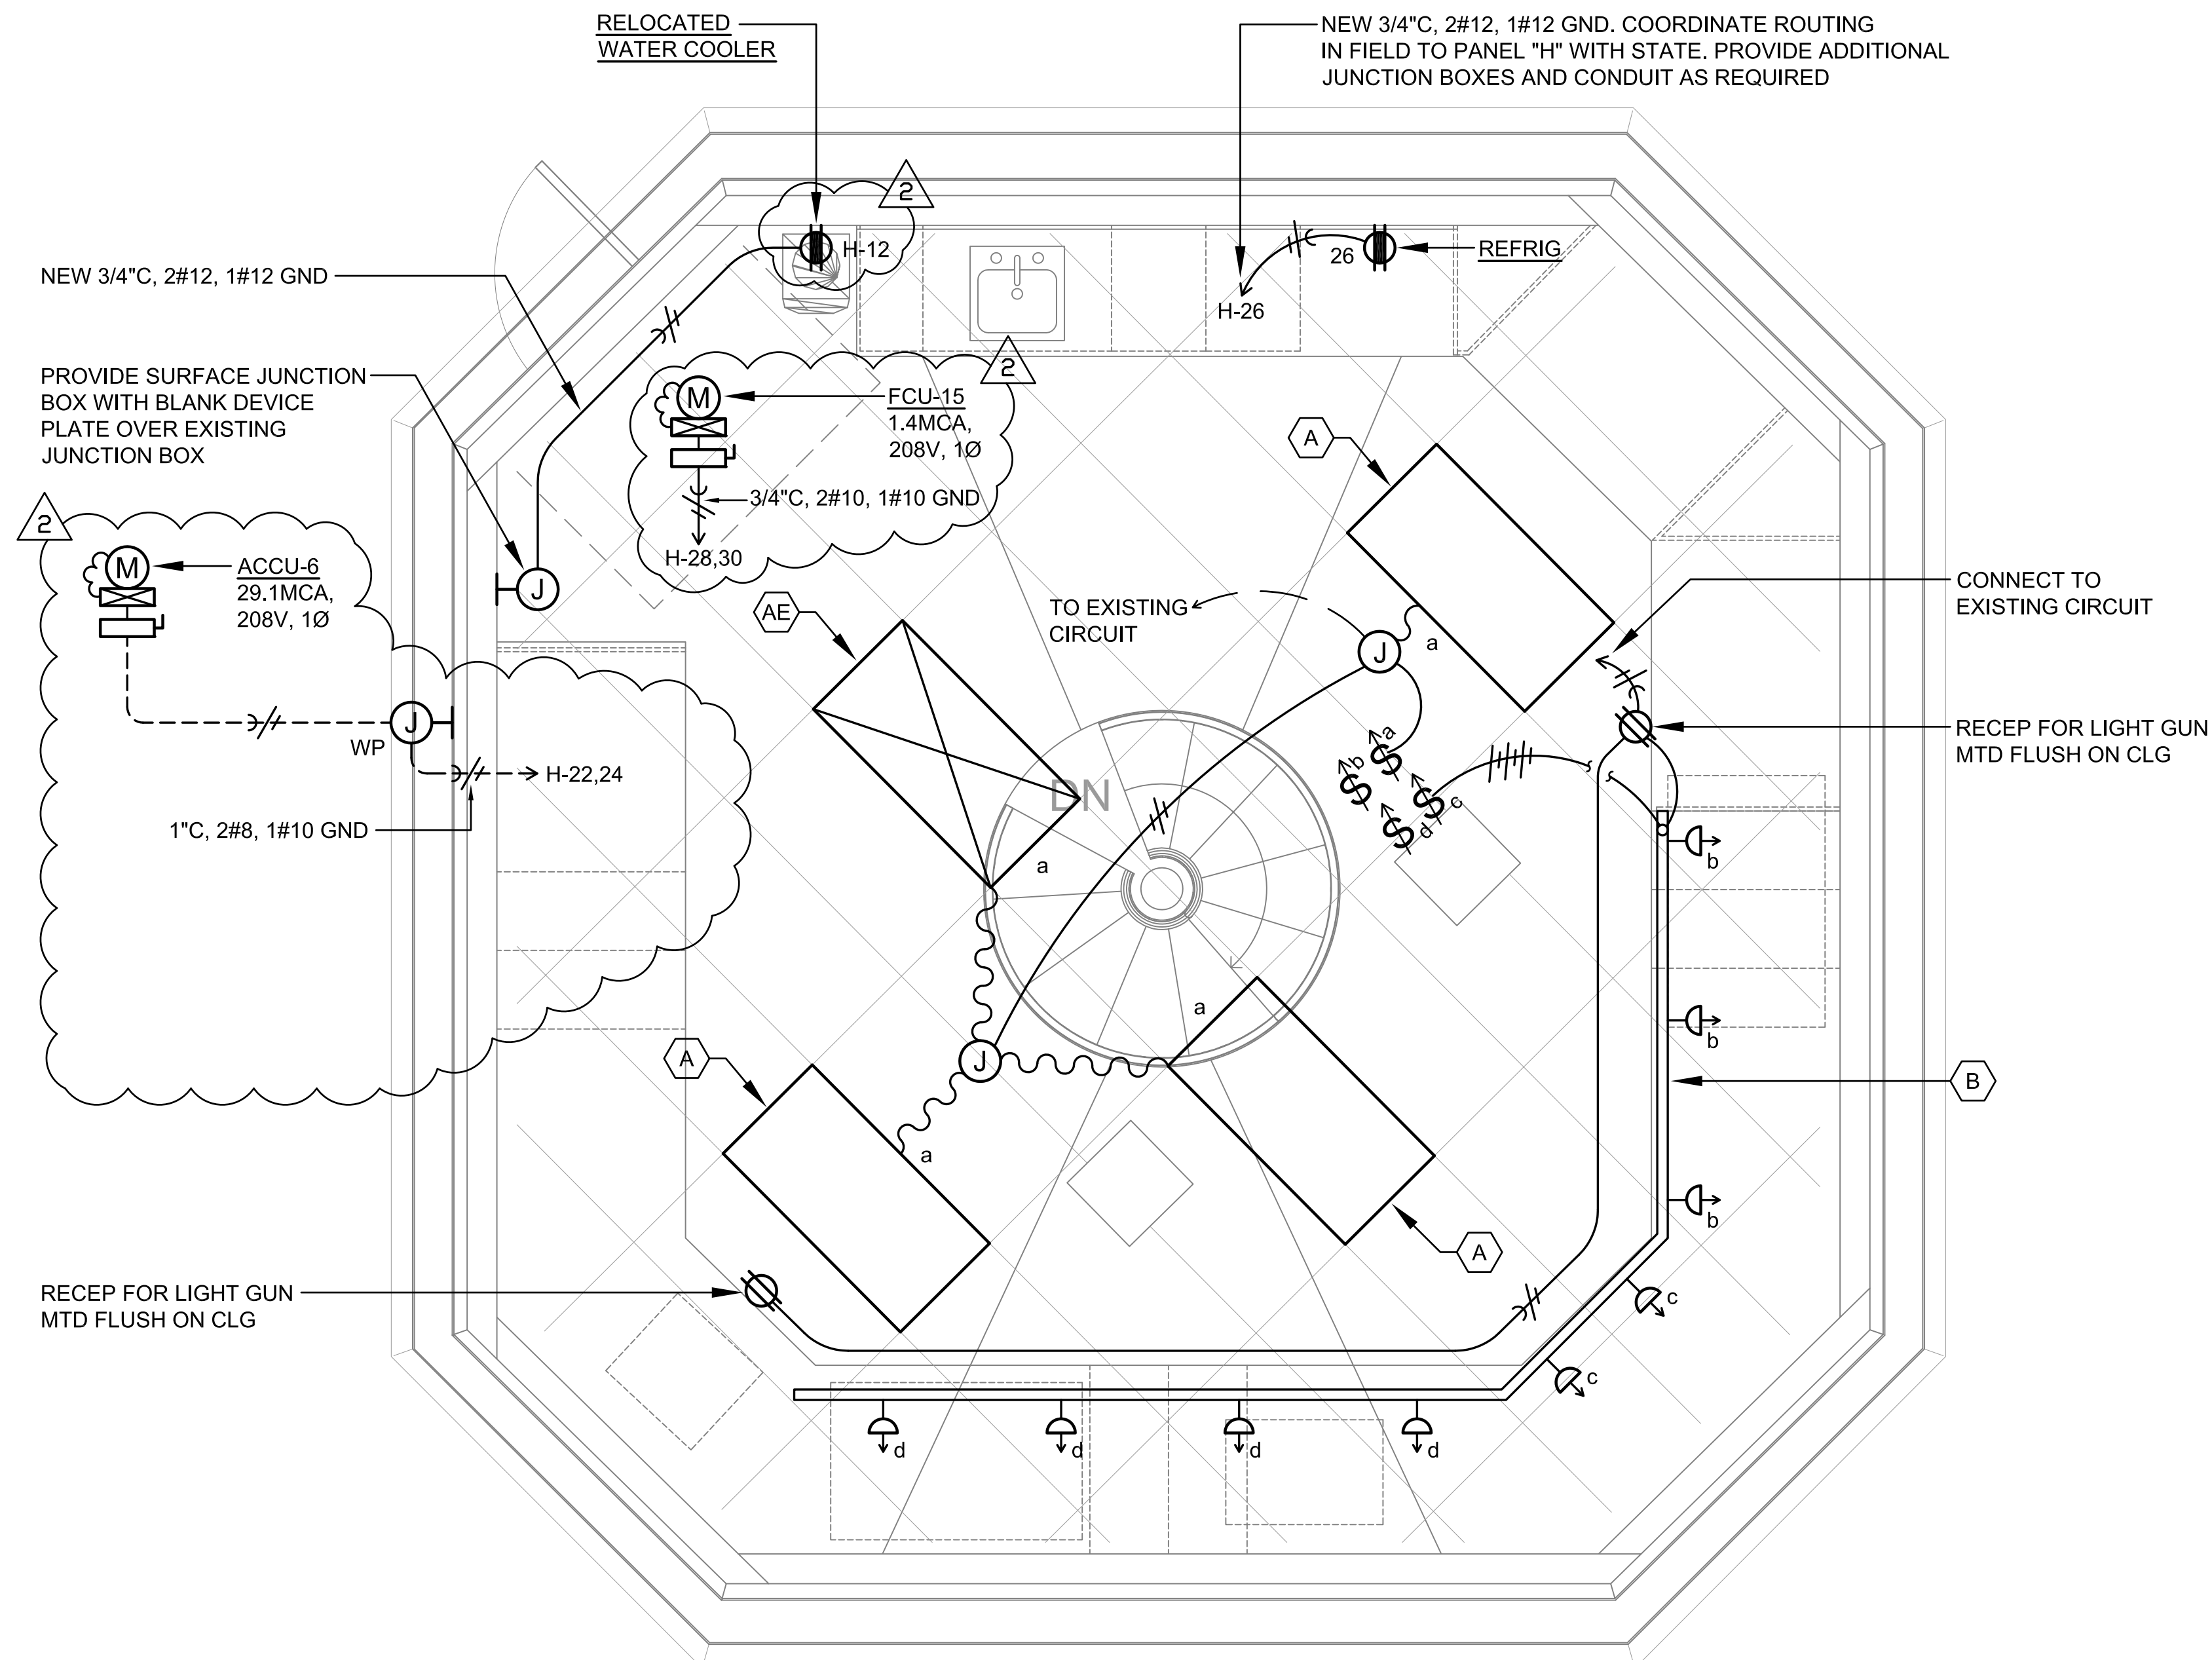

**1**  
E100  
**CONTROL TOWER ELECTRICAL PLAN - NEW WORK**  
SCALE : 1/2" = 1' - 0"

