

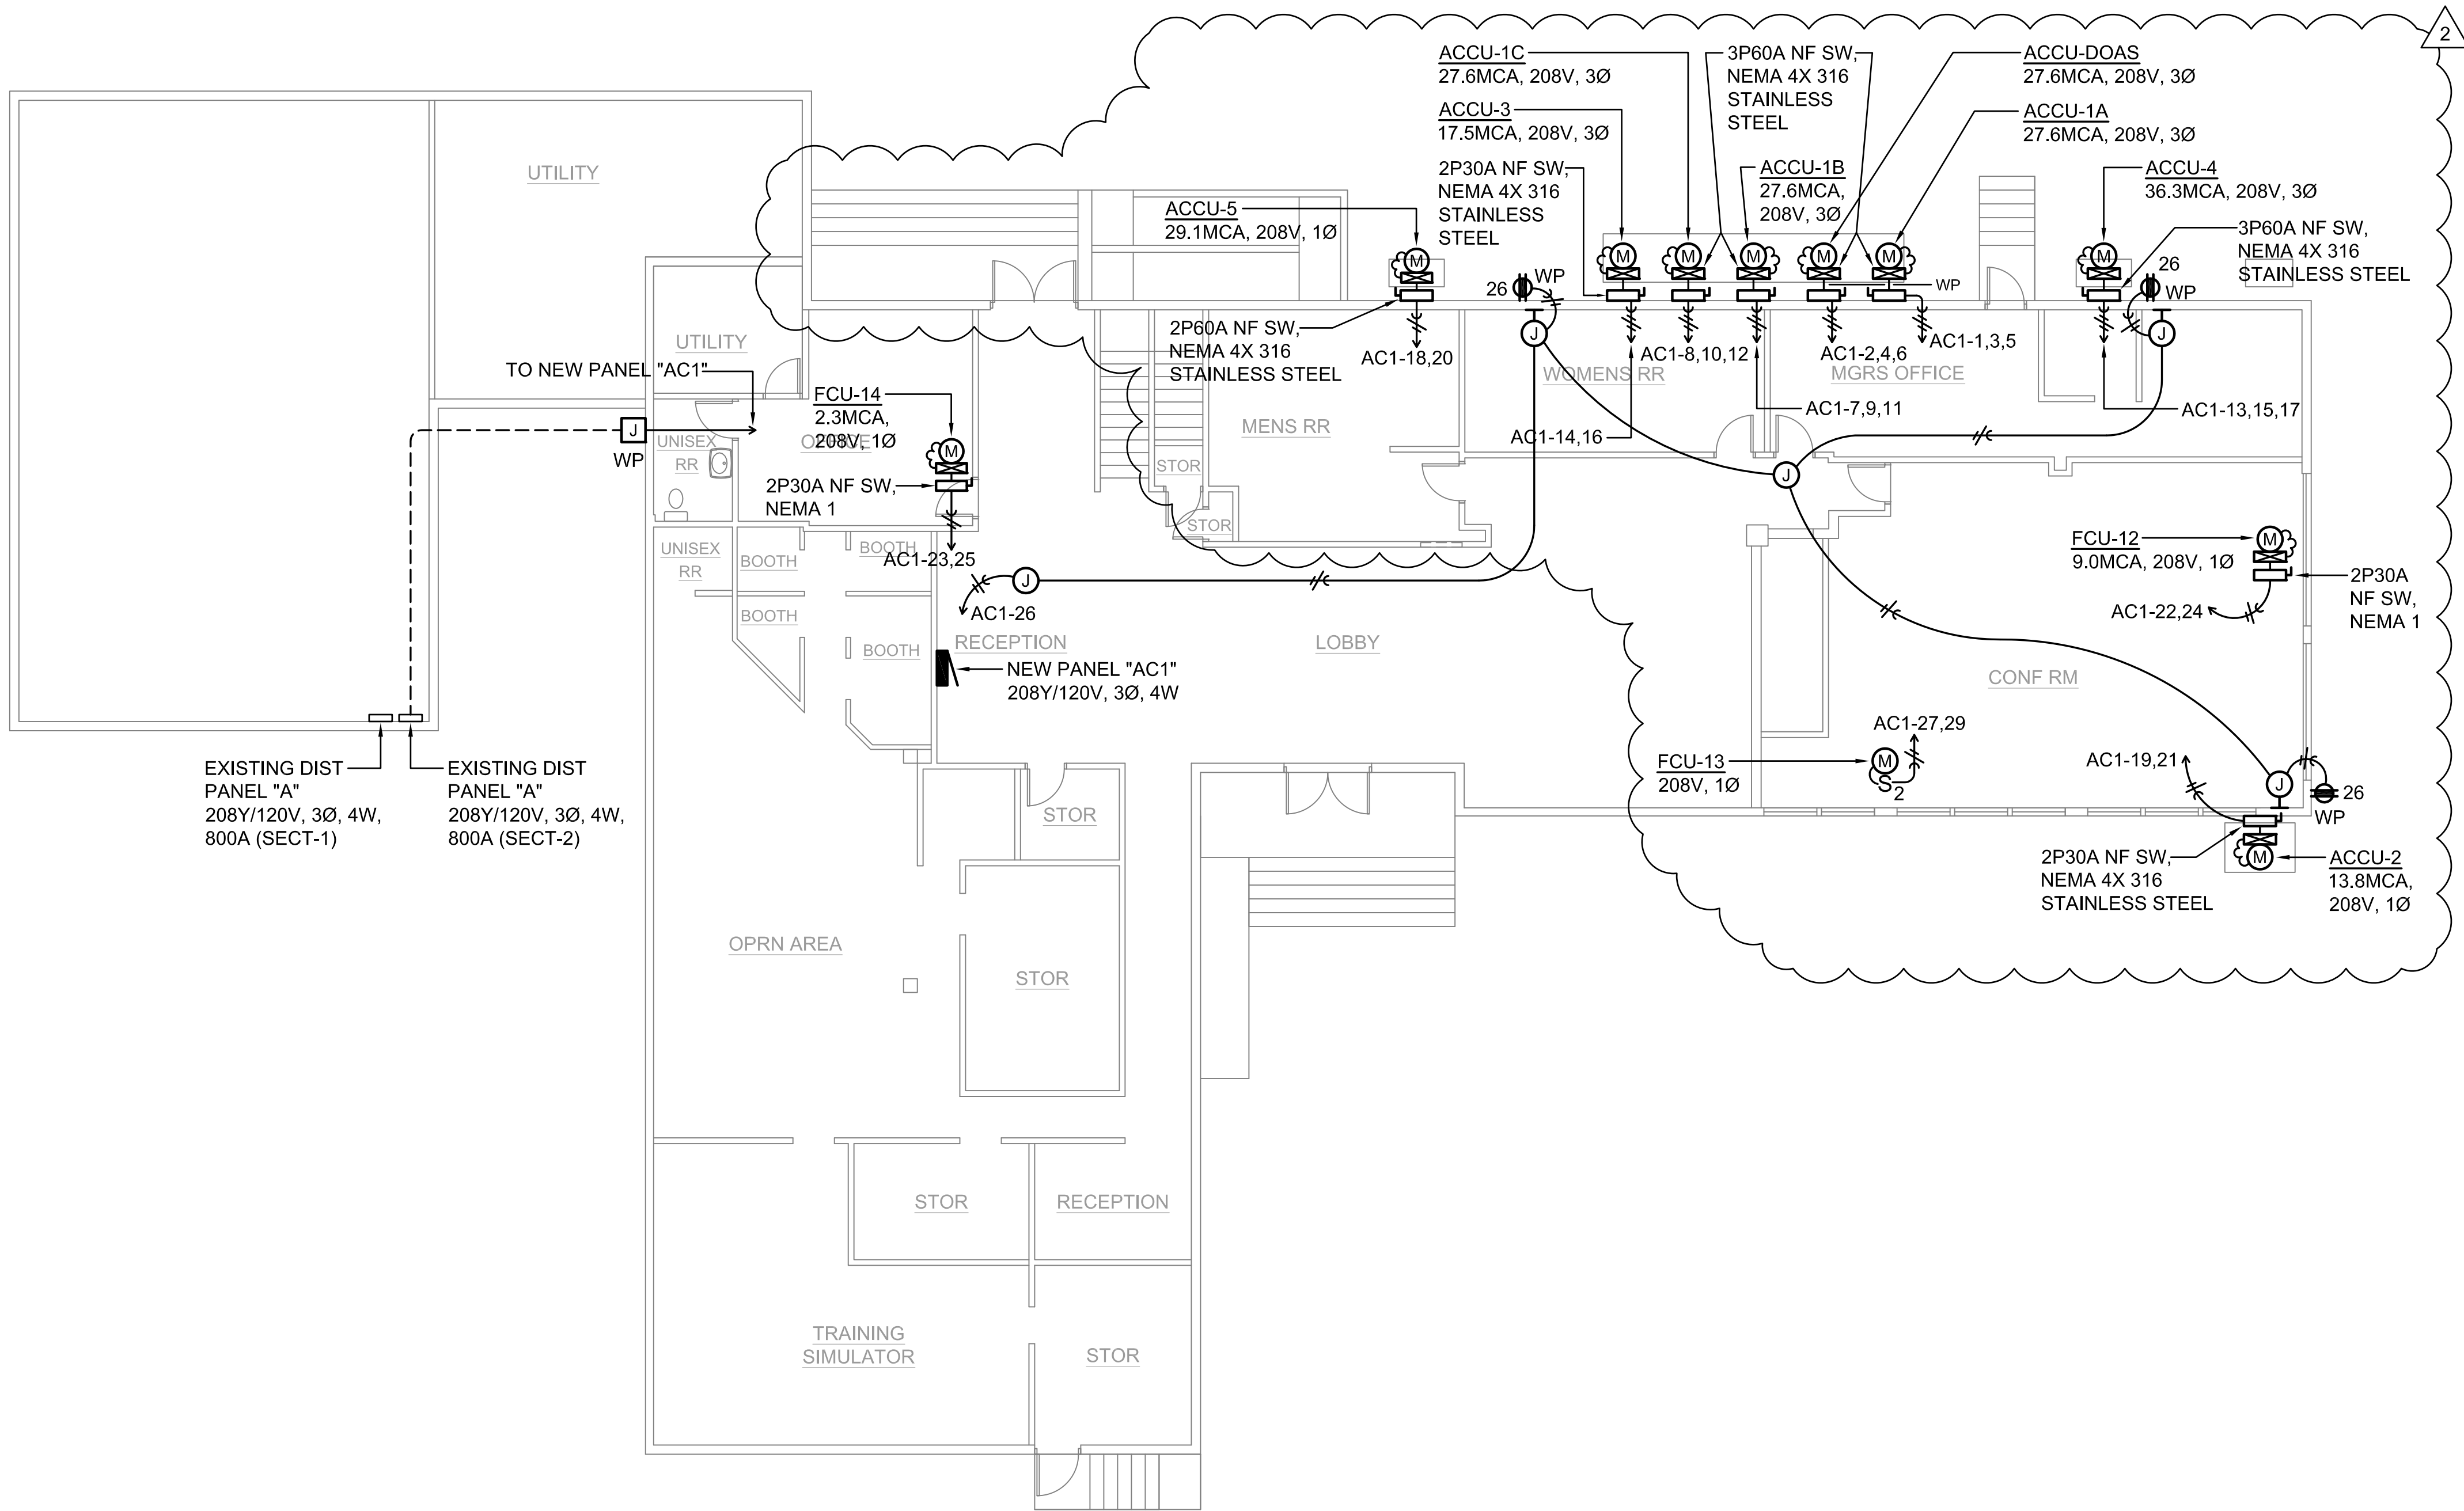
 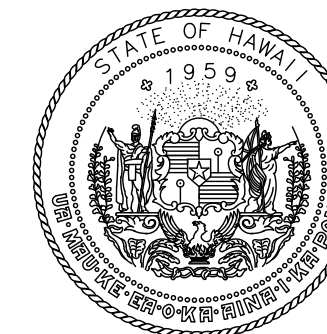


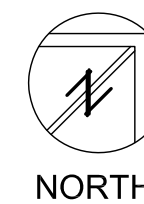

1
E202

GROUND FLOOR POWER PLAN - NEW WORK

SCALE : 3 / 16" = 1' - 0"



Airports Division
DEPARTMENT OF TRANSPORTATION
STATE OF HAWAII



04/30/24

License Expiration Date

This work was prepared by me or under my supervision.

DSGN.	DRWN.	CHKD.	APPD.
JY	JM	JY	-

NO.	DATE	REVISIONS
2	11/18/22	ADDENDUM #2
1	11/03/22	ADDENDUM #1

FINAL SUBMITTAL

09/30/22
DATE

PROJECT TITLE :

**AIR TRAFFIC CONTROL
TOWER REPAIRS**

AT
KALAELOA AIRPORT
BARBERS POINT, OAHU, HAWAII

PROJECT NO.:

AO5024-03

SHEET TITLE:

**GROUND FLOOR
POWER PLAN - NEW
WORK**

DATE :	DWG. NO.
09/30/22	E202
SHEET :	
OF SHEETS	