

License Expiration Date

This work was prepared by me or under my supervision.

DSGN.	DRWN.	CHKD.	APPD.
JY	JM	JY	-

NO.	DATE	REVISIONS
-----	------	-----------

FINAL SUBMITTAL

09/30/22
DATE

PROJECT TITLE :

AIR TRAFFIC CONTROL TOWER REPAIRS



AT
KALAELOA AIRPORT
BARBERS POINT, OAHU, HAWAII


PROJECT NO.:

AO5024-03

SHEET TITLE:

THIRD FLOOR ELECTRICAL PLAN - NEW WORK

DATE :		DWG. NO.
09/30/22		
SHEET :		
30 OF 49 SHEETS		

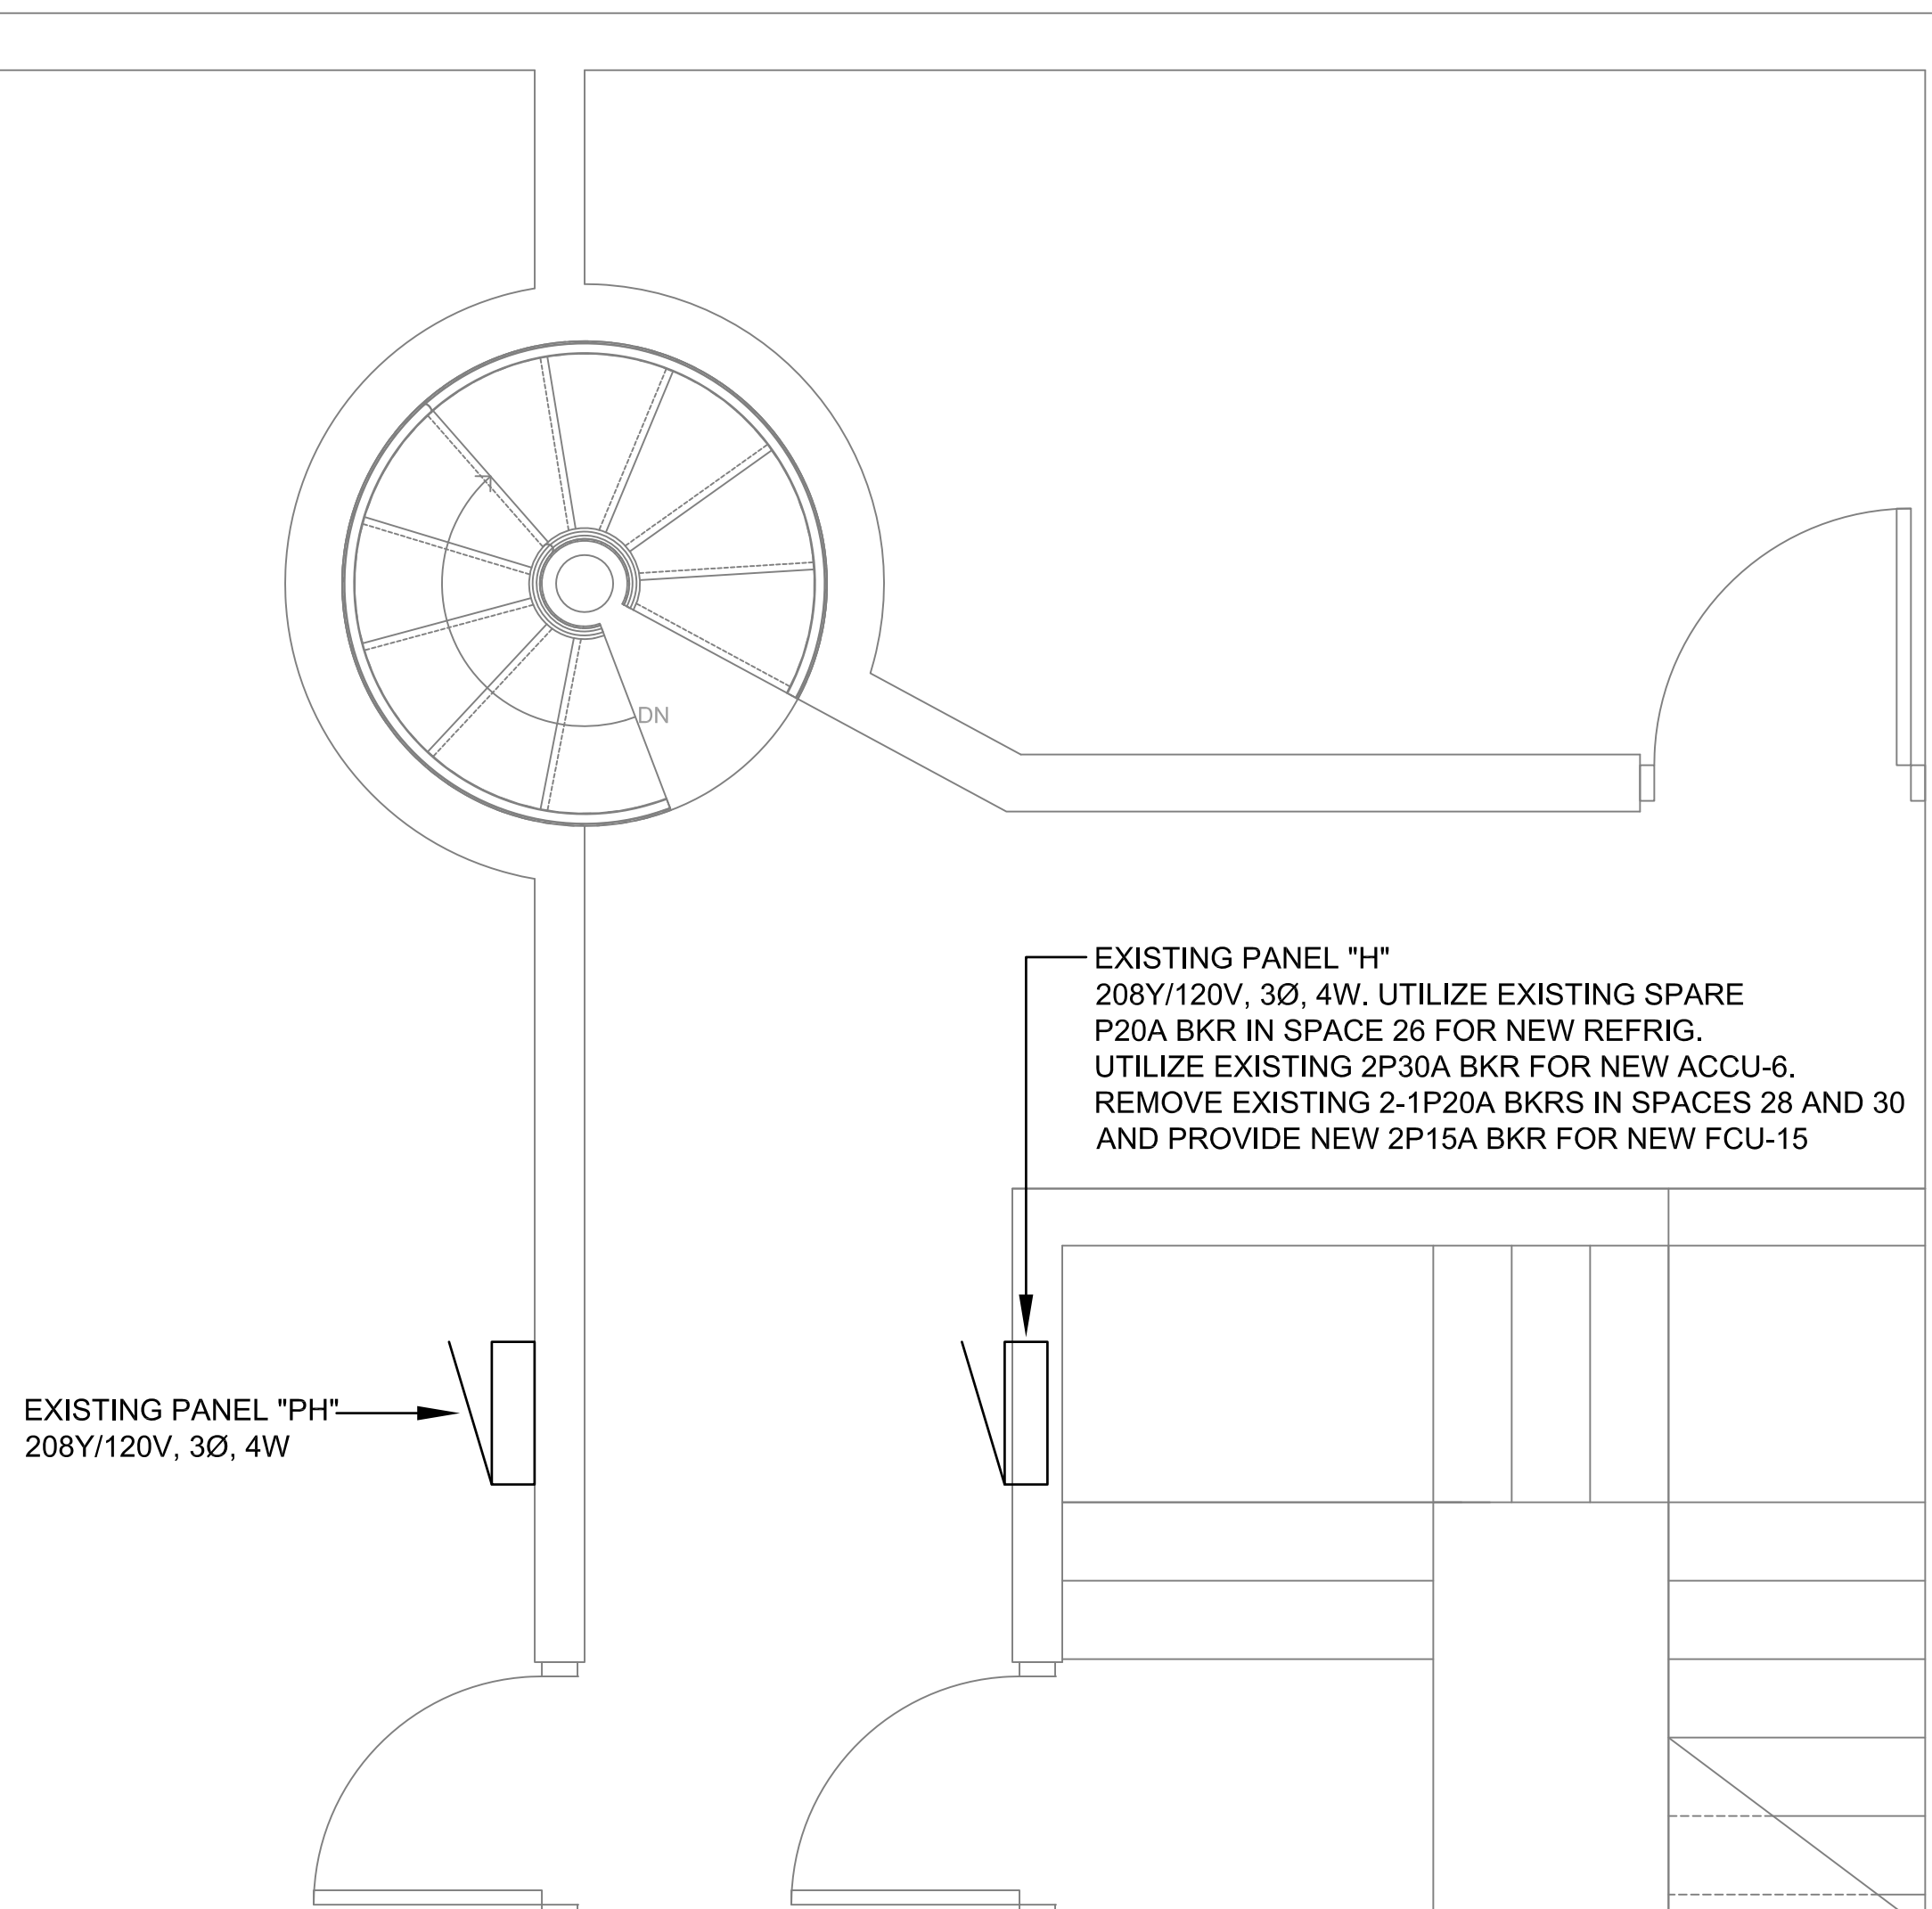

1 THIRD FLOOR ELECTRICAL PLAN - NEW WORK
E204 SCALE : 1/2" = 1' - 0"

