

INDEX TO DRAWINGS		COMPOSITE SHEET NO.
SHEET NO.	DESCRIPTION	
1	TITLE SHEET	1
2-6	TYPICAL SECTIONS	3-7
7-9	PLAN & PROFILE	12-14
10-16	DETAIL PLAN OF ROADWAY	18-24
17-23	PAVEMENT GRADE PLANS	32-38
24-25	CONSTRUCTION PHASE PLAN	47-48
26-35, 34A	CONCRETE RETAINING WALLS	49-58, 57A
36	MISCELLANEOUS DETAILS	67
37	DETAILS OF MANHOLES	68
38-42	DRAINAGE STRUCTURE	70-74
43	RELOCATION OF SIREN TOWER	75
44-46	RELOC. & REHAB. OF EXIST. IMPROVE. AT ROYAL SCHOOL	77-79
47-69, 67A	UTILITIES	80-87, 92-93, 100-106, 107-112, 110A
70-80	HIGHWAY LIGHTING SYSTEM	121-130, 136
81	TRAFFIC SIGNAL SYSTEM	137
82-88	TRAFFIC SIGNS	141-147
89-94	LANDSCAPE PLANS	155-160
95-100	SPRINKLER LAYOUT	166-171
101-118	CROSS SECTIONS	177-194
119-125	STRUCTURE NO. 8	208-214
126-136	STRUCTURE NO. 9	215-225
137-146	STRUCTURE NO. 11	226-235
147-148	STANDARD BRIDGE DETAILS	279-280

TERRITORY OF HAWAII
TERRITORIAL HIGHWAY DEPARTMENT
HONOLULU, OAHU, T. H.
AS BUILT
PLANS OF

LUNALILO FREEWAY

FEDERAL AID PROJECT NO. F-072-1 (1)


UNIT 3

DISTRICT OF HONOLULU

ISLAND OF OAHU

SCALES

Plan 1"=50' & 1"=20'
Profile Horiz. 1"=50'
Profile Vert. 1"=10'
X Section Horiz. 1"=10'
X Section Vert. 1"=10'

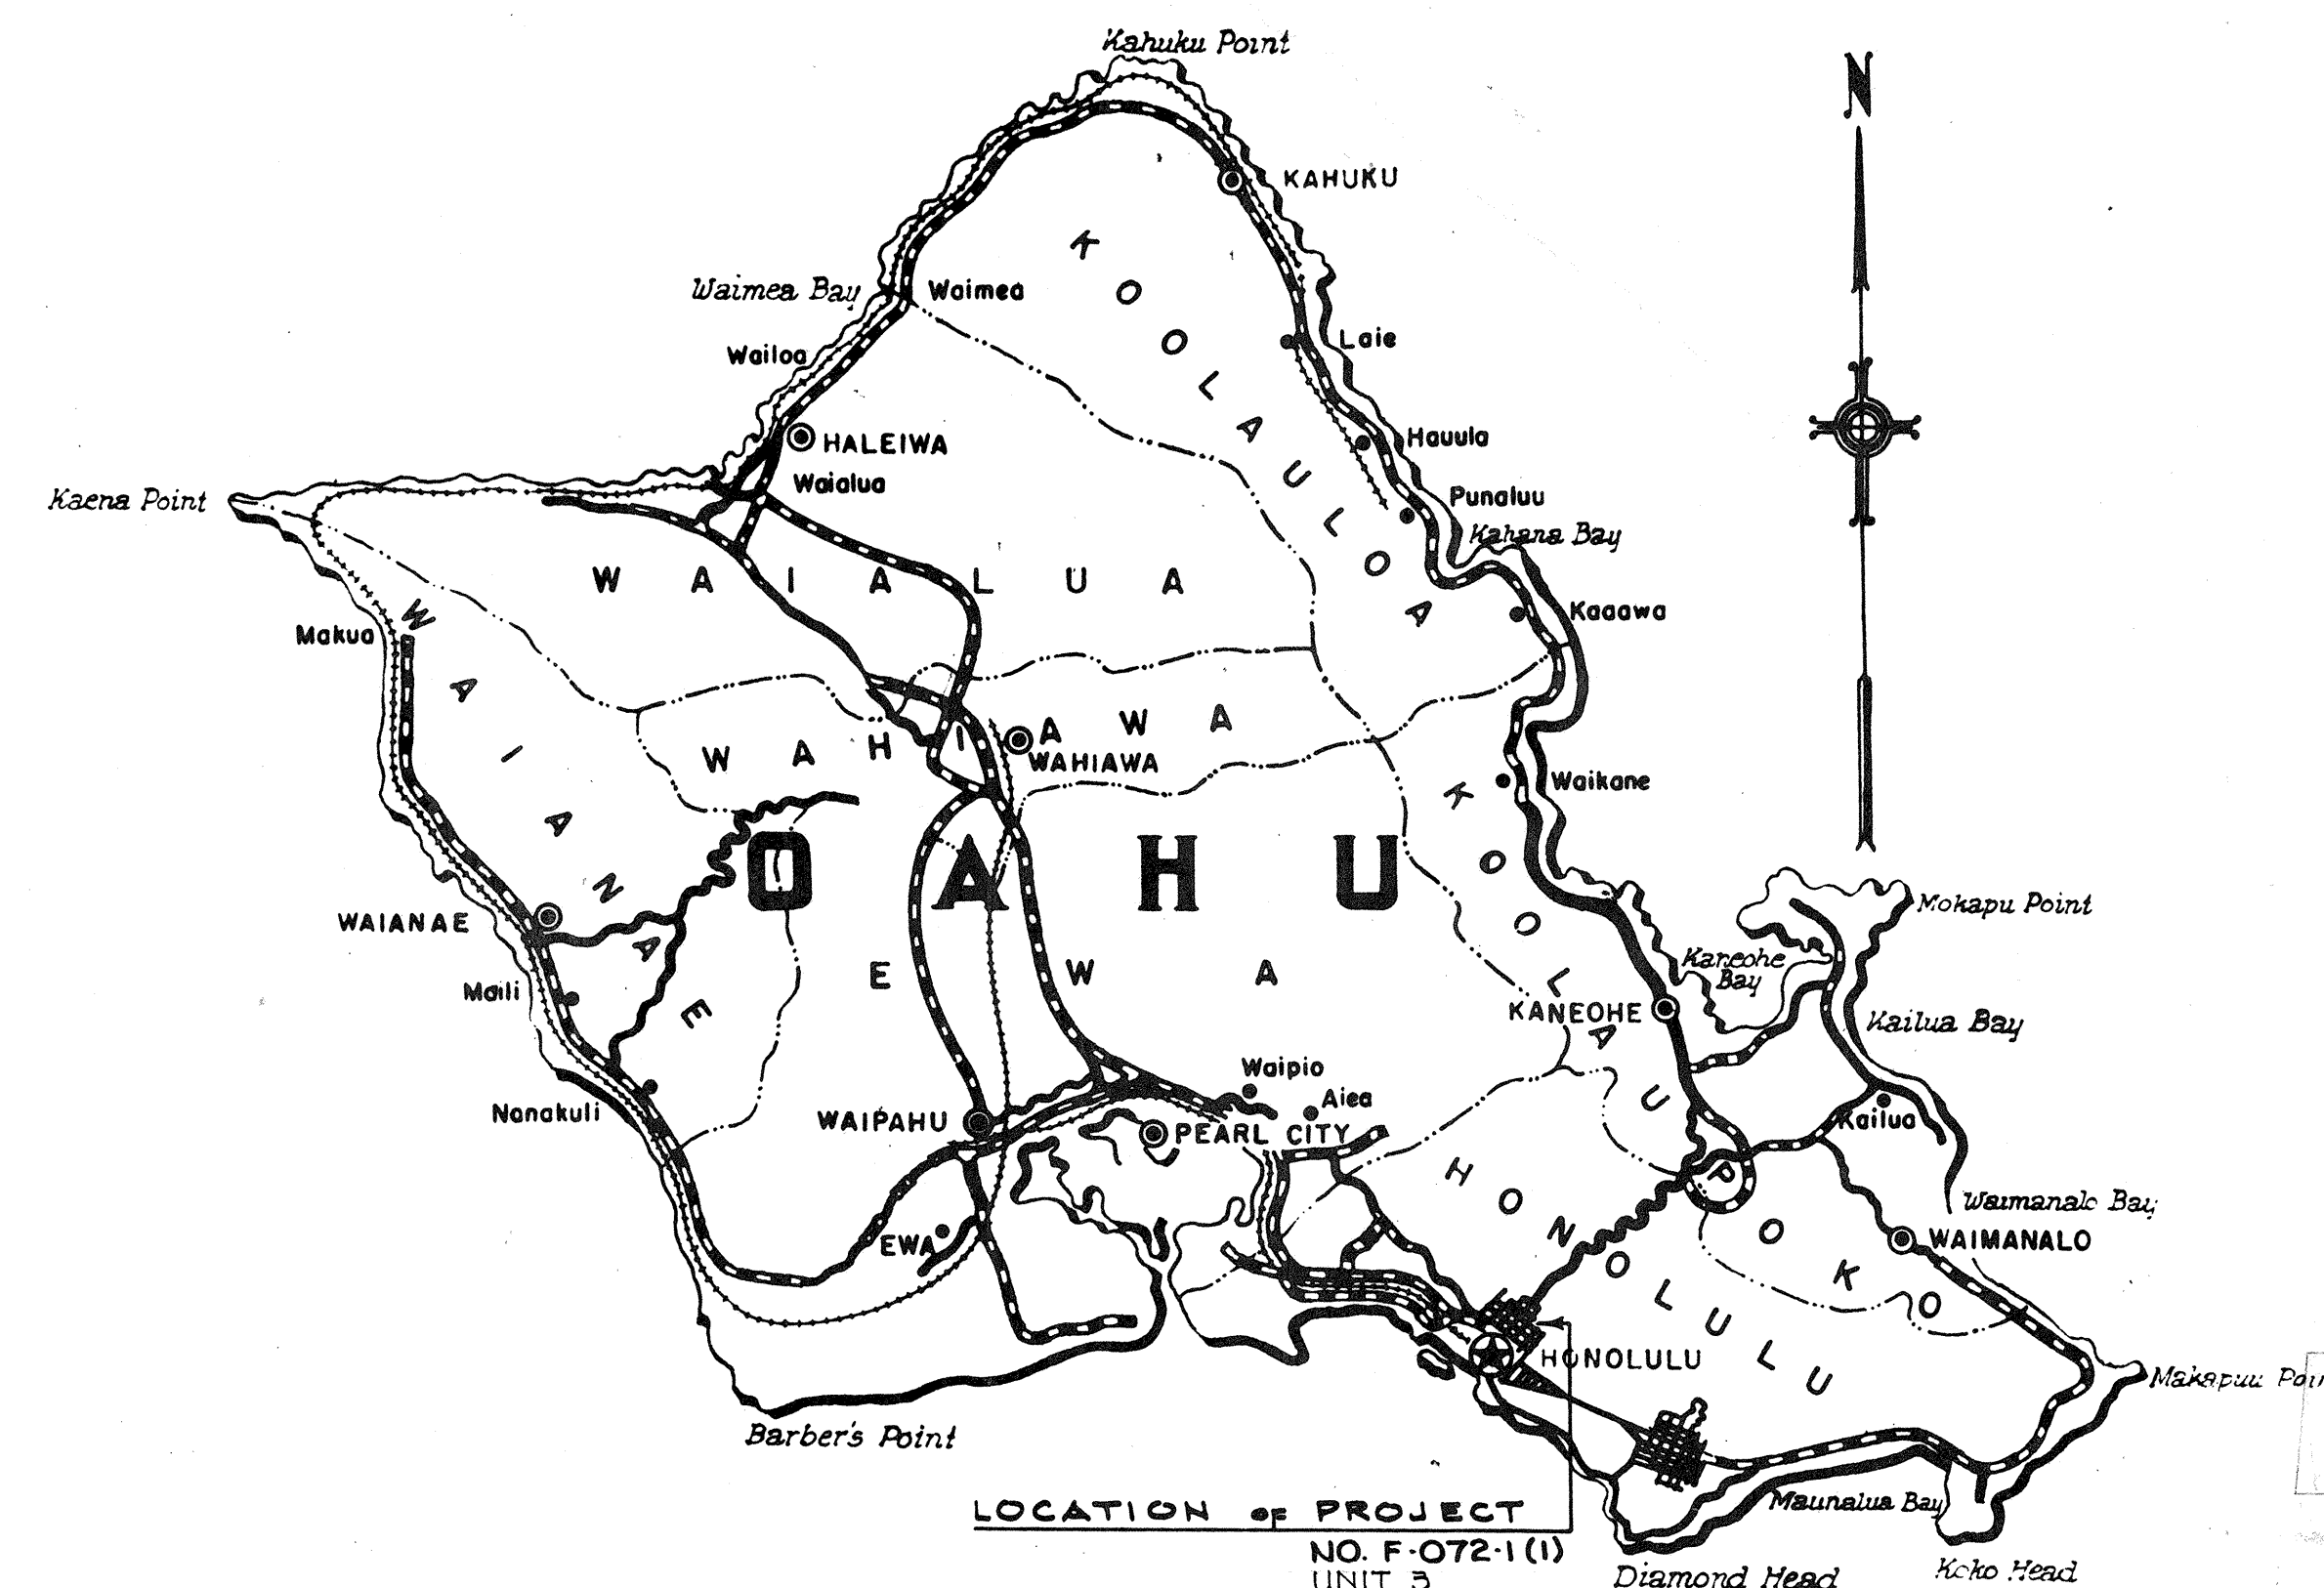


Federal Aid Projects Previously Constructed Or Under Construction

NOTE:

ALL CHANGES MADE DURING
CONSTRUCTION HAVE BEEN
NOTED IN THESE TRACINGS
IN RED AND CHECKED BY

R. T. Smith
PROJECT ENGINEER
8-9-63
DATE

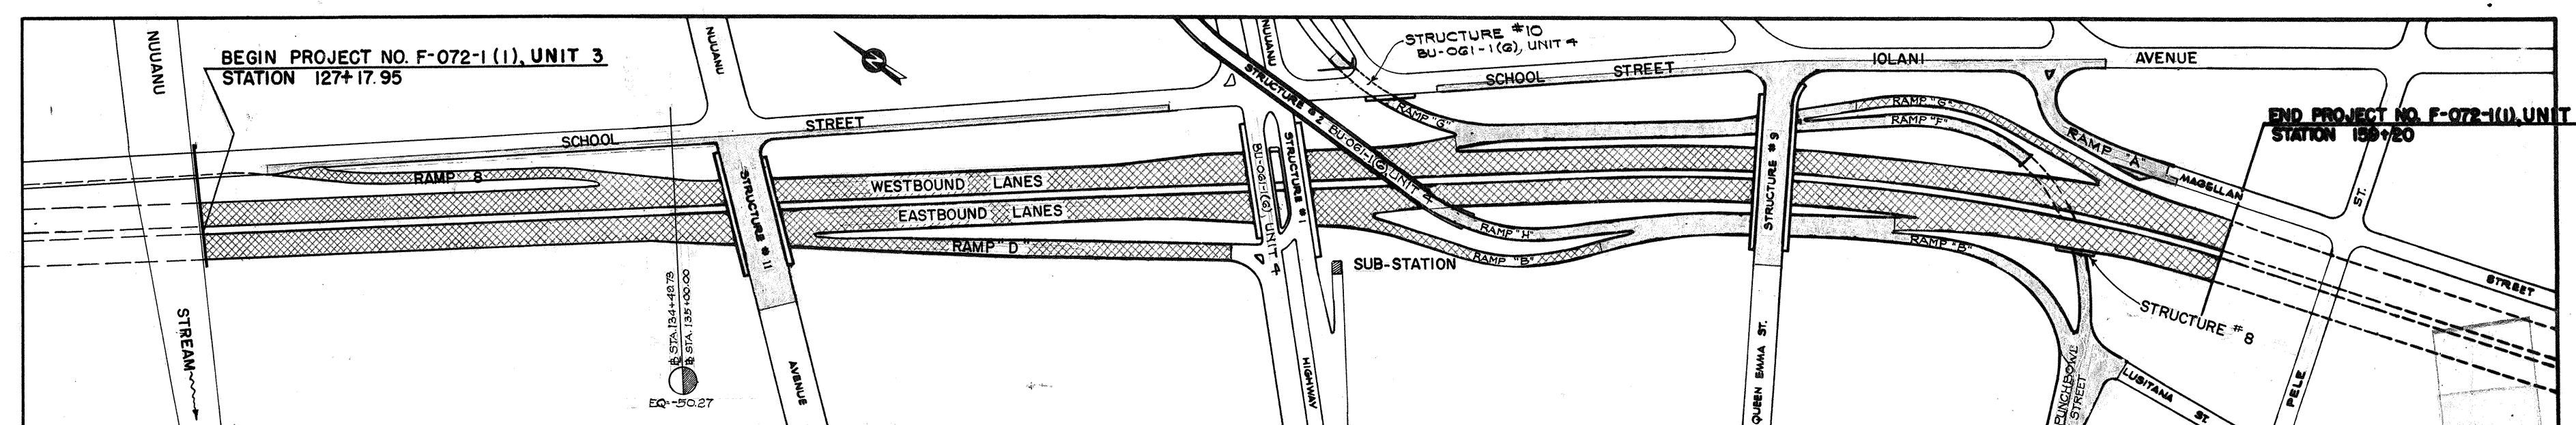

GROSS LENGTH OF PROJECT 0.597 MILE
BRIDGES OVER 20'-0" SPAN 0.009 MILE
NET LENGTH OF ROADWAY 0.588 MILE

LAYOUT PLAN

LEGEND
ROADWAY AREA TO BE COMPLETED WITH A. C., CURBS, ETC.
ROADWAY AREA TO HAVE SELECT BORROW ONLY

APPROVED *Wm. Whitte* DATE 11/24/58
TERRITORIAL HIGHWAY ENGINEER

DEPARTMENT OF COMMERCE
BUREAU OF PUBLIC ROADS
APPROVED: _____
DIVISION ENGINEER DATE

SHEET No. OF SHEETS

.8173 (1).1

DATE
DESIGNED BY
CHECKED BY
QUANTITIES BY
NOTED BY
ORIGINAL PLAN
NO.

DD-H-7