
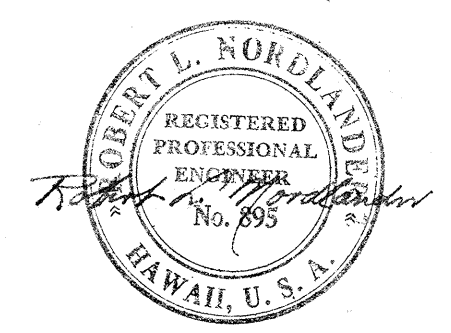


FED. ROAD DIST. NO.	STATE	FED. AID PROJ. NO.	FISCAL YEAR	SHEET NO.	TOTAL SHEETS
HAWAII	HAW.	US-0720(3)	1960	62	79
		BU-072-1(2)	1960	90	115
		BU-065-1(1)	1960	87	115

DATE	3-27
SURVEY PLOTTED BY	W. J. ...
ORIGINAL PLAN	...
TRACED BY	...
NOTE BOOK	...
CHECKED BY	...

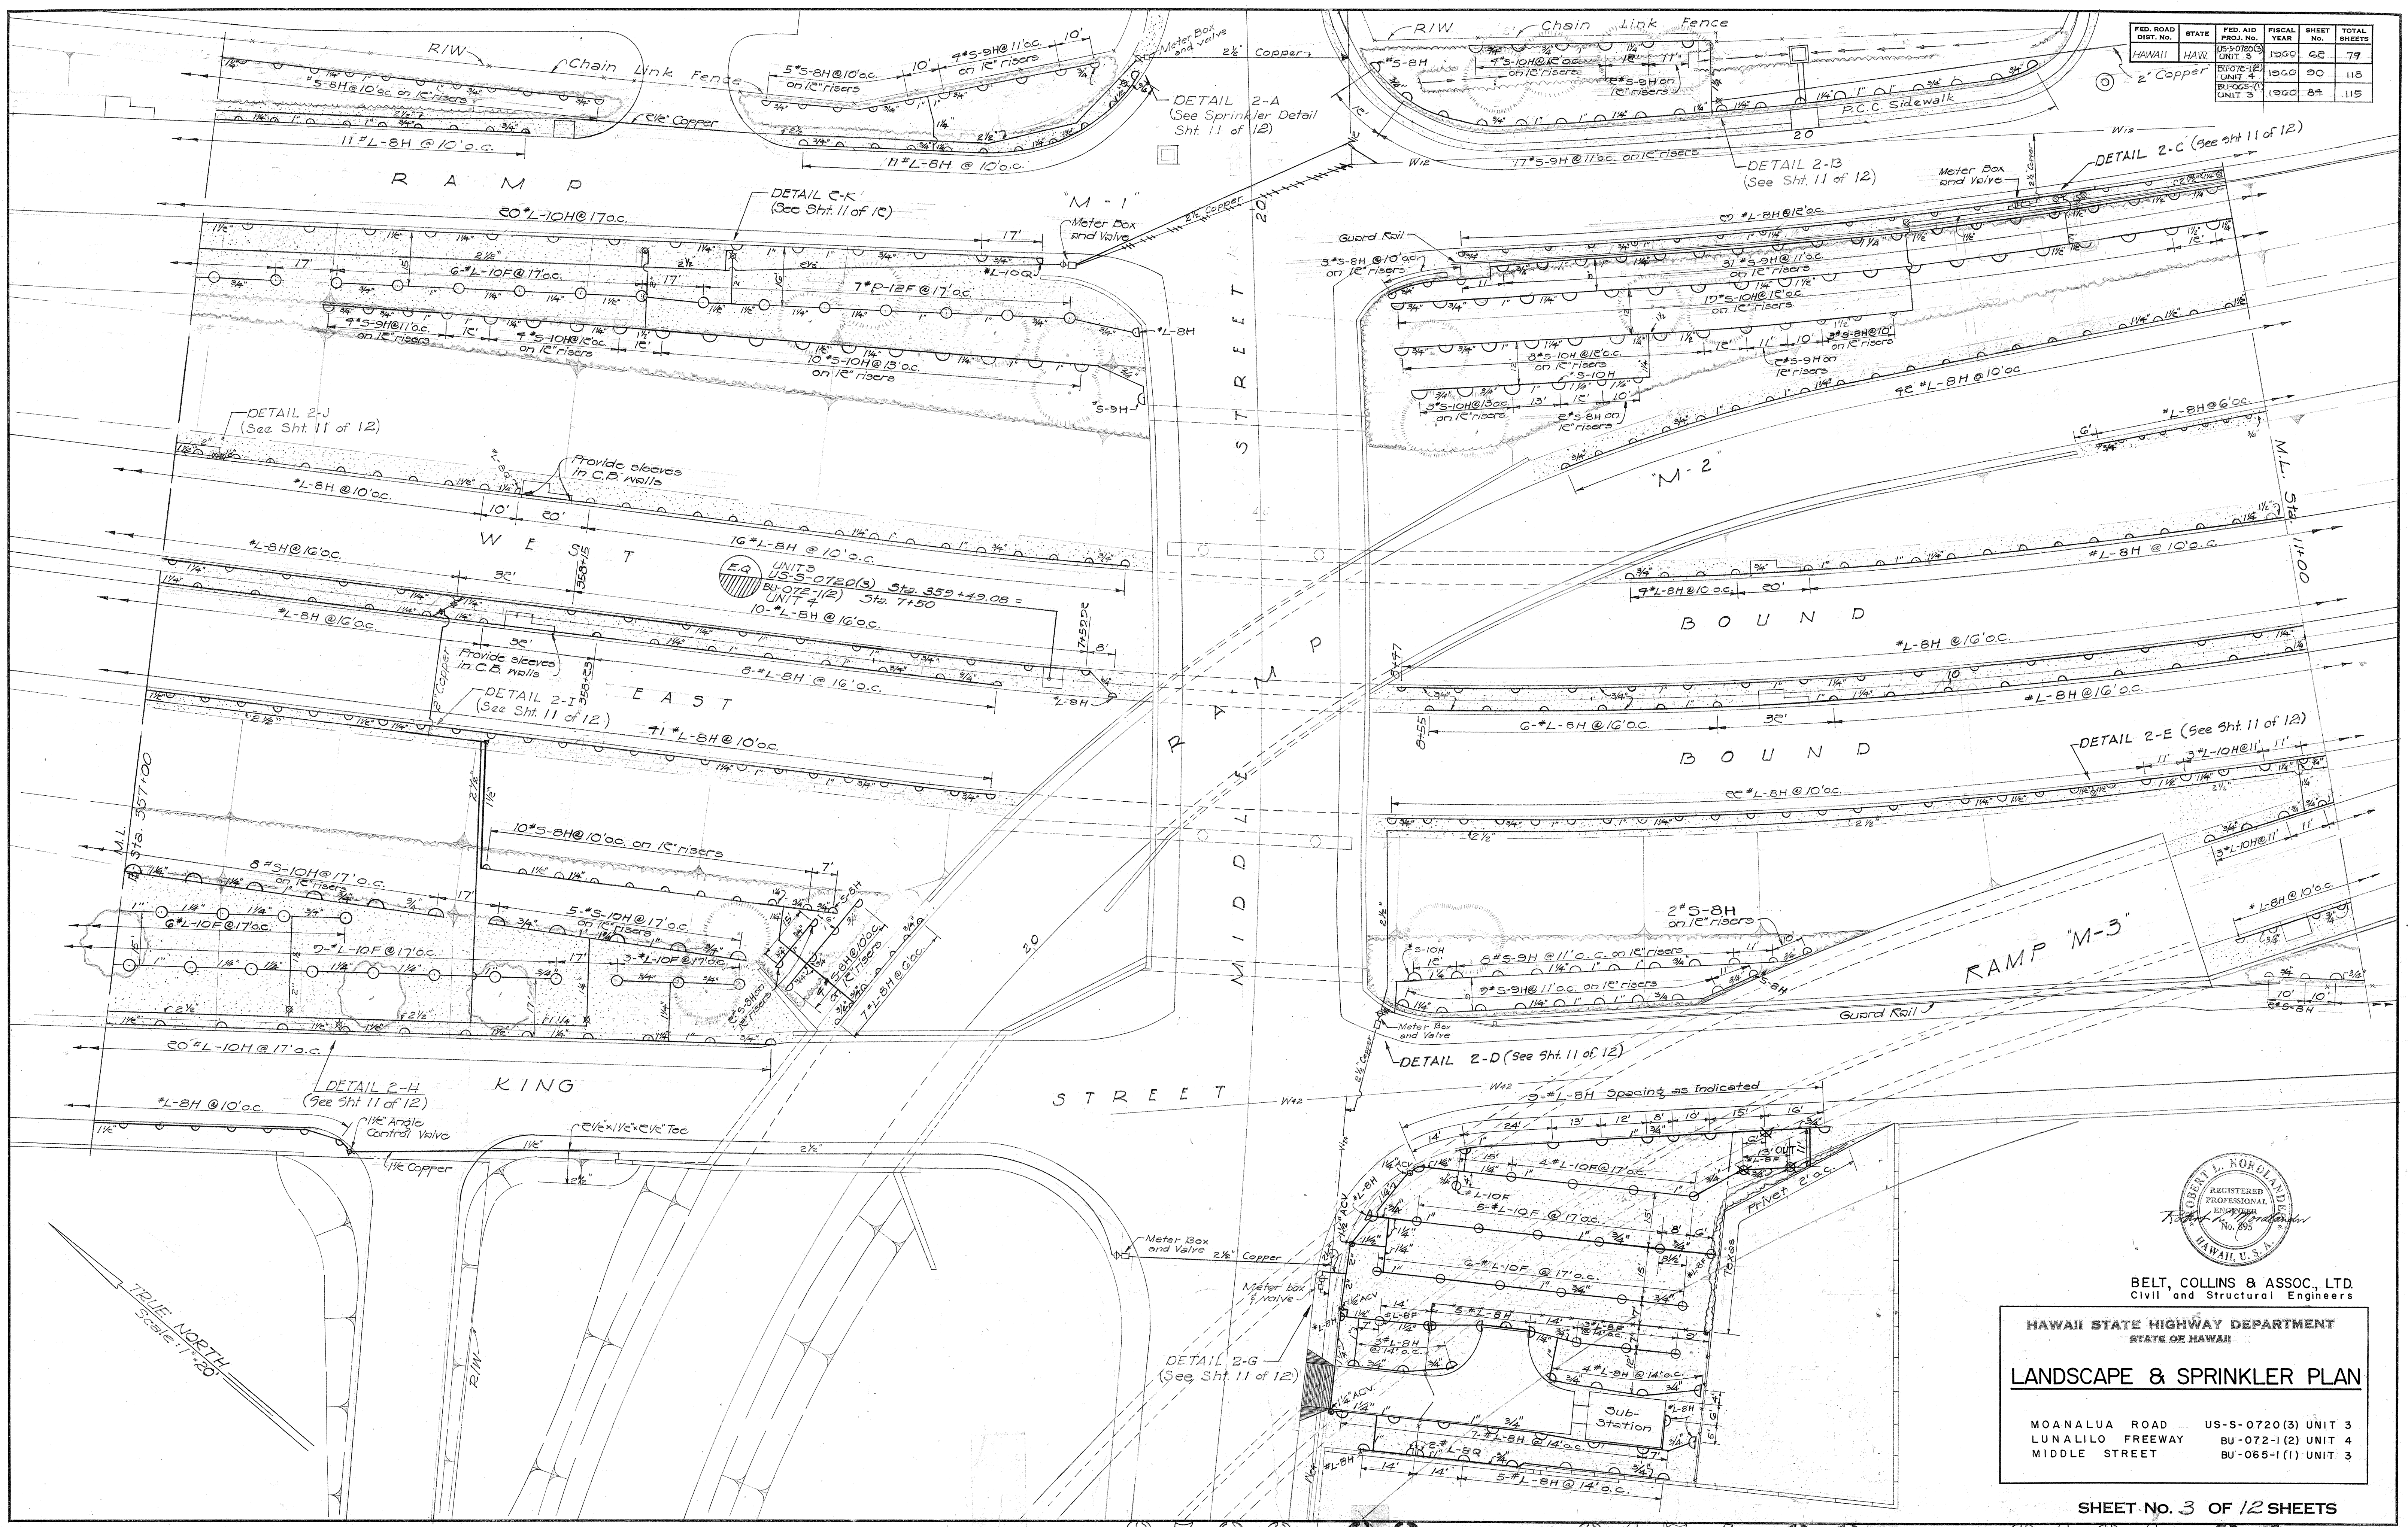

BELT, COLLINS & ASSOC., LTD.
Civil and Structural Engineers

HAWAII STATE HIGHWAY DEPARTMENT
STATE OF HAWAII

LANDSCAPE & SPRINKLER PLAN

MOANALUA ROAD US-S-0720(3) UNIT 3
LUNALILO FREEWAY BU-072-1(2) UNIT 4
MIDDLE STREET BU-065-1(1) UNIT 3

SHEET No. 3 OF 12 SHEETS

\$526.62 \$174.90 \$161.84 130


ORIGINAL PLAN	SURVEY PLOTTED BY DESIGNED BY <u>P. Hicrta</u> DRAWN BY <u>K. Watanabe</u> TRACED BY _____ QUANTITIES BY <u>P. Hicrta</u> QUANTITIES CHECKED BY _____ CHECKED BY <u>S. Taguchi</u>	DATE " 3-57 " 3-57 " 3-57 " 3-57
NOTE BOOK No.		

SHEET NO. 4 OF 12 SHEETS

\$1741.91 \$161.85 131

BELT, COLLINS & ASSOC., LTD.
Civil and Structural Engineers

FED. ROAD DIST. No.	STATE	FED. AID PROJ. No.	FISCAL YEAR	SHEET No.	TOTAL SHEET
HAWAII	HAW.	BU-072-1(2) UNIT 4	1960	92	118
		BU-065-1(1) UNIT 3	1960	86	115

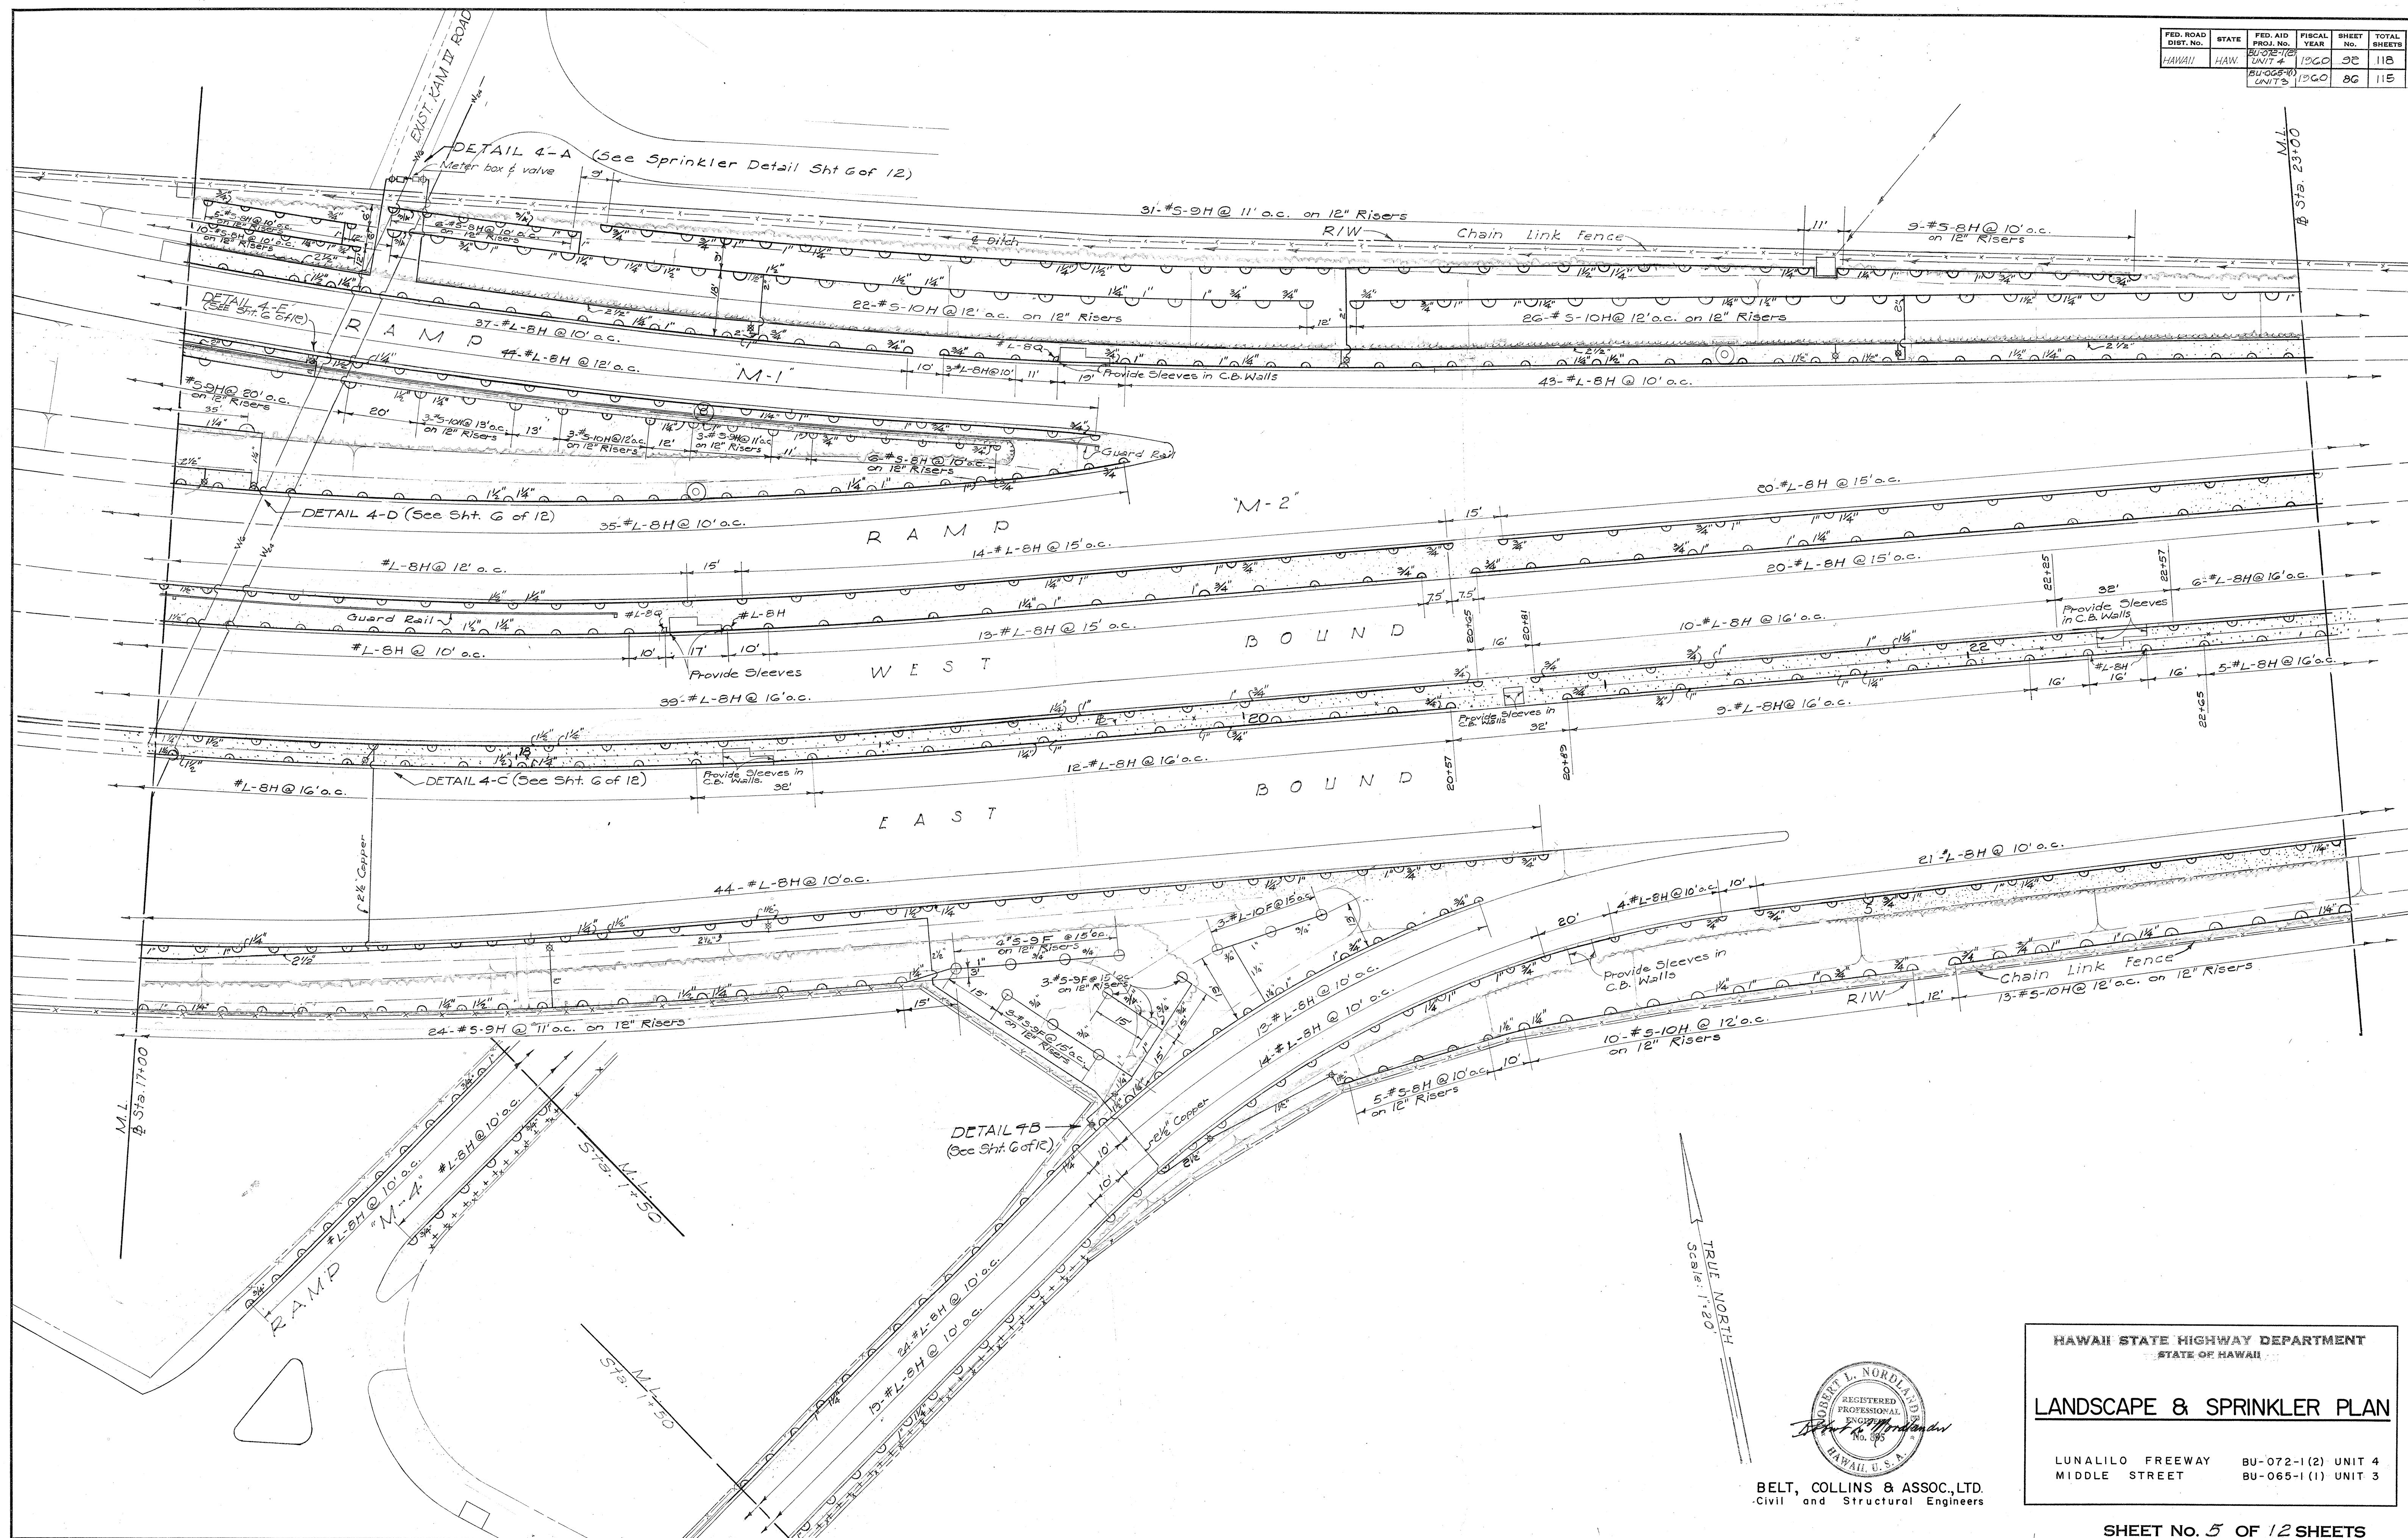

ORIGINAL PLAN	SURVEY PLOTTED BY		DATE
	DESIGNED BY	<i>P. Hirota</i>	" 3-57
	DRAWN BY	<i>R. Kakimaga</i>	" 3-57
	TRACED BY	"	"
	QUANTITIES BY	<i>P. Hirota</i>	" 3-57
	QUANTITIES CHECKED BY	"	"
	CHECKED BY	<i>R. Tazuchi</i>	" 3-57

BELT, COLLINS & ASSOC., LTD.
Civil and Structural Engineers

HAWAII STATE HIGHWAY DEPARTMENT
STATE OF HAWAII

LANDSCAPE & SPRINKLER PLAN

LUNALILO FREEWAY BU-072-1(2) UNIT 4
MIDDLE STREET BU-065-1(1) UNIT 3


SHEET No. 5 OF 12 SHEETS

\$174.92


§ 161. SG

132

FED. ROAD DIST. NO.	STATE	FED. AID PROJ. NO.	FISCAL YEAR	SHEET NO.	TOTAL SHEETS
HAWAII	HAW.	BU-072-1(2)	1960	93	118
		UNIT 4			
		BU-065-1(1)	1960	87	115

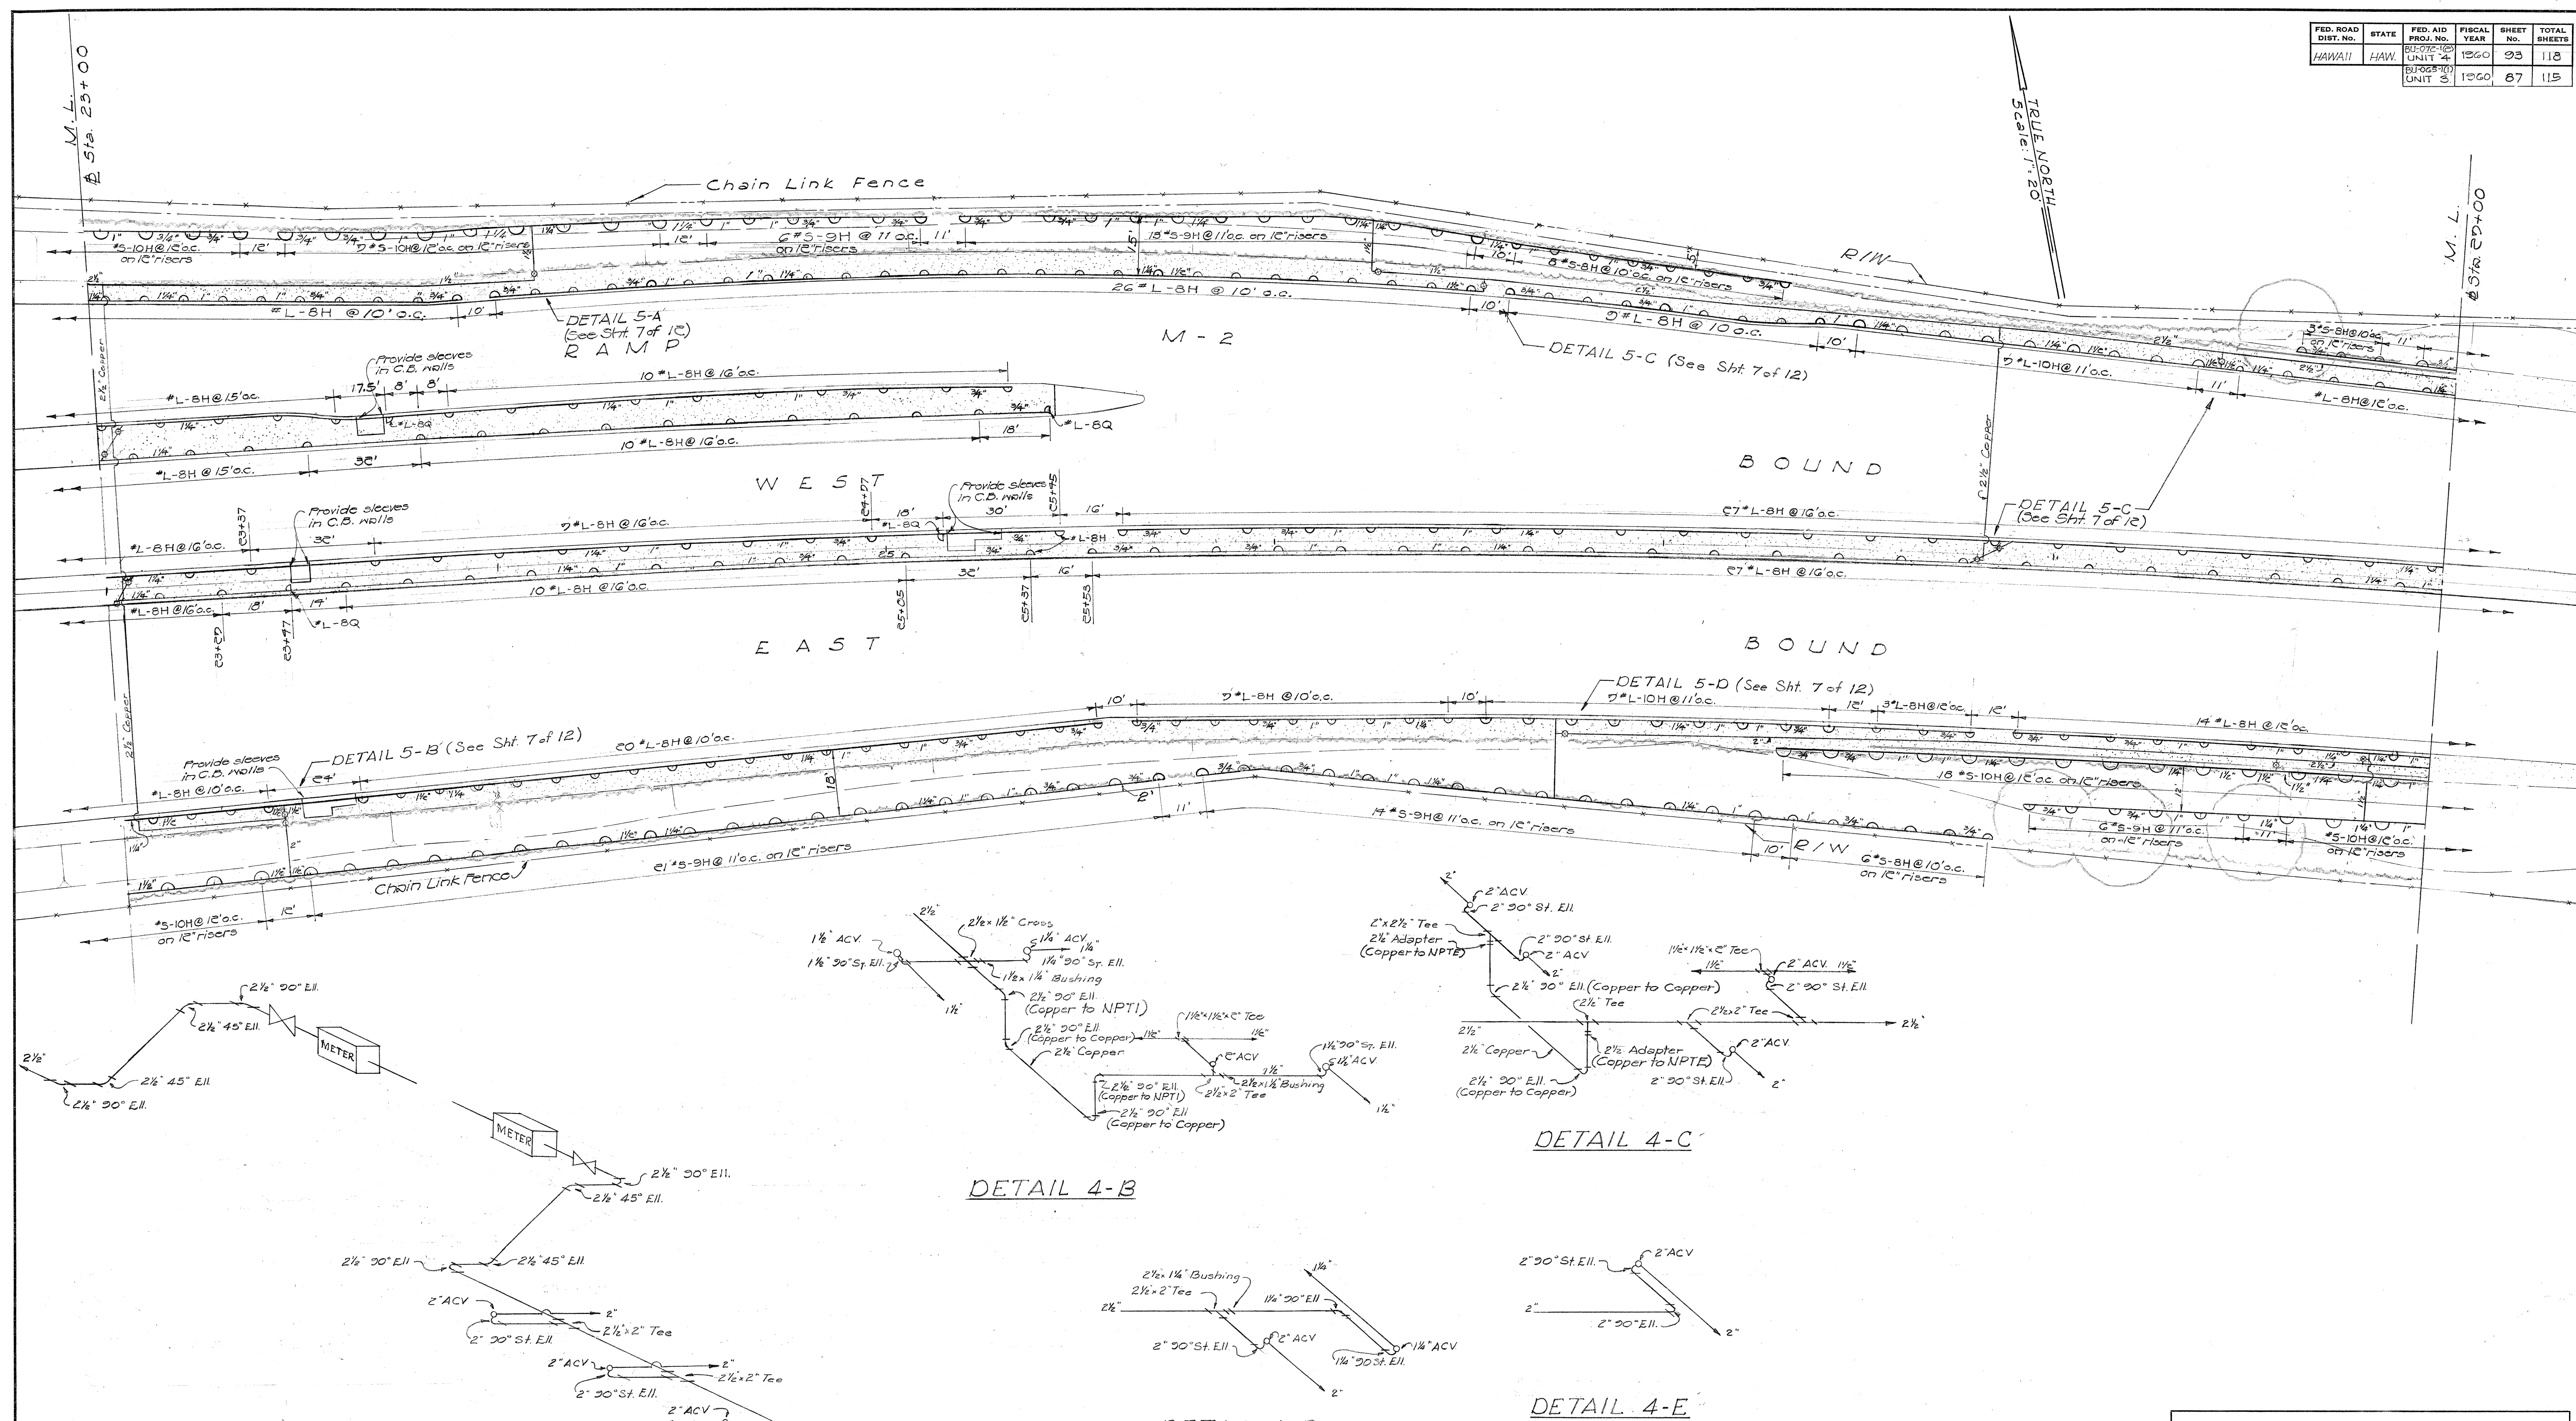

DATE	DESIGNED BY	TRACED BY	QUANTITIES BY	CHECKED BY
8-27	P. Wanda	P. Wanda	P. Wanda	P. Wanda
8-27				
8-27				
8-27				

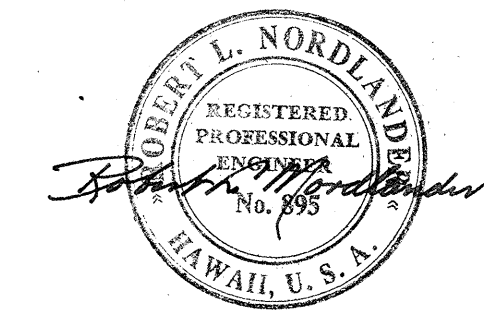

BELT, COLLINS & ASSOC. LTD.
Civil and Structural Engineers

HAWAII STATE HIGHWAY DEPARTMENT
STATE OF HAWAII


LANDSCAPE & SPRINKLER PLAN

LUNALILO FREEWAY BU-072-1(2) UNIT 4
MIDDLE STREET BU-065-1(1) UNIT 3


SHEET NO. 6 OF 12 SHEETS

\$174.93 \$161.87 133

FED. ROAD DIST. NO.	STATE	FED. AID PROJ. NO.	FISCAL YEAR	SHEET NO.	TOTAL SHEETS
HAWAII	HAW.	BU-072-1(2)	1960	94	118
		UNIT 4			
		BU-065-1(1)	1960	88	115
		UNIT 3			

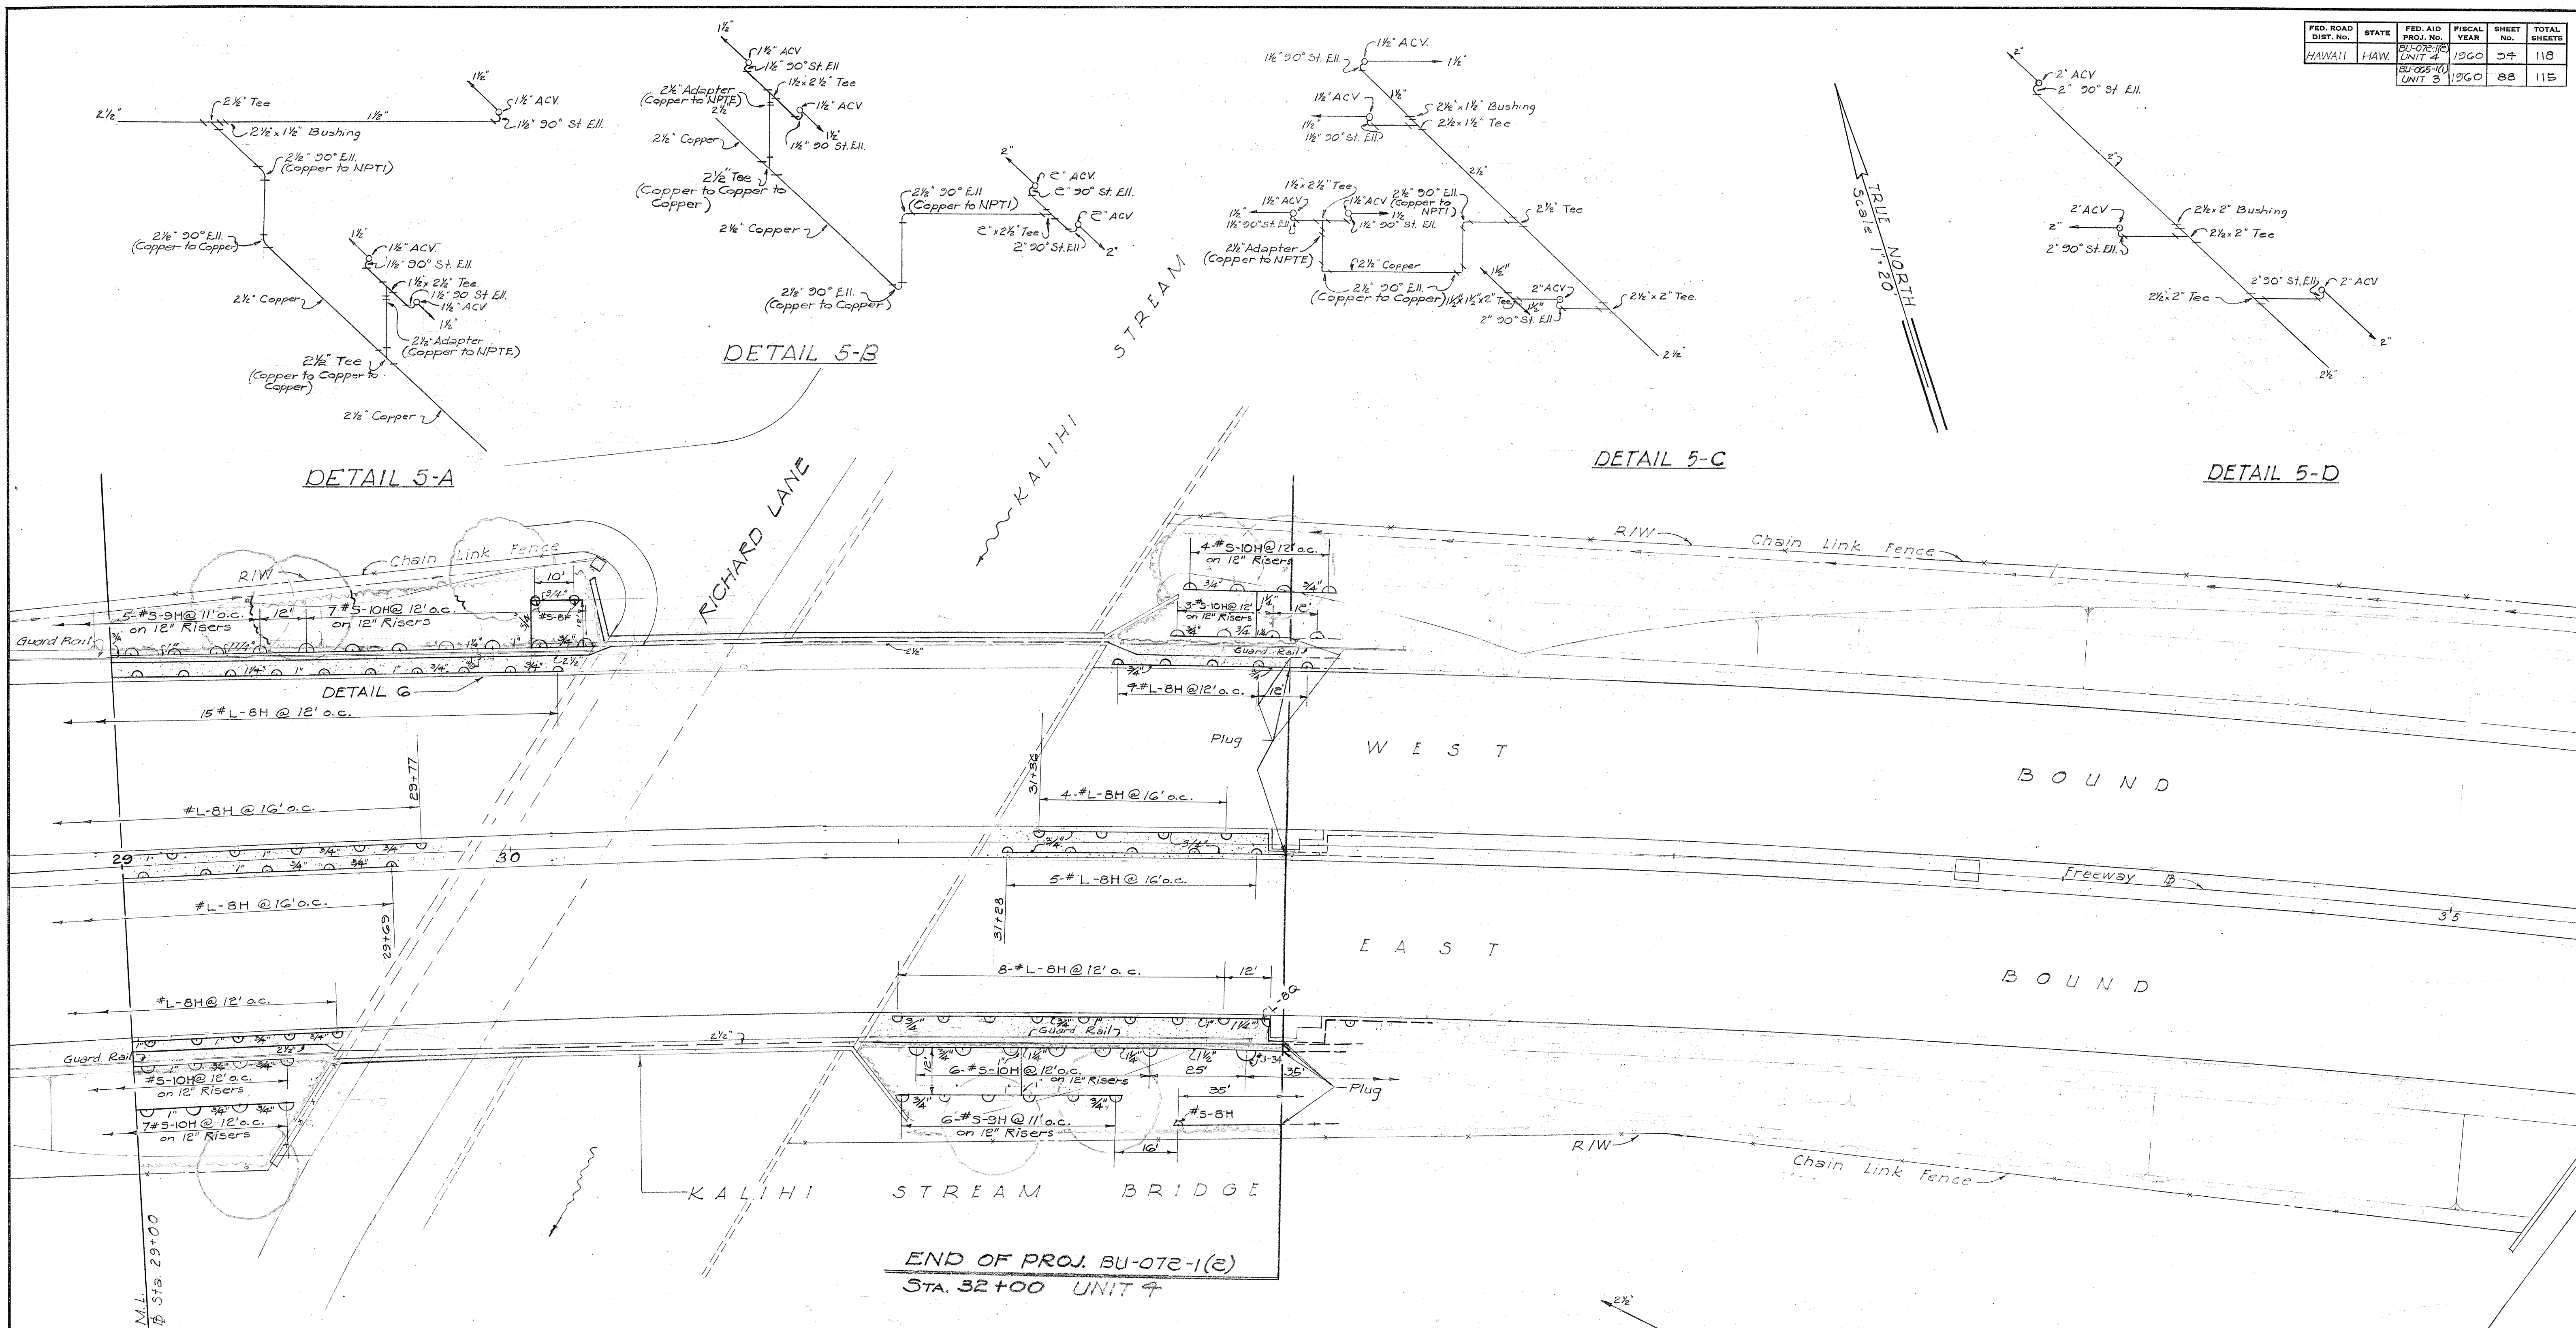

SURVEY PLOTTED BY	DATE
DESIGNED BY	
DRAWN BY	
TRACED BY	
QUANTITIES CHECKED BY	
CHECKED BY	
ORIGINAL PLAN	
NOTE BOOK	
No.	

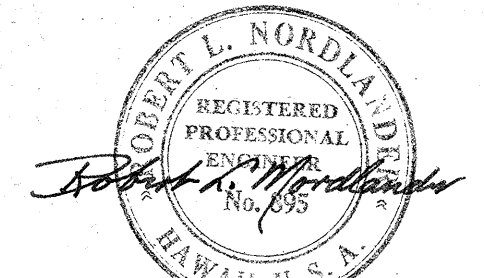

BELT, COLLINS & ASSOC., LTD.
Civil and Structural Engineers

HAWAII STATE HIGHWAY DEPARTMENT
STATE OF HAWAII

LANDSCAPE & SPRINKLER PLAN

LUNALILO FREEWAY BU-072-1(2) UNIT 4
MIDDLE STREET BU-065-1(1) UNIT 3

SHEET No. 7 OF 12 SHEETS

See Sheet 3 of 12
for continuation of
1 1/2" Line.



FED. ROAD DIST. NO.	STATE	FED. AID PROJ. NO.	FISCAL YEAR	SHEET NO.	TOTAL SHEETS
US-0720(3)	HAW.	0720(3)	1960	64	79
UNIT 3		BU-072-1(2)	1960	96	118
		BU-065-1(1)	1960	98	115

DETAIL 1-A

DETAIL 1-B

DETAIL 1-C

DETAIL 1-D

DETAIL 1-G

DETAIL 1-E

DETAIL 1-F

DETAIL 2-A

DETAIL 2-B

DETAIL 2-C

DETAIL 2-D

DETAIL 2-E


DETAIL 2-G

DETAIL 2-H

DETAIL 2-I

DETAIL 2-J

DETAIL 2-K

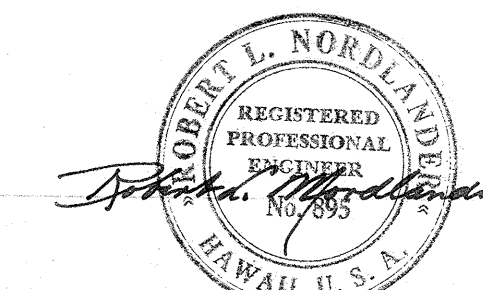

BELT, COLLINS & ASSOC., LTD.
Civil and Structural Engineers

HAWAII STATE HIGHWAY DEPARTMENT
STATE OF HAWAII

LANDSCAPE & SPRINKLER PLAN







MOANALUA ROAD US-S-0720(3) UNIT 3
MIDDLE STREET BU-072-1(2) UNIT 4
LUNALILOV FREEWAY BU-065-1(1) UNIT 3

SHEET No. 11 OF 12 SHEETS

\$526.64 \$174.96 \$161.92 138

DESIGNED BY	DATE
DRAWN BY	3-57
CHECKED BY	3-57
QUANTITIES CHECKED BY	3-57
NOTE BOOK	
No.	

FED. ROAD DIST. NO.	STATE	FED. AID PROJ. NO.	FISCAL YEAR	SHEET No.	TOTAL SHEETS
HAWAII	HAW.	US-5-070-0(3) UNIT 3	1960	65	79
		BU-070-1(1) UNIT 4	1960	97	118
		BU-065-1(1) UNIT 3	1960	93	115

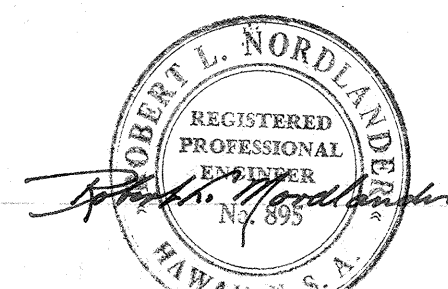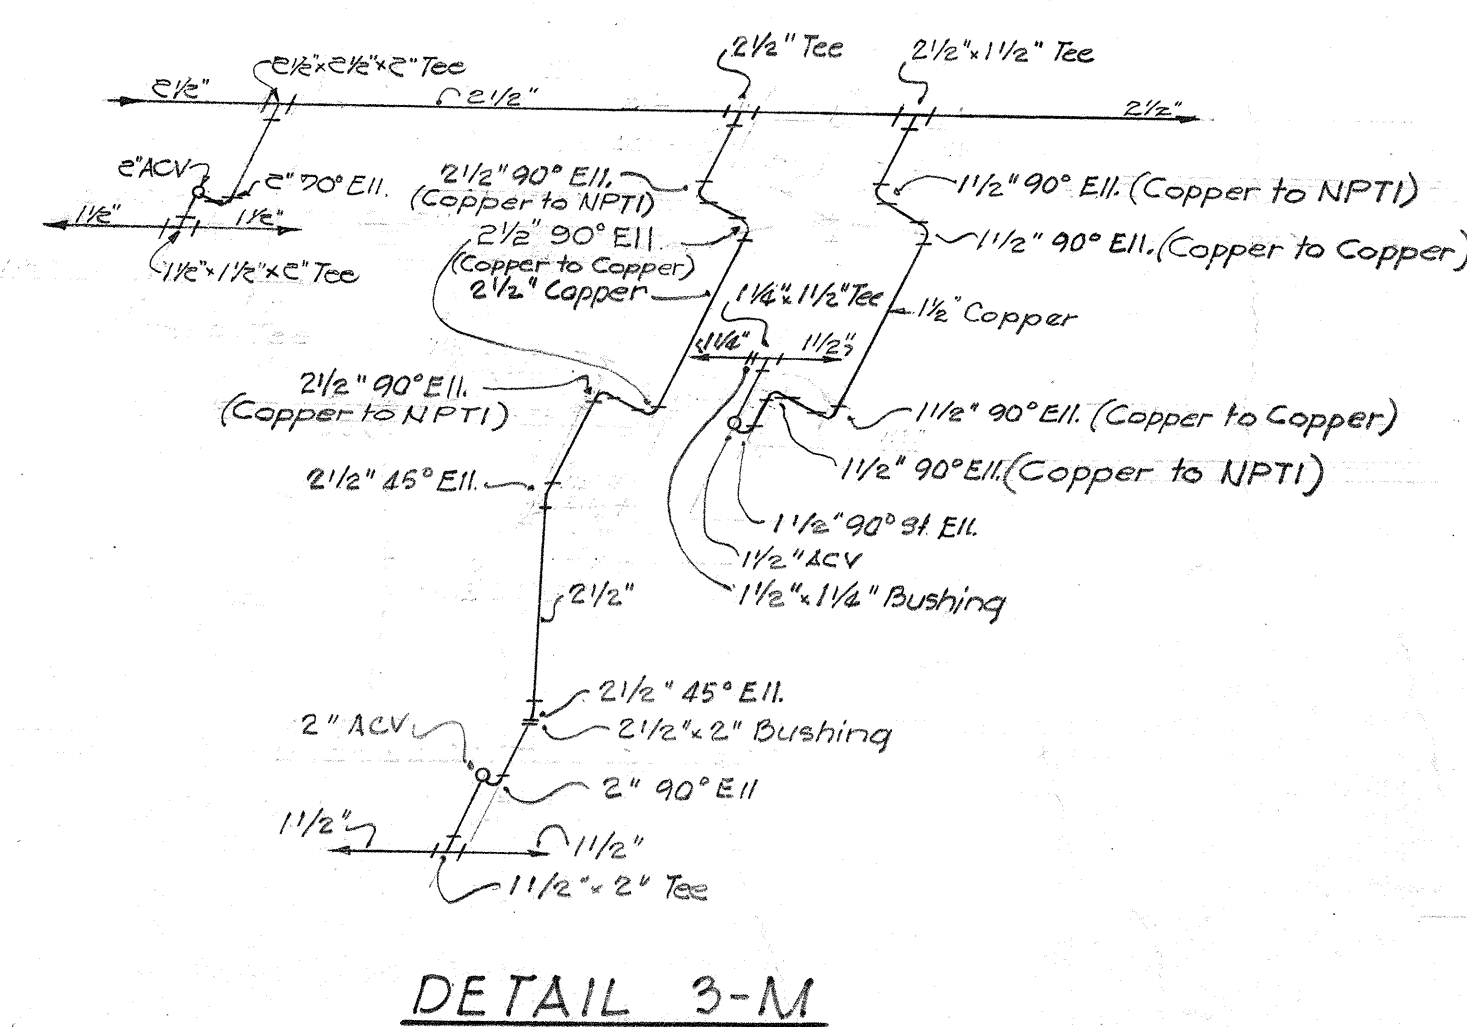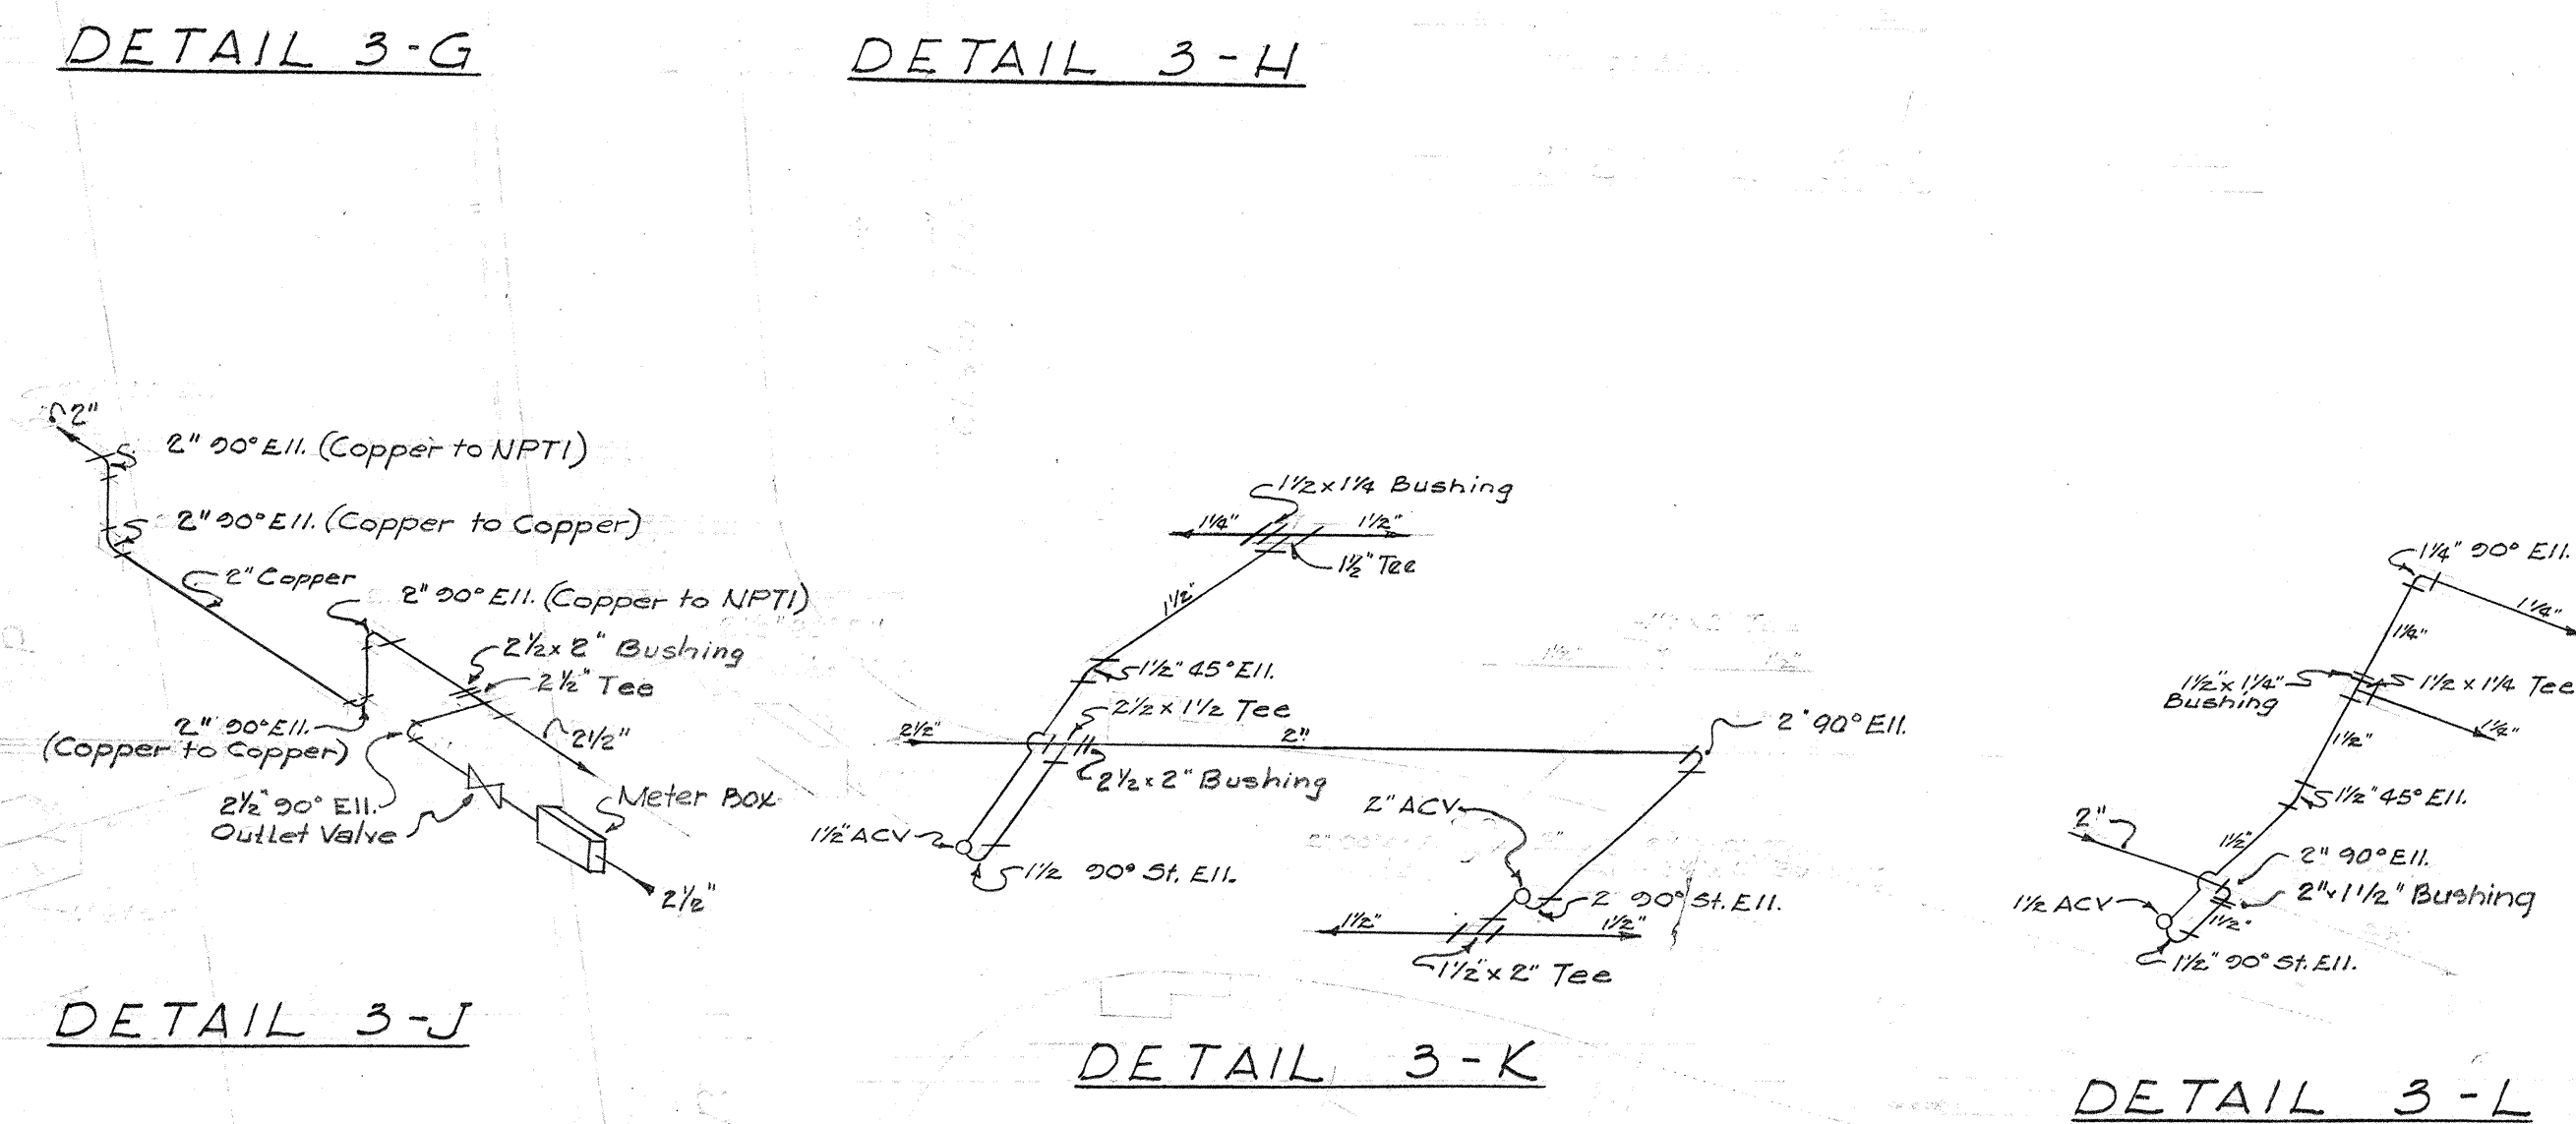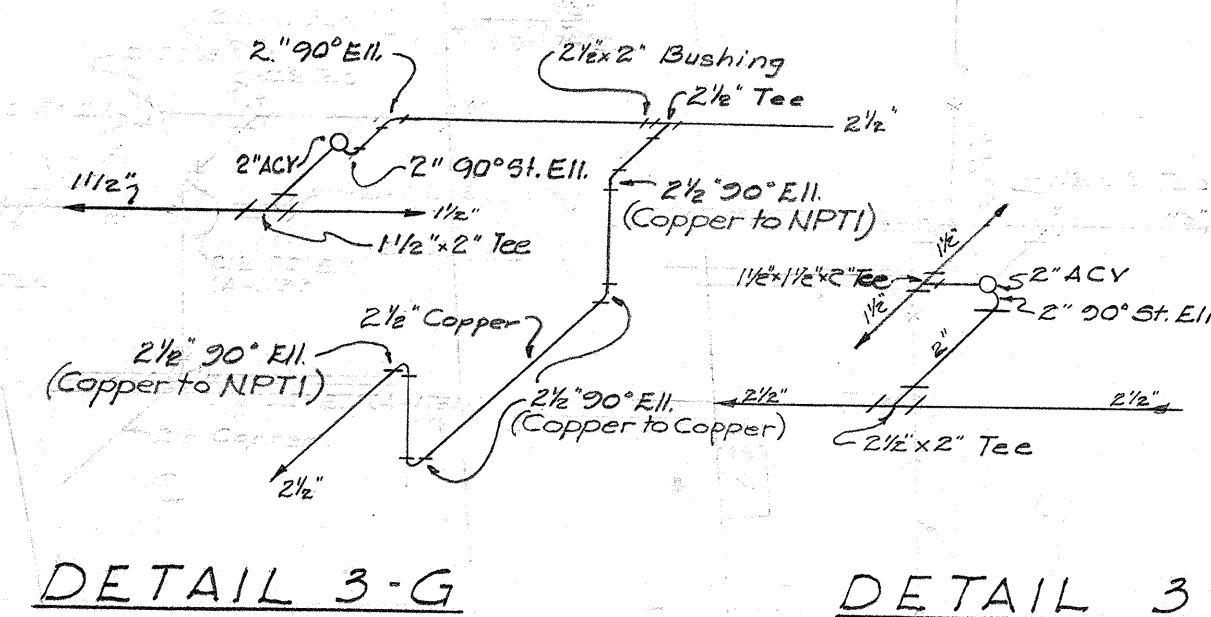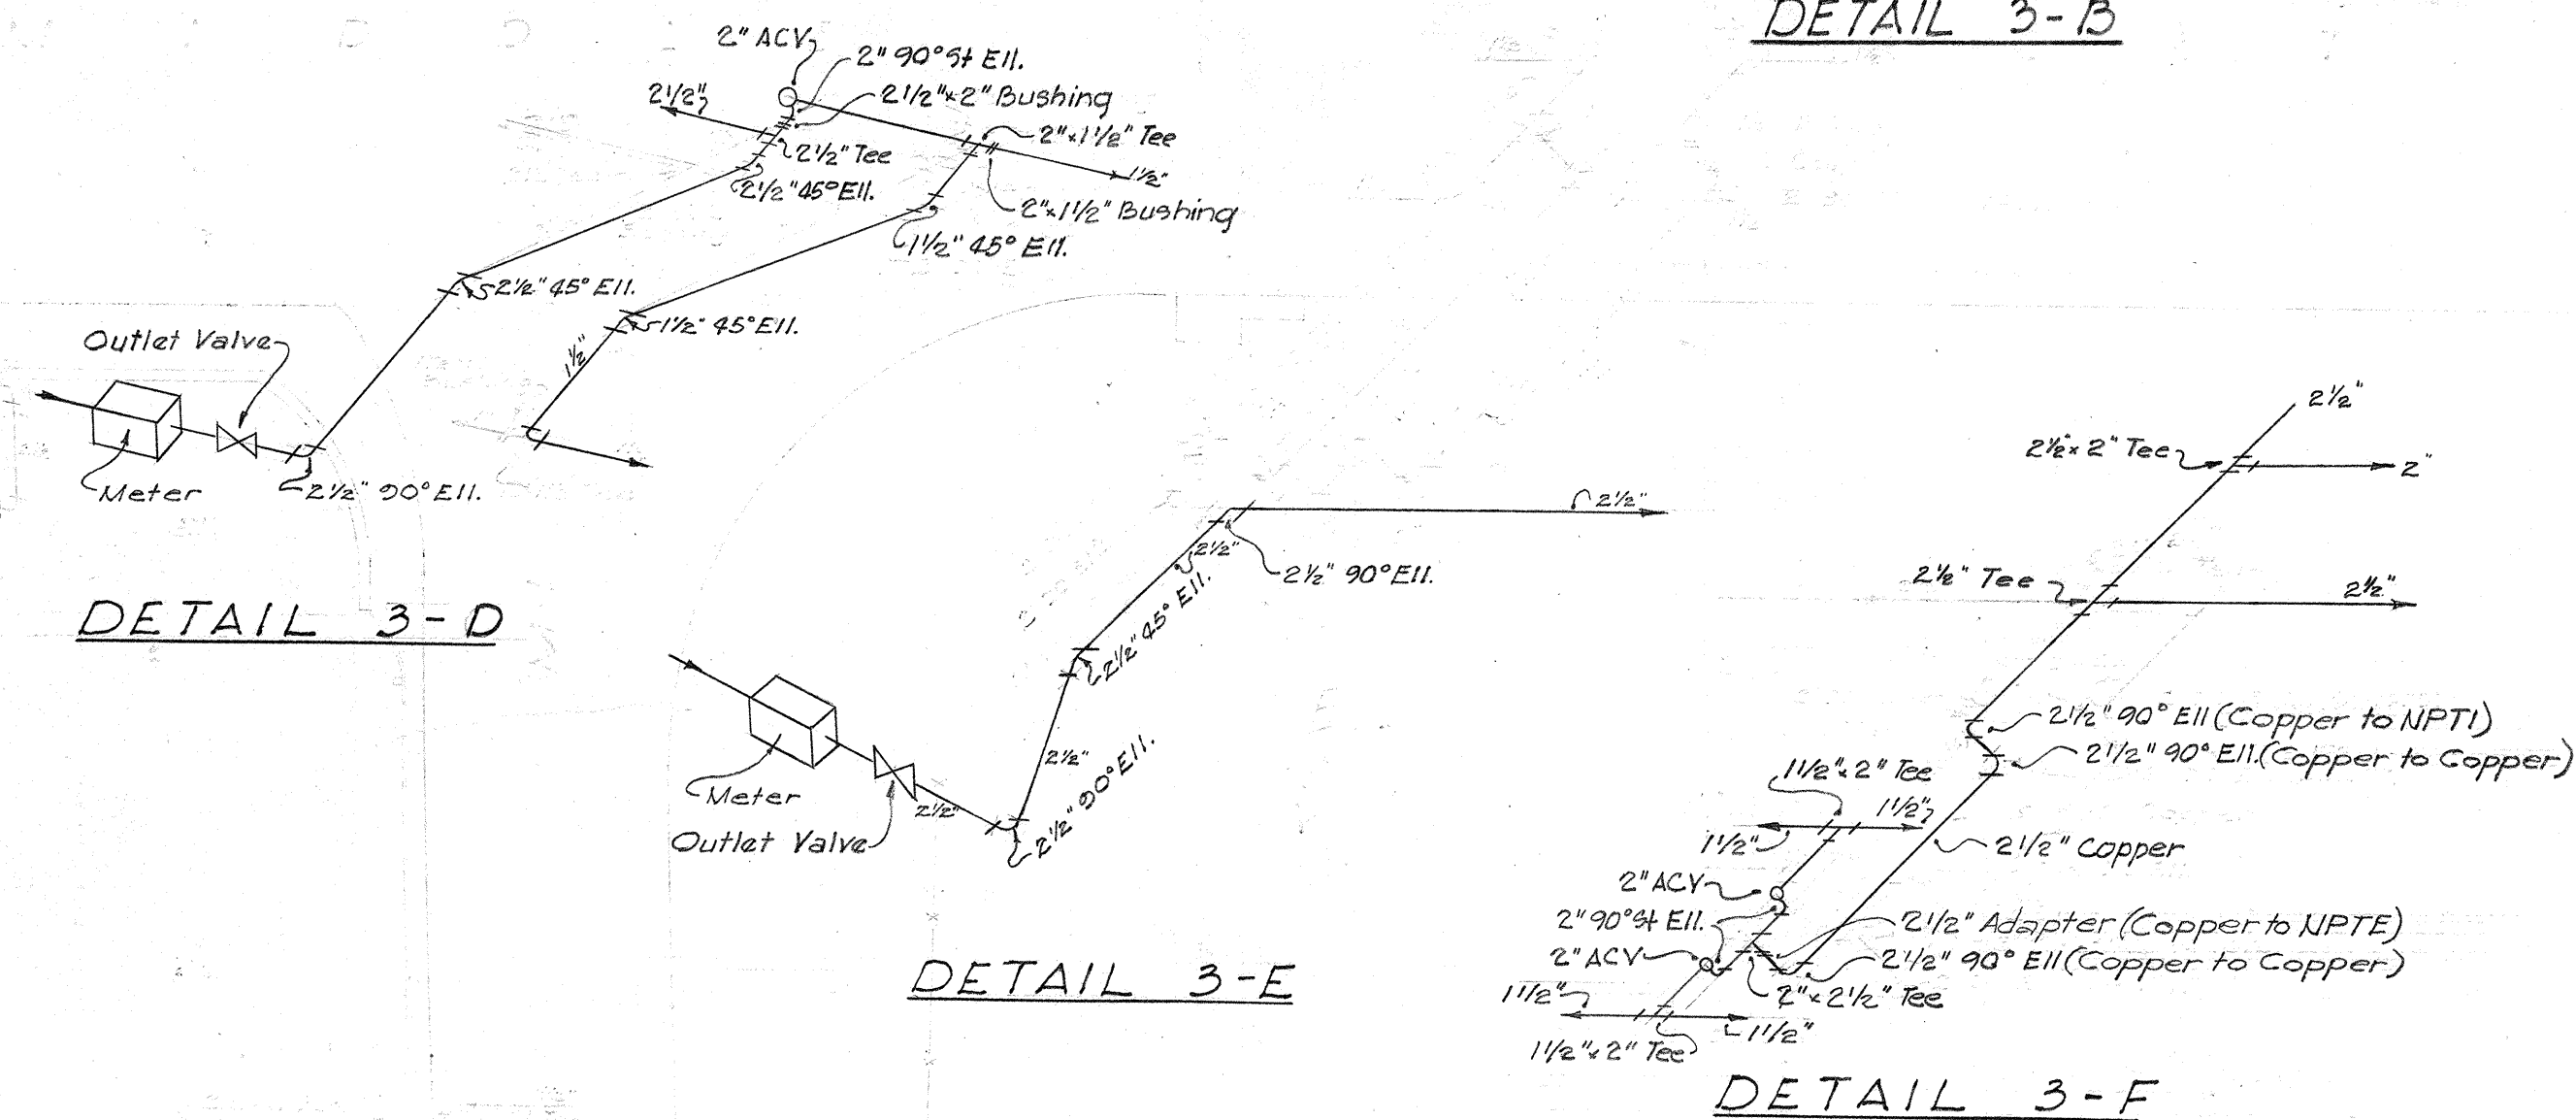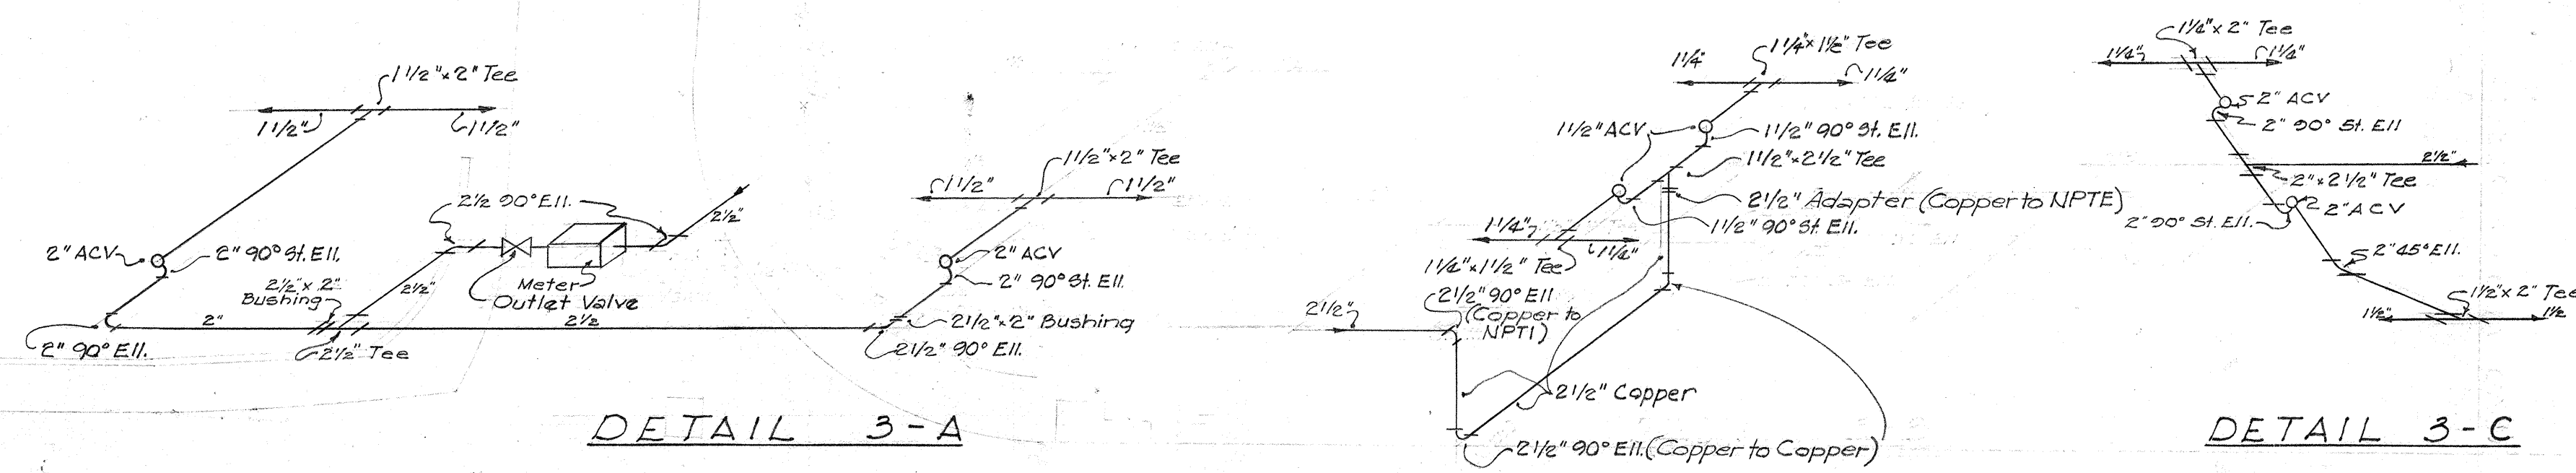

HAWAII STATE HIGHWAY DEPARTMENT
STATE OF HAWAII

LANDSCAPE & SPRINKLER PLAN

MOANALUA ROAD	US-S-0720 (3) UNIT 3
LUNALILO FREEWAY	BU-072-I (2) UNIT 4
MIDDLE STREET	BU-065-I (1) UNIT 3

SHEET No. 12 OF 12 SHEETS

ORIGINAL PLAN	SURVEY PLOTTED BY DESIGNED BY <i>P. Hirota</i> DRAWN BY <i>M. Nagita</i>	DATE " <i>3-37</i> " <i>8-57</i>
NOTE BOOK No.	TRACED BY QUANTITIES CHECKED BY <i>P. Hirota</i> CHECKED BY <i>S. Taguchi</i>	" <i>3-57</i> " <i>3-57</i> " <i>3-57</i>

PRINTED ON DIEPO 1000H CLEARPRINT

SHEET NO. 7 OF 12 SHEETS

\$526.65 \$174.97 \$161.93 139