

INDEX TO DRAWINGS		
SHEET NO.	DESCRIPTION	COMP. SHEET NO.
1	Title Sheet	2
2-5	Typical Sections	4-7
6-12	Plan & Profile	8-10, 12, 13, 15, 16
13-13A	Construction Phases	17-17A
14-15	Boring Logs	18-19
16-22	Detail Plan of Roadway	22-26, 29, 30
23-25A	Miscellaneous Details	31-33A
26-27	Storm Drain Details	34-35
28-33	Structure "A"	43-48
34-36	Ola Lane Overpass	64-66
37-43	Kalihi Stream Bridge	67-73
44-46	Typical Structural Details	74-76
47A-47B	Standard Bridge Details	77A-77B
48	St'd Aluminum Railing Detail	78
49-51	Retaining Walls	79-81
52-54	Telephone, Electric, Gas & Existing Utilities	82-84
55-59	Standard Details for Utilities	86-88, 90-91
60-66	Sewer System	92-98
67-73	Water System	99, 101-106
74	Telephone Syst. Details (Ft. Shafter)	112
75-83	Lighting, Signal System & Sub-Sta.	113-121
84-89D	Traffic Signs	122-127D
90-97	Landscape & Sprinkler Plans	130-134, 137-139
98-100	Rehabilitation of Bldgs "A" & "B"	140-142
101A-101K	Standard Details	143A-143K
102-118	Cross Sections	156-168, 174-177

Sheet No. 4
DELETED

Sheet No. 6
DELETED

STATE OF HAWAII
DEPARTMENT OF TRANSPORTATION
DIVISION OF HIGHWAYS
HONOLULU, OAHU, HAWAII
"AS BUILT"
PLANS OF

LUNALILO FREEWAY MIDDLE STREET TO PINKHAM STREET


FEDERAL AID PROJECT NO. BU-072-1(2), UNIT 4

DISTRICT OF HONOLULU
ISLAND OF OAHU


NOTE:
ALL CHANGES MADE DURING CONSTRUCTION
HAVE BEEN NOTED IN RED ON THESE TRACINGS
AND CHECKED BY

RESIDENT ENGINEER

DATE

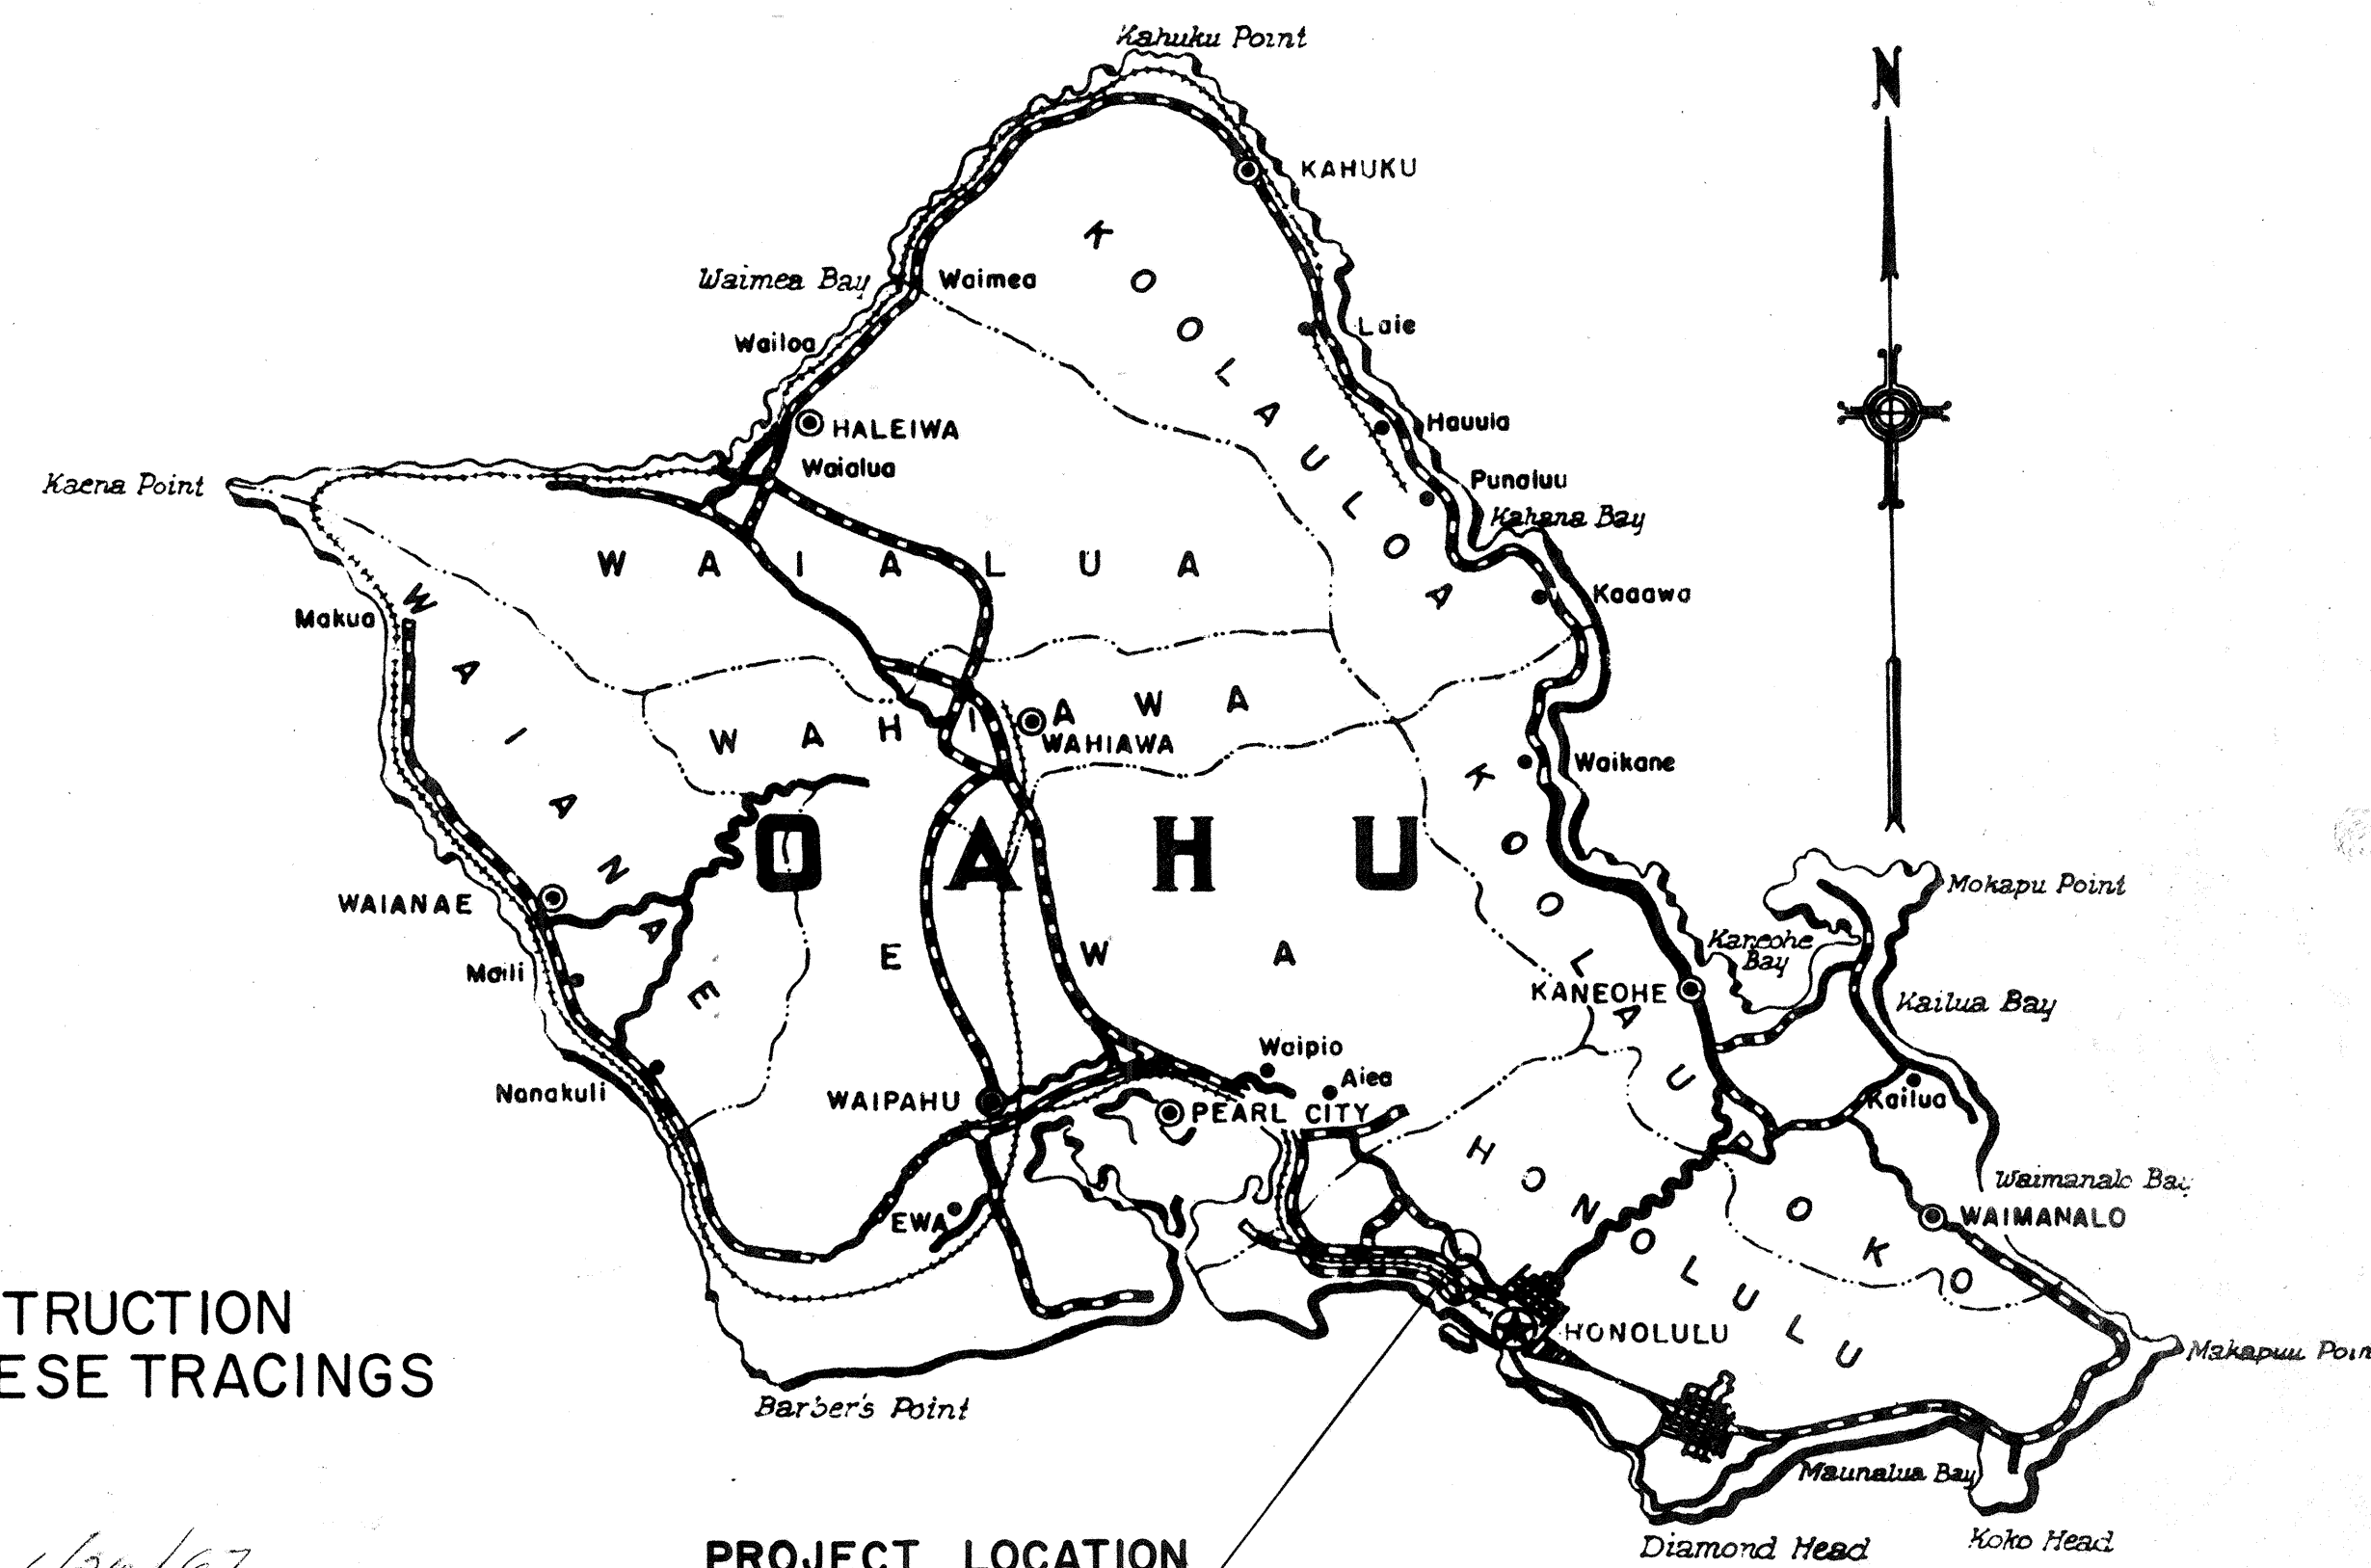

Federal Aid Projects Previously Constructed Or Under Construction

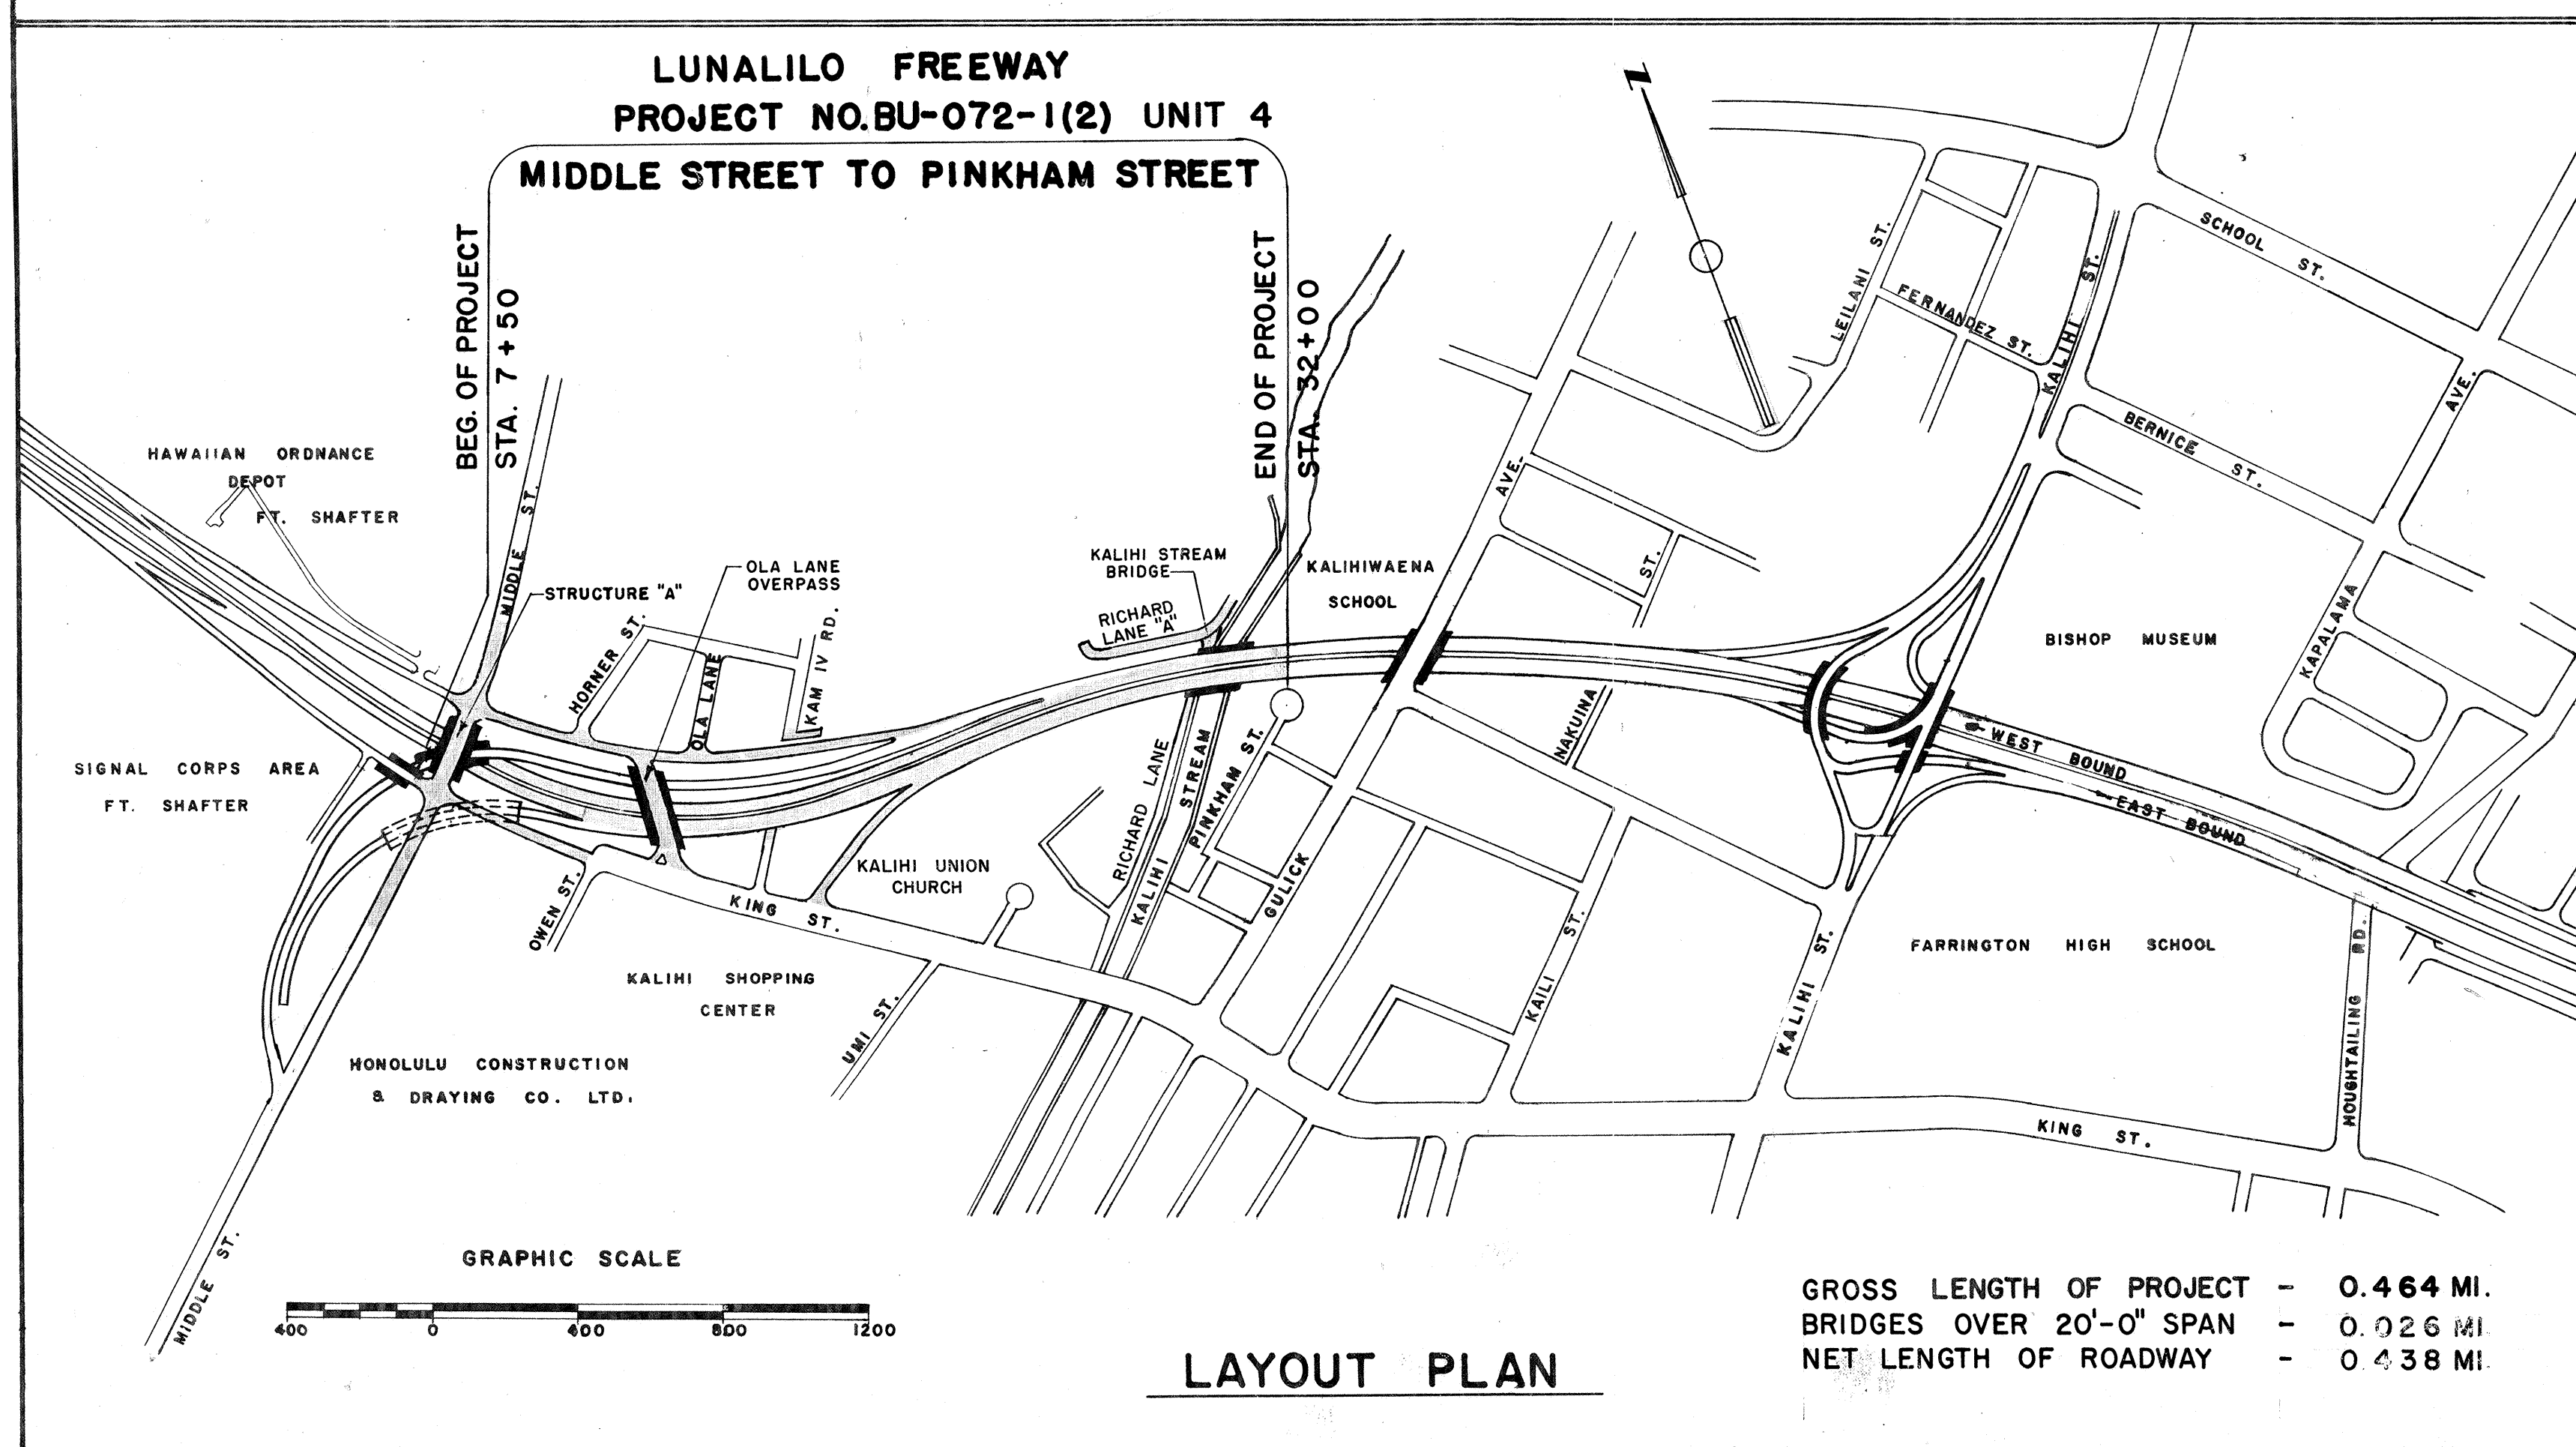

BELT, COLLINS & ASSOCIATES, LTD.
Civil and Structural Engineers

· ASSOCIATES ·

MOFFATT, NICHOL & TAYLOR - Structural Engineers
JAMES B. MANN - Surveyor
PAUL R. WEISSICH - Landscape Architect
WYNN NAKAMURA - Electrical Engineer

APPROVED: *[Signature]* DATE 2-20-50
DIRECTOR OF TRANSPORTATION

DEPARTMENT OF COMMERCE
BUREAU OF PUBLIC ROADS
APPROVED: _____
DIVISION ENGINEER DATE

8174.1