

INDEX OF DRAWINGS	
SHEET NO.	DESCRIPTION
1	TITLE SHEET
2 - 6	TYPICAL SECTIONS
7 - 17	PLAN & PROFILE W/S.E. DATA
18 - 29	DETAIL ROADWAY PLANS
30 - 59	SPECIAL DETAILS
(30-37)	ROADWAY
(38-52)	DRAINAGE 42A & 42B ADDED SHT.
(53-59)	R/W ADJUSTMENTS
60-84	ELECTRIC & TELEPHONE UTILITIES W/DETAILS
85-101	WATER, SEWER & GAS UTILITIES W/DETAILS
102-122	REGULATORY, WARNING AND GUIDE SIGNS WITH DETAILS 102B & 112B ADDED SHT.
123-127	TRAFFIC SIGNAL SYSTEM
128-133	HIGHWAY LIGHTING PLANS
134-138	LANDSCAPING PLANS
139-149	SPRINKLER SYSTEM PLANS
150-155	PEDESTRIAN CROSSING STRUCTURES
22, 36	GRADE SEPARATION STRUCTURES AND
156-183	RETAINING WALLS WITH DETAILS
184-217	CROSS SECTIONS
218B	R/W ADJUSTMENTS
219B-220B	BOX CULVERT DETAILS (DELETED)
221B	UTILITY DETAILS
222B-231B	TEMPORARY RAMPS - PLANS & DETAILS

STATE OF HAWAII
DEPARTMENT OF TRANSPORTATION
HIGHWAYS DIVISION
HONOLULU, HAWAII



PLANS OF
LUNALILO FREEWAY
FIRST AVENUE TO KOKO HEAD AVENUE
FEDERAL AID INTERSTATE PROJECT No. I-HI-1(4):24
DISTRICT OF HONOLULU
ISLAND OF OAHU
"AS BUILT"
SCALES:

PLAN & PROFILEHOR.
.....VER.

1" = 50'
1" = 10'

DETAIL ROADWAY PLAN
CROSS SECTION.....HOR.
.....VER.

1" = 20'
1" = 10'
1" = 10'

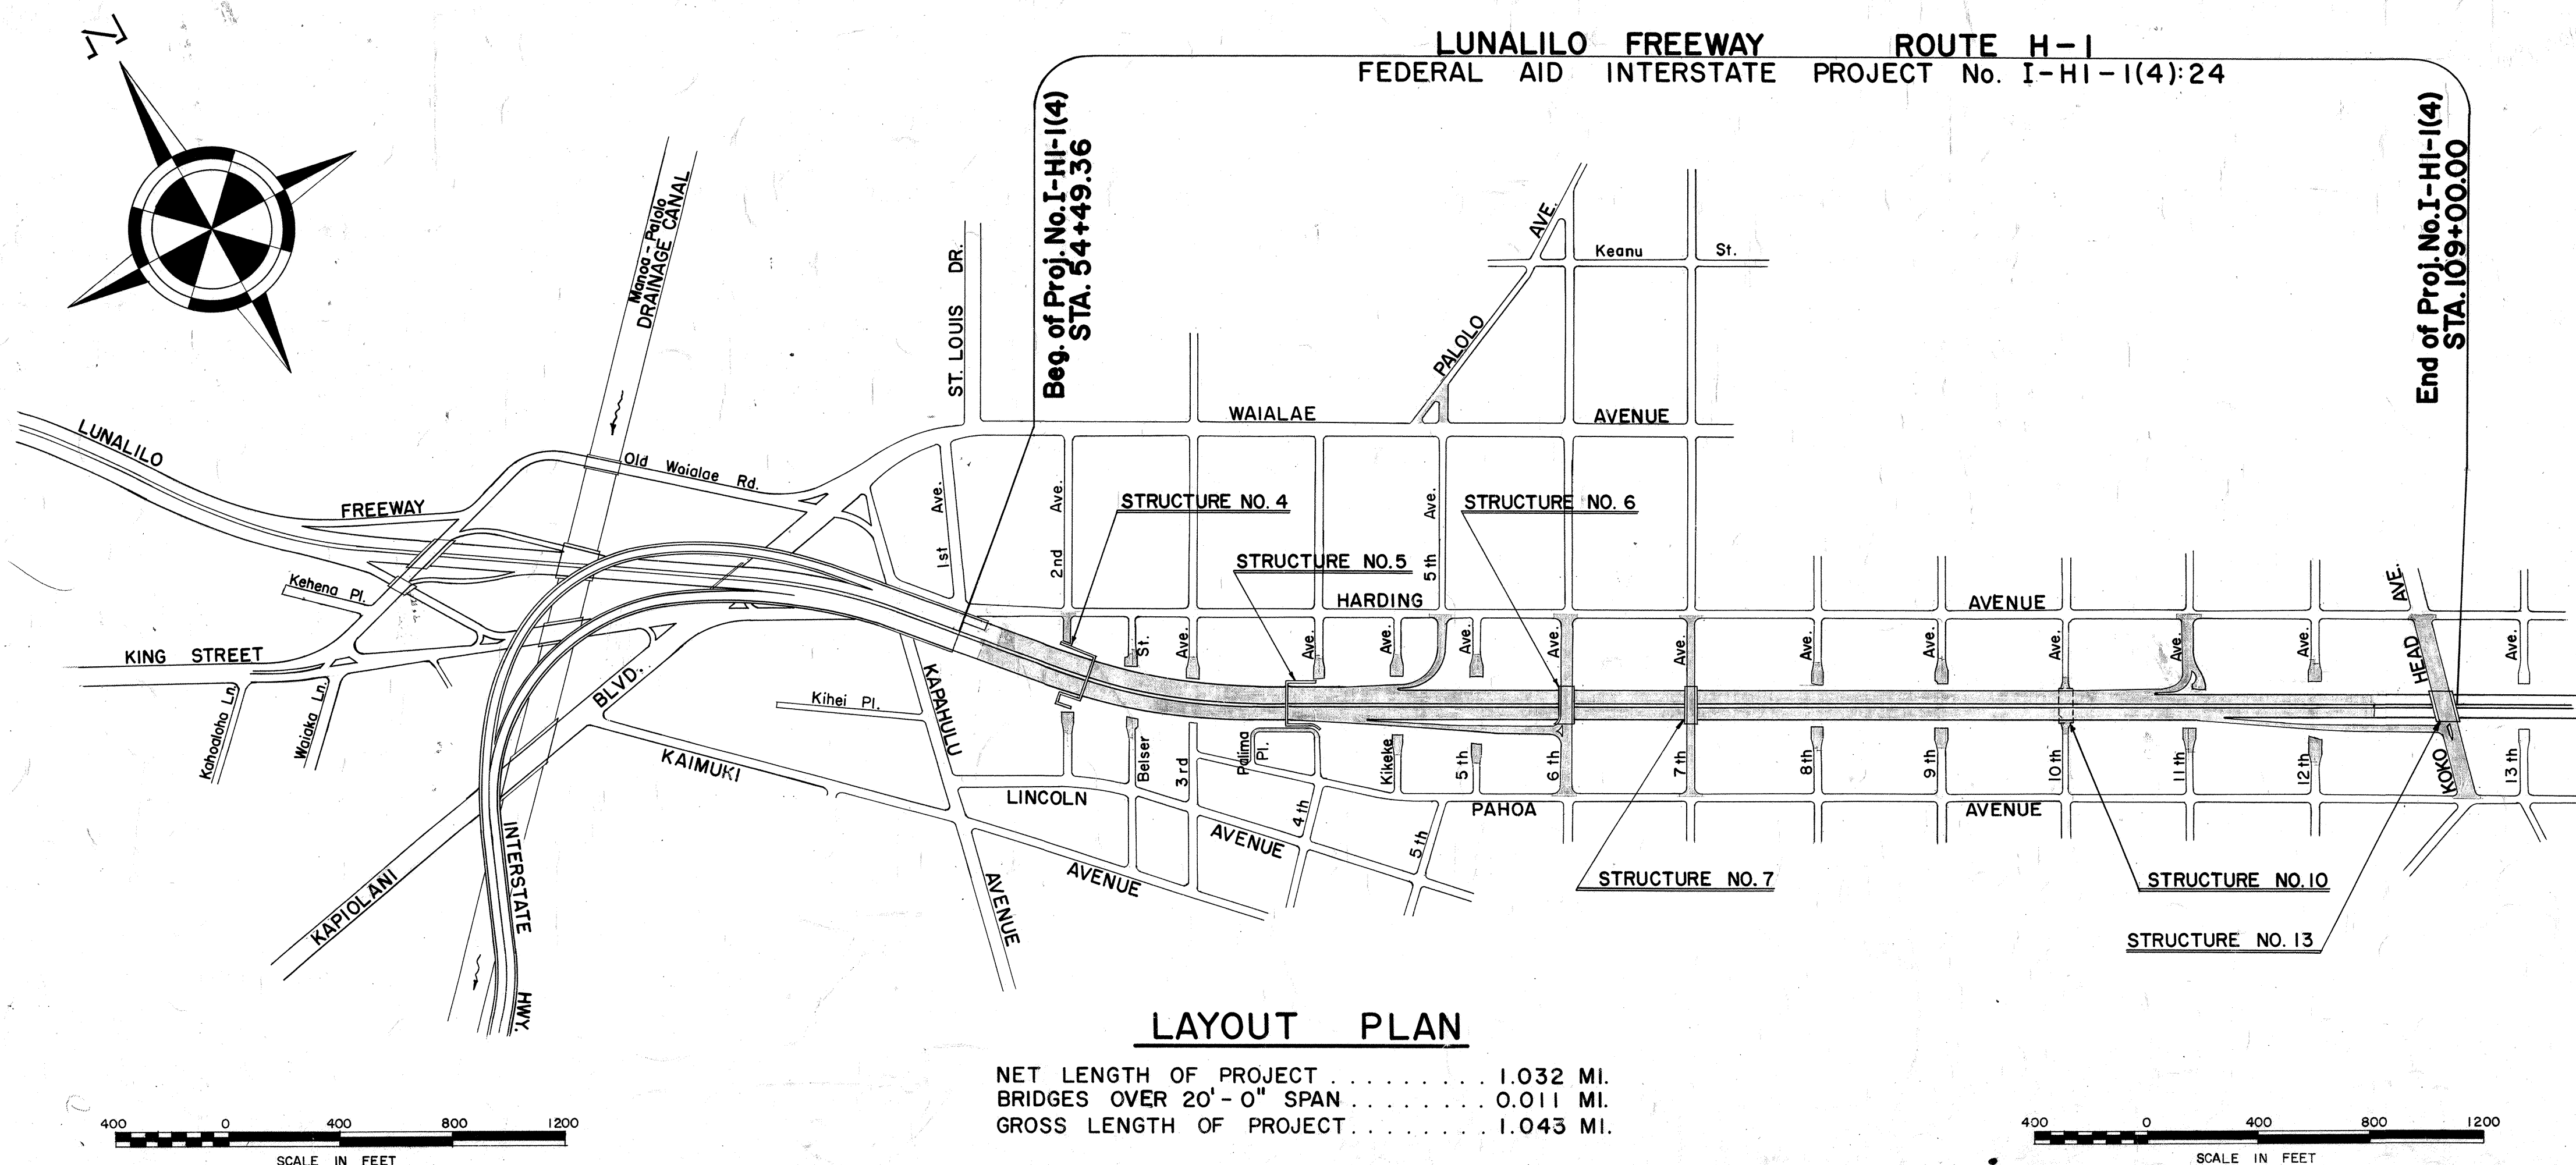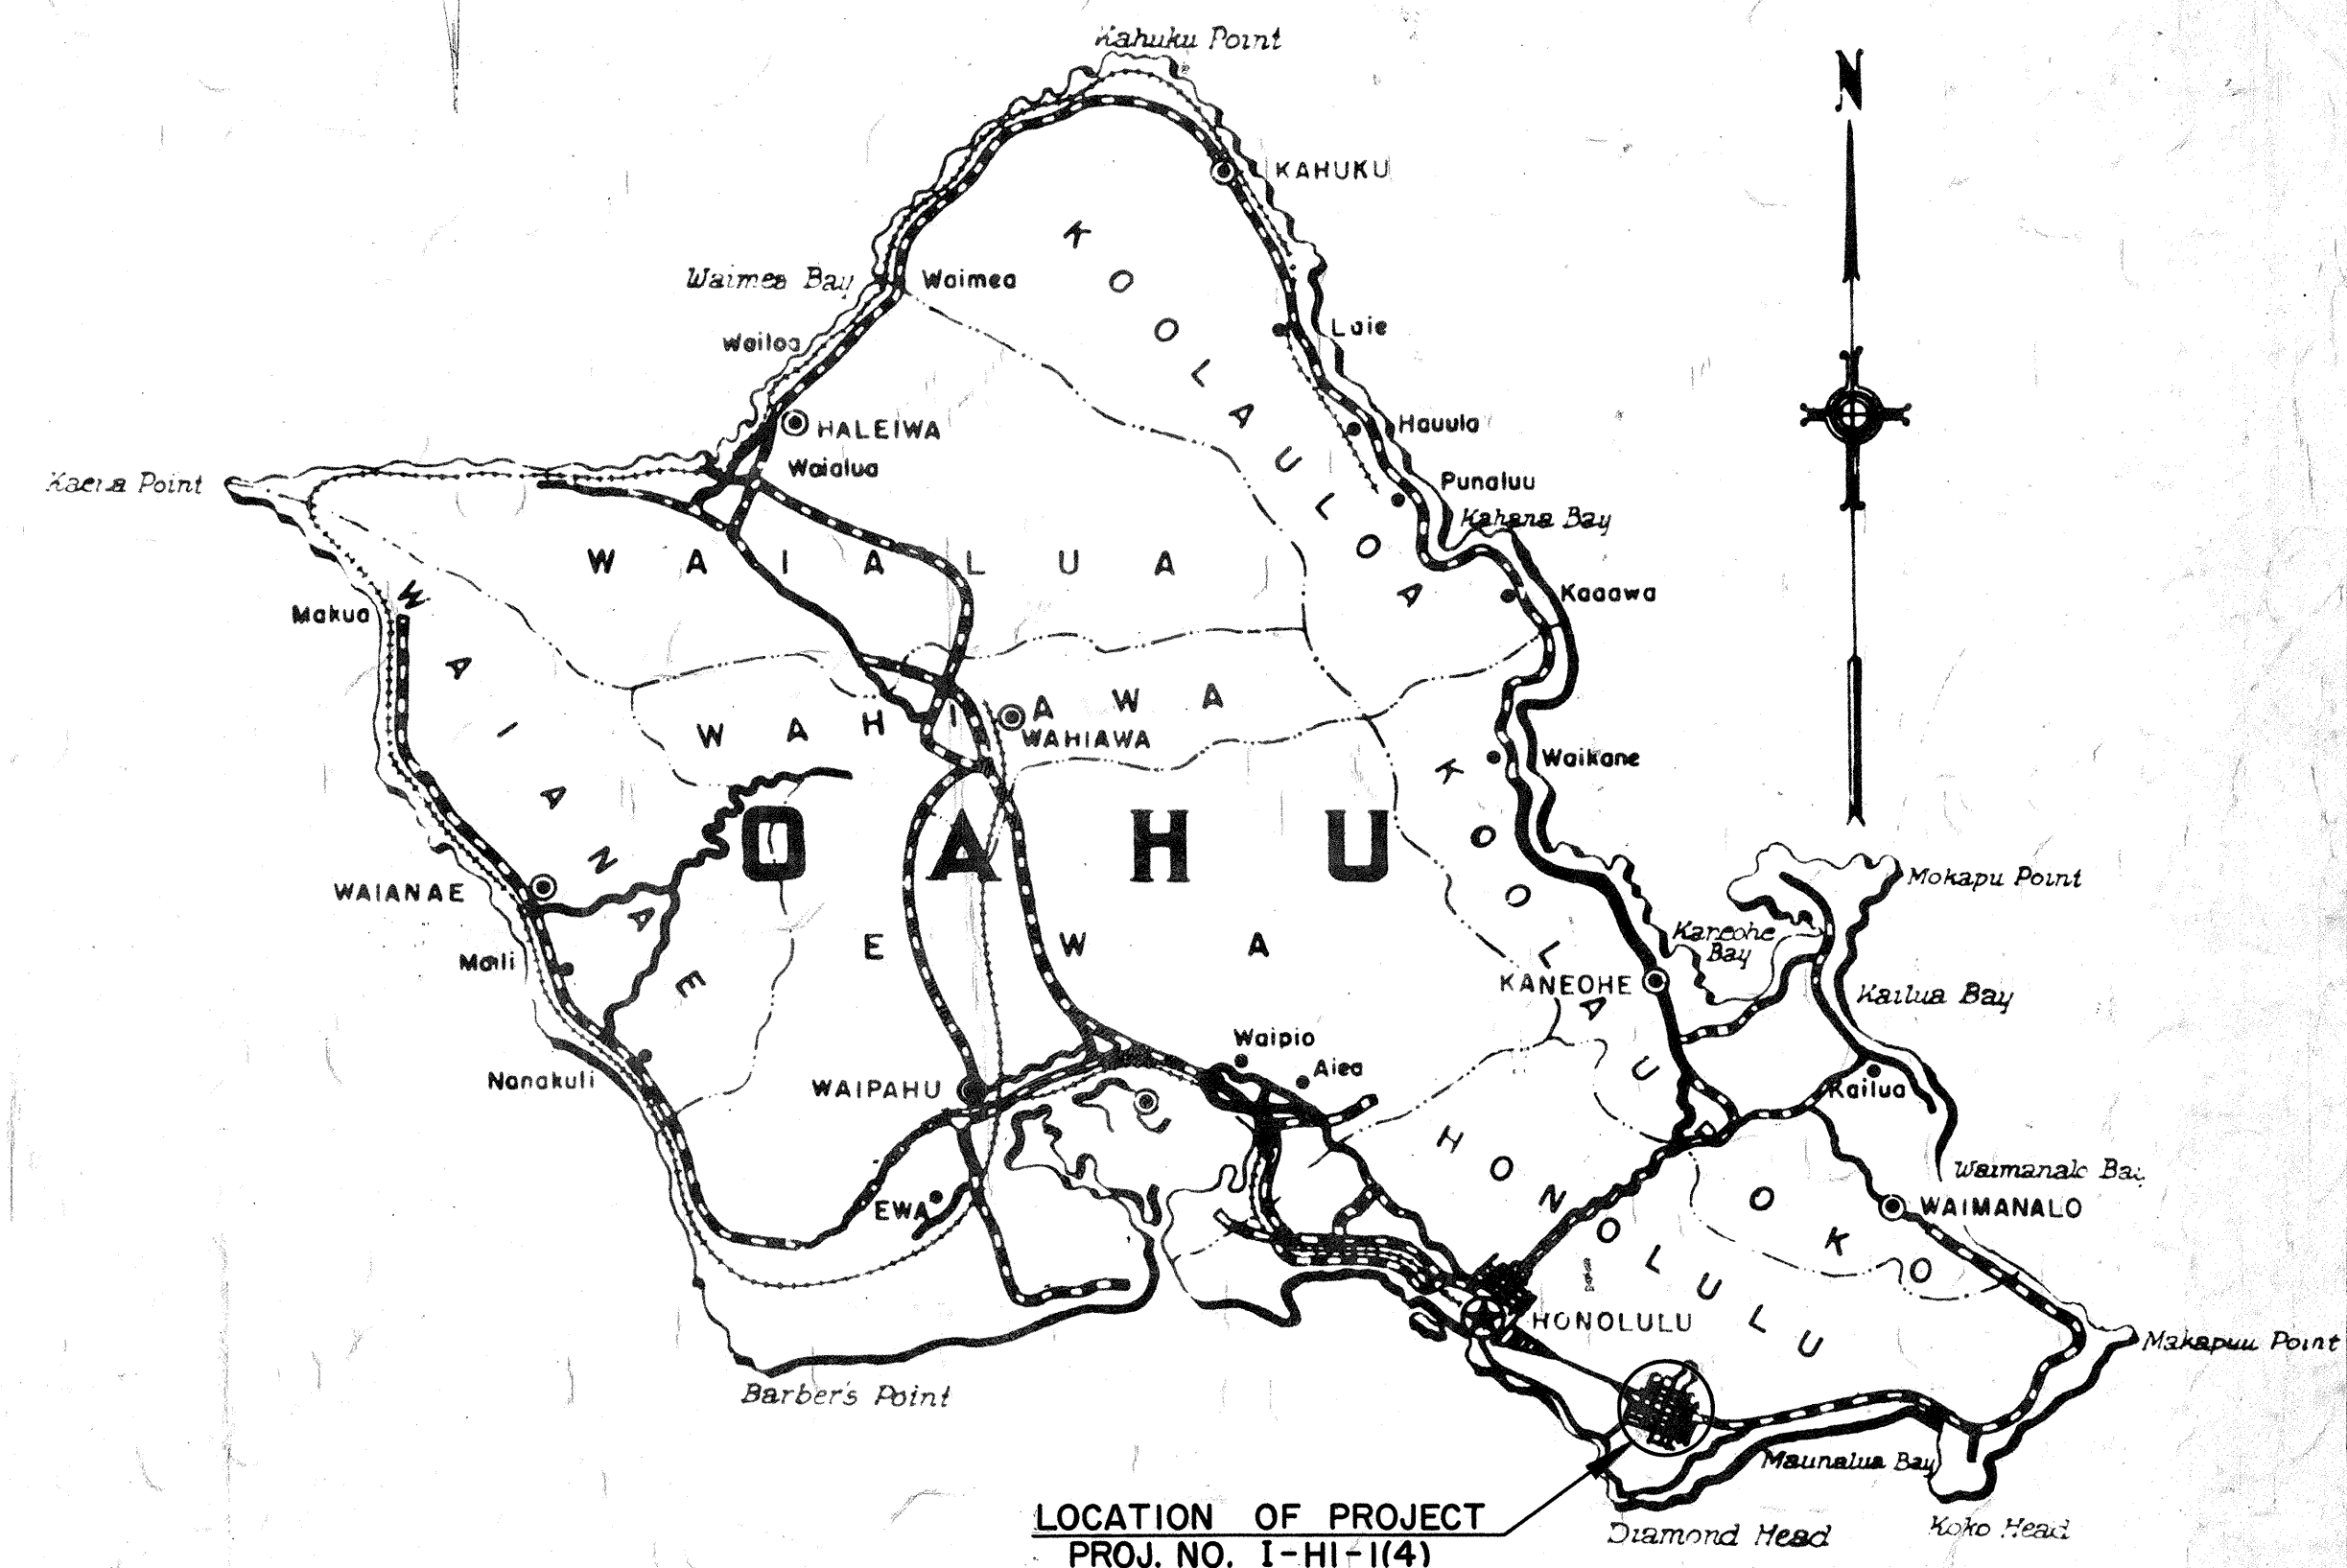

Federal Aid Projects Previously Constructed Or Under Construction

DESIGN CLASSIFICATION
DESIGN ADT (1975).....95,400
DHV.....10%
D.....70/30
T.....3%
V.....50 M.P.H.

NOTE:
ALL CHANGES MADE DURING CONSTRUCTION
HAVE BEEN NOTED IN RED ON THESE TRACINGS
AND CHECKED BY
Thomas N. Muijawa
RESIDENT ENGINEER
December 8, 1966
DATE

APPROVED: DATE *1 May 63*
Tajis Matsuda
DIRECTOR OF TRANSPORTATION

DEPARTMENT OF COMMERCE
BUREAU OF PUBLIC ROADS
APPROVED:

DIVISION ENGINEER

DATE

DATE	
DESIGNED BY	
DRAWN BY	
CHECKED BY	
NOTED BY	
QUANTITIES CHECKED BY	
NO.	