

PLANT LIST					
KEY	NAME	QUANT.	HT.	CONT.	SPACING
	Tabebuia donnell-smithii Gold Tree	25	5'-7'	3 Gal.	10' o.c.
	Plumeria obtusa Singapore Plumeria	13	4'-6"	5 Gal.	10' o.c.
	Wedelia trilobata	7480	12'-18"	1 Gal.	4' o.c.
	Grassed Area	See Standard Specifications.			
	Ligustrum texanum Texas Privet	311	10'-12"	1 qt.	8' o.c.

** Length of runner (Several per container)

NOTE: No planting is required on 1:1 Rockcuts.

*** All Ligustrum shall be planted in median strip at 8' o.c. Plant single centerline row. Grass median strip.

GENERAL NOTES

- All pipes under pavement and risers are to be copper.
- All copper pipes shall be connected with solder type fittings of bronze casting or wrought copper solder type fittings.
- In water piping diagrams (Details 1-A to 1-B inclusive) solder type fittings are shown. Pipes not noted copper are to be Galvanized Iron Screw Pipes and fittings not noted as copper are to be Galvanized Malleable Iron Fittings.
- After complete installation of the sprinkler system, each sprinkler shall be adjusted to the satisfaction of the Engineer.
- Unless otherwise stipulated or directed by the Engineer, feeder lines shall be located 6" from its E to the back of concrete curb at the median strip and shoulder.
- A.C.V. = Angle Control Valve.
- Sprinkler heads along opposite edges of median strips shall be staggered.
- Average pressure at the mains = 50 psi.
- All water service lines shown in these plans exist and are not to be disturbed.
- Connection at Station 32+00 and 33+00 shall be made as indicated if sprinkler system for adjacent Lunalilo Freeway Project is in place. If not in place, thread and cap pipe and mark location with 1" x 2" x 12" redwood marker.


PROJECT No. U-072-1(10) & U-063-1(1)
SPRINKLER HEADS

FED. ROAD DIST. NO.	STATE	FED. AID PROJ. NO.	FISCAL YEAR	SHEET NO.	TOTAL SHEETS
HAWAII	HAW.	U-072-1(10)	1963	20	45
		U-063-1(1)	1963	17	45

Symbols	No.	Description	Pressure See Note 1	Flow See Note 2	Rad. of Cov. See Note 3	Quantity	
						U-072-1(10)	U-063-1(1)
	5-9F	Shrubbery Spray - Full Head	15	2.5	7	3	
	5-10F	Shrubbery Spray - Full Head	20	3.0	10		2
	5-13F	Shrubbery Spray - Full Head	30	5.0	13		1
	5-8H	Shrubbery Spray - Half Head	10	1.0	8	40	134
	5-9H	Shrubbery Spray - Half Head	15	1.7	9	31	243
	5-10H	Shrubbery Spray - Half Head	20	2.5	10	1	115
	L-9F	Lawn Type - Full Head	15	2.5	9		14
	L-8H	Lawn Type - Half Head	10	1.0	8	697	1145
	L-10H	Lawn Type - Half Head	20	2.5	10	43	166
	P-15H	Pop-Up - Half Head	30	3.6	15		23
	L-8Q	Lawn Type - Quarter Head	10	0.9	8	14	6
	L-10F	Lawn Type - Full Head	20	3.0	10		214
	J-34	Jet Nozzle - Part Circle	35	2.8	34	48	21
TOTALS						874	2,087


NOTE:

- "Pressure" is the minimum pressure, in pounds per square inch, which is available at the base of the last head. The operating pressure for acceptable heads must not exceed this value when operating at the tabulated flow and radius.
- "Flow" is the maximum flow, in gallons per minute, which is discharged at the tabulated "pressure".
- "Radius of Coverage" is the minimum radius at the tabulated "pressure".

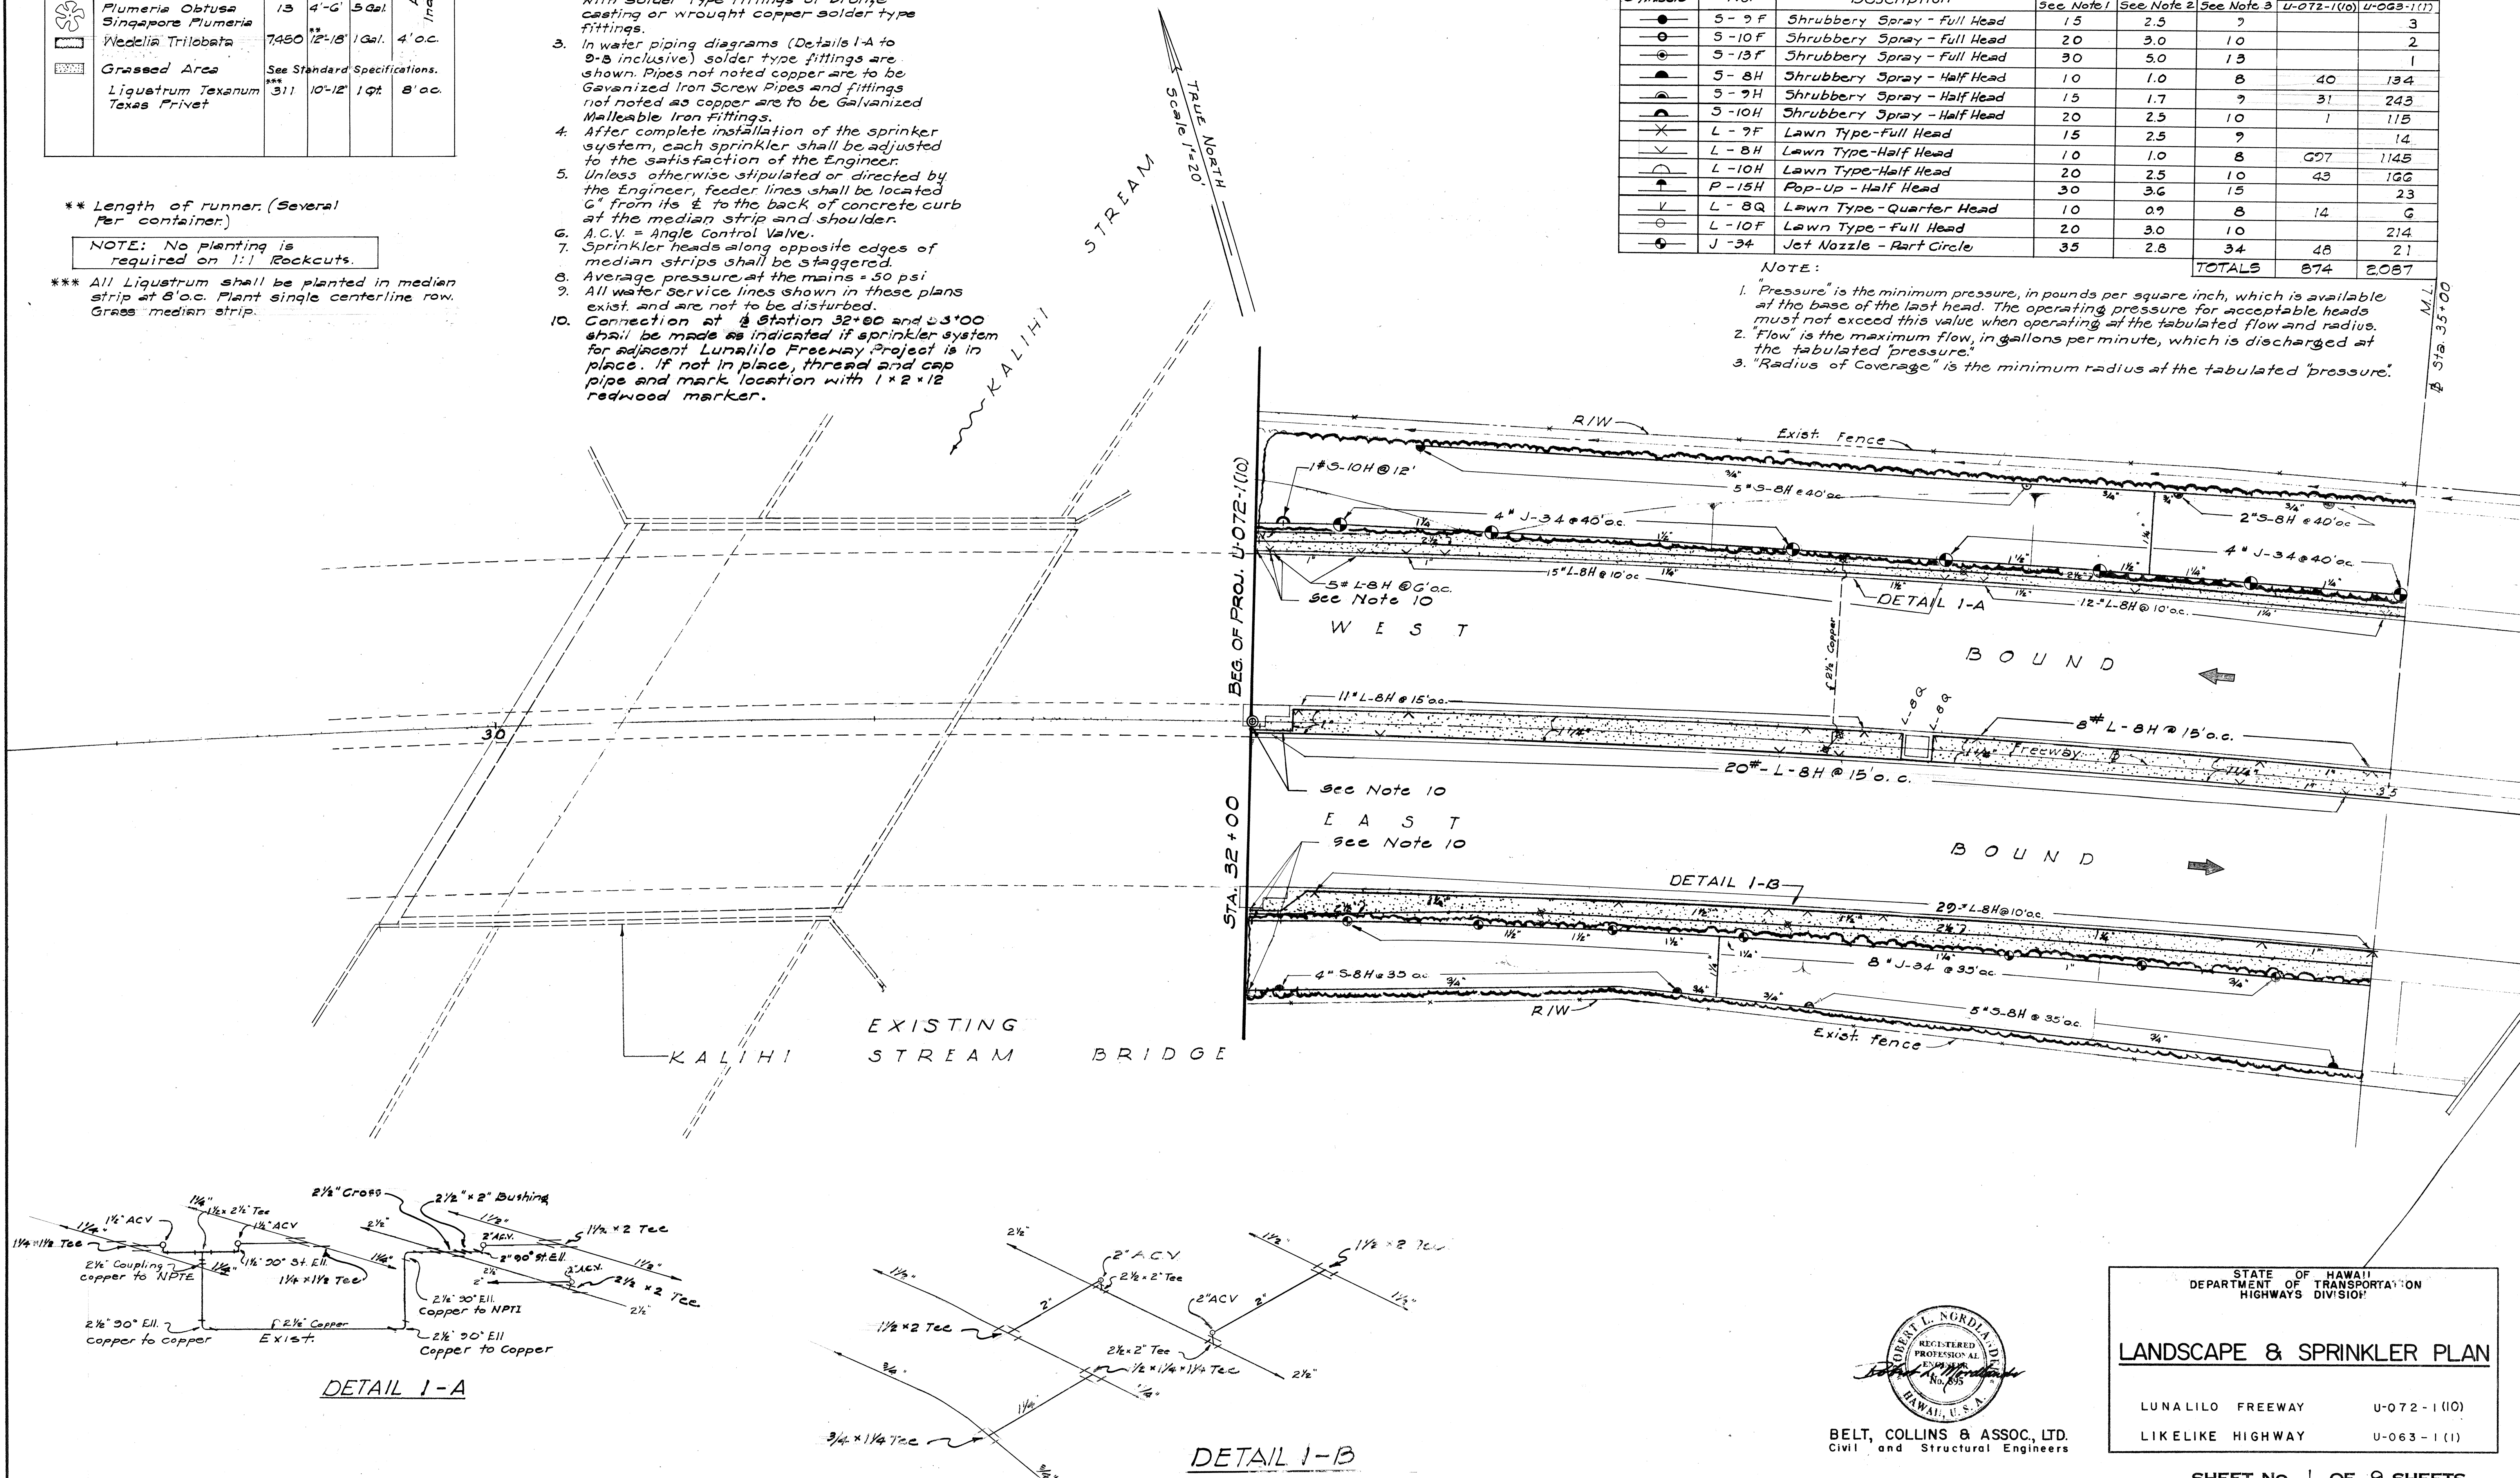

DETAIL 1-A

DETAIL 1-B

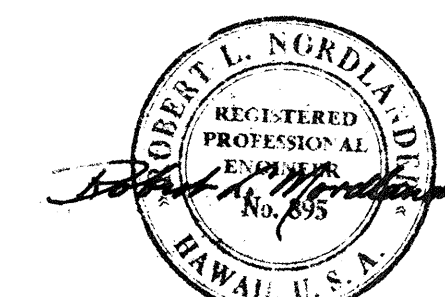


BELT, COLLINS & ASSOC., LTD.
Civil and Structural Engineers

STATE OF HAWAII DEPARTMENT OF TRANSPORTATION HIGHWAYS DIVISION	
LANDSCAPE & SPRINKLER PLAN	
LUNALILO FREEWAY	U-072-1(10)
LIKIE HIGHWAY	U-063-1(1)

SHEET NO. 1 OF 9 SHEETS

A 20 B 17

FED. ROAD DIST. NO.	STATE	FED. AID PROJ. NO.	FISCAL YEAR	SHEET NO.	TOTAL SHEETS
HAWAII	HAW.	U-072-1(10)	1963	A21	45
		U-063-1(10)	1963	B18	45

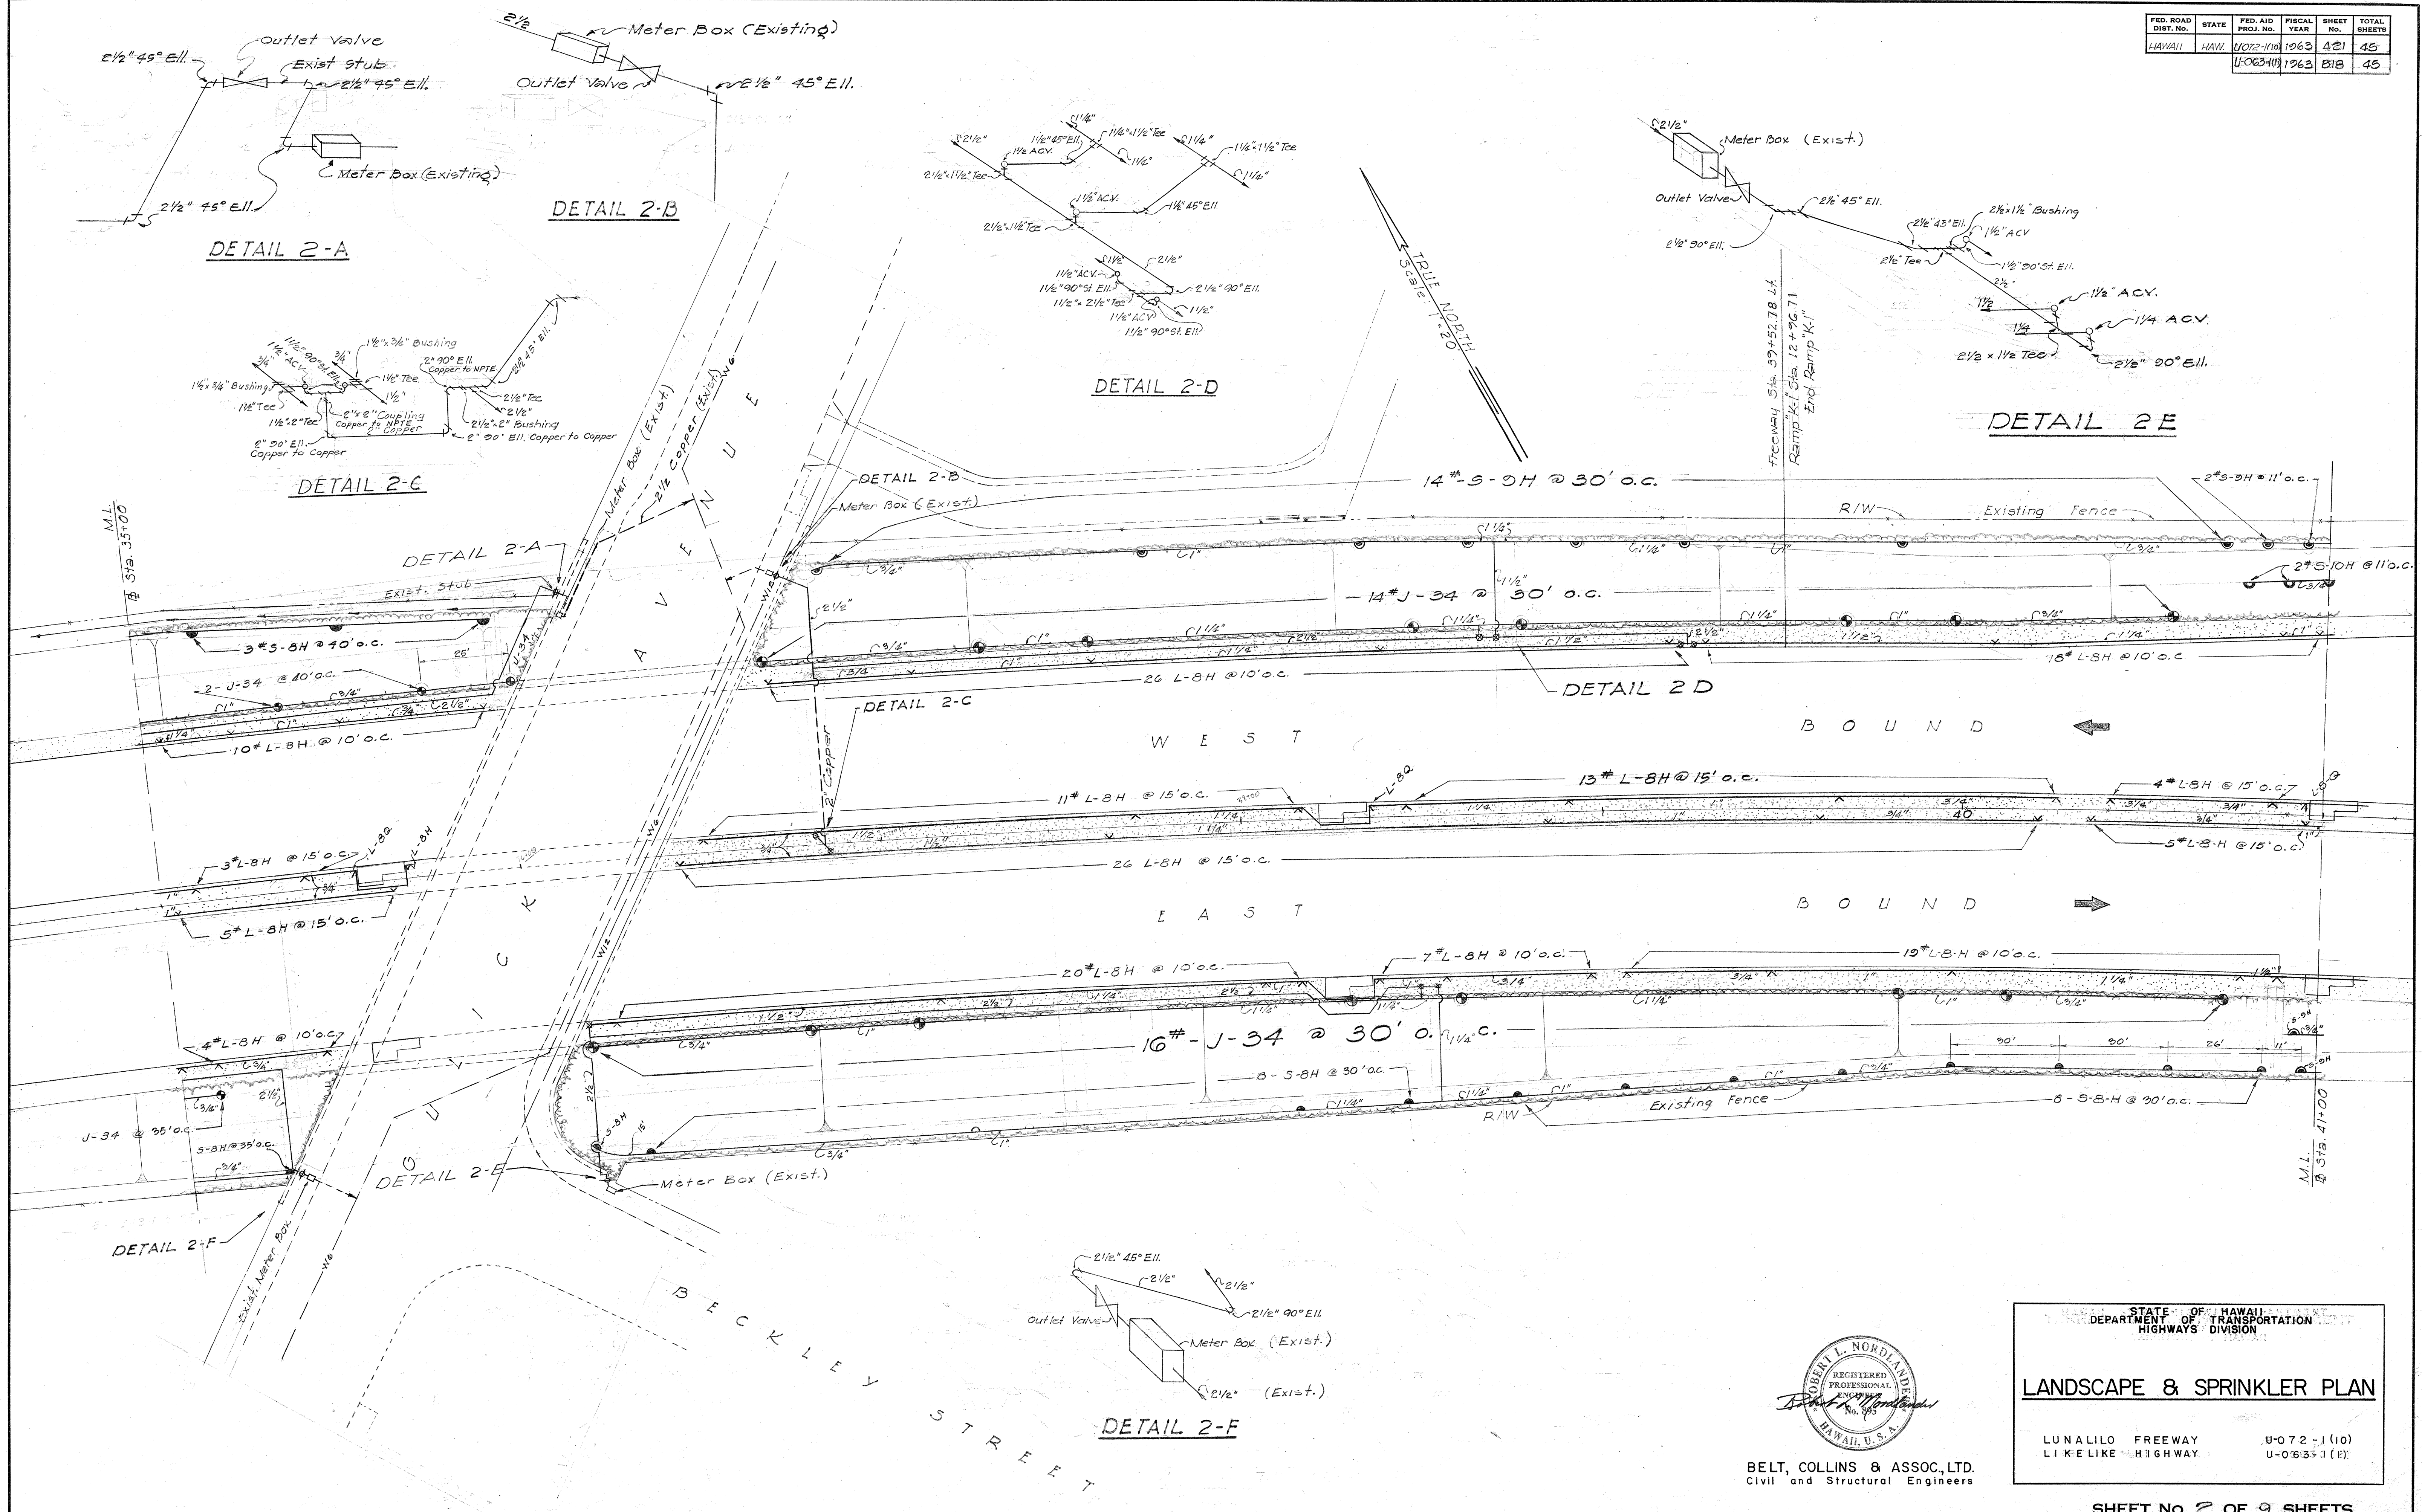

DATE	3-27
SURVEY PLOTTED BY	E. K. K.
DESIGNED BY	E. K. K.
DRAWN BY	E. K. K.
CHECKED BY	E. K. K.
QUANTITIES CHECKED BY	E. K. K.
NOTE BOOK NO.	3-27



BELT, COLLINS & ASSOC., LTD.
Civil and Structural Engineers

STATE OF HAWAII
DEPARTMENT OF TRANSPORTATION
HIGHWAYS DIVISION

LANDSCAPE & SPRINKLER PLAN

LUNALILO FREEWAY
LIKE LIKE HIGHWAY


U-072-1(10)
U-063-1(10)

SHEET NO. 2 OF 9 SHEETS


A 21 B 18

FED. ROAD DIST. NO.	STATE	FED. AID PROJ. NO.	FISCAL YEAR	SHEET NO.	TOTAL SHEETS
HAWAII	HAW.	U-072-1(10)	1968	21	45



TRUE NORTH
SCALE 1" = 20'

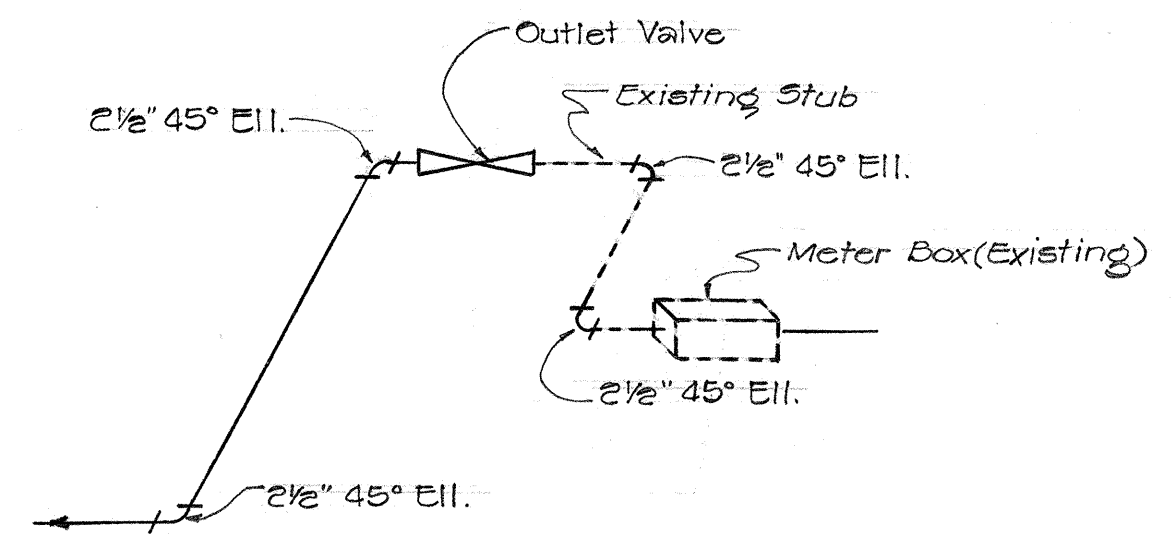


DETAIL 2-A

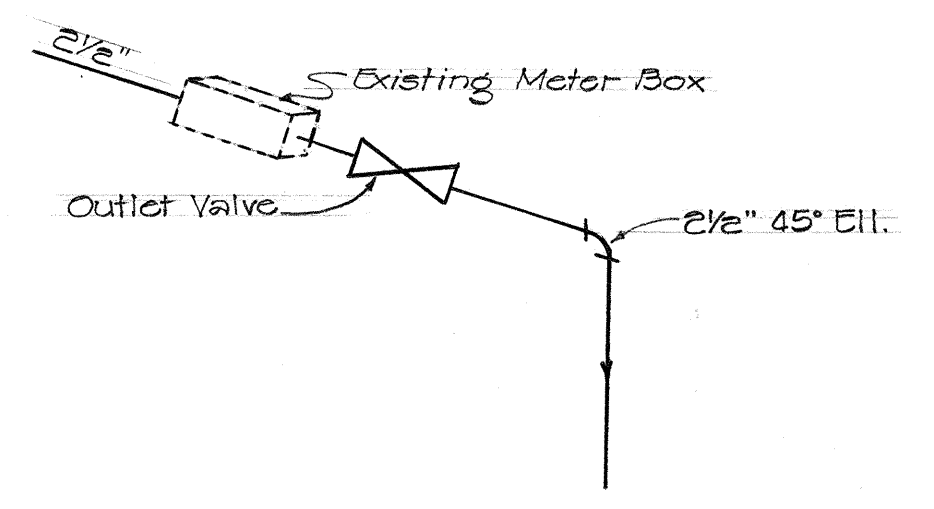

DETAIL 2-B

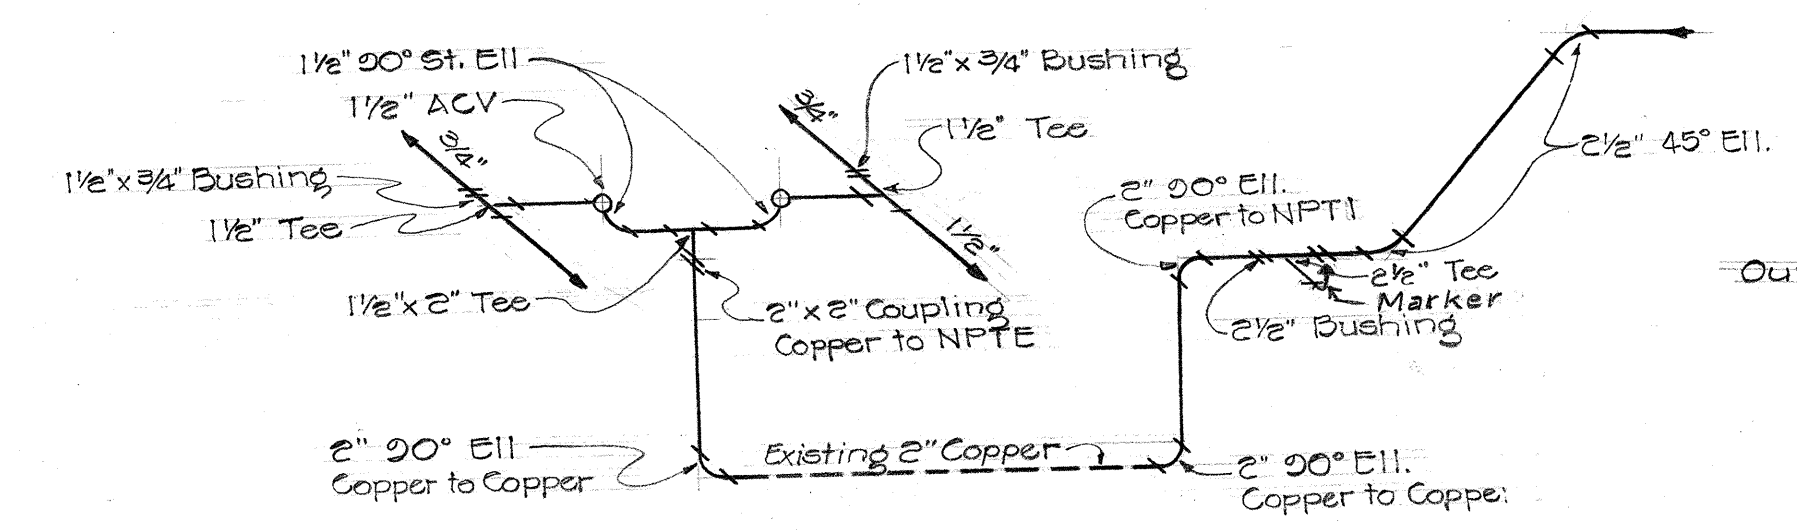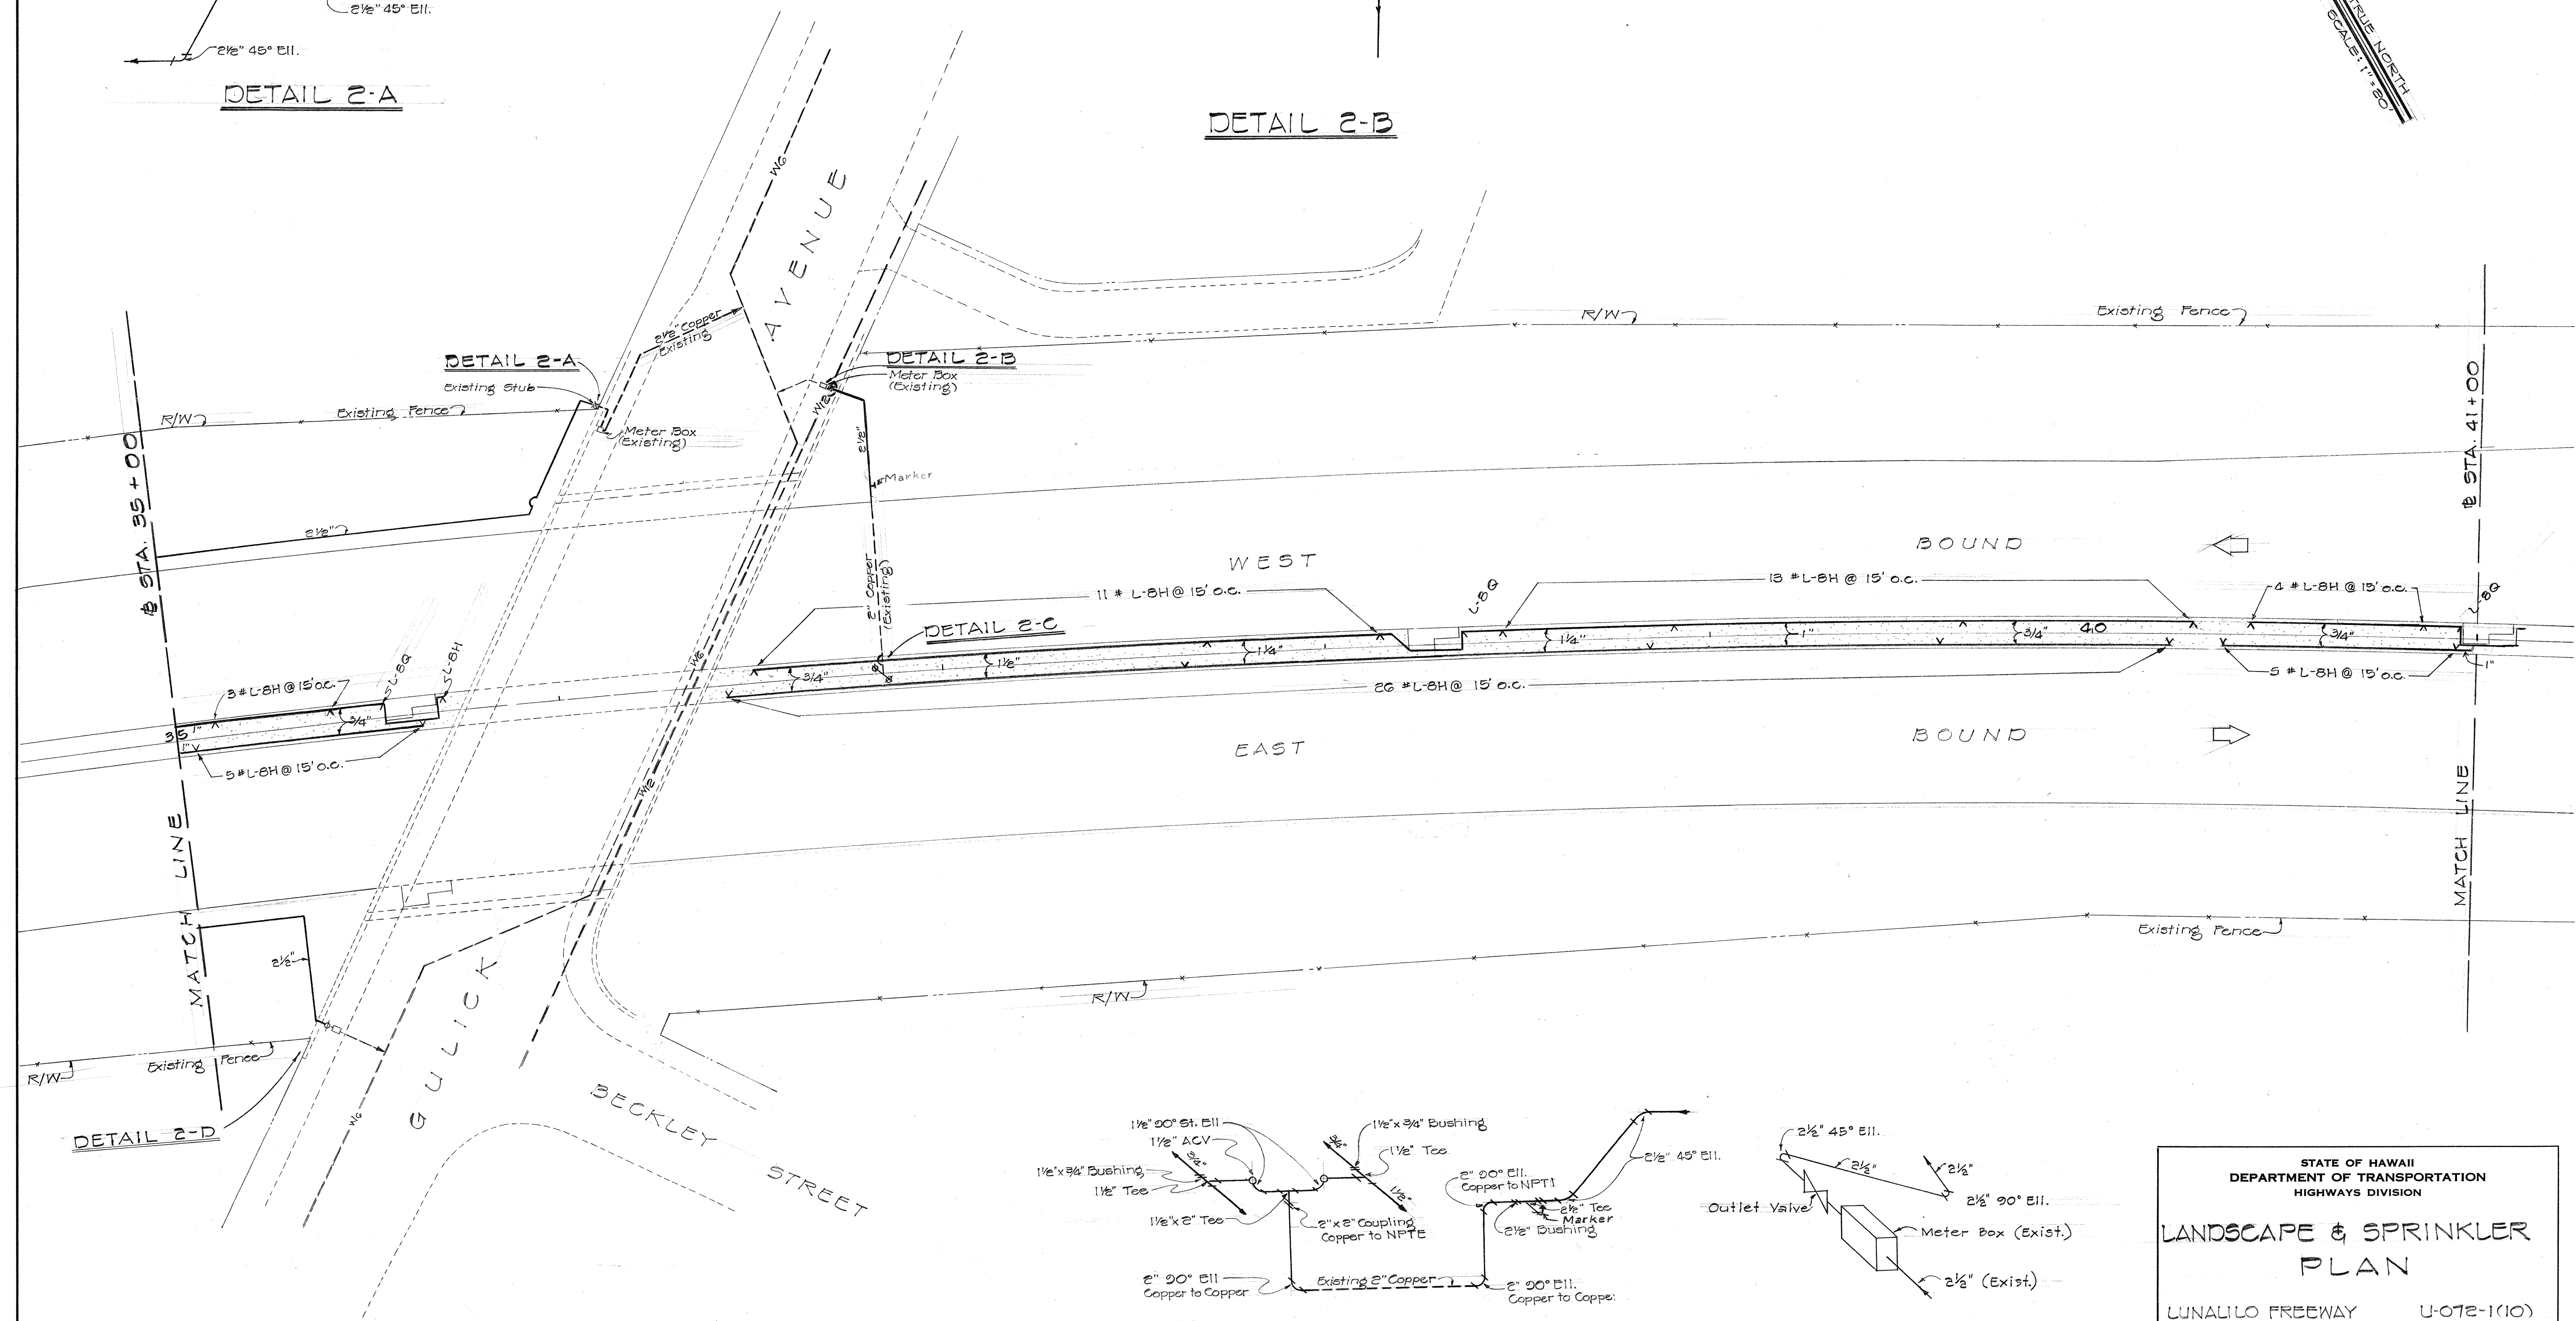

DETAIL 2-C

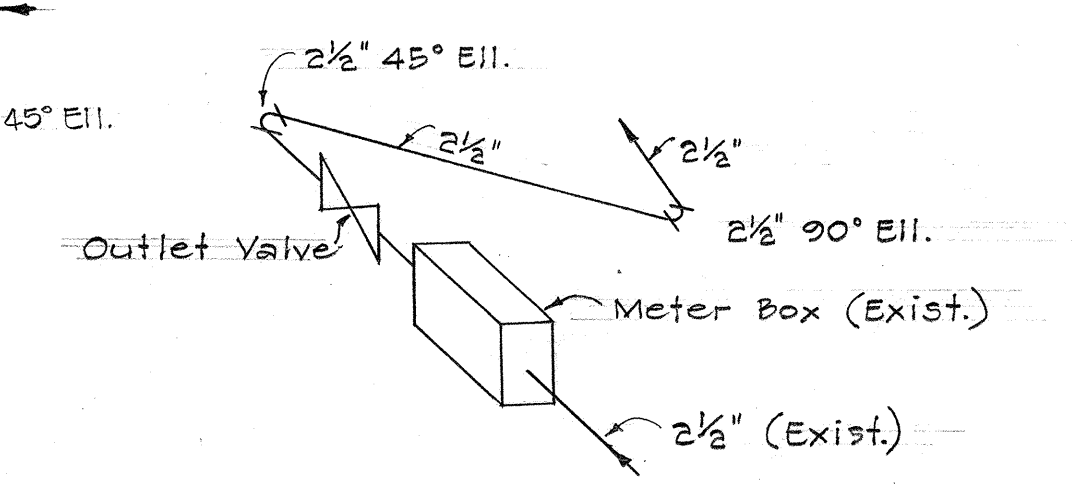

DETAIL 2-D

STATE OF HAWAII
DEPARTMENT OF TRANSPORTATION
HIGHWAYS DIVISION


LANDSCAPE & SPRINKLER PLAN

LUNALILO FREEWAY U-072-1(10)


SHEET No. OF SHEETS

ORIGINAL PLAN	DATE
DRAWN BY	
TRACED BY	
QUANTITIES BY	
CHECKED BY	

FED. ROAD DIST. NO.	STATE	FED. AID PROJ. NO.	FISCAL YEAR	SHEET NO.	TOTAL SHEETS
HAWAII	HAW.	U-072-1(1)	1963	A23	45
		U-063-1(1)	1963	B20	45

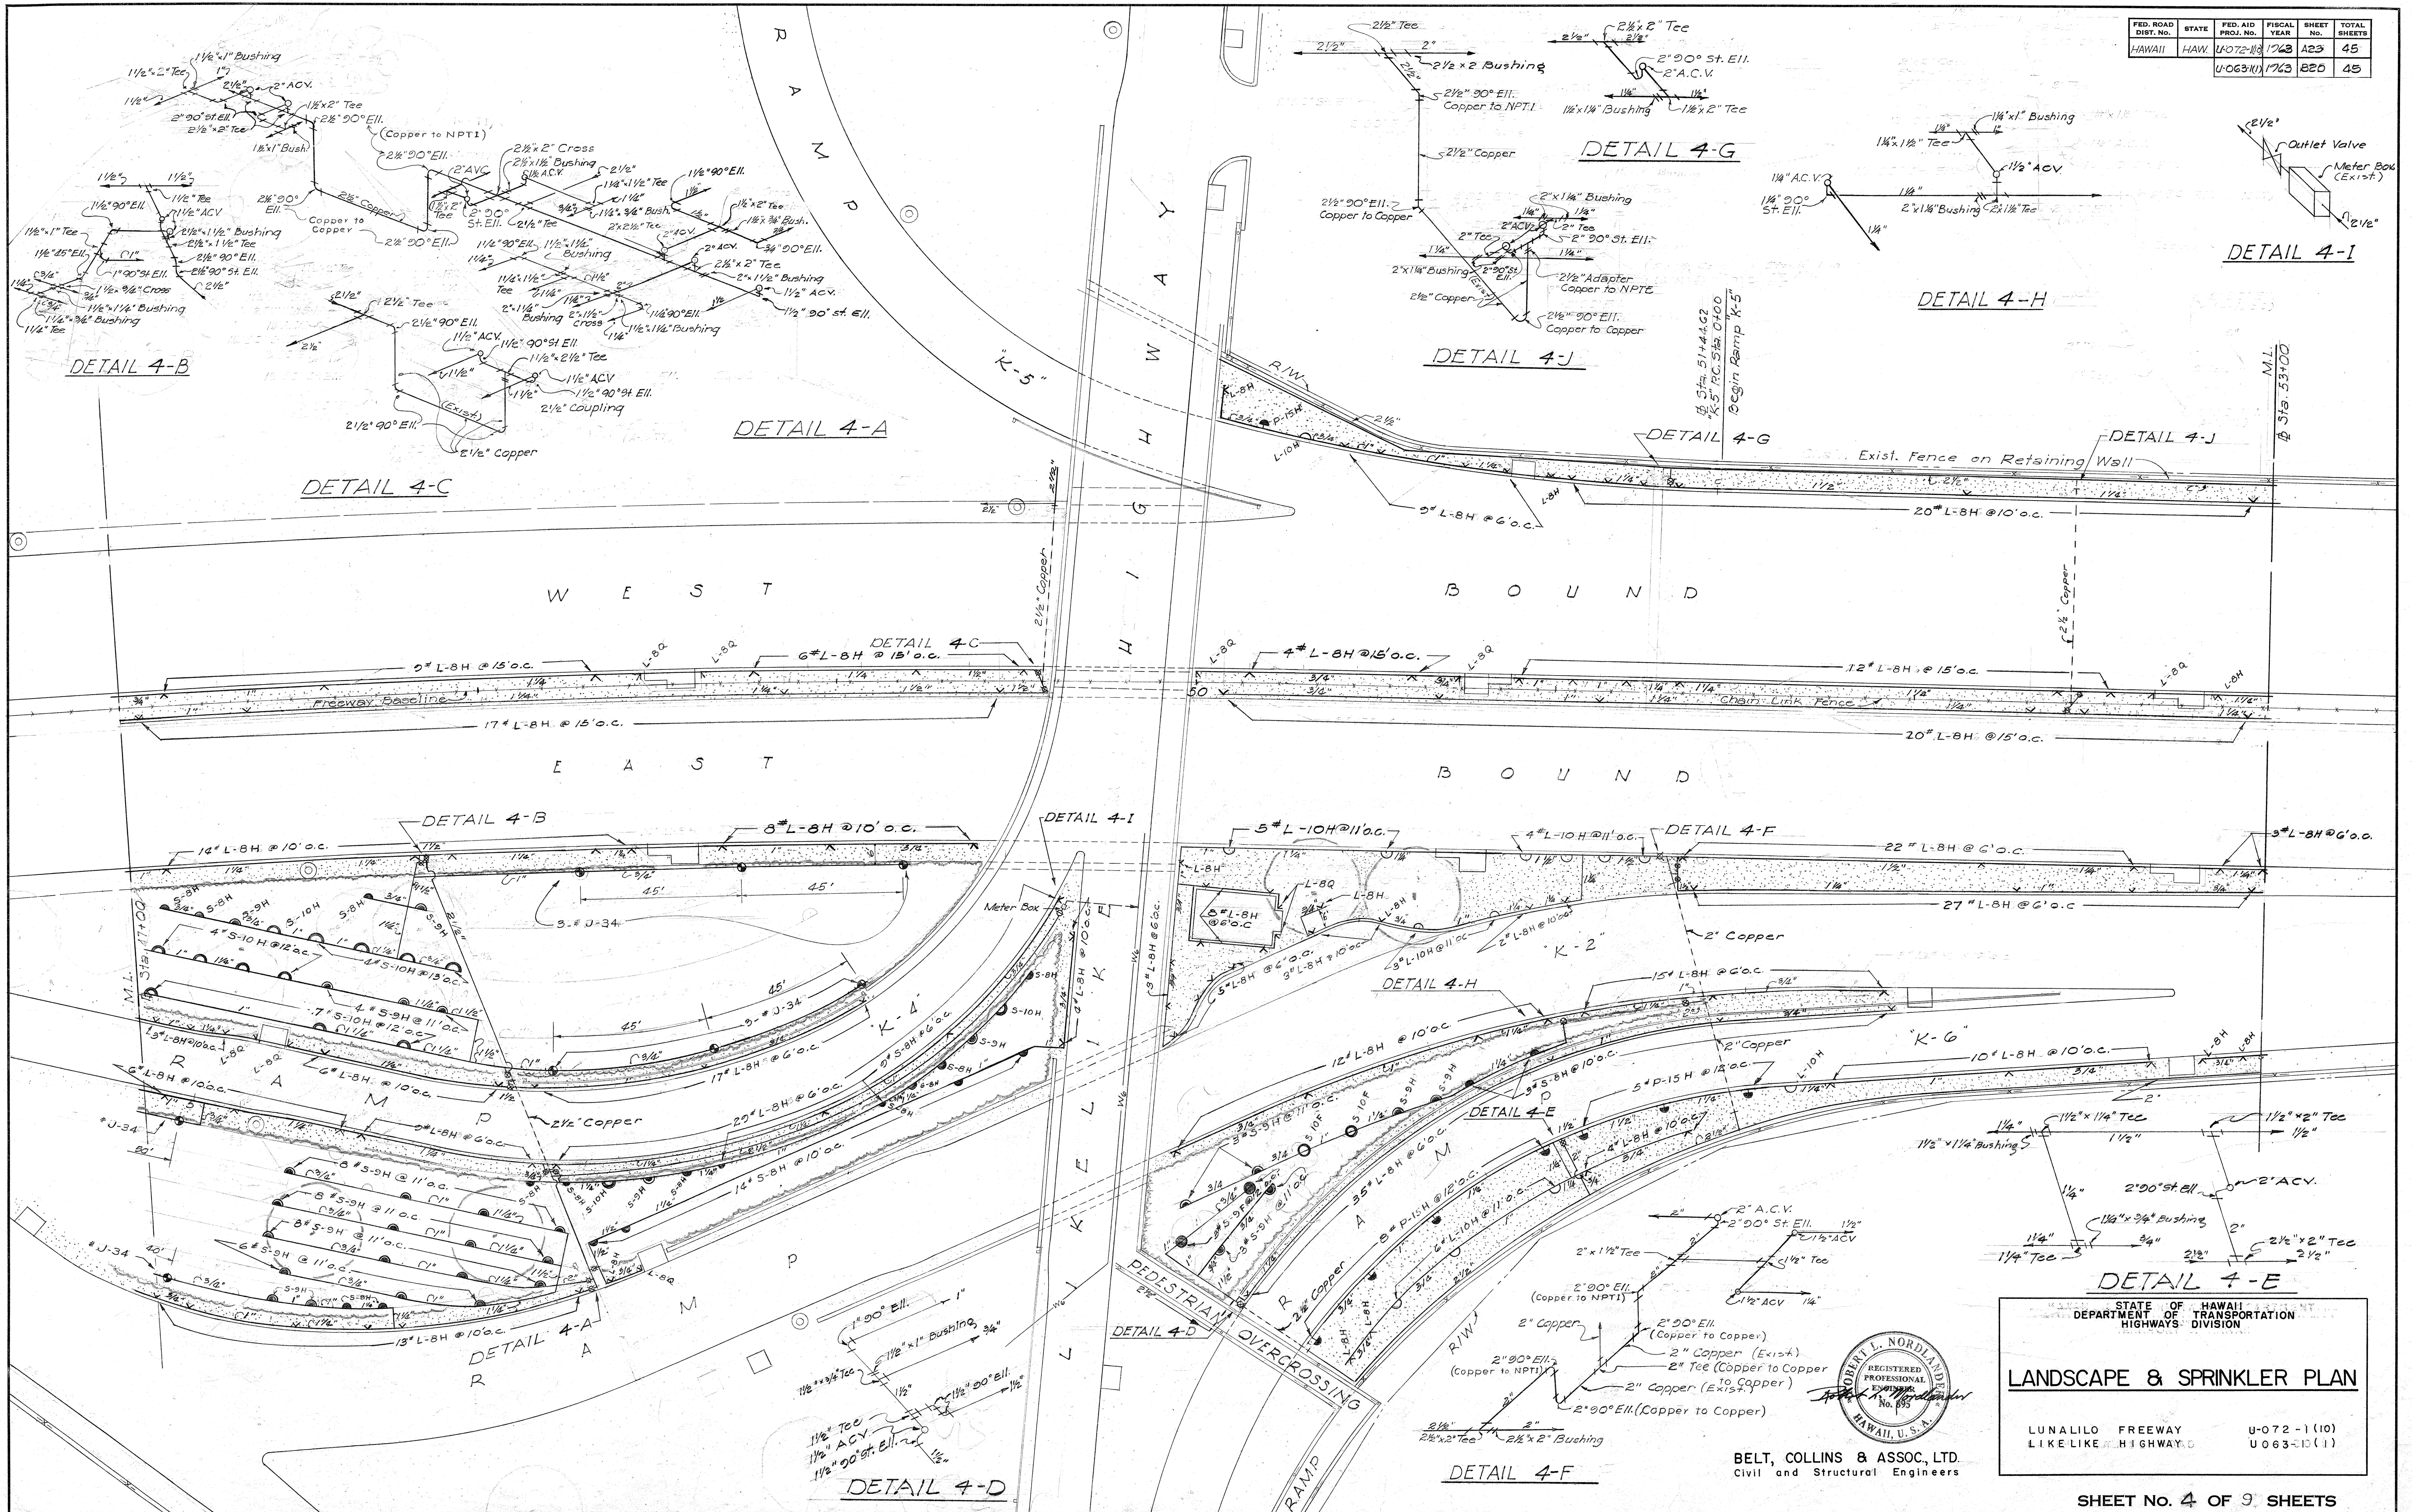

DATE	DESIGNED BY	TRACED BY	QUANTITIES CHECKED BY	NOTE BOOK NO.
3-27	W. Collins	W. Collins	W. Collins	3-27
3-27	W. Collins	W. Collins	W. Collins	3-27
3-27	W. Collins	W. Collins	W. Collins	3-27
3-27	W. Collins	W. Collins	W. Collins	3-27

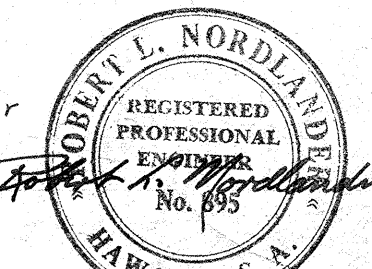

BELT, COLLINS & ASSOC. LTD.
Civil and Structural Engineers

STATE OF HAWAII
DEPARTMENT OF TRANSPORTATION
HIGHWAYS DIVISION

LANDSCAPE & SPRINKLER PLAN


LUNALILO FREEWAY
LIKE LIKE HIGHWAY

U-072-1(10)
U-063-1(11)

SHEET No. 4 OF 9 SHEETS


A 23 B 20 (25)

FED. ROAD DIST. NO.	STATE	FED. AID PROJ. NO.	FISCAL YEAR	SHEET NO.	TOTAL SHEETS
HAWAII	HAW.	U-072-1(10)	1963	23	45

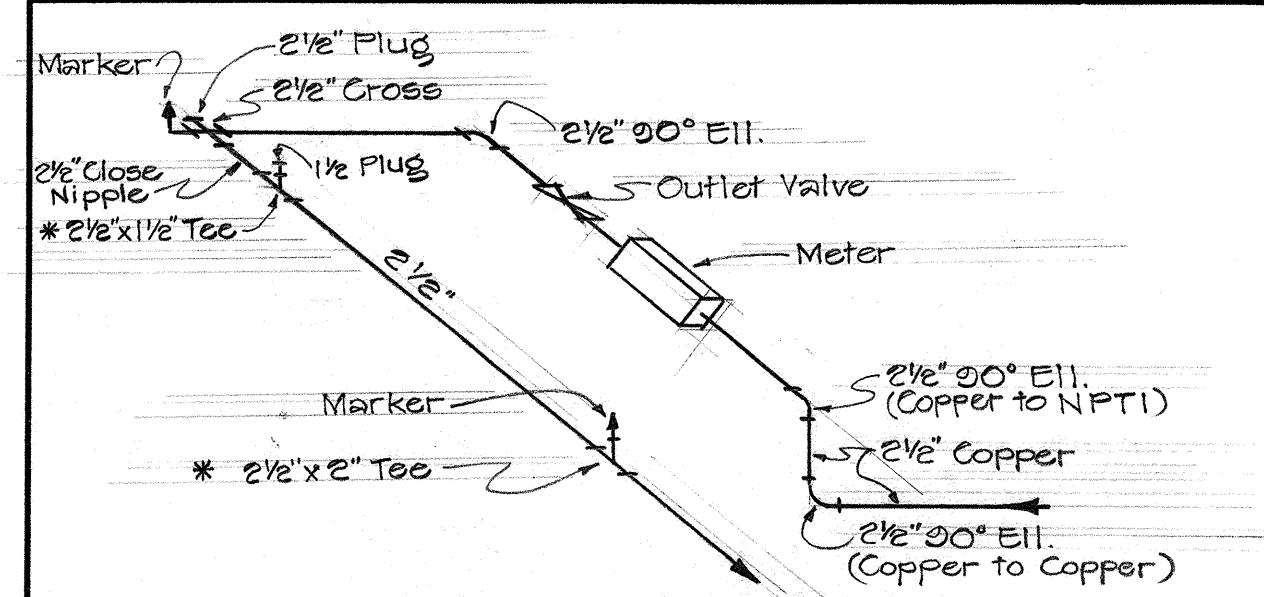


DETAIL 4-D


NOTE:
Tees shown with an asterisk (*) shall be installed with the branch of the Tee pointing vertically for future installation of angle control valves. All other Tees and Crosses shall be laid approximately horizontal.

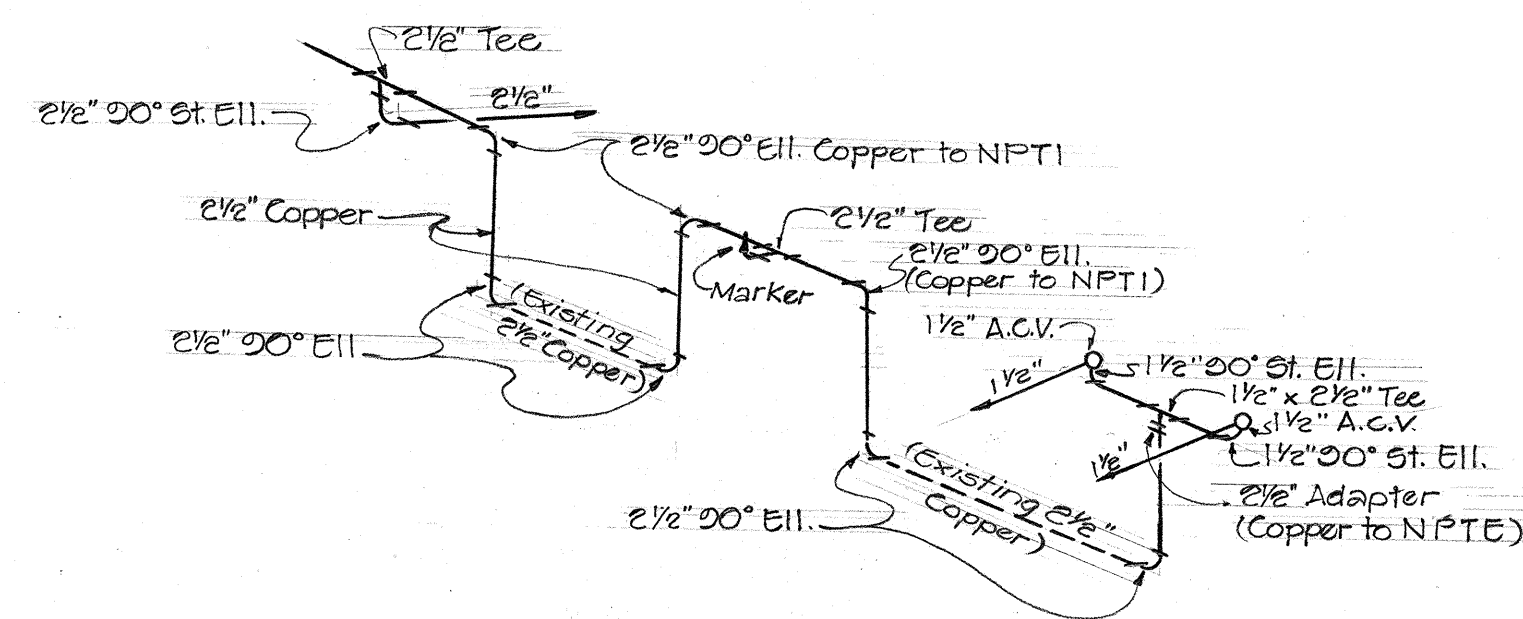



DETAIL 4-A

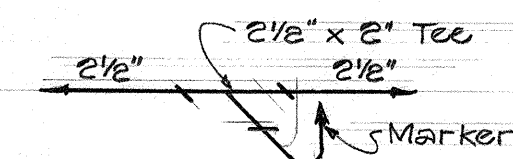

DETAIL 4-B

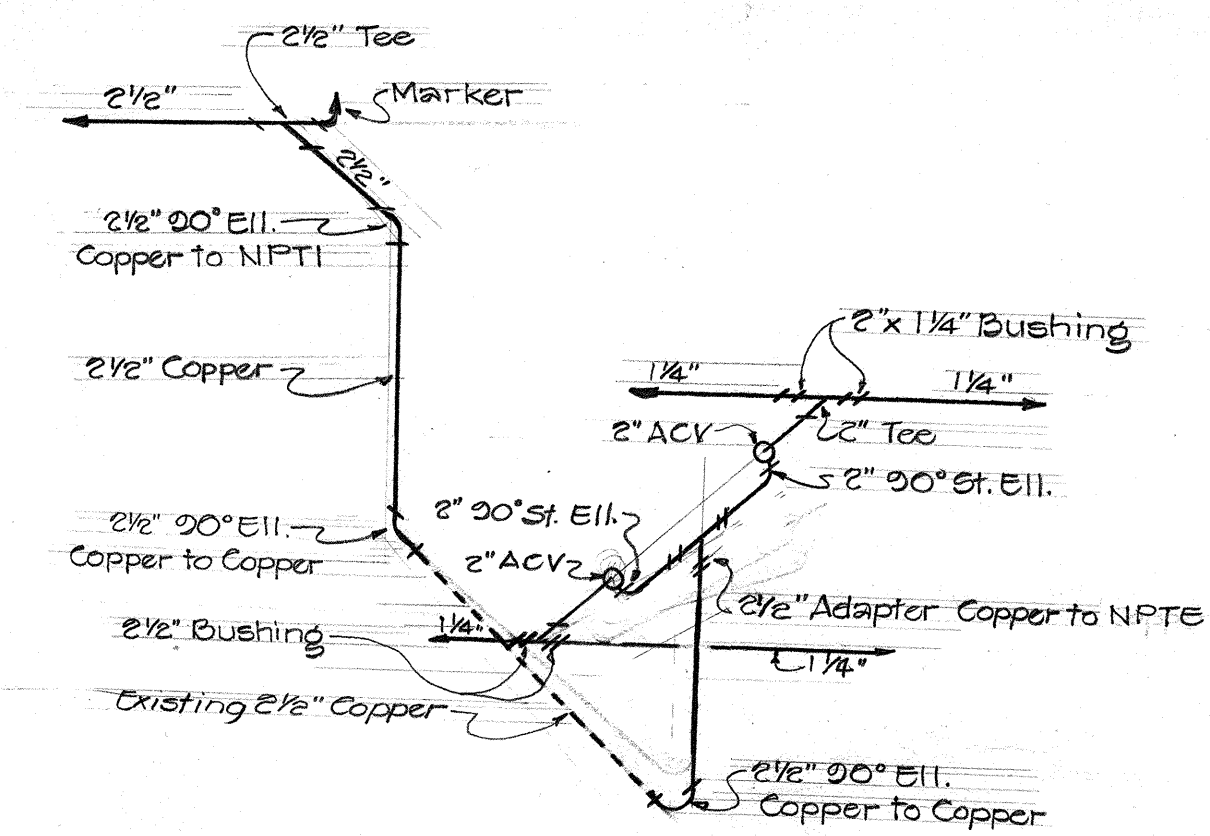

DETAIL 4-C

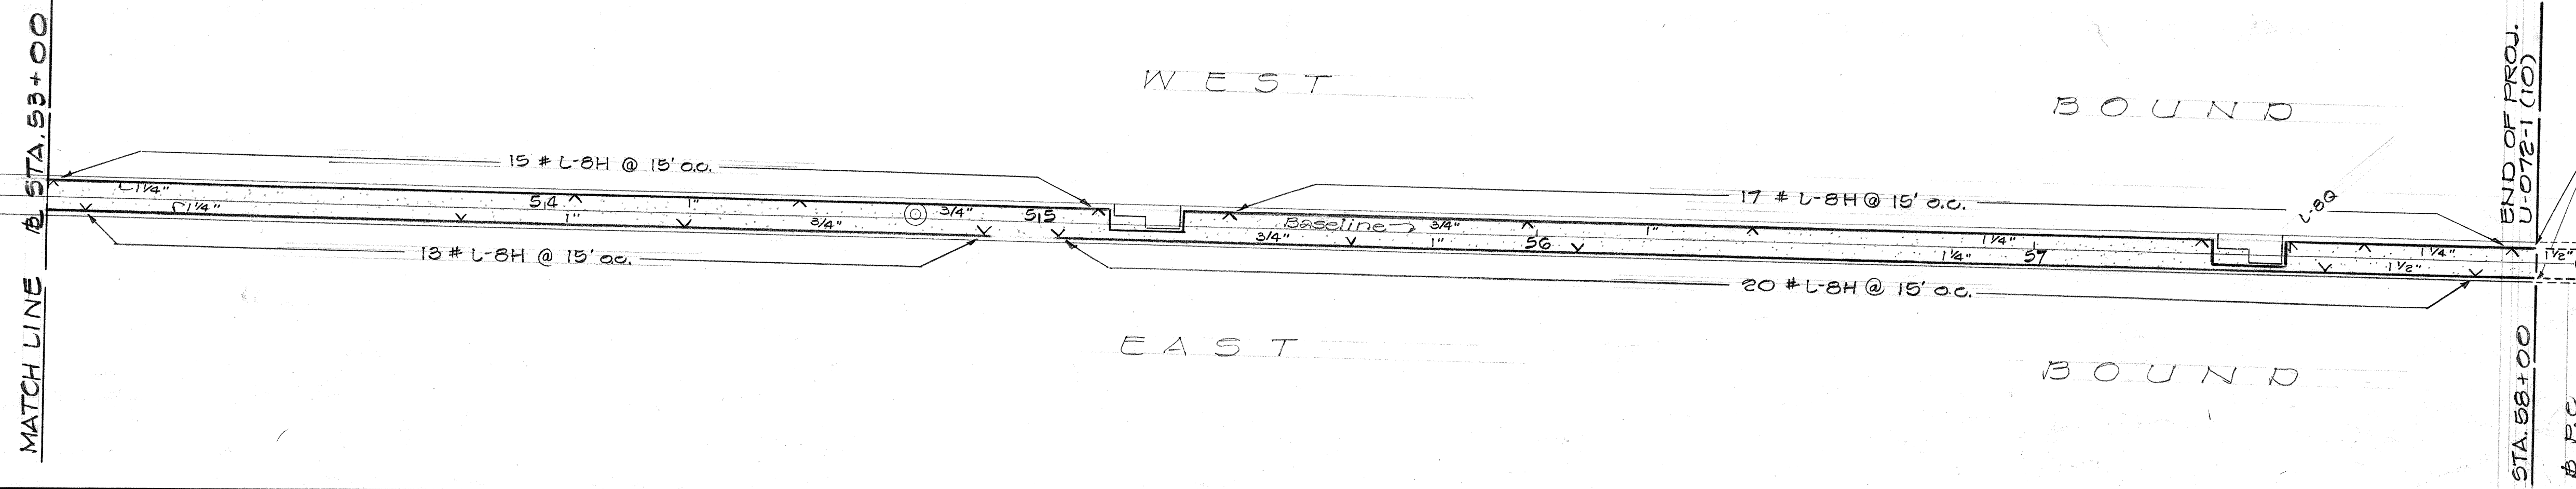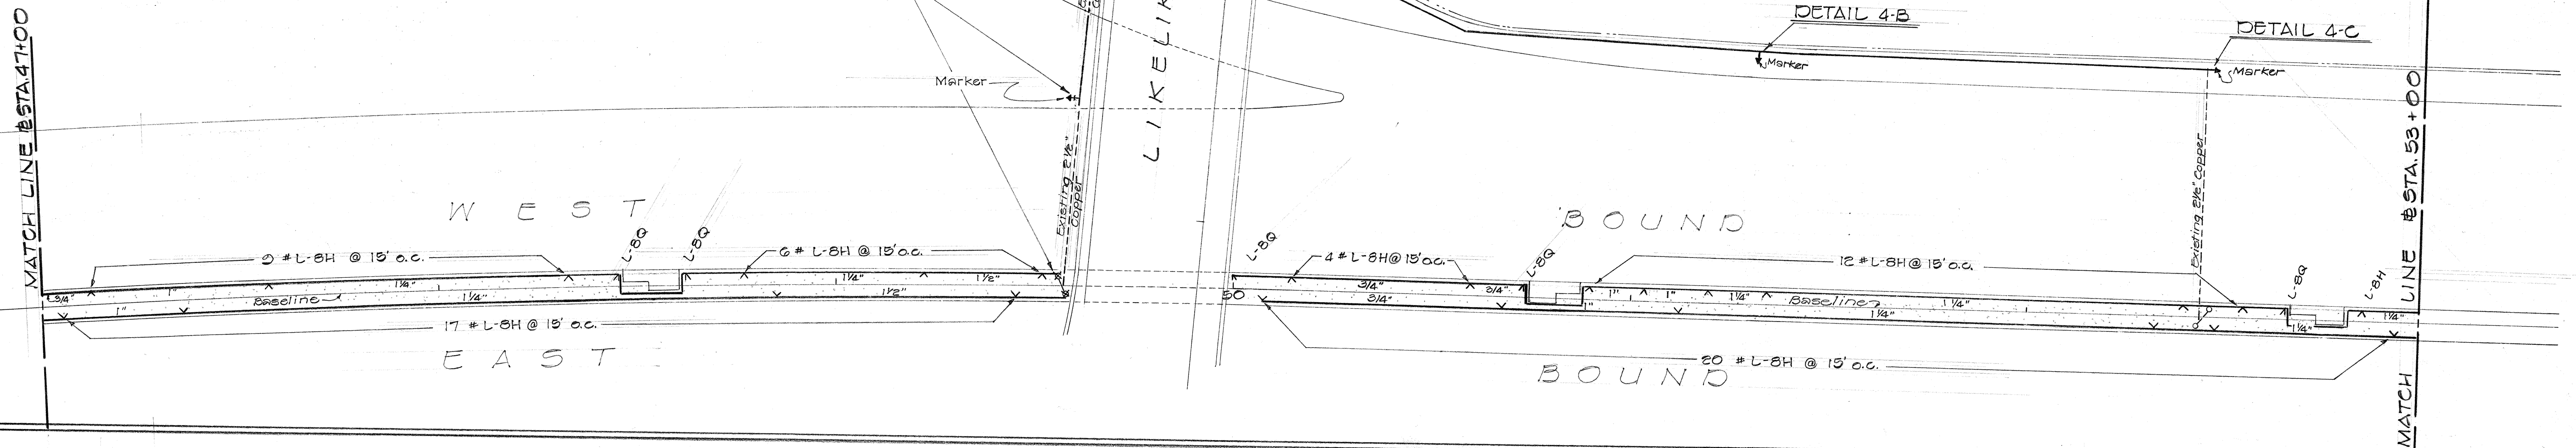

See Note 10 of Sht. 1

STATE OF HAWAII
DEPARTMENT OF TRANSPORTATION
HIGHWAYS DIVISION


LANDSCAPE & SPRINKLER PLAN

LUNALILO FREEWAY U-072-1(10)


SHEET No. OF SHEETS

FED. ROAD DIST. NO.	STATE	FED. AID PROJ. NO.	FISCAL YEAR	SHEET NO.	TOTAL SHEETS
HAWAII	HAW	U072-1(10)	1968	424	45
		U063-1(1)	1968	221	45

ML
#575 33+00

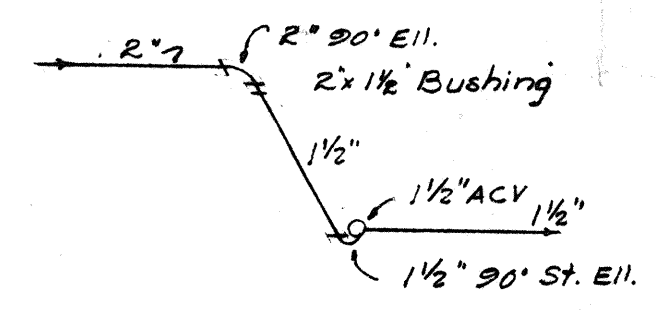


DETAIL 5-A

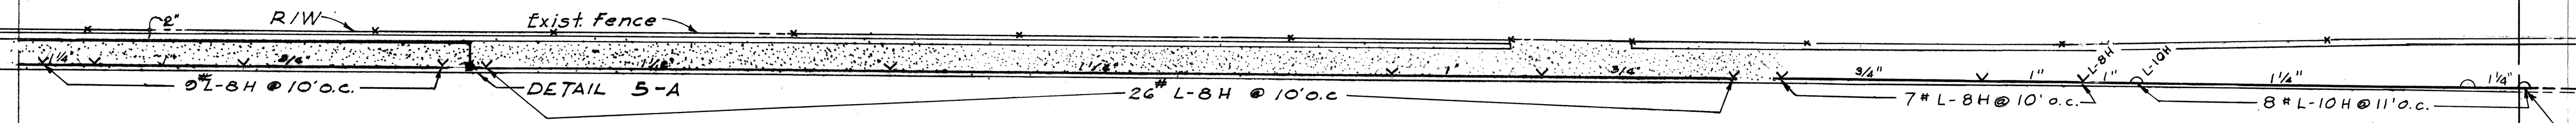

WEST


BOUND

See Note 10 of Sheet 1

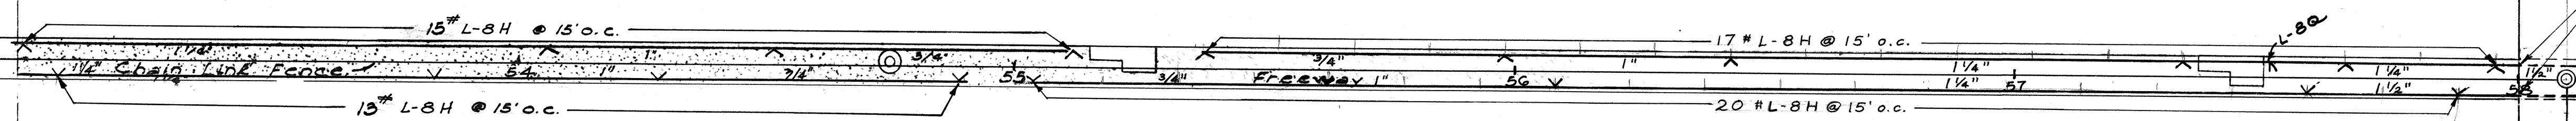

EAST


BOUND

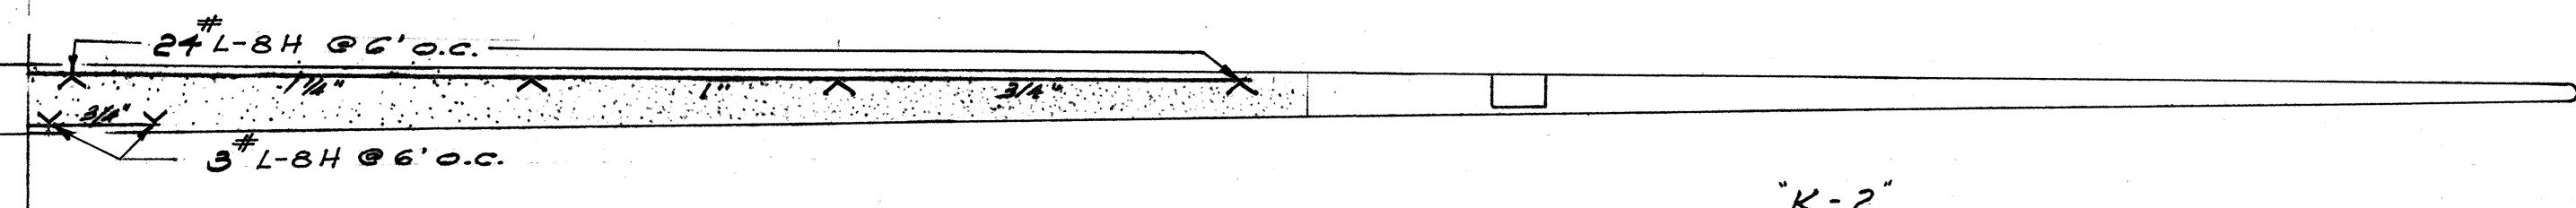


RAMP

"K-2"

See Note 10 of Sheet 1

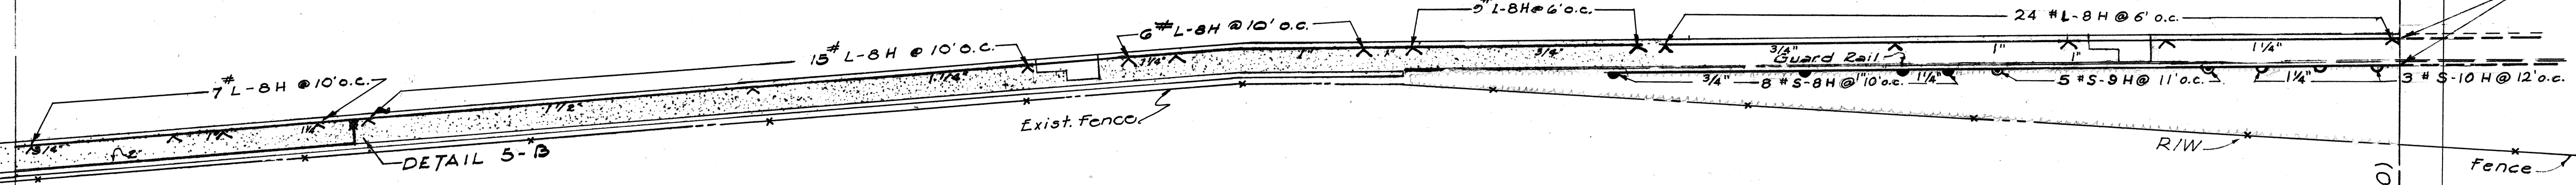


DETAIL 5-B

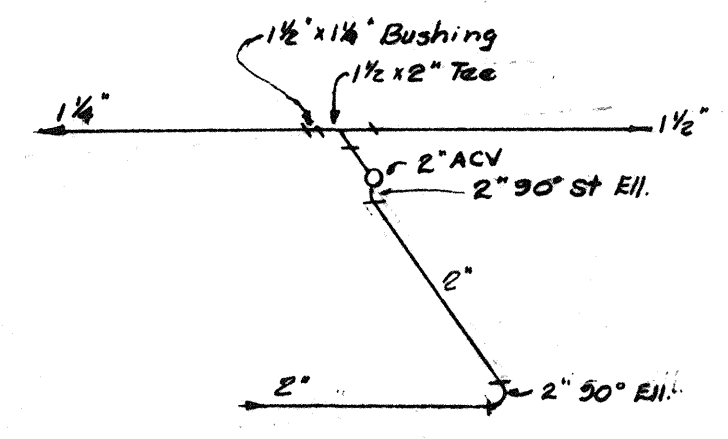

DETAIL 5-B

#575 58+00 END OF PROJ. NO. U-072-1(10)

PC 575 58+00.98

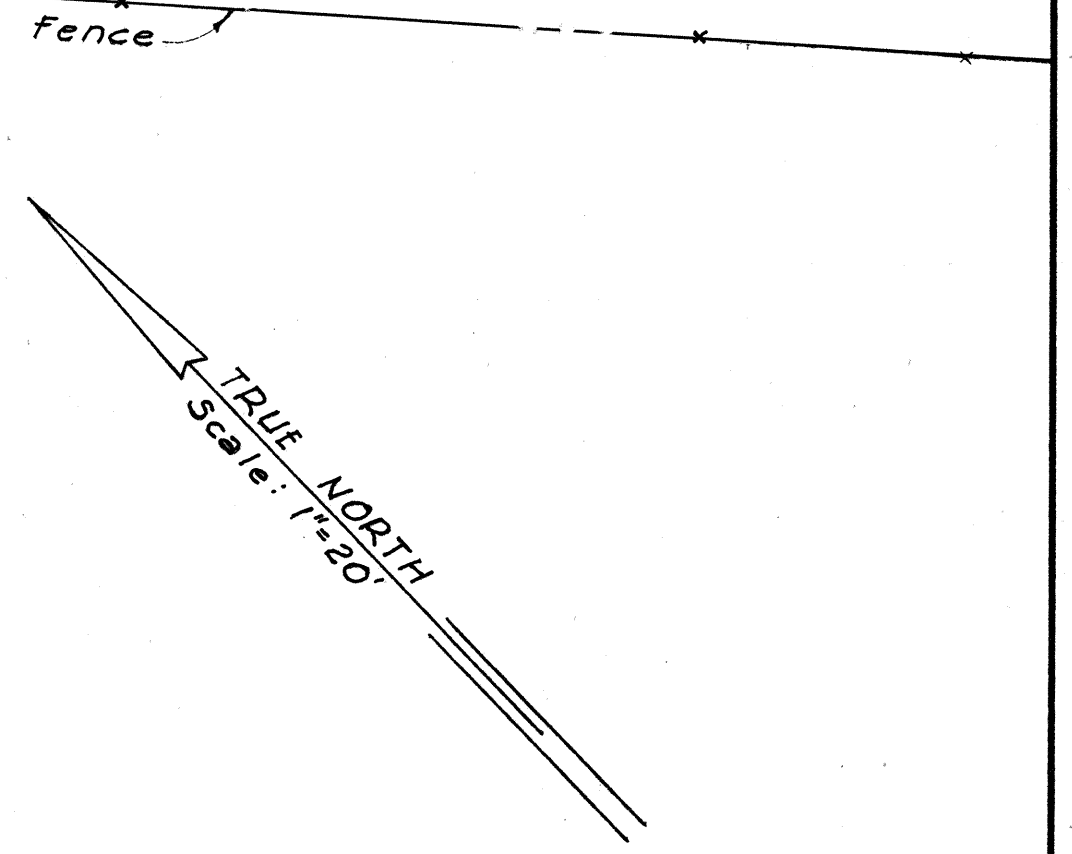

ORIGINAL PLAN	DATE
SURVEY PLOTTED BY	3-57
DRAWN BY	3-57
TRACED BY	3-57
CHECKED BY	3-57
NOTE BOOK	
NO.	



BELT, COLLINS & ASSOC., LTD.
Civil and Structural Engineers

STATE OF HAWAII
DEPARTMENT OF TRANSPORTATION
HIGHWAYS DIVISION

LANDSCAPE & SPRINKLER PLAN

LUNALILO FREEWAY
LIKELIKE HIGHWAY

U-072-1(10)
U-063-1(1)

SHEET No. 5 OF 9 SHEETS

A 24 B 21

FED. ROAD DIST. NO.	STATE	FED. AID PROJ. NO.	FISCAL YEAR	SHEET NO.	TOTAL SHEETS
HAWAII	HAW.	U-072-1(10)	1963	25	45
		U-063-1(10)	1963	23	45

DATE	3-57
DESIGNED BY	E. Collins
TRACED BY	E. Collins
QUANTITIES CHECKED BY	E. Collins
CHECKED BY	E. Collins
ORIGINAL PLAN	
NOTE BOOK NO.	

