


INDEX TO DRAWINGS	
SHT. NO.	DESCRIPTION
1	TITLE SHEET
2 - 4	TYPICAL SECTIONS
5 - 9	CONSTRUCTION PHASING & DETOUR PLANS WITH DETAILS
10 - 13	PLAN AND PROFILE
14 - 15	RAMP PROFILES
16	SUPERELEVATION DIAGRAM
17 - 29	DETAIL PLAN OF ROADWAY
30 - 52	SPECIAL DETAILS
(30 - 38)	ROADWAY
(39 - 45)	DRAINAGE
(46 - 52)	R/W ADJUSTMENTS
53 - 56	DEMOLITION PLANS
57 - 106	WATER, SEWER, GAS, ELECTRIC & TELEPHONE PLANS & DETAILS
107 - 130	REGULATORY, WARNING AND GUIDE SIGNS WITH DETAILS
131 - 137	TRAFFIC SIGNAL SYSTEM
138 - 147	HIGHWAY LIGHTING PLANS
148 - 243	GRADE SEPARATION STRUCTURES WITH DETAILS
(148 - 160)	STRUCTURE No. 1
(161 - 171)	STRUCTURE No. 2
(172 - 238)	STRUCTURE No. 3
(239 - 243)	STANDARD DETAILS
244 - 245	LANDSCAPING PLANS
246 - 255	SPRINKLER SYSTEM
256 - 274	CROSS SECTIONS
275 - 276	SUPPLEMENTARY DETAIL PLAN OF ROADWAY

CO 40S-I, CO 62 S-I, CO 72 S-I, CO 223 S(I), CO 225 S(I) & CO 241(I) are supplementary sheets added to the plans during the course of construction.

STATE OF HAWAII
DEPARTMENT OF TRANSPORTATION
HIGHWAYS DIVISION
HONOLULU, HAWAII
"AS BUILT"
PLANS OF

INTERSTATE HIGHWAY (LUNALILO FREEWAY)
KAPIOLANI INTERCHANGE, OLD WAIALAE ROAD TO FIRST AVENUE
FEDERAL AID INTERSTATE PROJECT No. I-HI-I(5):24, UNIT 2
DISTRICT OF HONOLULU
ISLAND OF OAHU

SCALES:	
PLAN & PROFILE	HOR. 1" = 50' VER. 1" = 10'
DETAIL ROADWAY PLAN	1" = 20'
CROSS SECTION	HOR. 1" = 10' VER. 1" = 10'

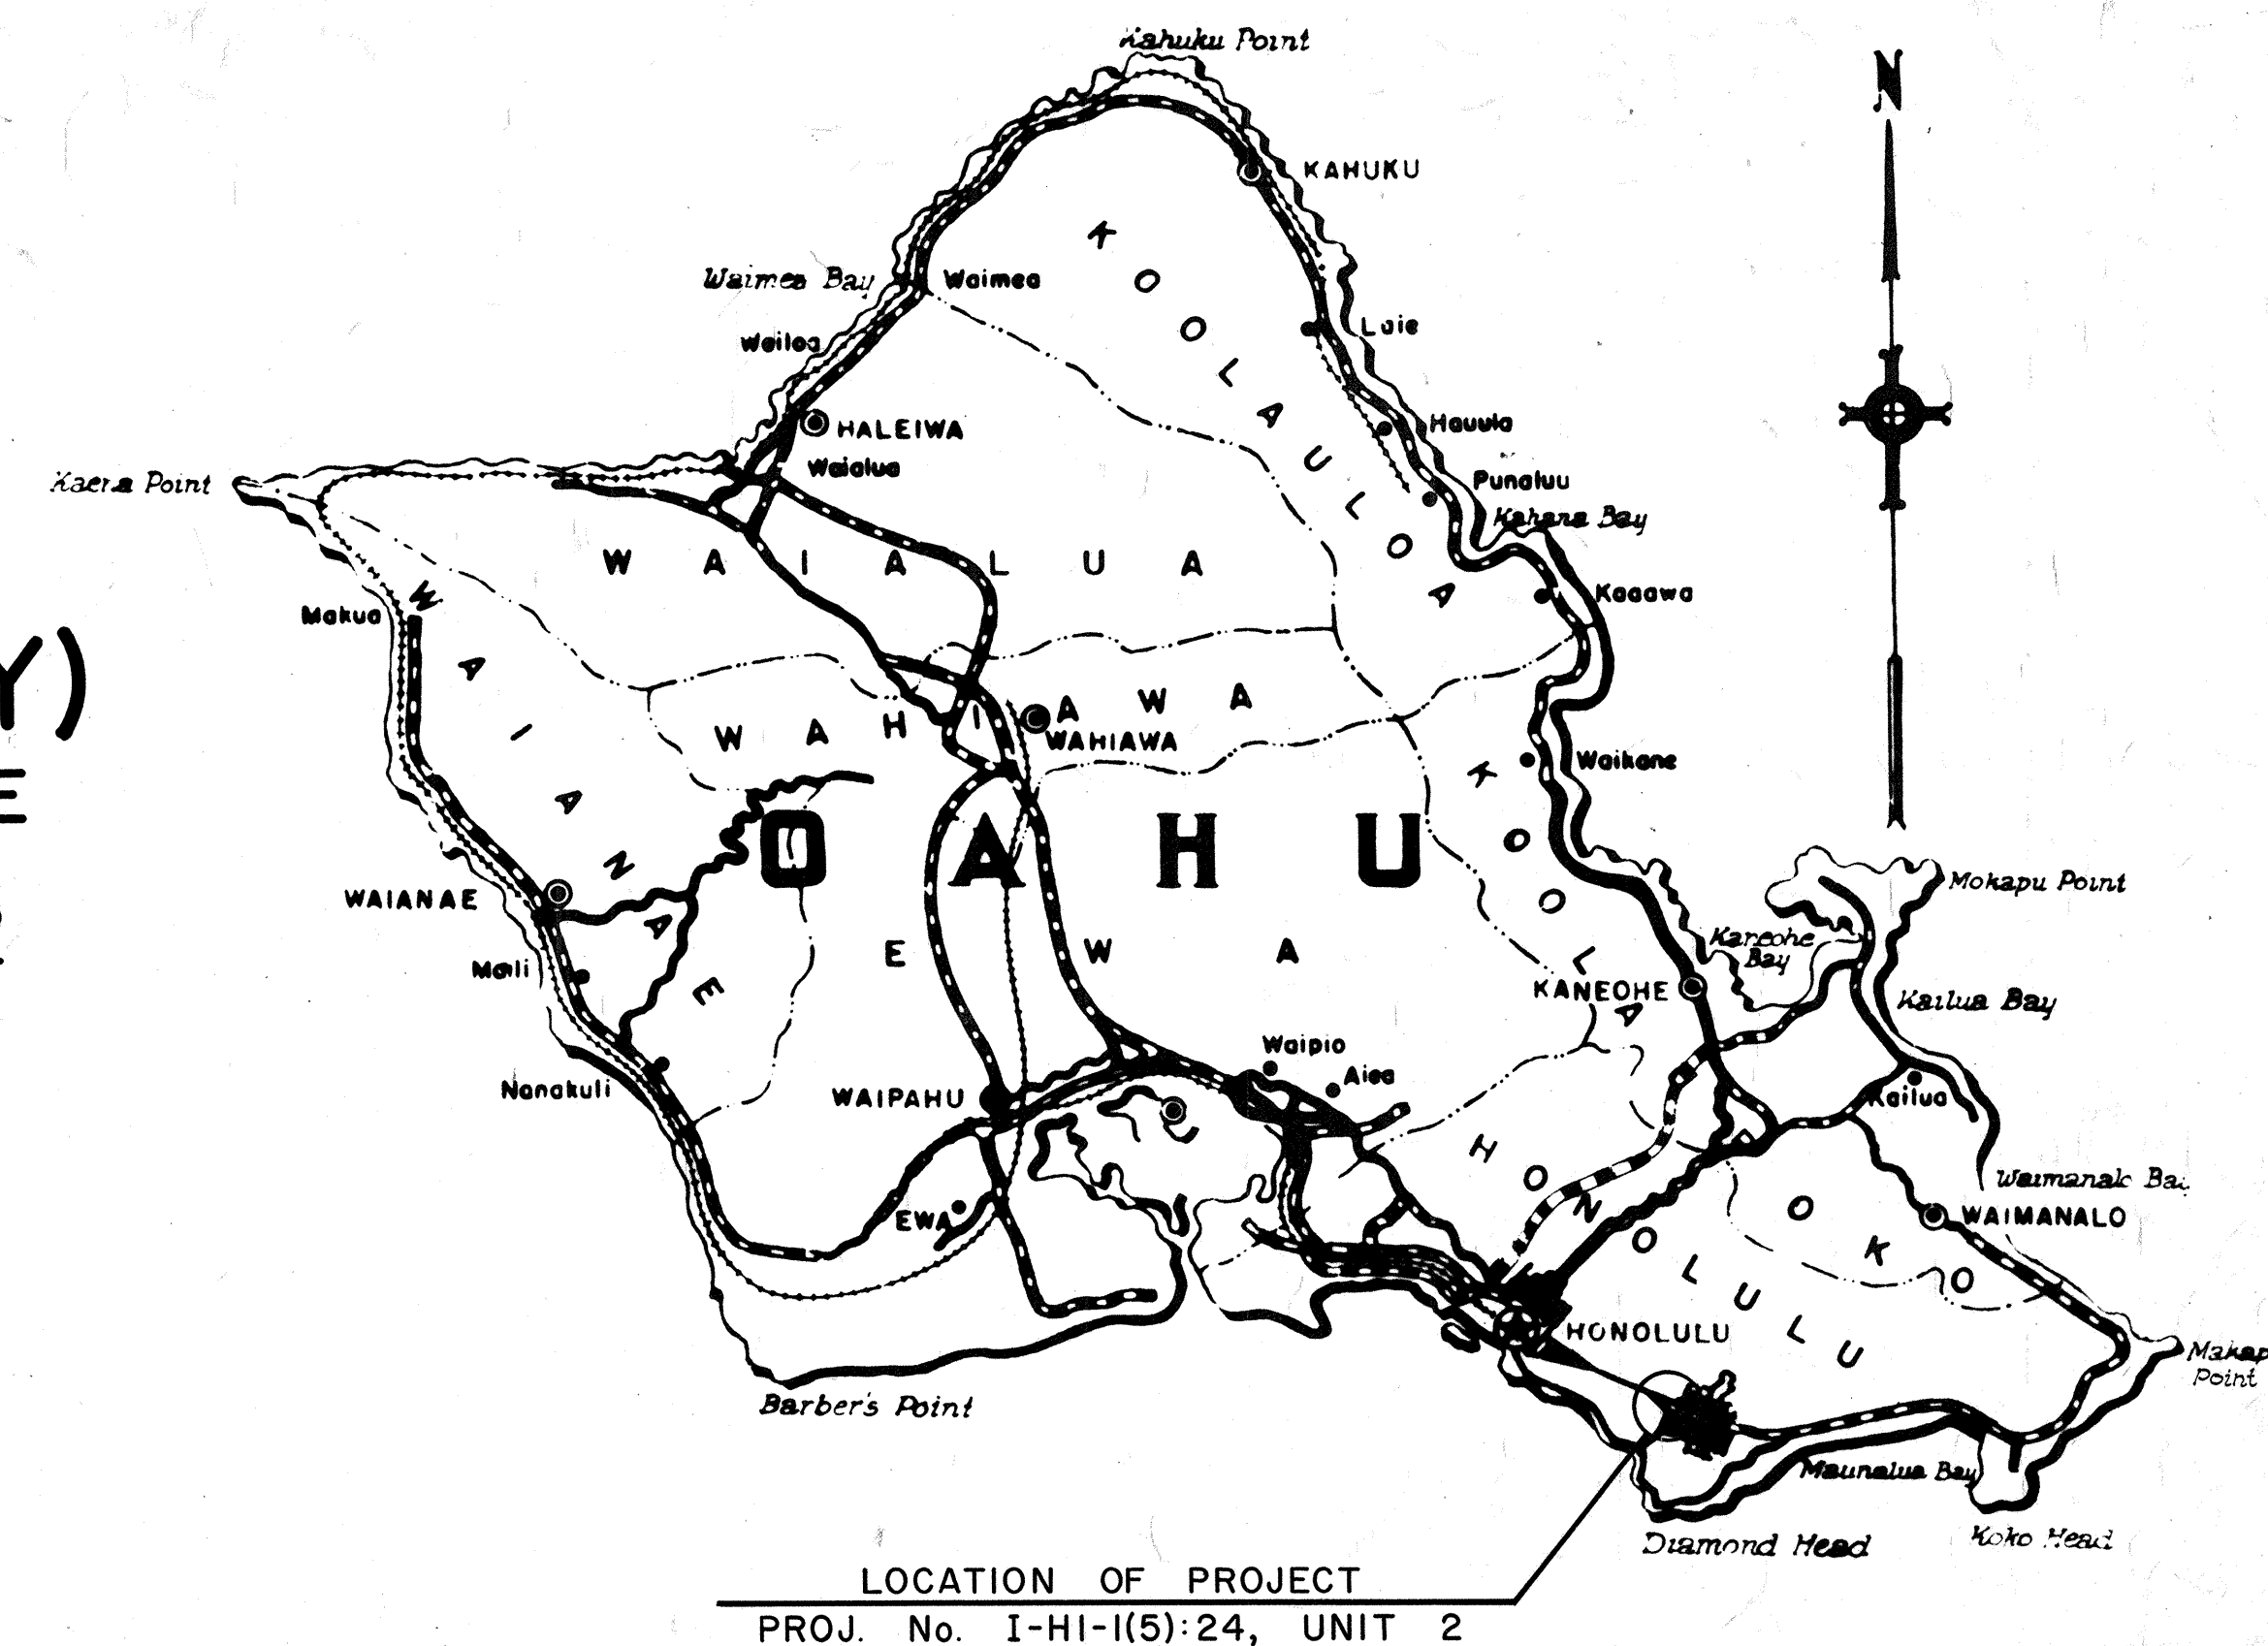

Federal Aid Projects Previously Constructed Or Under Construction

NOTE:
ALL CHANGES MADE DURING CONSTRUCTION HAVE BEEN NOTED ON THESE TRACINGS IN RED AND CHECKED BY:


Thomas N. Muijanoff 10/16/65
PROJECT ENGINEER DATE

DESIGN CLASSIFICATION

ADT (1964).....49,500
DESIGN ADT (1975).....73,700
DHV.....6,900
D.....55/45
T.....7 %
V.....50 M.P.H.

APPROVED: DATE 5-29-65
Kaiyo T. Kaku
ACTING DIRECTOR OF TRANSPORTATION

DEPARTMENT OF COMMERCE
BUREAU OF PUBLIC ROADS
APPROVED: 6/14/65
John M. Stearns
DIVISION ENGINEER DATE

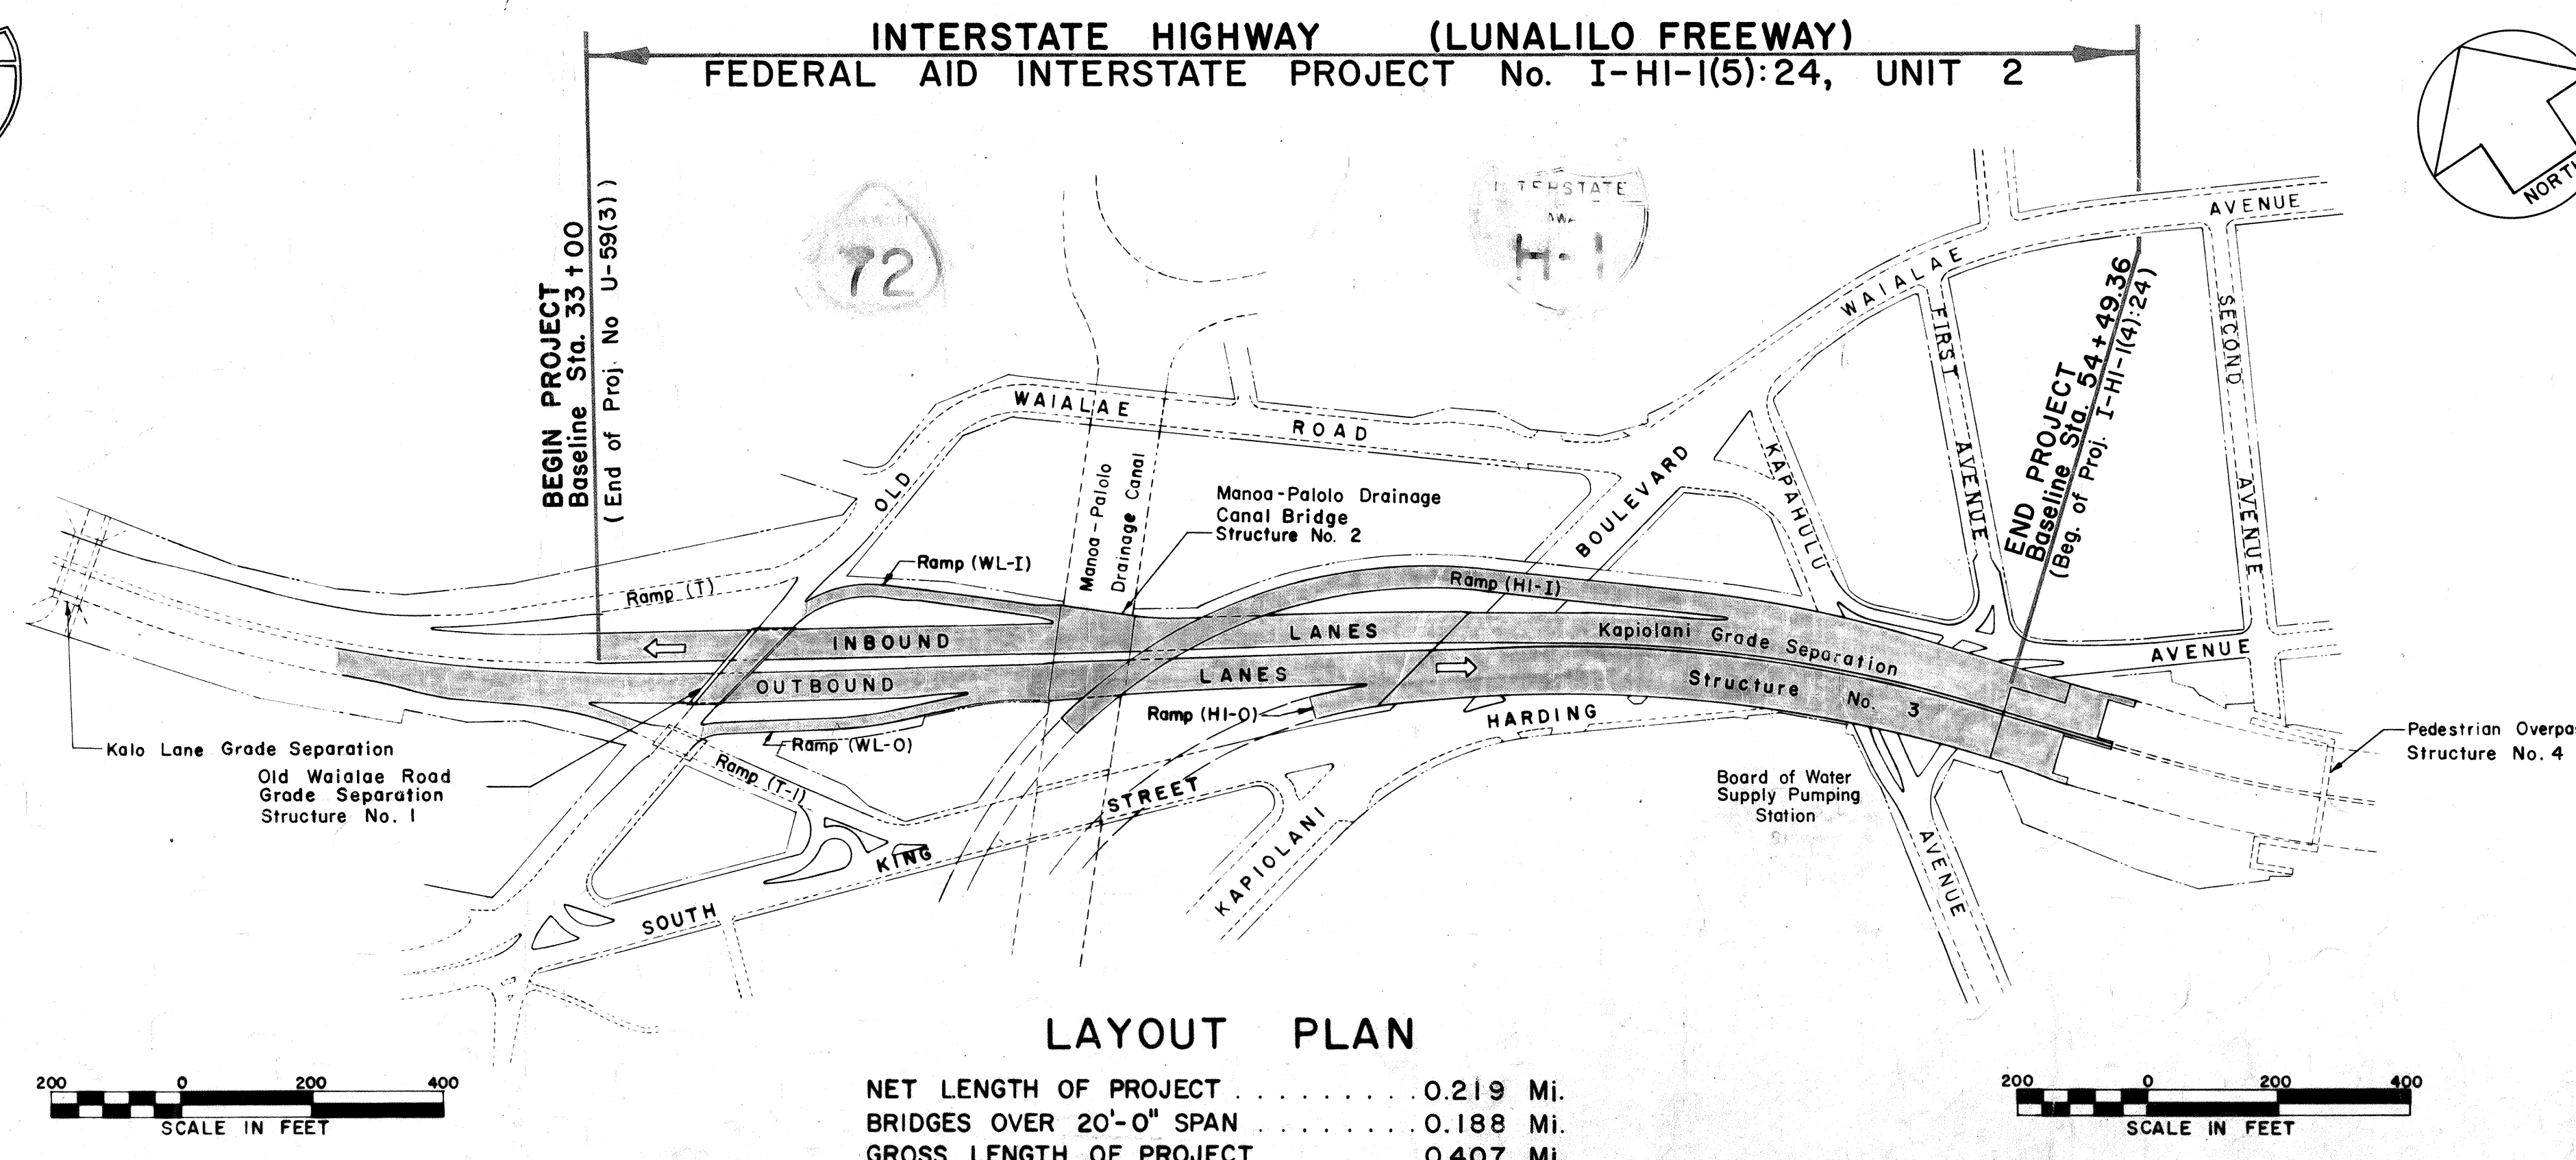

LAYOUT PLAN

NET LENGTH OF PROJECT0.219 Mi.
BRIDGES OVER 20'-0" SPAN0.188 Mi.
GROSS LENGTH OF PROJECT0.407 Mi.

DATE
SURVEY PLOTTED BY
DRAWN BY
CHECKED BY
ORIGINAL PLAN
NOTE BOOK
NO.