

INDEX TO DRAWINGS	
SHEET NO	DESCRIPTION
1	TITLE SHEET
2-10	TYPICAL SECTIONS
11-18	PLAN AND PROFILES
19-20	CONSTRUCTION PHASE
21-23	BORING DATA
24-36	DETAIL PLAN OF ROADWAY
37-43	REINF. CONC. RET. WALLS
44	HOLLOW TILE WALL
45-52	MISC. ROADWAY DETAILS & STDS.
53	BOX CULV'T. EXTENSION FOR EXIST. WAIALAE MAJOR STORM DRAIN
54-64	DRAINAGE SYSTEM
65-81	UTILITIES - WATER & SEWER
82	UTILITIES - SEWER TUNNEL DETAILS
83-117	UTILITIES - ELECTRIC, TELEPHONE, GAS, C.B.C. STREET LIGHTING, AND FIRE ALARM SYSTEMS
118-126	HIGHWAY LIGHTING SYSTEM
127-139	TRAFFIC SIGNAL SYSTEM
140-157	TRAFFIC, DESTINATION, AND REGULATORY SIGNS
158-166	LANDSCAPING AND SPRINKLING
166A-166E	TRANSPLANTED TREES PLAN
167-175	CROSS SECTIONS
176-208	WAIALAE OFF-RAMP (STRUCTURE NO. 20) AND WAIALAE VIADUCT (STRUCTURE NO. 21)
209-223	WAIALAE-NUI STREAM BRIDGES (STRUCTURE NO. 22)
* 224-232	KAPAKAHI STREAM BRIDGE (STRUCTURE NO. 23)
233-235	STANDARD DETAILS - BRIDGE

* C.O. 232 S-1, S-2, S-3, S-4, S-5 & S-6
CHANGE ORDER DETAILS

STATE OF HAWAII
DEPARTMENT OF TRANSPORTATION
HIGHWAYS DIVISION
HONOLULU, HAWAII
AS BUILT
PLANS FOR
CONSTRUCTION OF A PORTION OF

INTERSTATE HIGHWAY (LUNALILO FREEWAY)
21ST AVENUE TO VICINITY OF KILAUEA AVENUE
FEDERAL AID INTERSTATE PROJECT NO. I-HI-1 (6) UNIT 3

DISTRICT OF HONOLULU
ISLAND OF OAHU

NOTE:

ALL CHANGES MADE DURING CONSTRUCTION
HAVE BEEN NOTED IN RED ON THESE TRACINGS
AND CHECKED BY:


J. S. Suter
PROJECT ENGINEER
MAR 8, 1971
DATE

SCALES:

PLAN & PROFILE HOR. 1" = 50'
VER. 1" = 10'


DETAIL ROADWAY PLAN 1" = 20'

CROSS SECTION HOR. 1" = 10'
VER. 1" = 10'

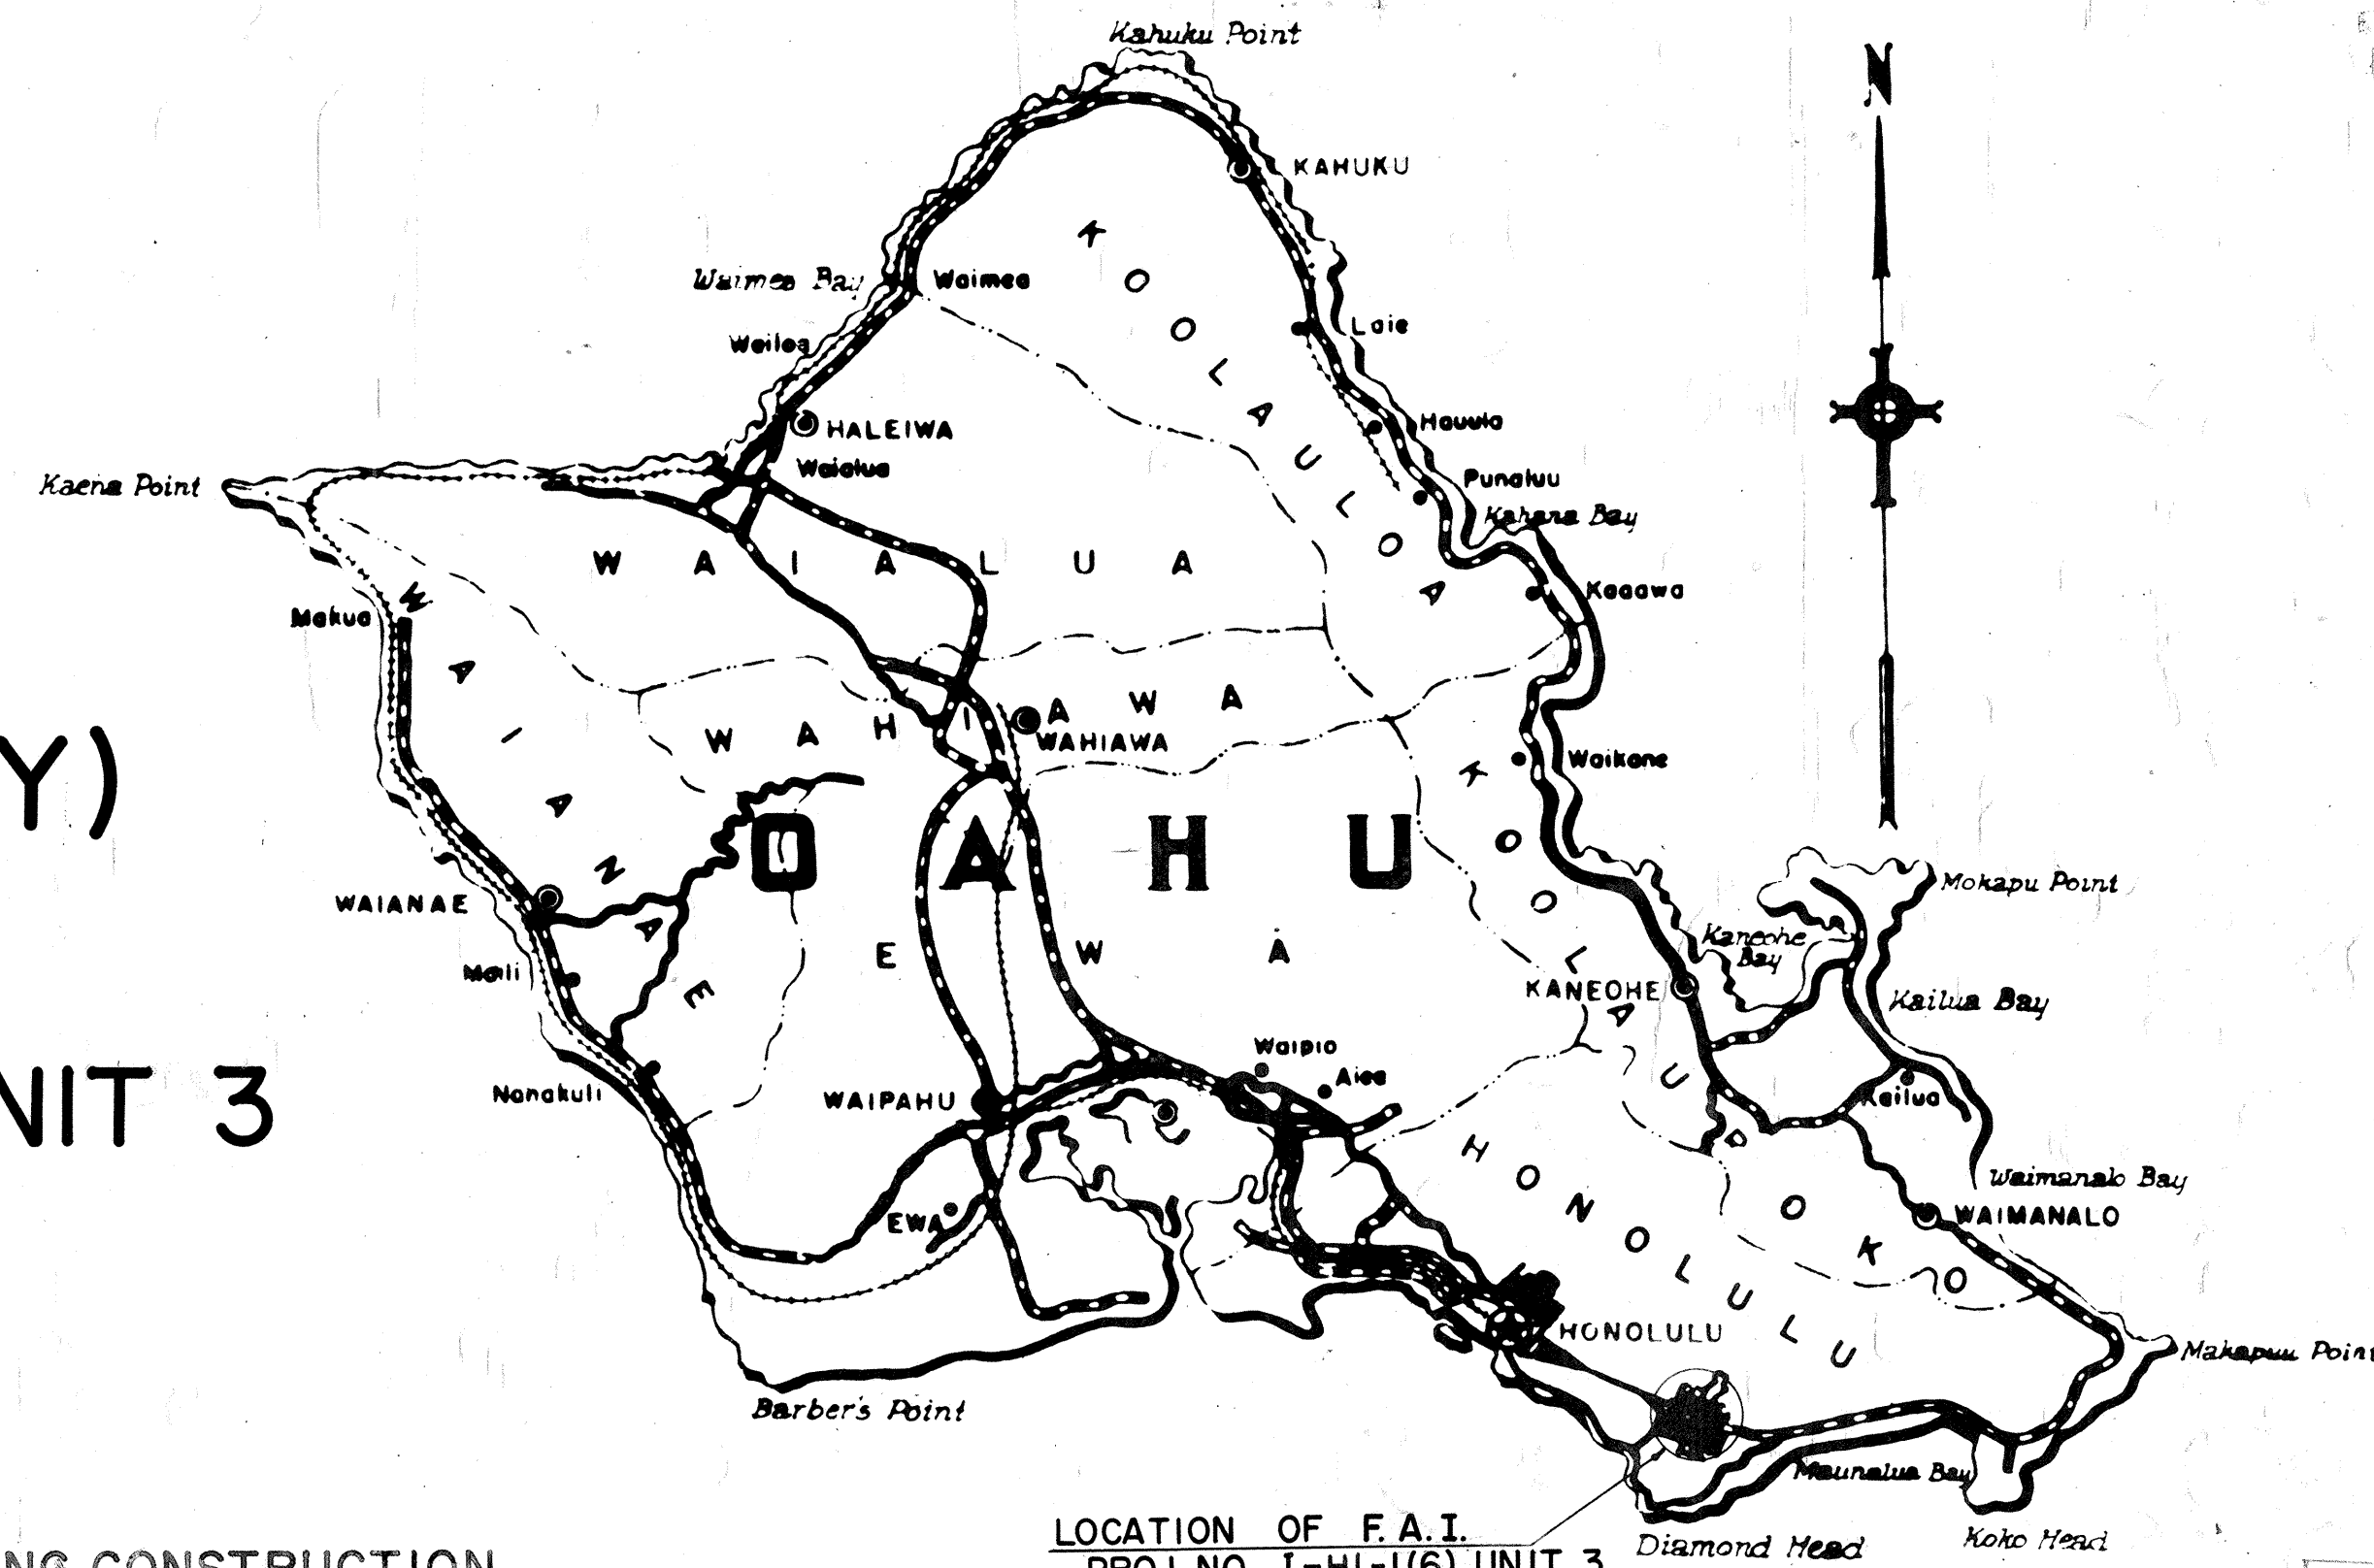

LOCATION OF F.A.I.
PROJ. NO. I-HI-1(6) UNIT 3

Federal Aid Projects Previously Constructed Or Under Construction

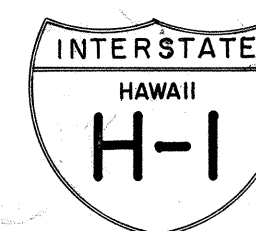


DESIGN CLASSIFICATION

DESIGN ADT (1975) 49,200
DHV 10 %
D 70/30
T 3 %
V 50 M.P.H.

WILSON, OKAMOTO, OKA, INC. • PARK ASSOCIATES, INC.
CONSULTING ENGINEERS

APPROVED: *John M. Suter* DATE 11-2-66
DIRECTOR OF TRANSPORTATION

DEPARTMENT OF COMMERCE
BUREAU OF PUBLIC ROADS
APPROVED: *John B. Doherty* 4-21-67
DIVISION ENGINEER DATE

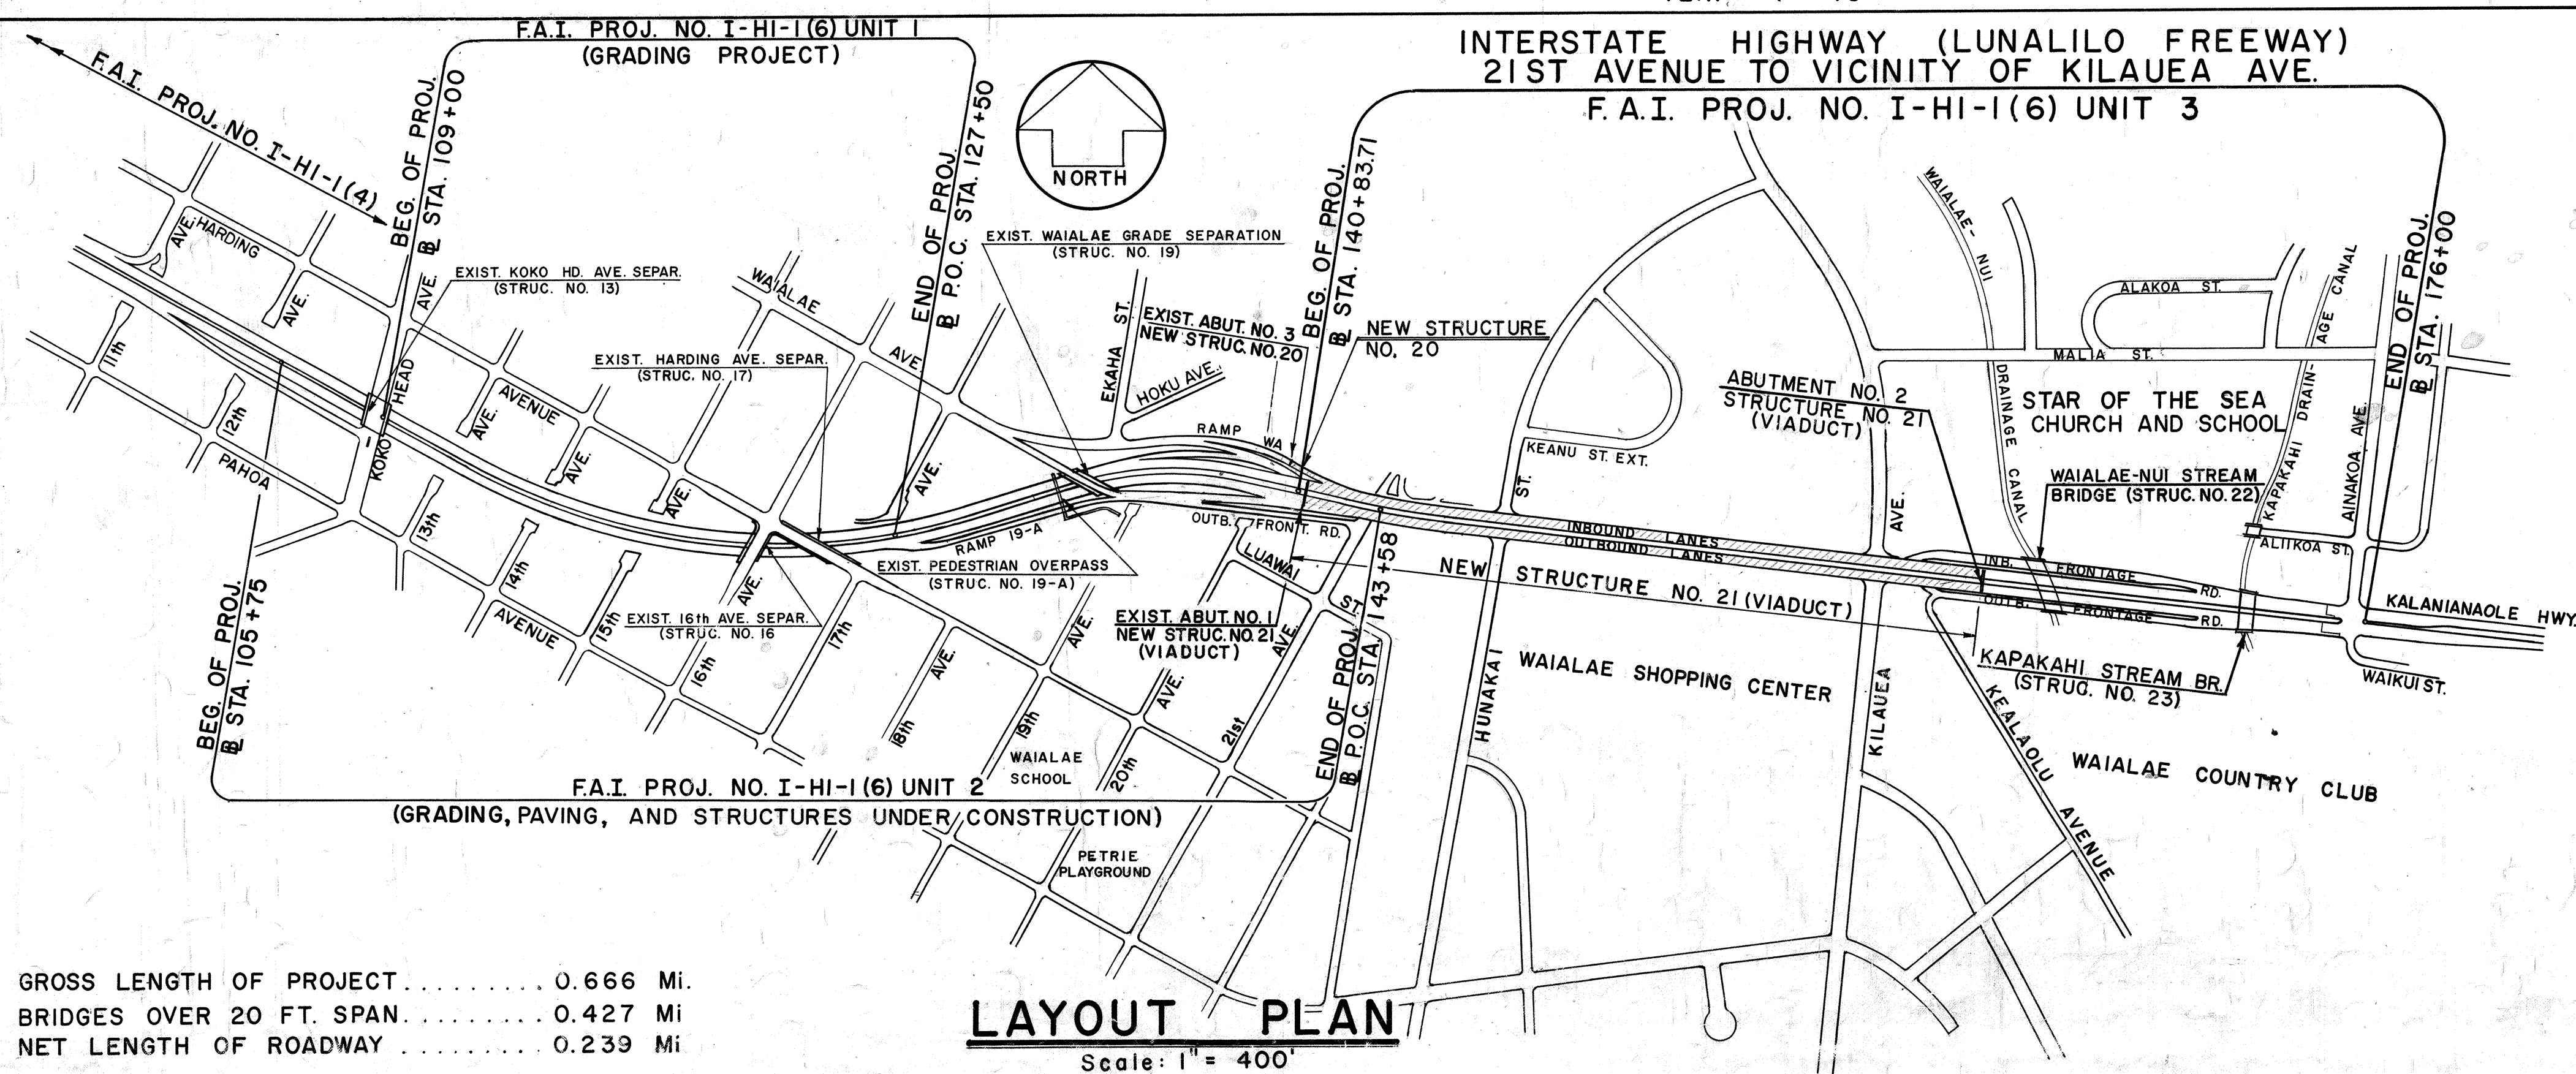

GROSS LENGTH OF PROJECT 0.666 Mi.
BRIDGES OVER 20 FT. SPAN 0.427 Mi
NET LENGTH OF ROADWAY 0.239 Mi

LAYOUT PLAN
Scale: 1" = 400'

DATE: Oct 66
DRAWN BY: R. Oishi
CHECKED BY: J. Suter
NOTE BOOK: No.