

INDEX TO DRAWINGS	
SHEET NO.	DESCRIPTION
1	TITLE SHEET
2	TYPICAL SECTIONS
3-5	PLAN AND PROFILE
6-10	DETAIL PLAN OF ROADWAY
11-17	MISC. ROADWAY DETAILS
18-20	R/W ADJUSTMENT PLANS
21-23	DEMOLITION PLANS
24-35, 35A	DRAINAGE PLANS AND DETAILS
36-51	SEWER AND WATER PLANS AND DETAILS
52-67	ELECTRIC, TELEPHONE AND GAS PLANS AND DETAILS
68-72	HIGHWAY LIGHTING PLANS AND DETAILS
73-88	REGULATORY, WARNING AND GUIDE SIGNS WITH DETAILS
89-90	LANDSCAPING, PLANS
91-95	SPRINKLER SYSTEM
96-143	GRADE SEPARATION STRUCTURES WITH DETAILS
144-152	CROSS SECTIONS
18S	R/W ADJUSTMENT PLANS
153S-156S	TRAFFIC SIGNS AND DETAILS

STATE OF HAWAII

DEPARTMENT OF TRANSPORTATION

HIGHWAYS DIVISION

HONOLULU, HAWAII

"AS BUILT"

PLANS OF

INTERSTATE HIGHWAY (LUNALILO FREEWAY)

KAPIOLANI INTERCHANGE, RAMP CONNECTION TO KAPIOLANI BOULEVARD


FEDERAL AID INTERSTATE PROJECT No. I-HI-I(5):24, UNIT 3

AND

FEDERAL AID INTERSTATE PROJECT No. I-HI-I(2):24, UNIT 7

DISTRICT OF HONOLULU

ISLAND OF OAHU

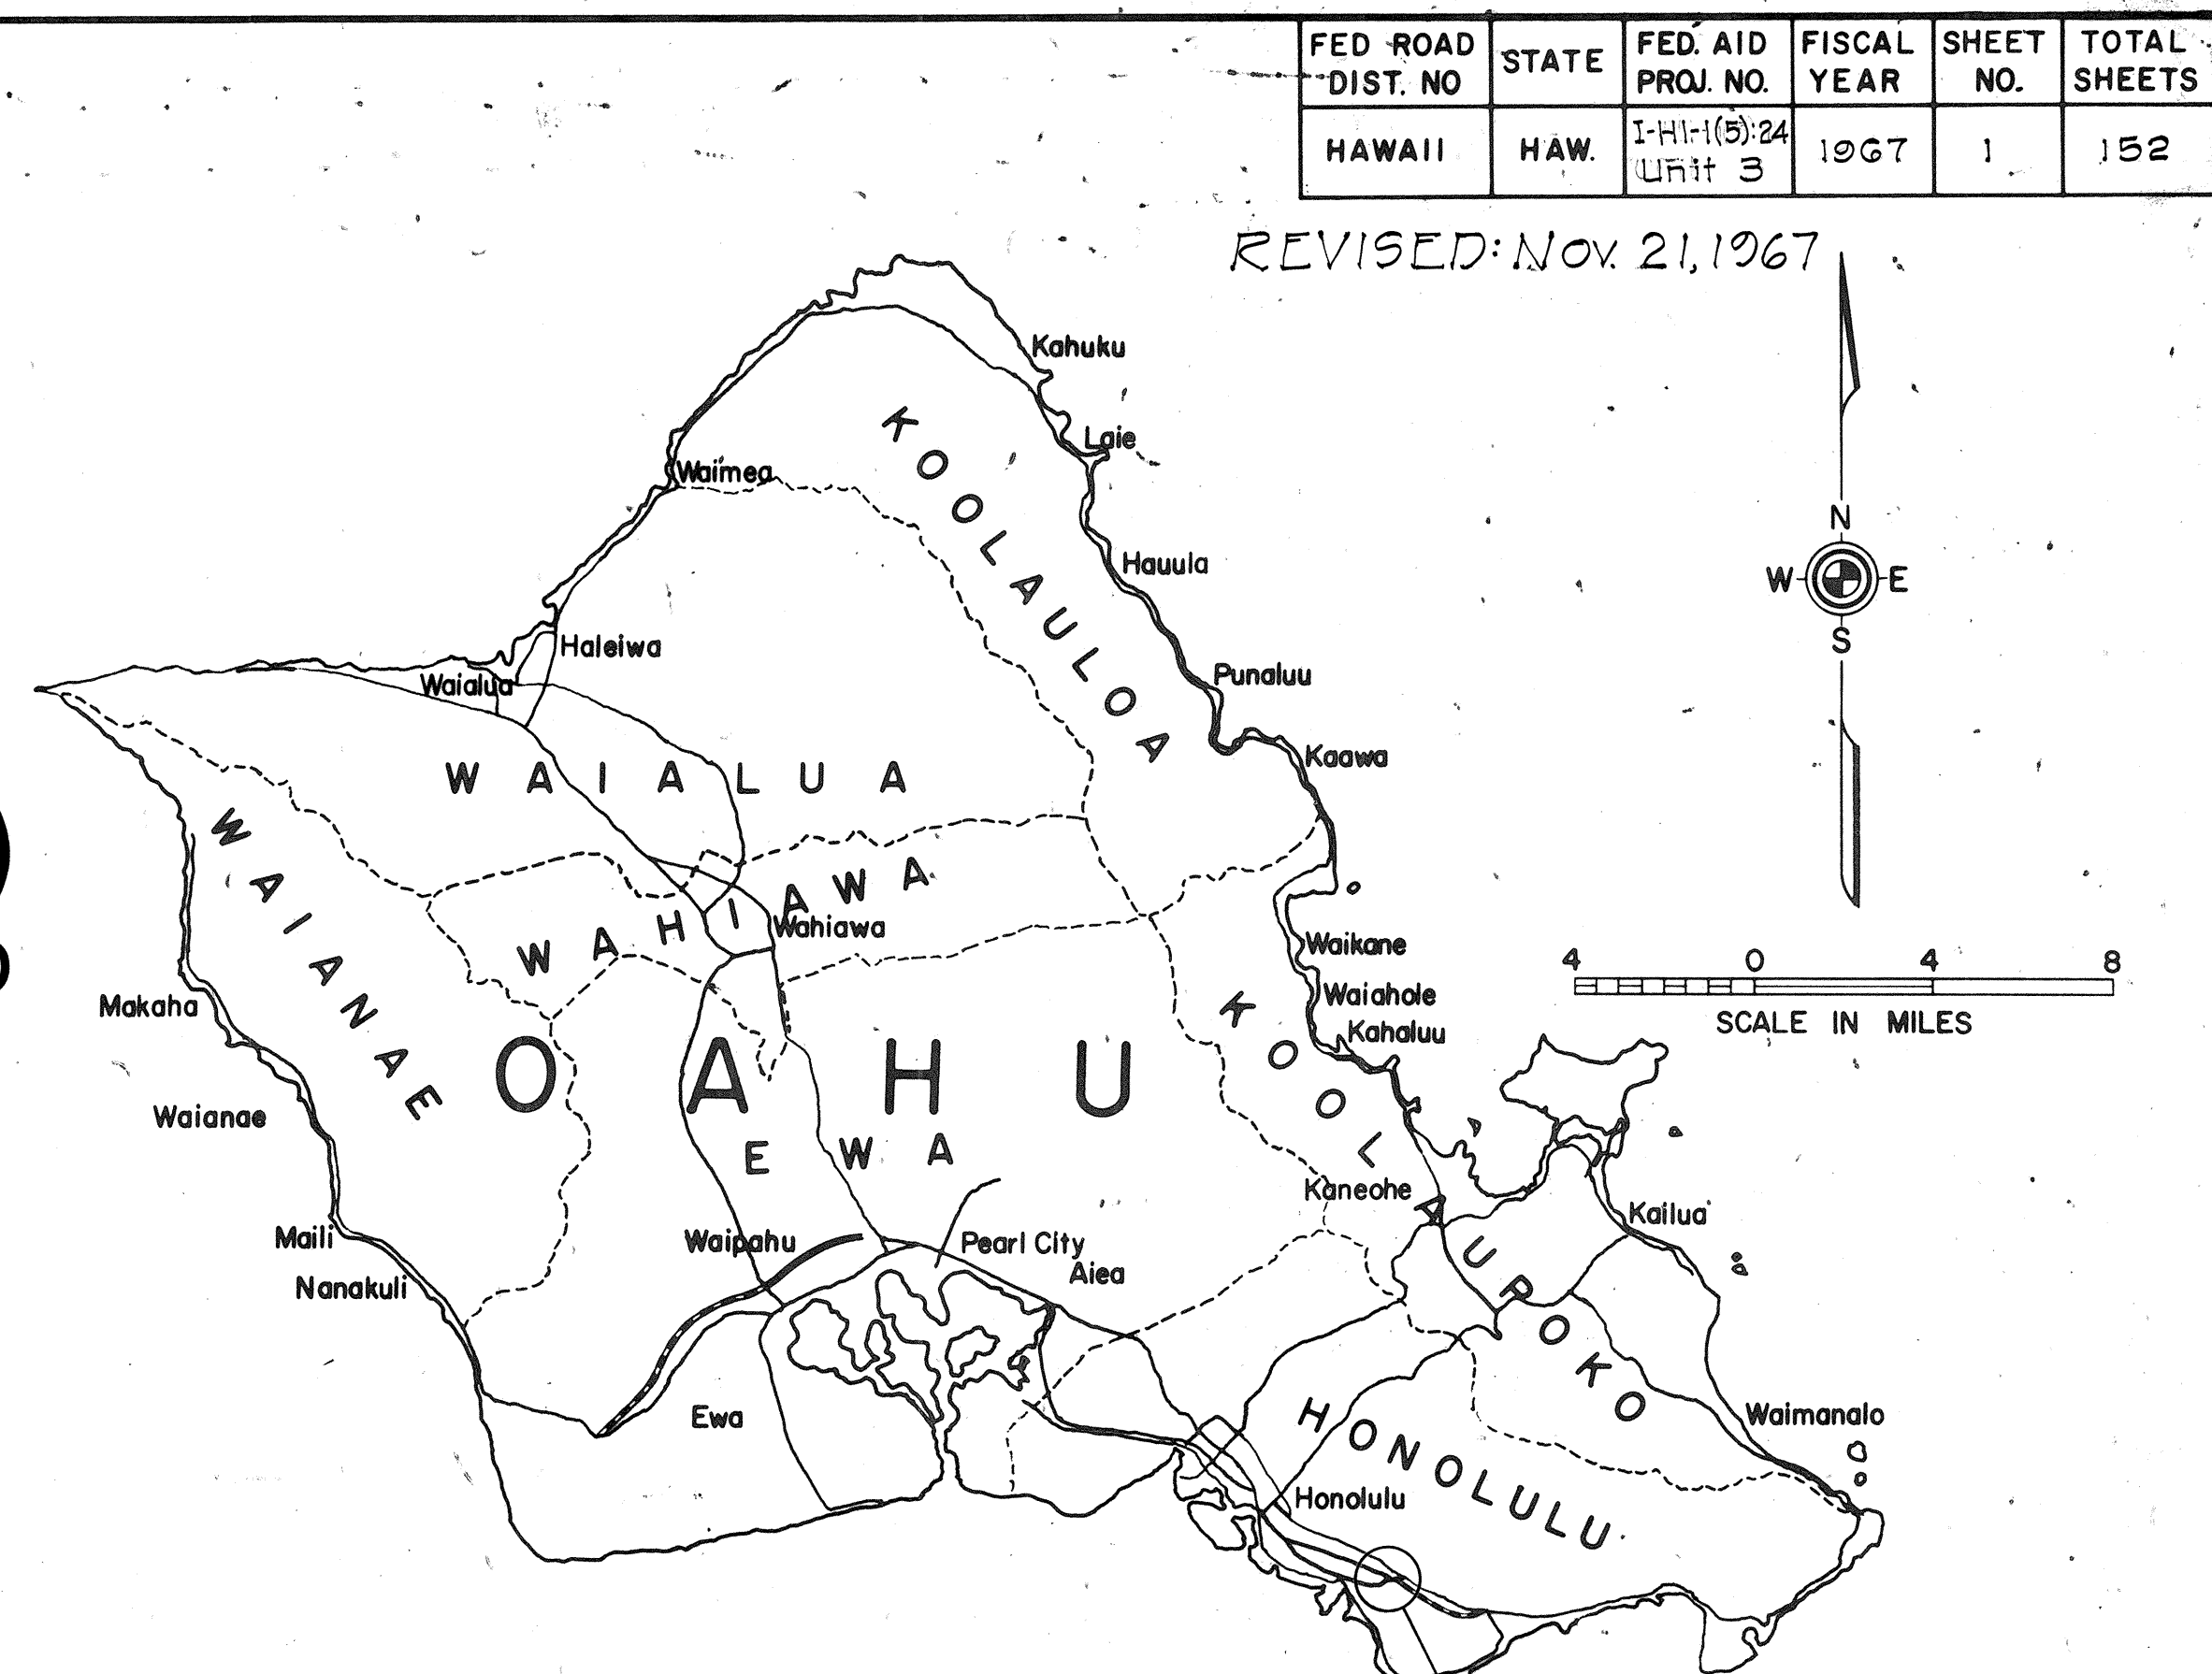

May, 1967

DATE

50511 Ext. 301



PHONE

C

HWY. DESIGN UNIT

Mike Miura

DESIGN ENGR.

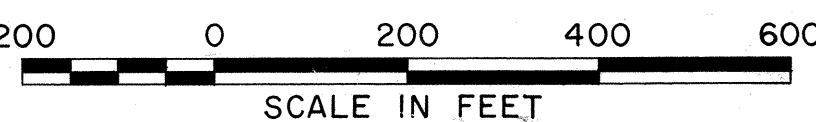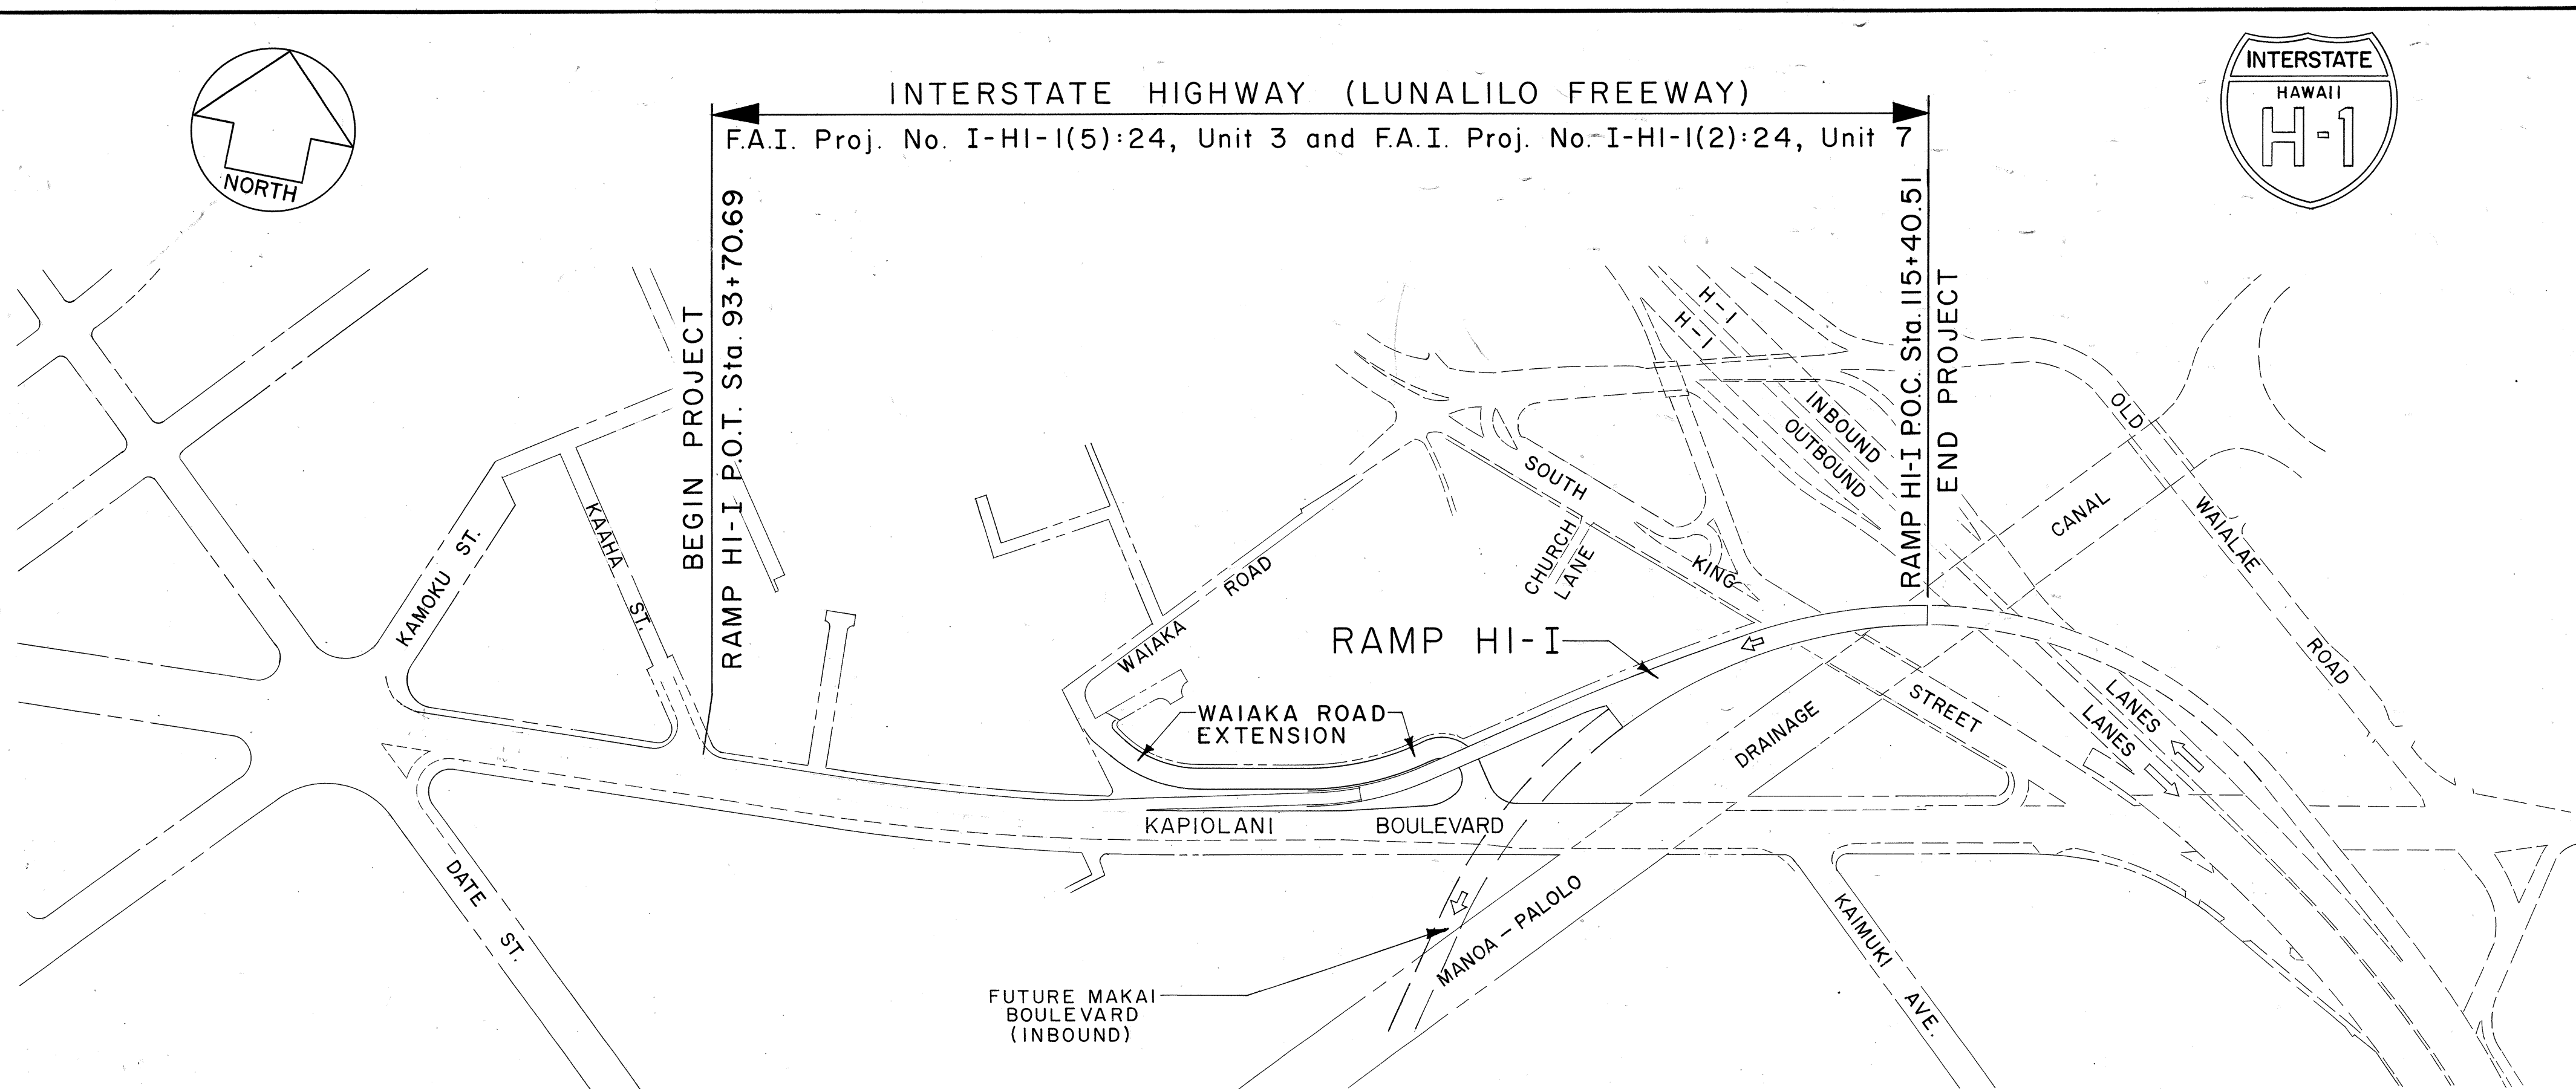

LAYOUT PLAN

GROSS LENGTH OF PROJECT

 
0.410 MI.

BRIDGES OVER 20.00' SPAN

0.196 MI.

NET LENGTH OF ROADWAY

0.214 MI.



LOCATION OF PROJECT

PROJ. No. I-HI-I(5):24, UNIT 3

PROJ. No. I-HI-I(2):24, UNIT 7

Federal Aid Interstate Projects Previously Constructed or Under Construction

NOTE: ALL CHANGES MADE DURING CONSTRUCTION HAVE BEEN NOTED IN RED ON THESE TRACINGS AND CHECKED BY.

Ralph J. Horie

RESIDENT ENGINEER

8-20-70

DATE

DESIGN CLASSIFICATION

CURRENT ADT (1967)

0

INTERIM ADT (1977)

12,400

DESIGN ADT (1987)

9,700

DHV

1,400

D

100%

T

1.5%

V

40 M.P.H.

CONTROL OF ACCESS = FULL

THIS SHEET SUPERSEDES SHEET NO. 1

DEPARTMENT OF TRANSPORTATION

BUREAU OF PUBLIC ROADS

APPROVED:

John M. Sen

9-5-67

DIVISION ENGINEER

DATE

DEPARTMENT OF TRANSPORTATION

STATE OF HAWAII

APPROVED:

John M. Sen

6-22-67

DIR. OF TRANSPORTATION

DATE