

INDEX TO DRAWINGS	
SHT. NO.	DESCRIPTION
1	TITLE SHEET
2	PLAN AND PROFILE
3 - 4	DETAIL PLAN OF ROADWAY
5	RELOCATION OF INCINERATOR FOR HALE MOHALU HOSPITAL
6 - 7	MISCELLANEOUS AND STANDARD DETAILS
8 - 41	PEARL CITY VIADUCT
42 - 43	LIGHTING PLAN AND DETAILS

STATE OF HAWAII

DEPARTMENT OF TRANSPORTATION

HIGHWAYS DIVISION

HONOLULU, HAWAII

"AS BUILT" PLANS OF

INTERSTATE ROUTE H-1

WAIAWA STREAM TO WEST OF WAI'AU INTERCHANGE

( STA 38+50 TO WAIMANO STREAM )

FEDERAL AID INTERSTATE PROJECT NO. I-HI-1(43):10

DISTRICT OF EWA


ISLAND OF OAHU

SCALES


PLAN ----- 1 INCH = 100 FT.

PROFILE ----- HOR. 1 INCH = 100 FT.

VER. 1 INCH = 10 FT.

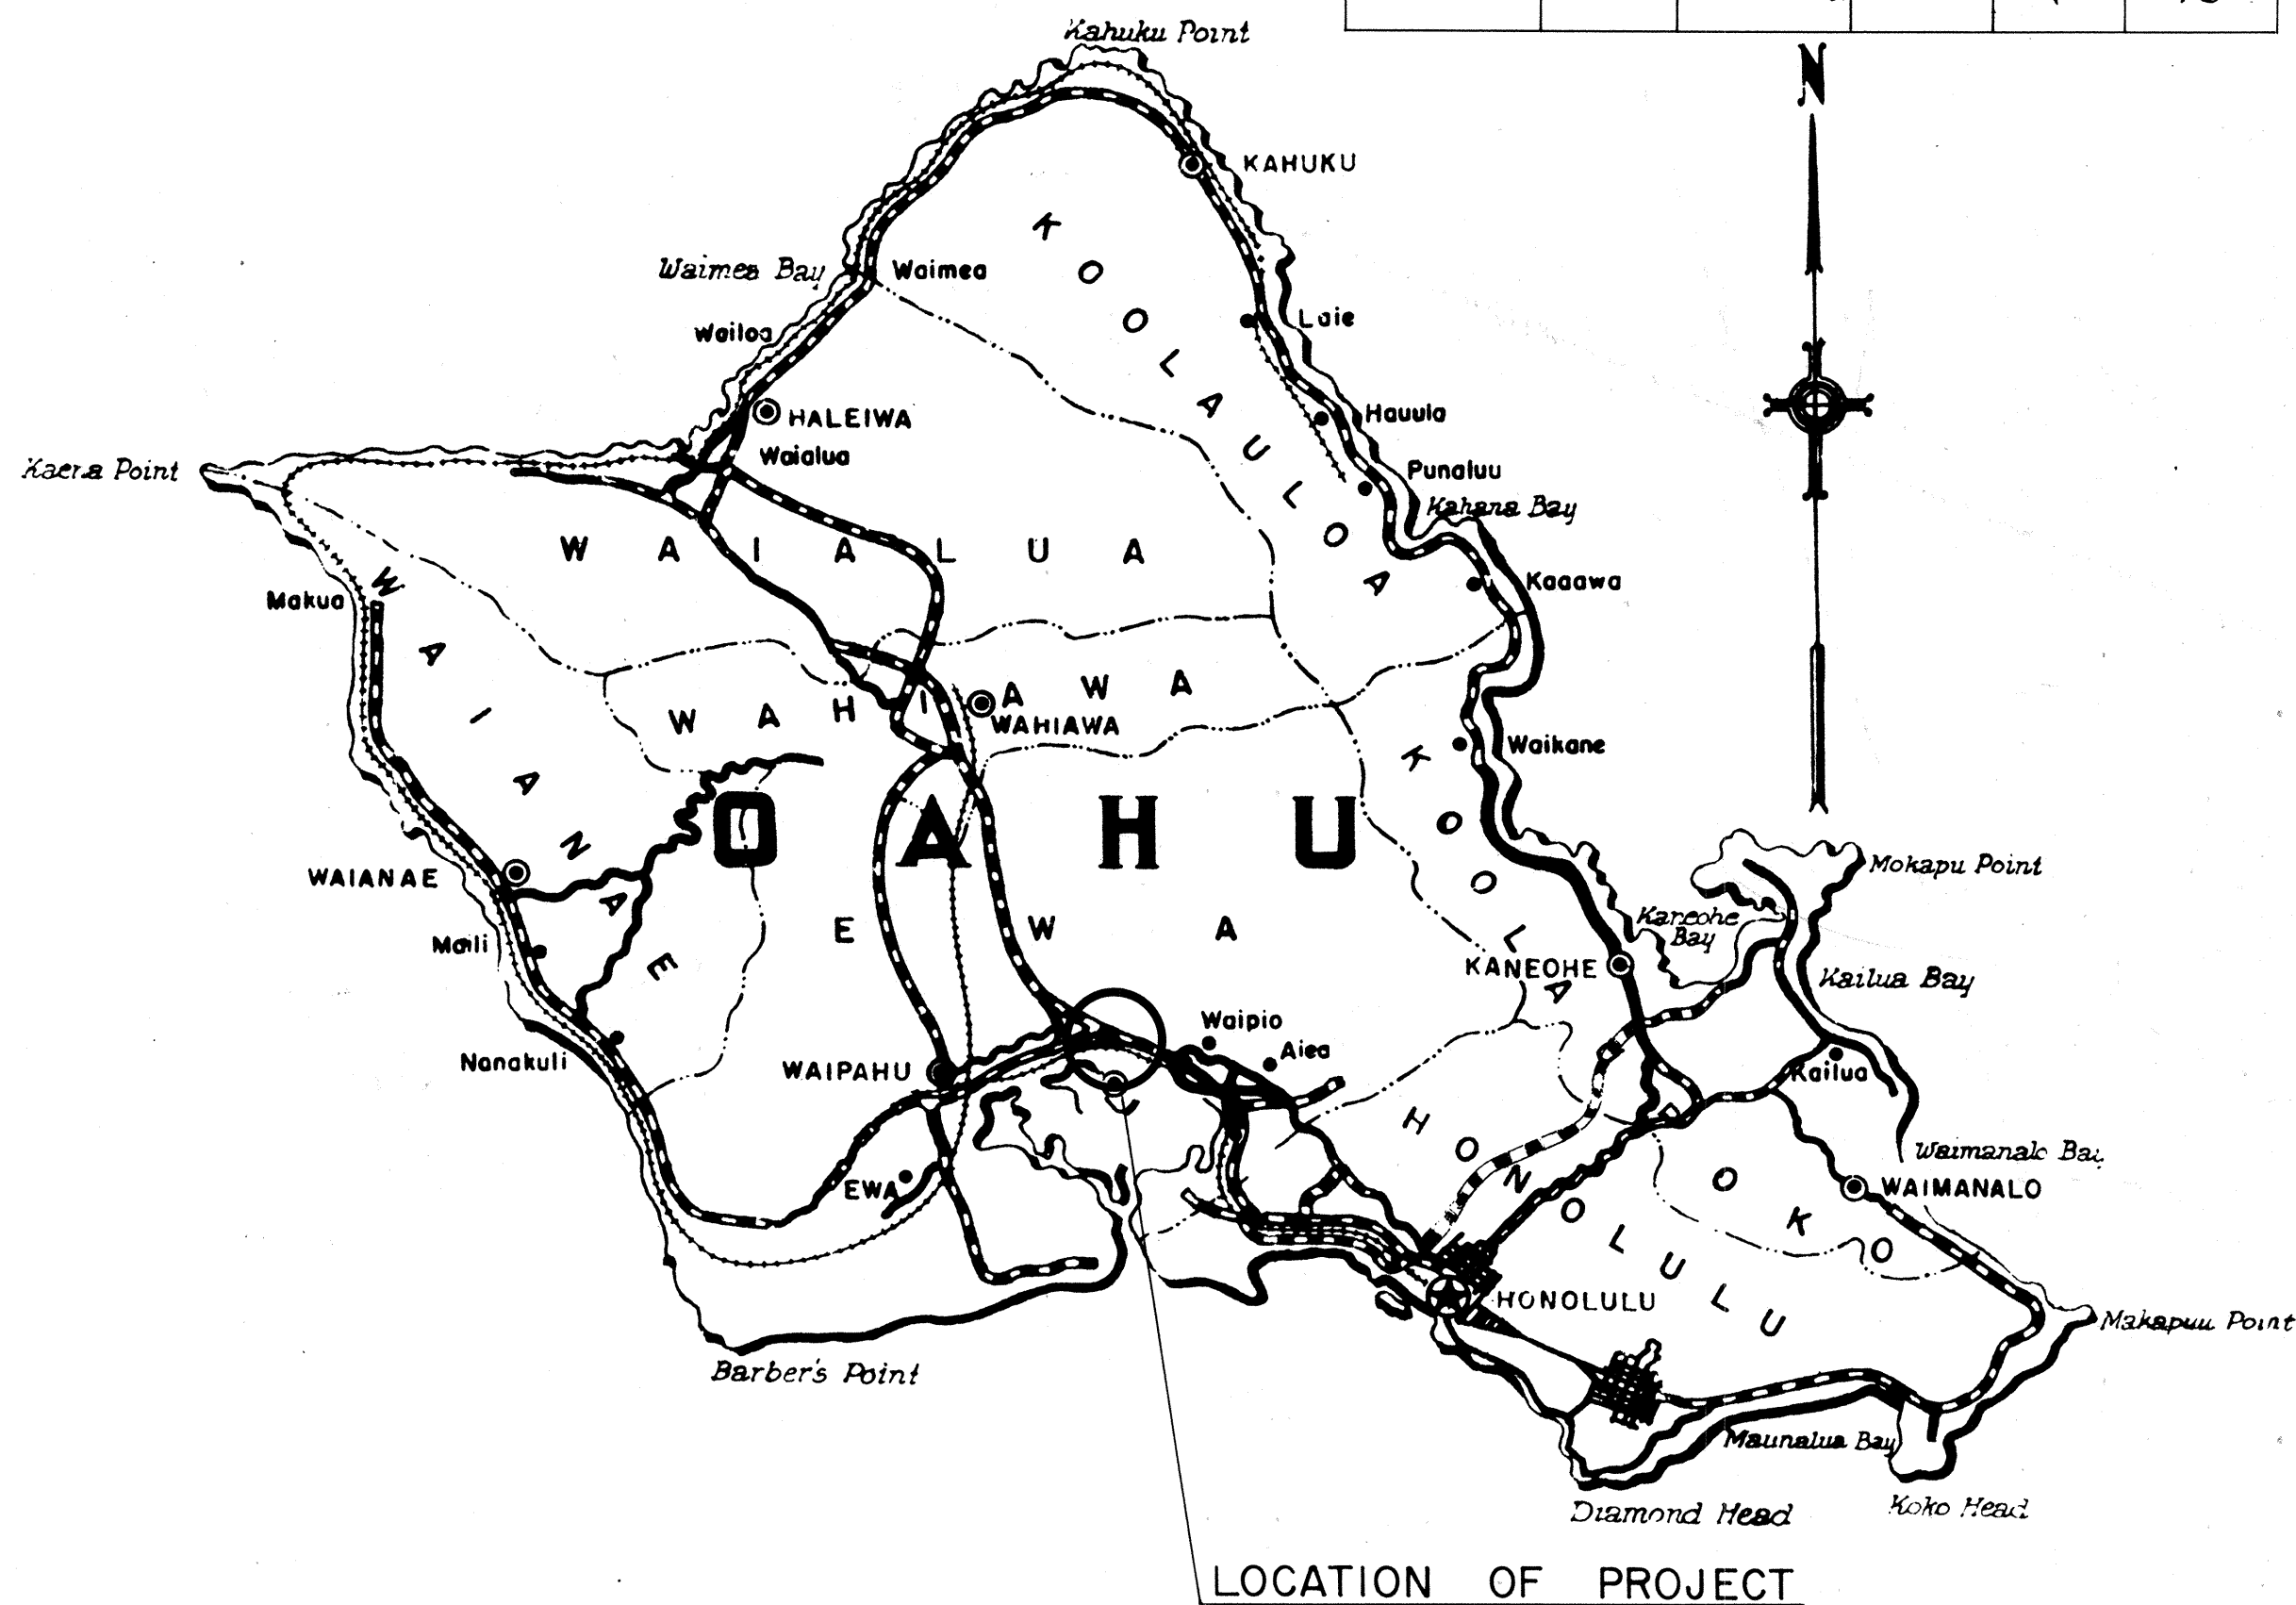

FED. ROAD DIST. NO.	STATE	FED. AID PROJ. NO.	FISCAL YEAR	SHEET NO.	TOTAL SHEETS
HAWAII	HAW.	I-HI-1(43)	1967	1	43

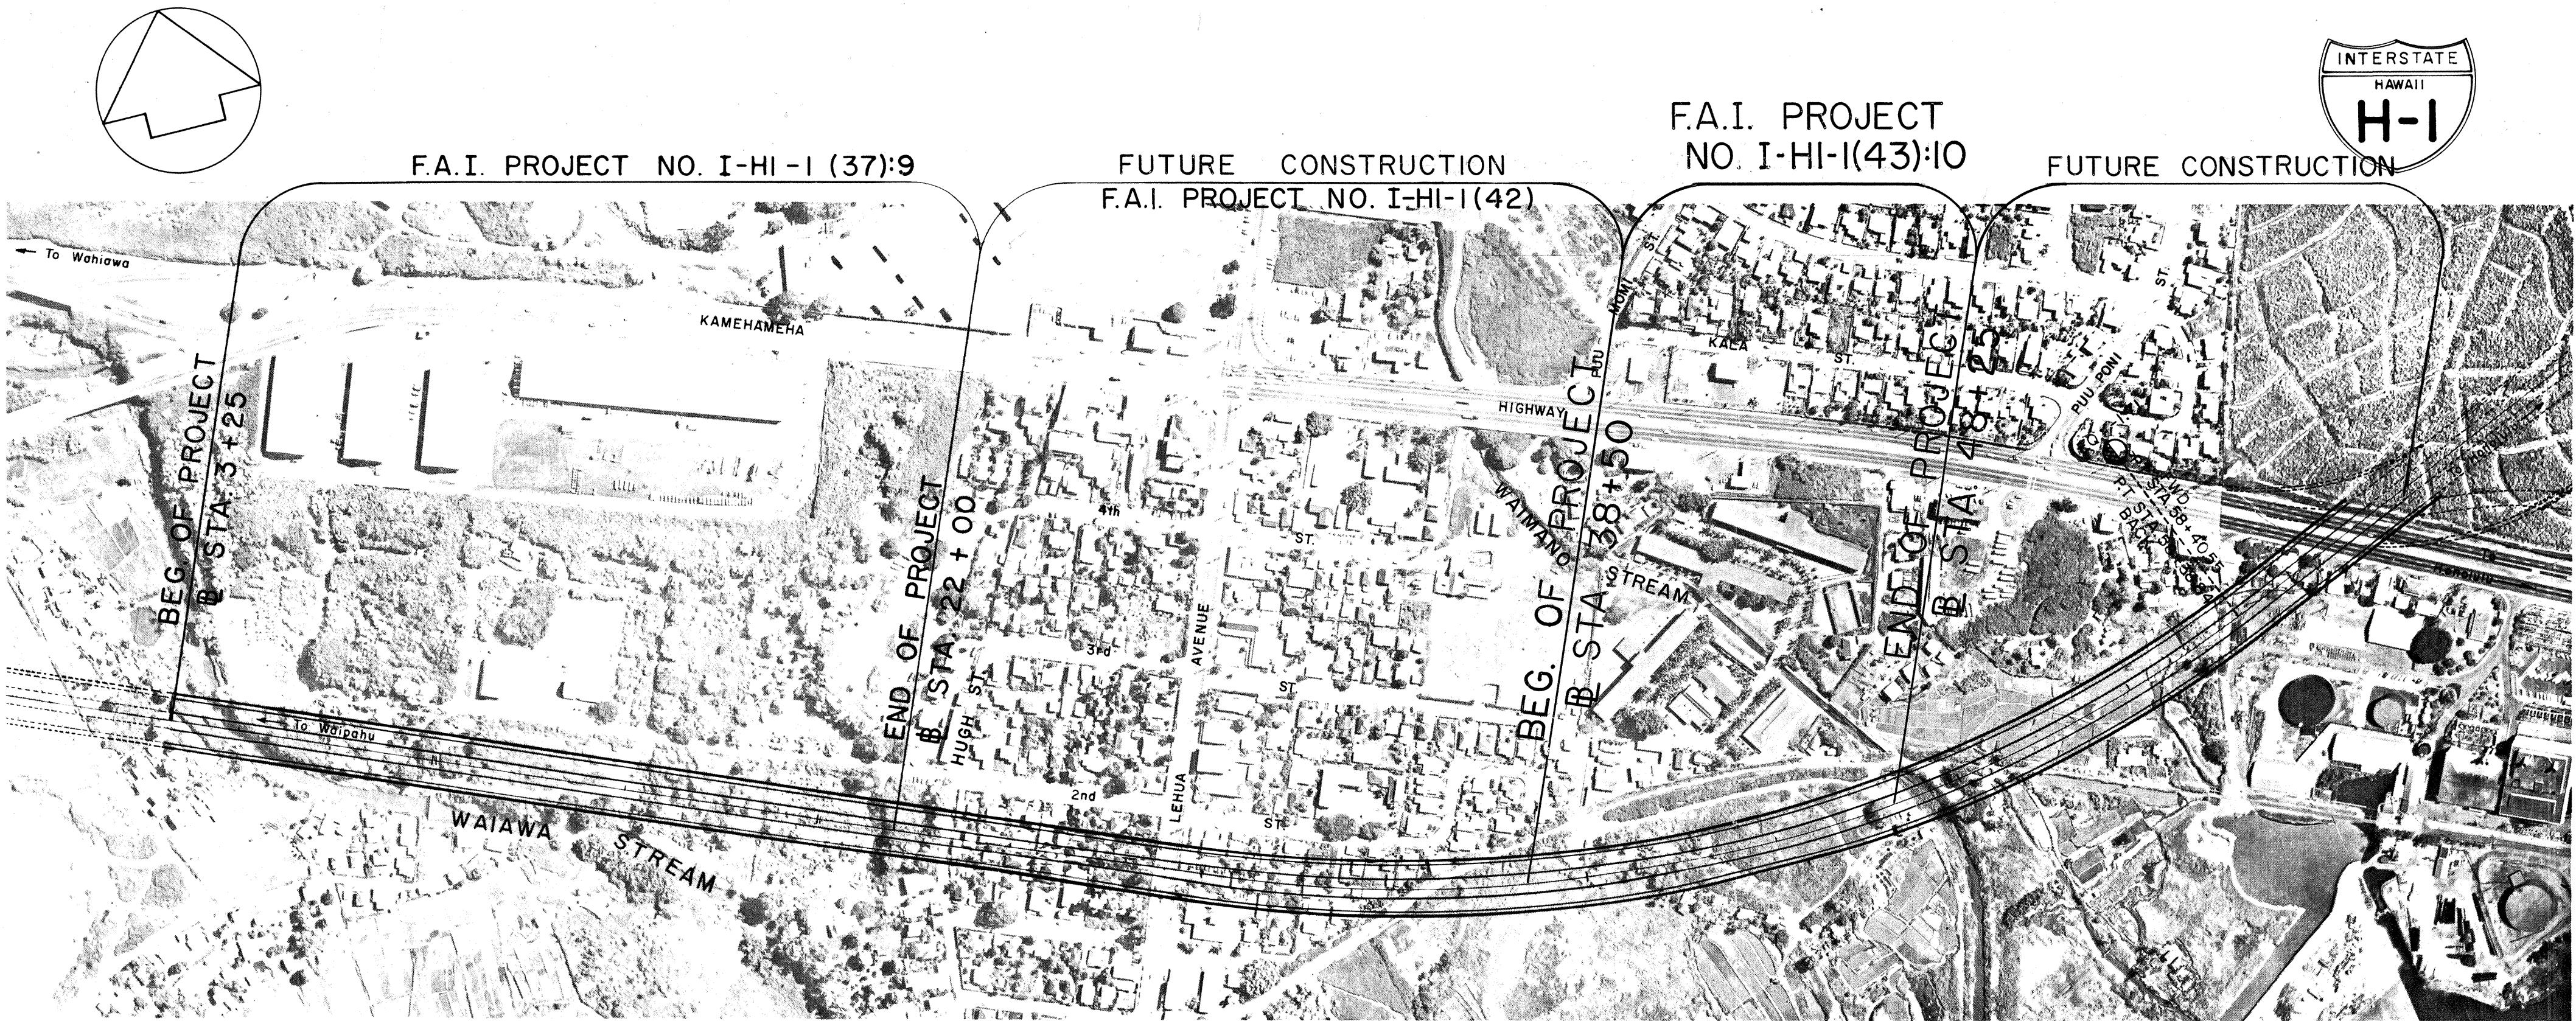

Federal Aid Projects Previously Constructed Or Under Construction

DESIGN CLASSIFICATION

ADT (1965)	0
ADT (1988)	80,900
D	65 35
DHV	10.5 %
T	4.0 %
T24	6.0 %
V	70 M.P.H.

NOTE:

ALL CHANGES MADE DURING CONSTRUCTION HAVE BEEN NOTED IN RED ON THESE TRACINGS AND CHECKED BY:

PROJECT ENGINEER

9/21/71

DATE

APPROVED: DATE

DIRECTOR OF TRANSPORTATION

DEPARTMENT OF TRANSPORTATION

BUREAU OF PUBLIC ROADS

APPROVED:

FOR DIVISION ENGINEER

10/31/67

DATE

SURVEY PLOTTED BY	DATE
DESIGNED BY	10/2/67
TRACED BY	
QUANTITIES BY	
CHECKED BY	
NO.	

LAYOUT PLAN

300 0 300 600 900

SCALE IN FEET

LENGTH OF PROJECT.....0.185 MILE

LENGTH OF STRUCTURE.....0.173 MILE