




FED. ROAD DIST. NO.	STATE	FED. AID PROJ. NO.	FISCAL YEAR	SHEET NO.	TOTAL SHEETS
HAWAII	HAW.	I-HI-1(42)	1968	43	50

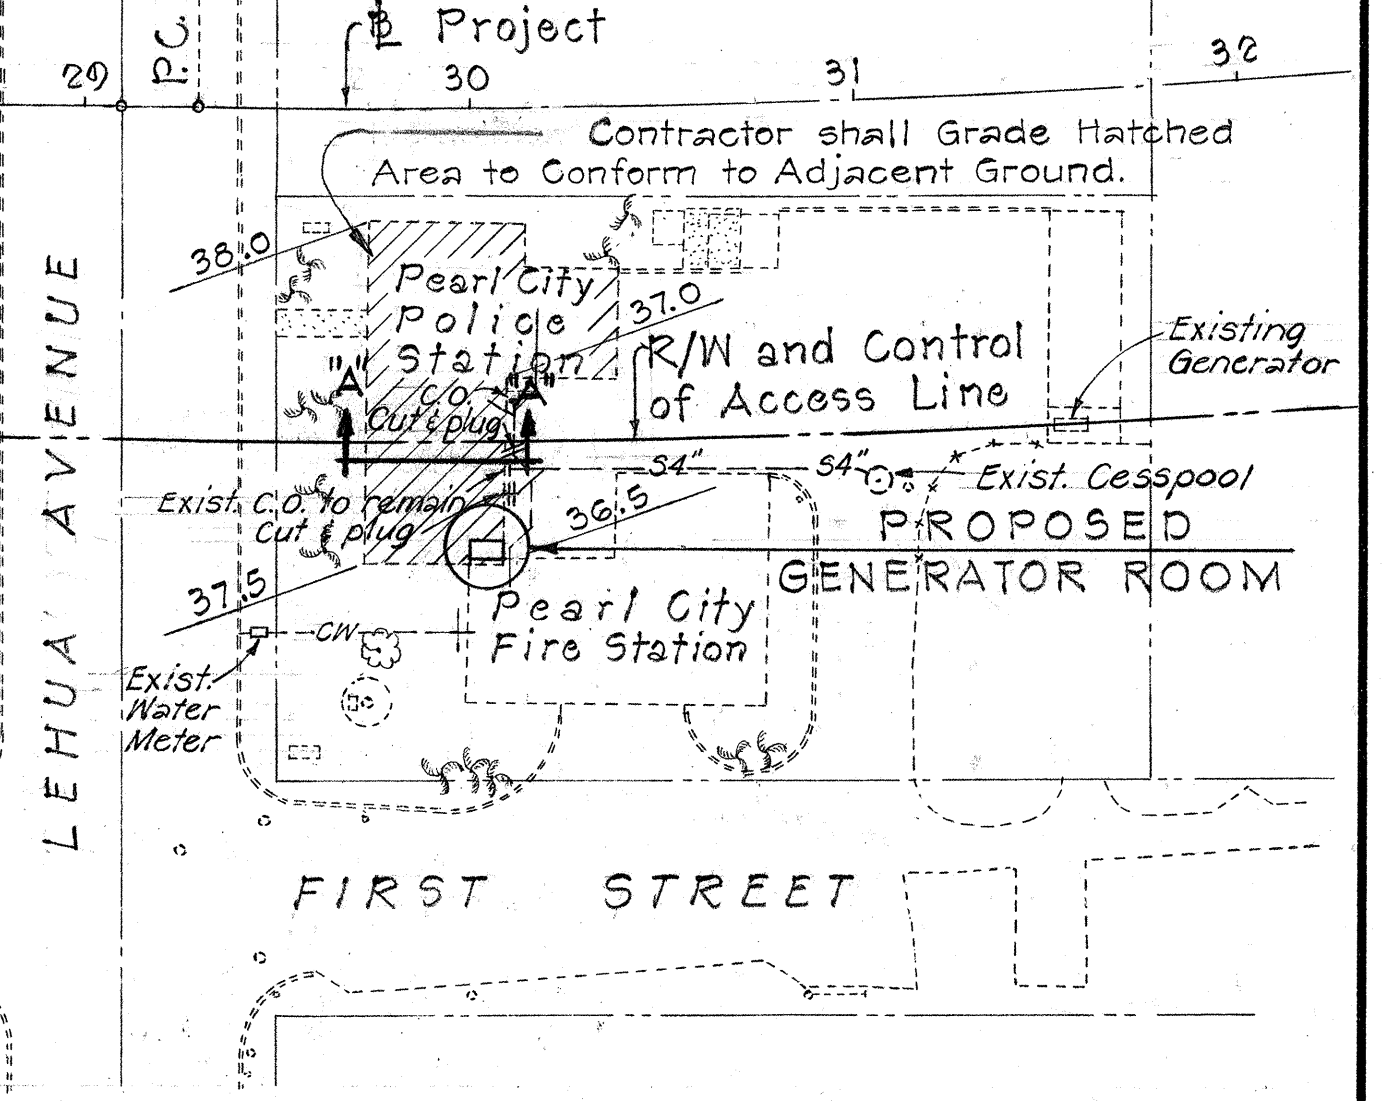


PLOT PLAN

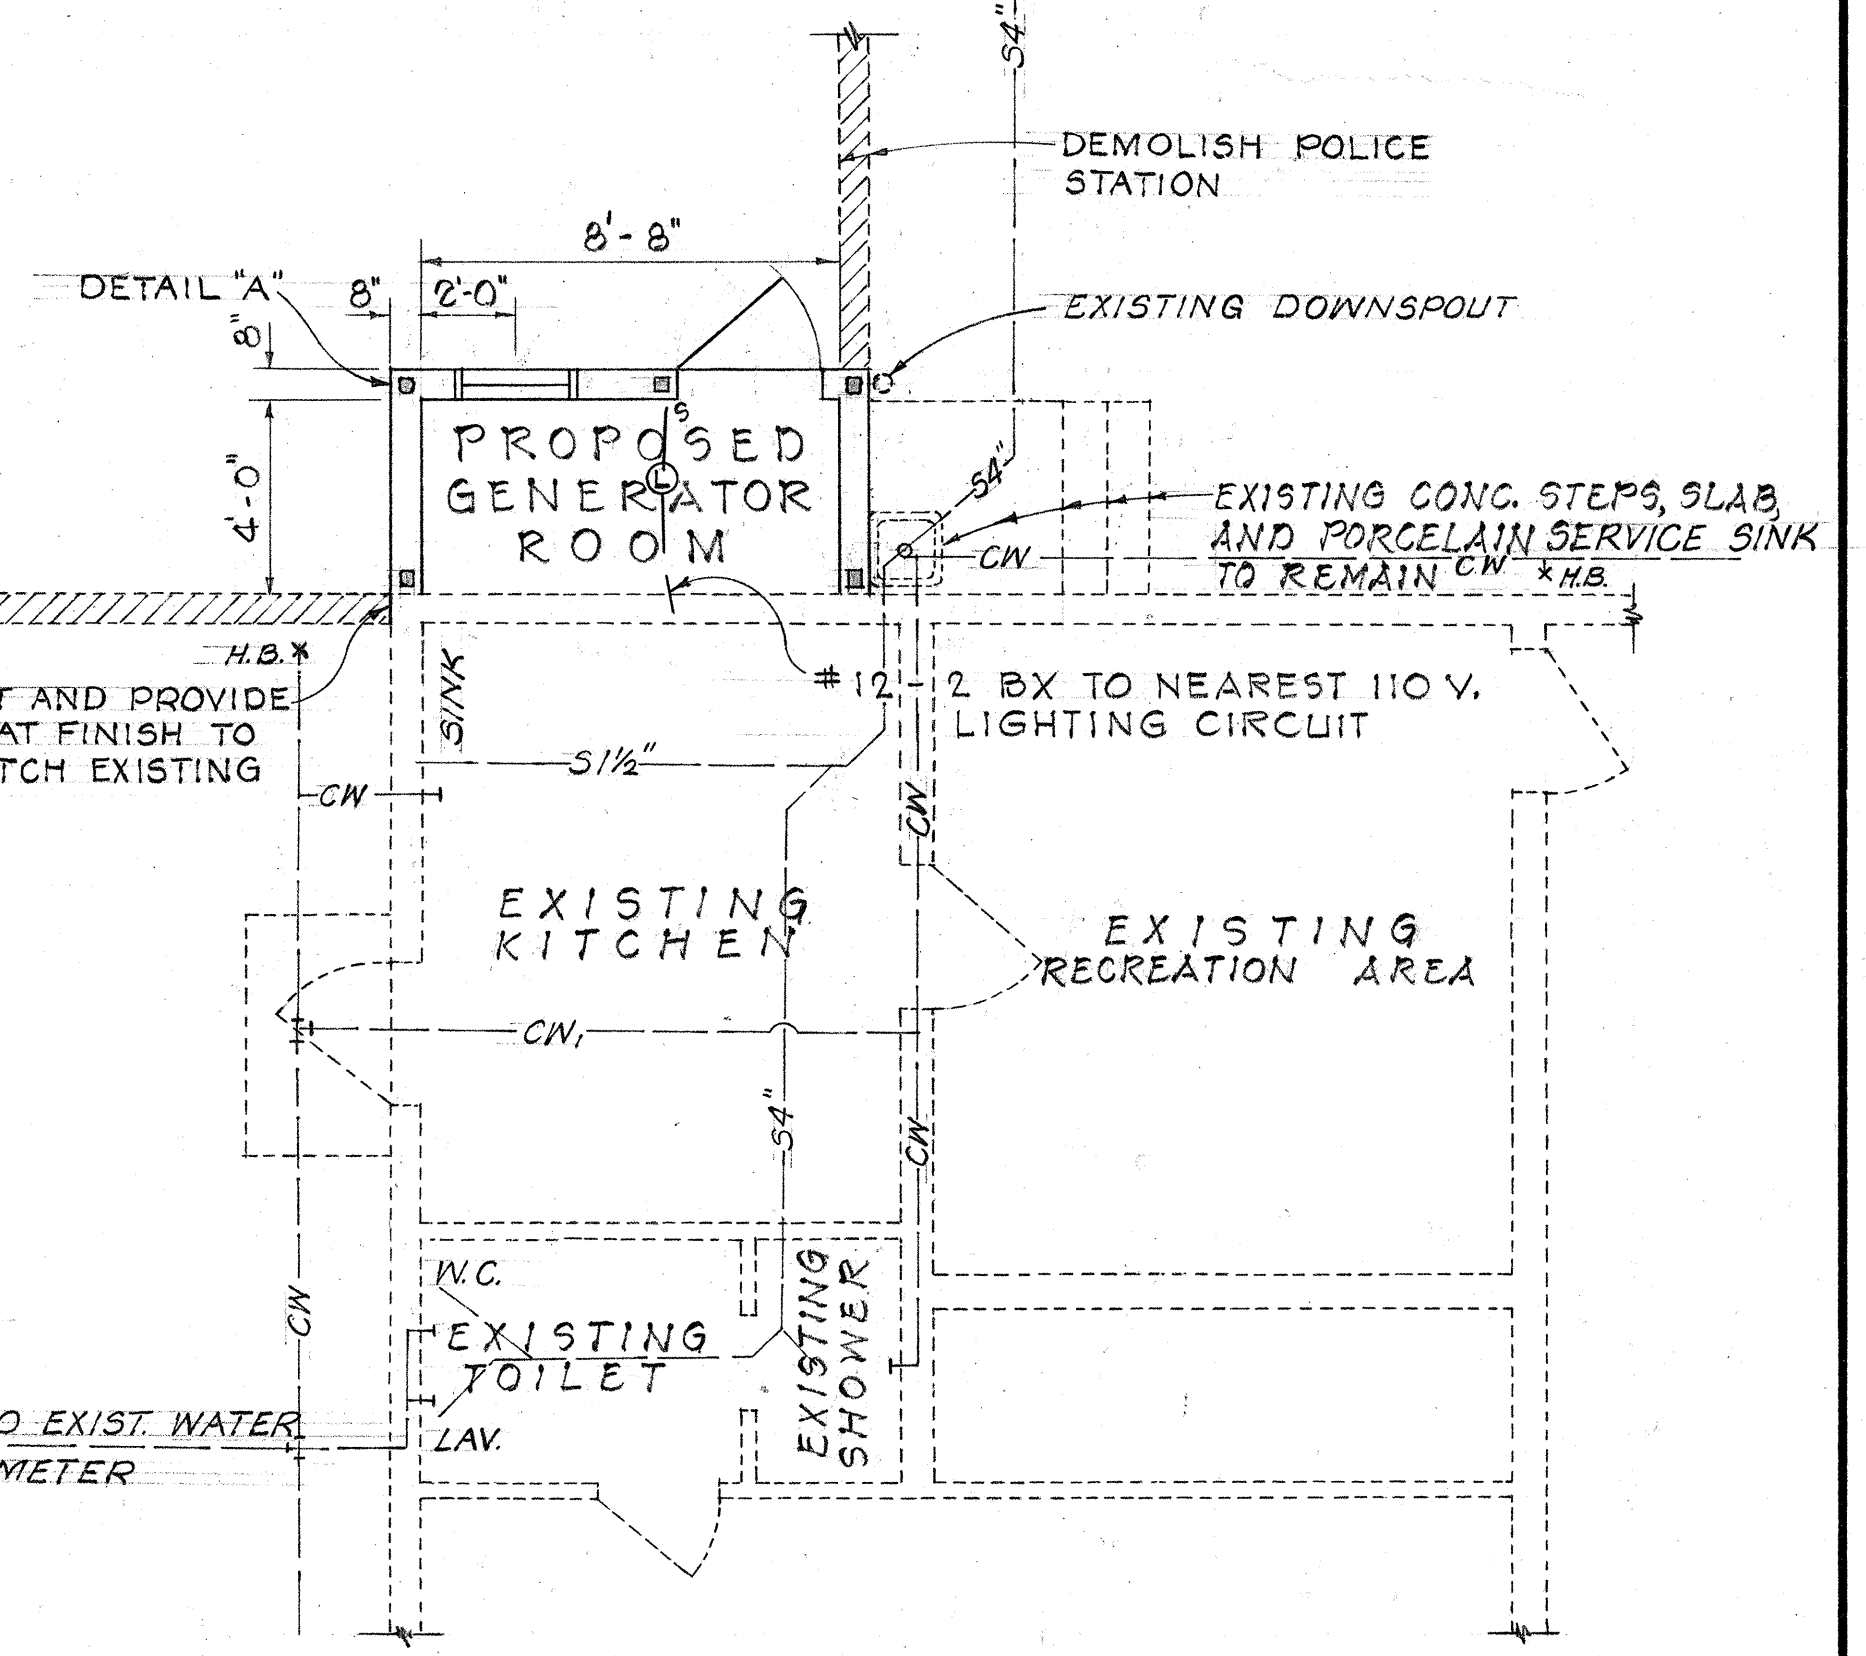


FLOOR PLAN
SCALE: 1/4" = 1'-0"

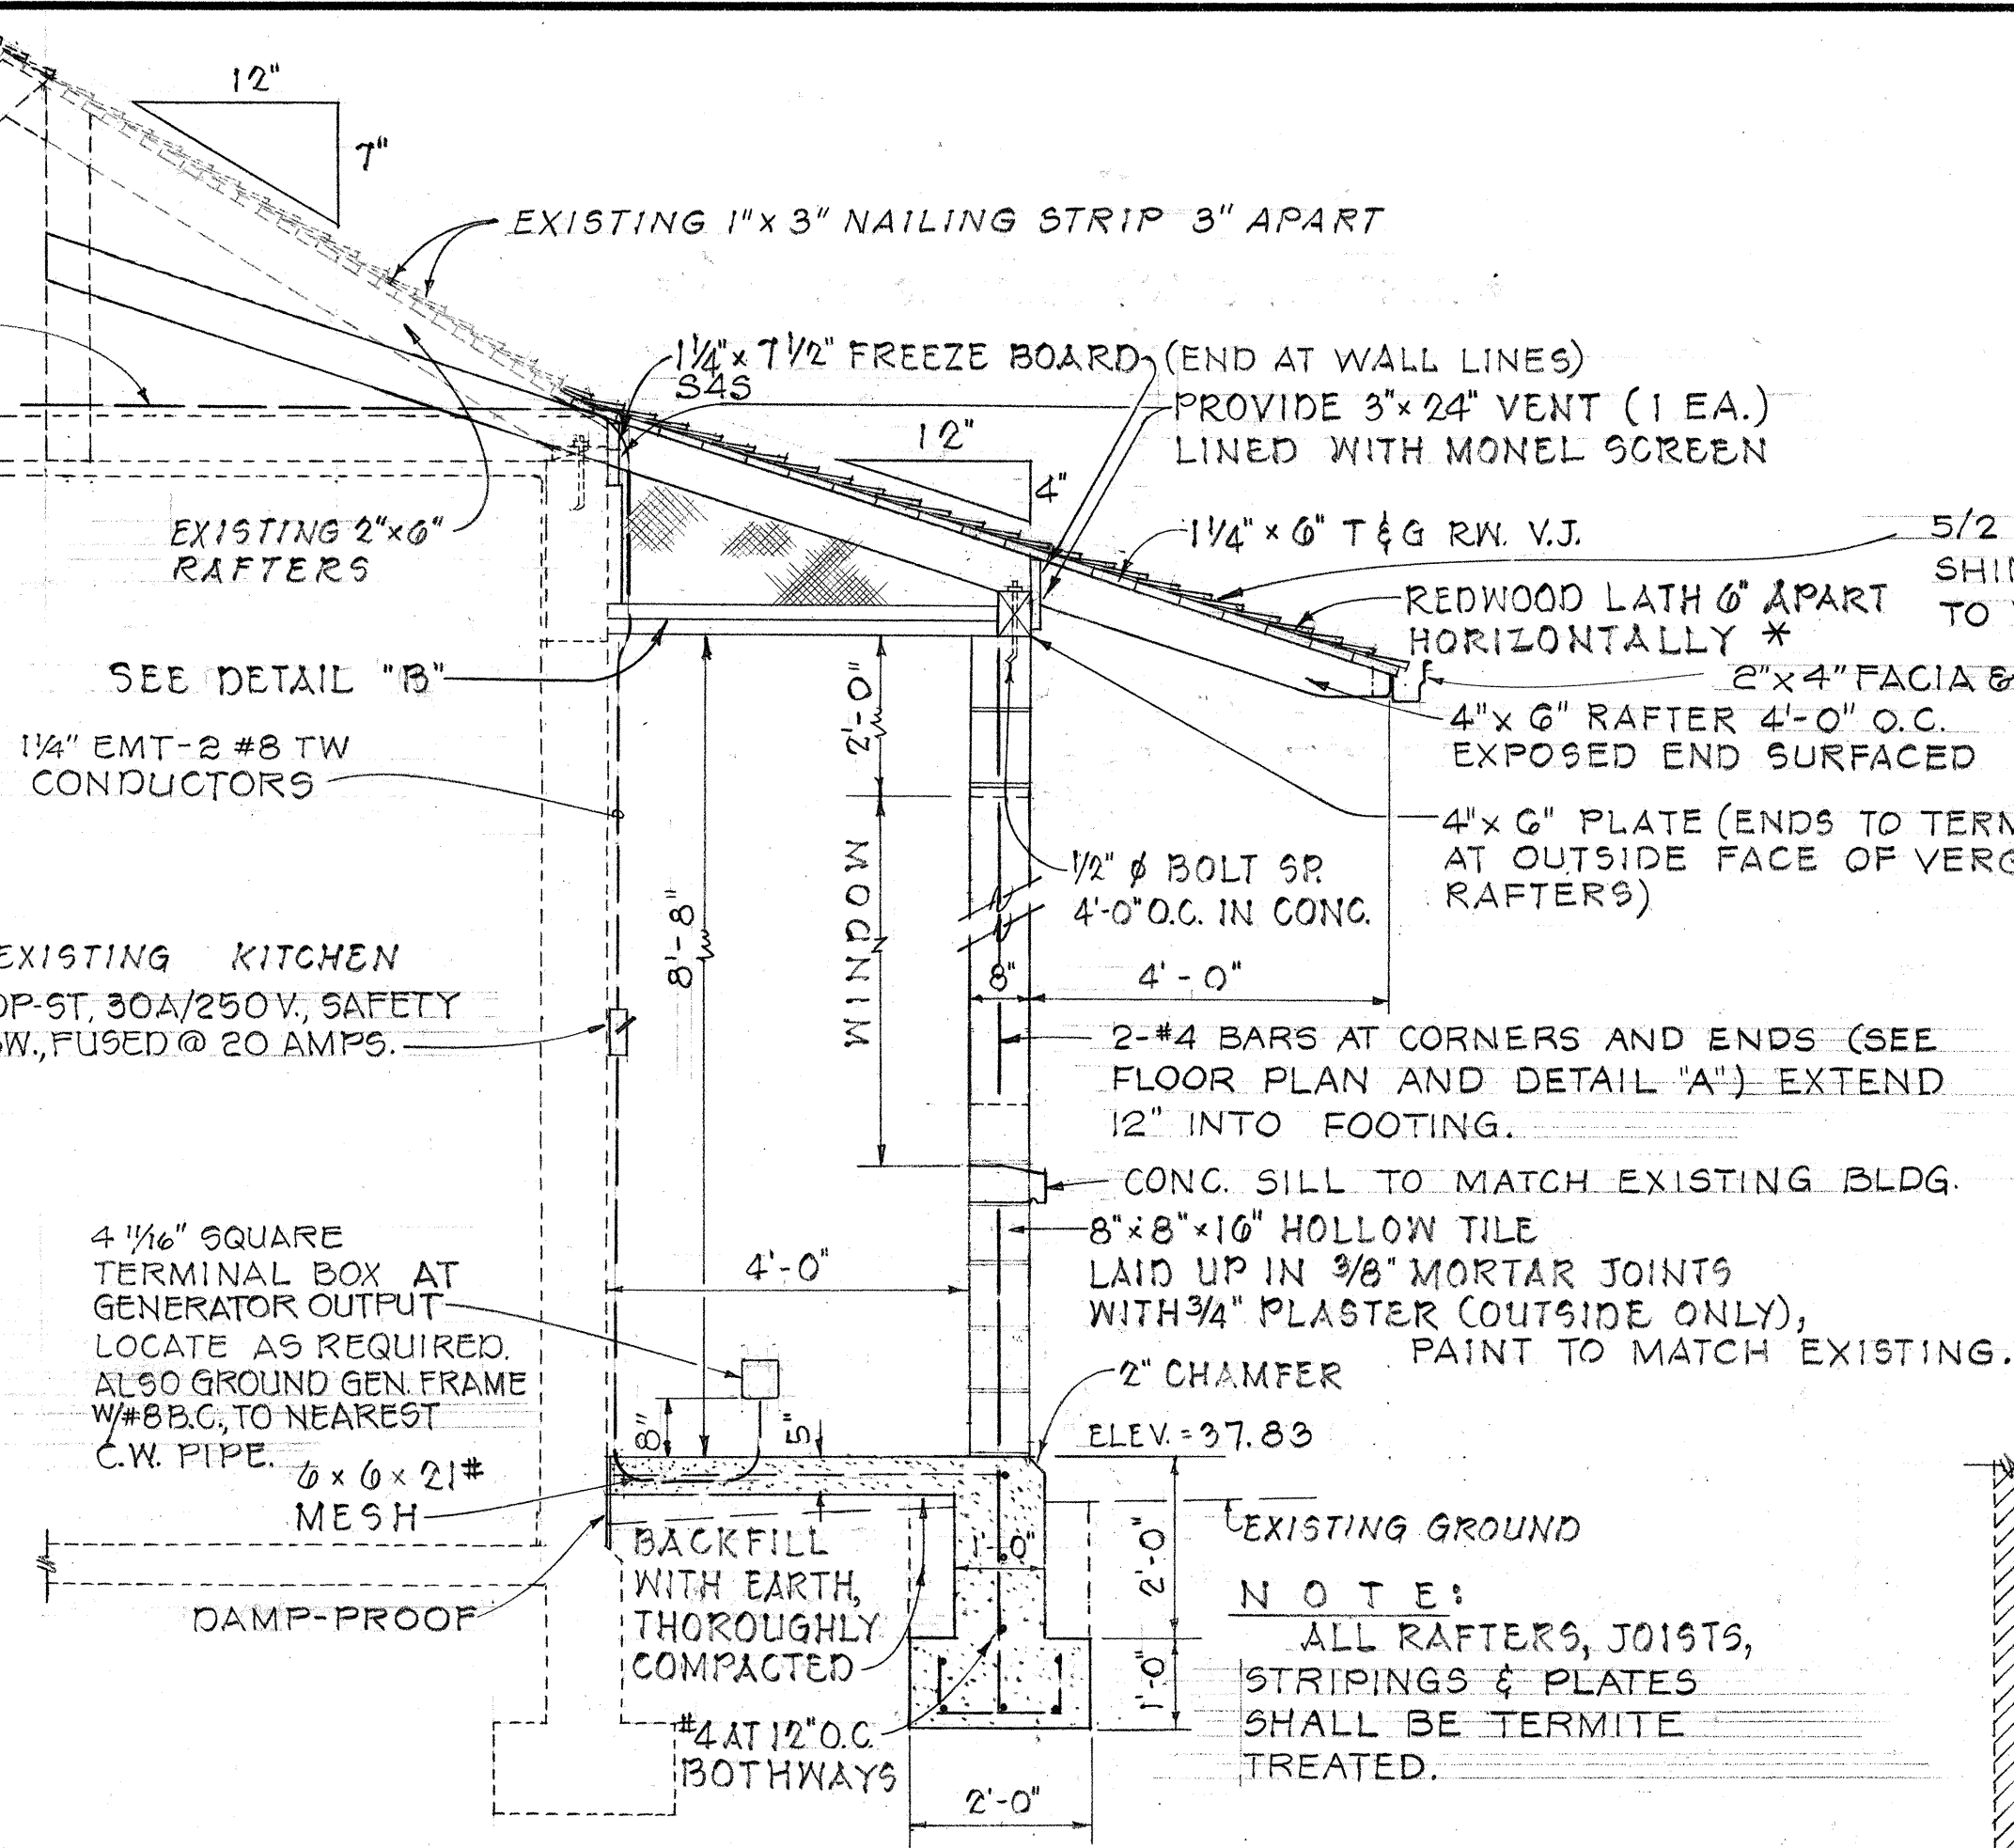


TYPICAL WALL SECTION
SCALE: 1/2" = 1'-0"

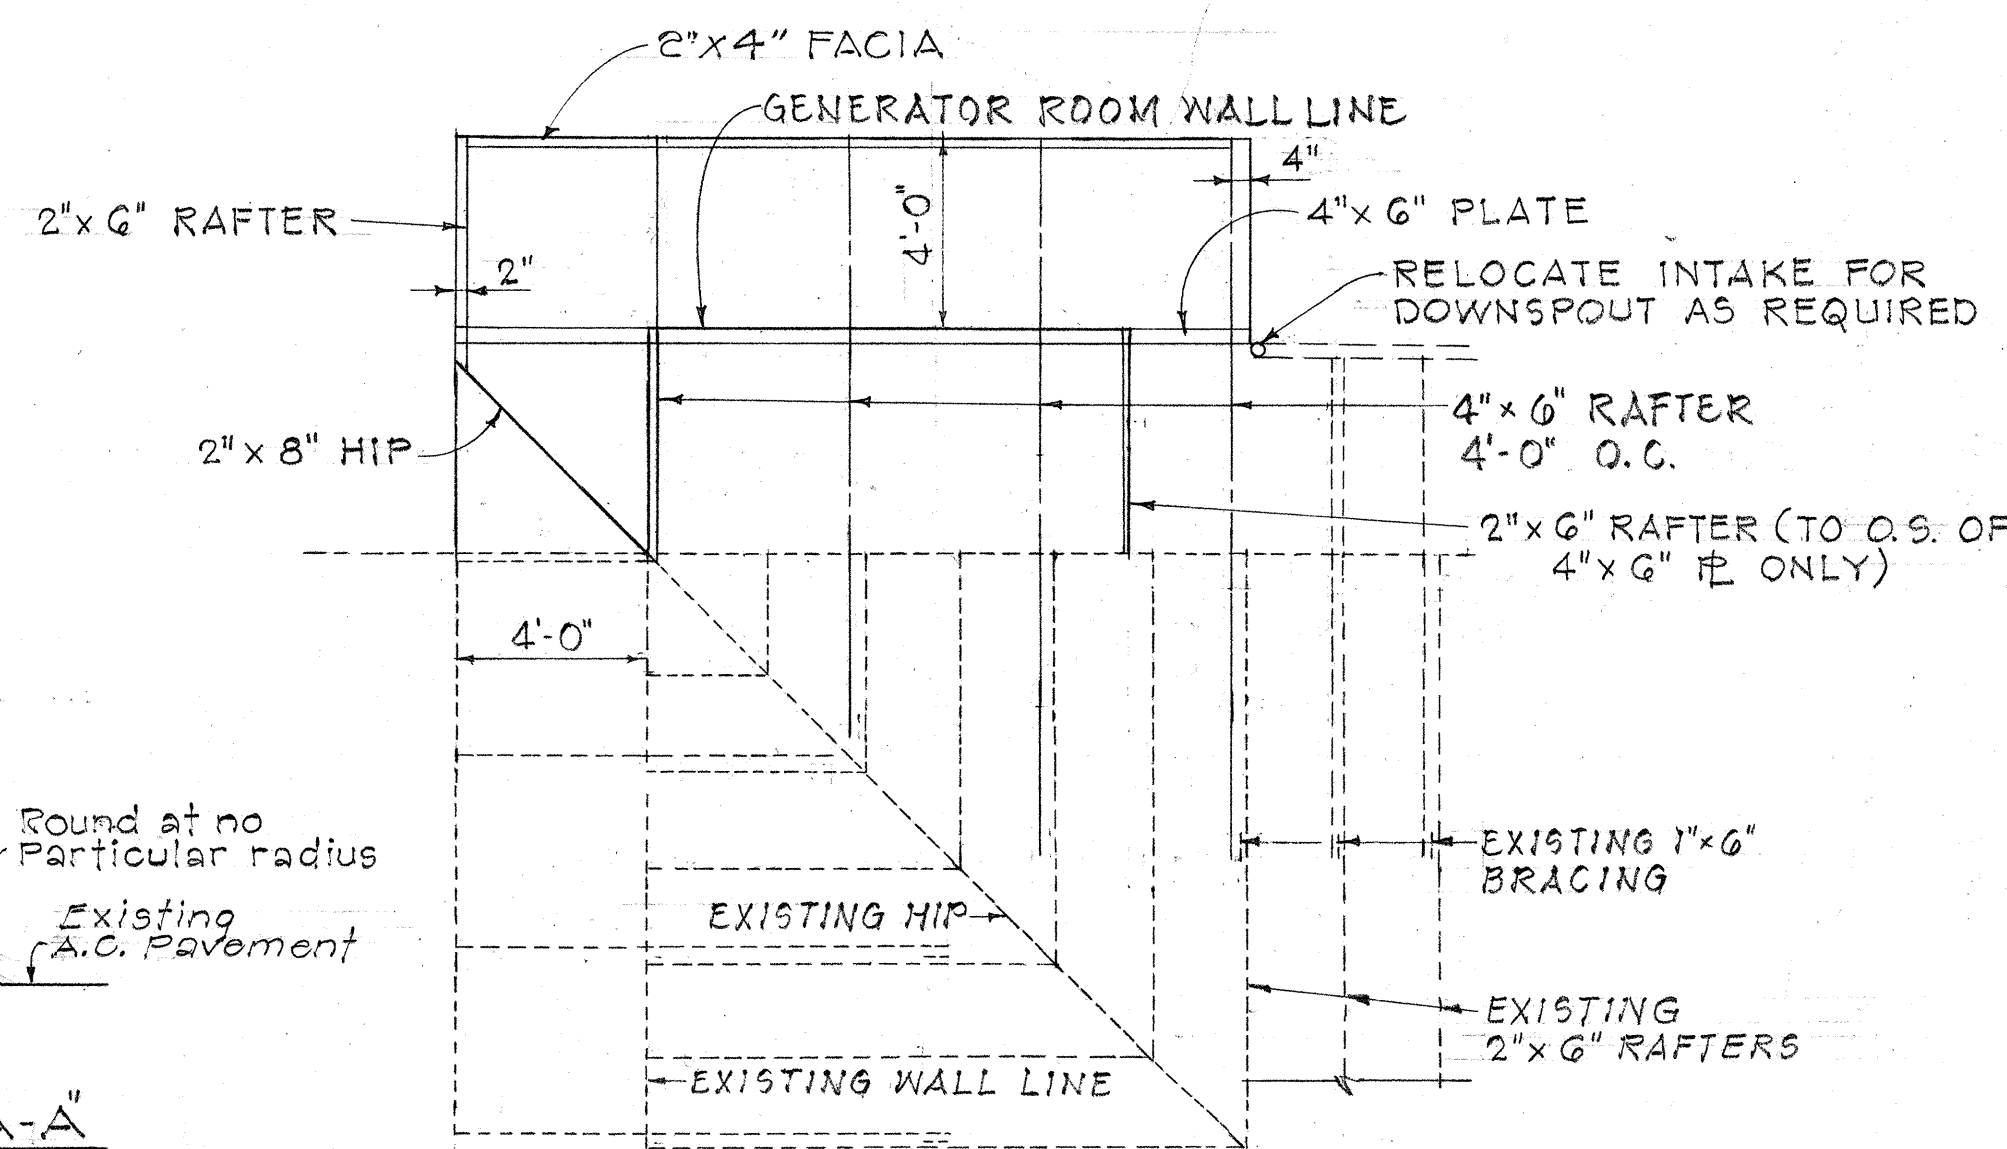


ROOF PLAN
SCALE: 1/4" = 1'-0"

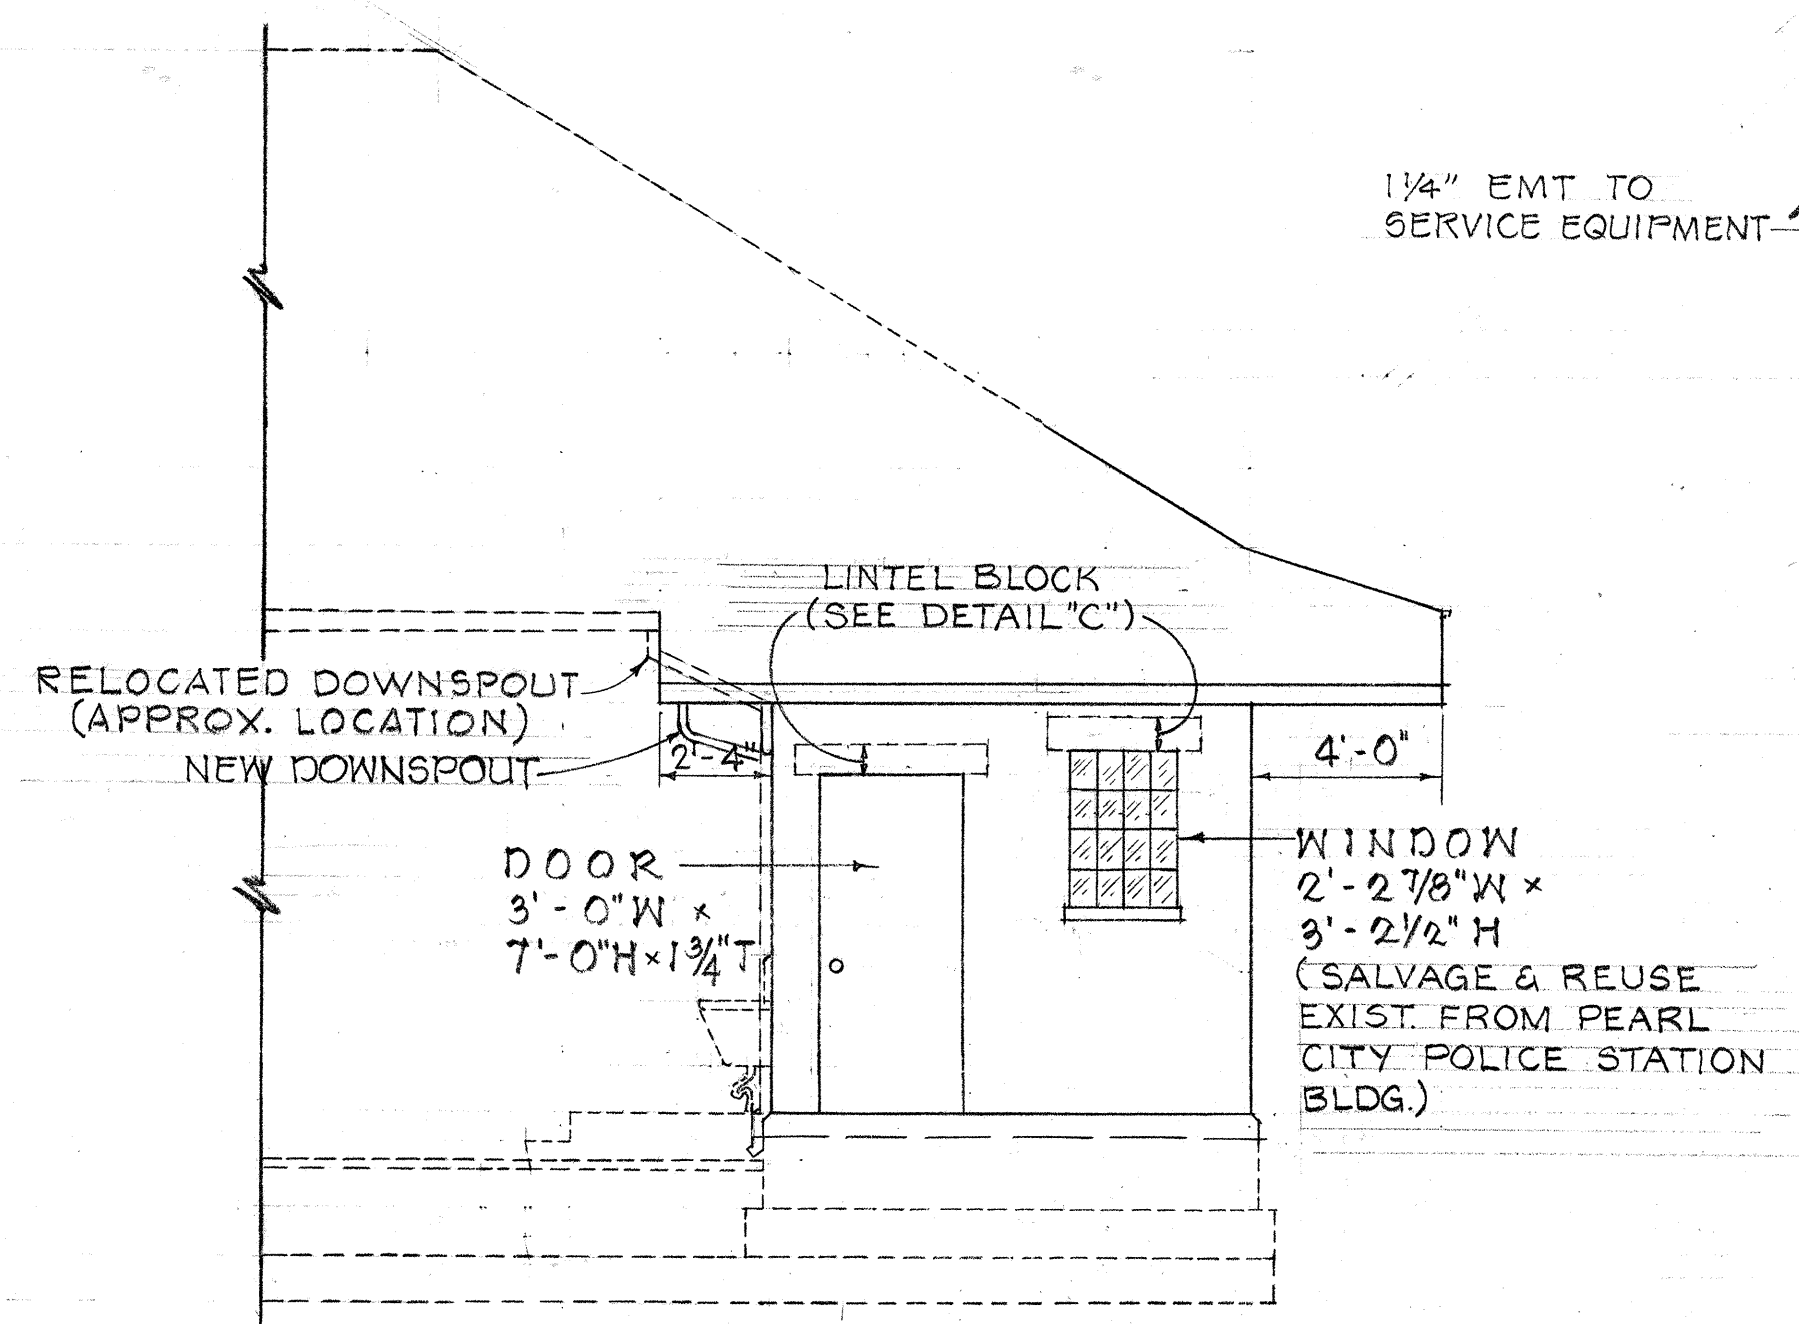


NORTH ELEVATION
SCALE: 1/4" = 1'-0"

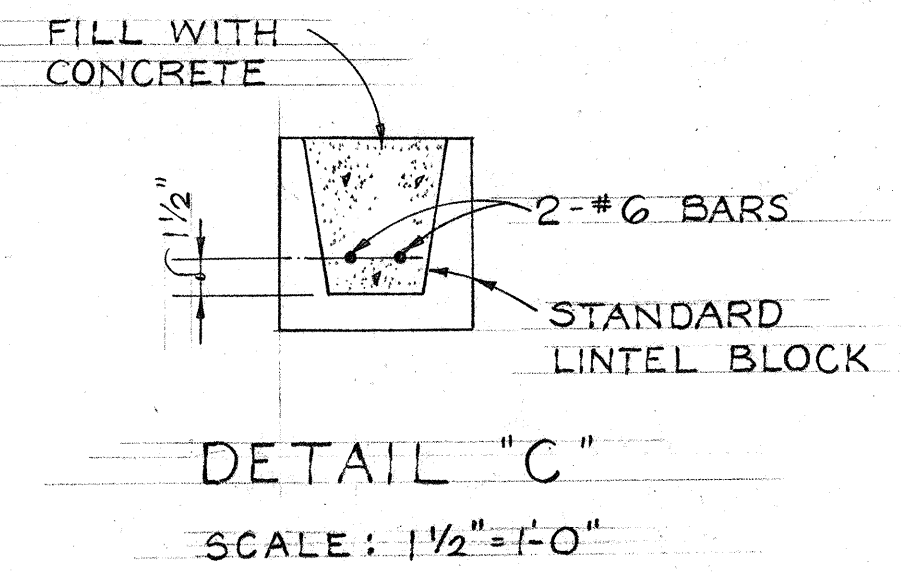


DETAIL "C"
SCALE: 1 1/2" = 1'-0"

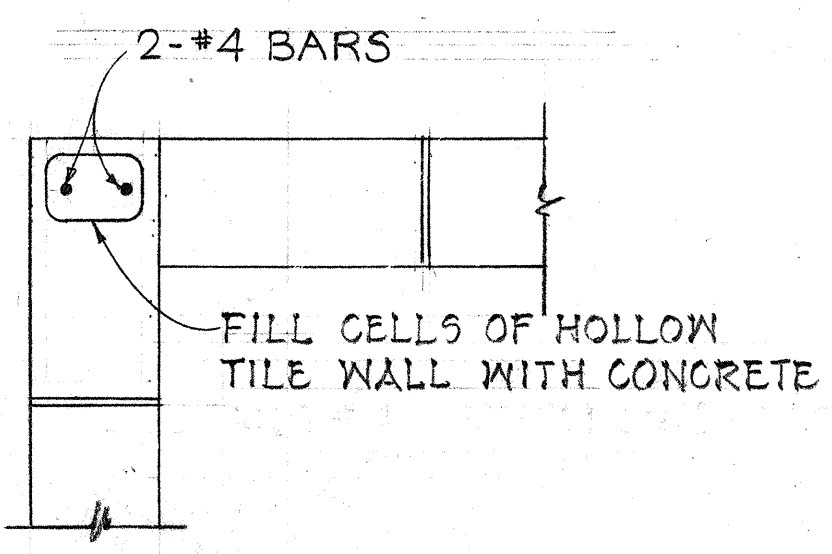

DETAIL "A"
SCALE: 1" = 1'-0"

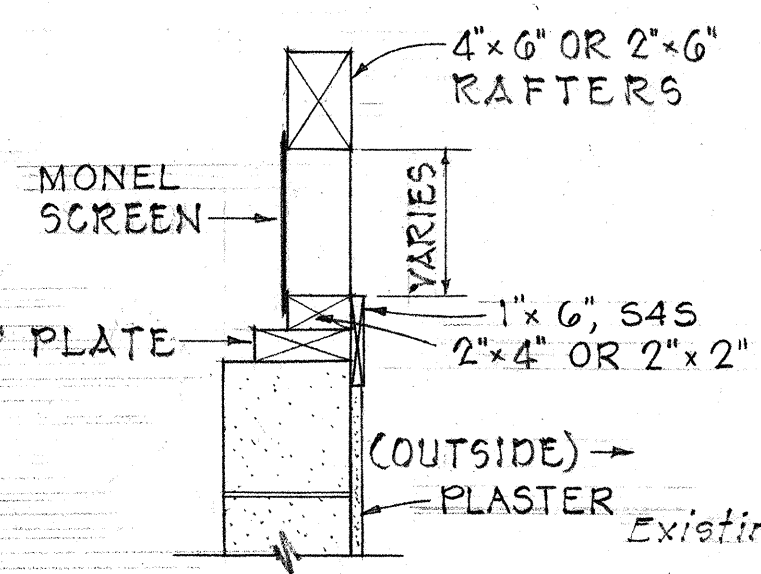

DETAIL "B"
SCALE: 1" = 1'-0"

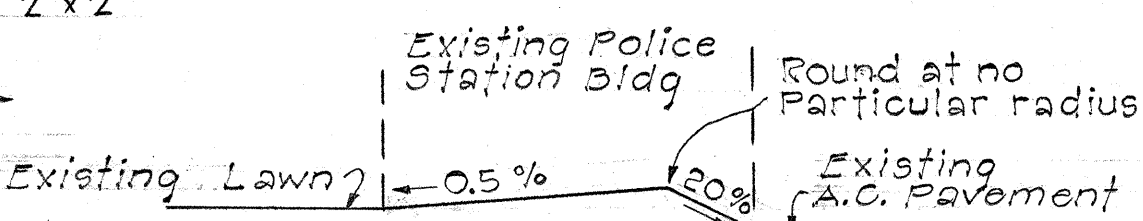

SECTION "A-A"
TYPICAL SECTION GRADING
Not to Scale
(Between Fire Station and R/W Line)

GENERAL NOTES:

1. ROOFING MATERIAL ON GENERATOR ROOM SHALL CONFORM TO ROOF ON EXISTING BUILDING.
2. CONTRACTOR SHALL CONSTRUCT BASE-RELOCATE EXISTING EMERGENCY GENERATOR & CONTROL EQUIPMENT, AND PROVIDE ELECTRICAL CONNECTION FOR GENERATOR TO CONFORM TO EXISTING SET-UP.
3. NEW GUTTER SHALL BE OF THE SAME PATTERN AND MATERIAL AS EXISTING.
4. SITE OF EXISTING POLICE STATION SHALL BE GRADED AS SHOWN IN SECTION "A-A" AND SODDED.
5. LUMBER SHALL BE ALL NEW OF DOUGLAS FIR SELECT GRADE UNLESS OTHERWISE NOTED.
6. THE UTILITY LINES SHOWN ON THESE PLANS ARE LOCATED FROM THE BEST SOURCES AVAILABLE. HOWEVER, THEY ARE NOT GUARANTEED TO BE CORRECT. THE CONTRACTOR SHALL CHECK AND VERIFY THE EXACT LOCATION AND DEPTH OF SAME.

DATE	
DESIGNED BY	
TRACED BY	
NOTE BOOK	
QUANTITIES BY	
CHECKED BY	

STATE OF HAWAII
DEPARTMENT OF TRANSPORTATION
HIGHWAYS DIVISION
PROPOSED GENERATOR ROOM FOR PEARL CITY FIRE STATION
INTERSTATE ROUTE H-1
F.A.I. PROJ. NO. I-HI-1(42)
SCALE: AS NOTED
SHEET No. 1 OF 1 SHEETS