
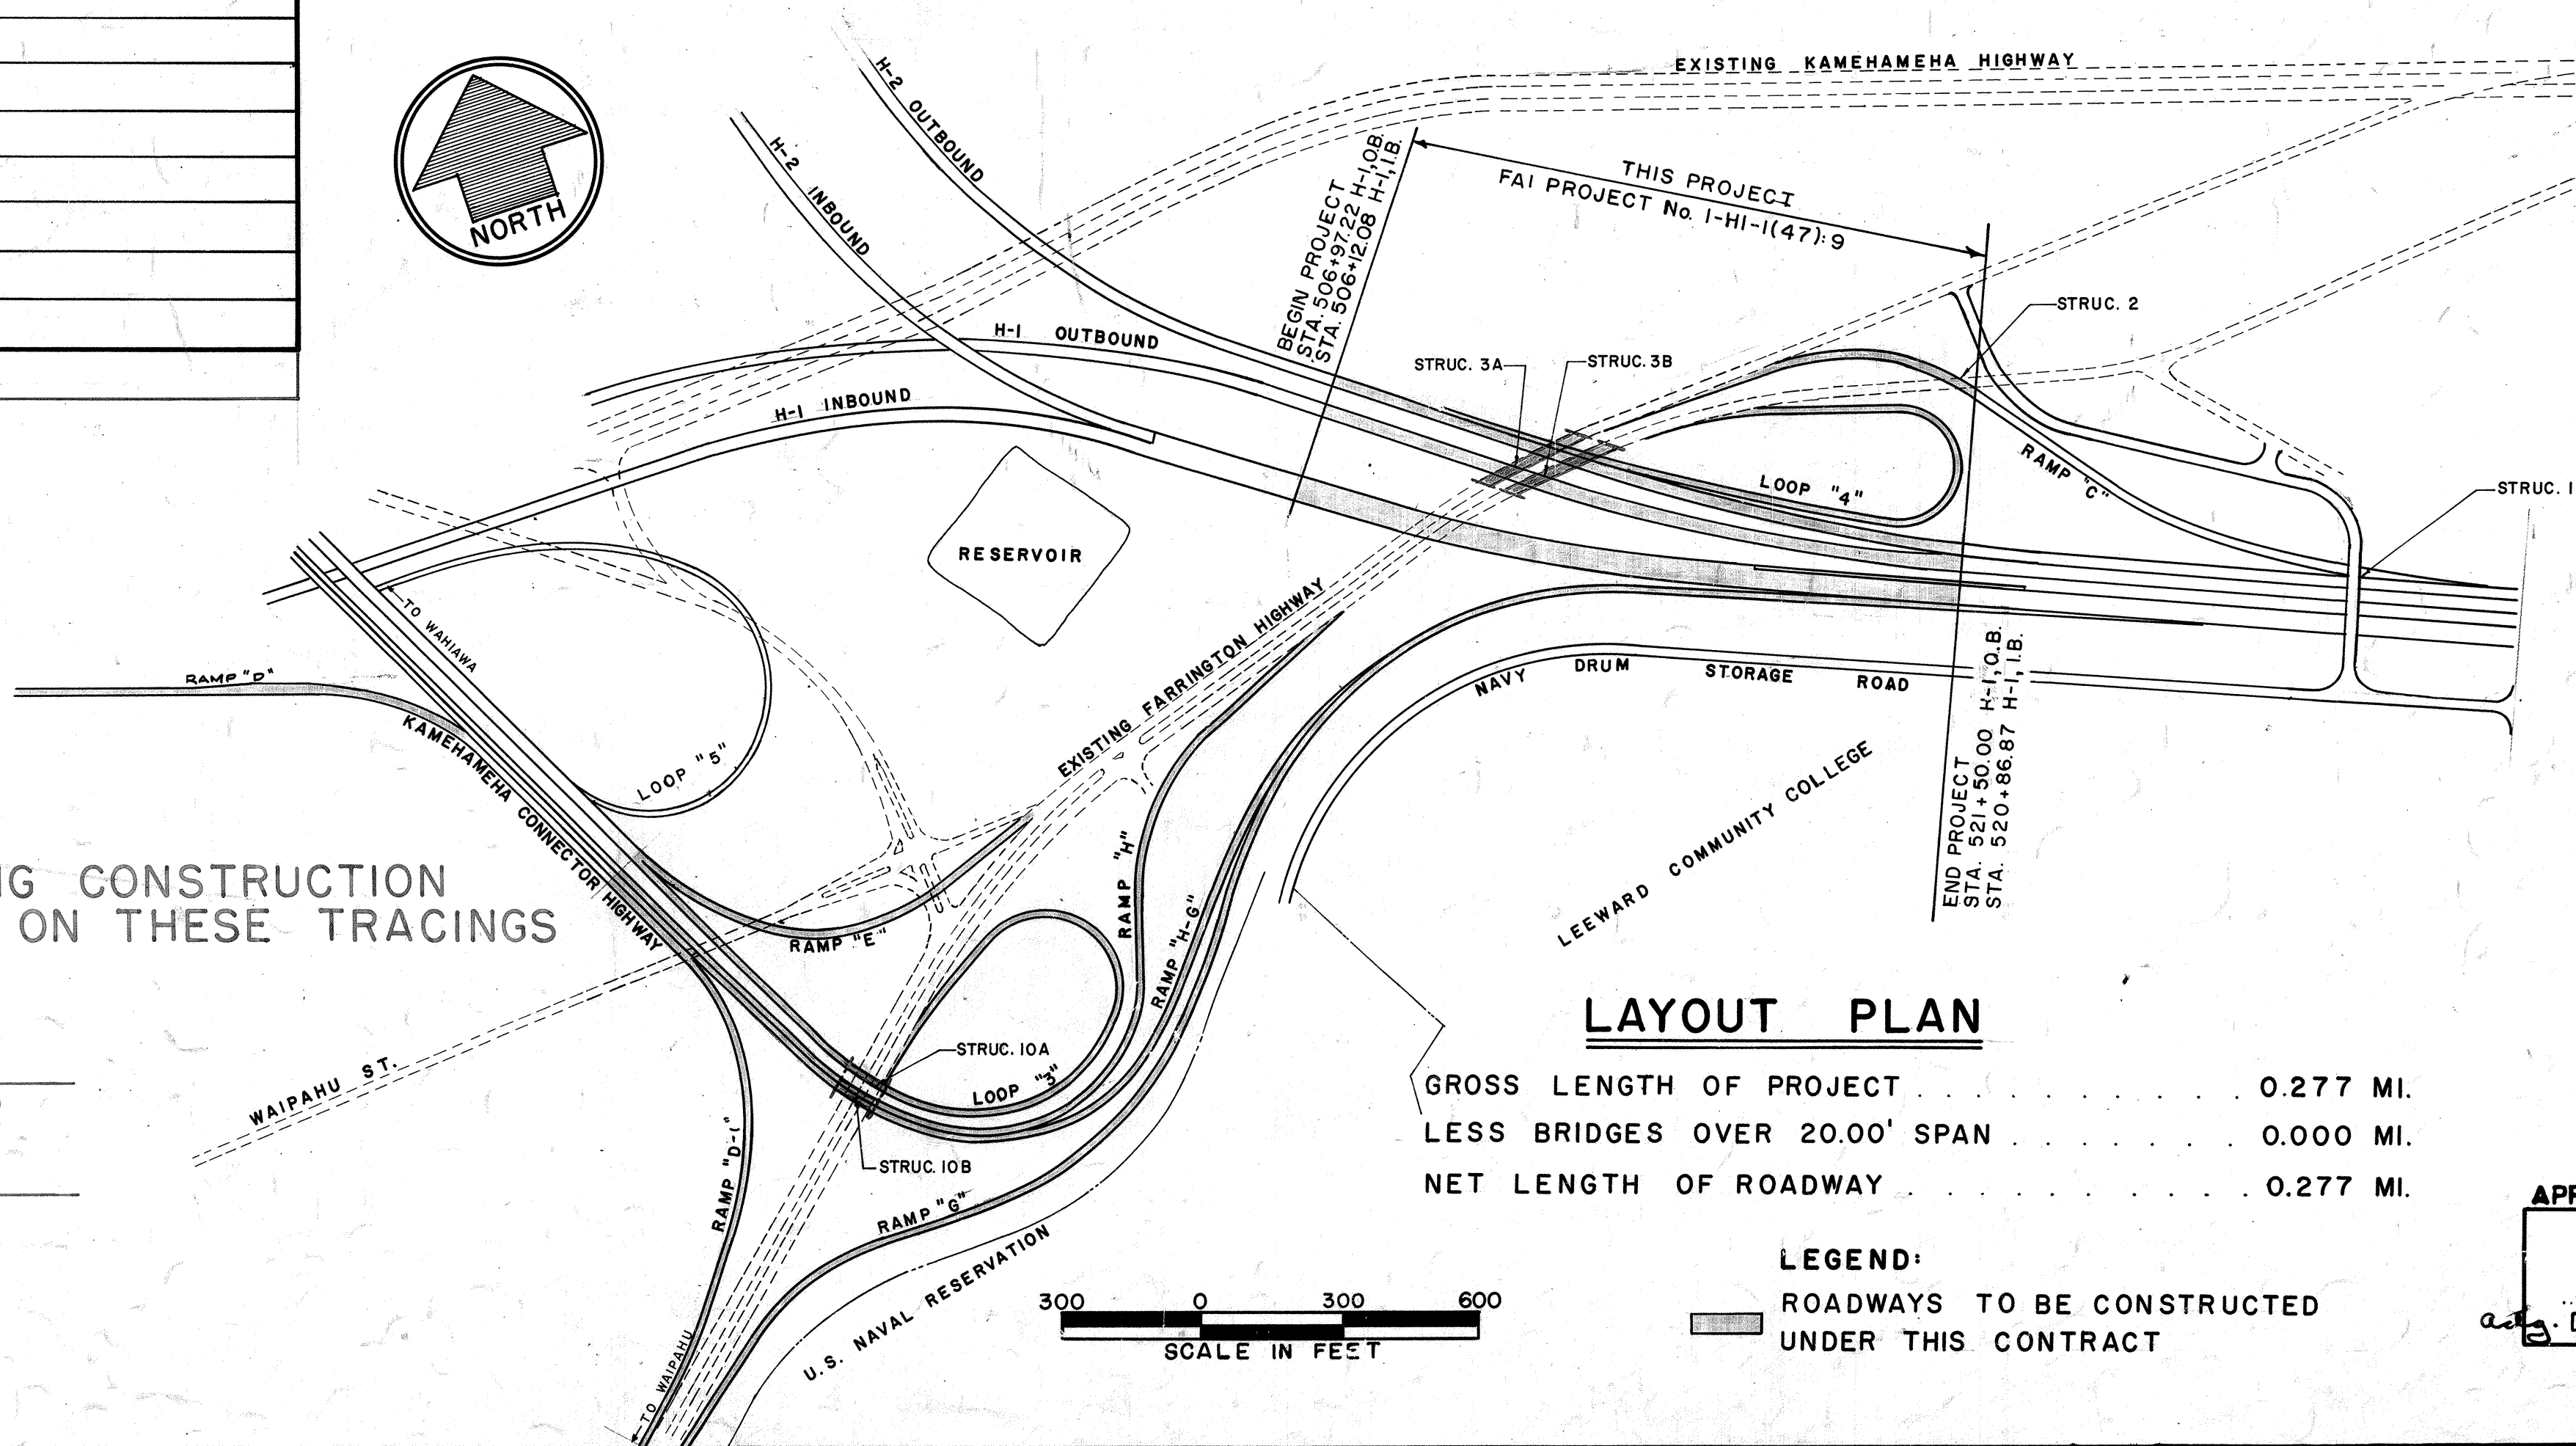


INDEX TO DRAWINGS	
SHEET NO.	DESCRIPTION
1	TITLE SHEET
2	EXIST. MON. & BORING LOCATION
3	BORING DATA
4	SUGGESTED CONSTRUCTION PHASING
5-10	TYPICAL SECTIONS
11	H-1 & H-2 I.B. & O.B. PLAN & I.B. PROFILE
12	LOOP #4 PLAN & PROFILE
13	H-1 & H-2 O.B., LOOP #4 PROFILES
14-15	RAMP "C" PLAN & PROFILE
16	FARR. HWY. PROFILE AT STRUCTURES 3A & 3B
17	INTERCHANGE PLAN - RAMP "H", "H-G", "G", "D-I", "E", LOOP #3, KAM HWY. CONNECTOR (STA. 22+00 TO 26+30)
18	RAMP "E" PLAN & PROFILE
19-21	RAMP "G" PLAN & PROFILES
22	RAMP "H" PLAN & PROFILE
23	RAMP "D-I" PROFILE
24	LOOP #3 & RAMP "H-G" PROFILES
25	KAM HWY. CONN. I.B. & O.B. (STA. 22+00 TO 26+30), RAMP "H" PROFILES
26	RAMP "D" PLAN & PROFILE
27	KAM HWY. CONN. (STA. 4+37 TO 9+42) PLAN & PROFILE & RETAINING WALL PROFILE
28	ROAD "C" (SUBSTATION)
29-39	GRADING & DRAINAGE-PLAN, PROFILES, DETAILS & SUMMARY
40-44	AVIATION GAS LINES- PLAN, PROFILES & DETAILS
45-47	TRAFFIC DETOURS
48-51	SIGNING & PAV'T. MARKING PLANS
52-58	EXPRESSWAY SIGNS & DETAILS
STRUCTURE PLANS	
59-86	STRUCTURE 3A & 3B
87-102	STRUCTURE 10A & 10B
103-109	STANDARD BRIDGE DETAILS
110-111	LIGHTING SUBSTATION
112-146	ELECTRICAL PLANS
147	CROSS SECTION INDEX
148-196	ROAD CROSS SECTIONS
197-199	DISPOSAL SITE & CROSS SECTIONS
200-227	MISCELLANEOUS DETAILS
228-238	MISCELLANEOUS DETAILS

STATE OF HAWAII
DEPARTMENT OF TRANSPORTATION
HIGHWAYS DIVISION
HONOLULU, HAWAII
"AS BUILT"
PLANS FOR
CONSTRUCTION OF A PORTION OF
INTERSTATE ROUTE H-1
WAIAWA INTERCHANGE

FEDERAL AID INTERSTATE PROJECT No. I-HI-1(47):9
DISTRICT OF EWA
ISLAND OF OAHU

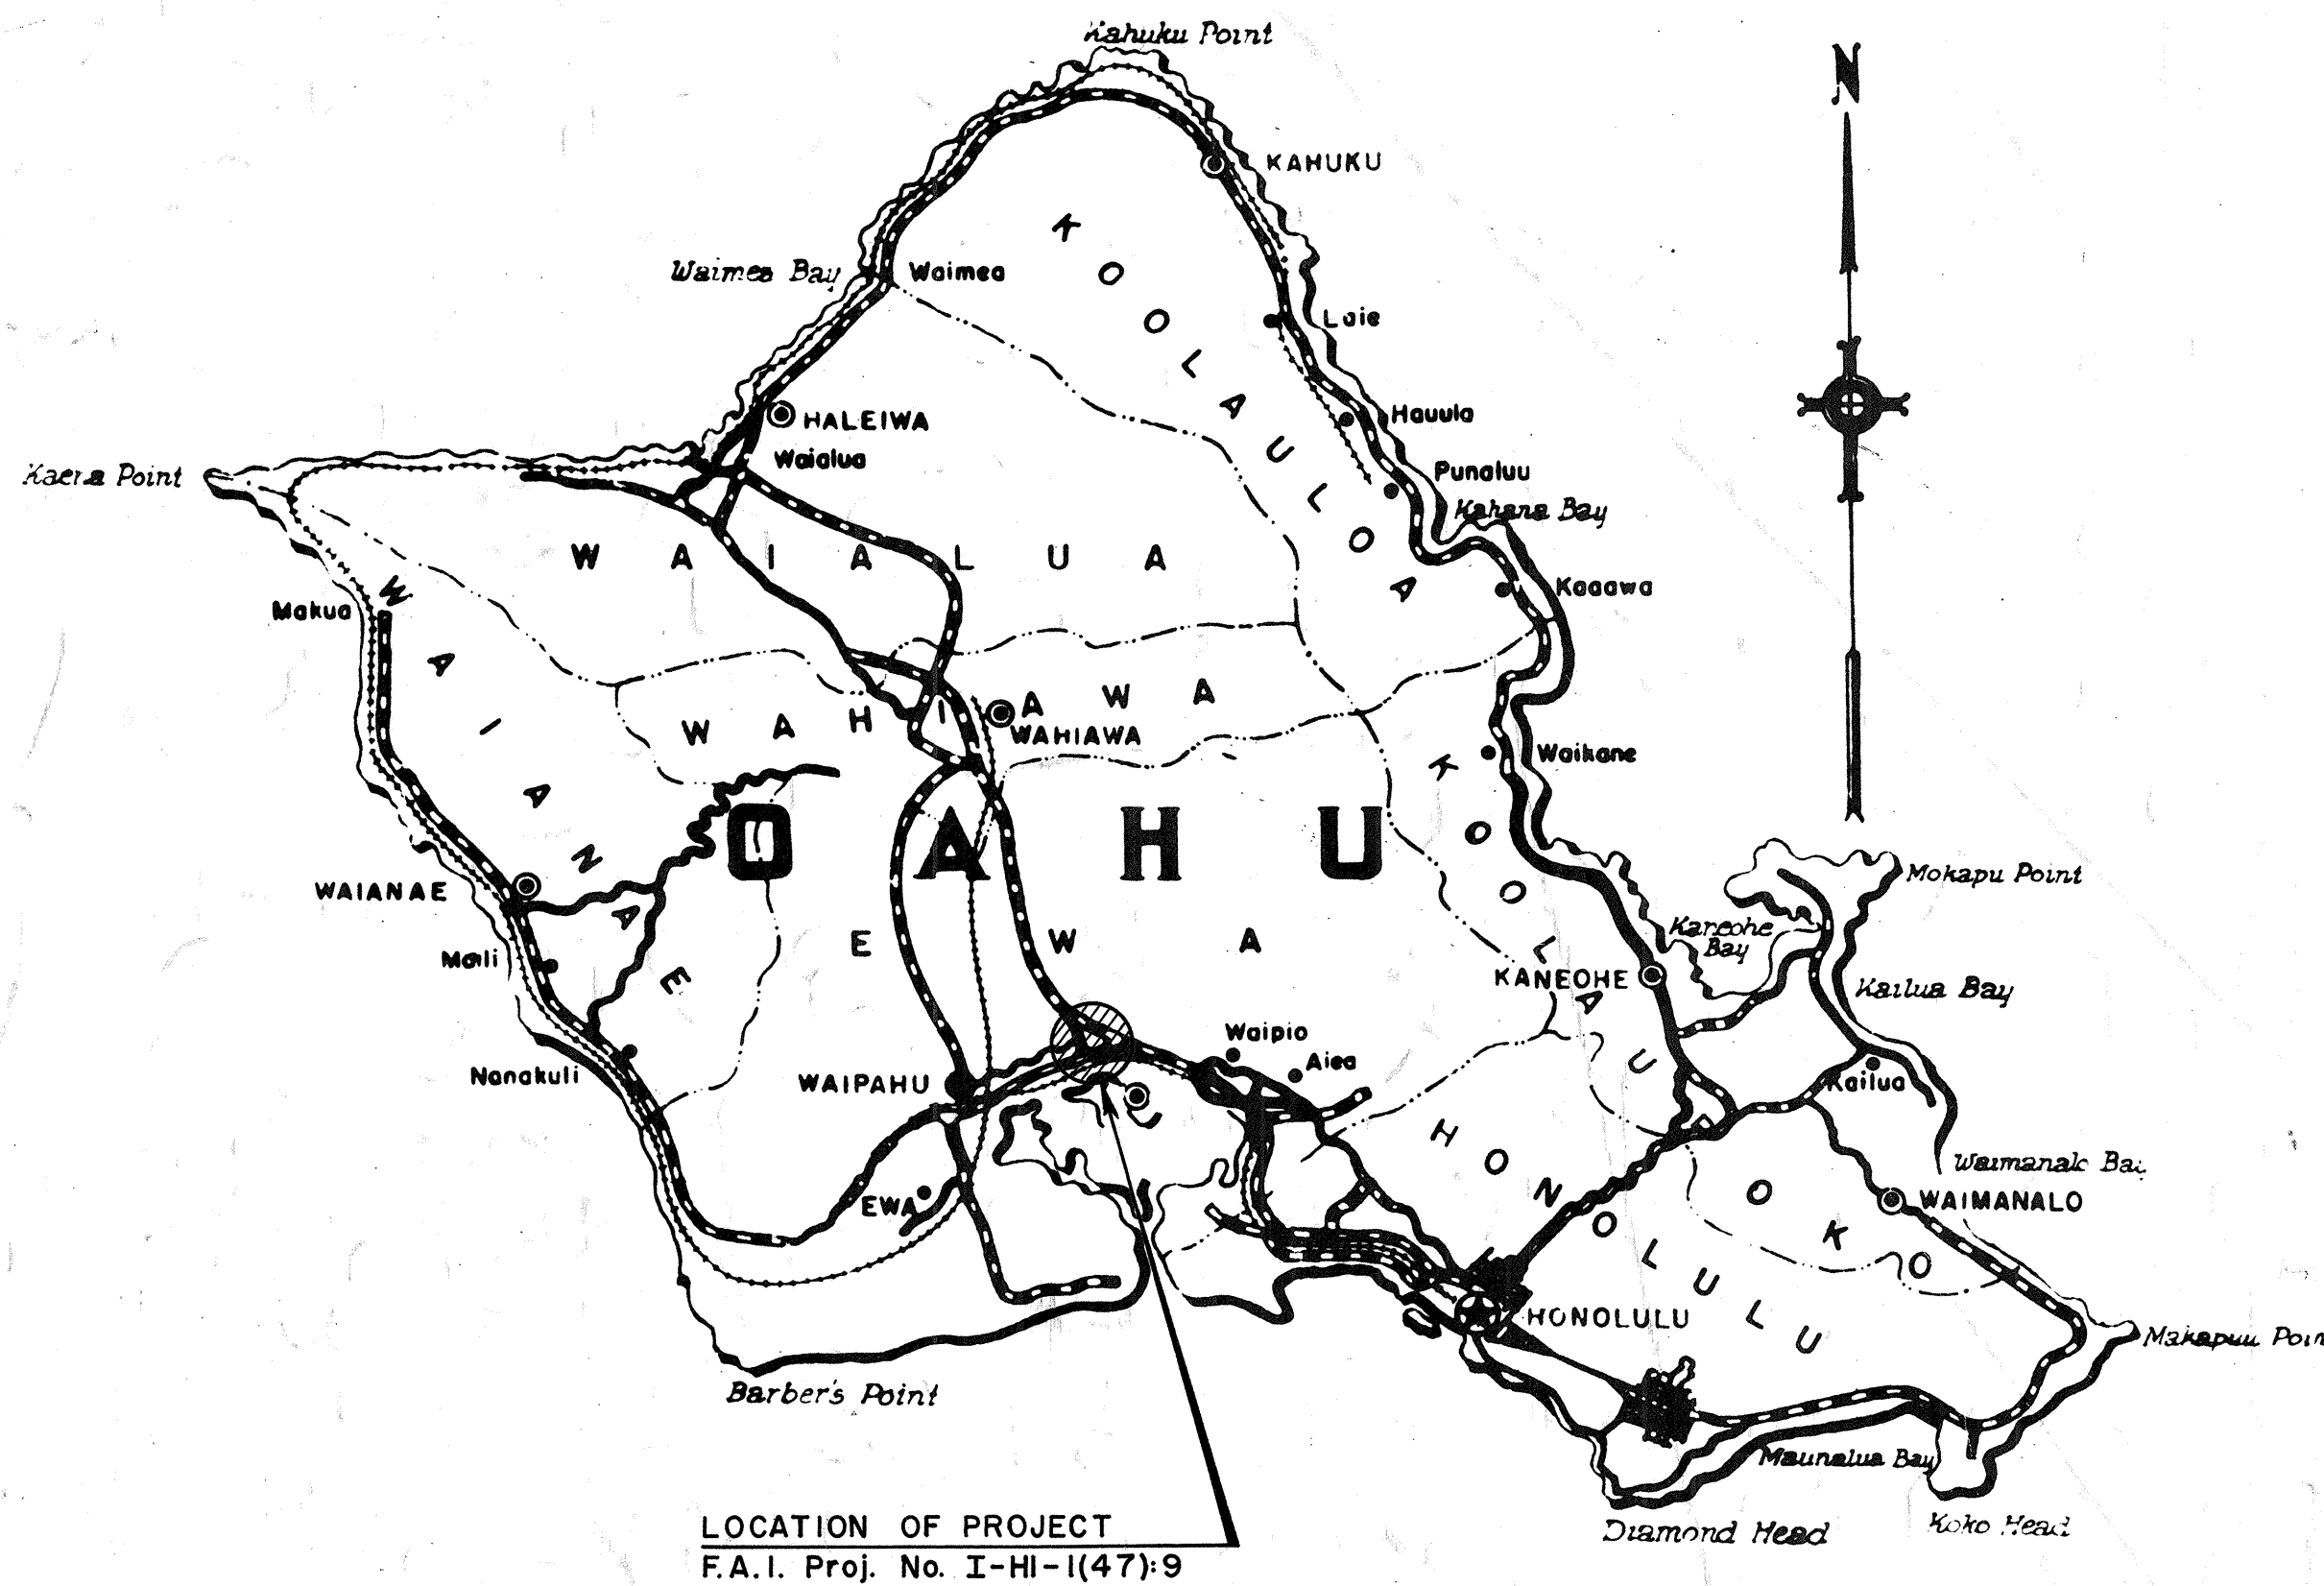

Federal Aid Projects Previously Constructed Or Under Construction

DESIGN CLASSIFICATION

DESIGN ADT (1988)	58,050
DHV	11%
D	65/35
T	4.0%
V	70 mph

NOTE:
ALL CHANGES MADE DURING CONSTRUCTION
HAVE BEEN NOTED IN RED ON THESE TRACINGS
AND CHECKED BY:



Sage O. P.
PROJECT ENGINEER
Oct. 12, 1971
DATE

LAYOUT PLAN

GROSS LENGTH OF PROJECT	0.277 MI.
LESS BRIDGES OVER 20.00' SPAN	0.000 MI.
NET LENGTH OF ROADWAY	0.277 MI.

LEGEND:
ROADWAYS TO BE CONSTRUCTED
UNDER THIS CONTRACT

APPROVED: *E. Olesky Wright*
DIRECTOR OF TRANSPORTATION
DATE 9/25/68

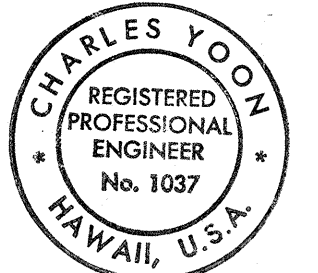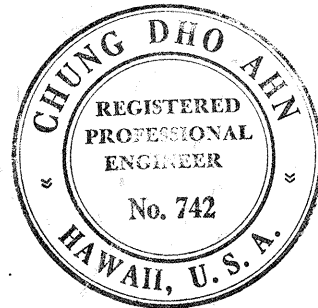

THIS WORK WAS PREPARED BY
ME OR UNDER MY SUPERVISION,
Charles Yoon

DEPARTMENT OF TRANSPORTATION
BUREAU OF PUBLIC ROADS
APPROVED: *Neil Dillabough*
FOR DIVISION ENGINEER
DATE 12-3-68

DATE: Aug 68
SURVEY PLOTTED BY: R. Wong
DESIGNED BY: R. Wong
TRACED BY: R. Wong
NOTED BY: R. Wong
QUANTITIES CHECKED BY: R. Wong
CHECKED BY: R. Wong