


FED. ROAD DIST. NO.	STATE	FED. AID PROJ. NO.	FISCAL YEAR	SHEET NO.	TOTAL SHEETS
HAWAII	HAW.	I-HI-1(68):10	1968	78	91


SYMBOLS

- NEW STREET LIGHT STANDARD WITH MAST ARM, 400 WATT MERCURY LUMINAIRE & PHOTOELECTRIC CONTROL ON EXIST BASE & EXIST ANCHOR BOLTS.
- NEW STREET LIGHT STANDARD WITH MAST ARM, 400 WATT MERCURY LUMINAIRE & PHOTOELECTRIC CONTROL ON NEW BASE & WITH NEW ANCHOR BOLTS & CAST J.B.
- NEW WIRES IN EXISTING RIGID STEEL CONDUIT ENCASED IN CONCRETE BARRIER WALL
- NEW WIRES IN NEW RIGID STEEL CONDUIT ENCASED IN CONCRETE BARRIER WALL
- EXISTING EXPANSION COUPLING
- NEW EXPANSION COUPLING
- NEW CAST STEEL JUNCTION BOX, WATERTIGHT
- SIGN LIGHTING
- UNDERPASS LUMINAIRE, 6', 2 LAMP FLUORESCENT

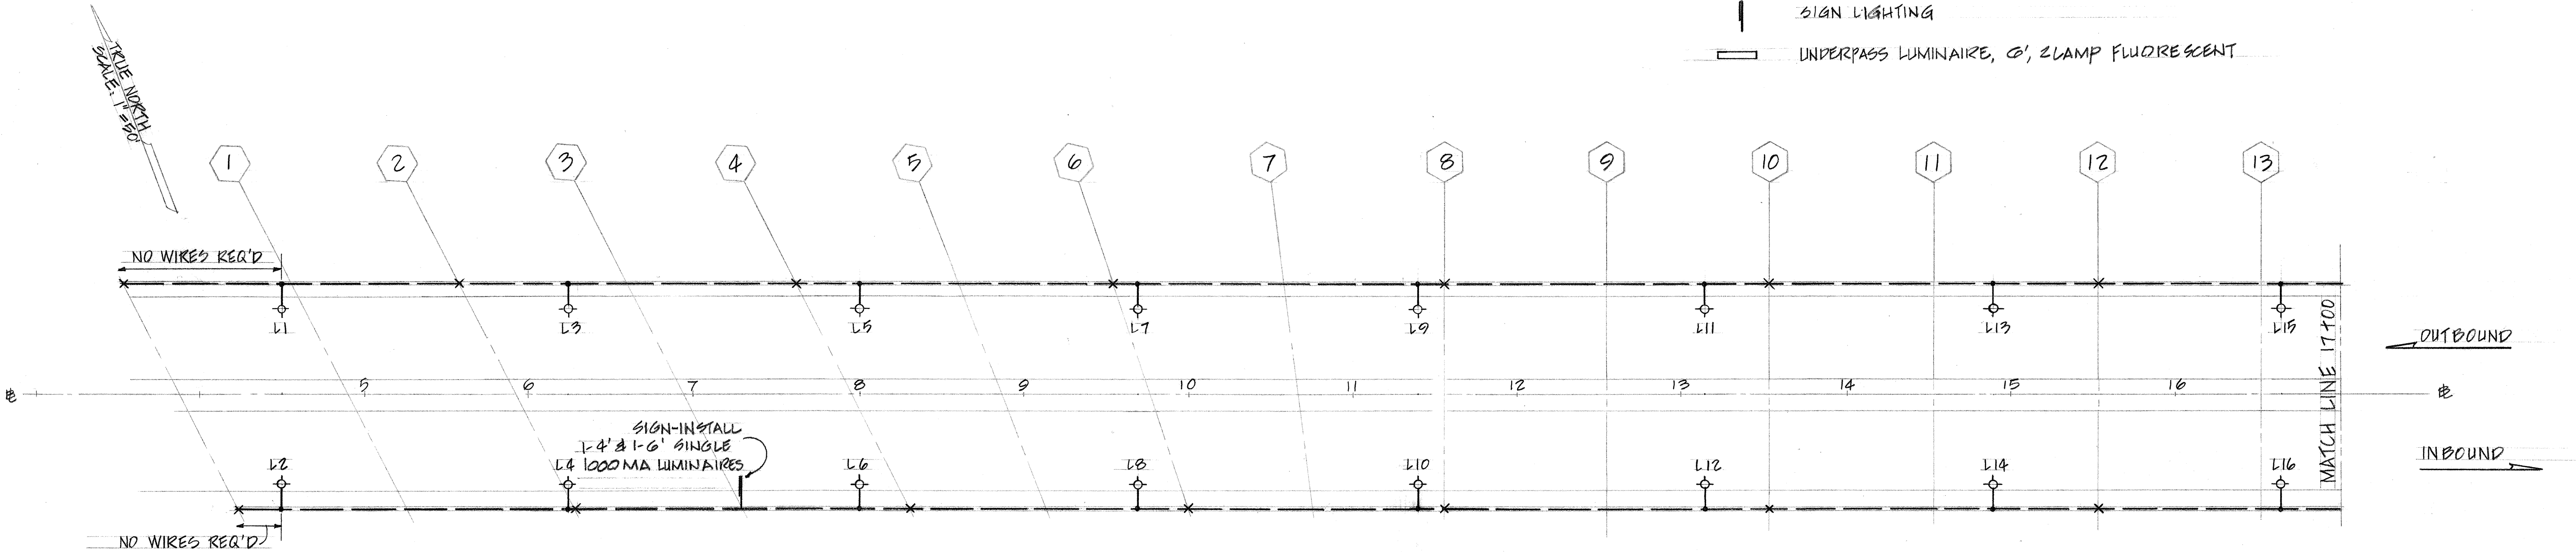

ORIGINAL PLAN	SURVEY PLOTTED BY	DATE
NOTE BOOK	DRAWN BY	
No.	DESIGNED BY	
	QUANTITIES BY	
	CHECKED BY	



THIS WORK WAS PREPARED BY ME
OR UNDER MY SUPERVISION
Albert S. C. Chong
Albert S. C. Chong, PE

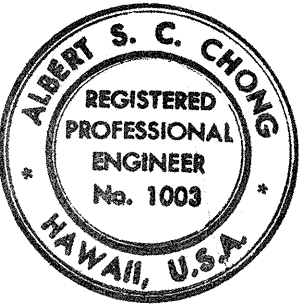


STATE OF HAWAII
DEPARTMENT OF TRANSPORTATION
HIGHWAYS DIVISION

PEARL CITY VIADUCT
LIGHTING PLAN
INTERSTATE ROUTE H-1
F.A.I. Proj. No I-HI-1(68):10
Scale: 1"=50'


FED. ROAD DIST. NO.	STATE	FED. AID PROJ. NO.	FISCAL YEAR	SHEET NO.	TOTAL SHEETS
HAWAII	HAW.	I-H-1(68):10	1968	79	91

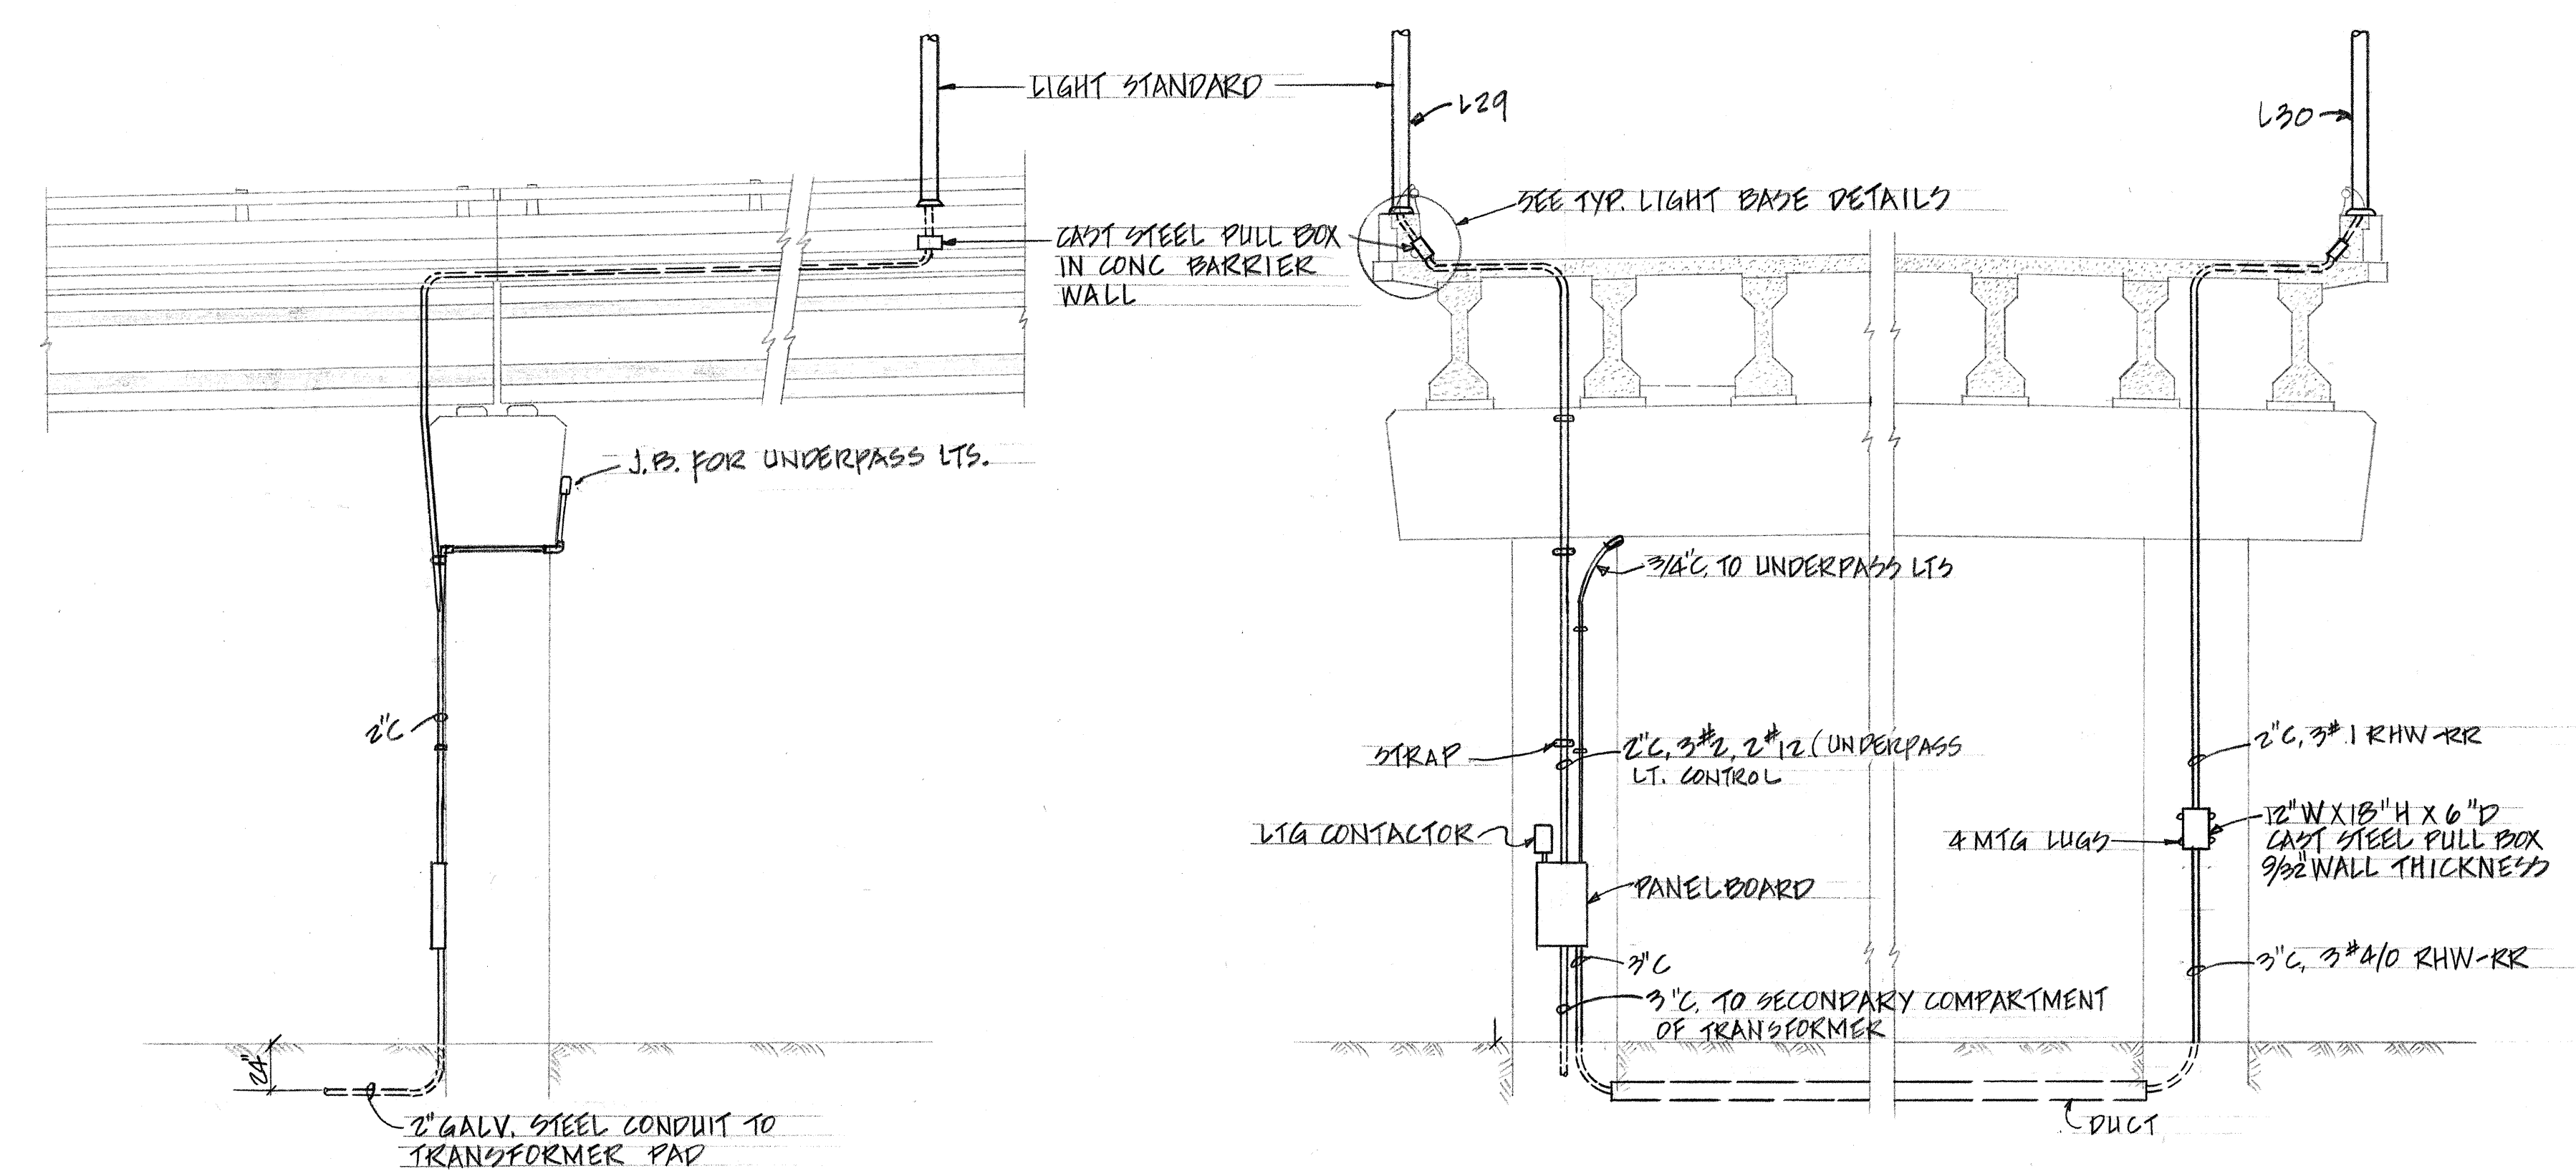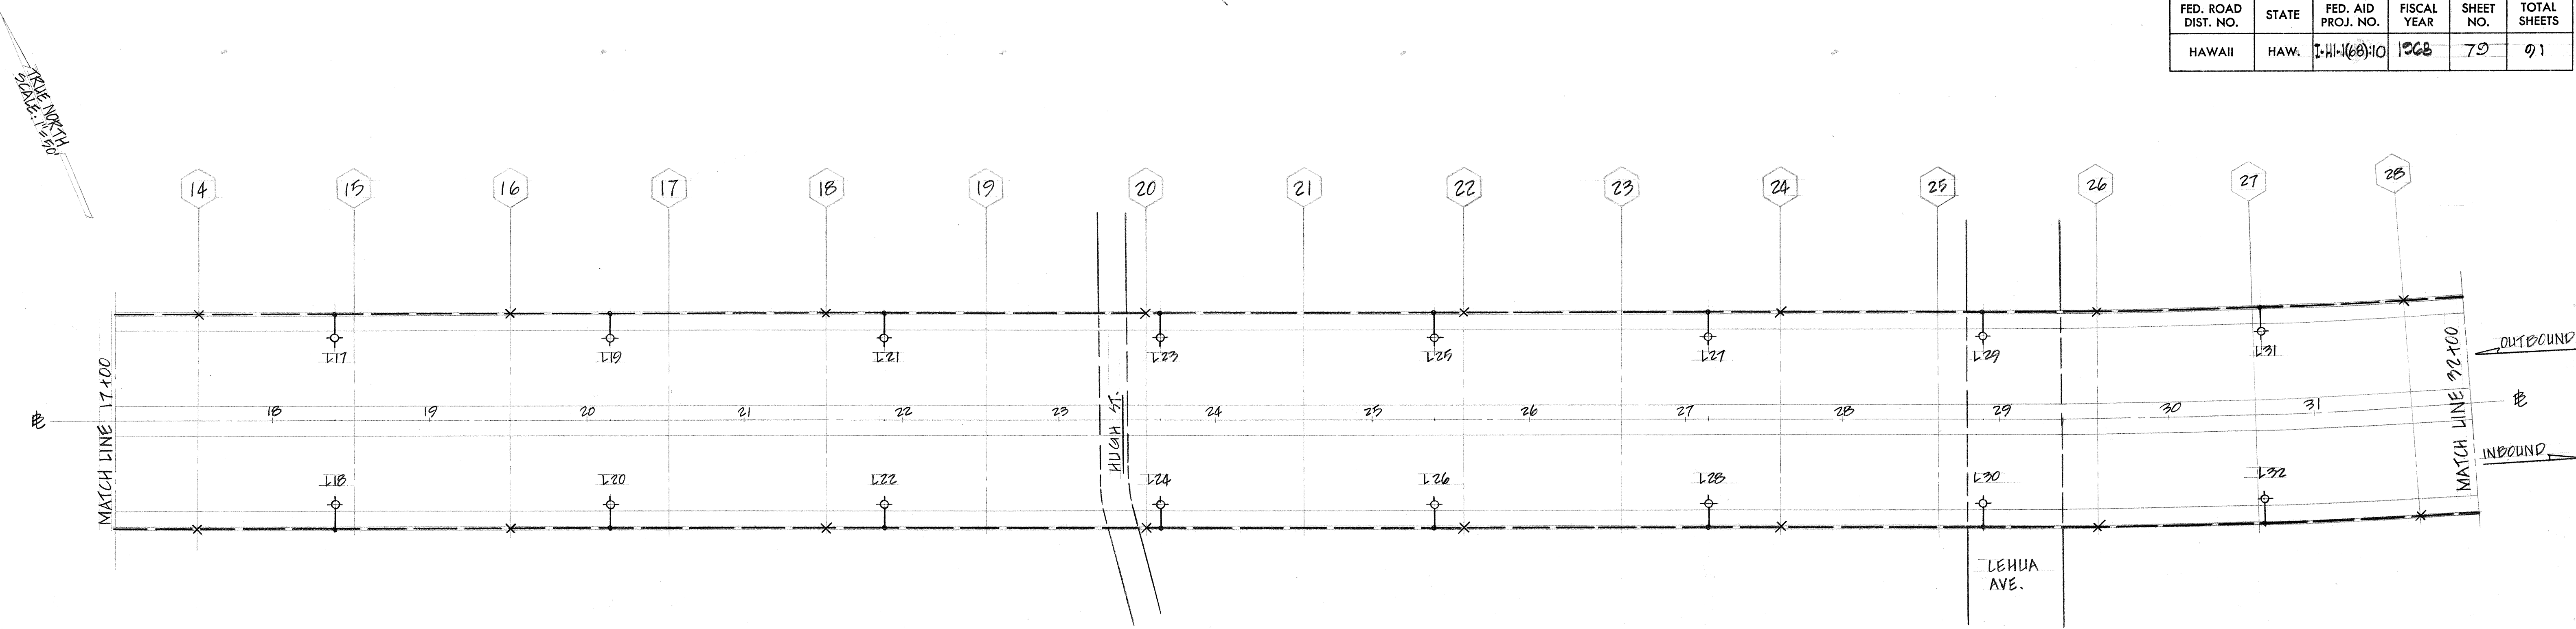

SECTION A
SCALE: 3/16" = 1'-0"

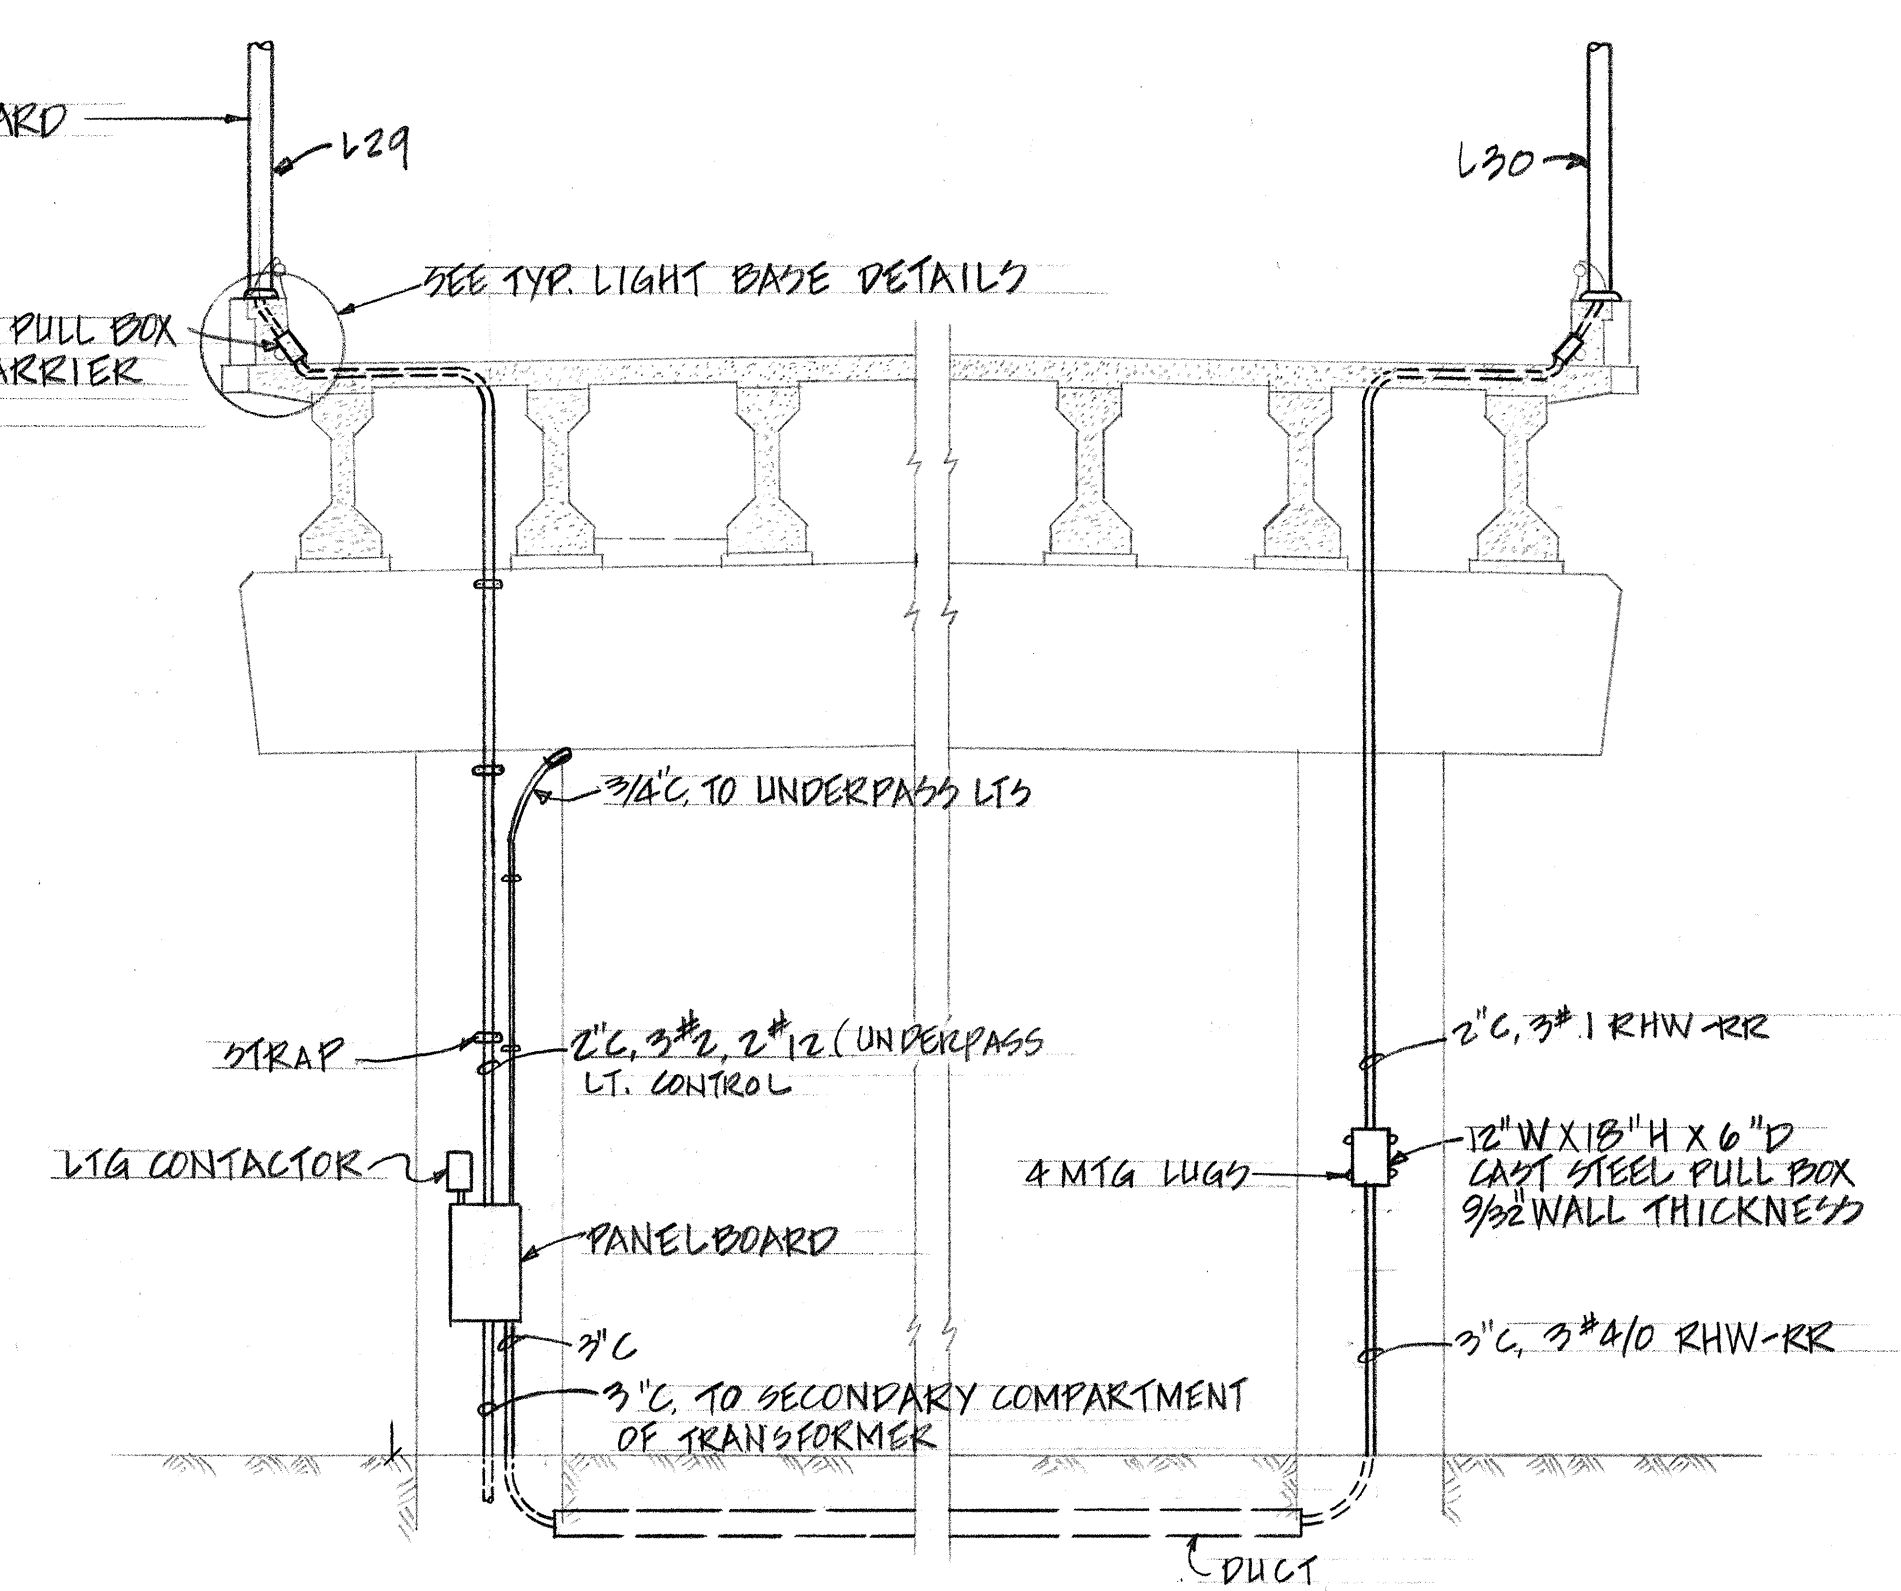


SECTION B
SCALE: 3/16" = 1'-0"

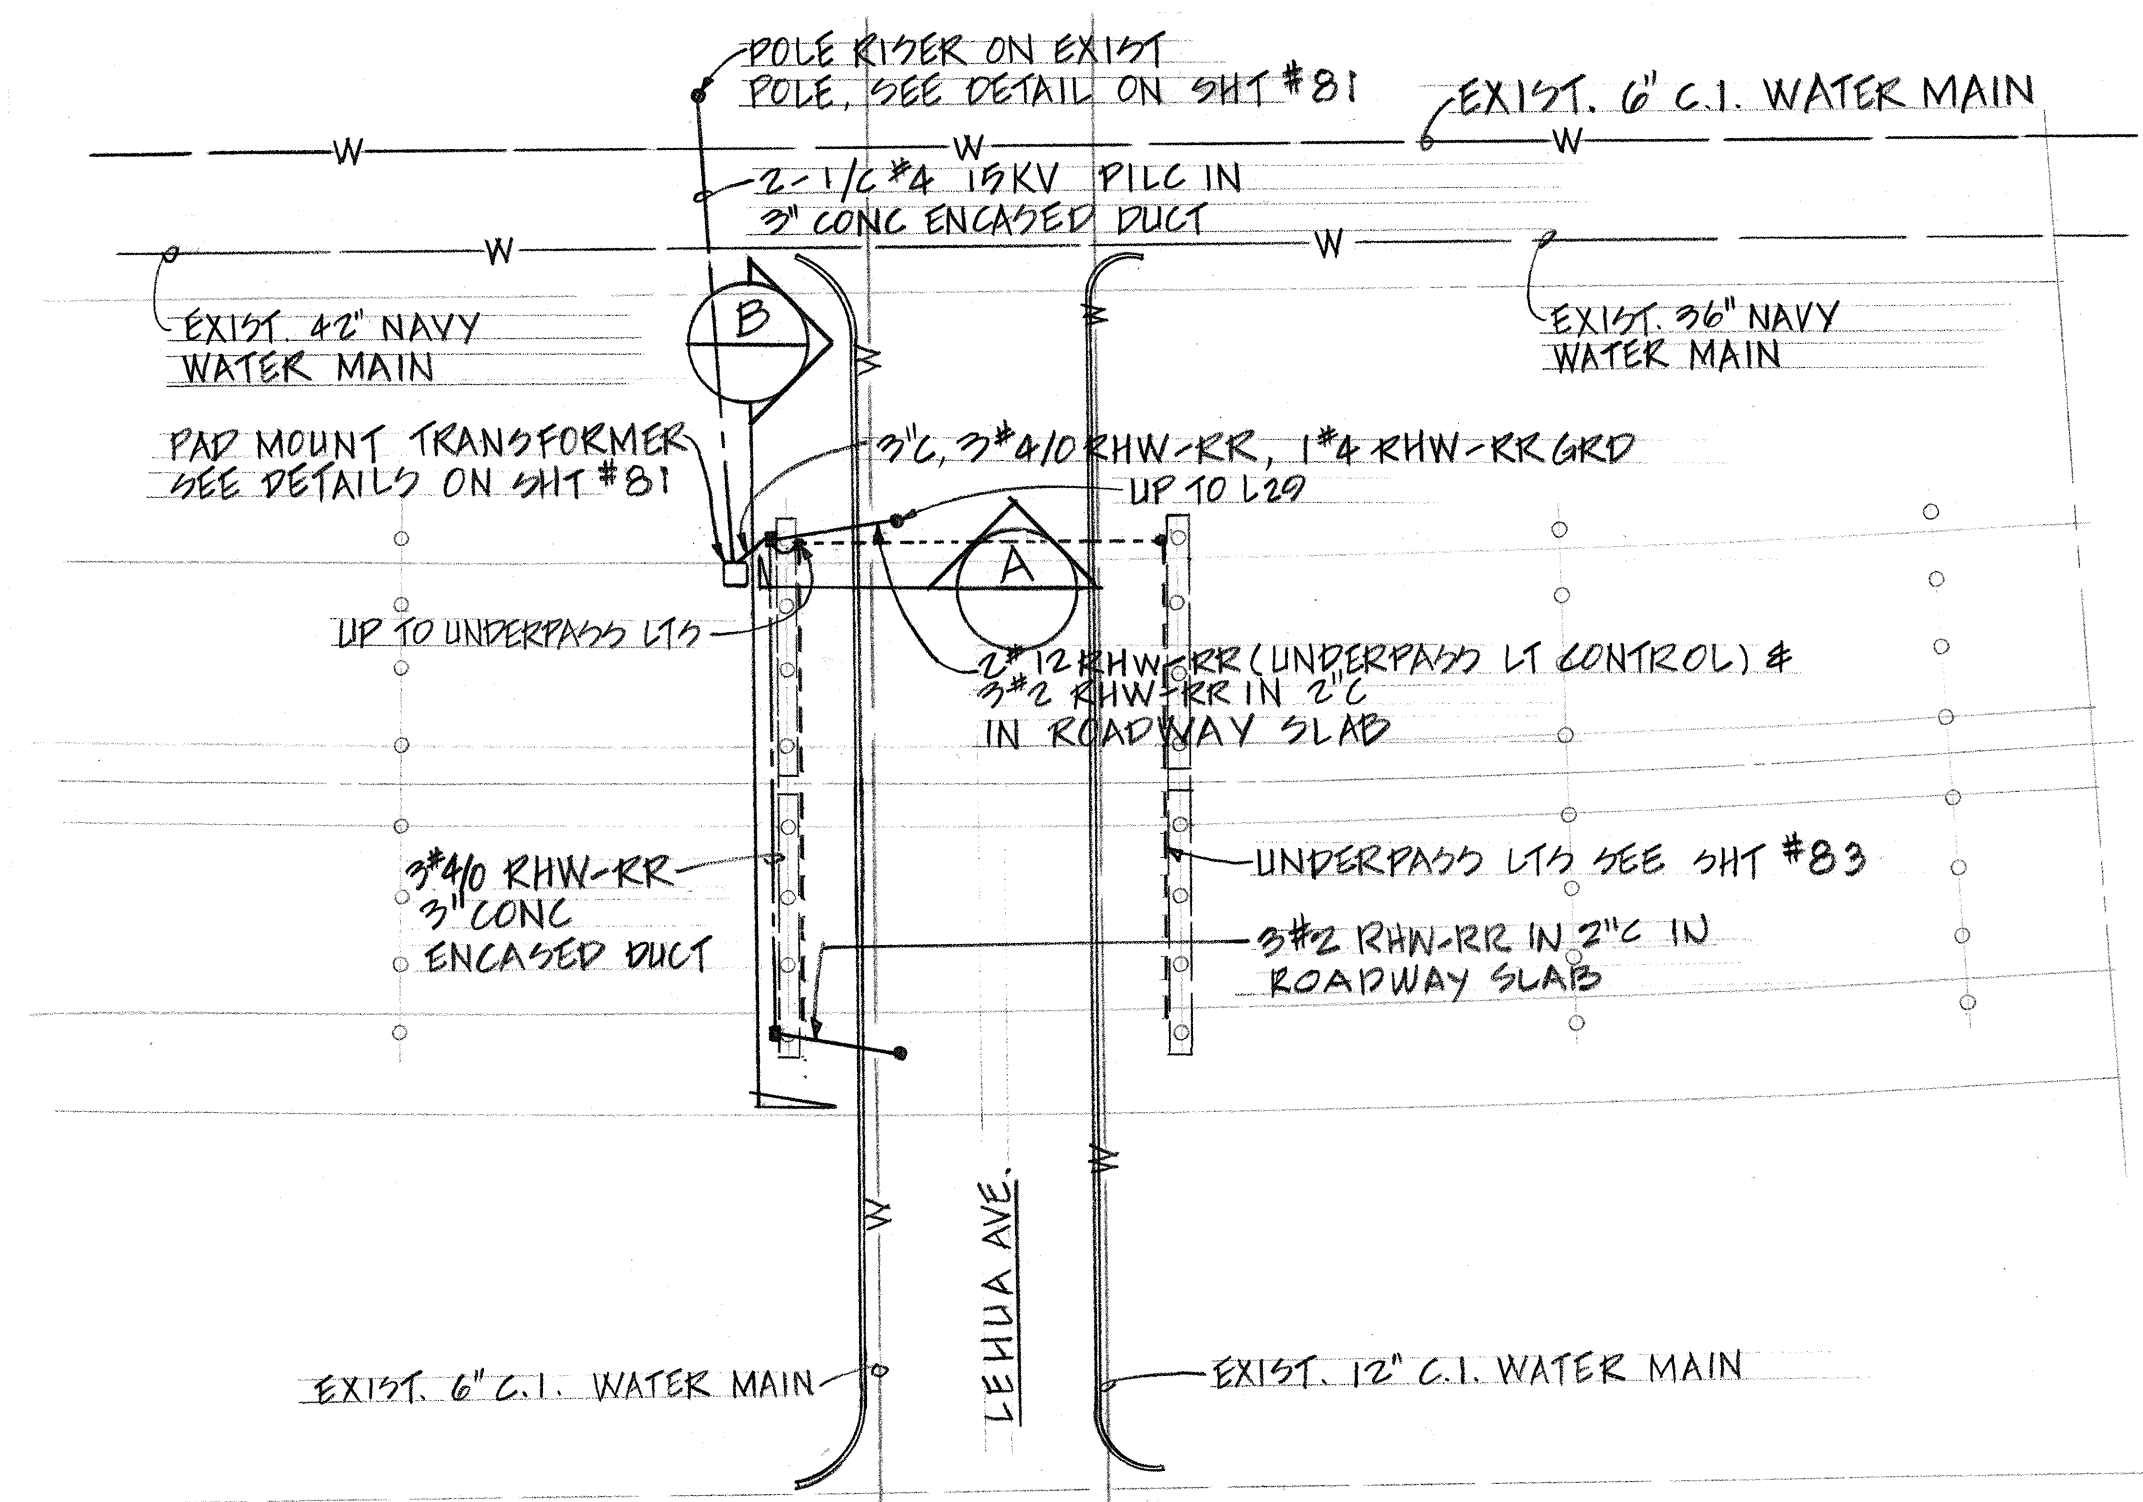

PARTIAL PLAN BELOW VIADUCT
SCALE: 1" = 50'

THIS WORK WAS PREPARED BY ME
OR UNDER MY SUPERVISION
Albert S. C. Chong
Albert S. C. Chong, PE

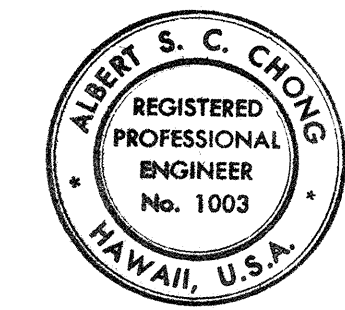


STATE OF HAWAII
DEPARTMENT OF TRANSPORTATION
HIGHWAYS DIVISION

PEARL CITY VIADUCT
LIGHTING PLAN & DETAILS
INTERSTATE ROUTE H-1
F.A.I. Proj. No I-H-1(68):10
Scale: 1" = 50'


DATE	_____
SURVEY BY	_____
DRAWN BY	_____
DESIGNED BY	_____
CHECKED BY	_____
ORIGINAL PLAN	_____
NOTE BOOK	_____
No.	_____

FED. ROAD DIST. NO.	STATE	FED. AID PROJ. NO.	FISCAL YEAR	SHEET NO.	TOTAL SHEETS
HAWAII	HAW.	I-H-1(68):10	1968	80	91

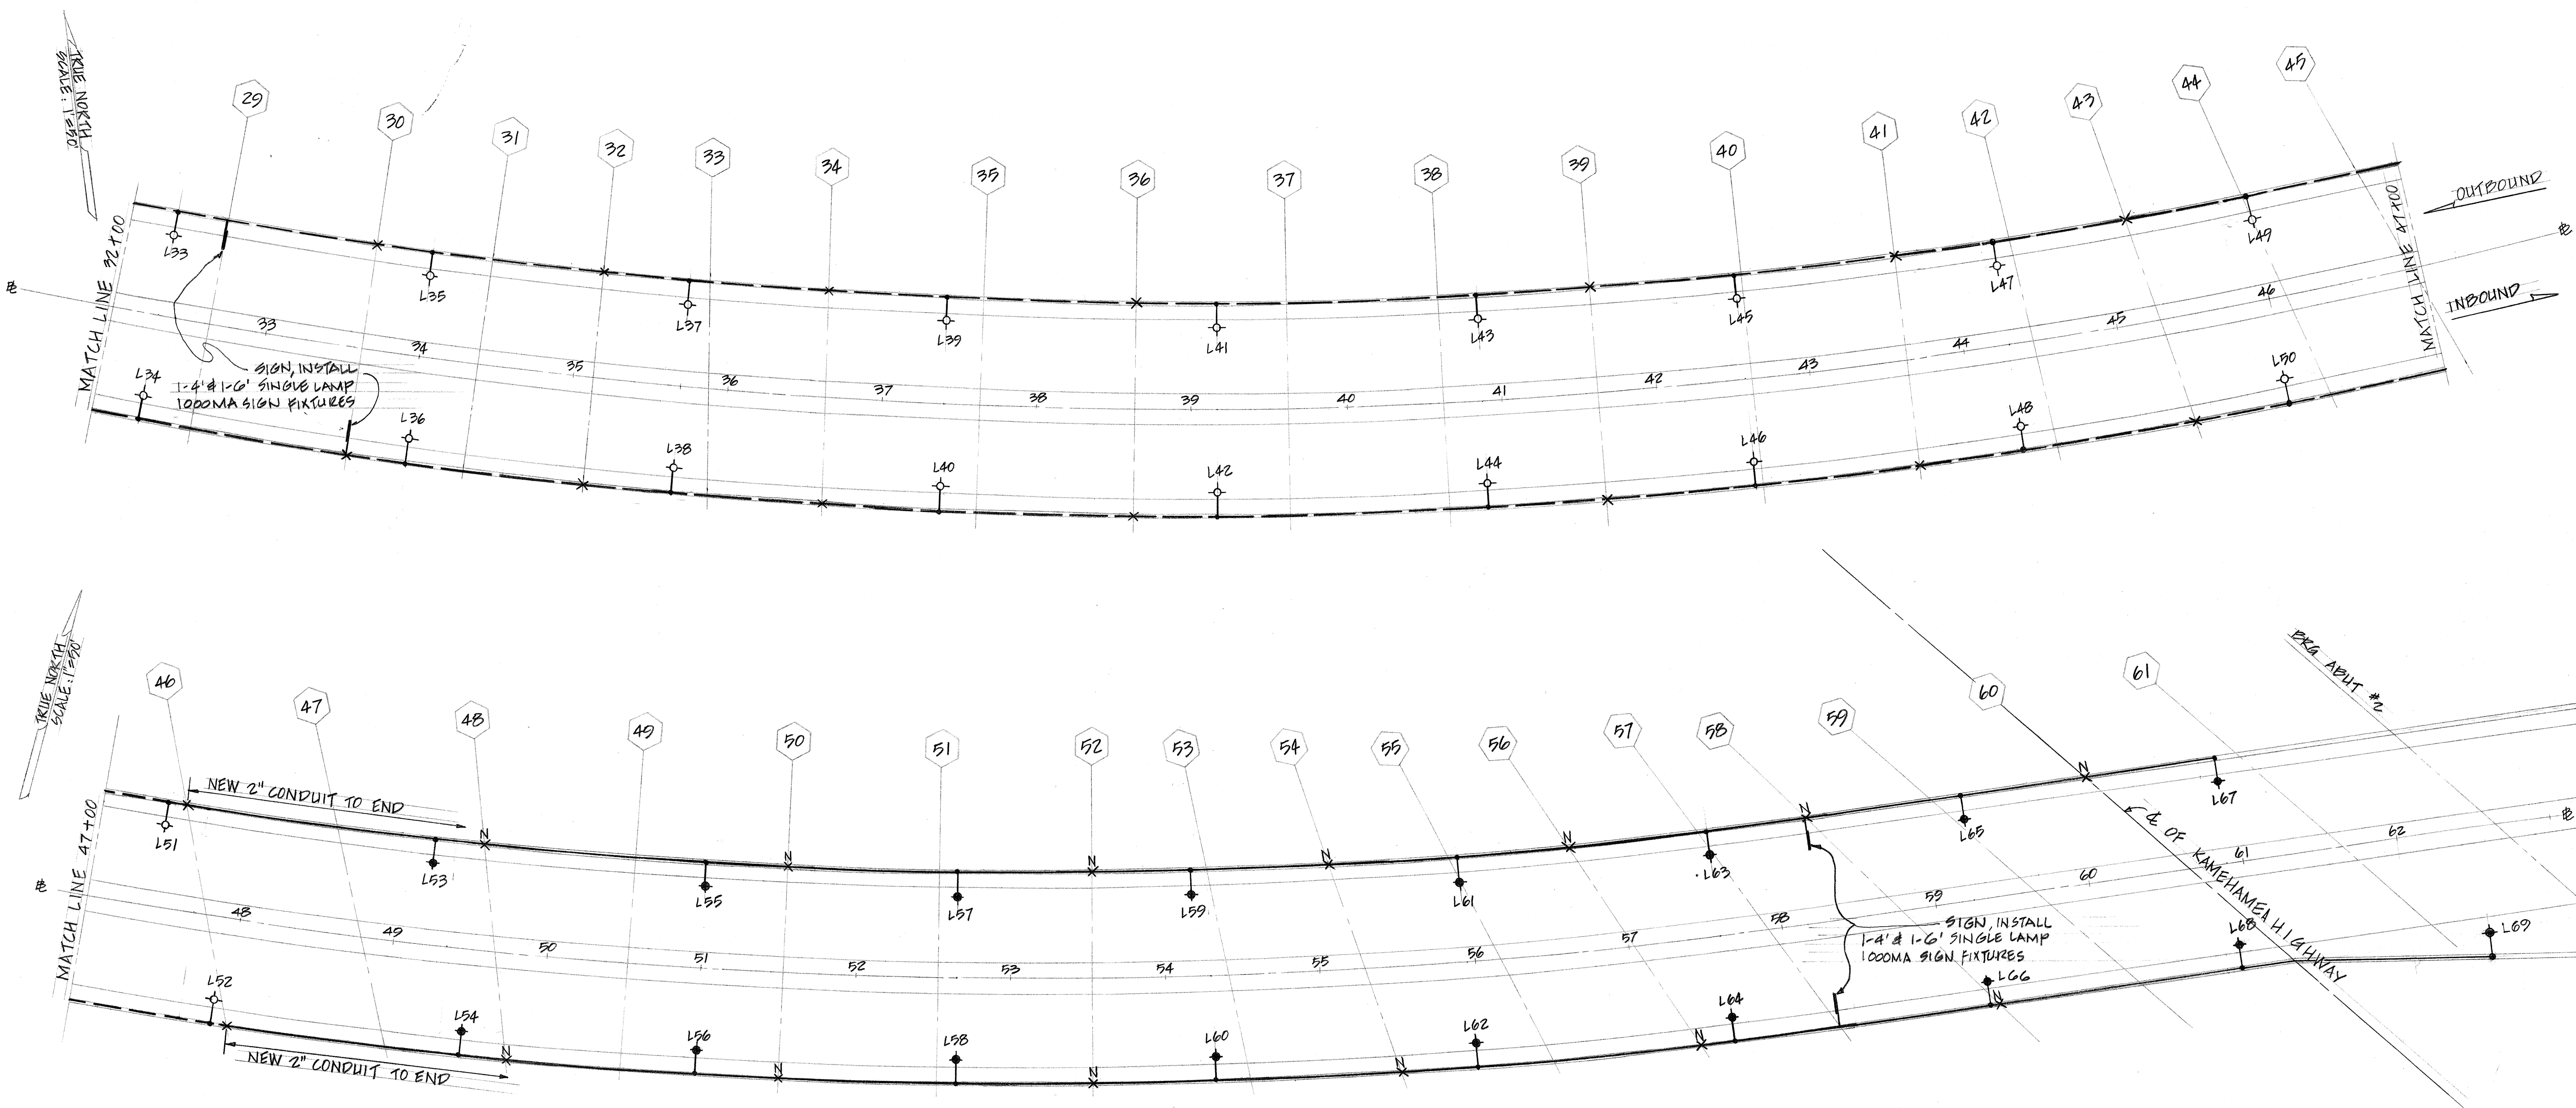






SURVEY PLANNED BY	DATE
DRAWN BY	
TRACED BY	
CHECKED BY	
QUANTITIES BY	
CHECKED BY	
ORIGINAL PLAN	
NOTE BOOK	
No.	

THIS WORK WAS PREPARED BY ME
OR UNDER MY SUPERVISION
Albert S. C. Chong
Albert S. C. Chong, PE

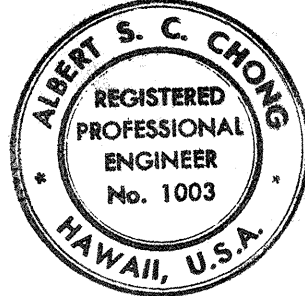


STATE OF HAWAII
DEPARTMENT OF TRANSPORTATION
HIGHWAYS DIVISION

PEARL CITY VIADUCT
LIGHTING PLAN
INTERSTATE ROUTE H-1
F.A.I. Proj. No I-H-1(68):10
Scale: 1"=50'

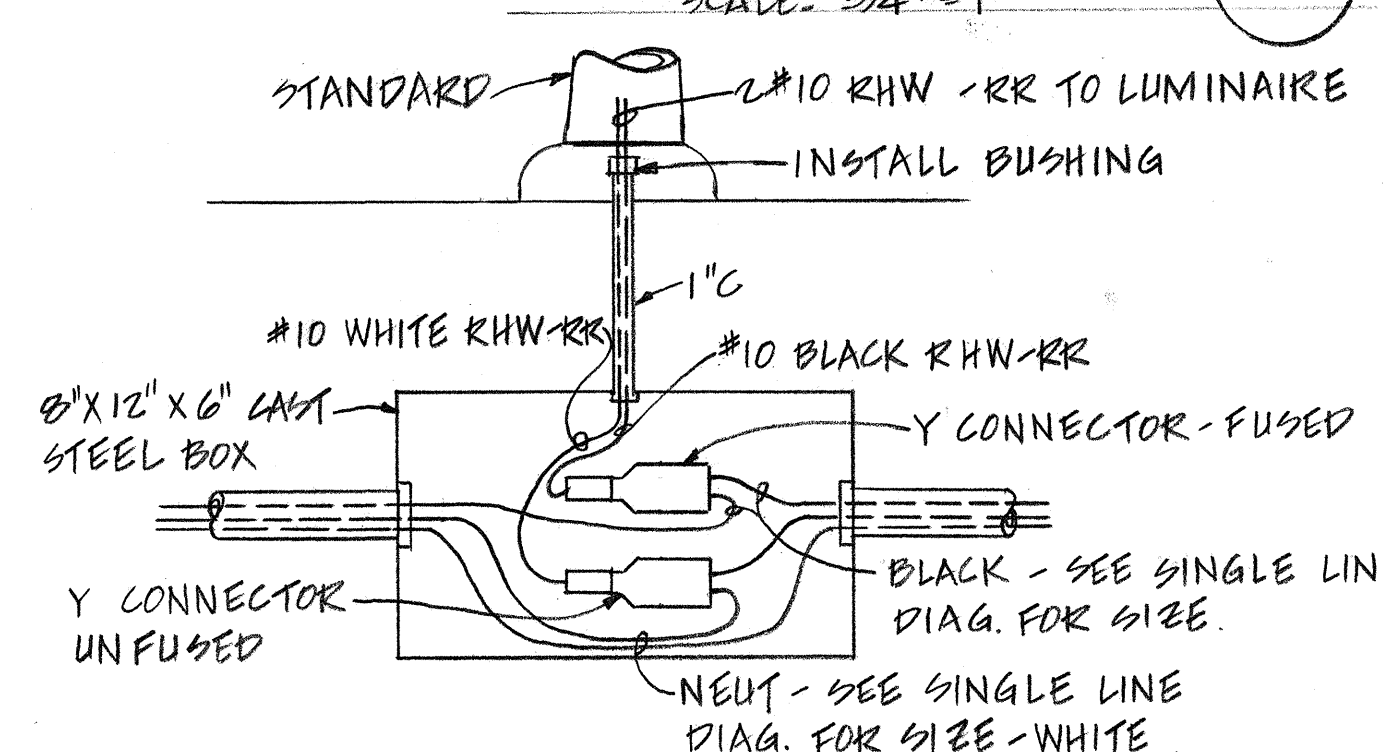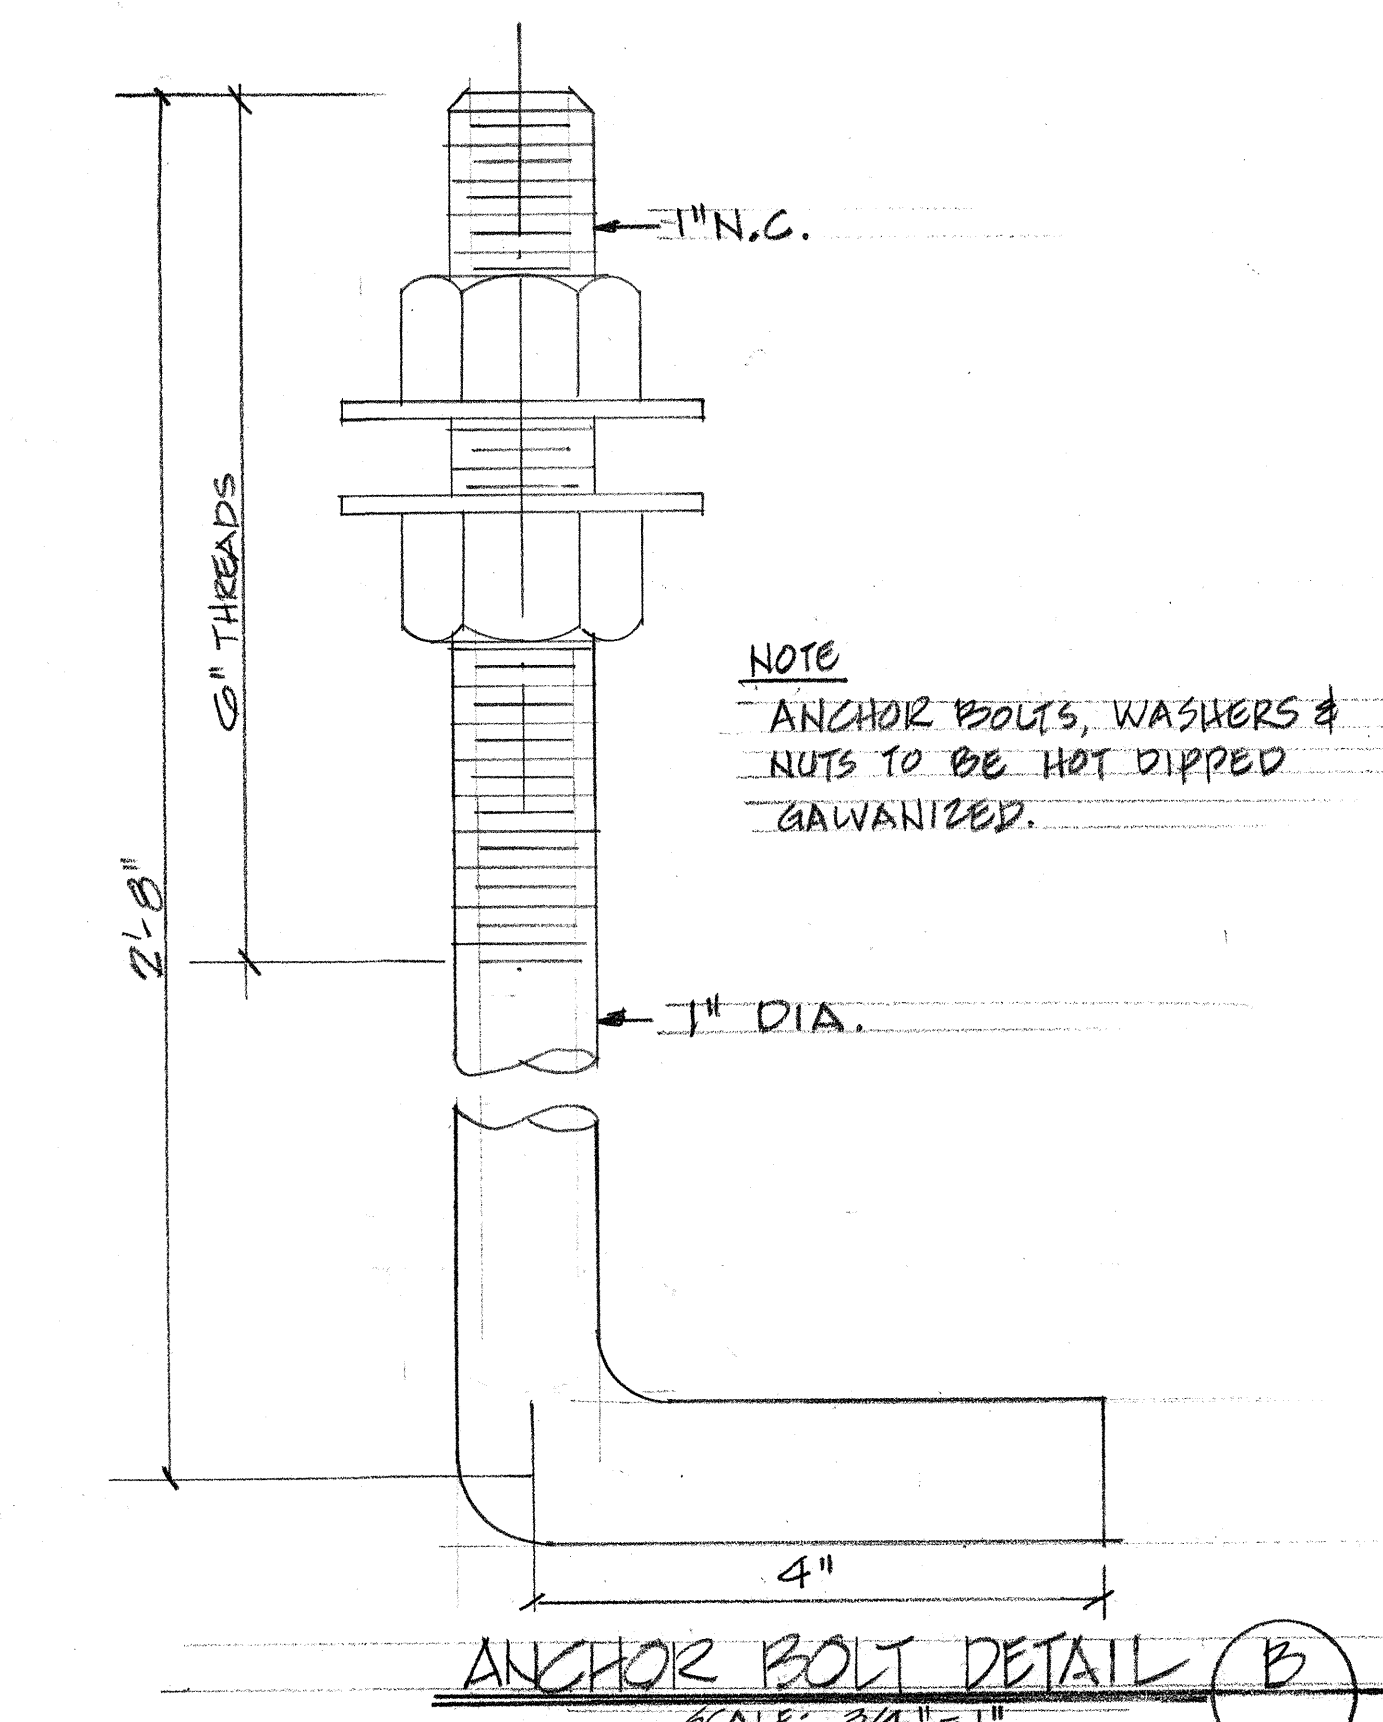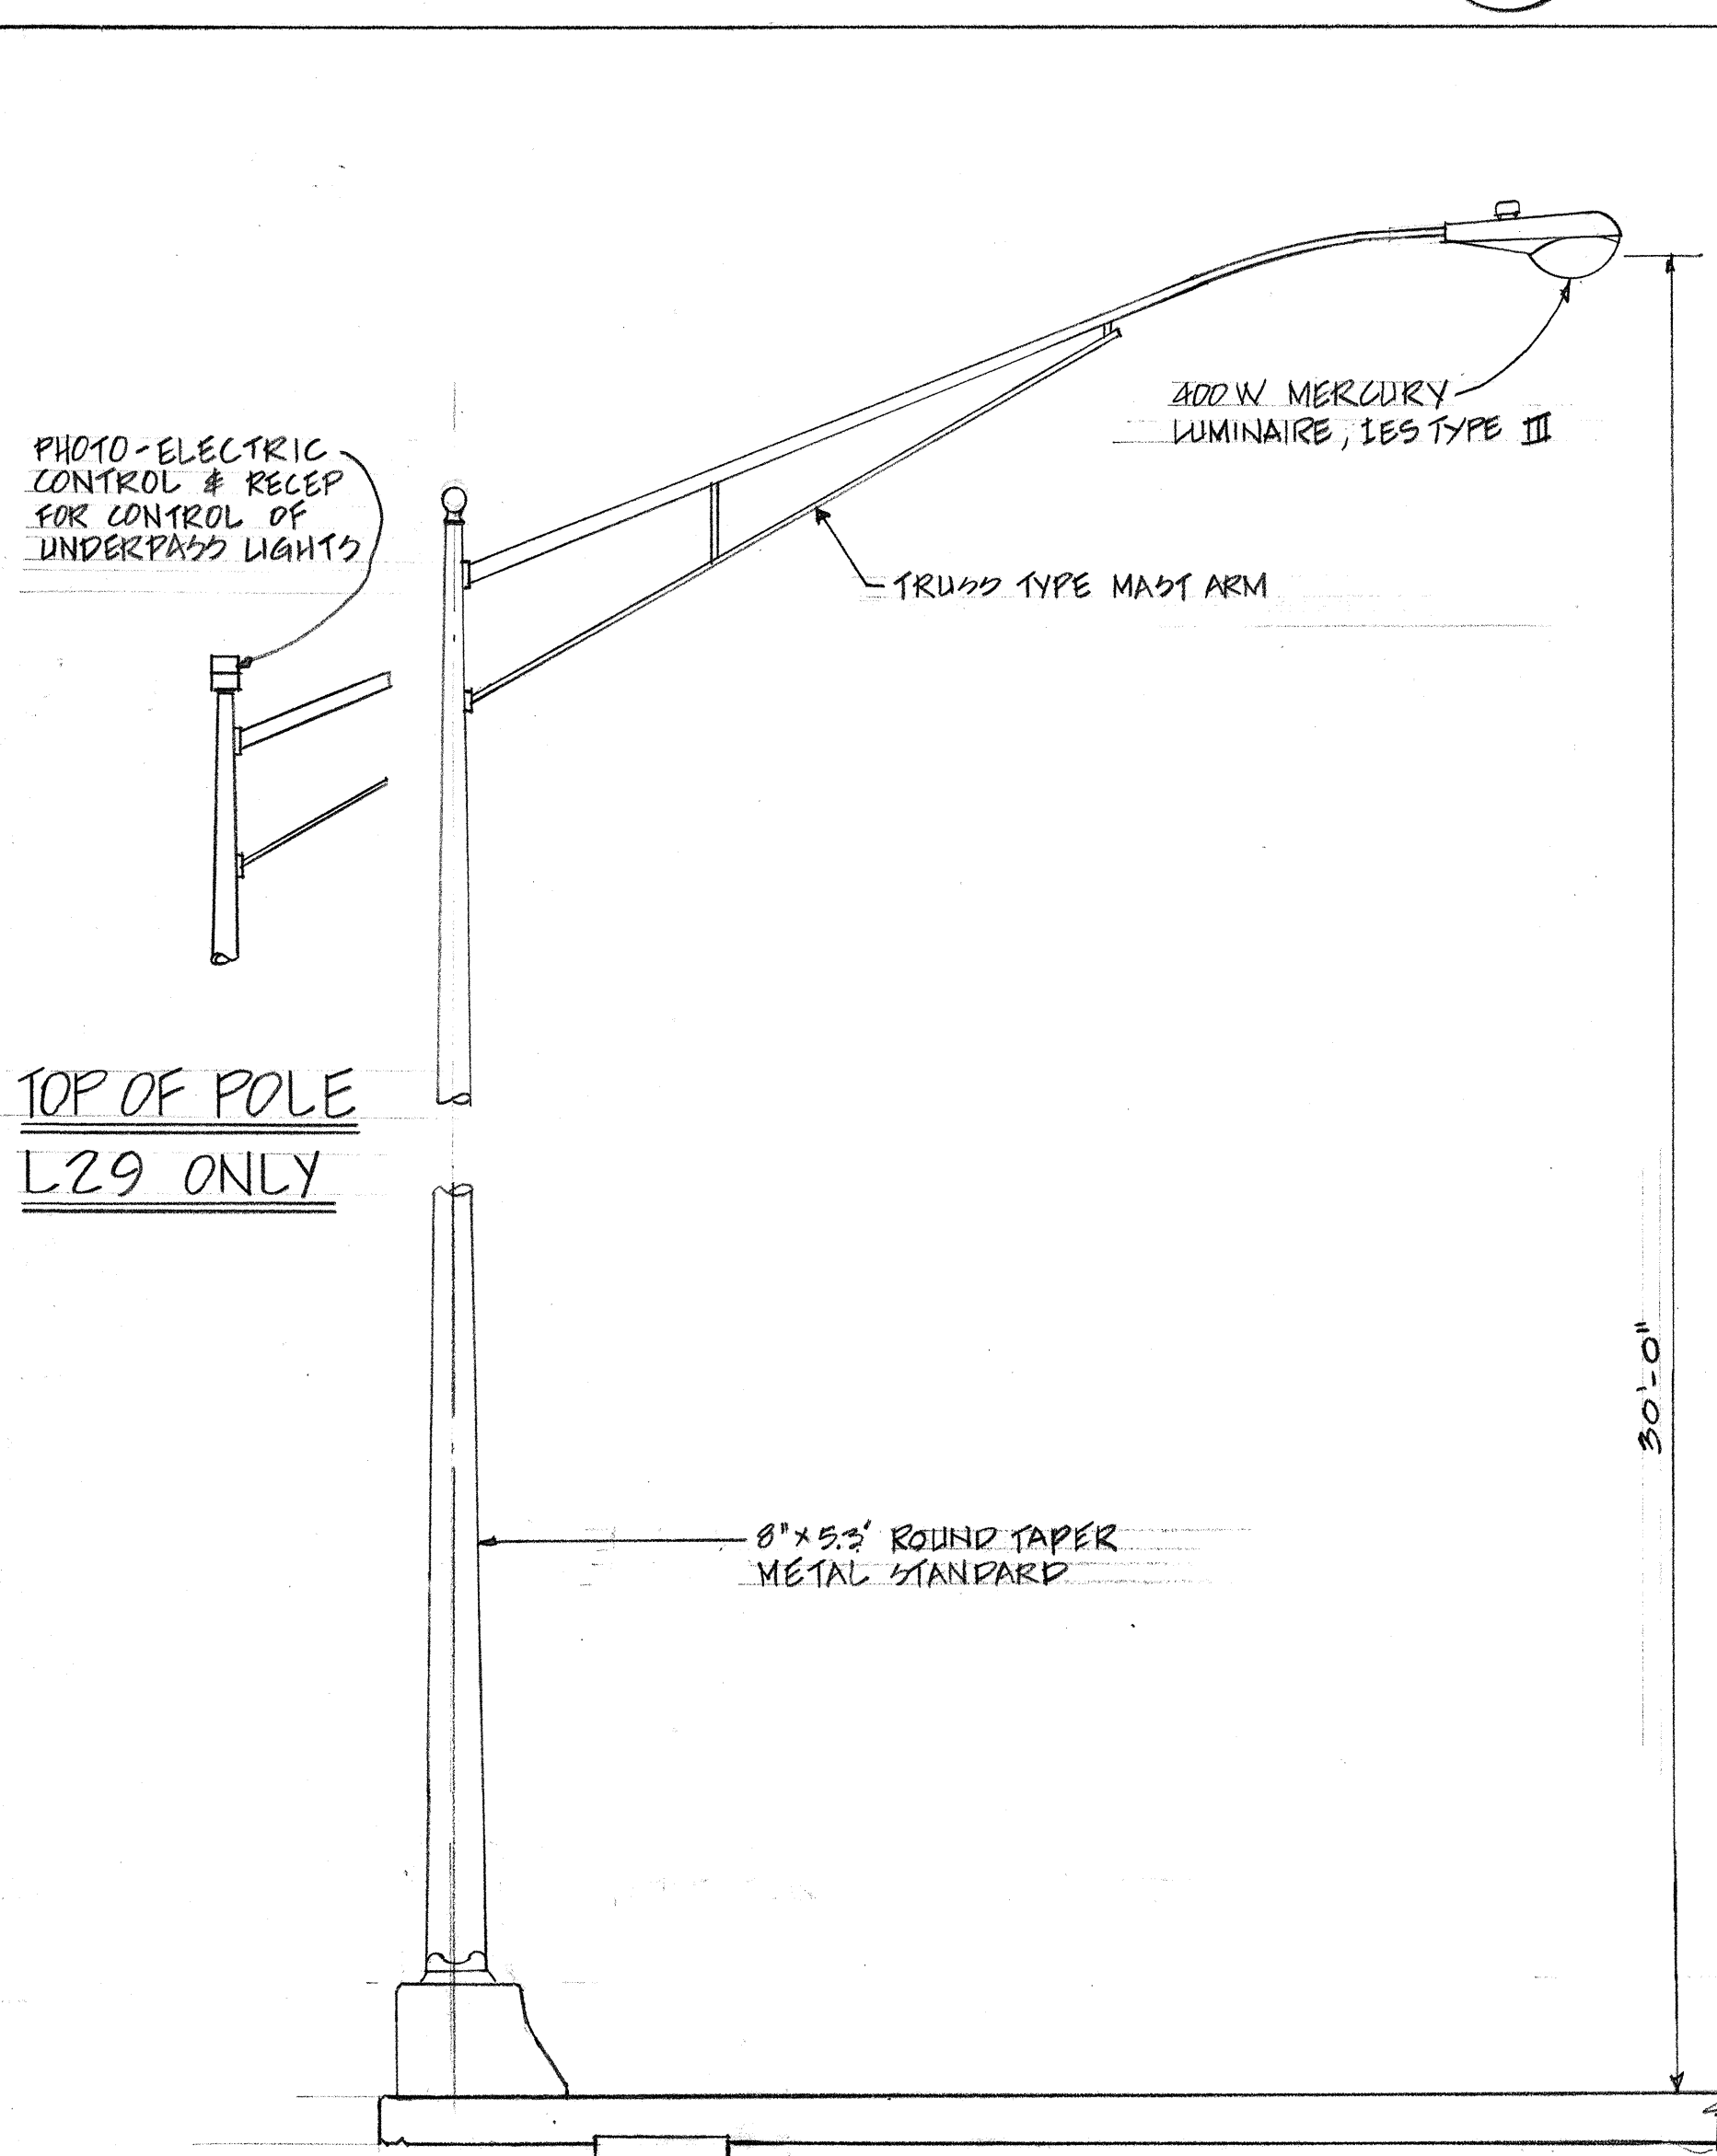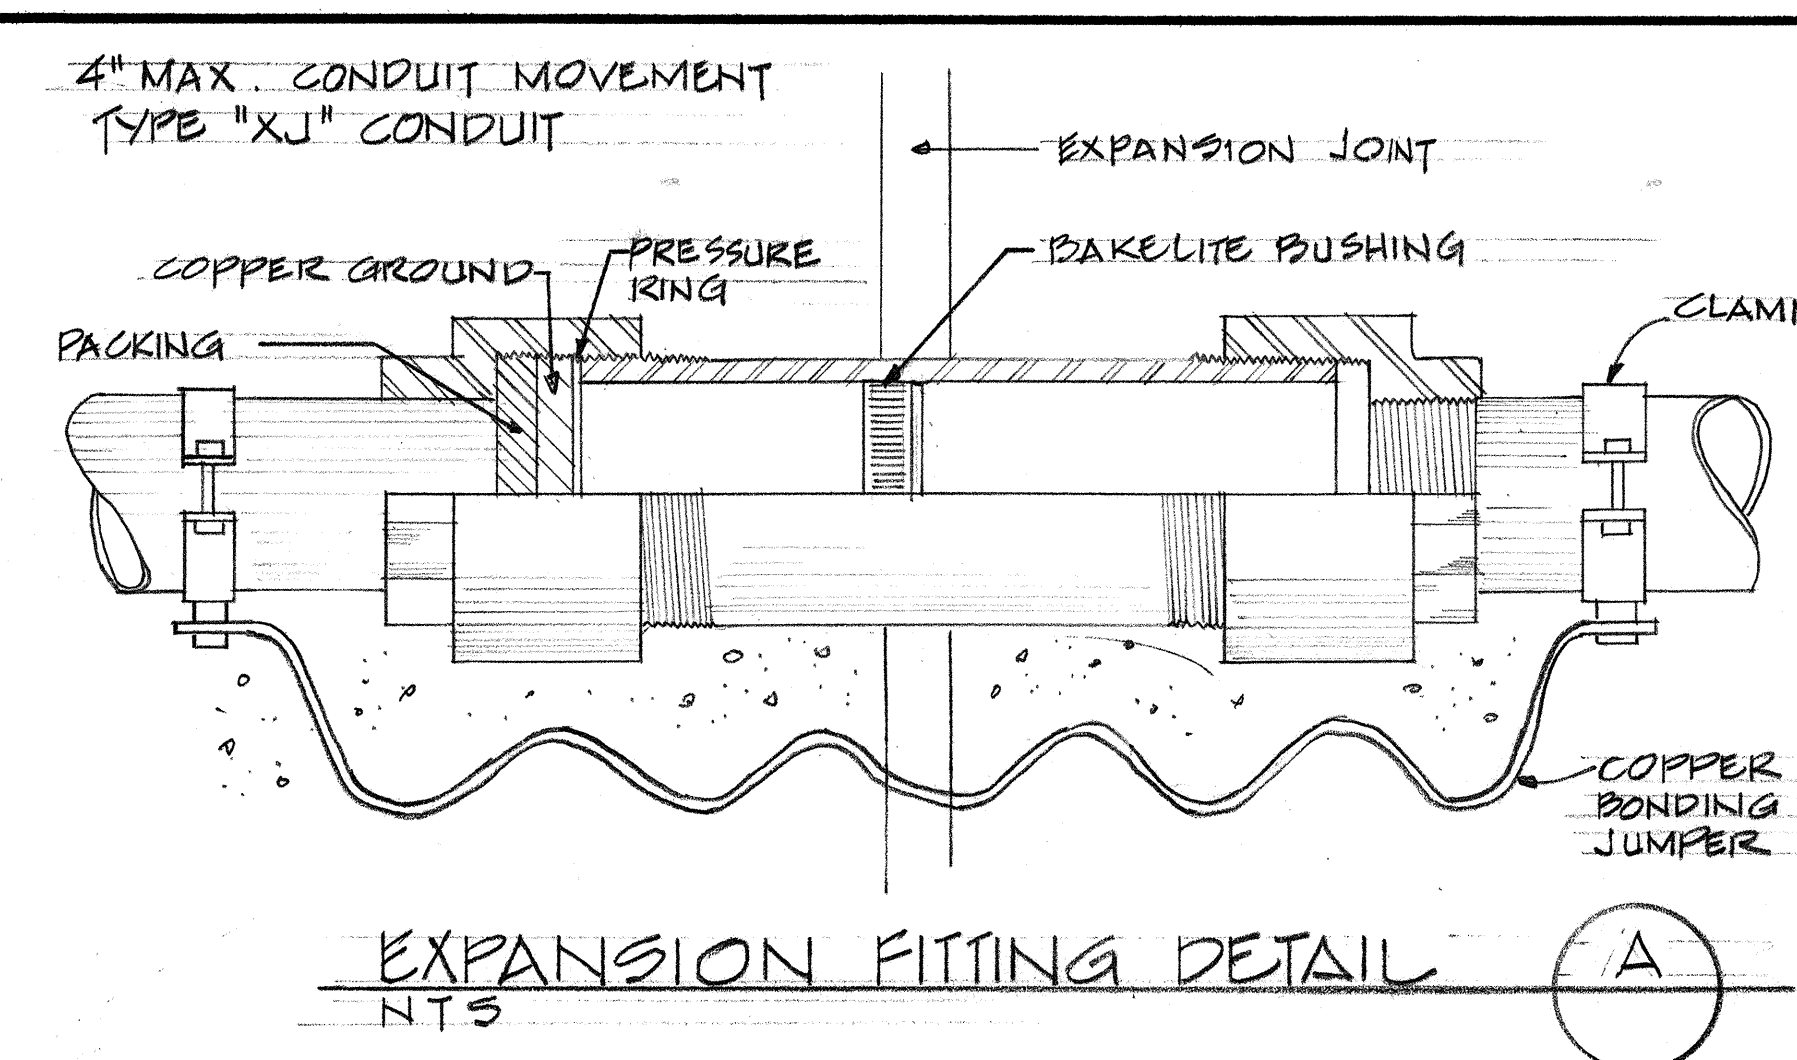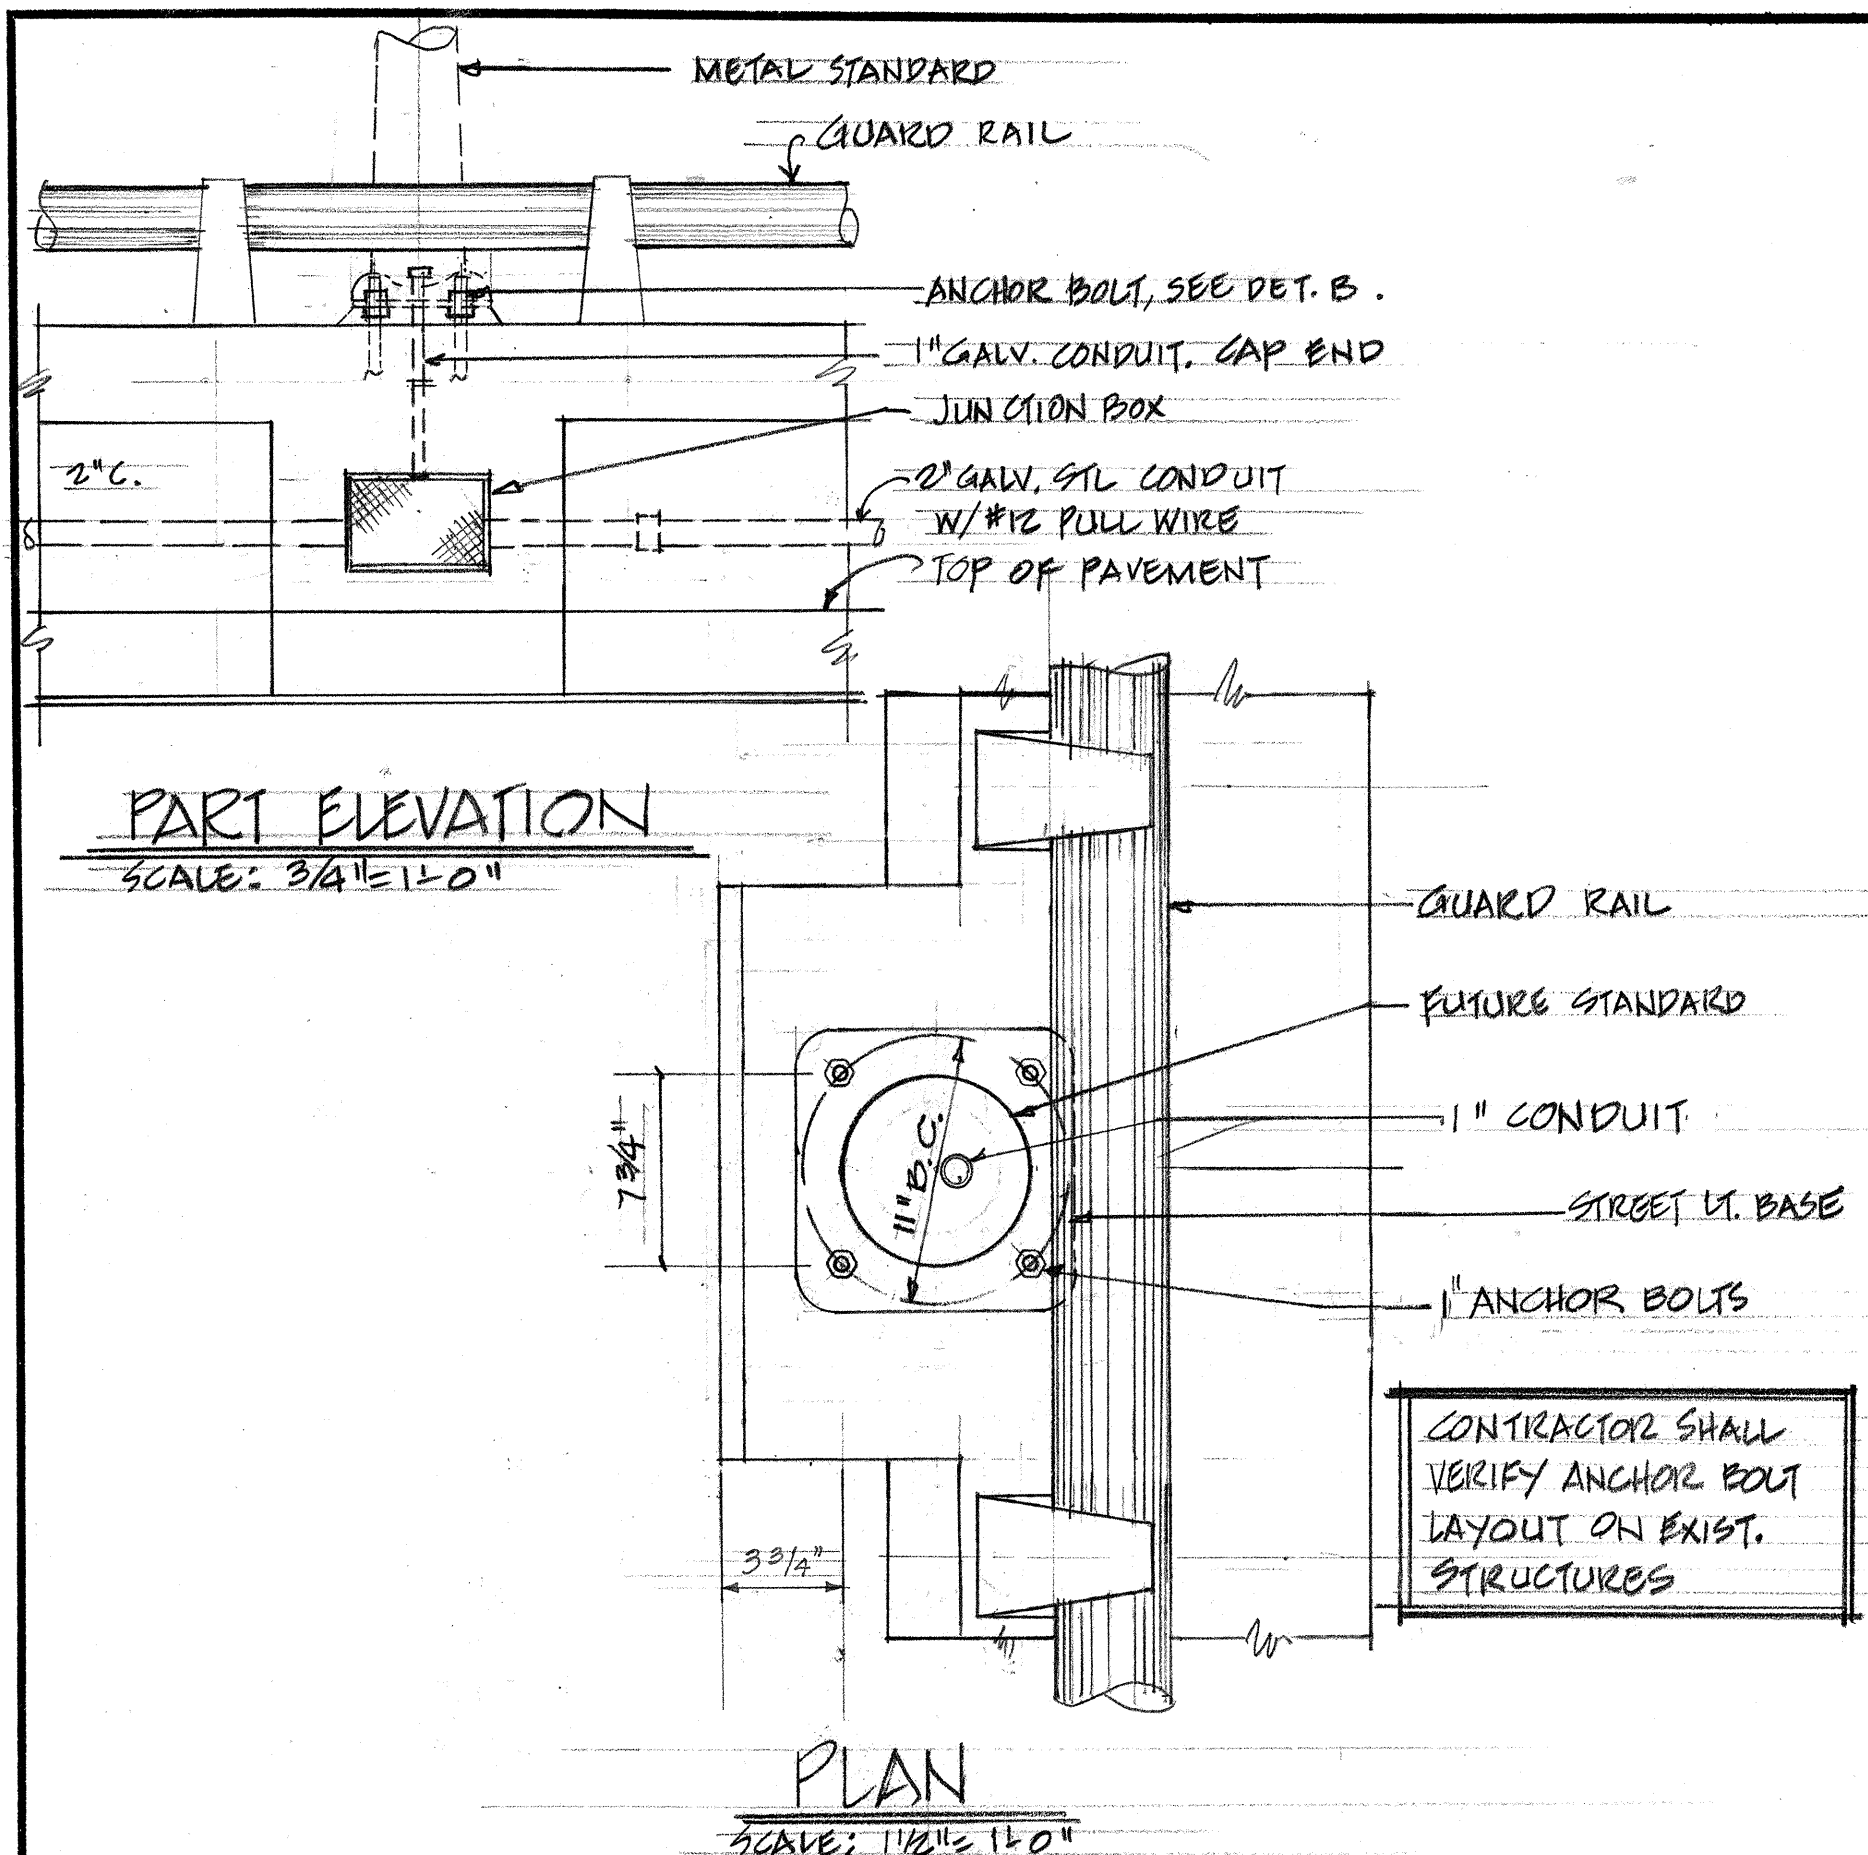


THIS WORK WAS PREPARED BY ME OR UNDER MY SUPERVISION
Albert S. C. Chong
 Albert S. C. Chong, PE

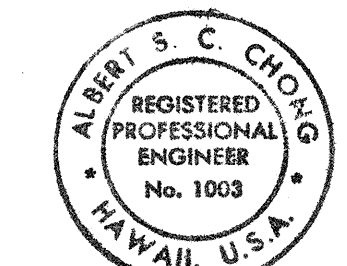


STATE OF HAWAII
 DEPARTMENT OF TRANSPORTATION
 HIGHWAYS DIVISION

PEARL CITY VIADUCT
 LIGHTING DETAILS
 INTERSTATE ROUTE H-1
 F.A.I. Proj. No I-HI-1(68)10
 Scale: As Noted


FED. ROAD DIST. NO.	STATE	FED. AID PROJ. NO.	FISCAL YEAR	SHEET NO.	TOTAL SHEETS
HAWAII	HAW.	I-H-1(68)10	1969	83A	91

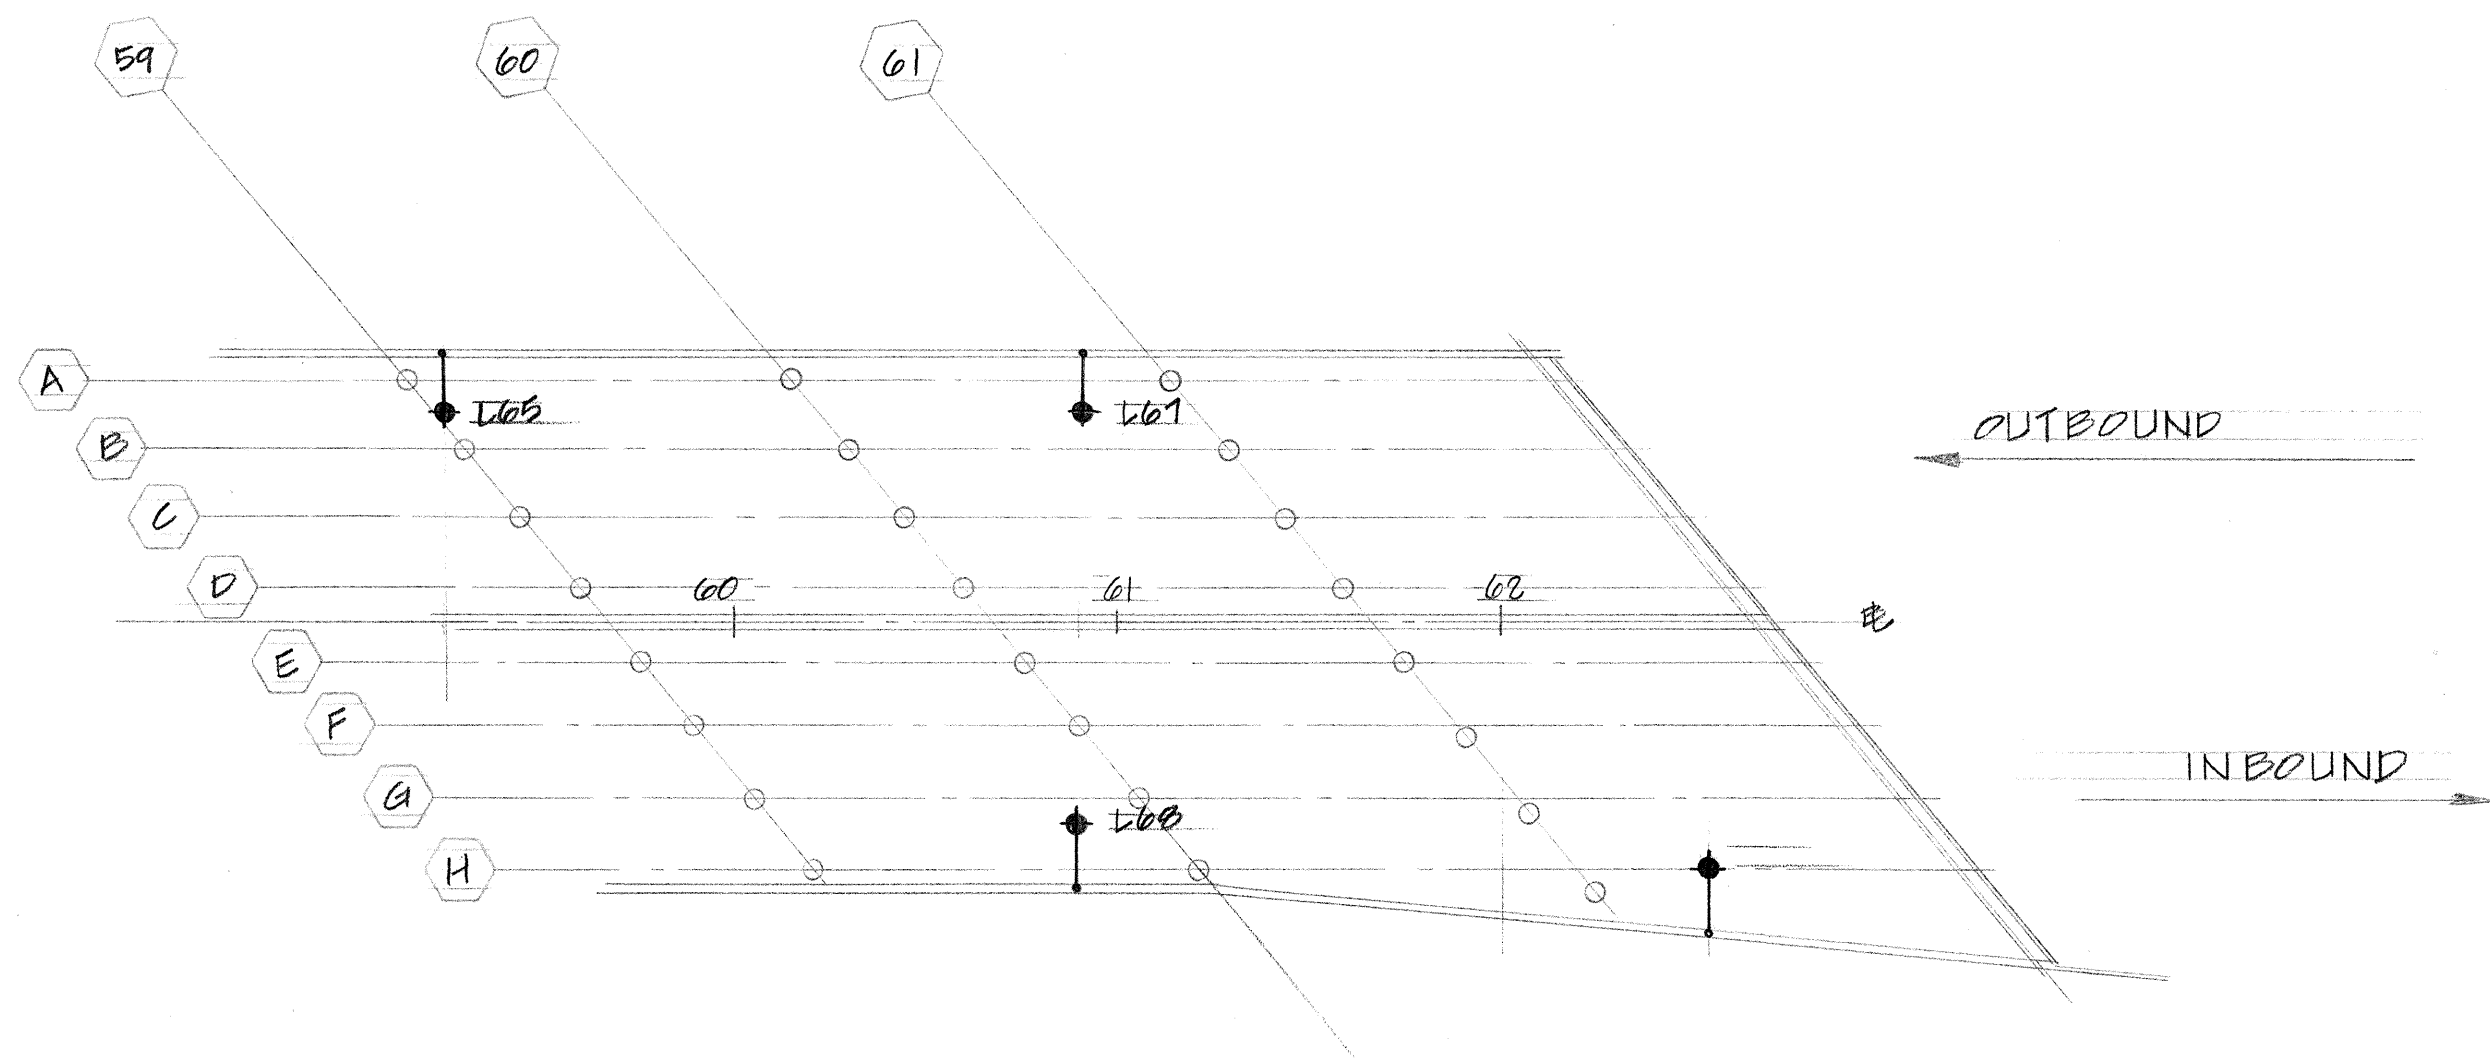

PART. PLAN OF VIADUCT
SCALE: 1" = 50'-0"

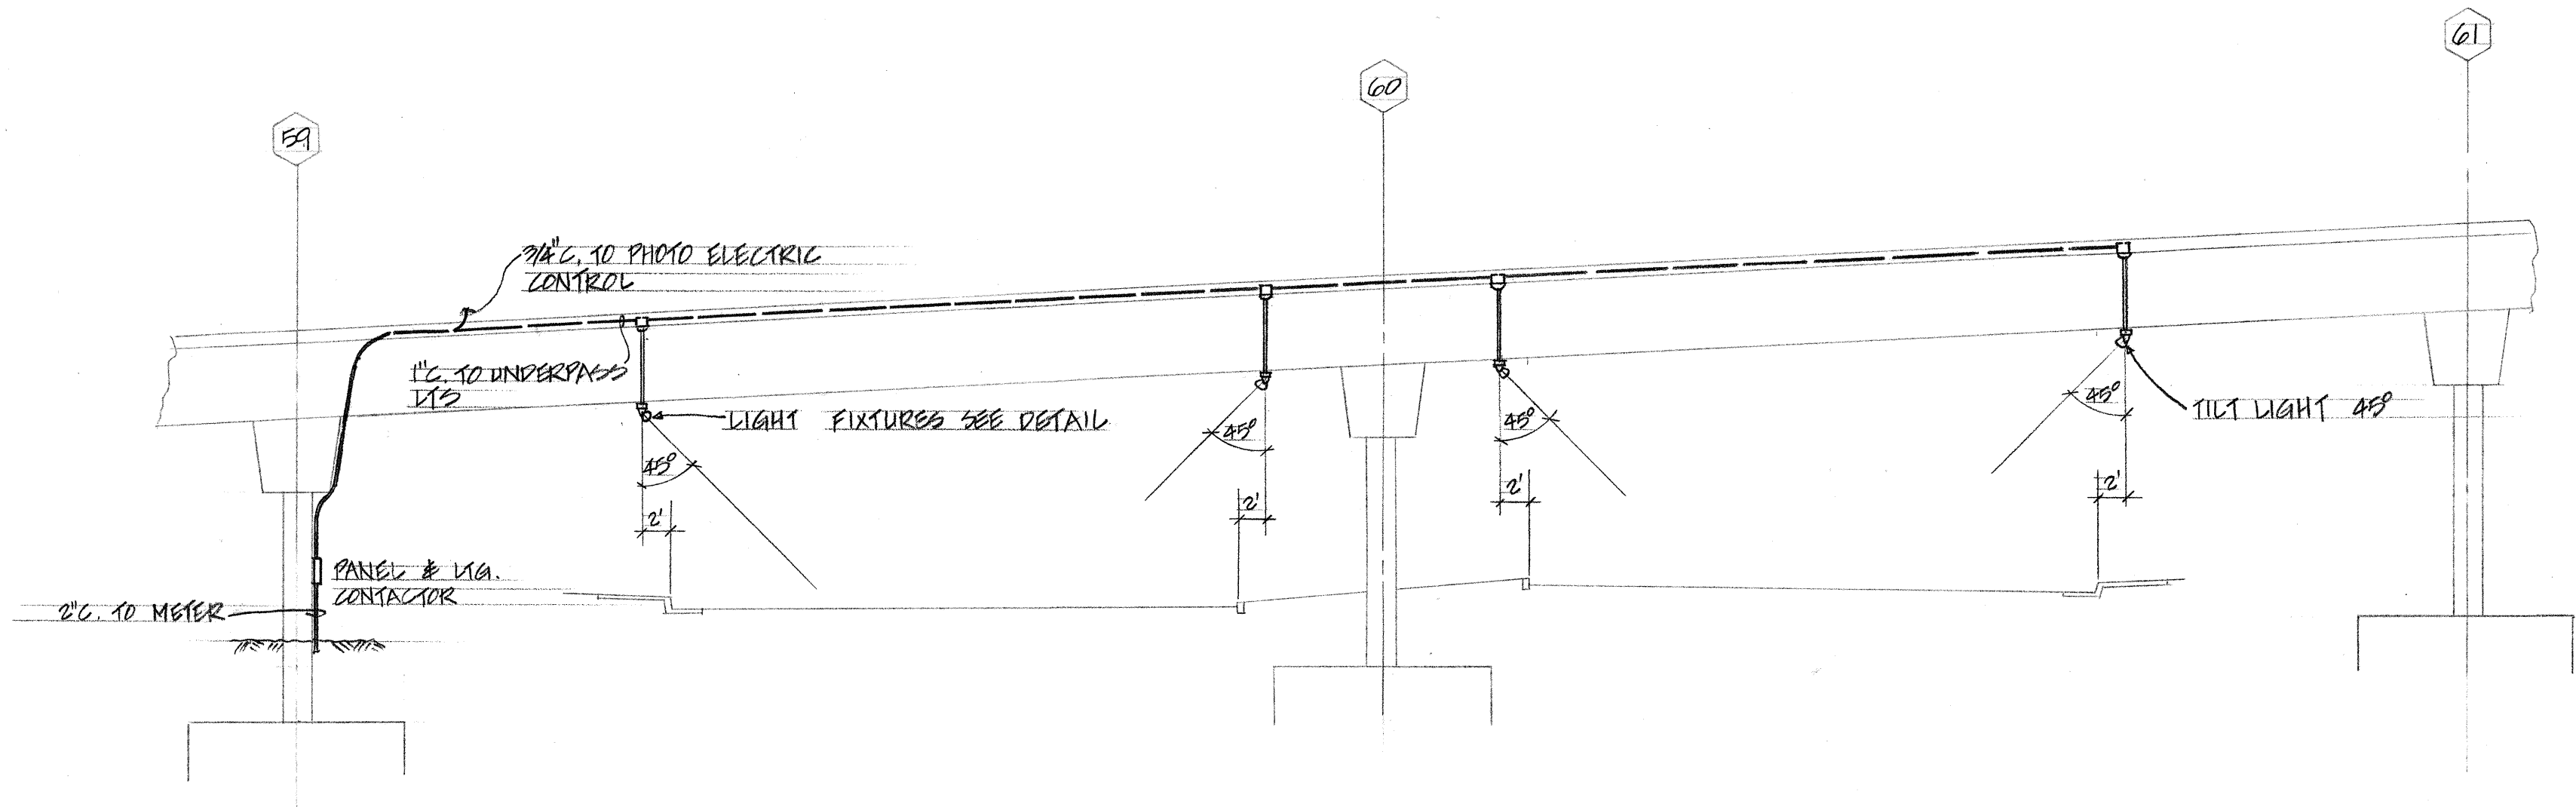


SECTION THRU KAMEHAMEHA HWY
SCALE: 1" = 10'-0"

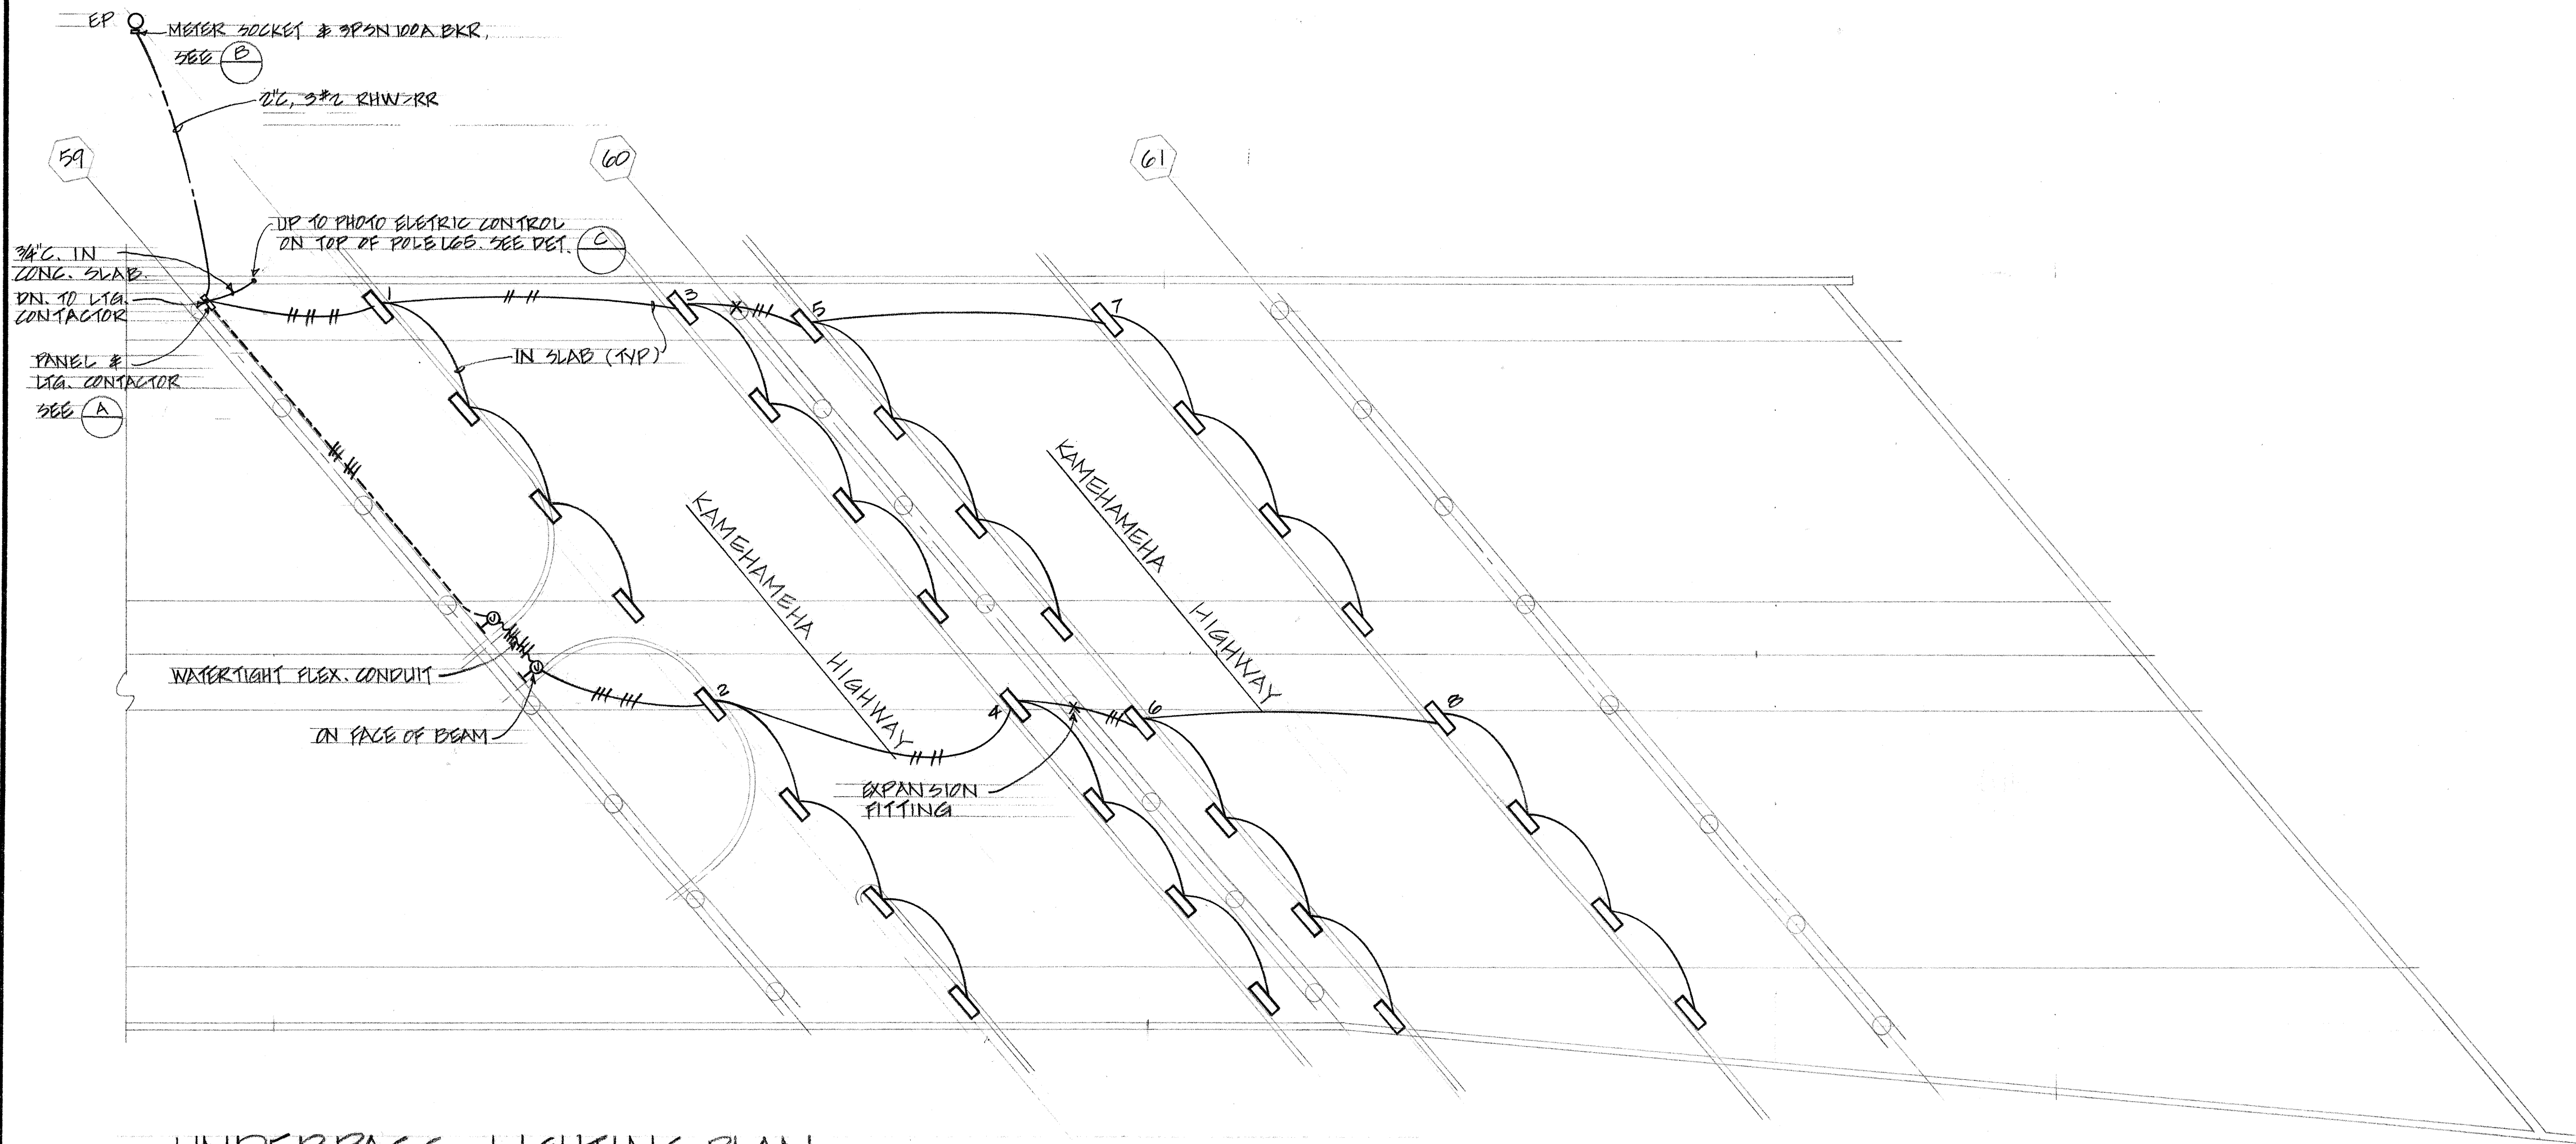

UNDERPASS LIGHTING PLAN
SCALE: 1" = 20'-0"

THIS WORK WAS PREPARED BY ME
OR UNDER MY SUPERVISION
Albert S. C. Chong
Albert S. C. Chong, PE

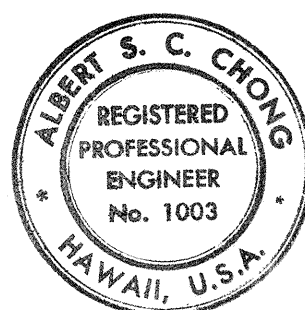

STATE OF HAWAII
DEPARTMENT OF TRANSPORTATION
HIGHWAYS DIVISION

PEARL CITY VIADUCT



INTERSTATE ROUTE H-1
F.A.I. Proj. No I-H-1(68)10
Scale: As Noted

SHEET No. OF SHEETS
83A 91

C O S S A
C O S S A

ORIGINAL PLAN	DATE
SURVEY PLOTTED BY	
DRAWN BY	
DESIGNED BY	
QUANTITIES BY	
CHECKED BY	
NOTE BOOK	
No.	

FED. ROAD DIST. NO.	STATE	FED. AID PROJ. NO.	FISCAL YEAR	SHEET NO.	TOTAL SHEETS
HAWAII	HAW.	I-HI-1(66)10	1969	838	91

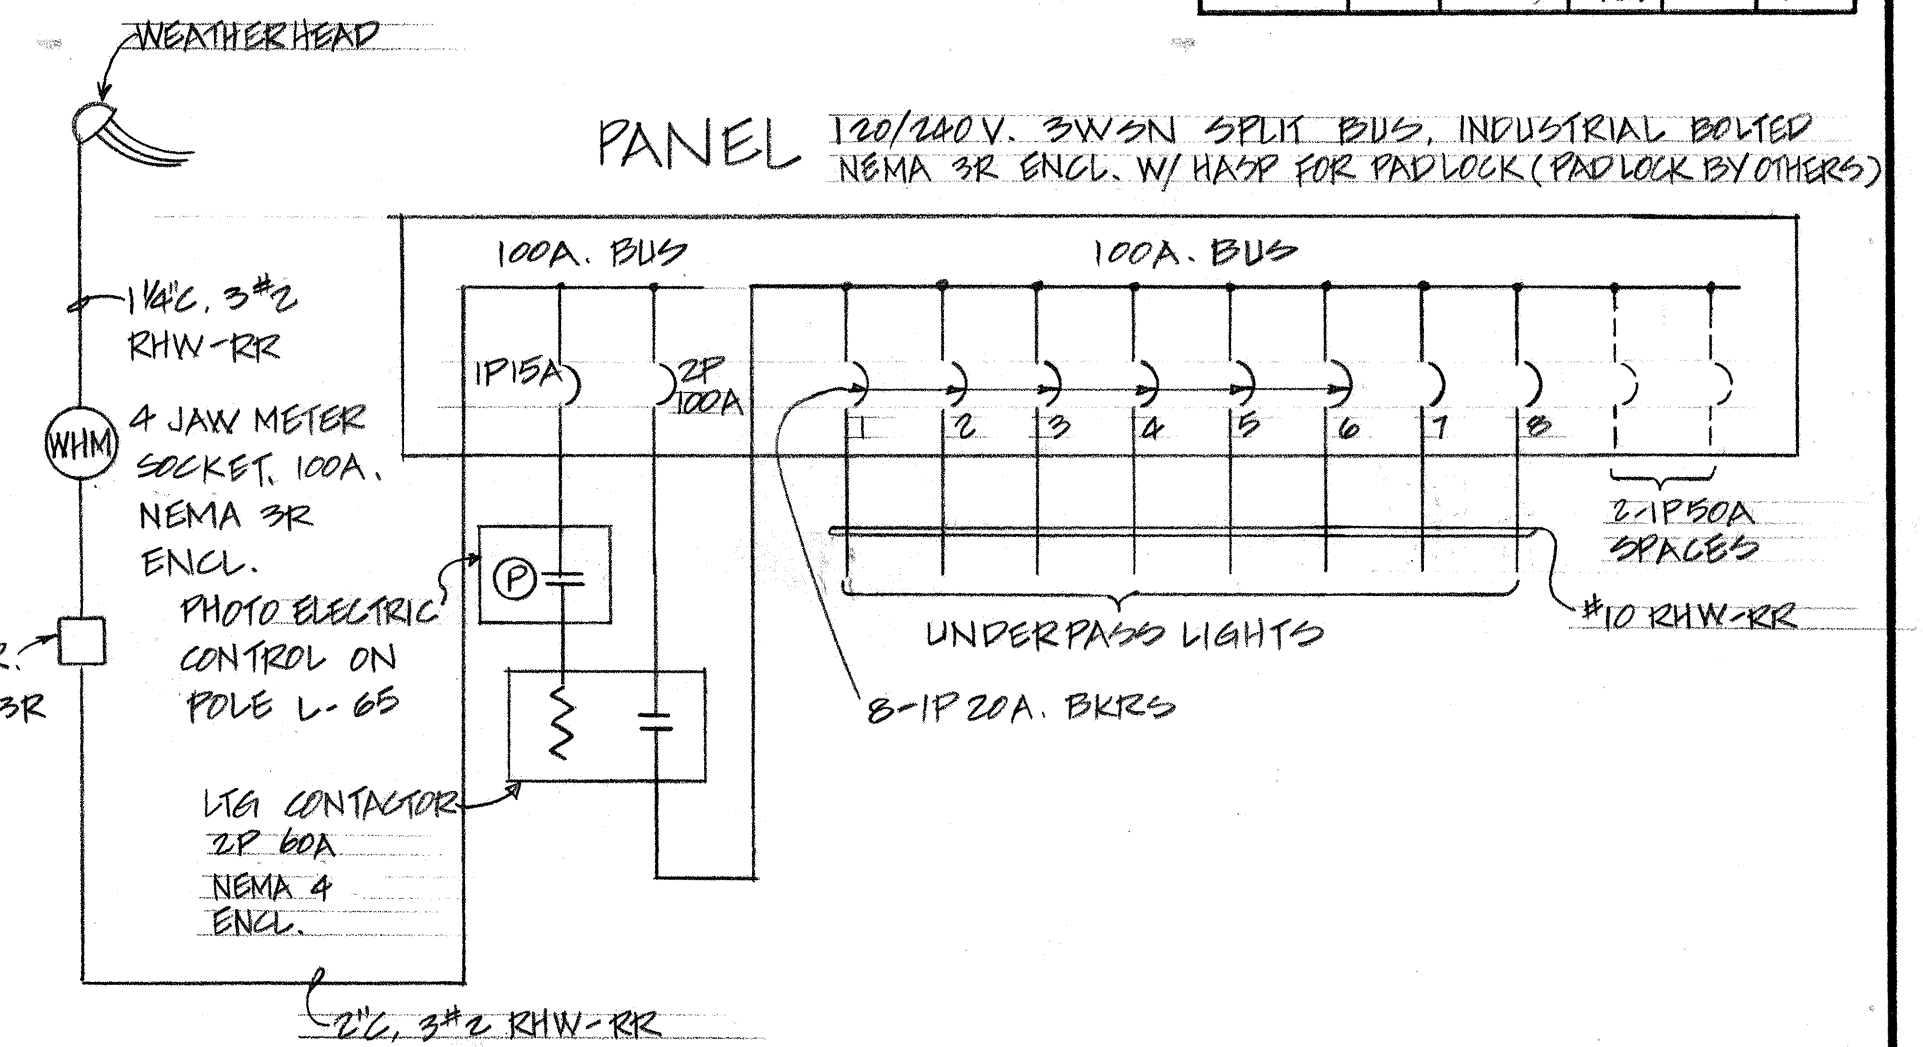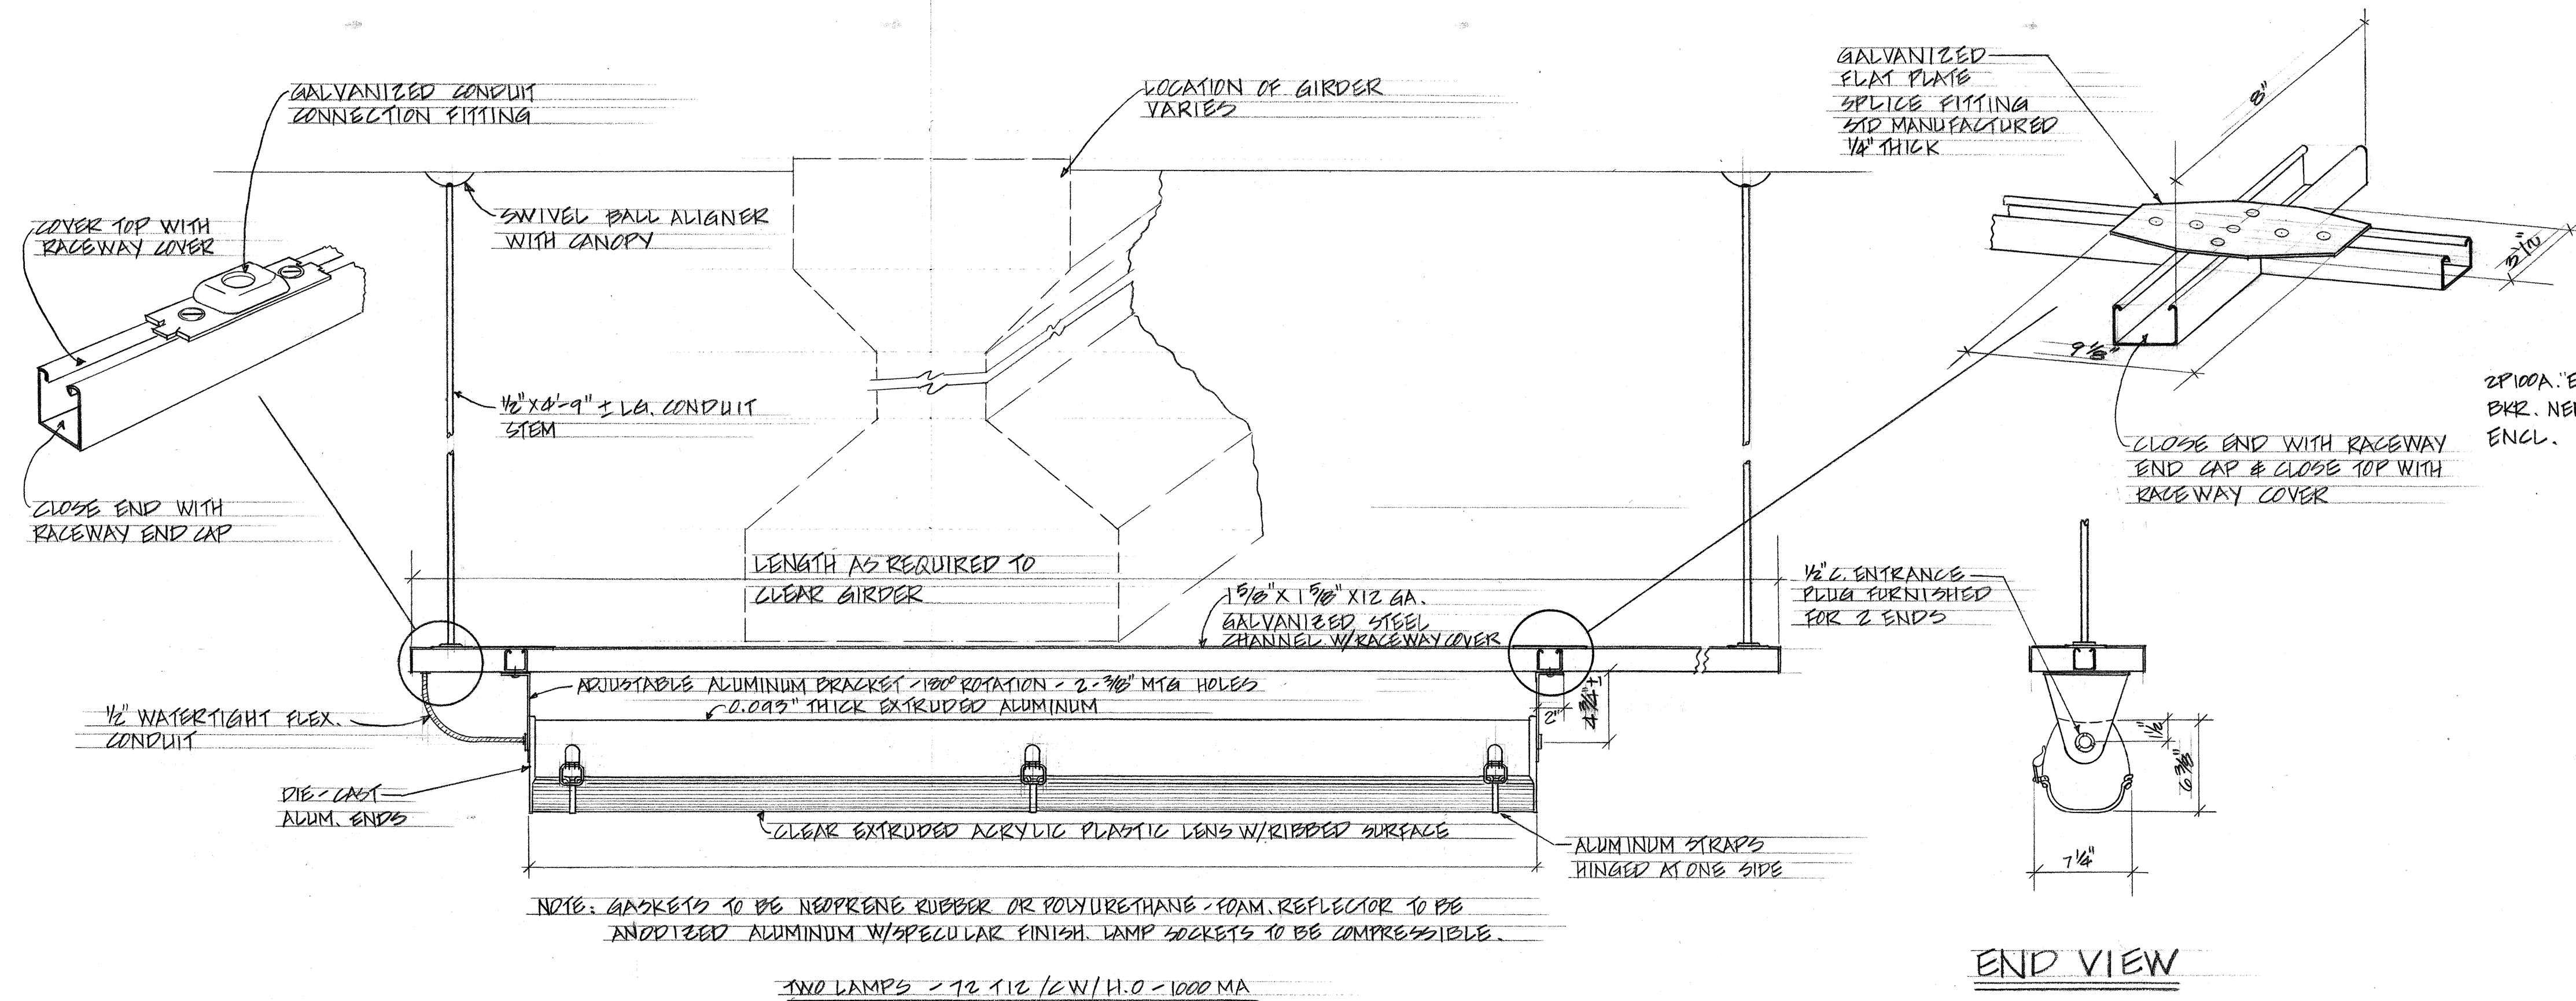


SINGLE LINE DIAGRAM

END VIEW

FIXTURE DETAIL-KAMEHAMEHA HWY UNDERPASS

NTS

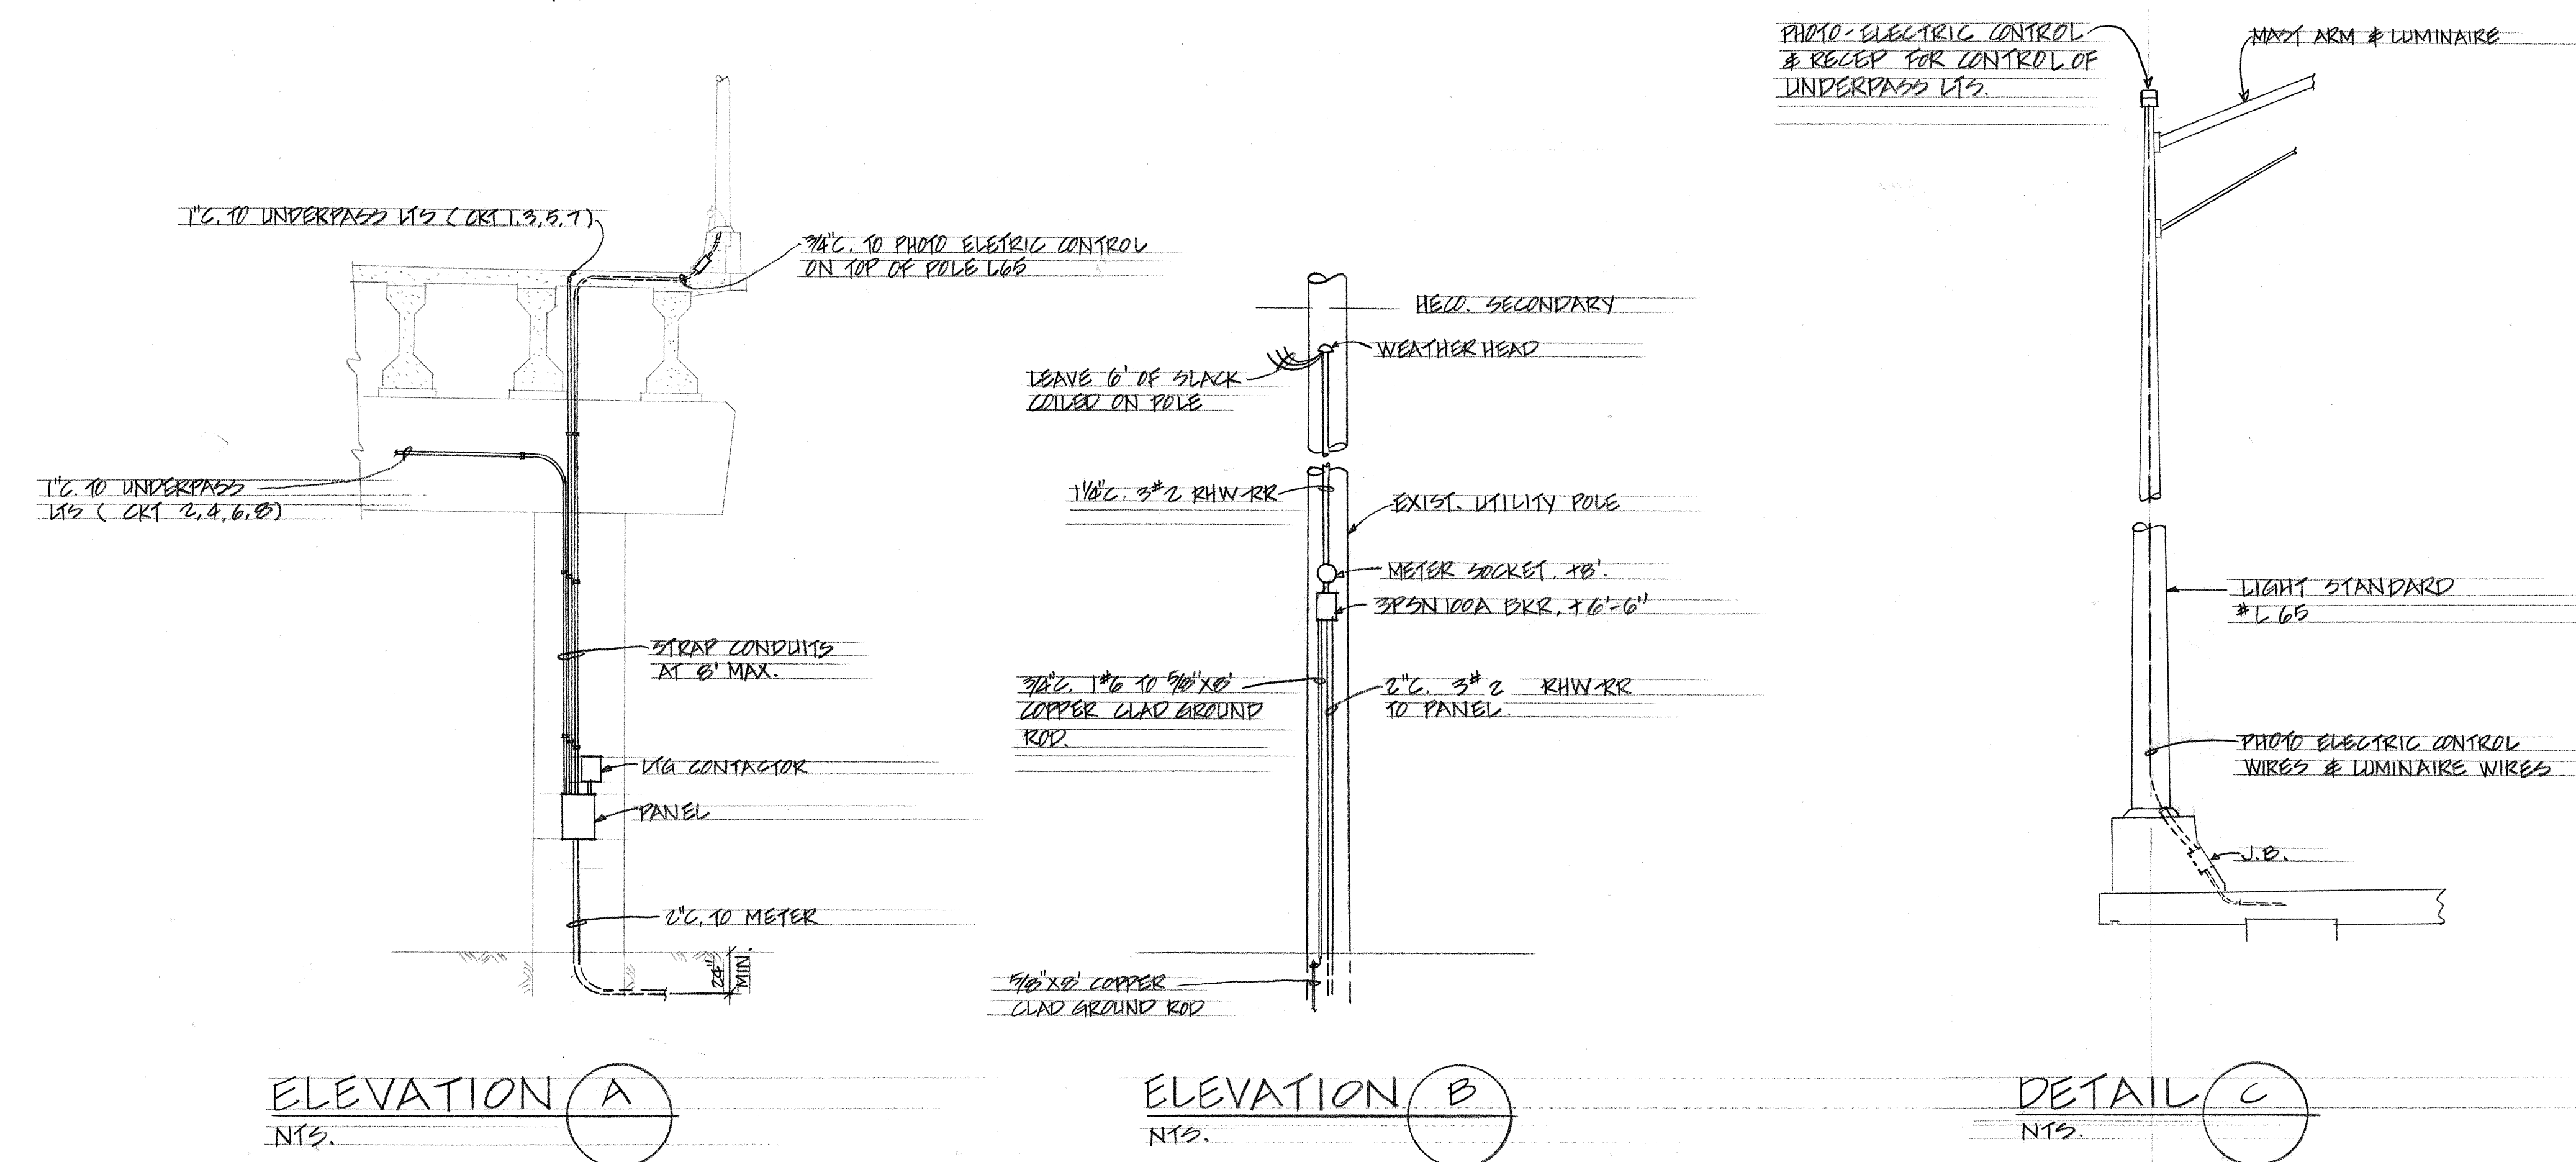

ELEVATION

ELEVATION (

DETAIL C

THIS WORK WAS PREPARED BY ME
OR UNDER MY SUPERVISION
Albert S. C. Chong
Albert S. C. Chong, PE

STATE OF HAWAII
DEPARTMENT OF TRANSPORTATION
HIGHWAYS DIVISION

PEARL CITY VIADUCT

INTERSTATE ROUTE H-1
F.A.I. Proj. No I-H1-1 (GB) 10
Scale: As Noted

SHEET No. OF SHEETS

C O S 3 1 3

CO 83B