


FED. ROAD DIST. NO.	STATE	FED. AID PROJ. NO.	FISCAL YEAR	SHEET NO.	TOTAL SHEETS
HAWAII	HAW.	I-H-1(66):10 I-H-1(67):10	1970	40	87

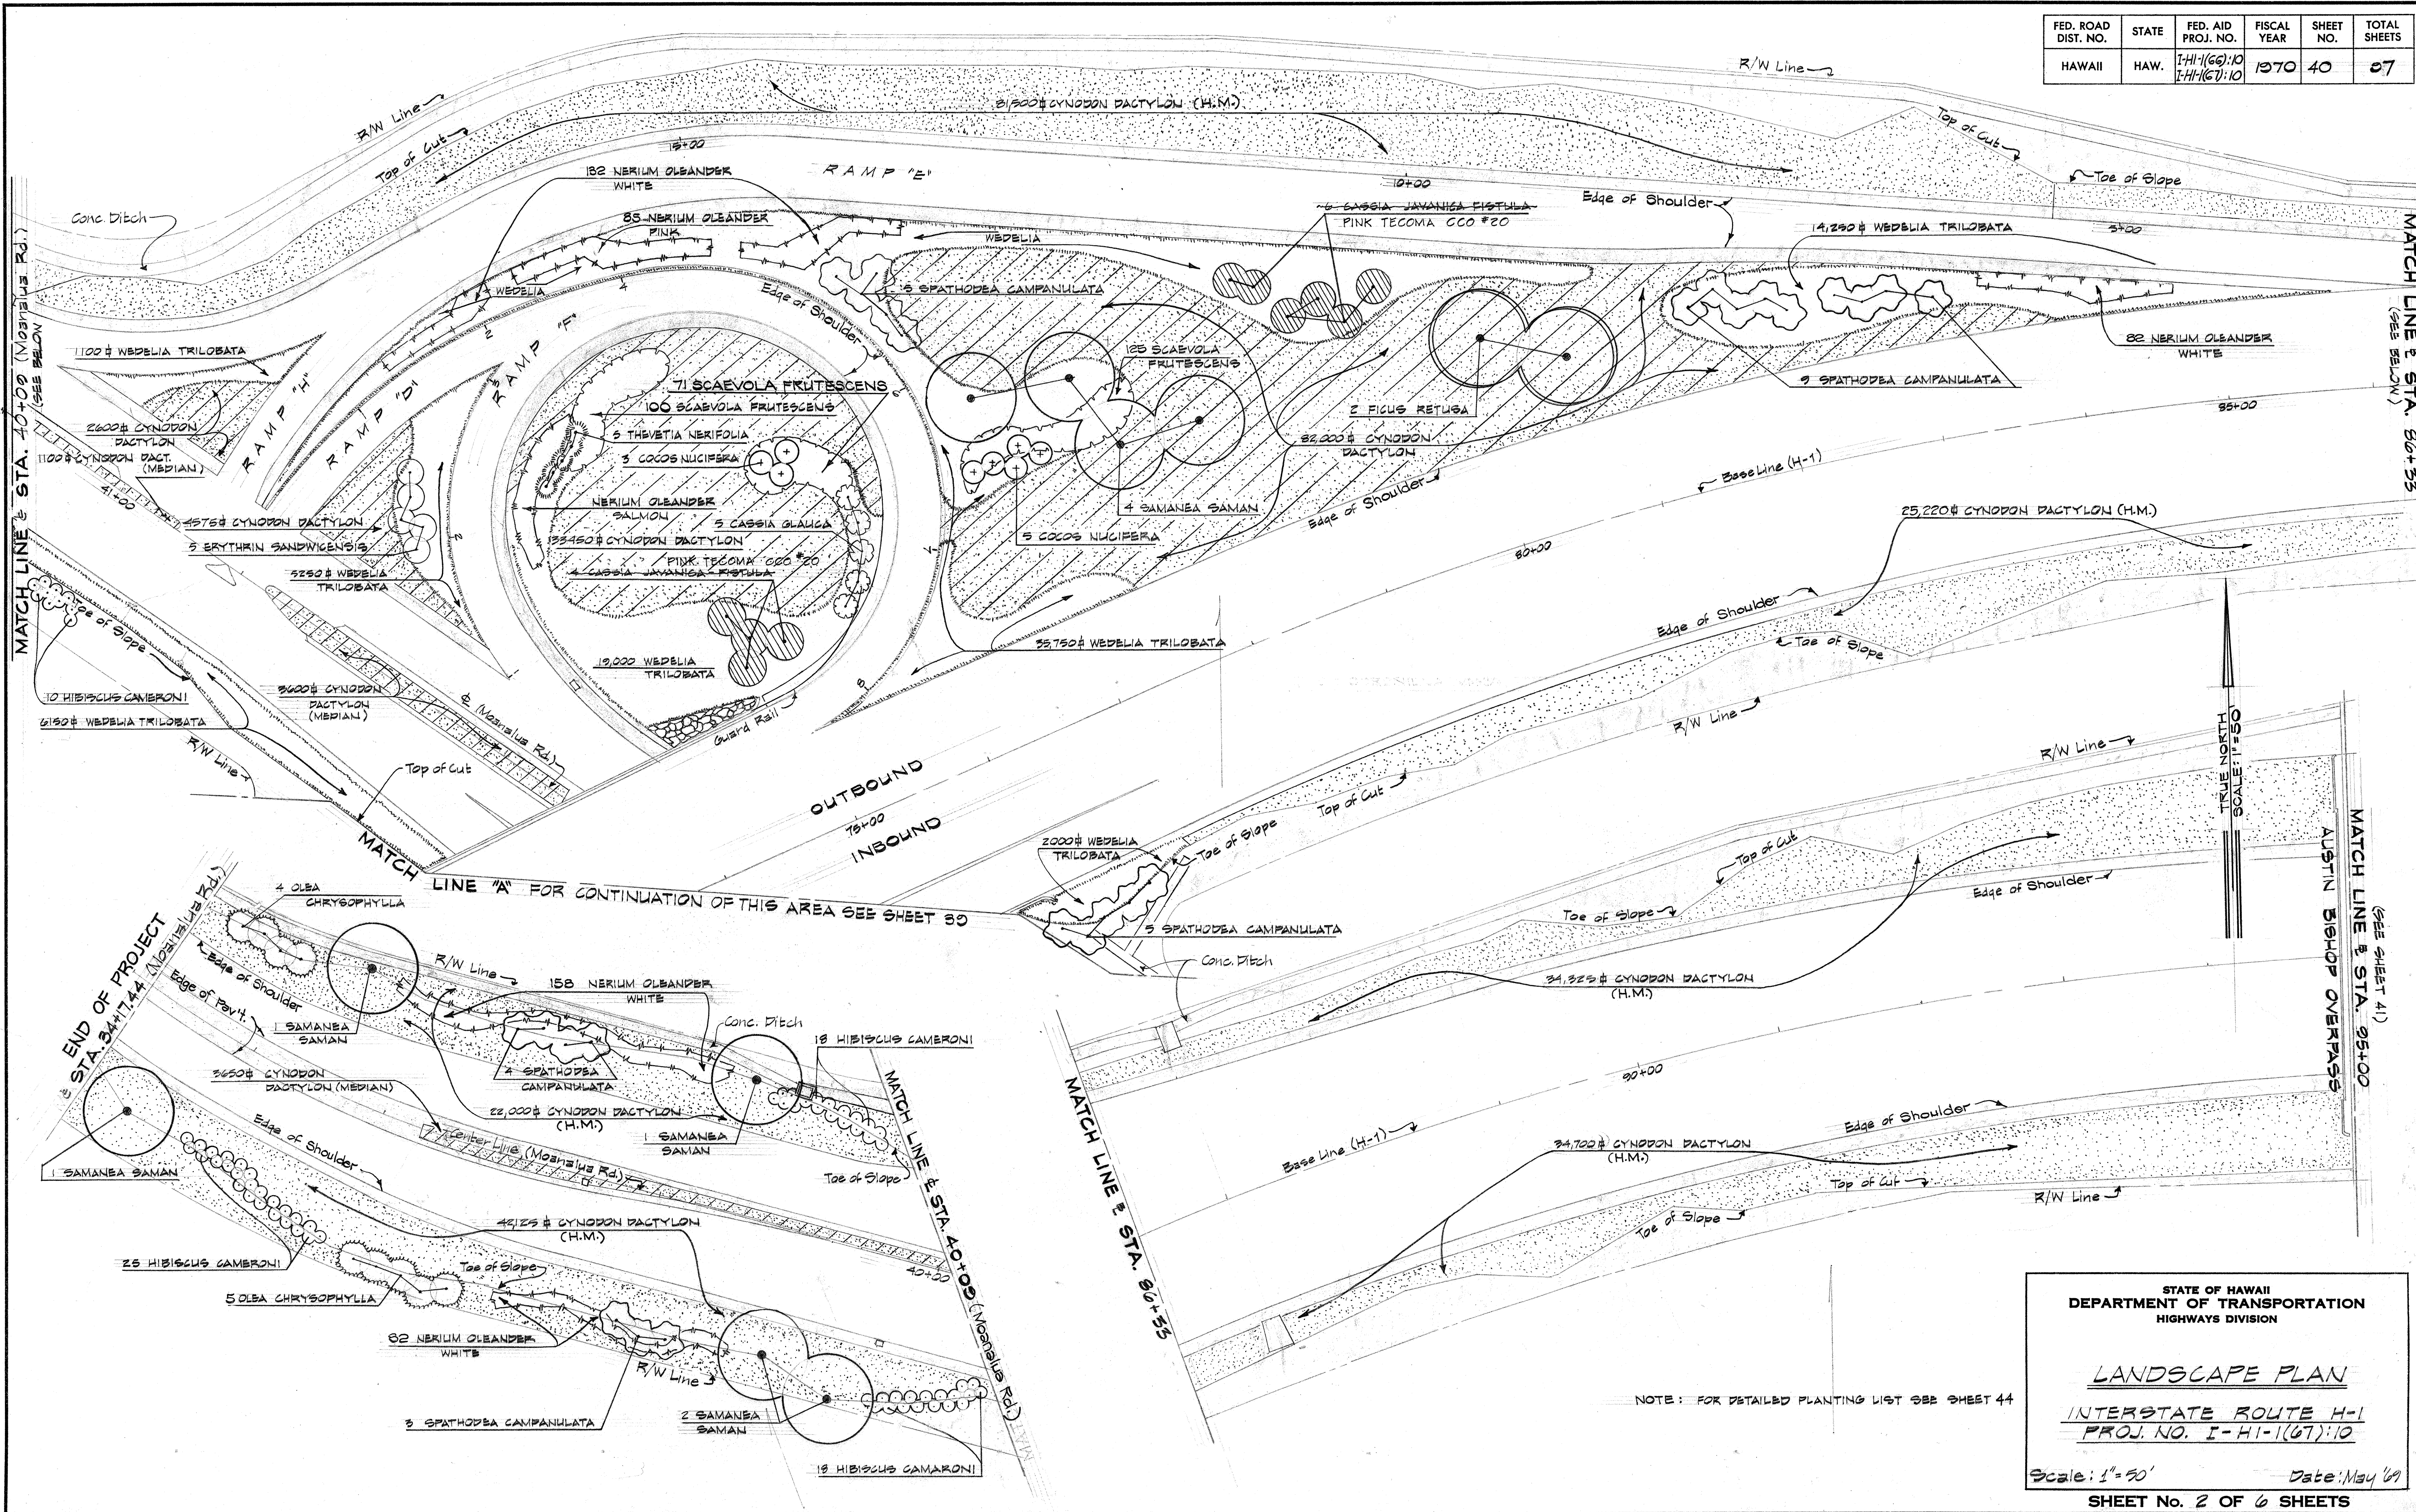

DATE	
ORIGINAL PLAN	
DESIGNED BY	
CHECKED BY	
NO.	

STATE OF HAWAII
DEPARTMENT OF TRANSPORTATION
HIGHWAYS DIVISION

LANDSCAPE PLAN

INTERSTATE ROUTE H-1
PROJ. NO. I-H-1(67):10


Scale: 1" = 50' Date: May '69

SHEET No. 2 OF 6 SHEETS


FED. ROAD DIST. NO.	STATE	FED. AID PROJ. NO.	FISCAL YEAR	SHEET NO.	TOTAL SHEETS
HAWAII	HAW.	I-H-1(66):10 I-H-1(67):10	1970	41	07

TRIM NOTES
SCALE 1"=50'

MATCH LINE @ STA. 95+00

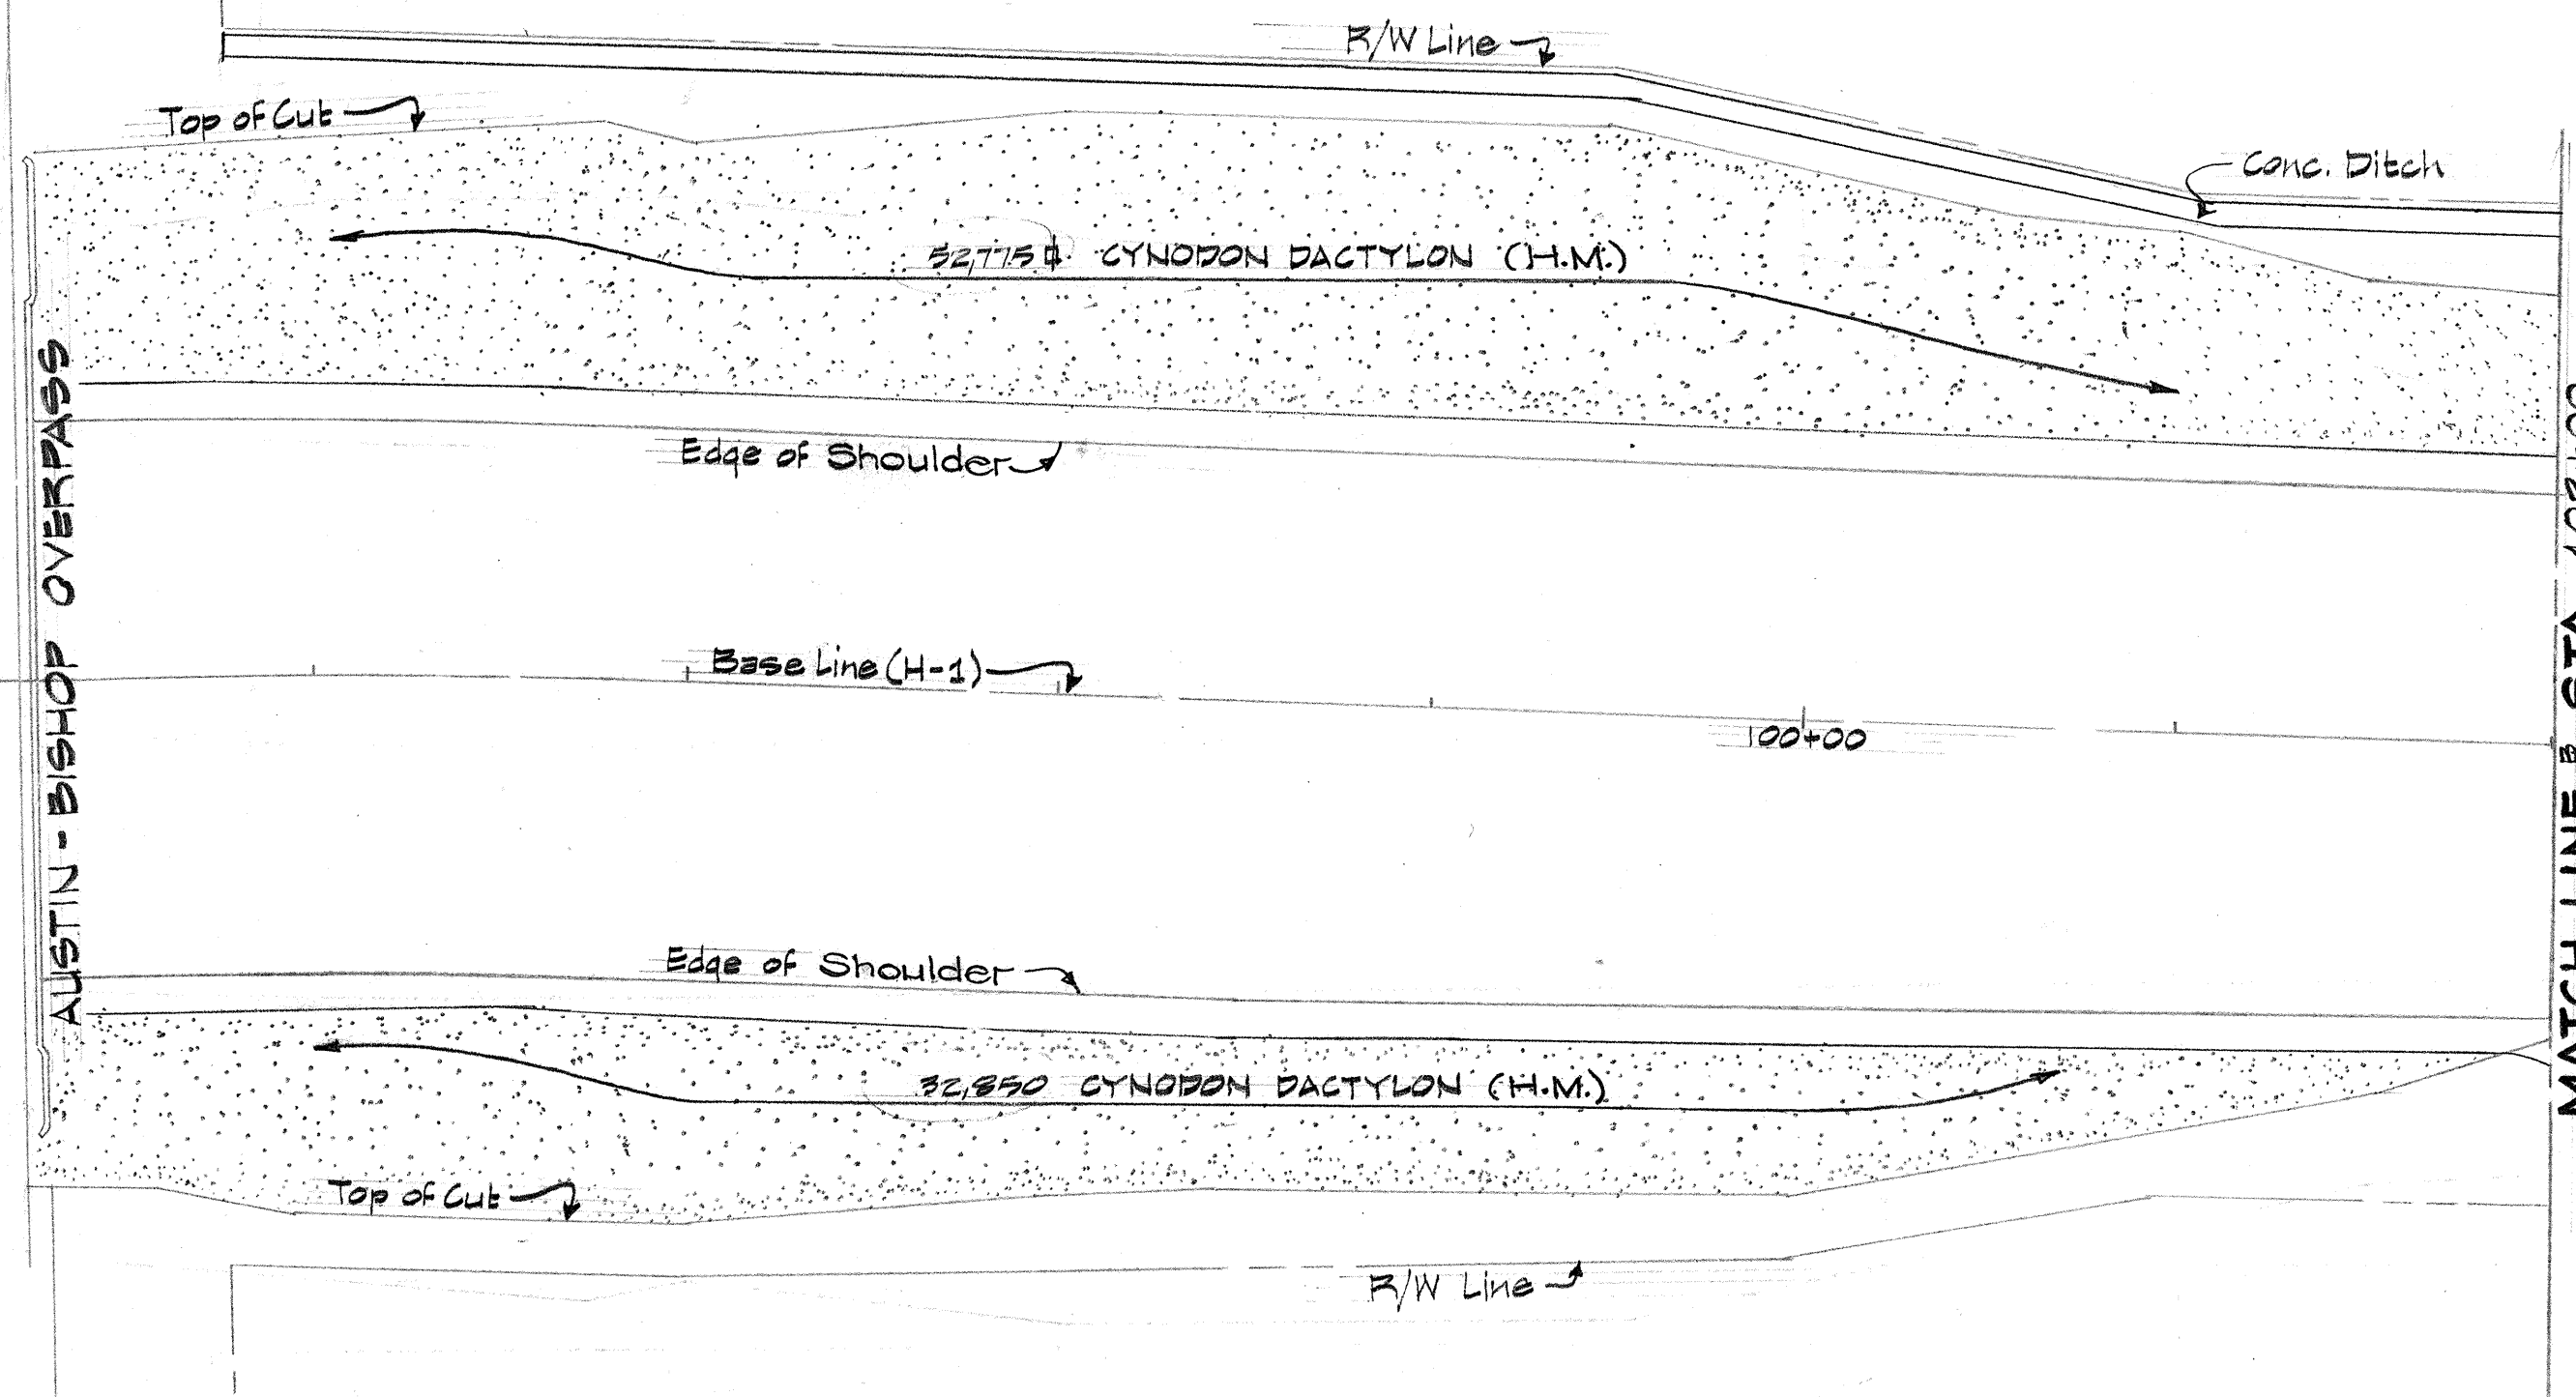

MATCH LINE @ STA. 102+00

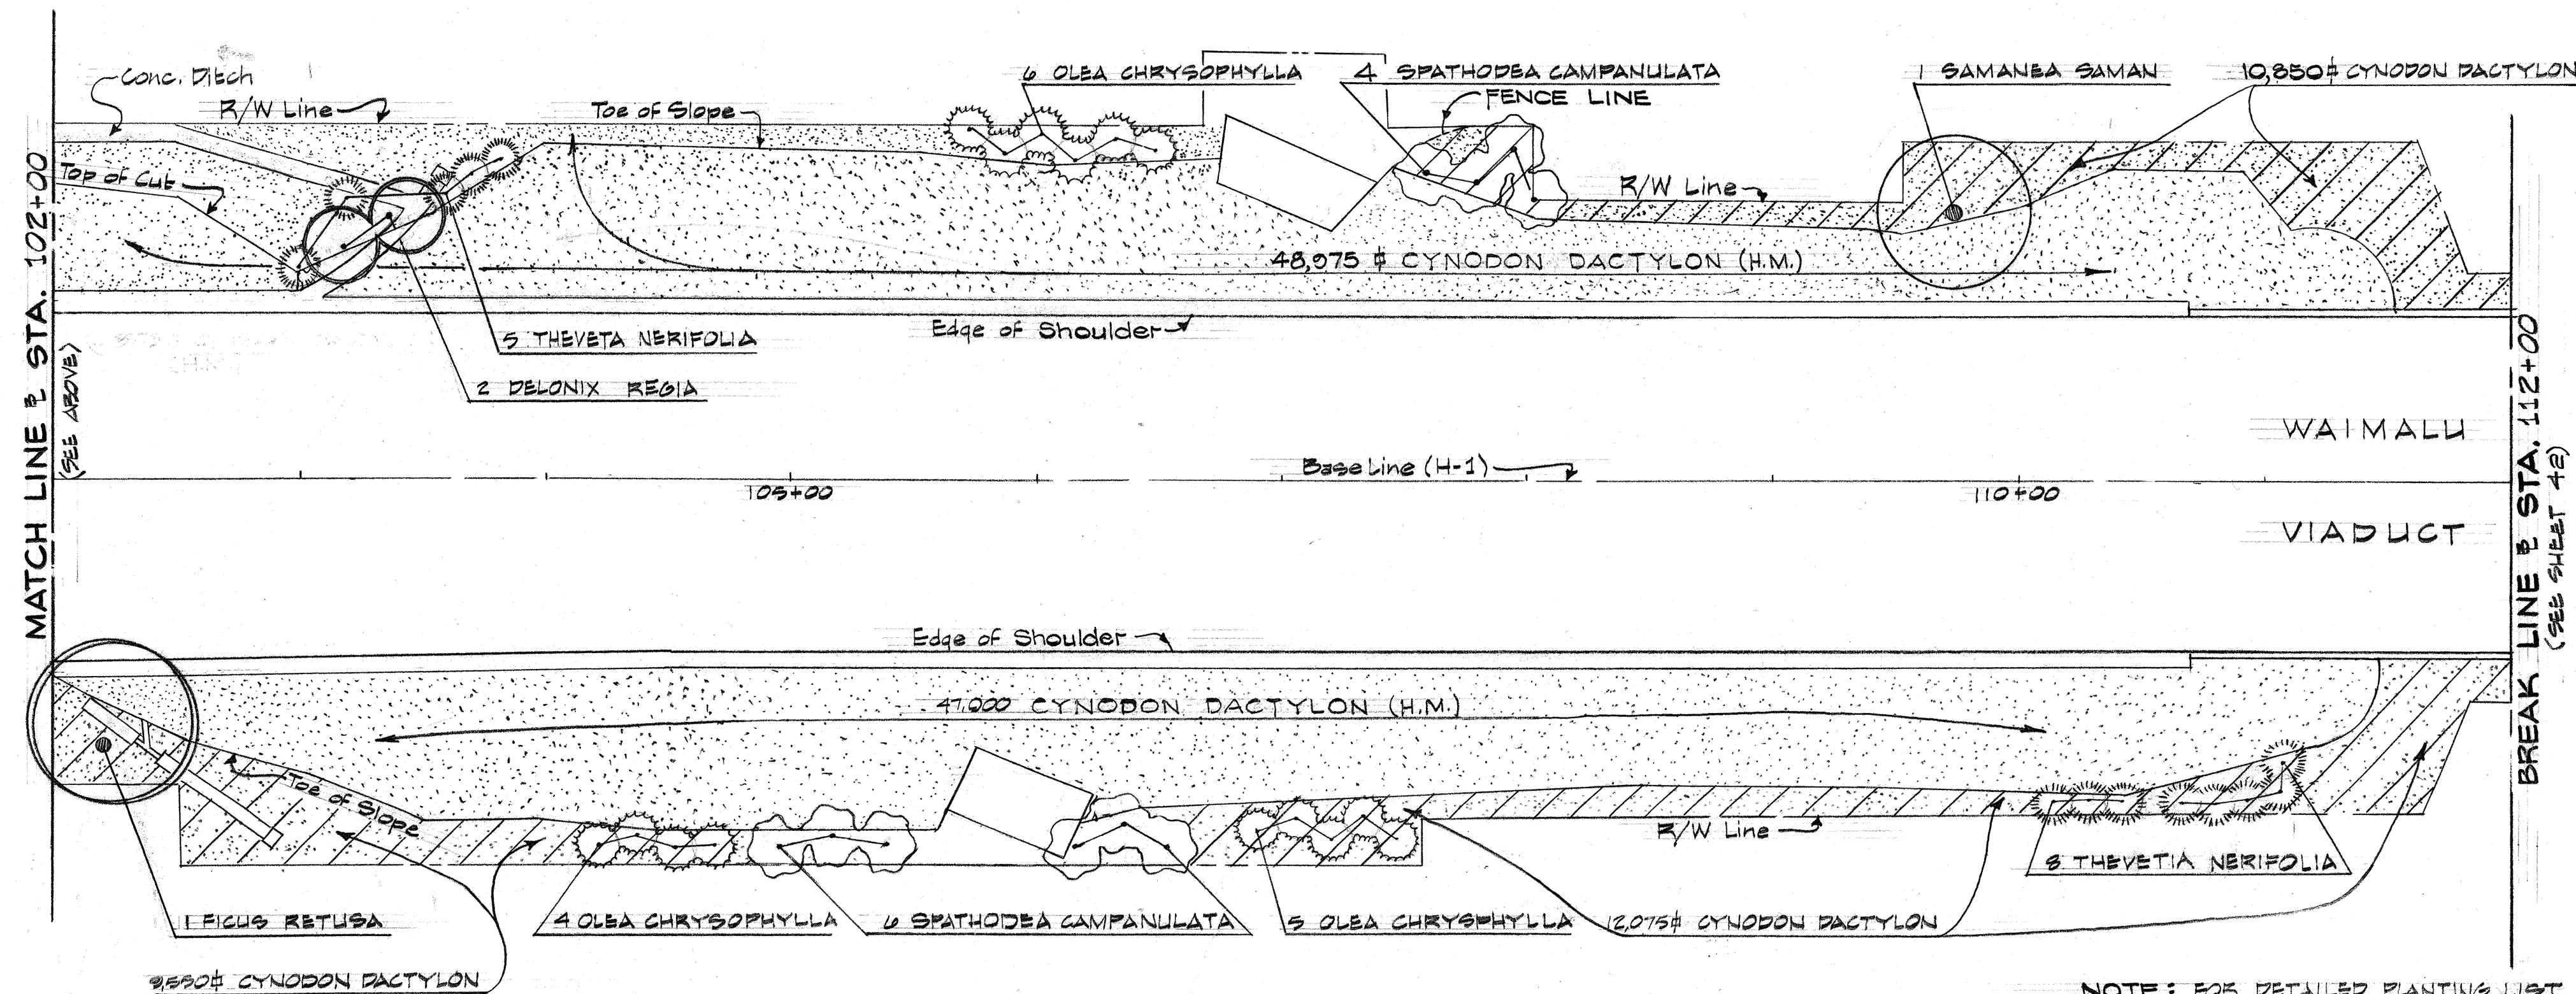

BREAK LINE @ STA. 112+00
(SEE SHEET 42)

NOTE: FOR DETAILED PLANTING LIST, SEE SHEET 44

STATE OF HAWAII
DEPARTMENT OF TRANSPORTATION
HIGHWAYS DIVISION


LANDSCAPE PLAN

INTERSTATE ROUTE H-1
PROJ. NO. I-H-1(67):10

Scale: 1"=50' Date: May '69

SHEET No. 3 OF 6 SHEETS

FED. ROAD DIST. NO.	STATE	FED. AID PROJ. NO.	FISCAL YEAR	SHEET NO.	TOTAL SHEETS
HAWAII	HAW.	IHI-1(67):10 IHI-1(67):10	1970	42	97

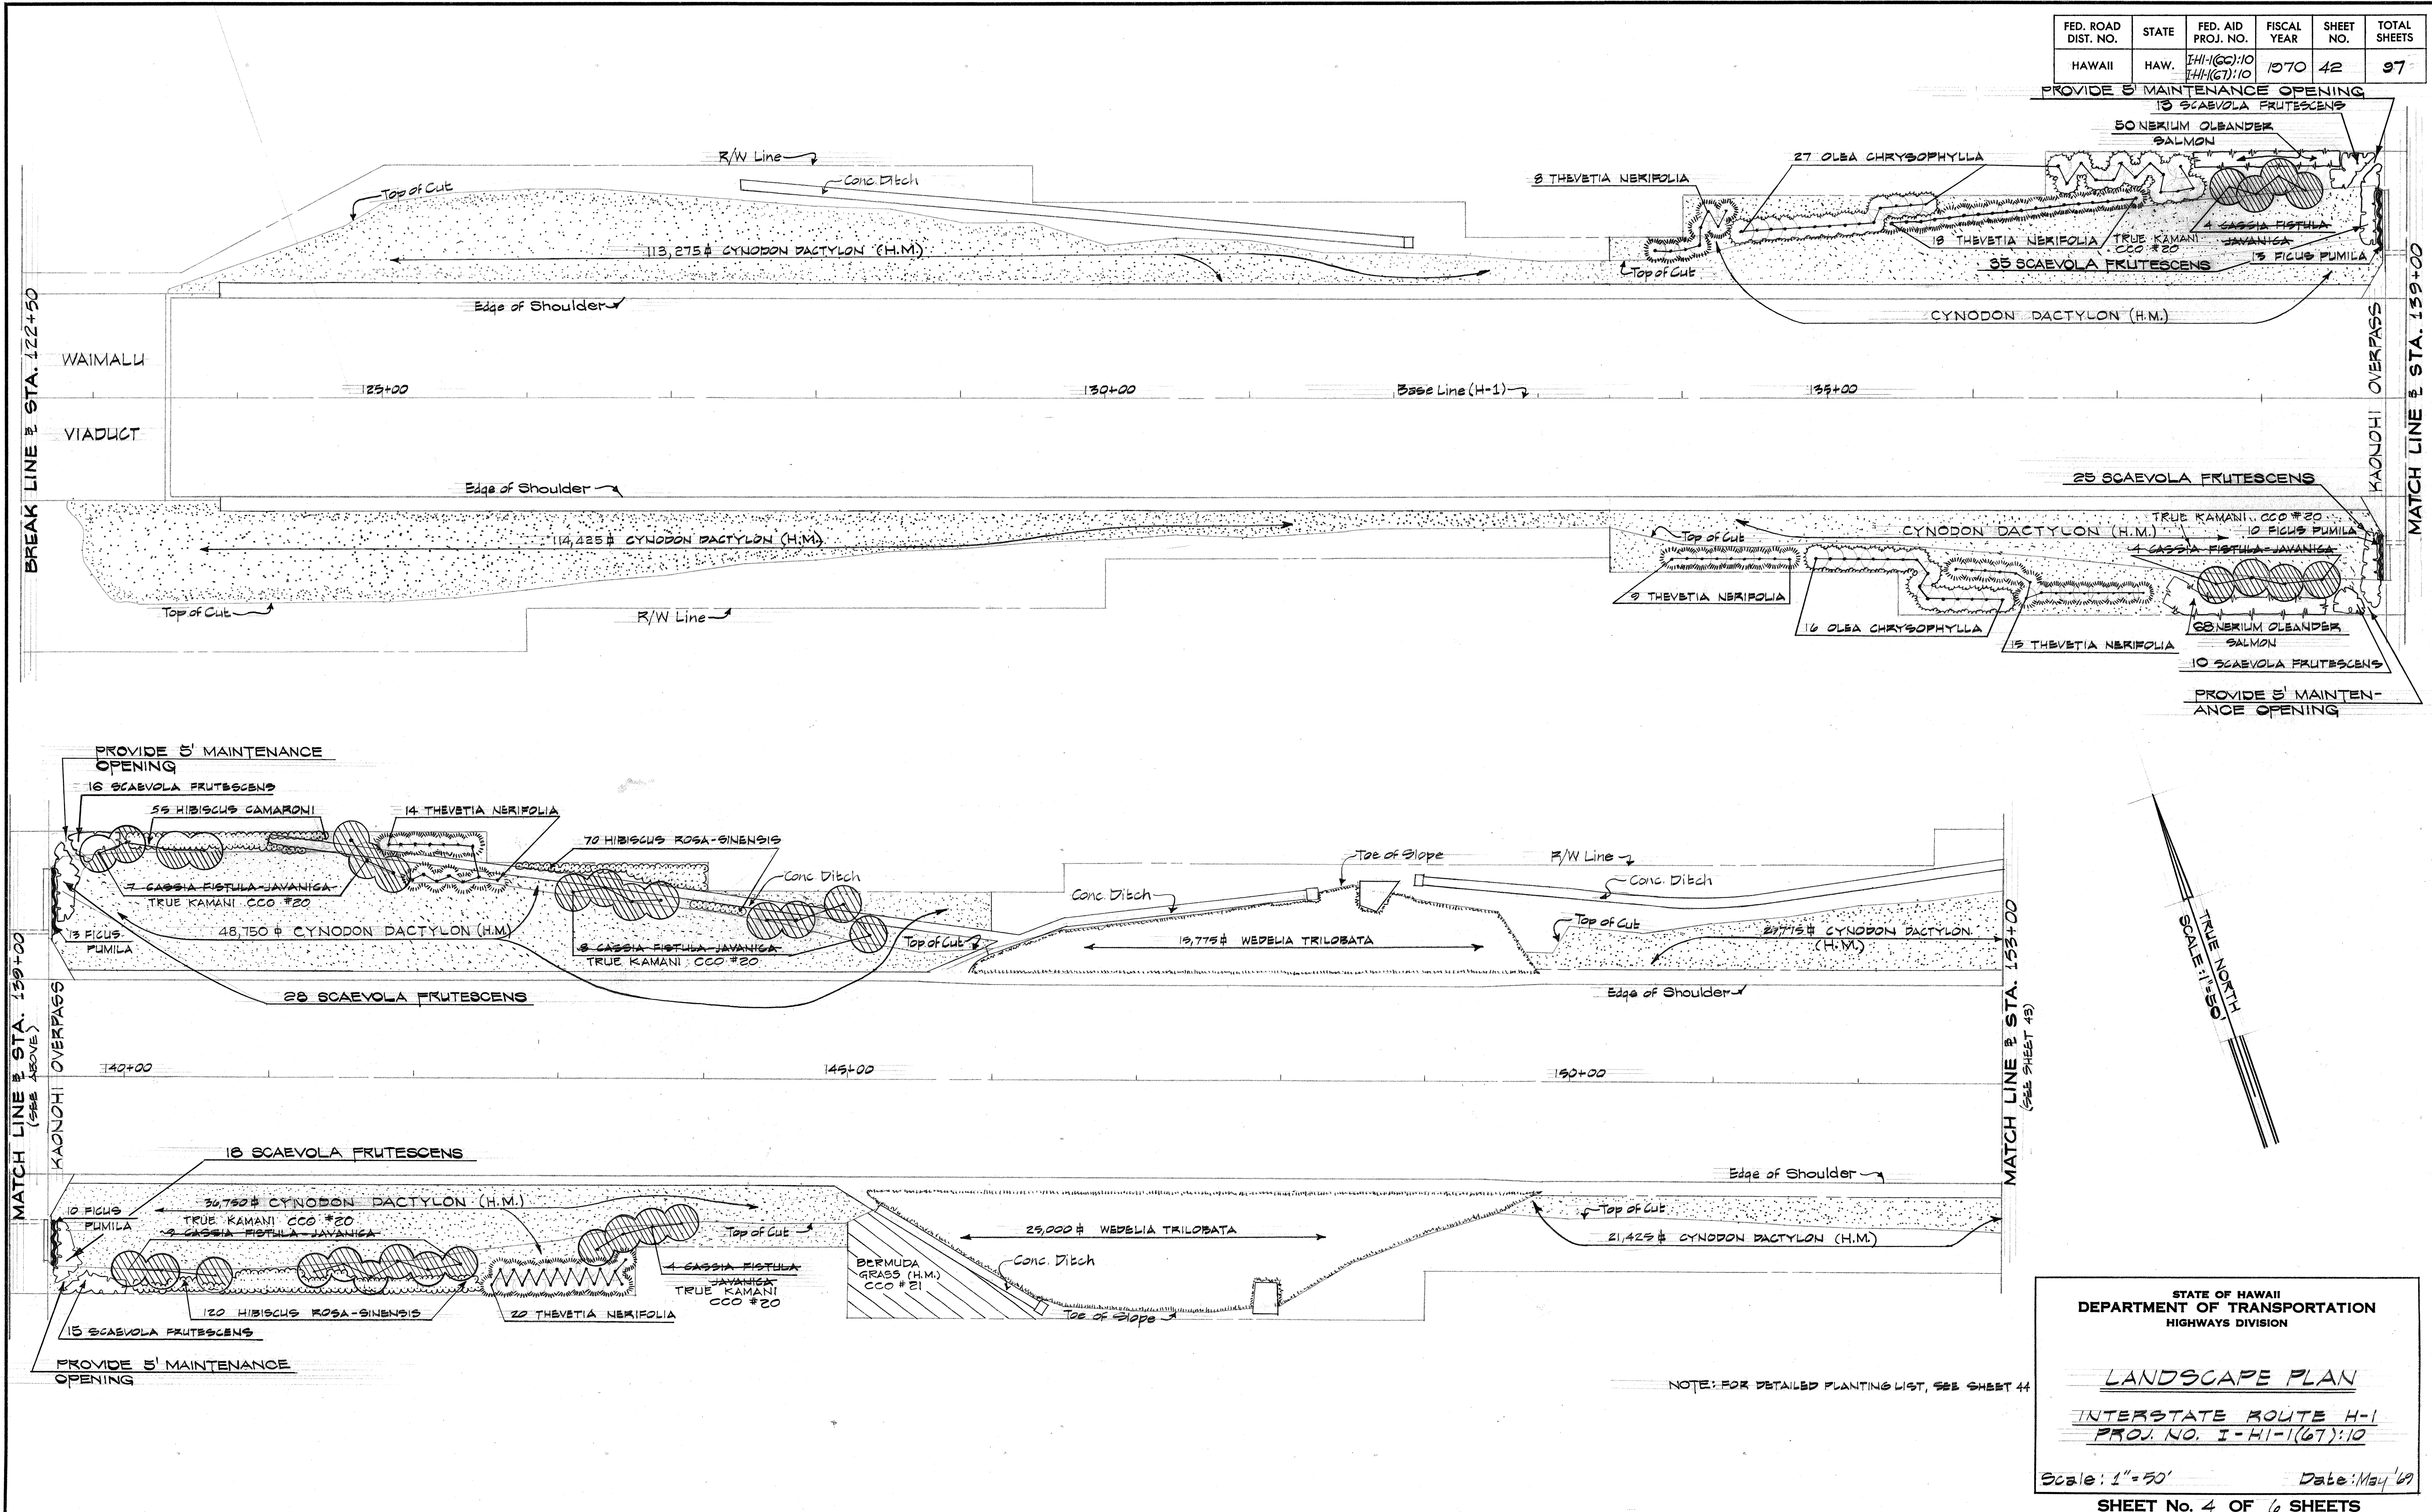

DATE	
SURVEY PLOTTED BY	
ORIGINAL PLAN	
DRAWN BY	
DESIGNED BY	
CHECKED BY	
NO.	

STATE OF HAWAII
DEPARTMENT OF TRANSPORTATION
HIGHWAYS DIVISION


LANDSCAPE PLAN

INTERSTATE ROUTE H-1
PROJ. NO. I-H-1(67):10

Scale: 1"=50' Date: May '69

SHEET No. 4 OF 6 SHEETS

FED. ROAD DIST. NO.	STATE	FED. AID PROJ. NO.	FISCAL YEAR	SHEET NO.	TOTAL SHEETS
HAWAII	HAW.	IHI-1(66):10 IHI-1(67):10	1970	43	97

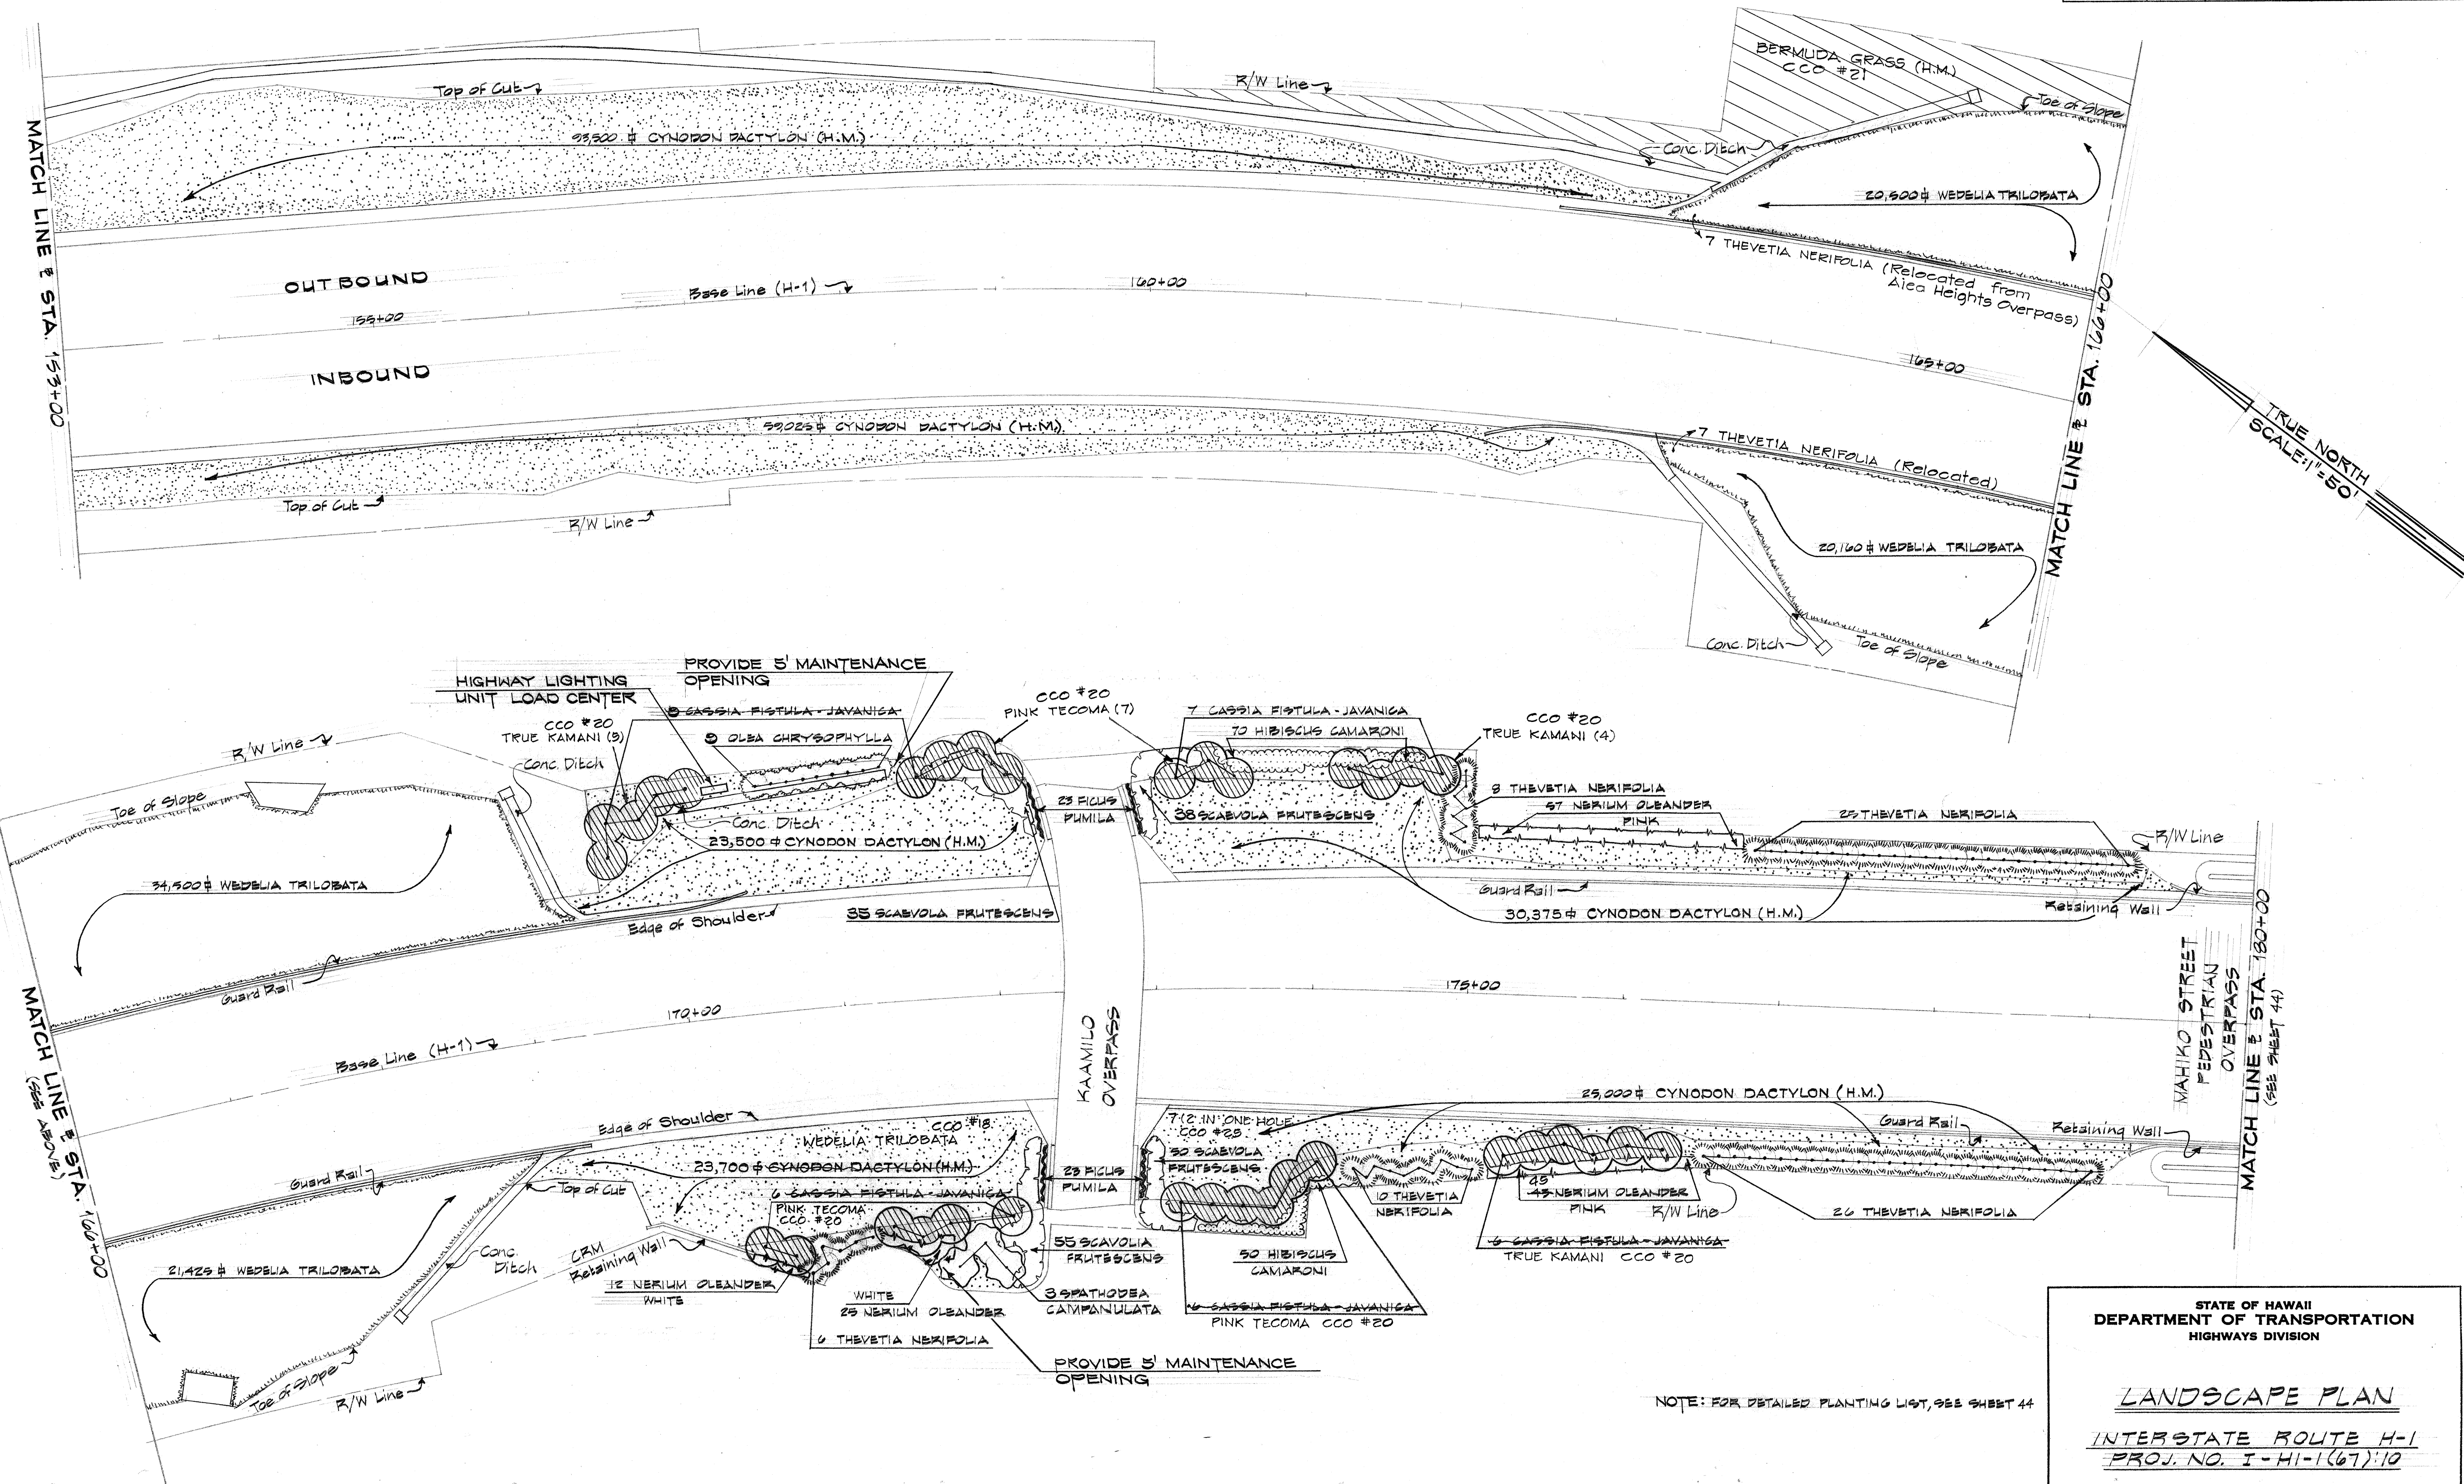

DATE	_____
SURVEY PLOTTED BY	_____
DRAWN BY	_____
CHECKED BY	_____
NOTE BOOK	_____
No.	_____

NOTE: FOR DETAILED PLANTING LIST, SEE SHEET 44

STATE OF HAWAII
DEPARTMENT OF TRANSPORTATION
HIGHWAYS DIVISION


LANDSCAPE PLAN

INTERSTATE ROUTE H-1
PROJ. NO. I-HI-1(67):10

Scale: 1"=50' Date: _____

SHEET No. 5 OF 6 SHEETS

FED. ROAD DIST. NO.	STATE	FED. AID PROJ. NO.	FISCAL YEAR	SHEET NO.	TOTAL SHEETS
HAWAII	HAW.	I-HI-1(66):10 I-HI-1(67):10	1970	44	97

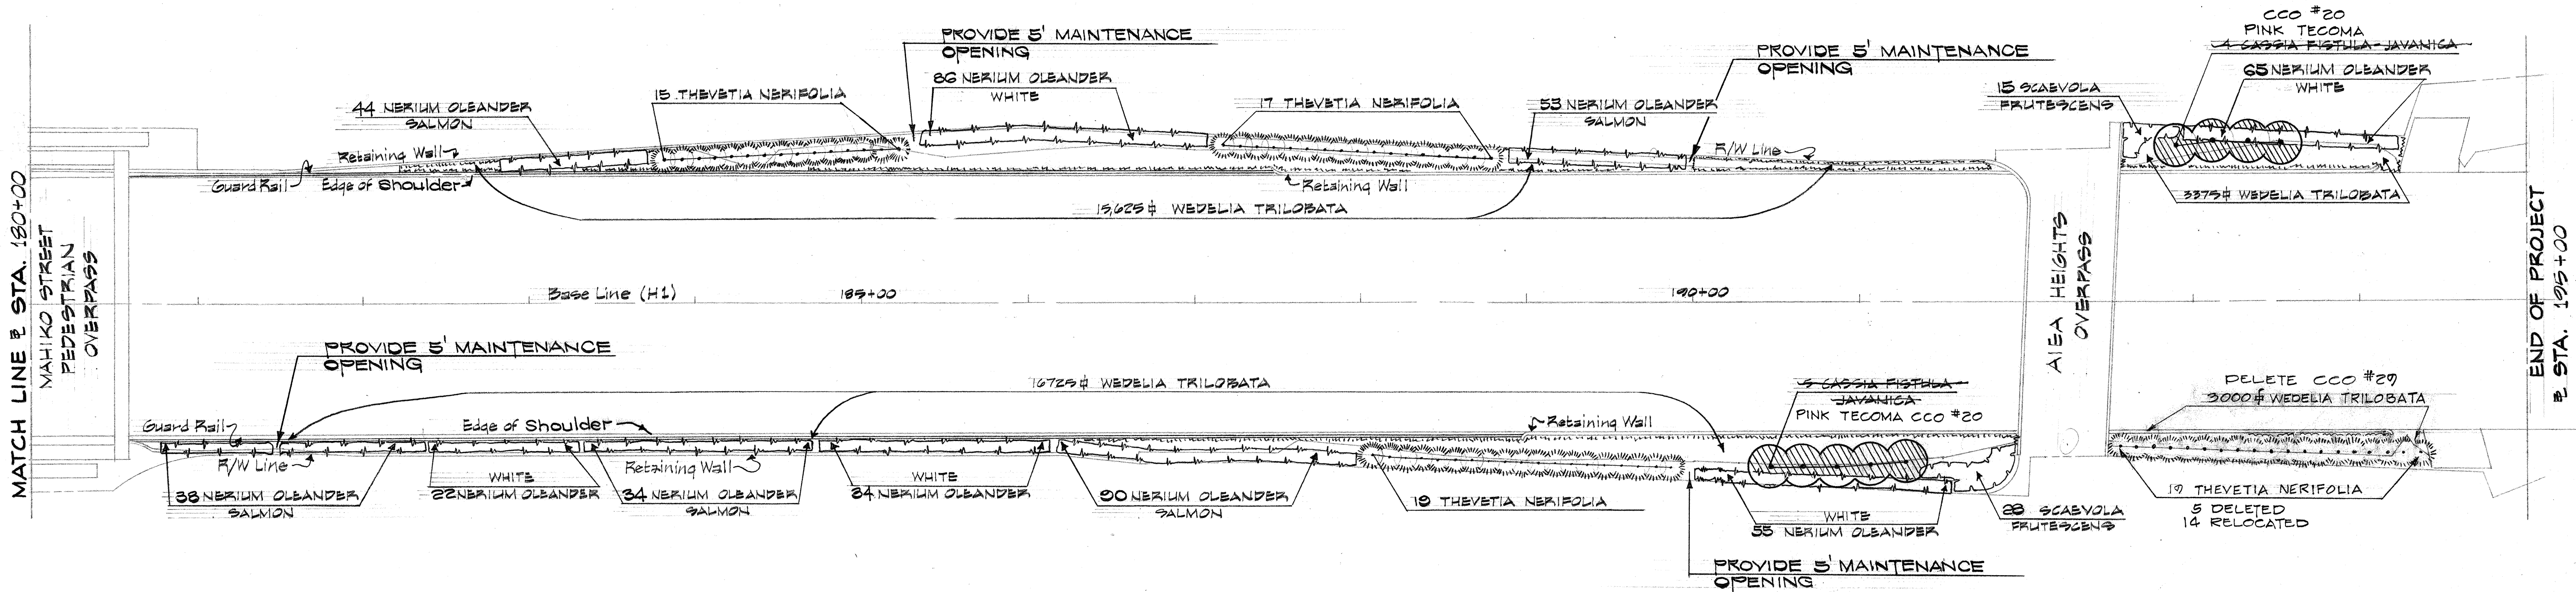

P L A N T L I S T				
QUANTITY	BOTANICAL NAME	COMMON NAME	SIZE & CONDITION	MIN. SPACING
15	BAMANEA SAMAN	MONKEY POD	8' HT. 10 GAL.	50'00.
4	FICUS RETUSA	CHINESE BANYAN	8' HT. 10 GAL.	60'00.
93-80	CASSIA FISTULA-JAVANICA	RAINBOW SHOWER	54" HT. 5 GAL.	20'00.
2	DELONIX REGIA	ROYAL POINCIANA	8' HT. 10 GAL.	30'00.
52	SPATHODEA CAMPANULATA	AFRICAN TULIP TREE	5' HT. 5 GAL.	20'00.
23	COCOS NUCIFERA	COCONUT PALM	1-2' TR. HT. B.P.	15'00.
76	OLEA CHRYSOPHYLLUA	WILD OLIVE	5' HT. 5 GAL.	15'00.
9	ERYTHRINA SANDWIGENSIS	WILI-WILI	5' HT. 5 GAL.	15'00.
10	CASSIA BAUHA	KALAMONA	2' HT. 1 GAL.	20'00.
254-259	THEVETIA NERIFOLIA	BB-STILL TREE	2' HT. 1 GAL.	10'00.
187-185	NERIUM OLEANDER	OLEANDER - PINK	2' HT. 1 GAL.	4'00.
156	NERIUM OLEANDER	OLEANDER - SALMON	2' HT. 1 GAL.	4'00.
941	NERIUM OLEANDER	OLEANDER - WHITE	2' HT. 1 GAL.	4'00.
190	HIBISCUS ROSA-SINENSIS	RED HIBISCUS	2' HT. 1 GAL.	4'00.
246	HIBISCUS CAMARONI	PINK HIBISCUS	2' HT. 1 GAL.	4'00.
1307-172	SCAEVOLA FRUTESCENS	BBACH NAUPAKA	18" HT. 1 GAL.	5'00.
92	FICUS PUMILA	CREeping FIG VINE	12" L. RUNNERS	3'00.
348,050 #	WEDELIA TRILOBATA	WEDELIA	12-18" L. RUNNERS	
340,600#	CYNODON DACTYLON	BERMUDA GRASS	ROOTED STOLON	
1,132,055#	CYNODON DACTYLON (H.M.)	BERMUDA GRASS	SEEDS	

REPLACED BY:
42 PINK TECOMA
51 TRUE KAMANI

CCO # 29

CCO # 4

(CCO #25-2 IN ONE HOLE.)
527

DELETED-CCO #18

NOTE:

- SEE SPRINKLER PLANS, SHEETS 48 TO 58, FOR THOSE AREAS THAT ARE TO BE IRRIGATED.
- (H.M.) - INDICATES AREAS TO BE GRASSED BY THE HYDROMULCHING PROCESS. HOWEVER WITH THE APPROVAL OF THE ENGINEER, THE CONTRACTOR SHALL BE PERMITTED TO PLANT ROOTED STOLONS IN ANY OF THE GRASSED AREA SO DESIGNATED. WITH THE APPROVAL OF THE ENGINEER, THE CONTRACTOR SHALL ALSO HAVE THE OPTION OF PLANTING ALL GRASSED AREAS BY THE HYDROMULCHING PROCESS.

316,806 # BERMUDA GRASS PLANTED BY HYDROMULCHING
CCO #18

STATE OF HAWAII
DEPARTMENT OF TRANSPORTATION
HIGHWAYS DIVISION

LANDSCAPE PLAN
INTERSTATE ROUTE H-1
PROJ. NO. I-HI-1(67):10

Scale: 1"=50' Date:

SHEET No. 6 OF 6 SHEETS

ORIGINAL PLAN	DATE
SURVEY PLOTTED BY	
DRAWN BY	
CHECKED BY	
NOTED BY	
QUANTITIES BY	
CHECKED BY	
No.	