

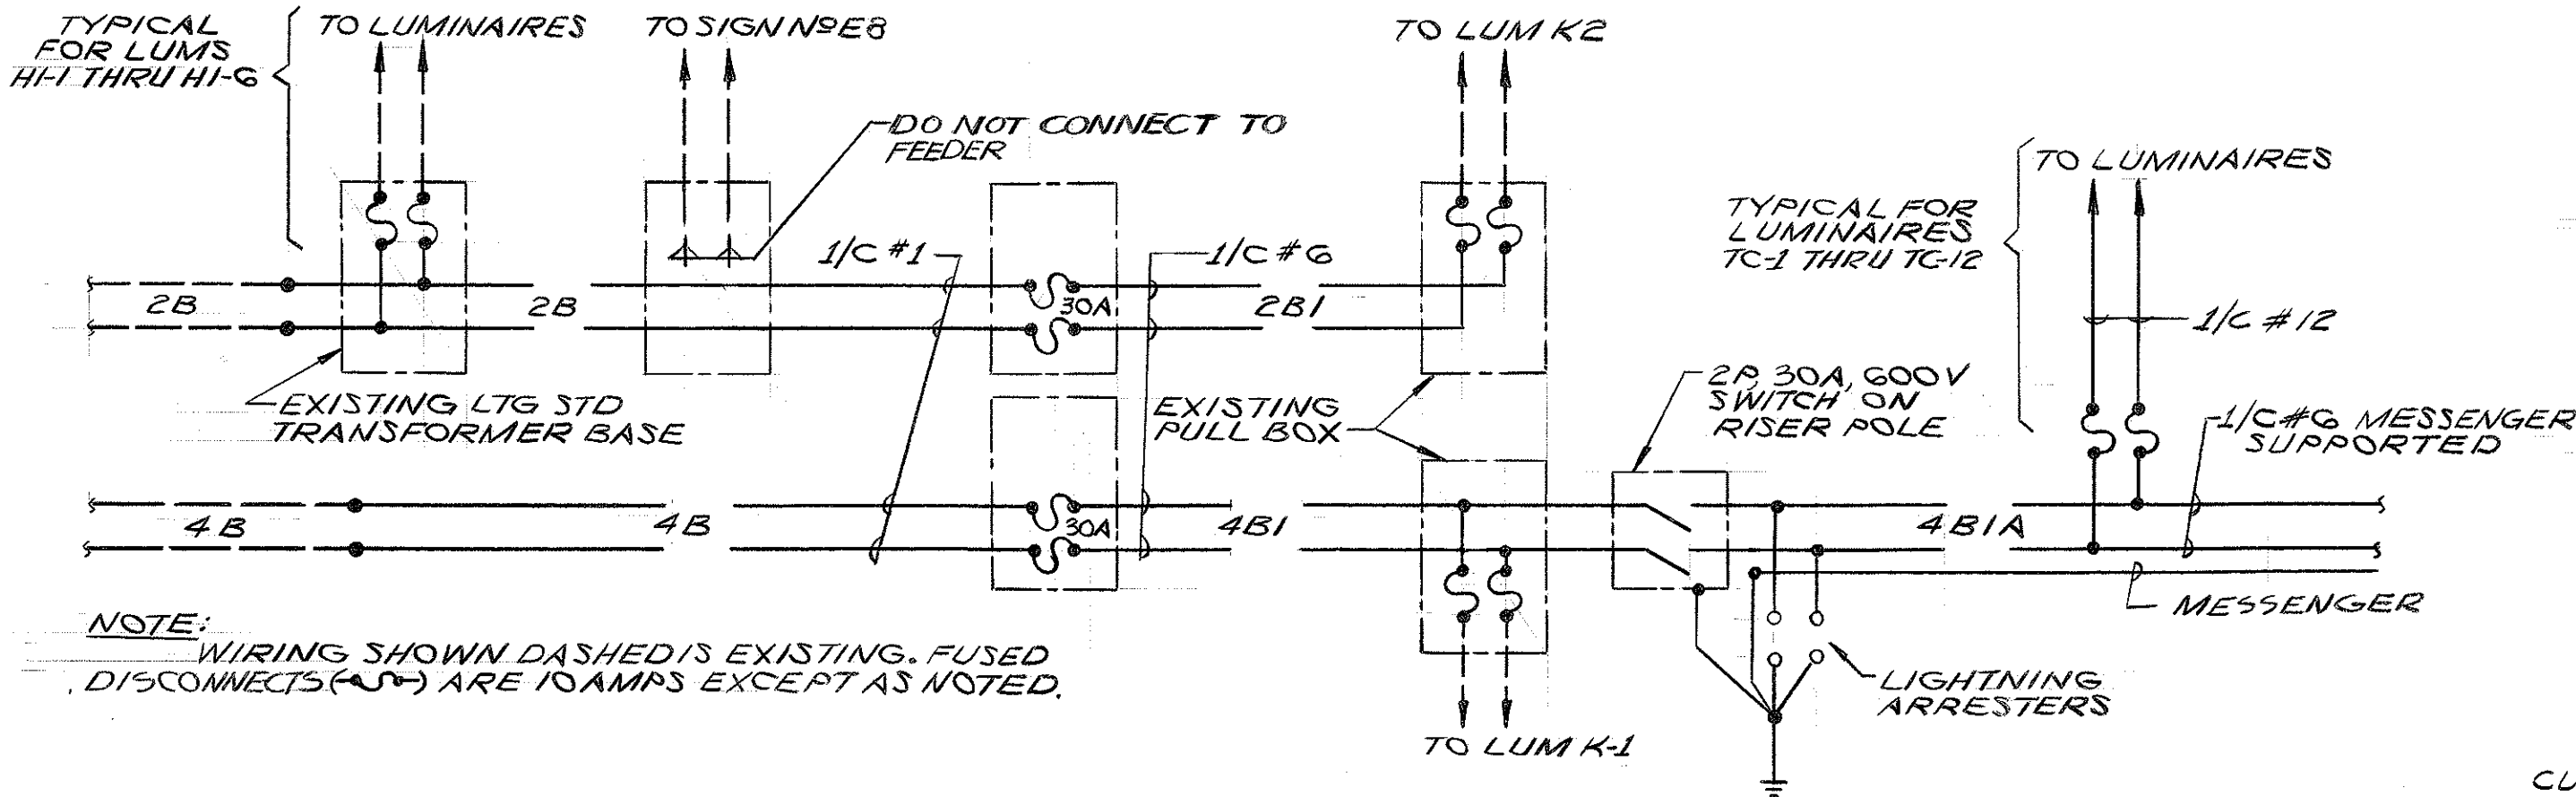
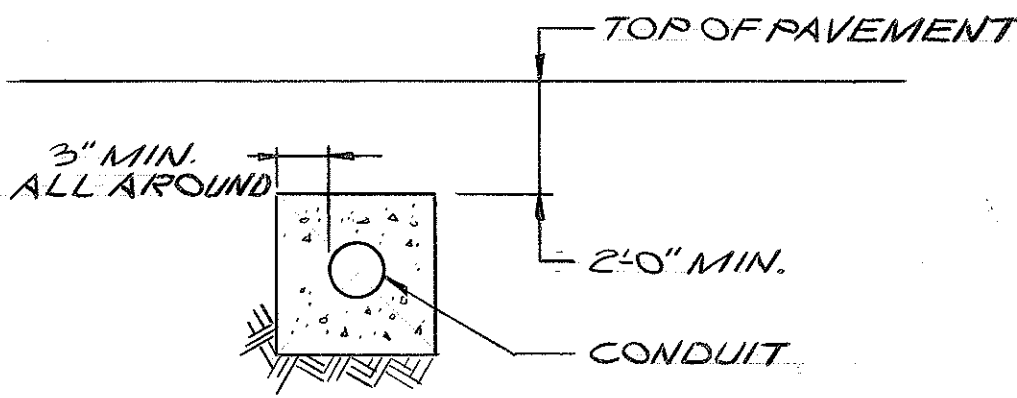



FED. ROAD DIST. NO.	STATE	FED. AID PROJ. NO.	FISCAL YEAR	SHEET NO.	TOTAL SHEETS
HAWAII	HAW.	I-HI(78):13	1970	39	47

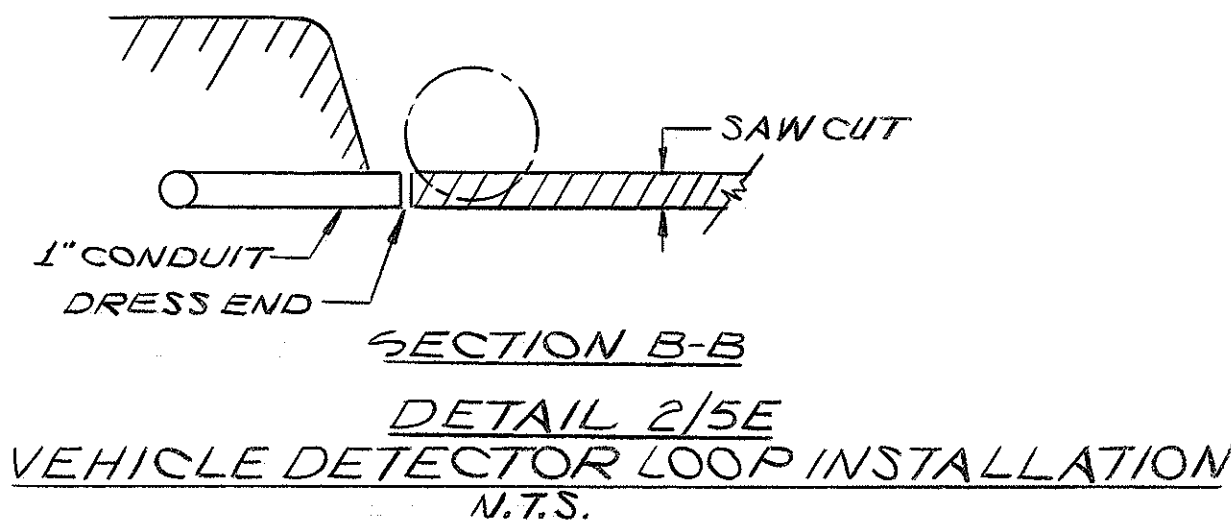


DETAIL 1/5E
SCHEMATIC DIAGRAM OF LUMINAIRE CONNECTIONS
N.T.S.

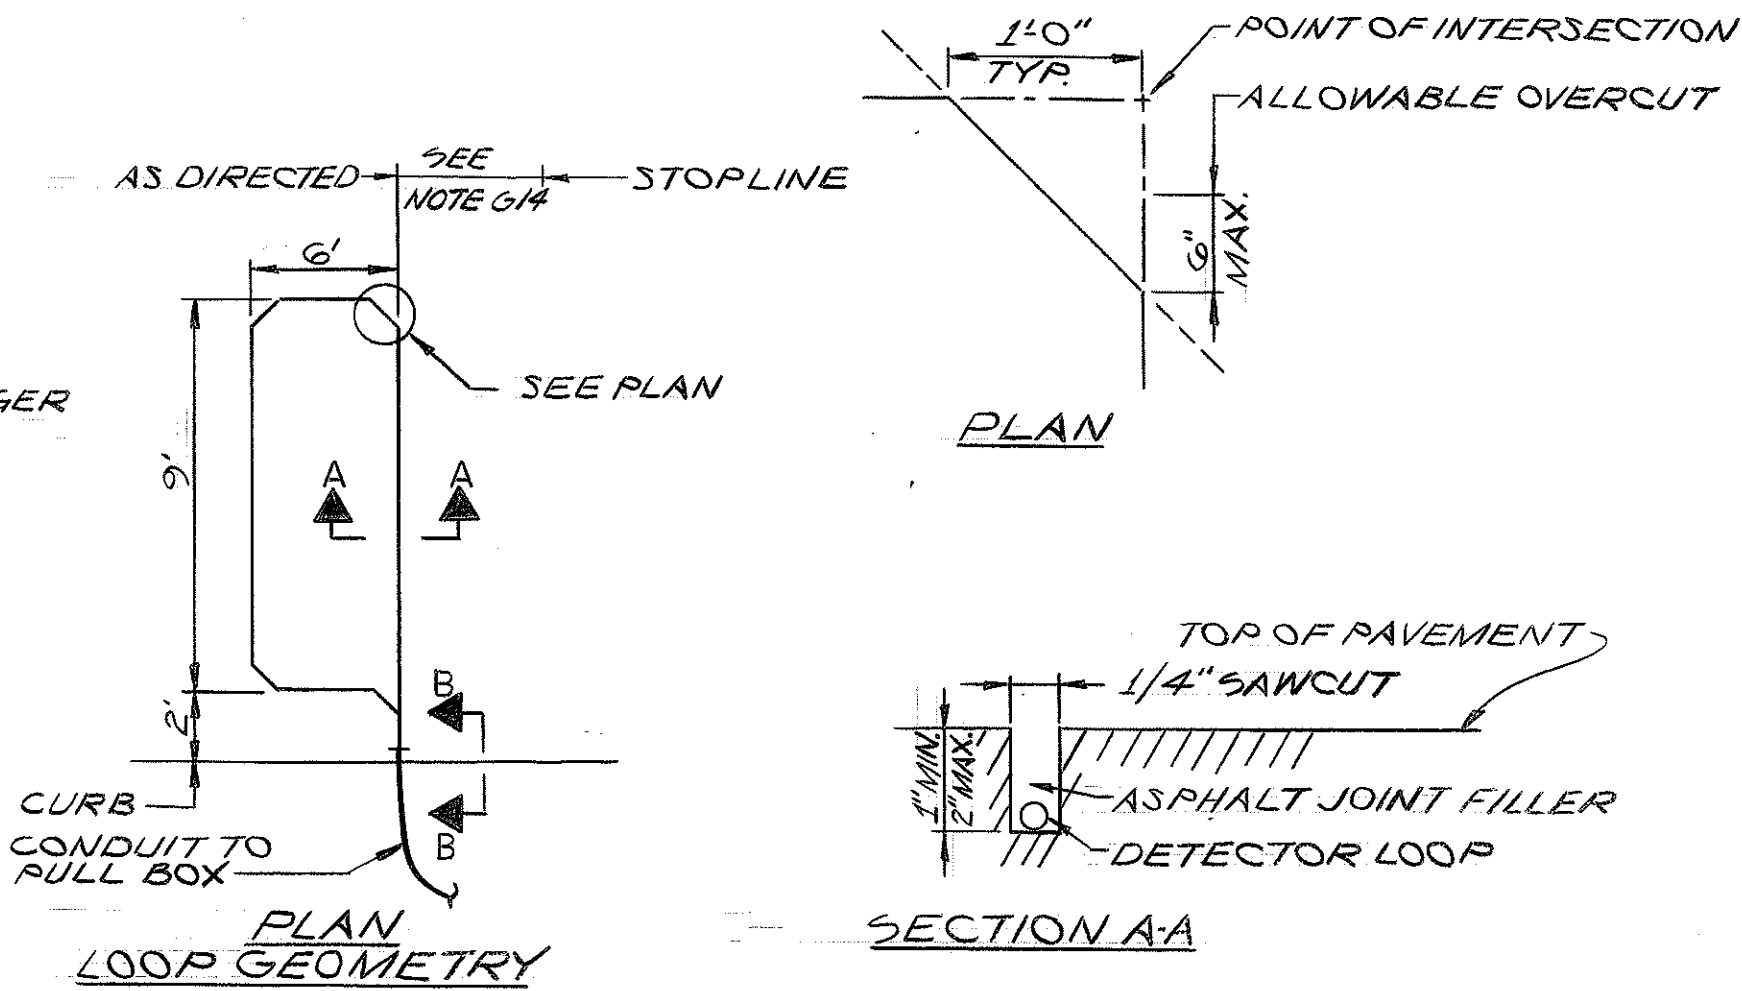


DETAIL 3/5E
TRAFFIC SIGNAL SYSTEMS
CONDUIT INSTALLATION
N.T.S.

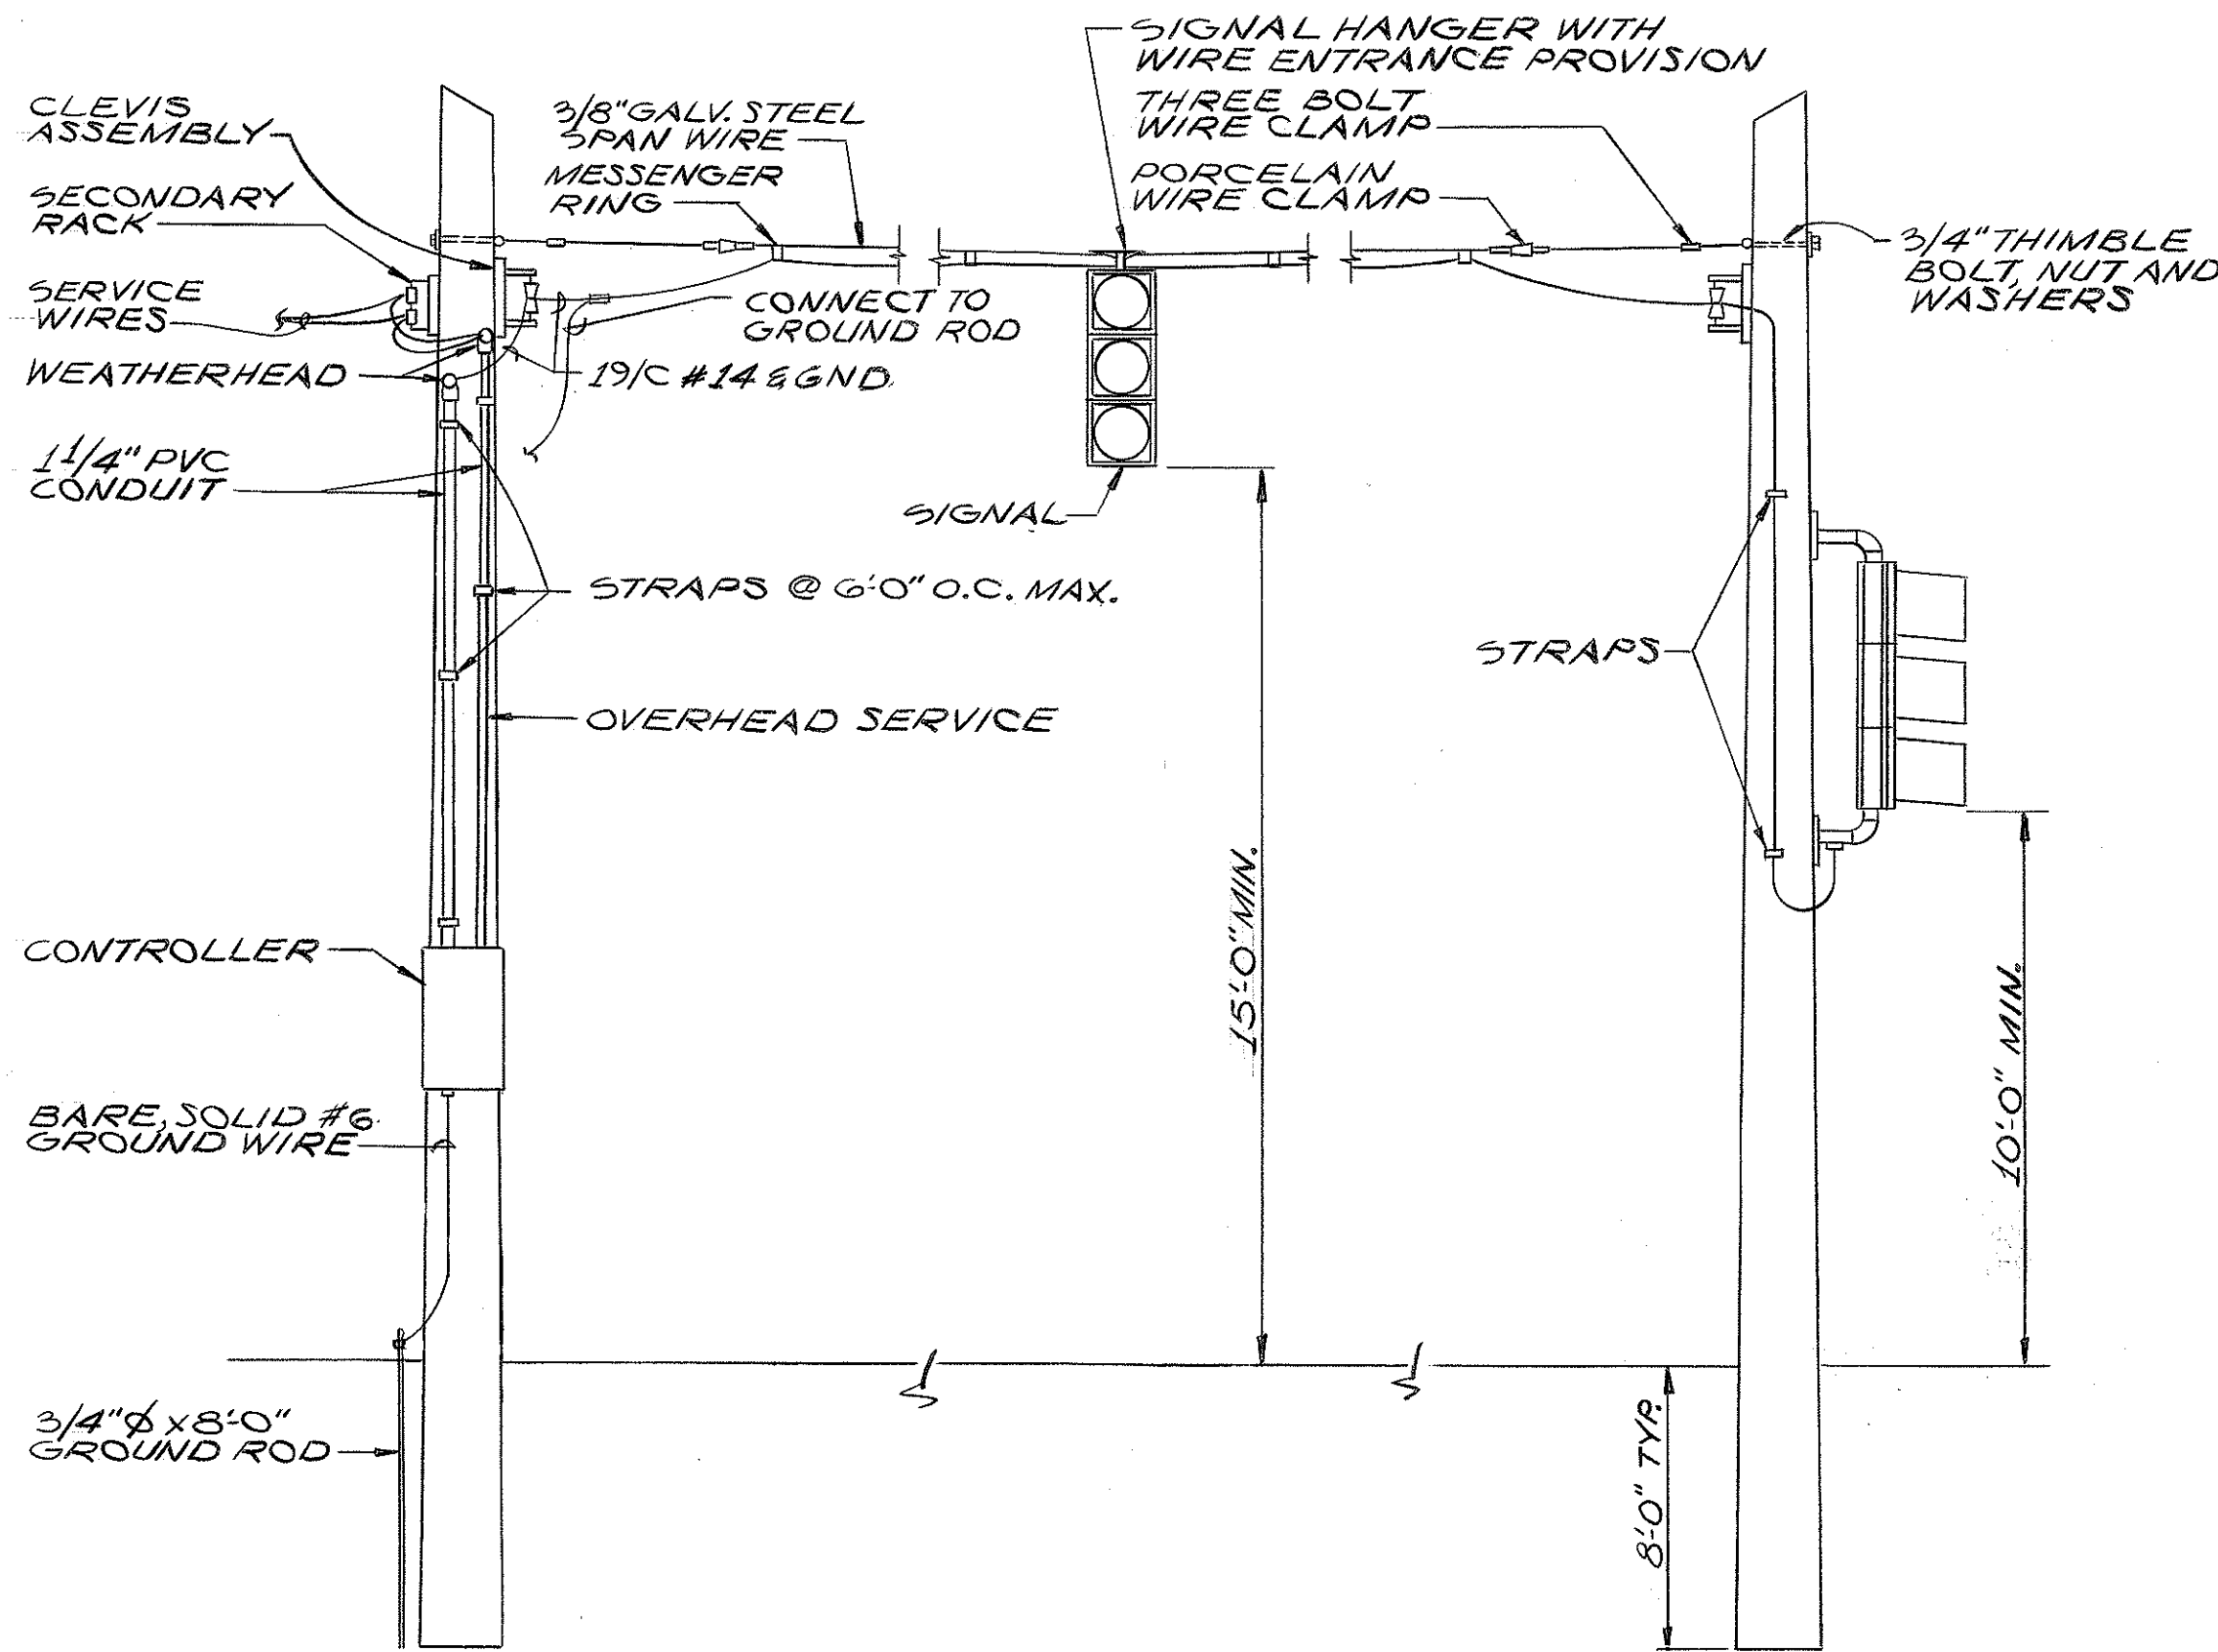


DETAIL 4/5E
TRAFFIC SIGNAL
FACILITIES
N.T.S.

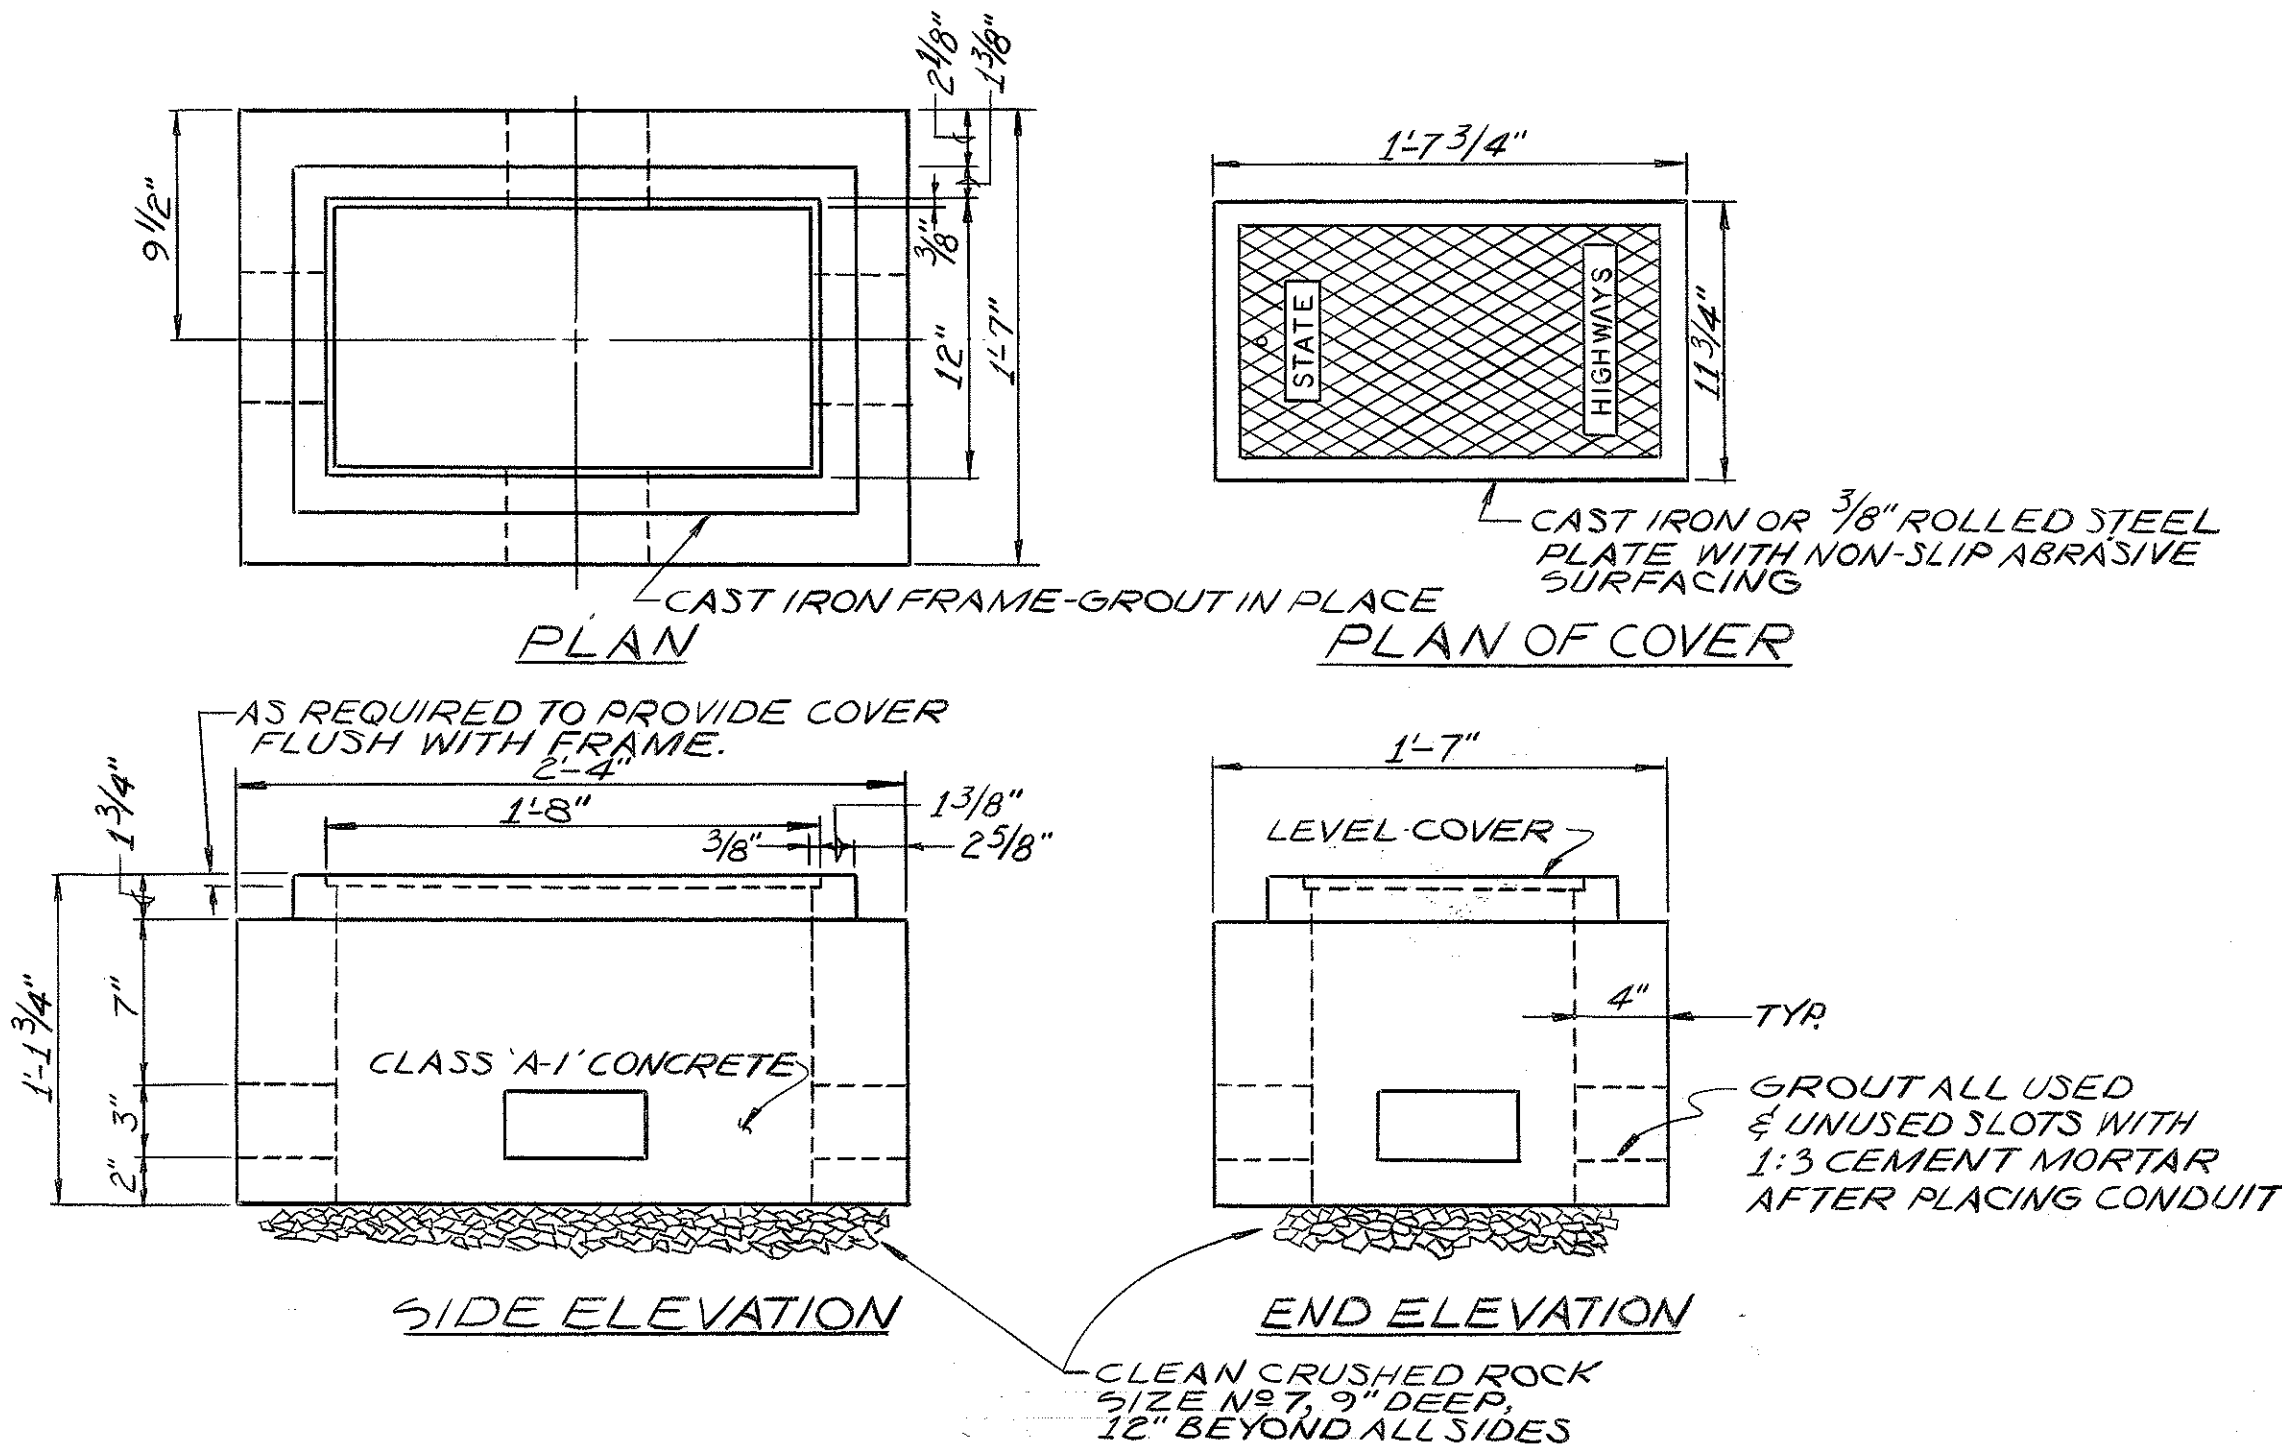

DETAIL 5/5E
TYPE 'B' PULL BOX
SCALE: 1/4" = 1'-0"

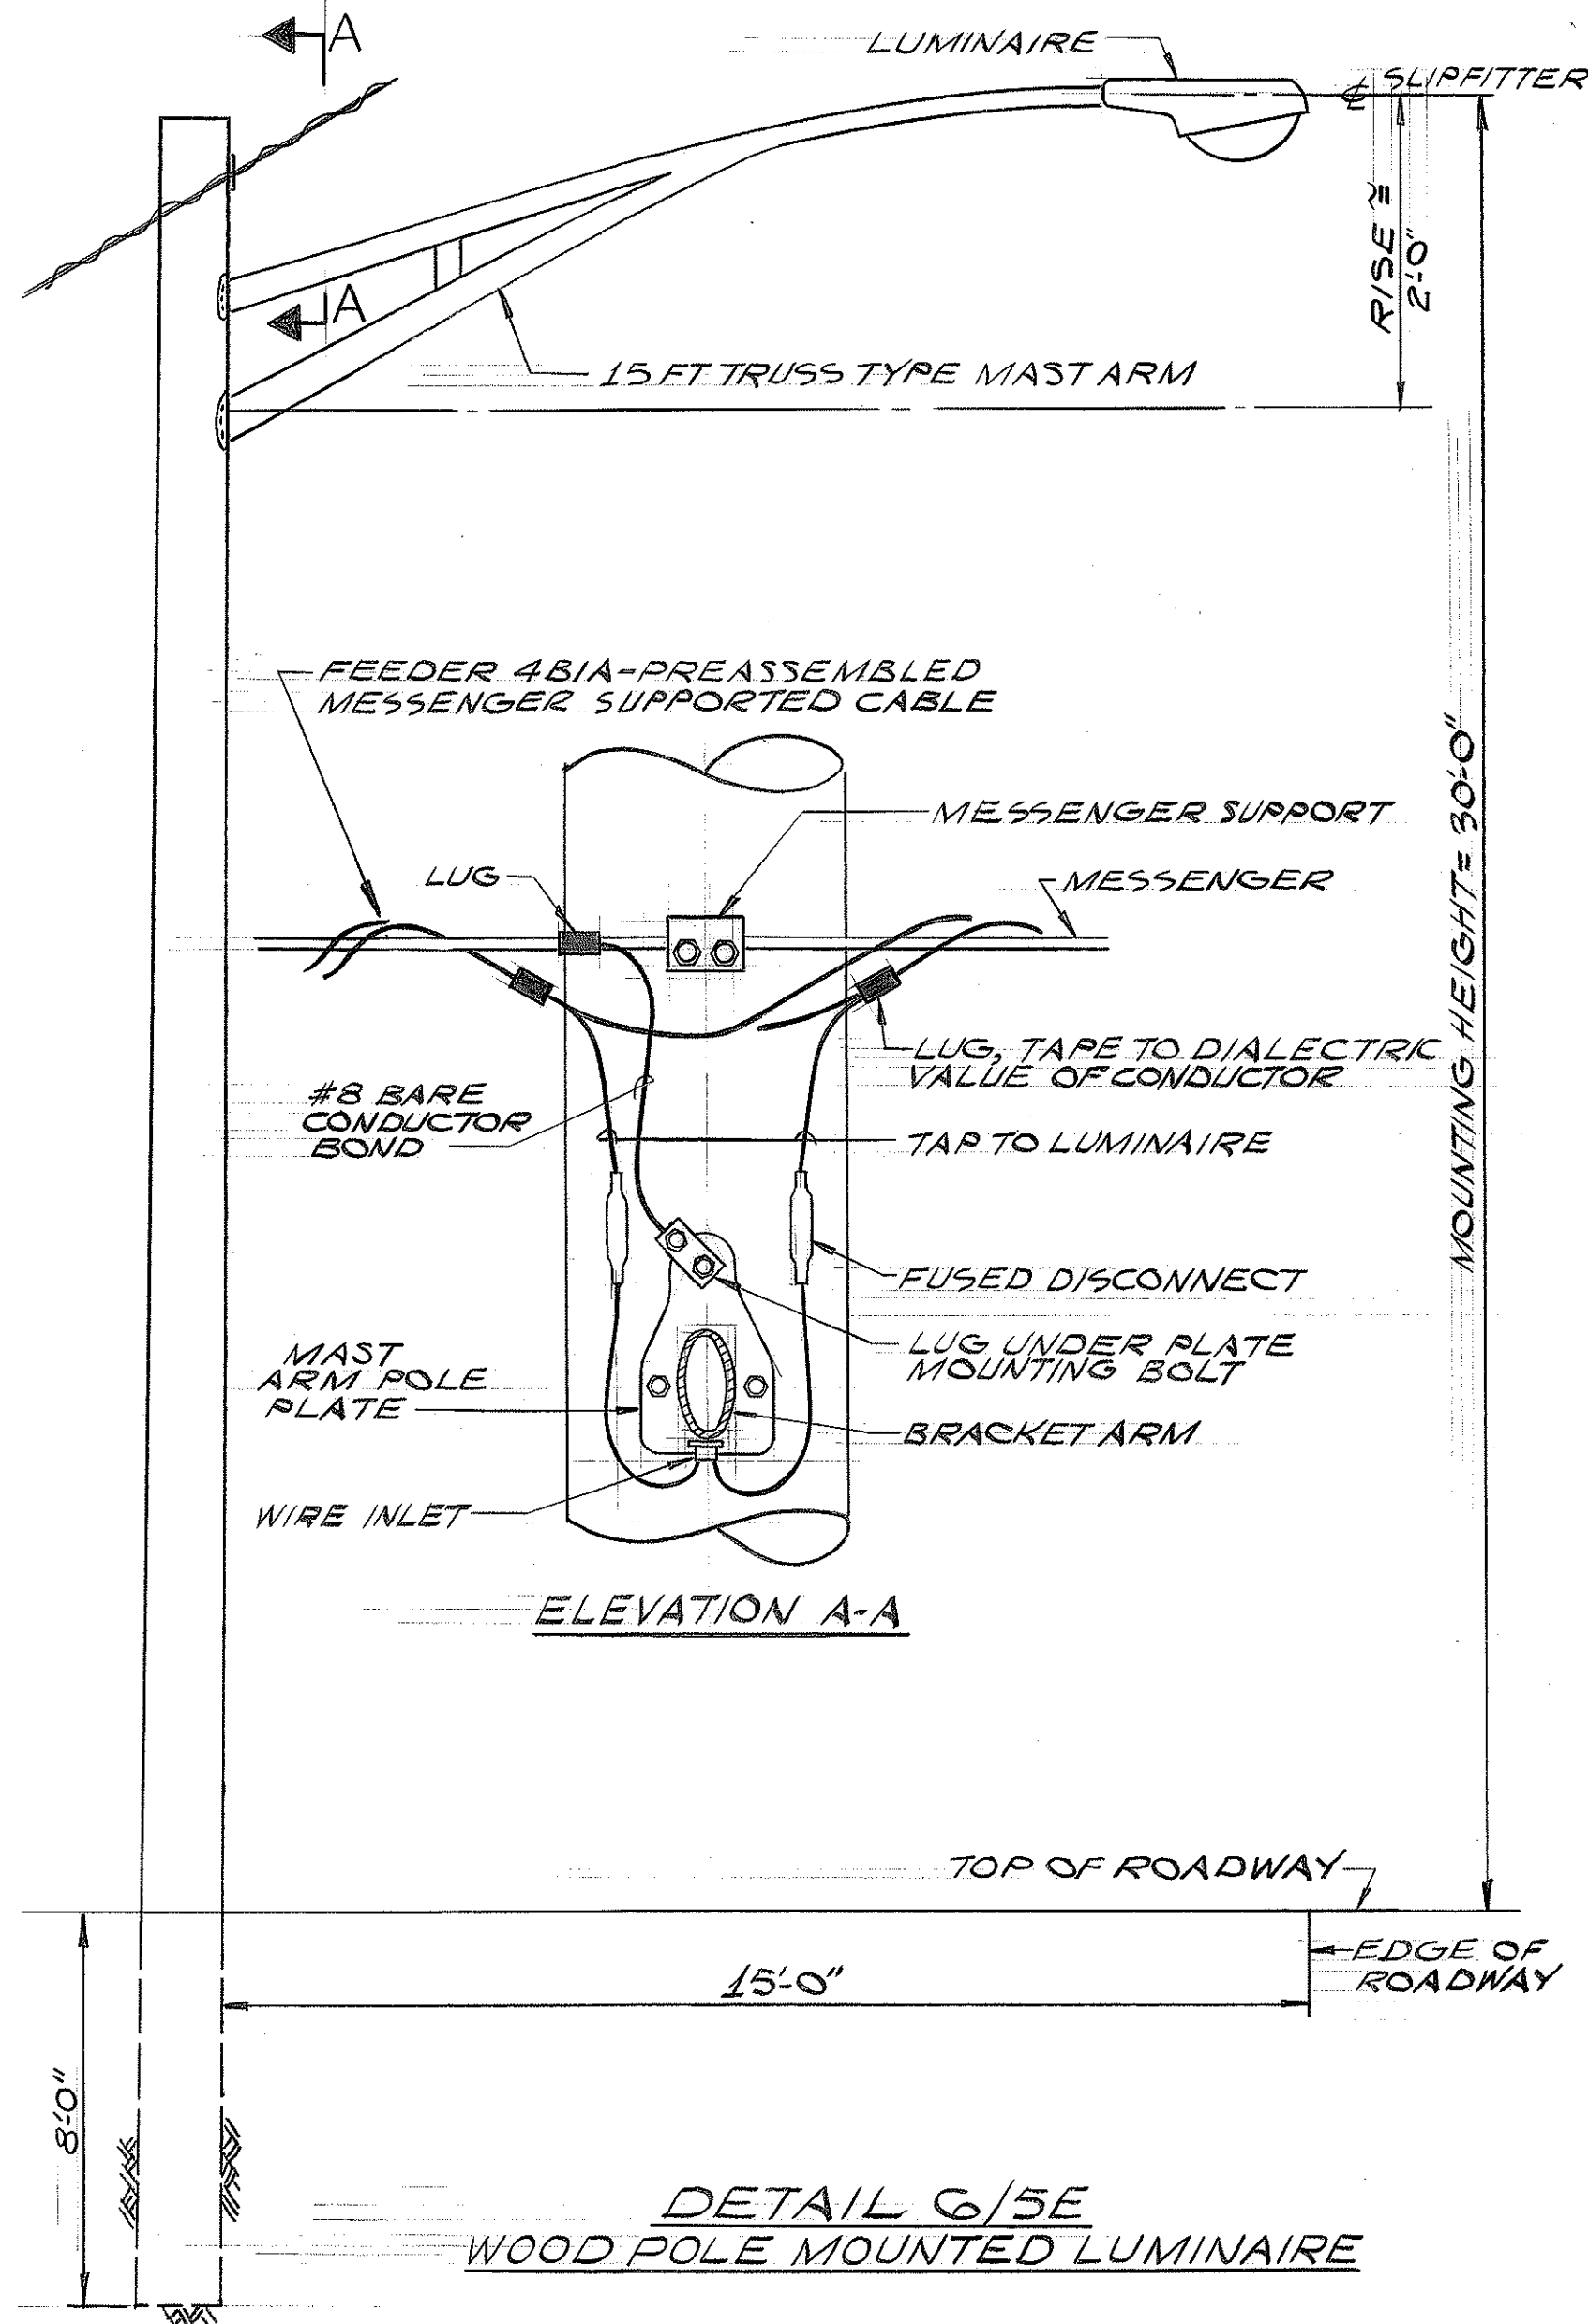

DETAIL 6/5E
WOOD POLE MOUNTED LUMINAIRE

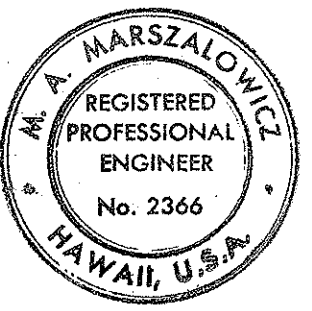

THIS WORK WAS PREPARED BY
ME OR UNDER MY SUPERVISION
Michael A. Marszalowicz

ELECTRICAL SHEET 5E

STATE OF HAWAII
DEPARTMENT OF TRANSPORTATION
HIGHWAYS DIVISION

ELECTRICAL DETAILS

HALAWA INTERCHANGE
PROJECT NO. I-HI(78):13

SCALE: AS NOTED DATE: APR. 9, 1970

SHEET No. 1 OF 1 SHEETS