


INDEX TO DRAWINGS	
SHEET NO.	DESCRIPTION
1	TITLE SHEET
2	TYPICAL SECTIONS
3	ALIGNMENT PLAN
4	PROFILES
5-8	ROADWAY CONSTRUCTION DRAINAGE & GRADING PLANS
9-18	MISC. ROADWAY DETAILS & STANDARD DETAILS
19	GENERAL NOTES AND TEMPORARY SIGNS
20	SIGN LOCATION AND BORING LOCATION PLAN
21-26	STANDARD SIGN DETAILS
27	BORINGS
28-34	UTILITY NOTES, PLANS & STANDARD DETAILS
35-36	LIGHTING PLANS
37-38	TRAFFIC SIGNAL PLANS
39	ELECTRICAL DETAILS
40-46	CROSS SECTIONS
47	PROJECT INFORMATION SIGN

STATE OF HAWAII
DEPARTMENT OF TRANSPORTATION
HIGHWAYS DIVISION
HONOLULU, HAWAII
"AS BUILT"
PLANS FOR
CONSTRUCTION OF A PORTION OF
INTERSTATE ROUTE H-1
HALAWA INTERCHANGE
TEMPORARY CONNECTION TO MOANALUA ROAD
FEDERAL AID INTERSTATE PROJECT NO. I-HI-1(78):13

FED. ROAD DIST. NO.	STATE	FED. AID PROJ. NO.	FISCAL YEAR	SHEET NO.	TOTAL SHEETS
HAWAII	HAW.	I-HI-1(78):13	1970	1	47

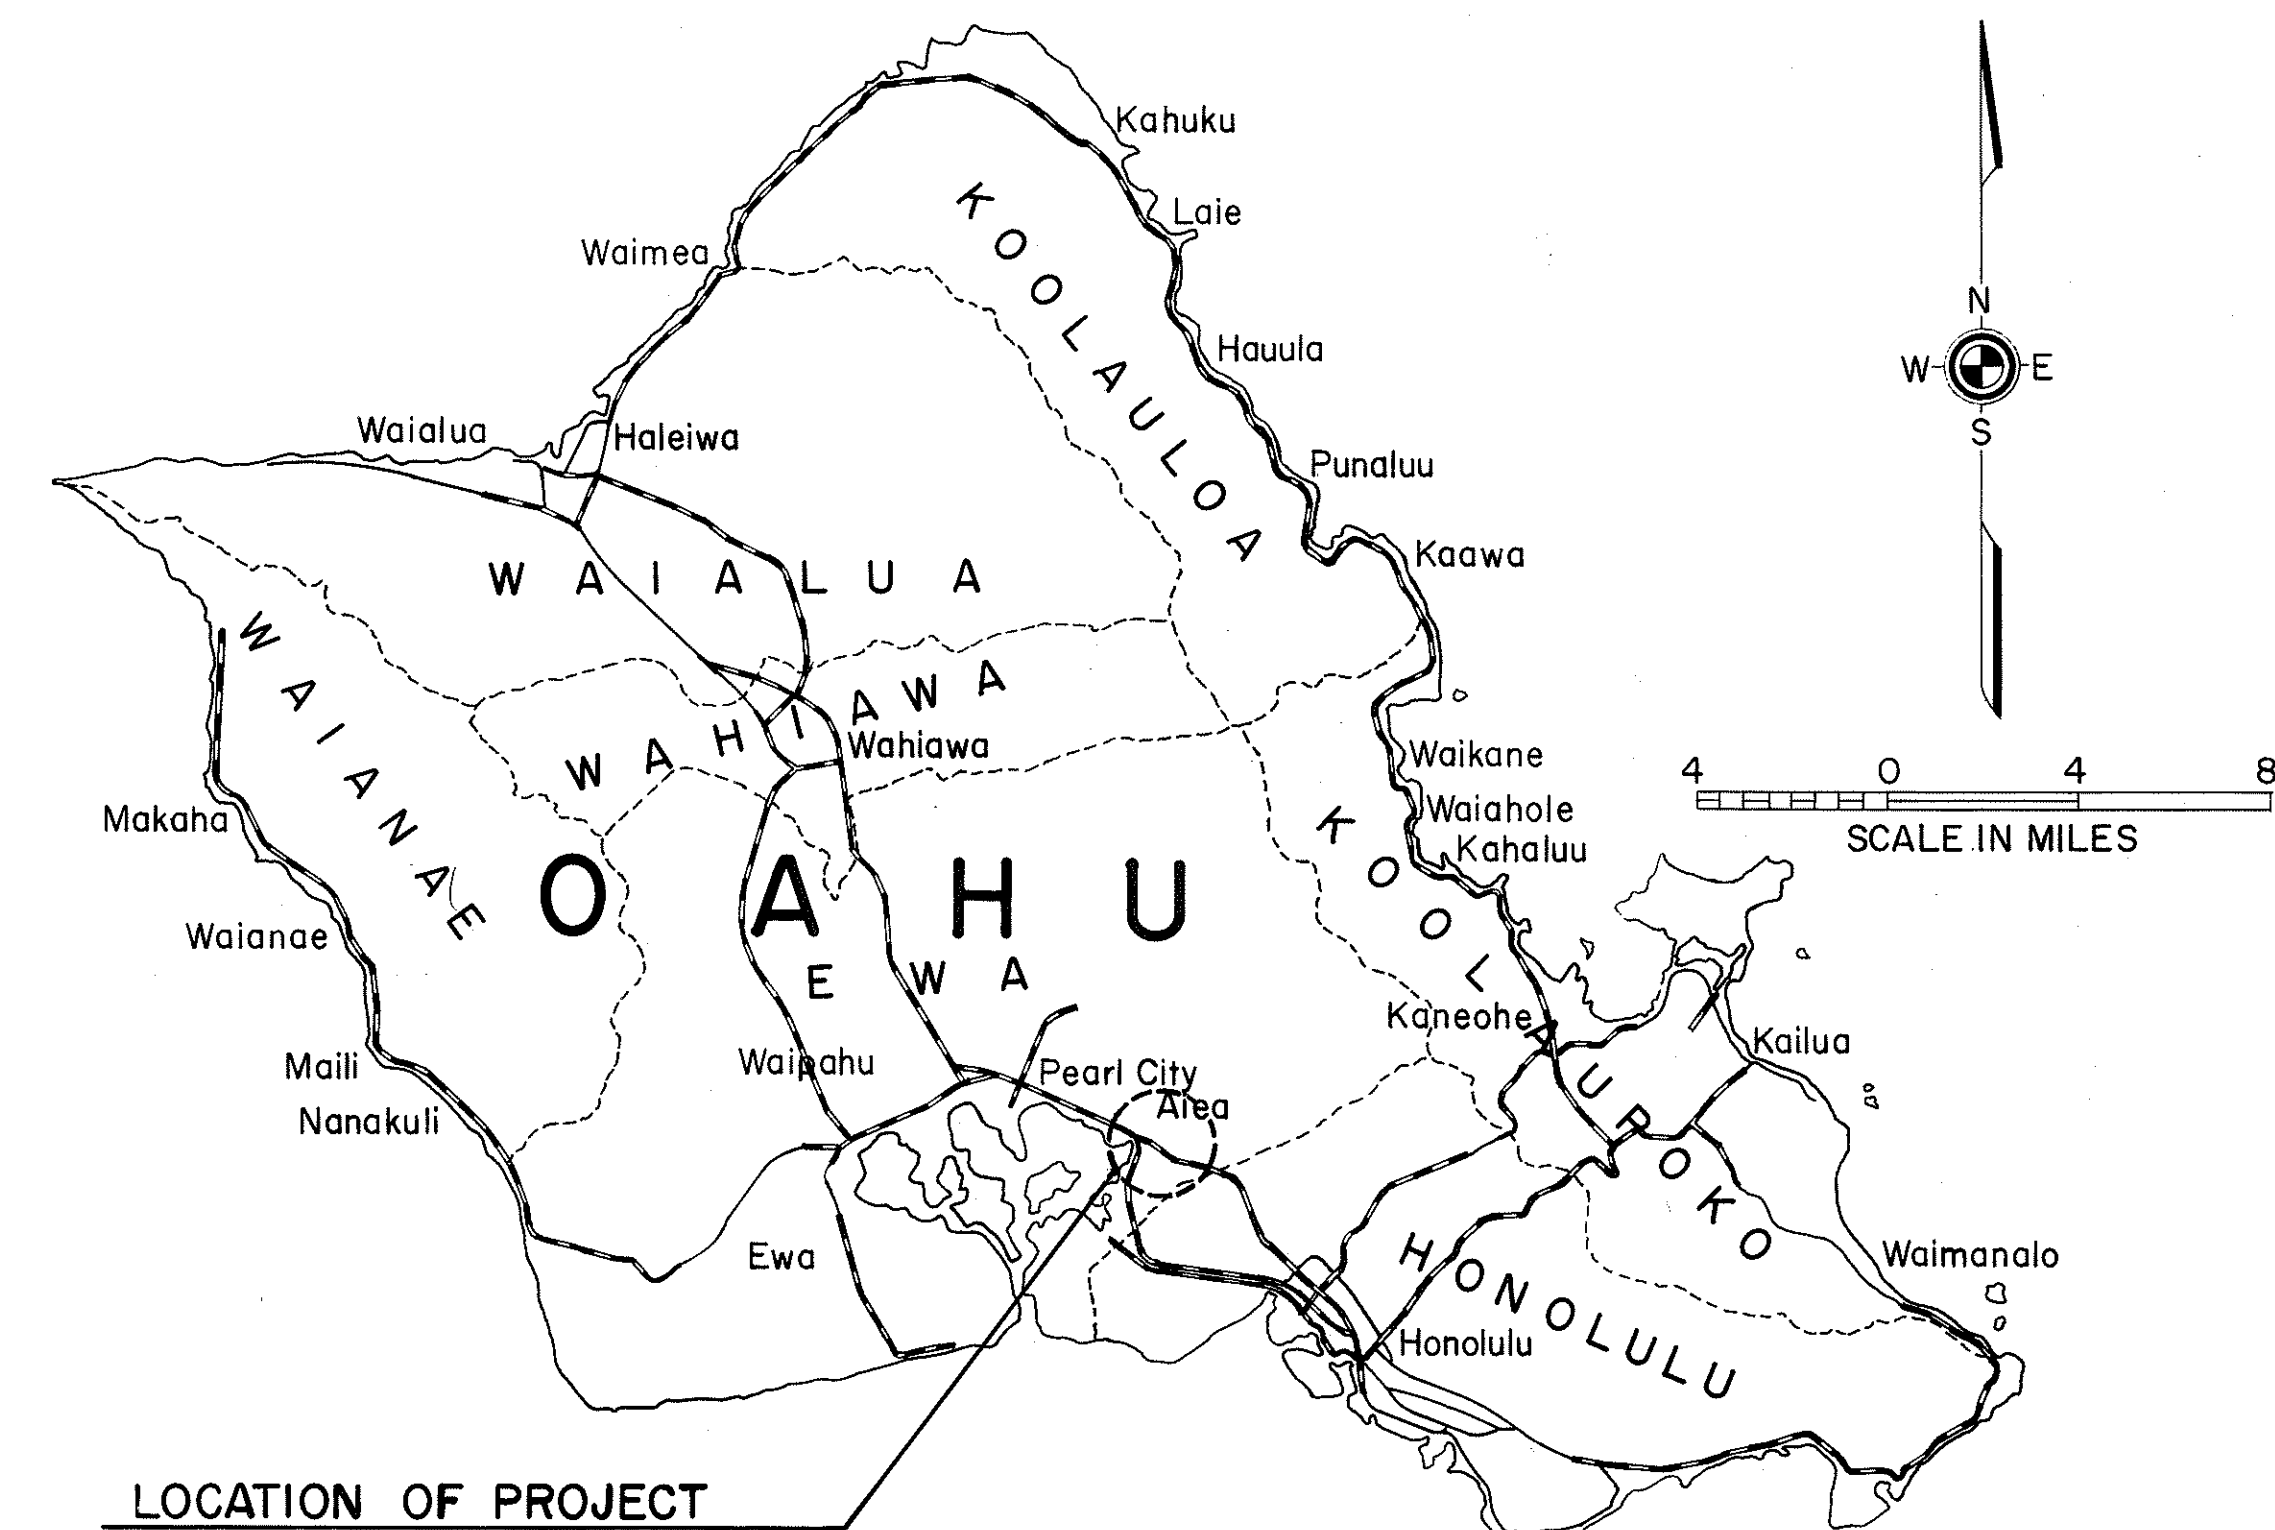

LOCATION OF PROJECT

— Federal Aid Projects Previously Constructed or Under Construction

NOTE:


ALL CHANGES MADE DURING CONSTRUCTION
HAVE BEEN NOTED IN RED ON THESE
TRACINGS AND CHECKED BY:

S. P. Poon
PROJECT ENGINEER
Aug 16, 1971
DATE

DESIGN CLASSIFICATION

DESIGN ADT (1970)..... 25,800
DESIGN ADT (1973)..... 27,900
DHV..... 10 %
D..... 55/45
T..... 3 %
V..... 25 MPH

ALL THE QUANTITIES SHOWN ARE ORIGINAL
THEORETICAL QUANTITIES. FOR ACTUAL
QUANTITIES, REFER TO PROJECT LEDGER
AND / OR COMPUTATION BOOK

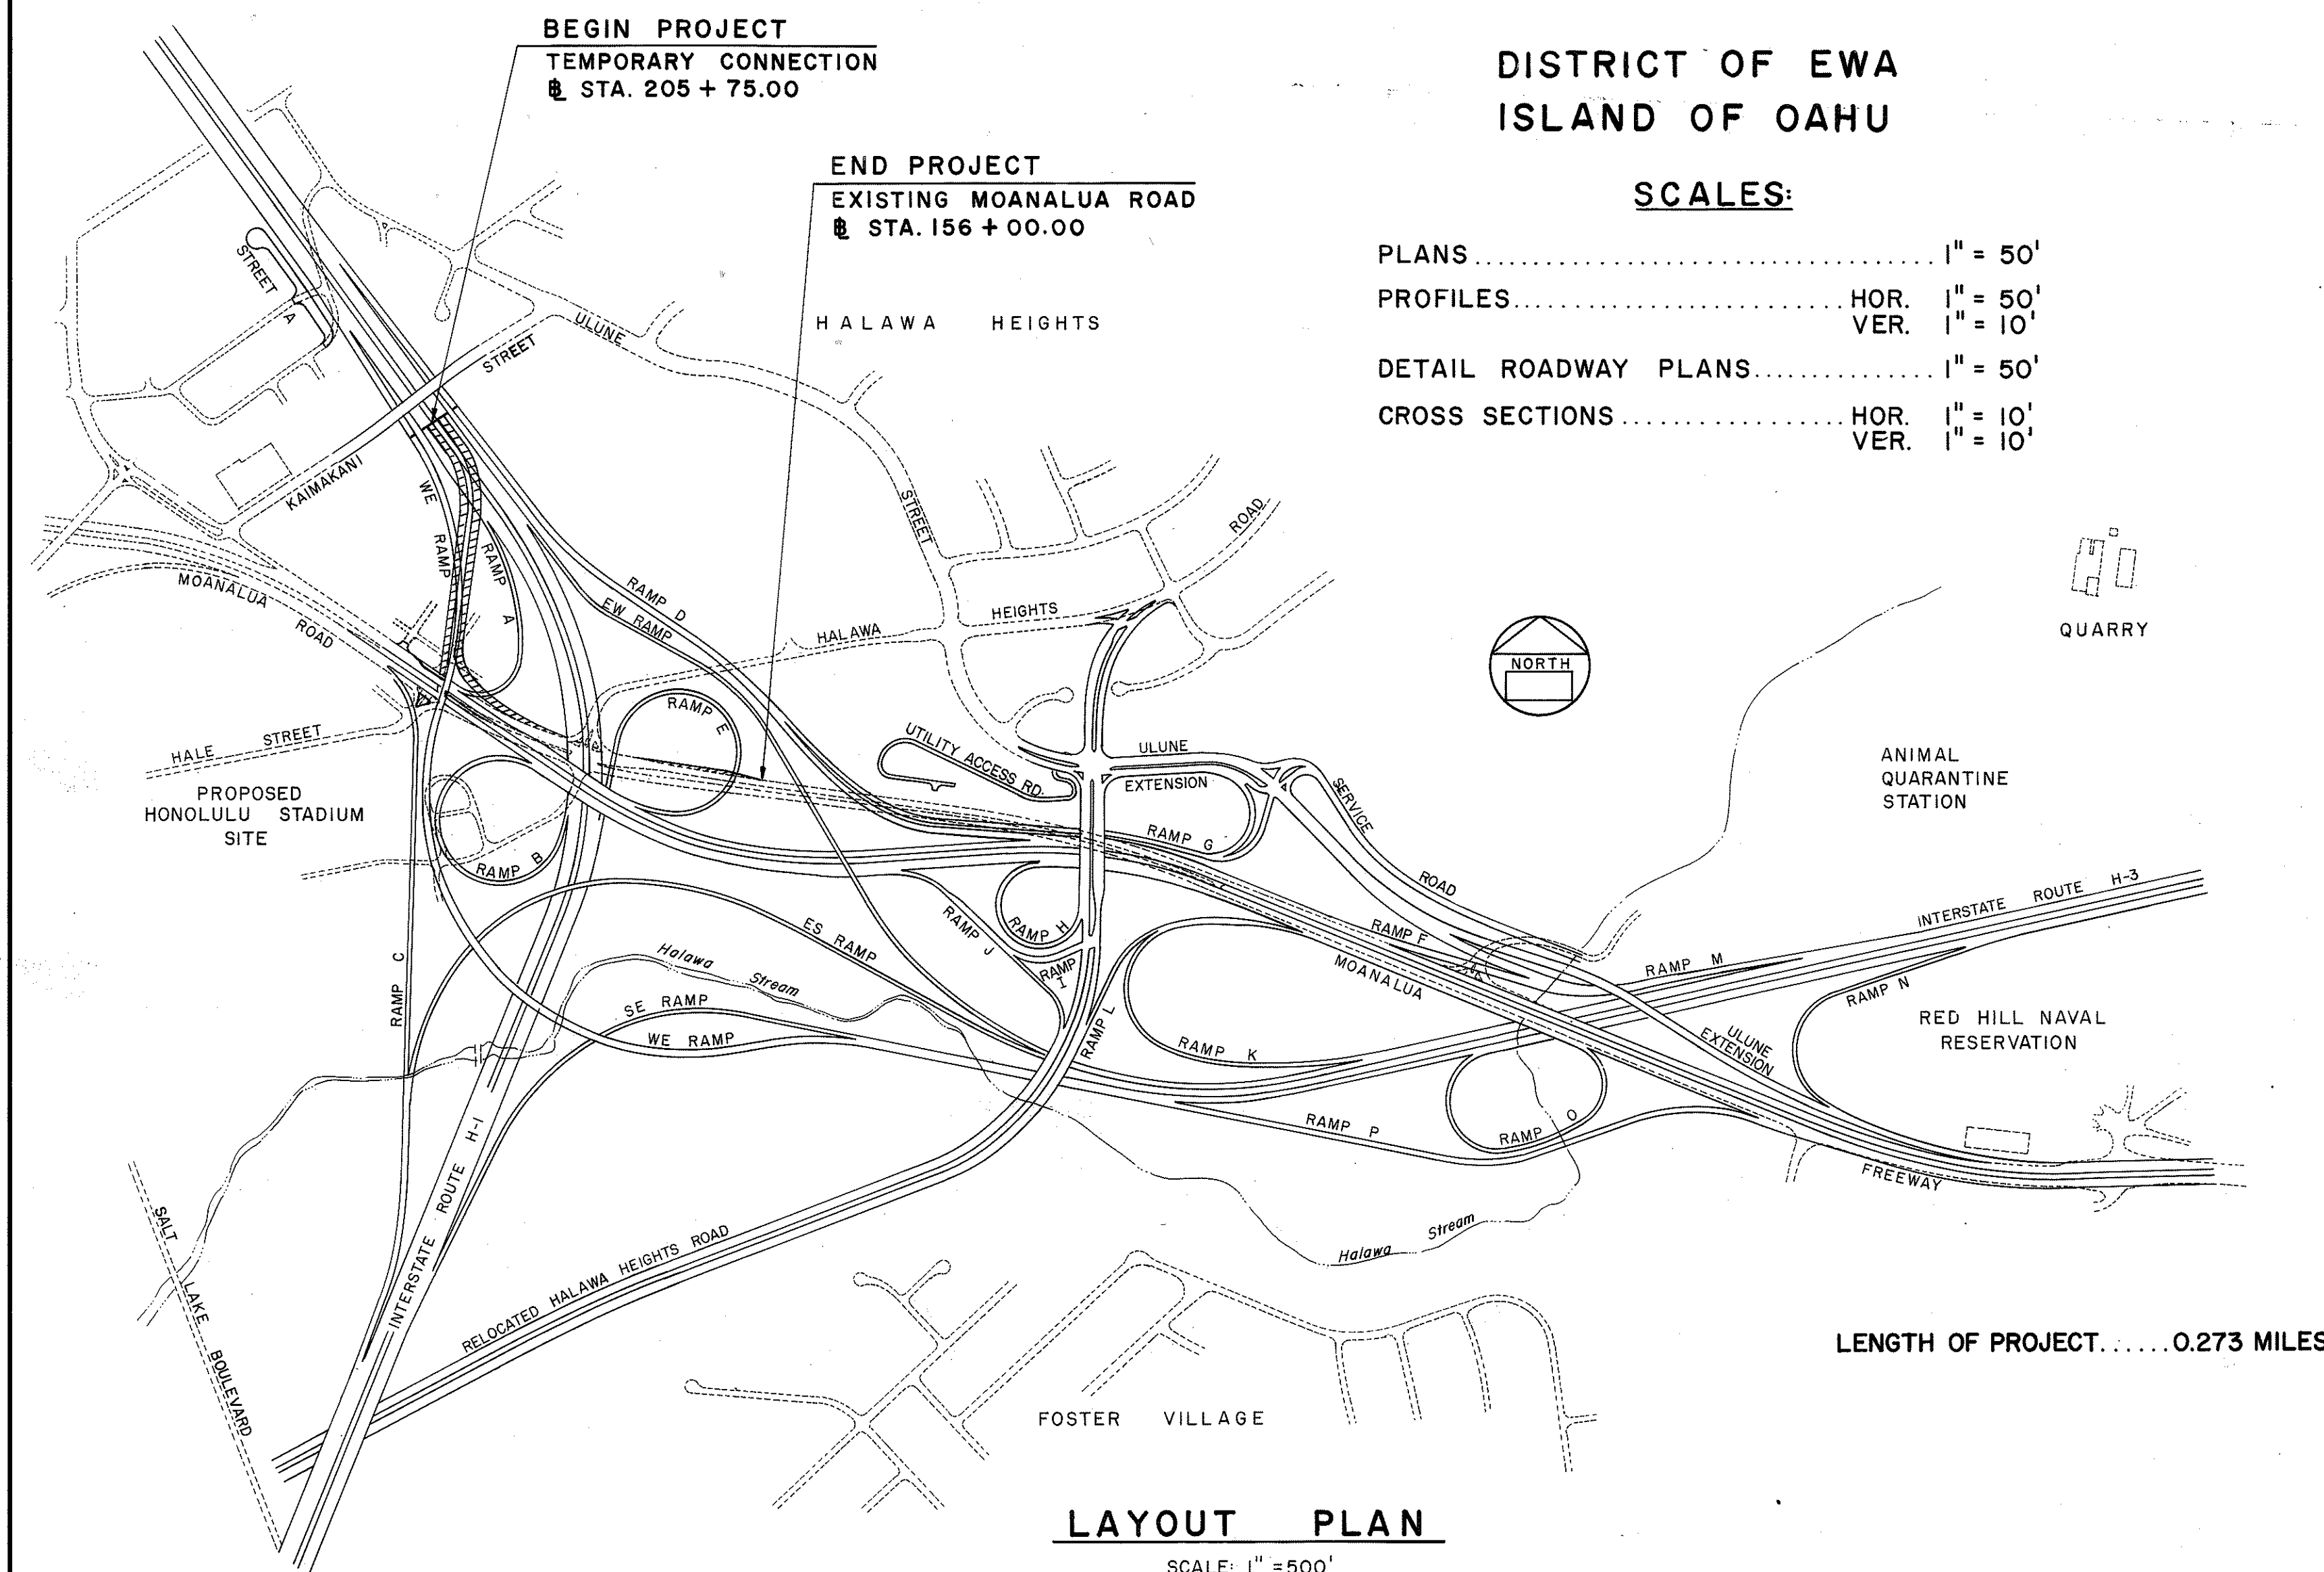

LENGTH OF PROJECT.....0.273 MILES

LAYOUT PLAN
SCALE: 1" = 500'

DEPARTMENT OF TRANSPORTATION
FEDERAL HIGHWAY ADMINISTRATION
APPROVED: *Ralph J. Seng* 5/28/70
FOR DIVISION ENGINEER DATE

DEPARTMENT OF TRANSPORTATION
STATE OF HAWAII
APPROVED: *G. Alvey Wright* 5/15/70
FOR DIR. OF TRANSPORTATION DATE

R. Mikami MAY, 1970