



FED. ROAD DIST. NO.	STATE	FED. AID PROJ. NO.	FISCAL YEAR	SHEET NO.	TOTAL SHEETS
HAWAII	HAW.	I-HI-1(78):13	1970	37	47

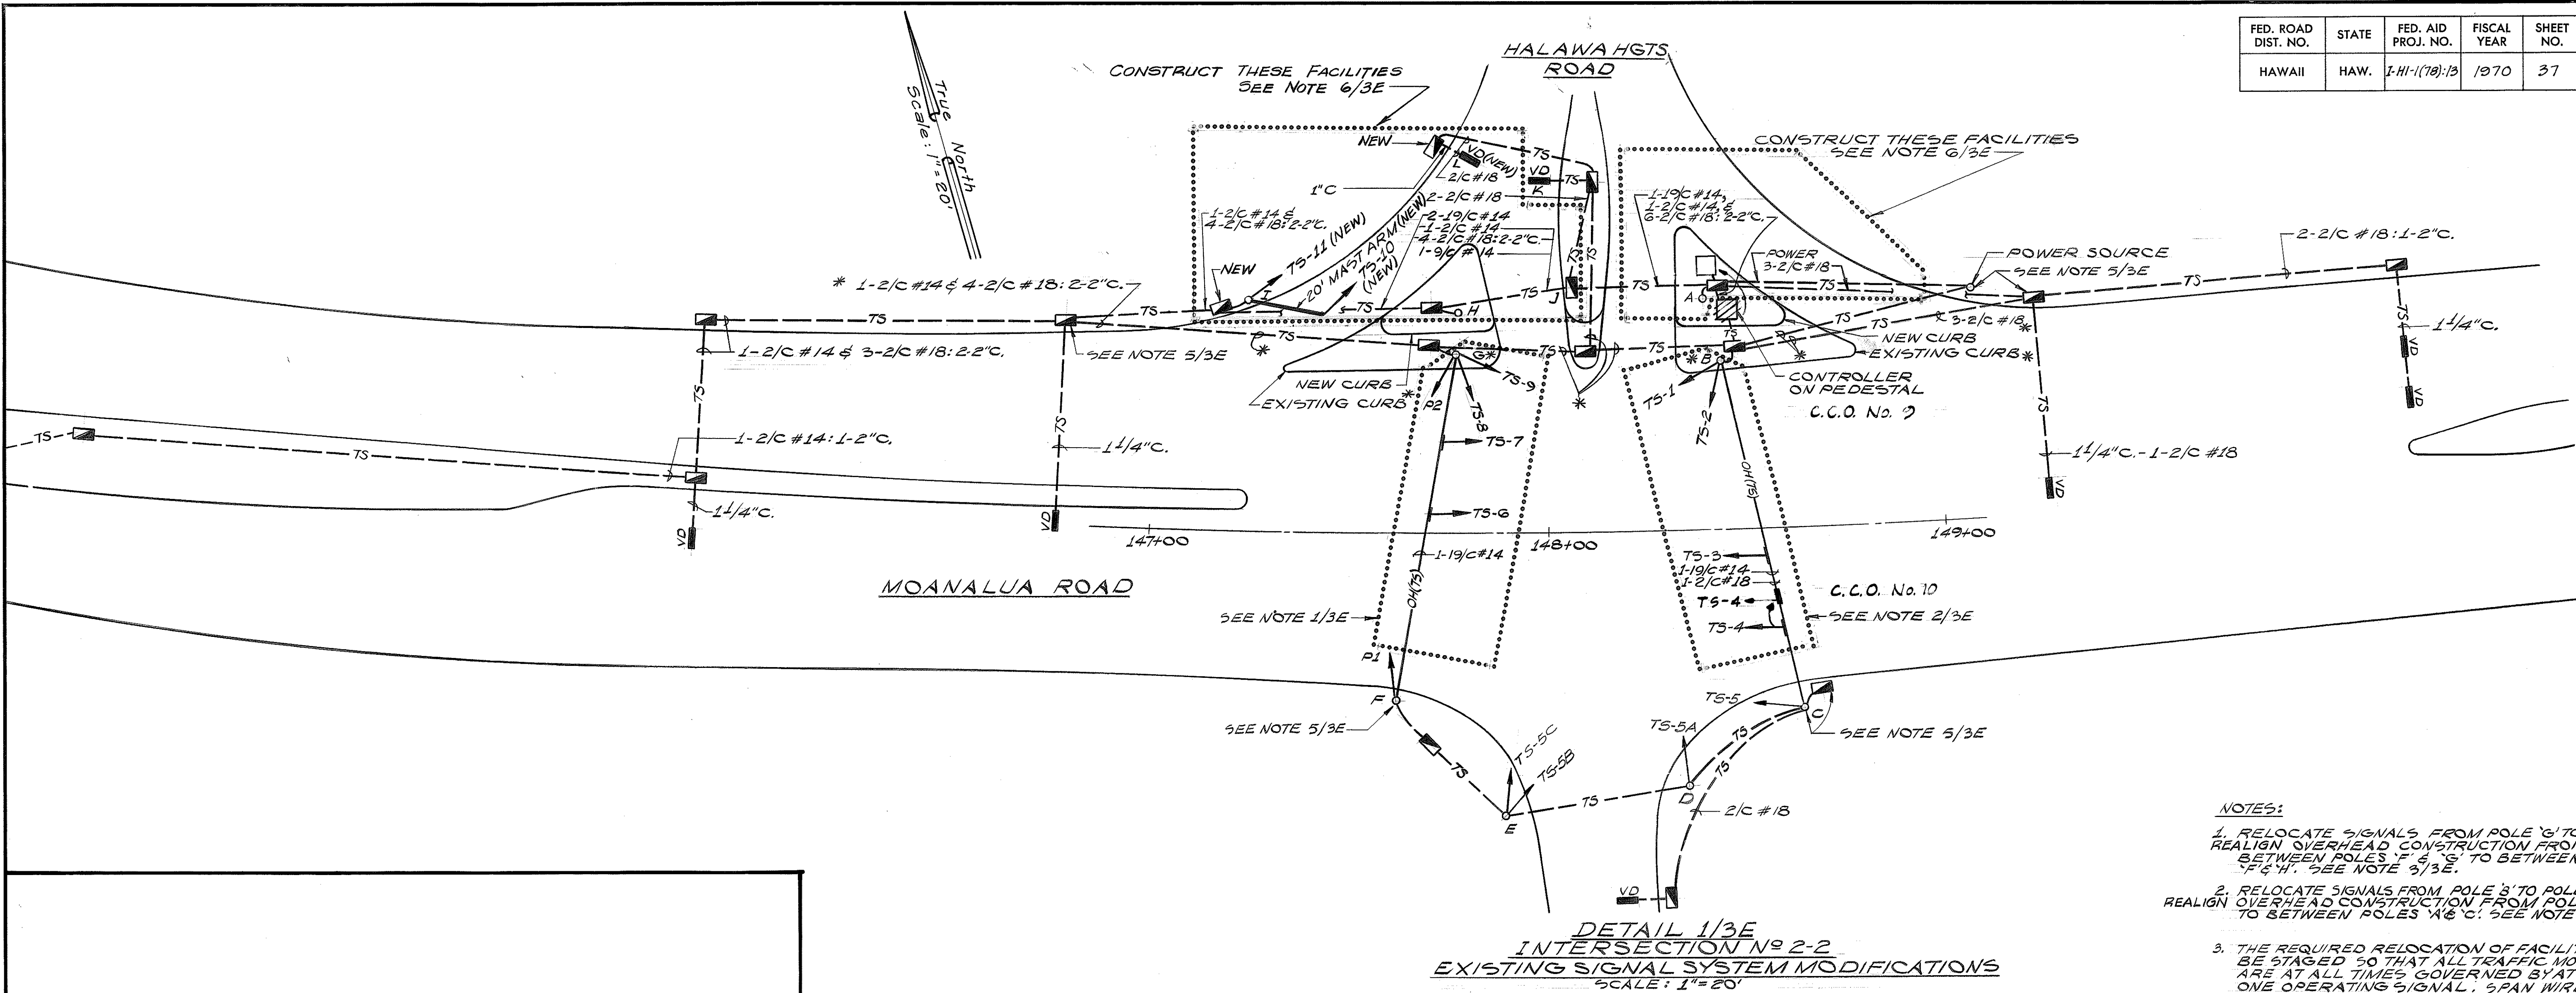

- NOTES:
1. RELOCATE SIGNALS FROM POLE 'G' TO POLE 'H'; REALIGN OVERHEAD CONSTRUCTION FROM BETWEEN POLES 'F' & 'G' TO BETWEEN POLES 'F' & 'H'. SEE NOTE 5/3E.
 2. RELOCATE SIGNALS FROM POLE 'B' TO POLE 'A'; REALIGN OVERHEAD CONSTRUCTION FROM POLES 'B' & 'C' TO BETWEEN POLES 'A' & 'C'. SEE NOTE 5/3E.
 3. THE REQUIRED RELOCATION OF FACILITIES SHALL BE STAGED SO THAT ALL TRAFFIC MOVEMENTS ARE AT ALL TIMES GOVERNED BY AT LEAST ONE OPERATING SIGNAL. SPAN WIRES MAY BE SPLICED AT THE INDICATED POINTS.
 4. ITEMS REFERENCED WITH ASTERISK (*) SHALL BE REMOVED.
 5. SPLICE EXISTING AND NEW CONDUCTORS TOGETHER AT POINT INDICATED. SEE DETAIL 2/4E.
 6. EXCEPT AS OTHERWISE NOTED, ALL FACILITIES SHOWN IN DETAIL 1/3E ARE EXISTING AND ARE TO REMAIN.

DETAIL 1/3E
INTERSECTION NO 2-2
EXISTING SIGNAL SYSTEM MODIFICATIONS
SCALE: 1"=20'

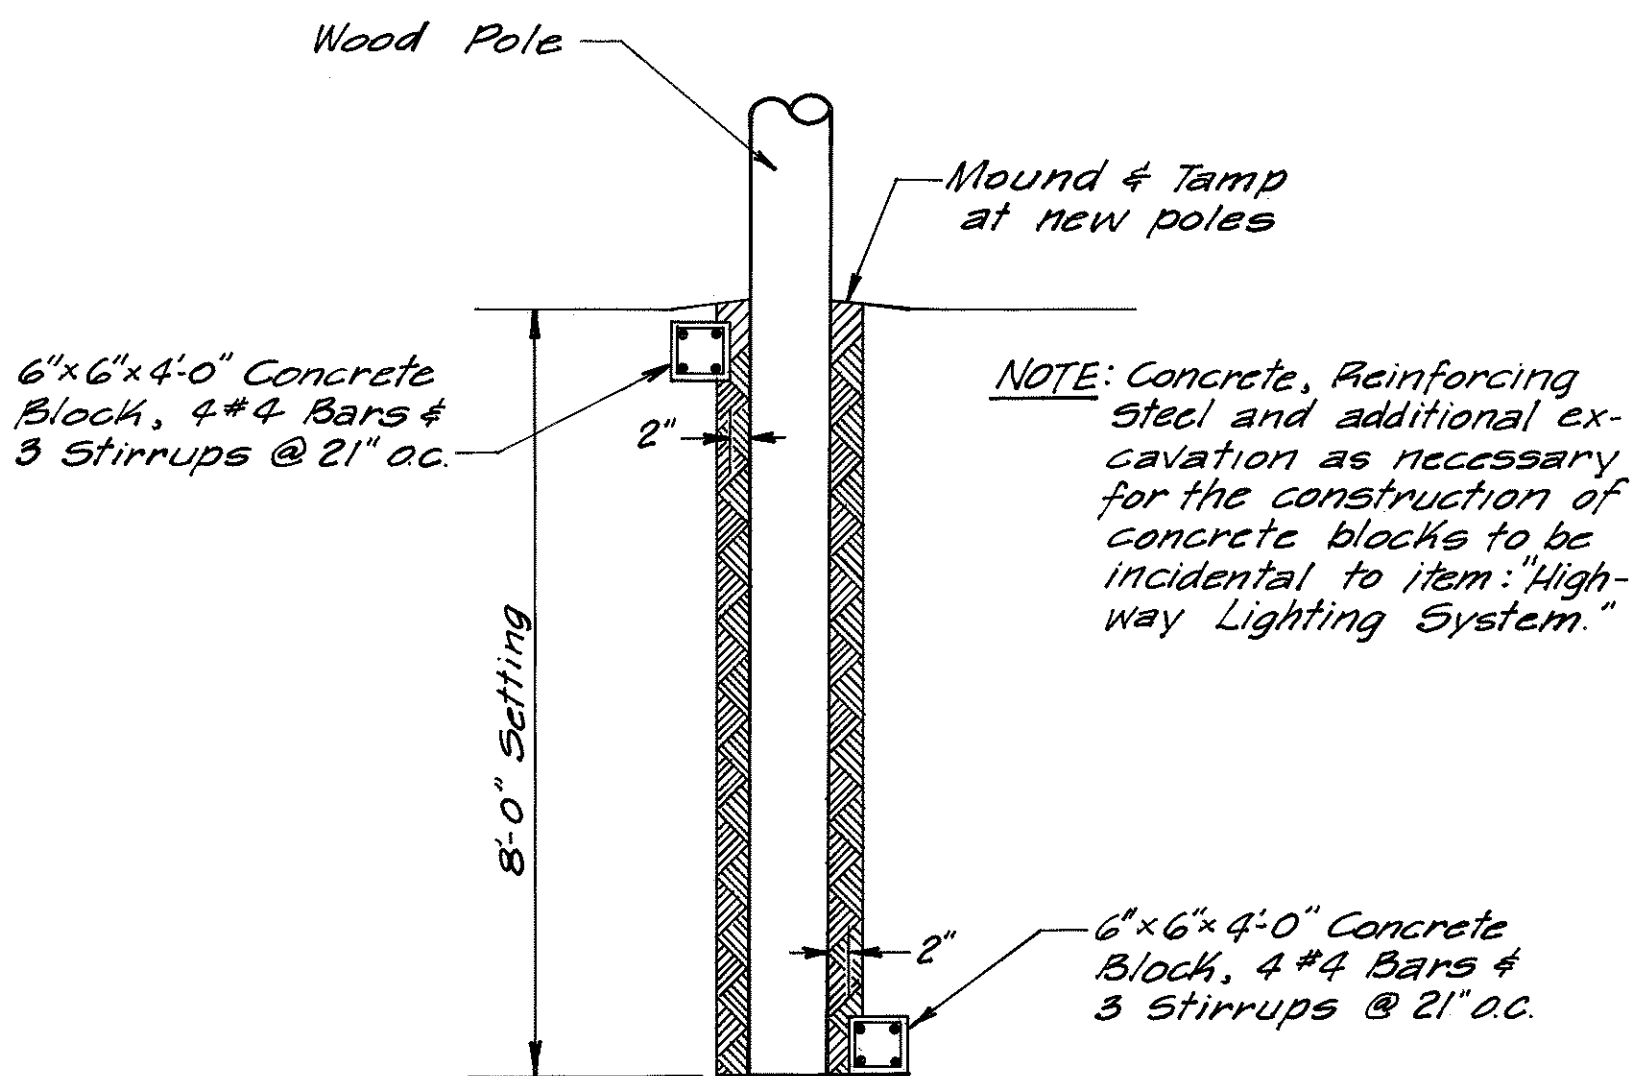

SPECIAL POLE SETTING DETAIL
NOT TO SCALE



THIS WORK WAS PREPARED BY
ME OR UNDER MY SUPERVISION

Michael A. Marszalowicz

ELECTRICAL SHEET 3E

STATE OF HAWAII
DEPARTMENT OF TRANSPORTATION
HIGHWAYS DIVISION

ELECTRICAL DETAILS AND TRAFFIC SIGNAL PLAN - PART II

HALAWA INTERCHANGE
PROJECT NO. I-HI-1(78):13

SCALE: 1"=20' DATE: APR. 9, 1970

SHEET No. 1 OF 2 SHEETS

33 8

DATE	_____
DESIGNED BY	_____
TRACED BY	_____
DESIGNED BY	_____
QUANTITIES BY	_____
CHECKED BY	_____
ORIGINAL	_____
PLAN	_____
NOTE BOOK	_____
No.	_____

