




FED. ROAD DIST. NO.	STATE	FED. AID PROJ. NO.	FISCAL YEAR	SHEET NO.	TOTAL SHEETS
HAWAII	HAW.	I-HI-(57)18	1973	15	16

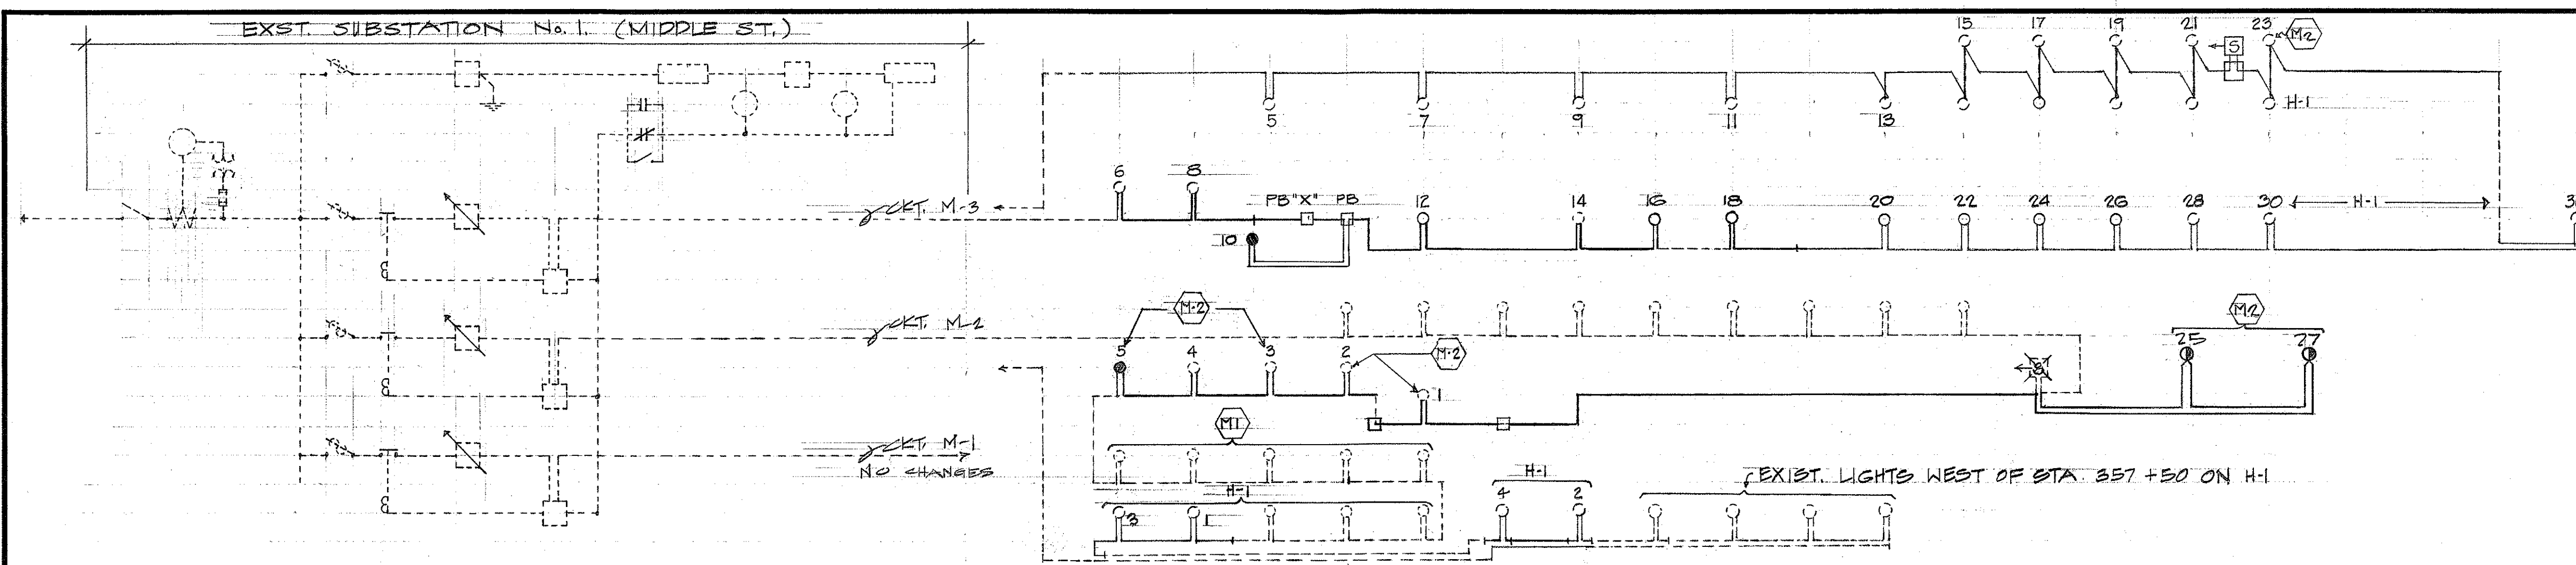



SUBSTATION NO. 1 ONE-LINE DIAGRAM

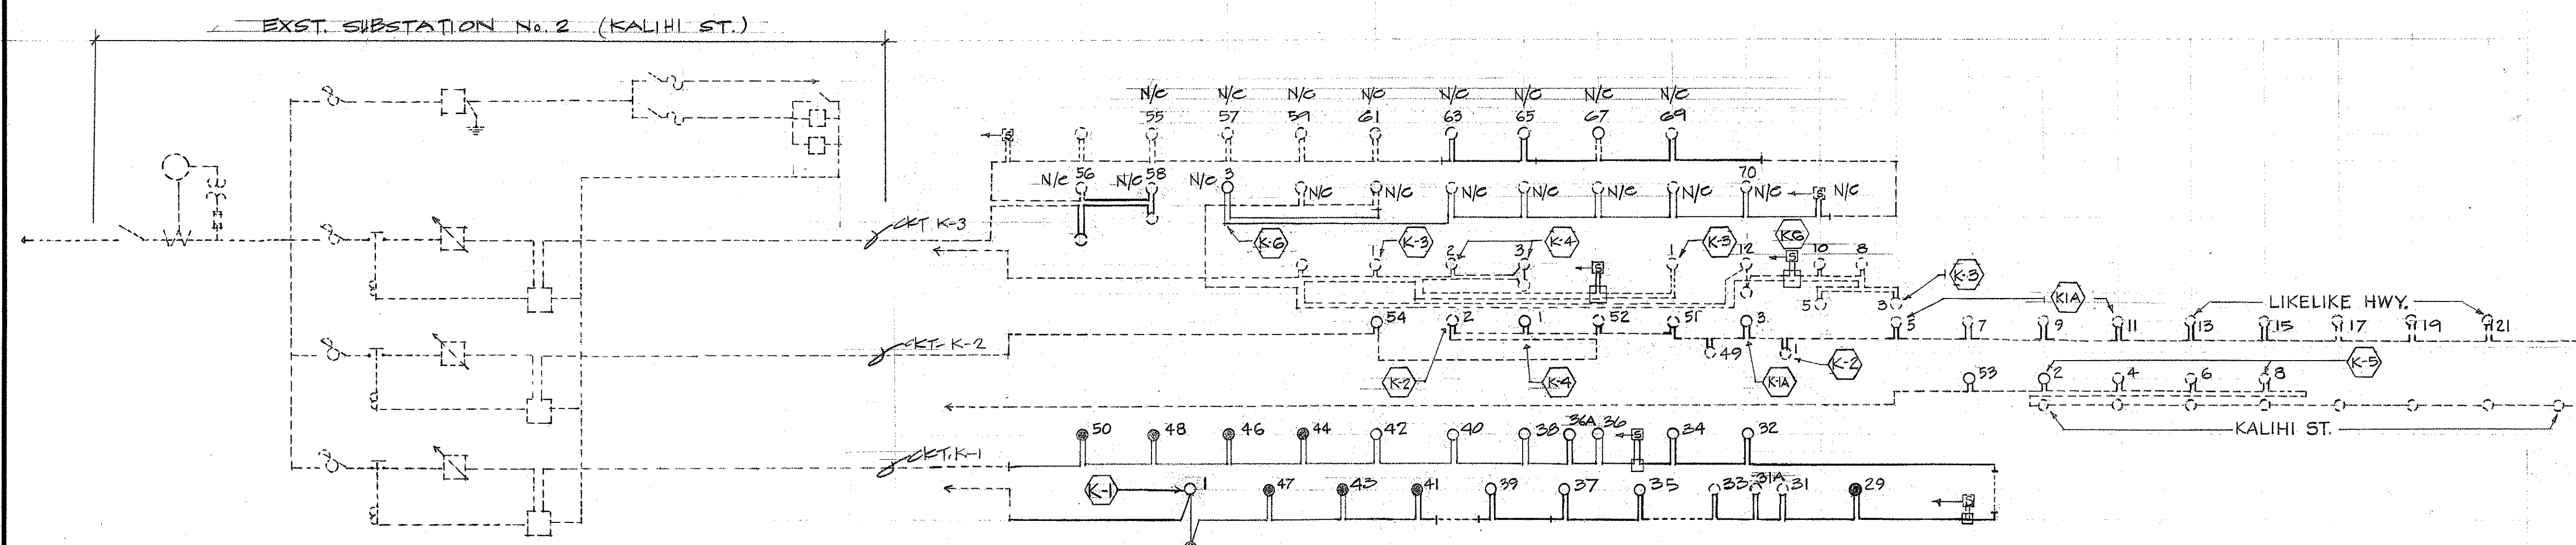

SUBSTATION NO. 2 ONE-LINE DIAGRAM

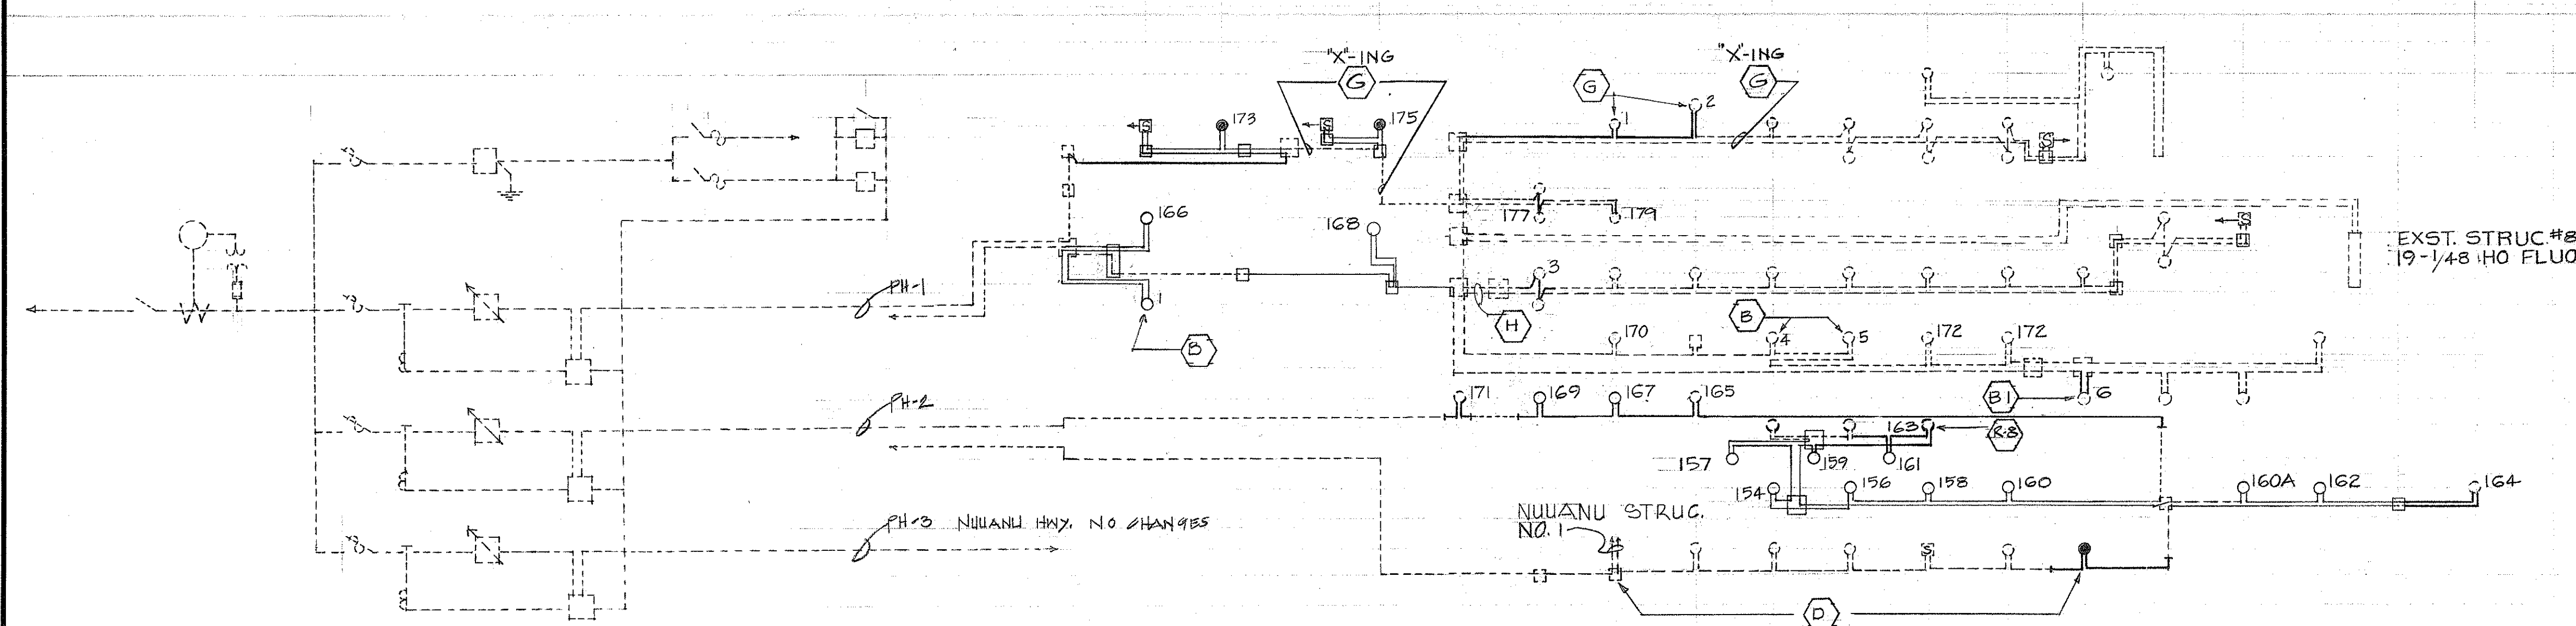


SUBSTATION NO. 3 ONE-LINE DIAGRAM

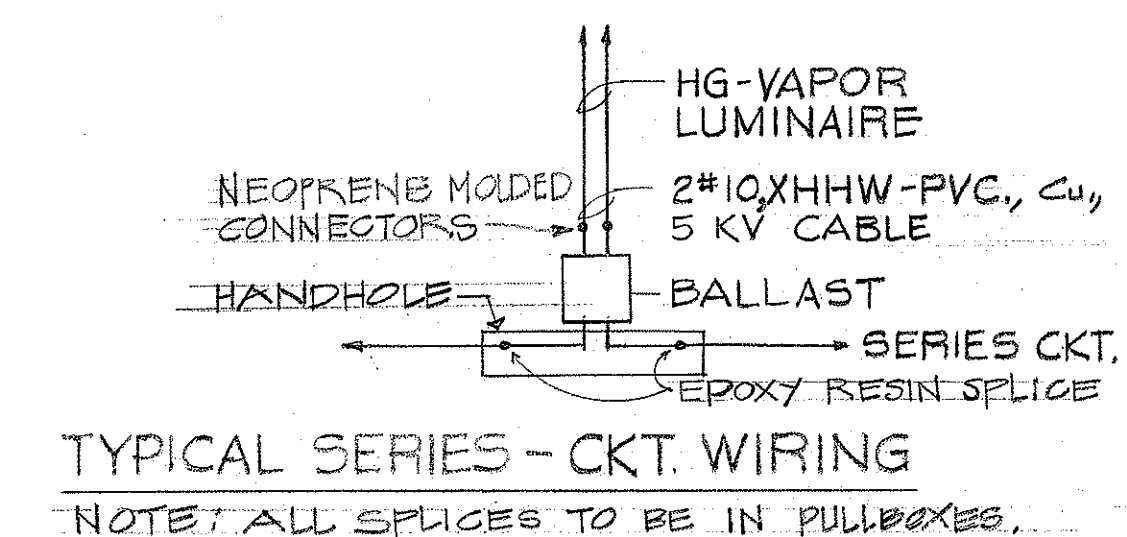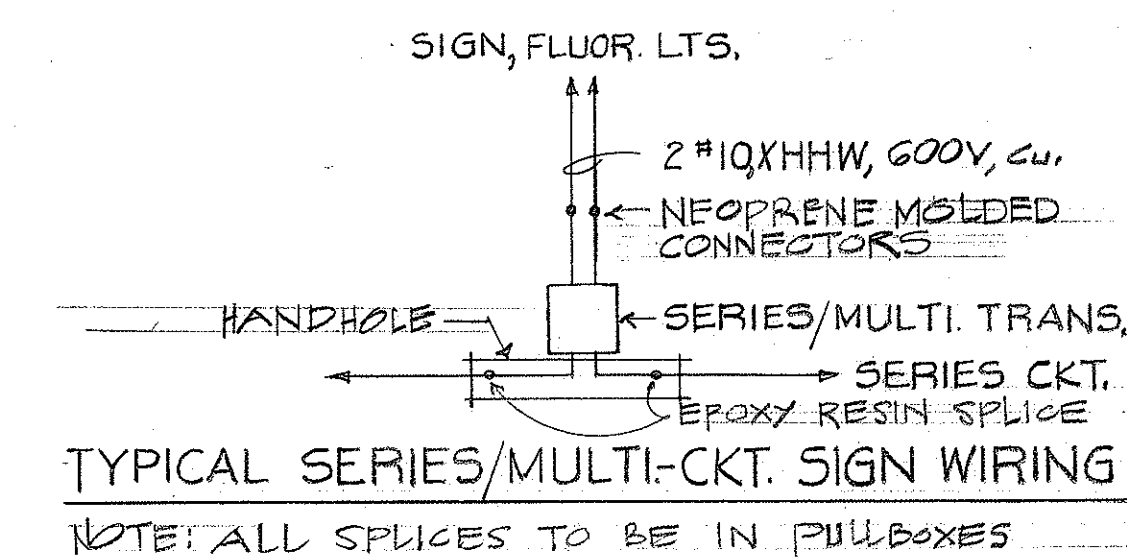

SYMBOLS

- (K-3) INDICATOR FOR RAMP ASSIGNMENT
- 700 W HG-VAPOR
- 400 W HG-VAPOR
- ILLUM. SIGN
- EXIST. CABLE
- NEW CABLE W/2" PVC, 36" DEEP
- 1000 W HG-VAPOR
- REUSE LUMINAIRE

NOTE:
DIAGRAMS ARE FOR GUIDE ONLY

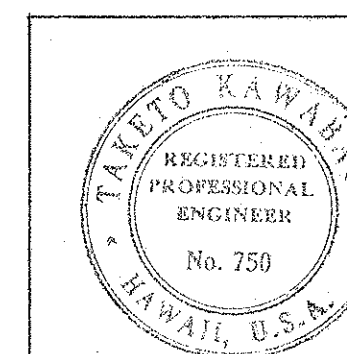

THIS WORK WAS PREPARED BY
ME OR UNDER MY SUPERVISION.
TAKITO KAWABATA

STATE OF HAWAII
DEPARTMENT OF TRANSPORTATION
HIGHWAYS DIVISION
HIGHWAY LIGHTING
SERIES SYSTEMS
SAFETY IMPROVEMENT
MIDDLE STREET TO KALIHI STREET
F.A.I. PROJECT NO. I-HI-(57)18
DATE: AUG. 1973

SHEET No. 15 OF SHEETS

PLAN	DRAWN BY	DATE
NOTE BOOK	TRACED BY	
	QUANTITIES BY	
	CHECKED BY	
	No.	