


FED. ROAD DIST. NO.	STATE	FED. AID PROJ. NO.	FISCAL YEAR	SHEET NO.	TOTAL SHEETS
HAWAII	HAW.	I-41-1(97):3	1973	15	27

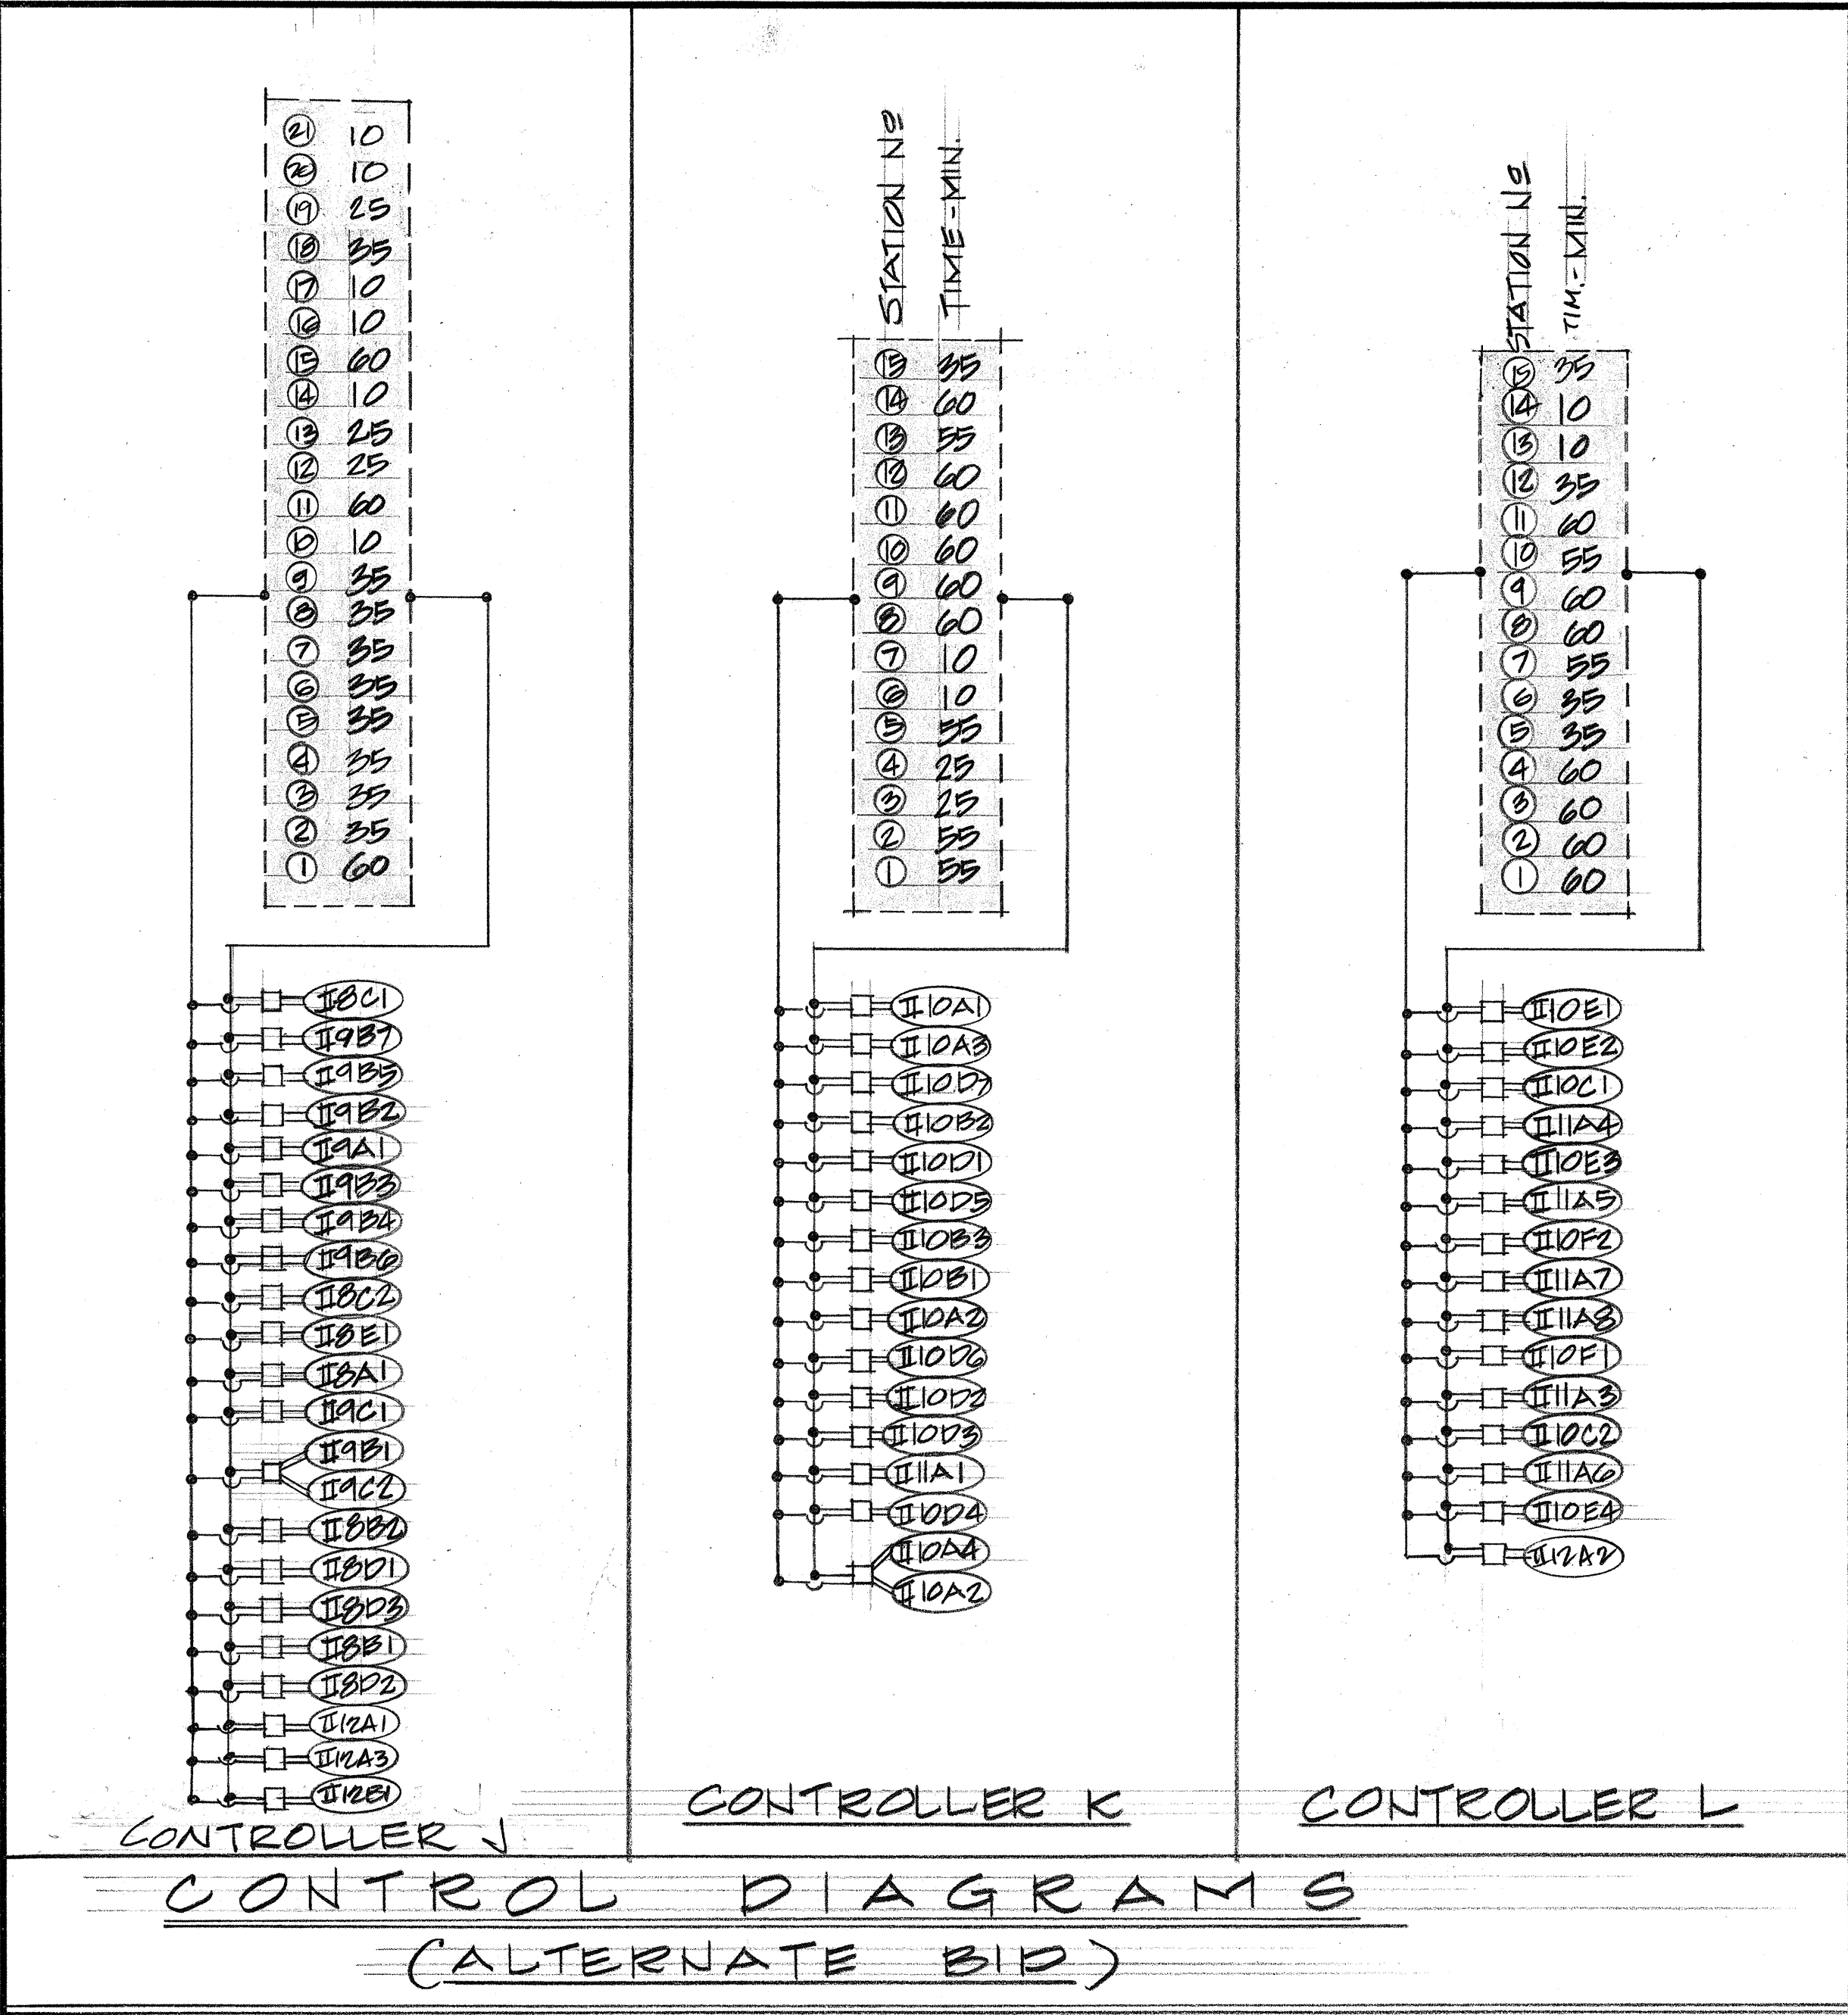

DELETE THIS SHEET SEE
SHEET NO. 145-1 THRU 145-3
145-1, THRU 145-3

ORIGINAL PLAN	SURVEY PLOTTED BY	DATE
NOTE BOOK	DRAWN BY	
No.	TRACED BY	
	CHECKED BY	
	QUANTITIES BY	
	CHECKED BY	

PHILIP K. H. YEE & ASSOCIATES
CONSULTING ENGINEERS
243 Uluokalani Ave., Rm. 101
Honolulu, Hawaii 96813

CURTIS Q. H. YEE
REGISTERED PROFESSIONAL ENGINEER
No. 2694-E
HAWAII, U.S.A.

THIS WORK WAS PREPARED BY ME
OR UNDER MY SUPERVISION.

STATE OF HAWAII
DEPARTMENT OF TRANSPORTATION
HIGHWAYS DIVISION

WAIAWA INTERCHANGE
WATER SPRINKLER SYSTEM
PROJ # I-41-1(97):3

CONTROL DIAGRAM
(ALT)