
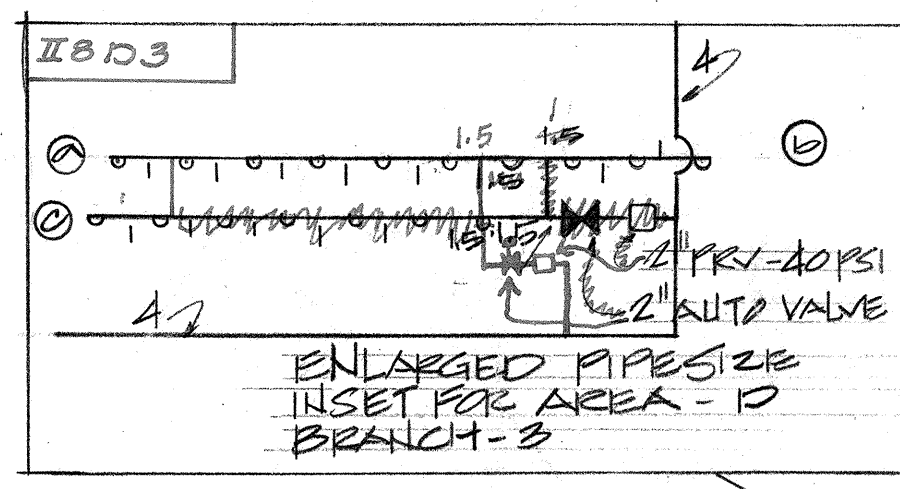


FED. ROAD DIST. NO.	STATE	FED. AID PROJ. NO.	FISCAL YEAR	SHEET NO.	TOTAL SHEETS
HAWAII	HAW.	I-41-(197):8	1973	4	27

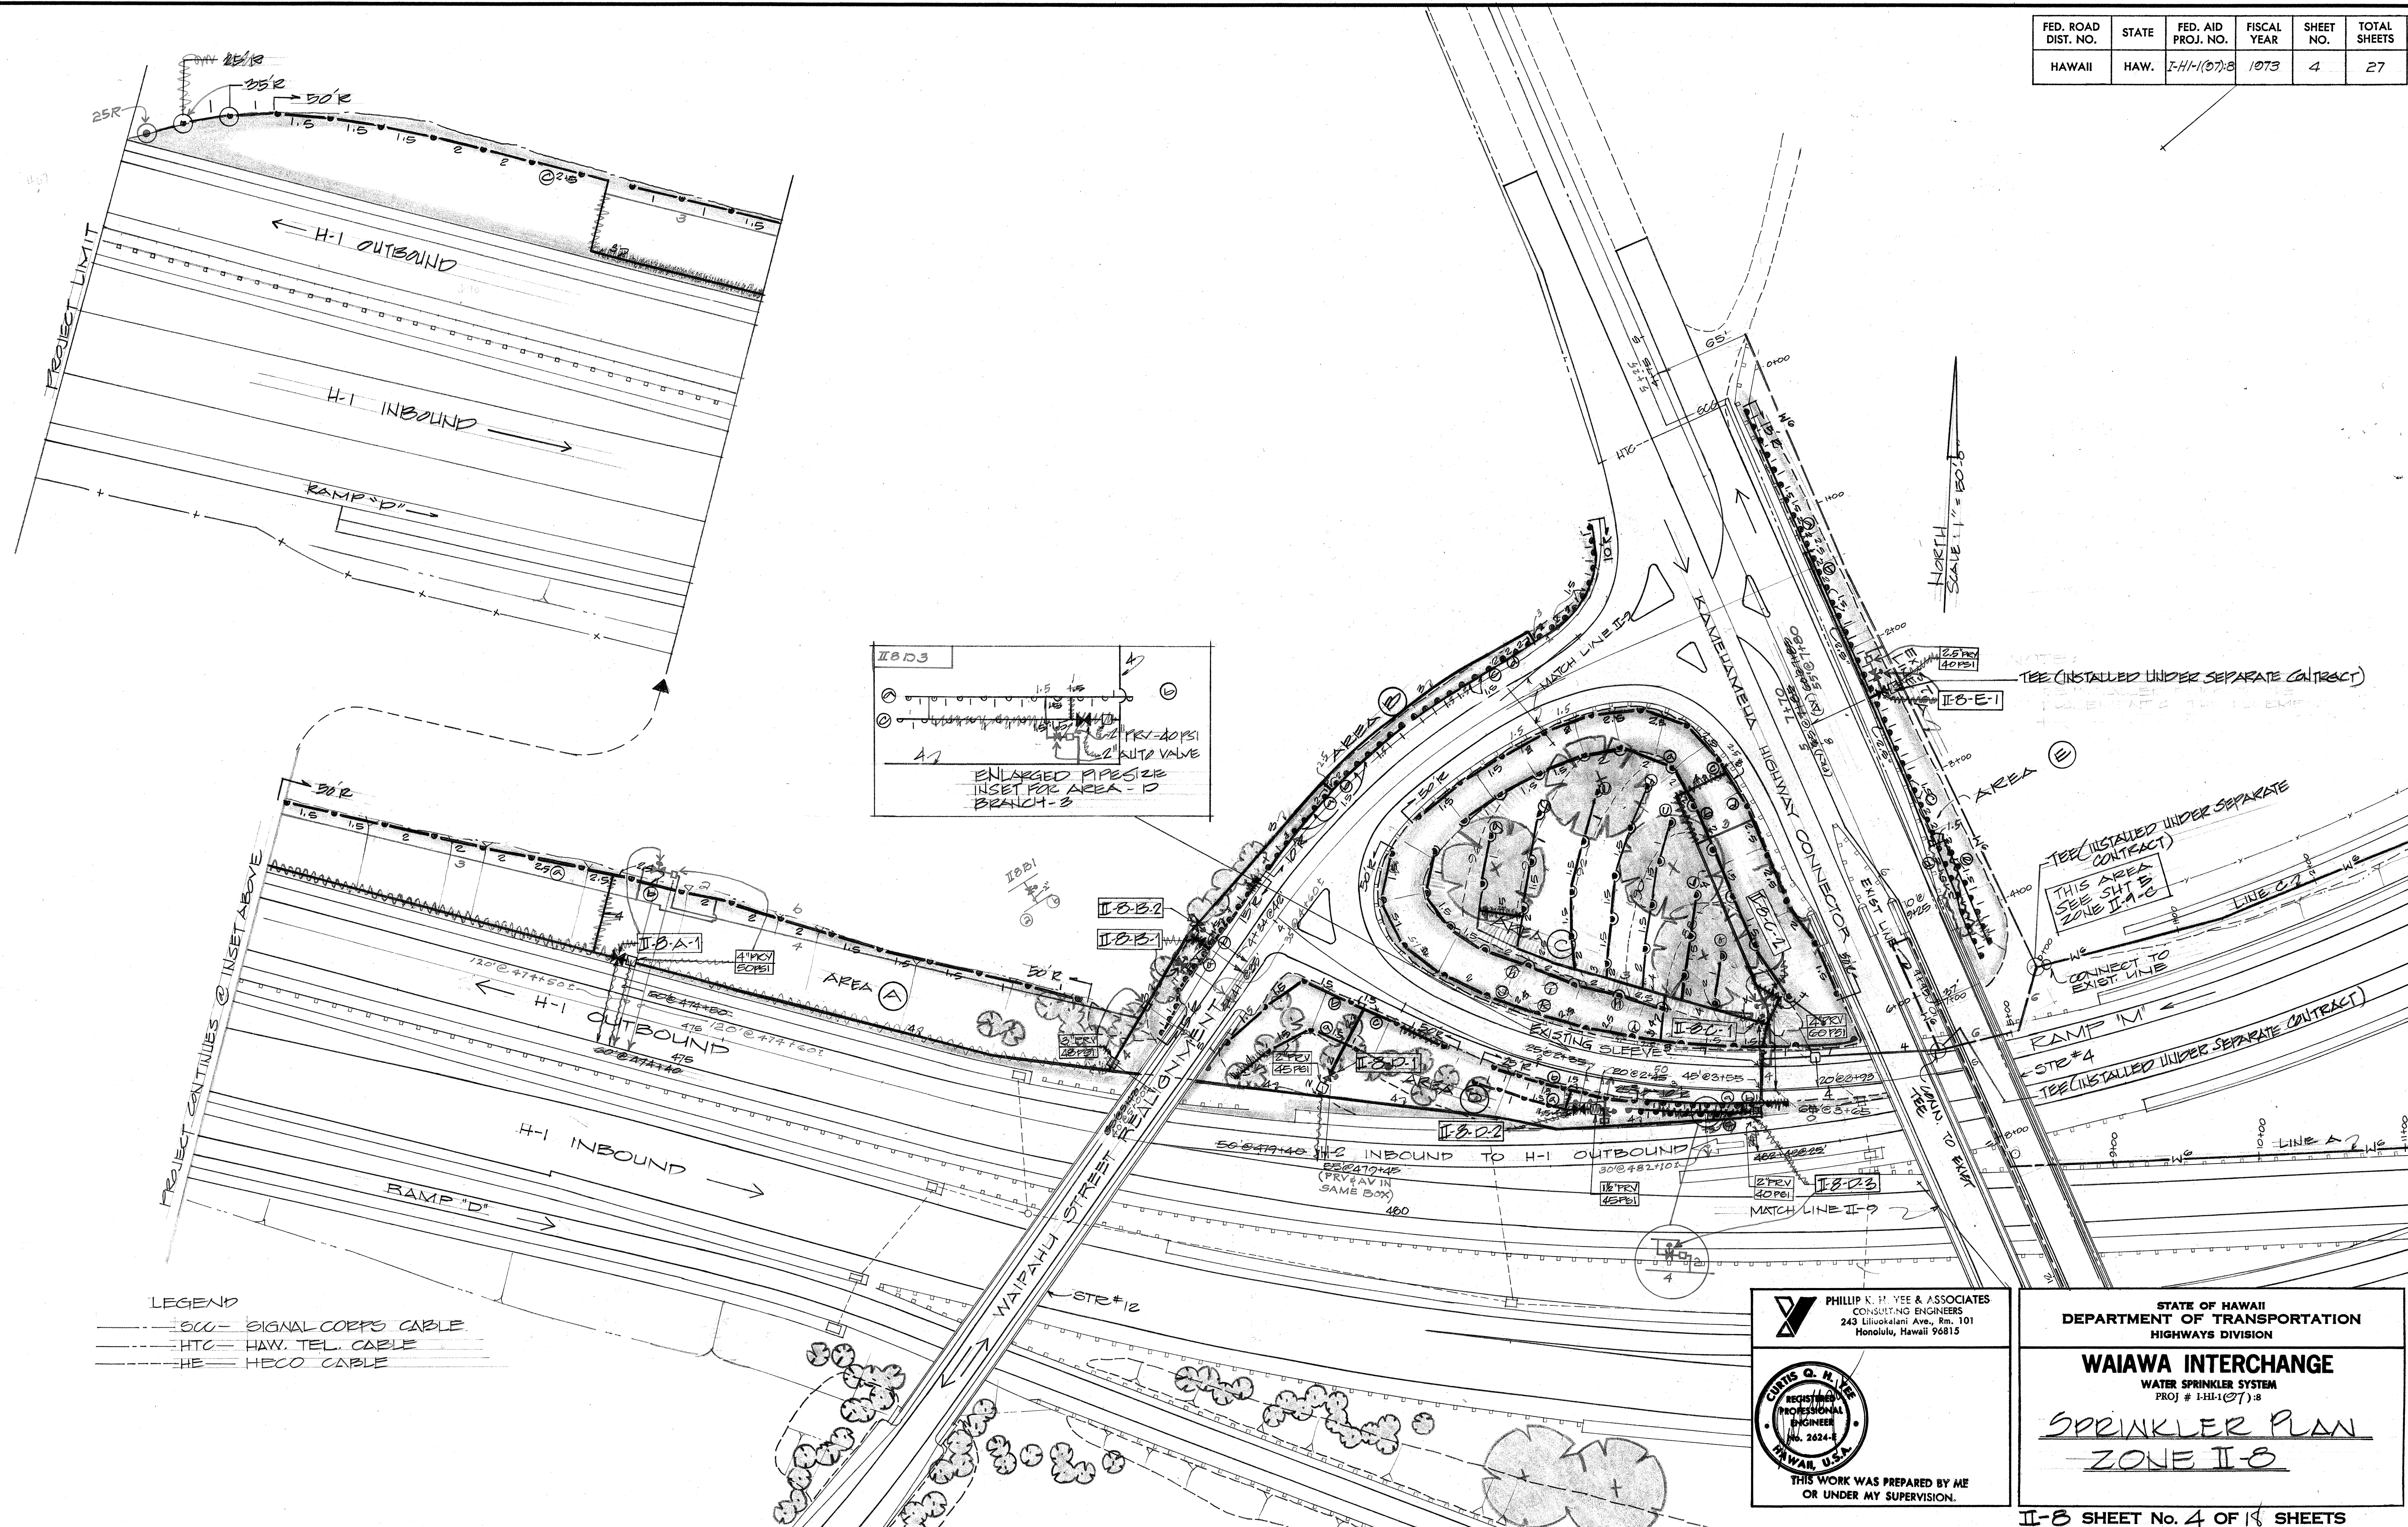

- LEGEND
- SCC --- SIGNAL CORPS CABLE
 - HTC --- HAW. TEL. CABLE
 - HE --- HECCO CABLE

DATE	_____
SURVEY PLOTTED BY	_____
DRAWN BY	_____
CHECKED BY	_____
NOTE BOOK	_____
NO.	_____

PHILLIP K. H. YEE & ASSOCIATES
 CONSULTING ENGINEERS
 243 Liliuokalani Ave., Rm. 101
 Honolulu, Hawaii 96815

THIS WORK WAS PREPARED BY ME
 OR UNDER MY SUPERVISION.

STATE OF HAWAII
 DEPARTMENT OF TRANSPORTATION
 HIGHWAYS DIVISION


WAIAWA INTERCHANGE
 WATER SPRINKLER SYSTEM
 PROJ # I-41-(197):8

SPRINKLER PLAN
ZONE II-B

II-B SHEET No. 4 OF 18 SHEETS


ADD. 4

FED. ROAD DIST. NO.	STATE	FED. AID PROJ. NO.	FISCAL YEAR	SHEET NO.	TOTAL SHEETS
HAWAII	HAW.	I-H-1(07):8	1973	5	27

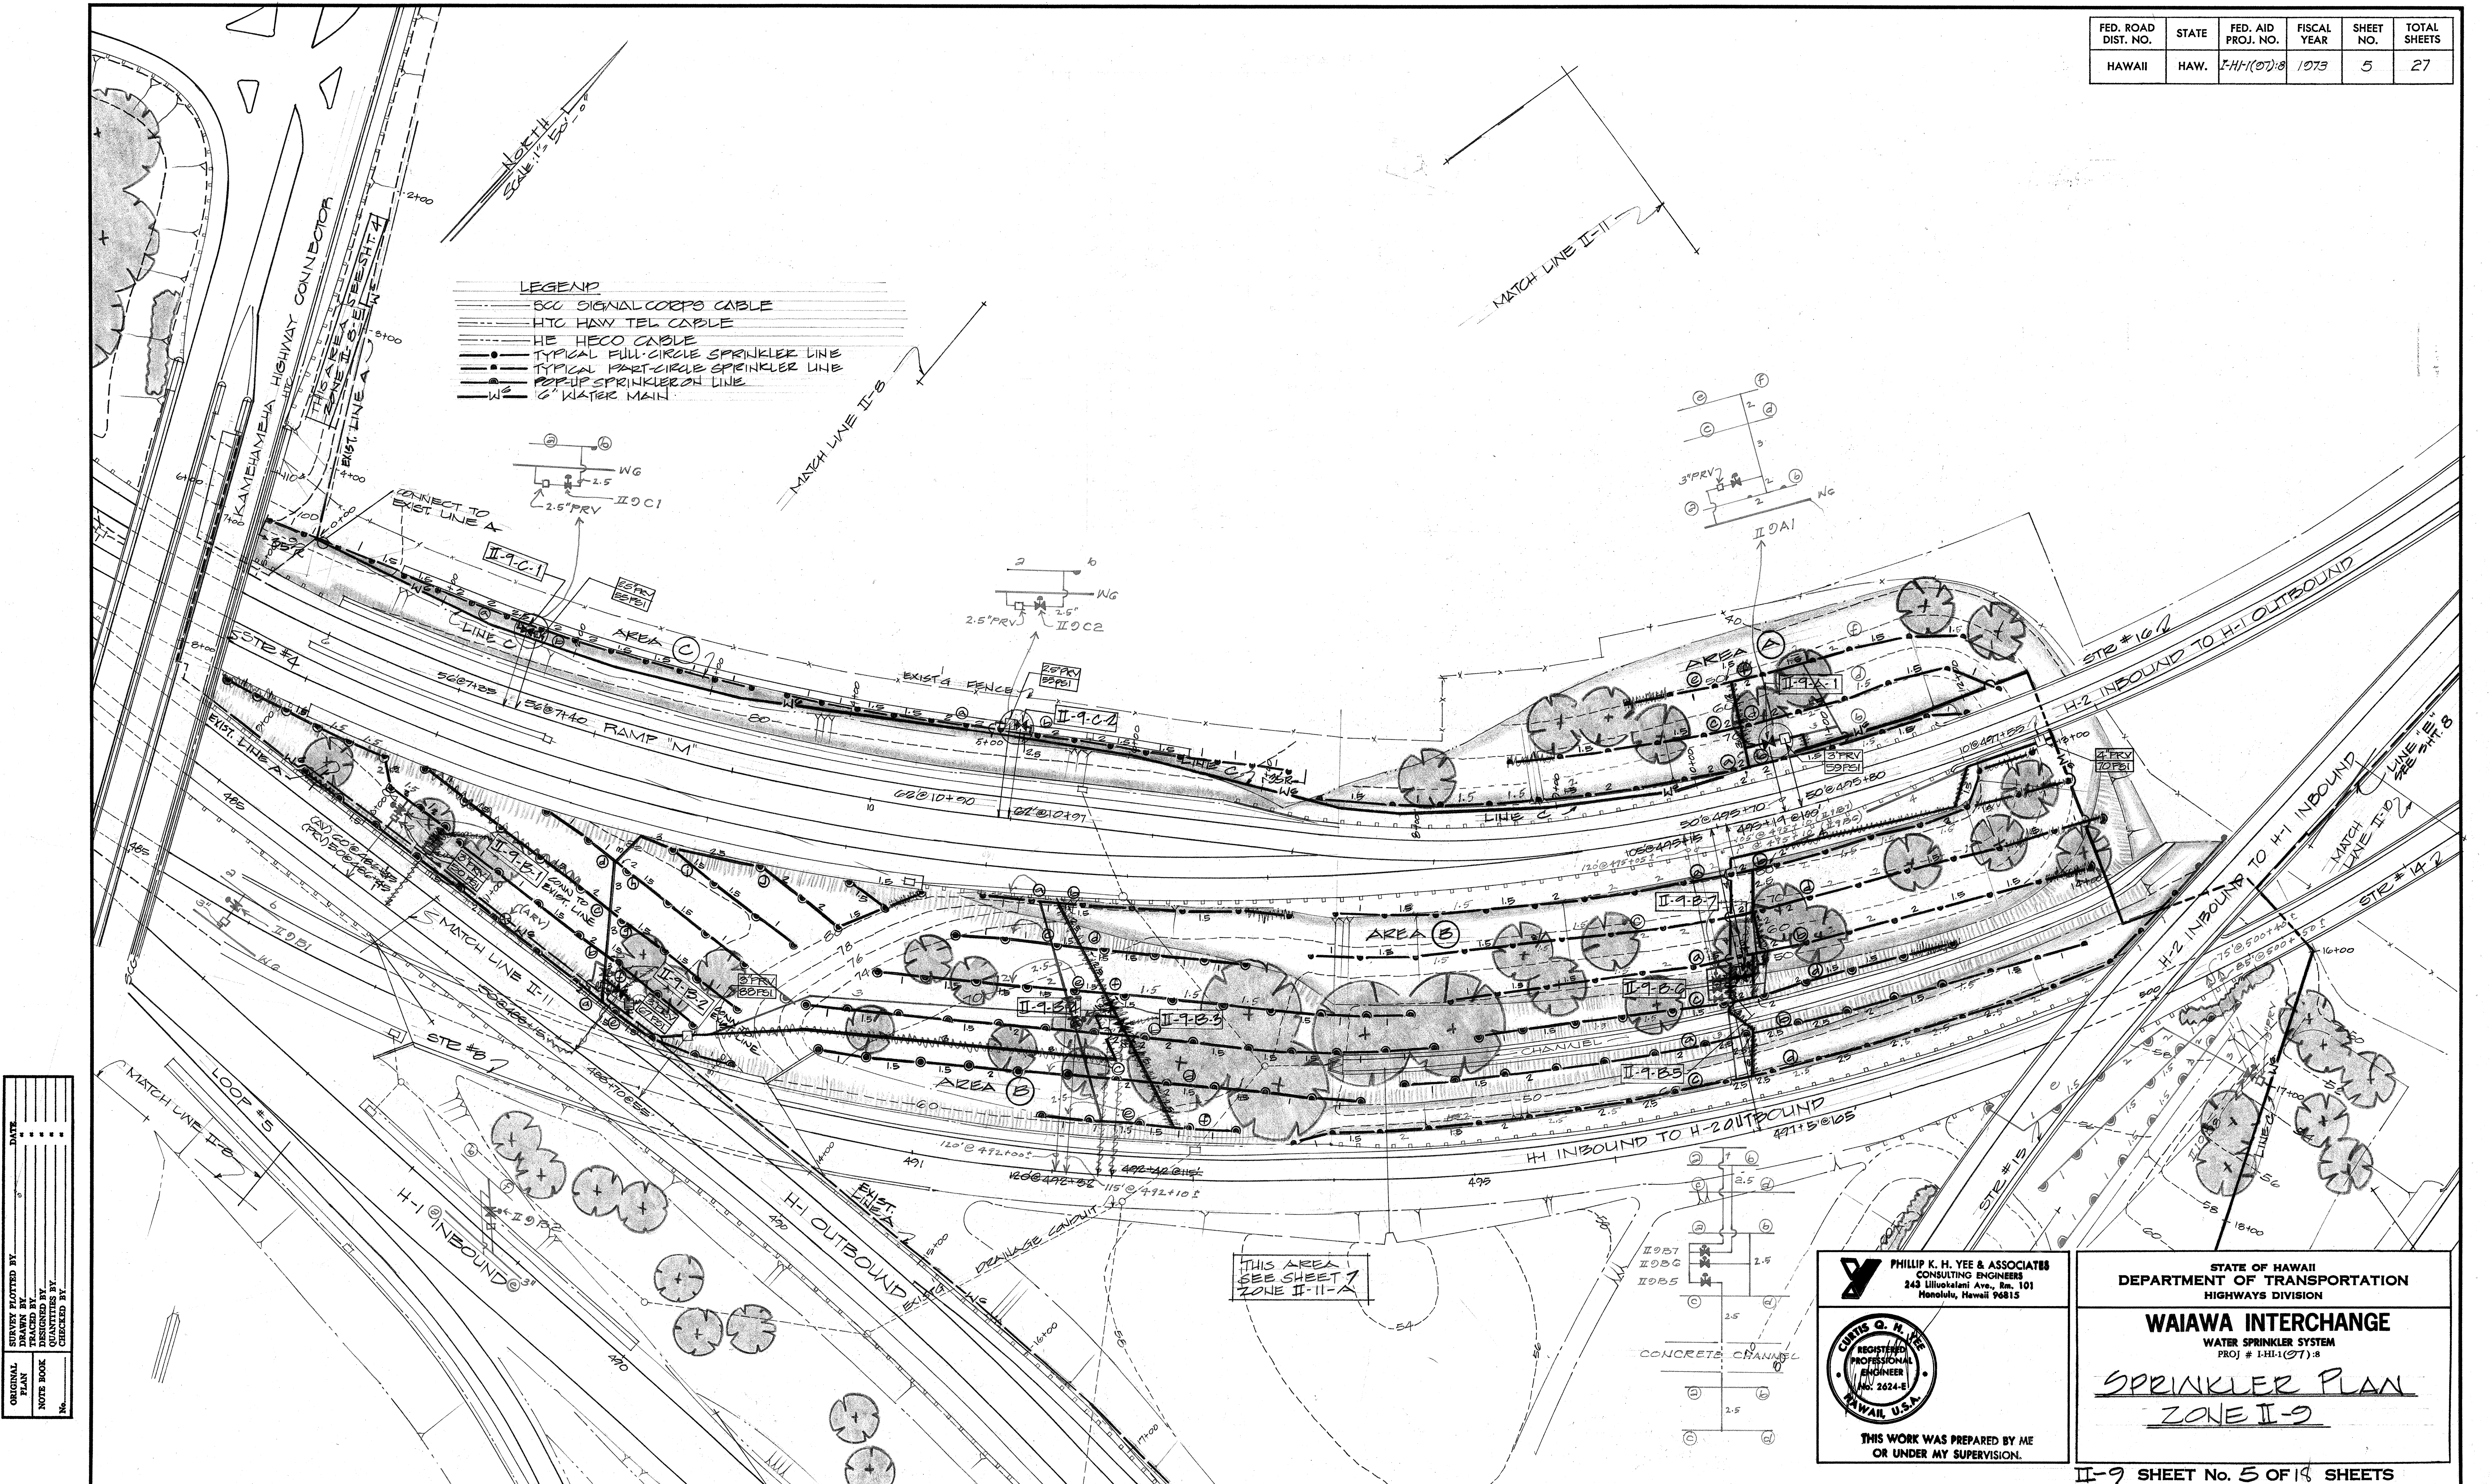

FED. ROAD DIST. NO.	STATE	FED. AID PROJ. NO.	FISCAL YEAR	SHEET NO.	TOTAL SHEETS
HAWAII	HAW.	I-HI-1(97)S	1973	7	27

ORIGINAL PLAN	SURVEY PLOTTED BY	DATE
TRACED BY	_____	_____
DESIGNED BY	_____	_____
CHECKED BY	_____	_____
NOTE BOOK	_____	_____
NO.	_____	_____

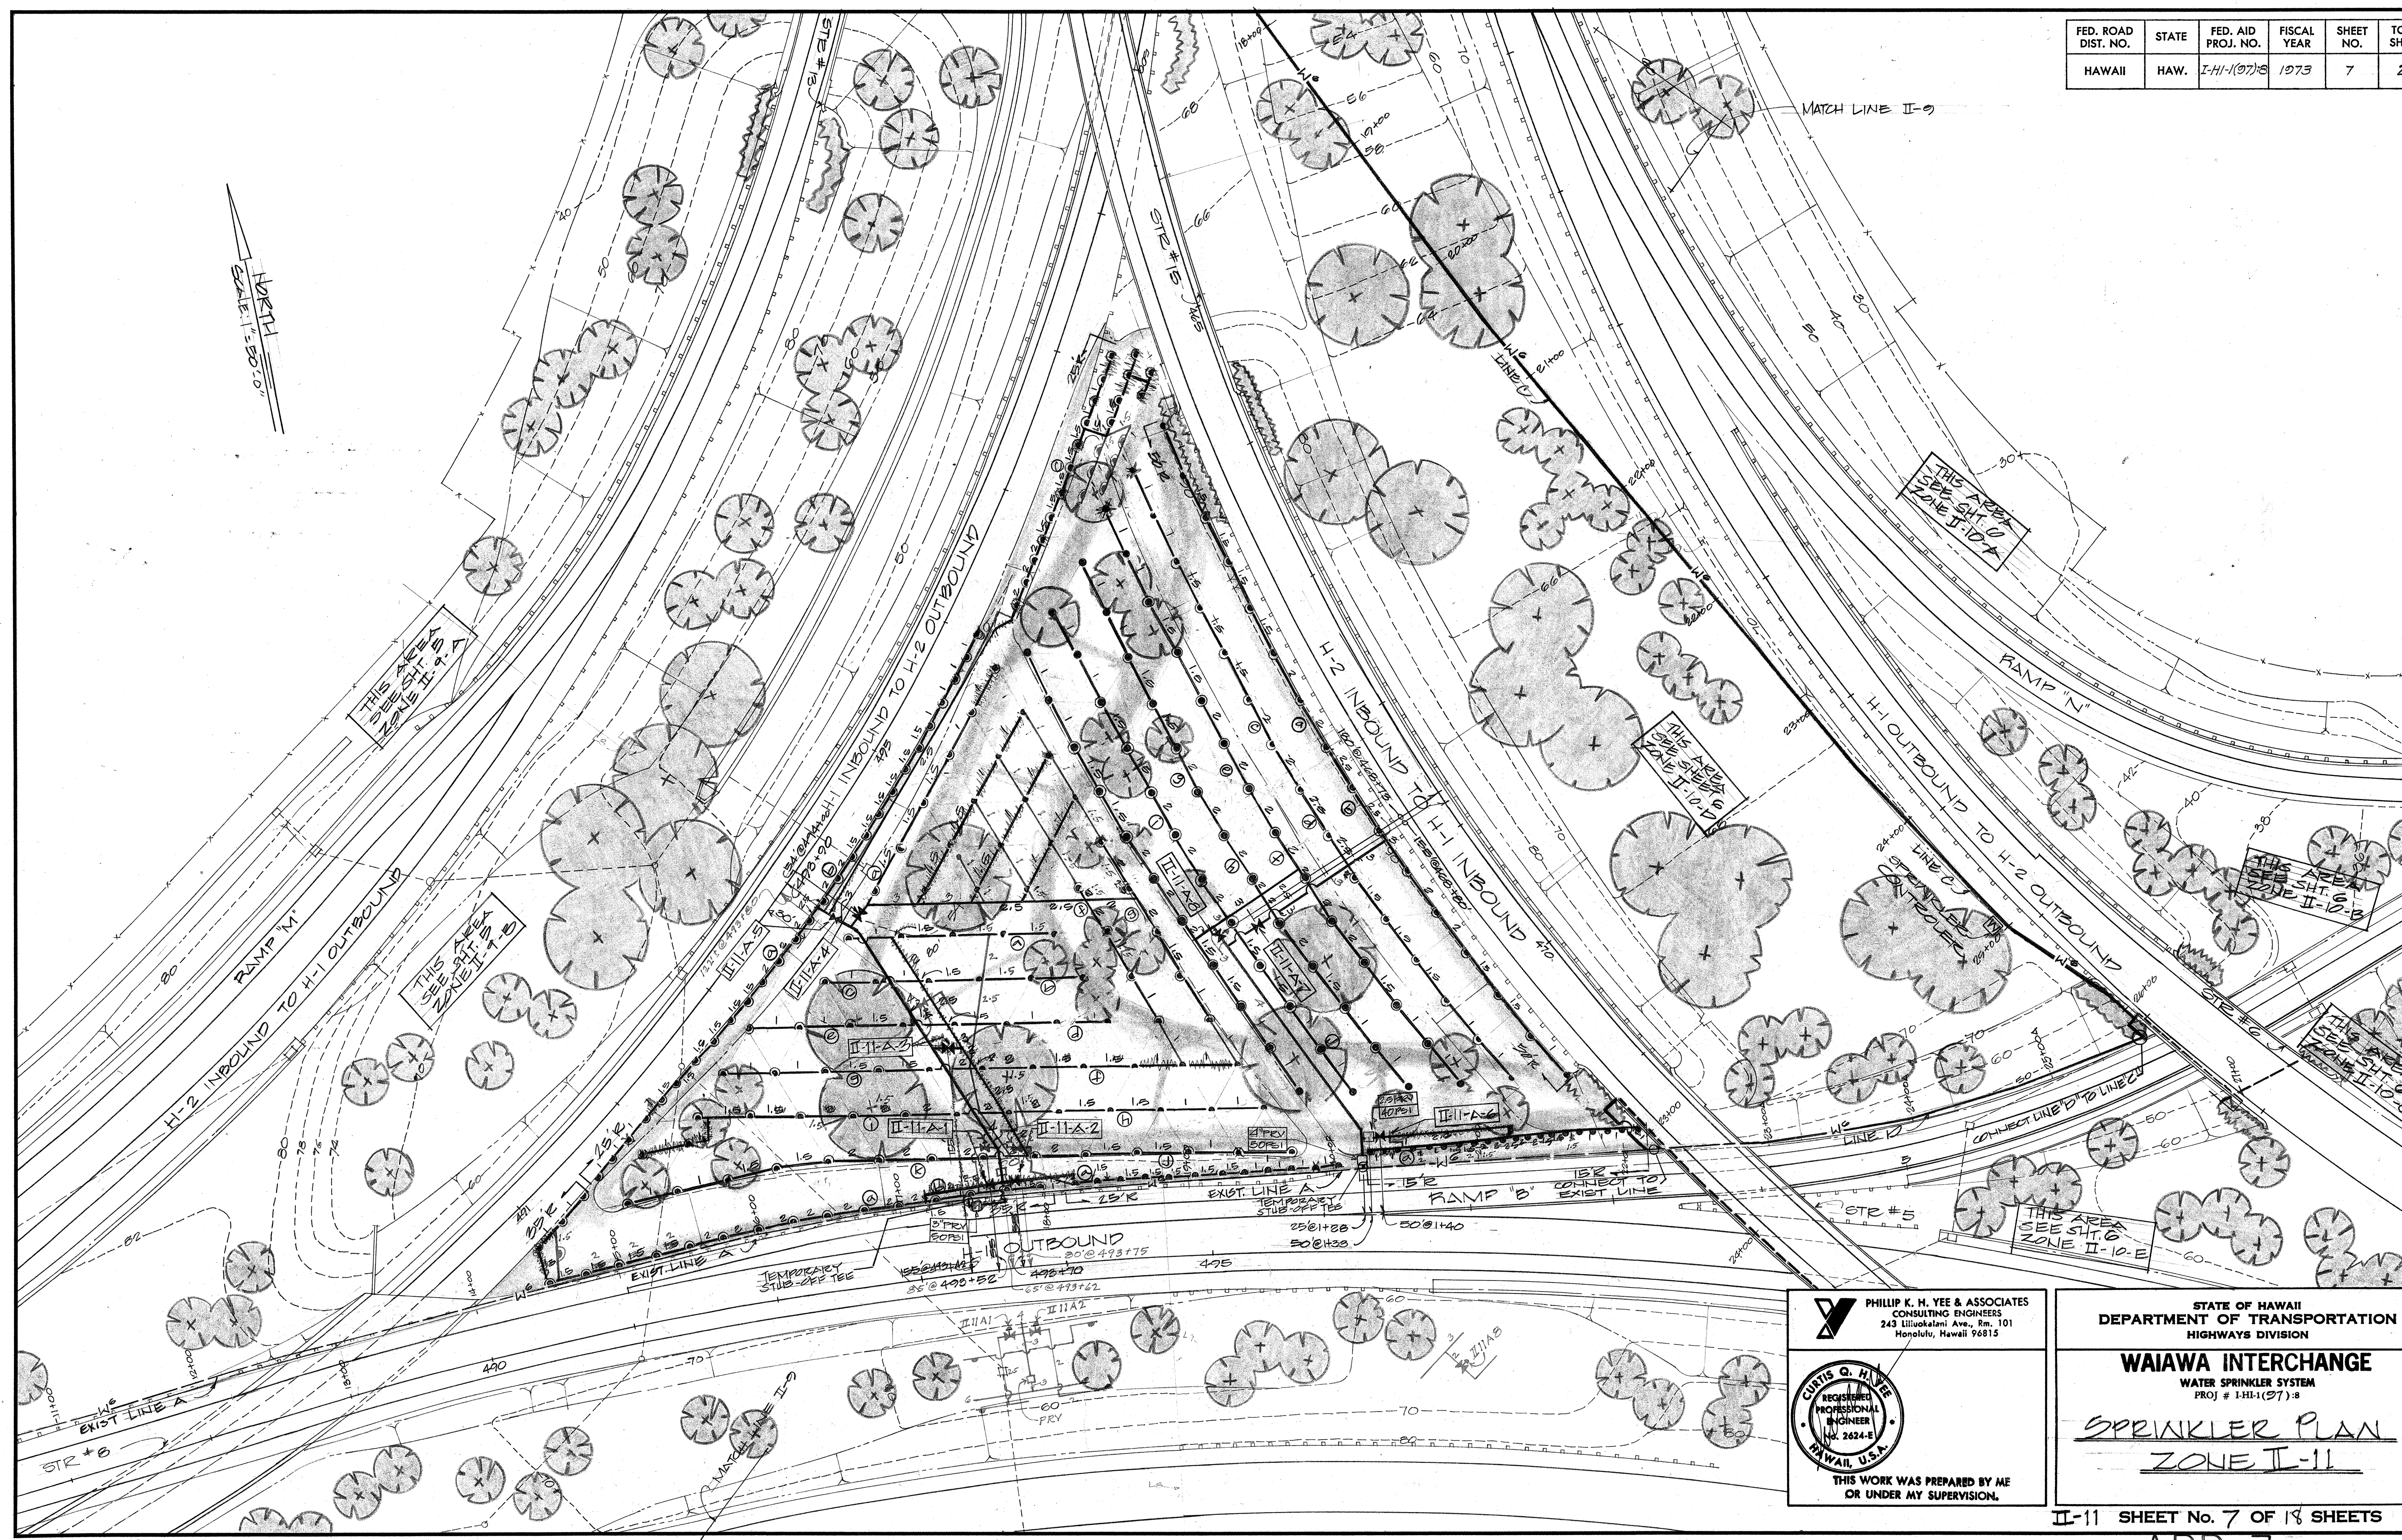



PHILIP K. H. YEE & ASSOCIATES
 CONSULTING ENGINEERS
 243 Liliuokalani Ave., Rm. 101
 Honolulu, Hawaii 96815



CURTIS Q. HILLE
 REGISTERED PROFESSIONAL ENGINEER
 No. 2624-E
 HAWAII, U.S.A.

THIS WORK WAS PREPARED BY ME OR UNDER MY SUPERVISION.

STATE OF HAWAII
DEPARTMENT OF TRANSPORTATION
HIGHWAYS DIVISION

WAIAWA INTERCHANGE
WATER SPRINKLER SYSTEM
PROJ # I-HI-1(97)S

SPRINKLER PLAN
ZONE II-11

FED. ROAD DIST. NO.	STATE	FED. AID PROJ. NO.	FISCAL YEAR	SHEET NO.	TOTAL SHEETS
HAWAII	HAW.	I-HF-1(97)28	1973	8	27

