



FED. ROAD DIST. NO.	STATE	FED. AID PROJ. NO.	FISCAL YEAR	SHEET NO.	TOTAL SHEETS
HAWAII	HAW.	1-HI-1(73):15	1974	34	369

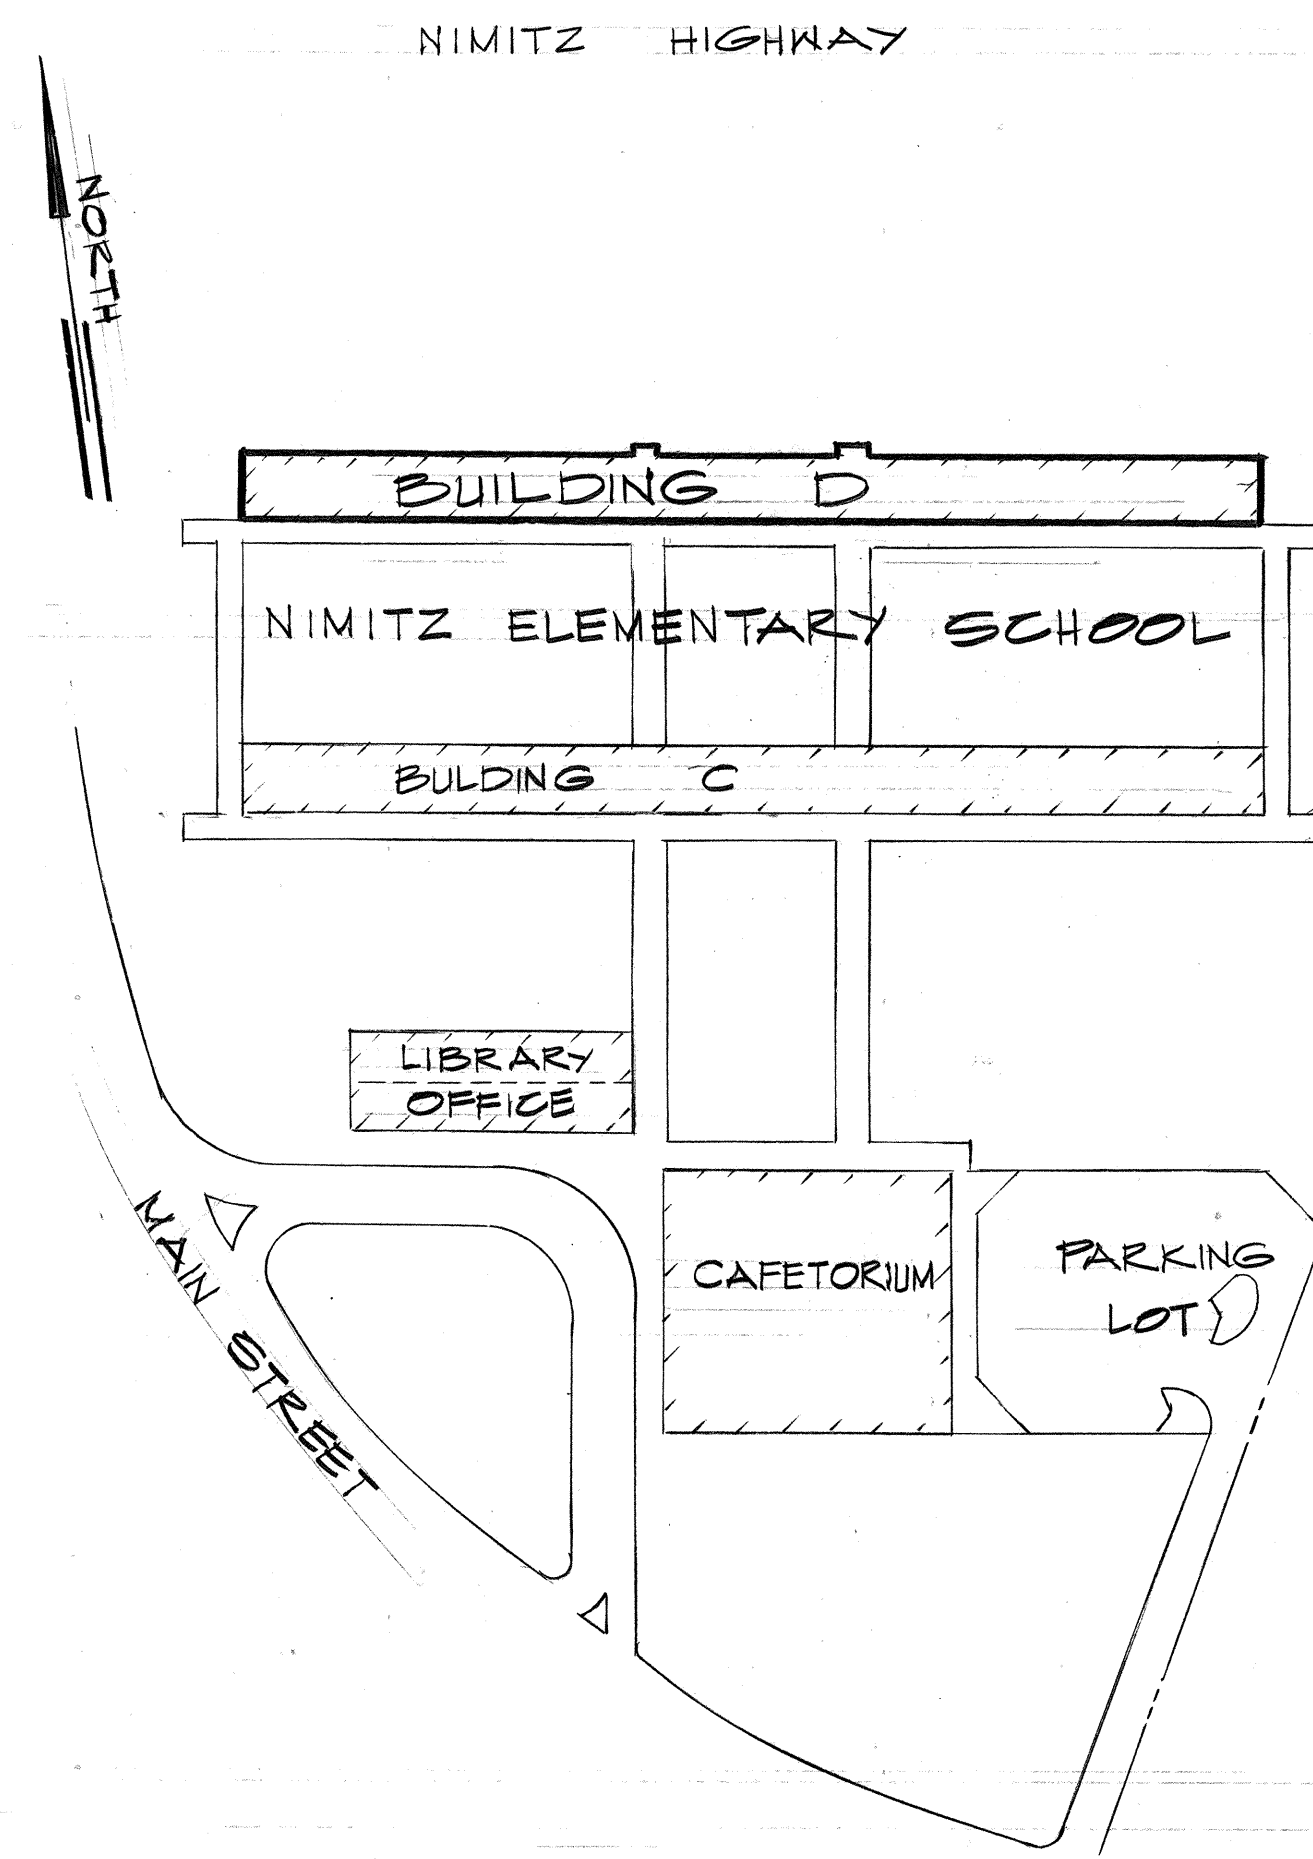


SITE PLAN
NO SCALE

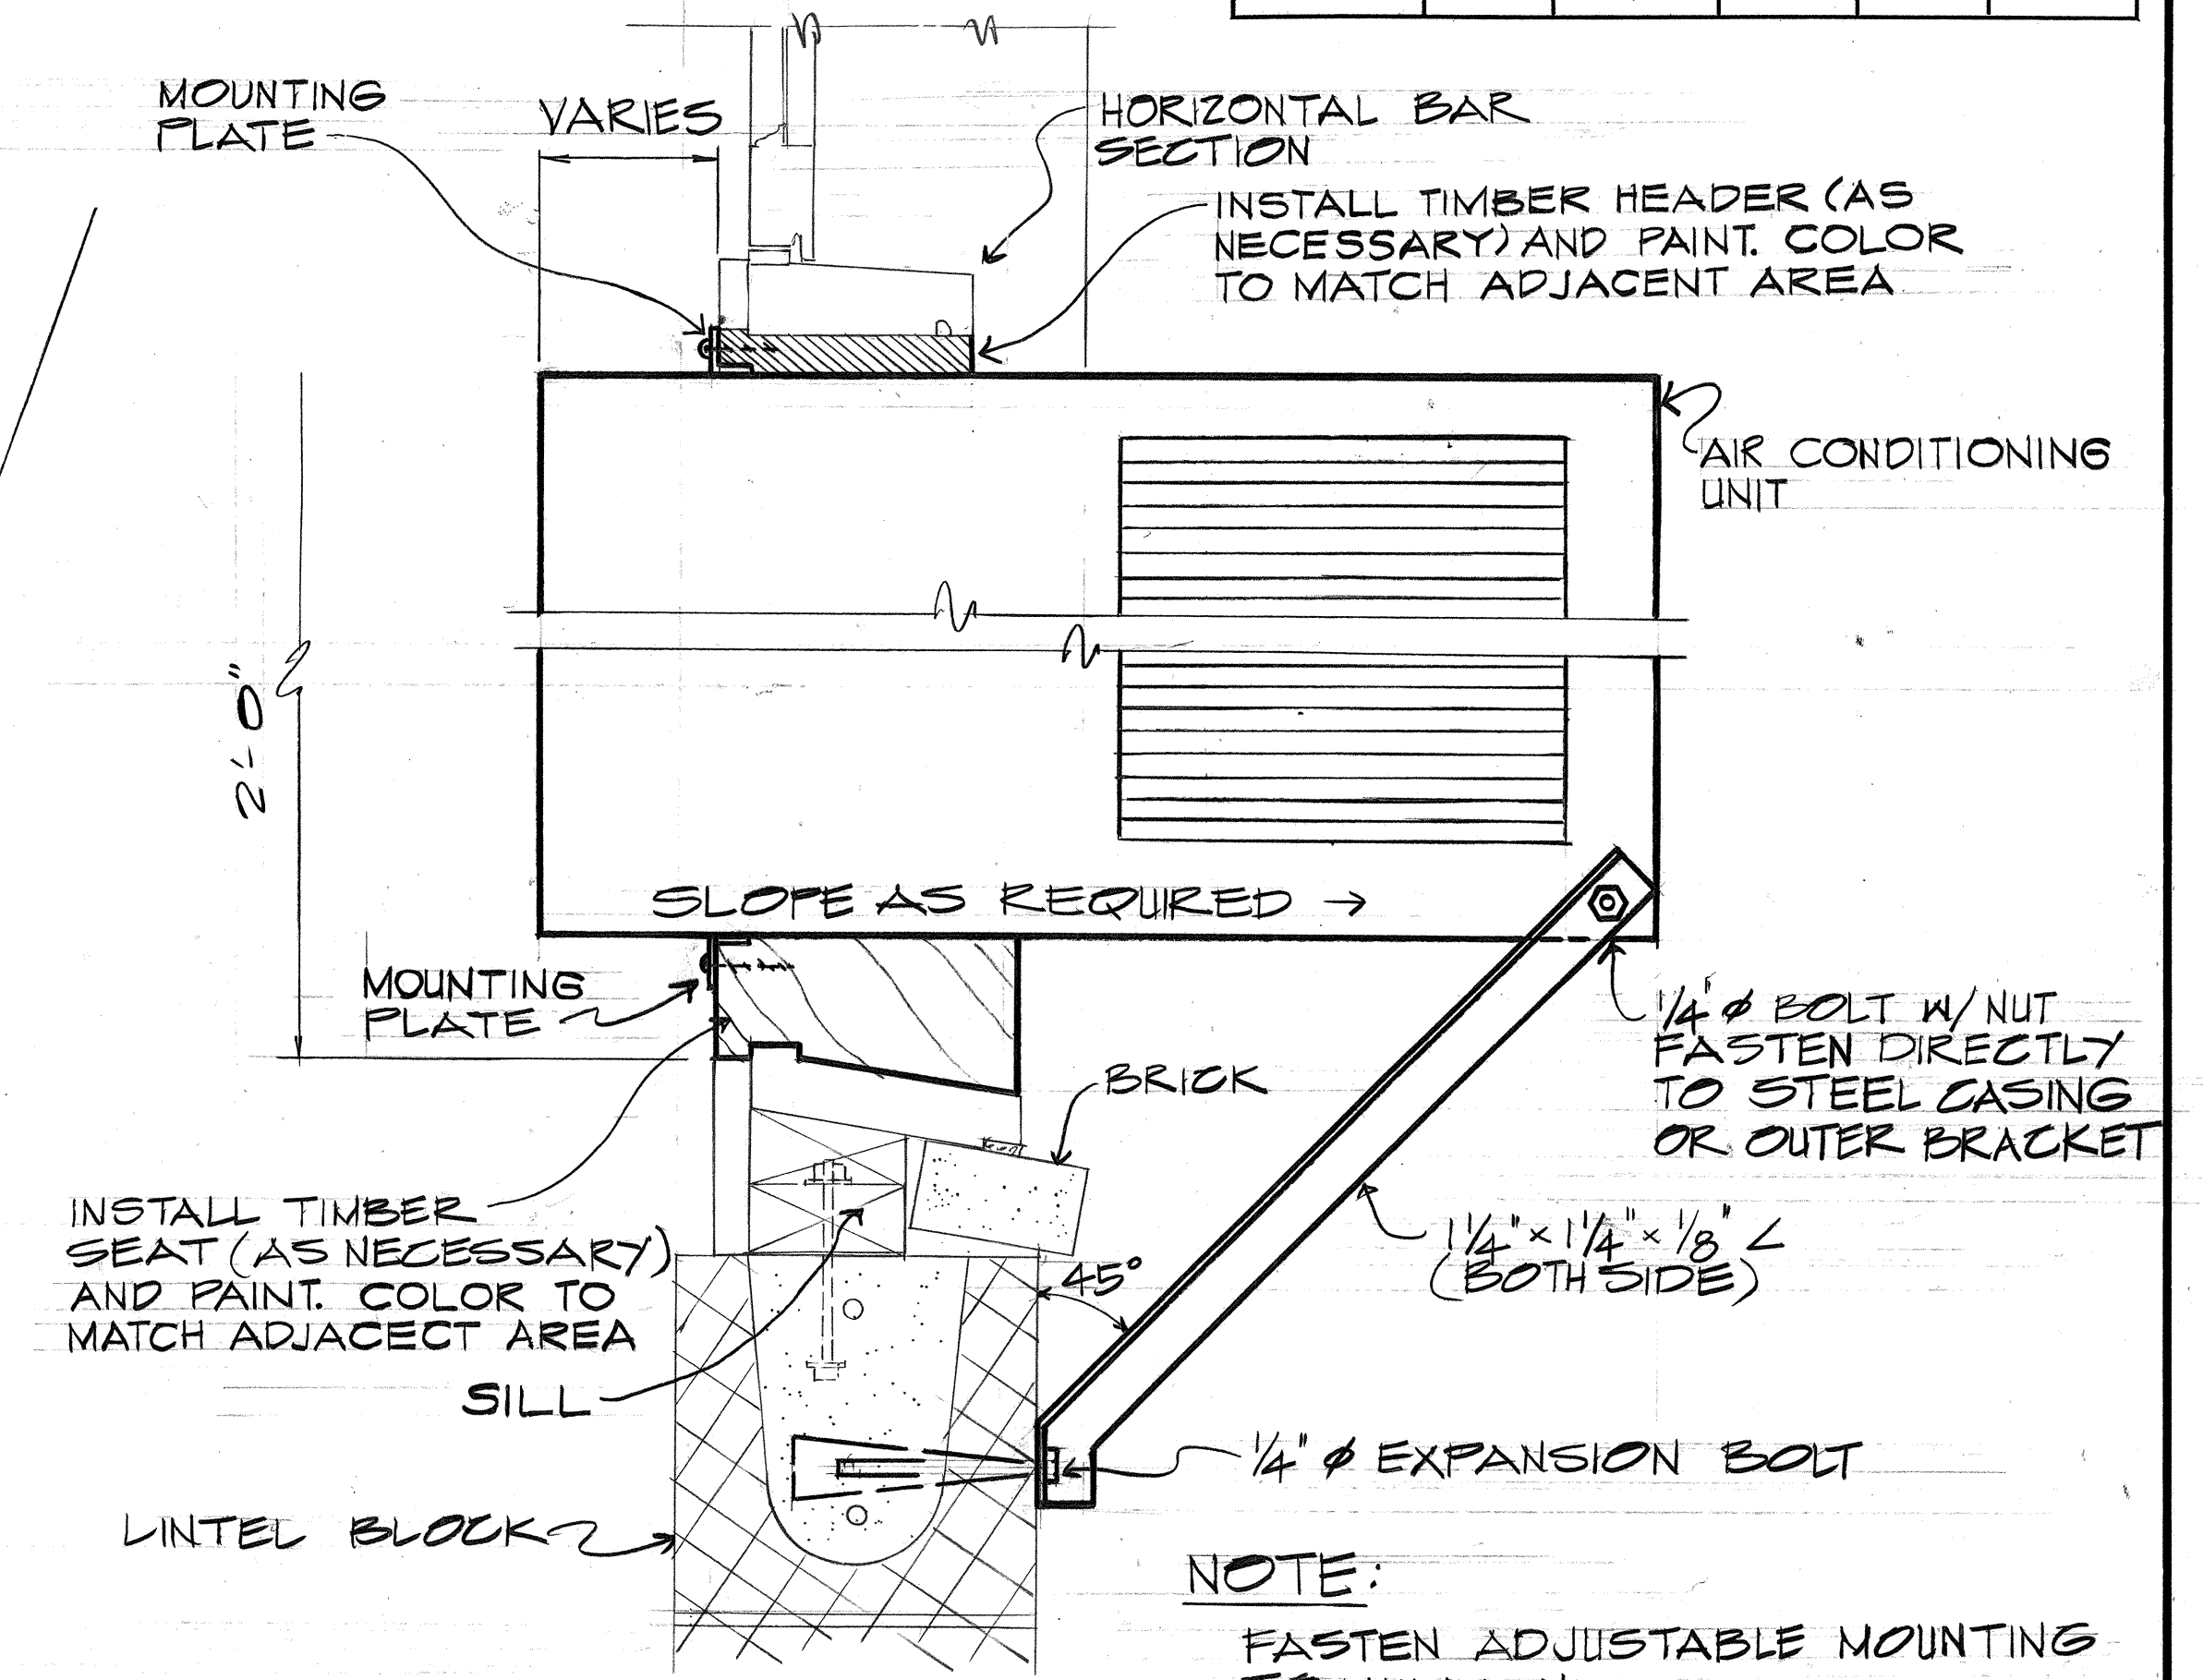

SECTION
SCALE: 3"=1'-0"

GENERAL NOTES

1. FOR ELECTRICAL CONNECTION DETAILS, SEE SHEETS 190 TO 193
2. INSTALL AIR CONDITIONING UNITS IN 20 CLASSROOMS, BUILDING D.
3. SEE SPECIAL PROVISIONS 644.
4. WORK SHOULD BE SCHEDULED SO CLASSROOM ACTIVITIES WILL NOT BE DISRUPTED.

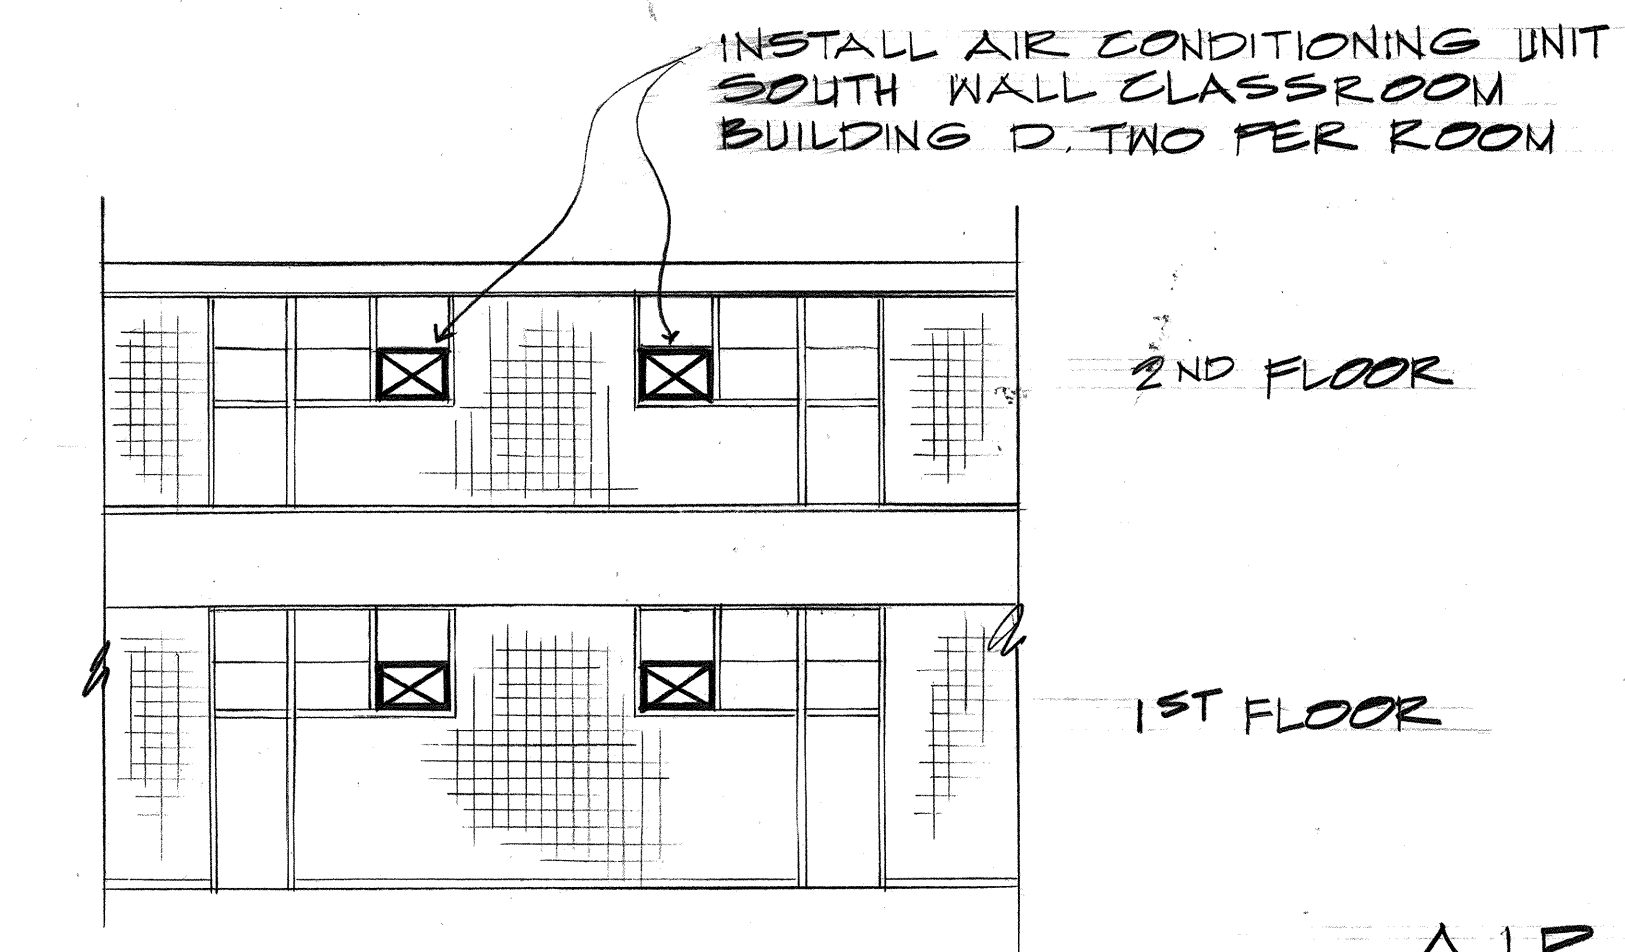

BUILDING D
PORTION OF SOUTH ELEVATION
SCALE: 1/8"=1'-0"

AIR CONDITIONING MOUNTING DETAILS



STATE OF HAWAII
DEPARTMENT OF TRANSPORTATION
HIGHWAYS DIVISION

**AIR CONDITIONING
INSTALLATION**

PEARL HARBOR INTERCHANGE
F.A.I. PROJ. NO. 1-HI-1(73):15

SCALE: AS SHOWN DATE: DEC. 7, 1973

SHEET NO. 1 OF 1 SHEETS

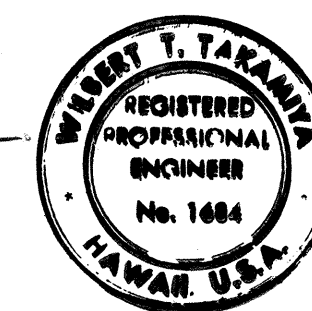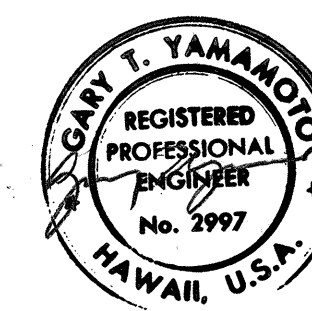

Willbert T. Takamiya
THIS WORK WAS PREPARED BY ME
OR UNDER MY SUPERVISION

ORIGINAL PLAN	DATE
SURVEY PLOTTED BY	
DRAWN BY	
TRACED BY	
DESIGNED BY	
QUANTITIES BY	
CHECKED BY	
NO.	