

INDEX TO DRAWINGS	
SHEET NO.	DESCRIPTION
1	TITLE
2-3	BORING PLAN & LOGS
4	CONSTRUCTION PHASING
5-7	TYPICAL ROADWAY SECTIONS
8	INDEX TO PLAN & PROFILE
9-22	PLAN & PROFILE
23-25	PROFILES
26-30	SUPERELEVATION DIAGRAMS
31	INTERSECTION DETAILS
32-33	MISCELLANEOUS DETAILS
34	AIR CONDITIONING INSTALLATION
35-36	STANDARD DETAILS
51-56	GRADING, DRAINAGE PLAN & PROFILE
61-66	DRAINAGE SUMMARY
67-83	DRAINAGE DETAILS
84-87	EXISTING CONDITIONS PLAN
88-93	CIVIL UTILITY RELOCATION
94-106	DETOUR PLAN & DETAILS
107	TEMPORARY TRAFFIC SIGNAL SYSTEM
108-133	TRAFFIC SIGNAL, SIGNING & PAVEMENT MARKINGS
134	BIKEWAY AND WALKWAY
135-138	LANDSCAPING
139-156	SPRINKLER SYSTEM
157-161	REMOVAL AND RELOCATION PLAN
162-171	ELECTRICAL PLANS
172-216	ELECTRICAL DETAILS
217-224	STRUCTURE NO. 4
225-256	STRUCTURE NO. 5 & 6
251-268	STRUCTURE NO. 7
269-296	STRUCTURE NO. 8
297-322	STRUCTURE DETAILS
323-331	RETAINING WALL NO. 3, 4, 5, 6, 7 & 8
332-333	RETAINING WALL DETAILS
334	INDEX TO CROSS SECTIONS
335-369	CROSS SECTIONS


SUPPLEMENTARY SHEETS TO THIS PROJECT ARE SHEET NOS.

DATE	DESCRIPTION
12/3/73	(a) C.O. 3'S-S-1
12/3/73	(b) C.O. 39 S-S-1
12/3/73	(c) C.O. 72 S-S-1 & 73 S-S-1
12/3/73	(d) C.O. 95 S-S-1, S-S-2, S-S-3, S-S-4, C.O. 96 S-S-1, C.O. 100 S-S-1 & S-S-2
12/3/73	(e) C.O. 108 S-S-1, C.O. 120 S-S-1 & C.O. 132 S-S-1
12/3/73	(f) C.O. 134 S-S-1
12/3/73	(g) 165 S-S-1, C.O. 170 S-S-1 & S-S-2
12/3/73	(h) C.O. 216 S-S-1 & S-S-2


DESIGNED BY
P. S. & E. BY
HI IWA
548-5812
PHONE
12/3/73
DATE

STATE OF HAWAII
DEPARTMENT OF TRANSPORTATION
HIGHWAYS DIVISION
HONOLULU, HAWAII
"AS-BUILT"
PLANS FOR
CONSTRUCTION OF A PORTION OF
INTERSTATE ROUTE H-1
PEARL HARBOR INTERCHANGE
FEDERAL AID INTERSTATE PROJECT NO. I-HI-1(73):15
DISTRICT OF HONOLULU
ISLAND OF OAHU

(j) 218 S-S-1 & 221 S-S-1
(j) 238 S-S-1
(k) C.O. 277 S-S-1 & C.O. 296 R-S-1
(l) C.O. 313 S-S-1
(m) C.O. 322 S-S-1
TOTAL SHEET COUNT AFTER
"AS-BUILT" POSTINGS: 396 SHEETS

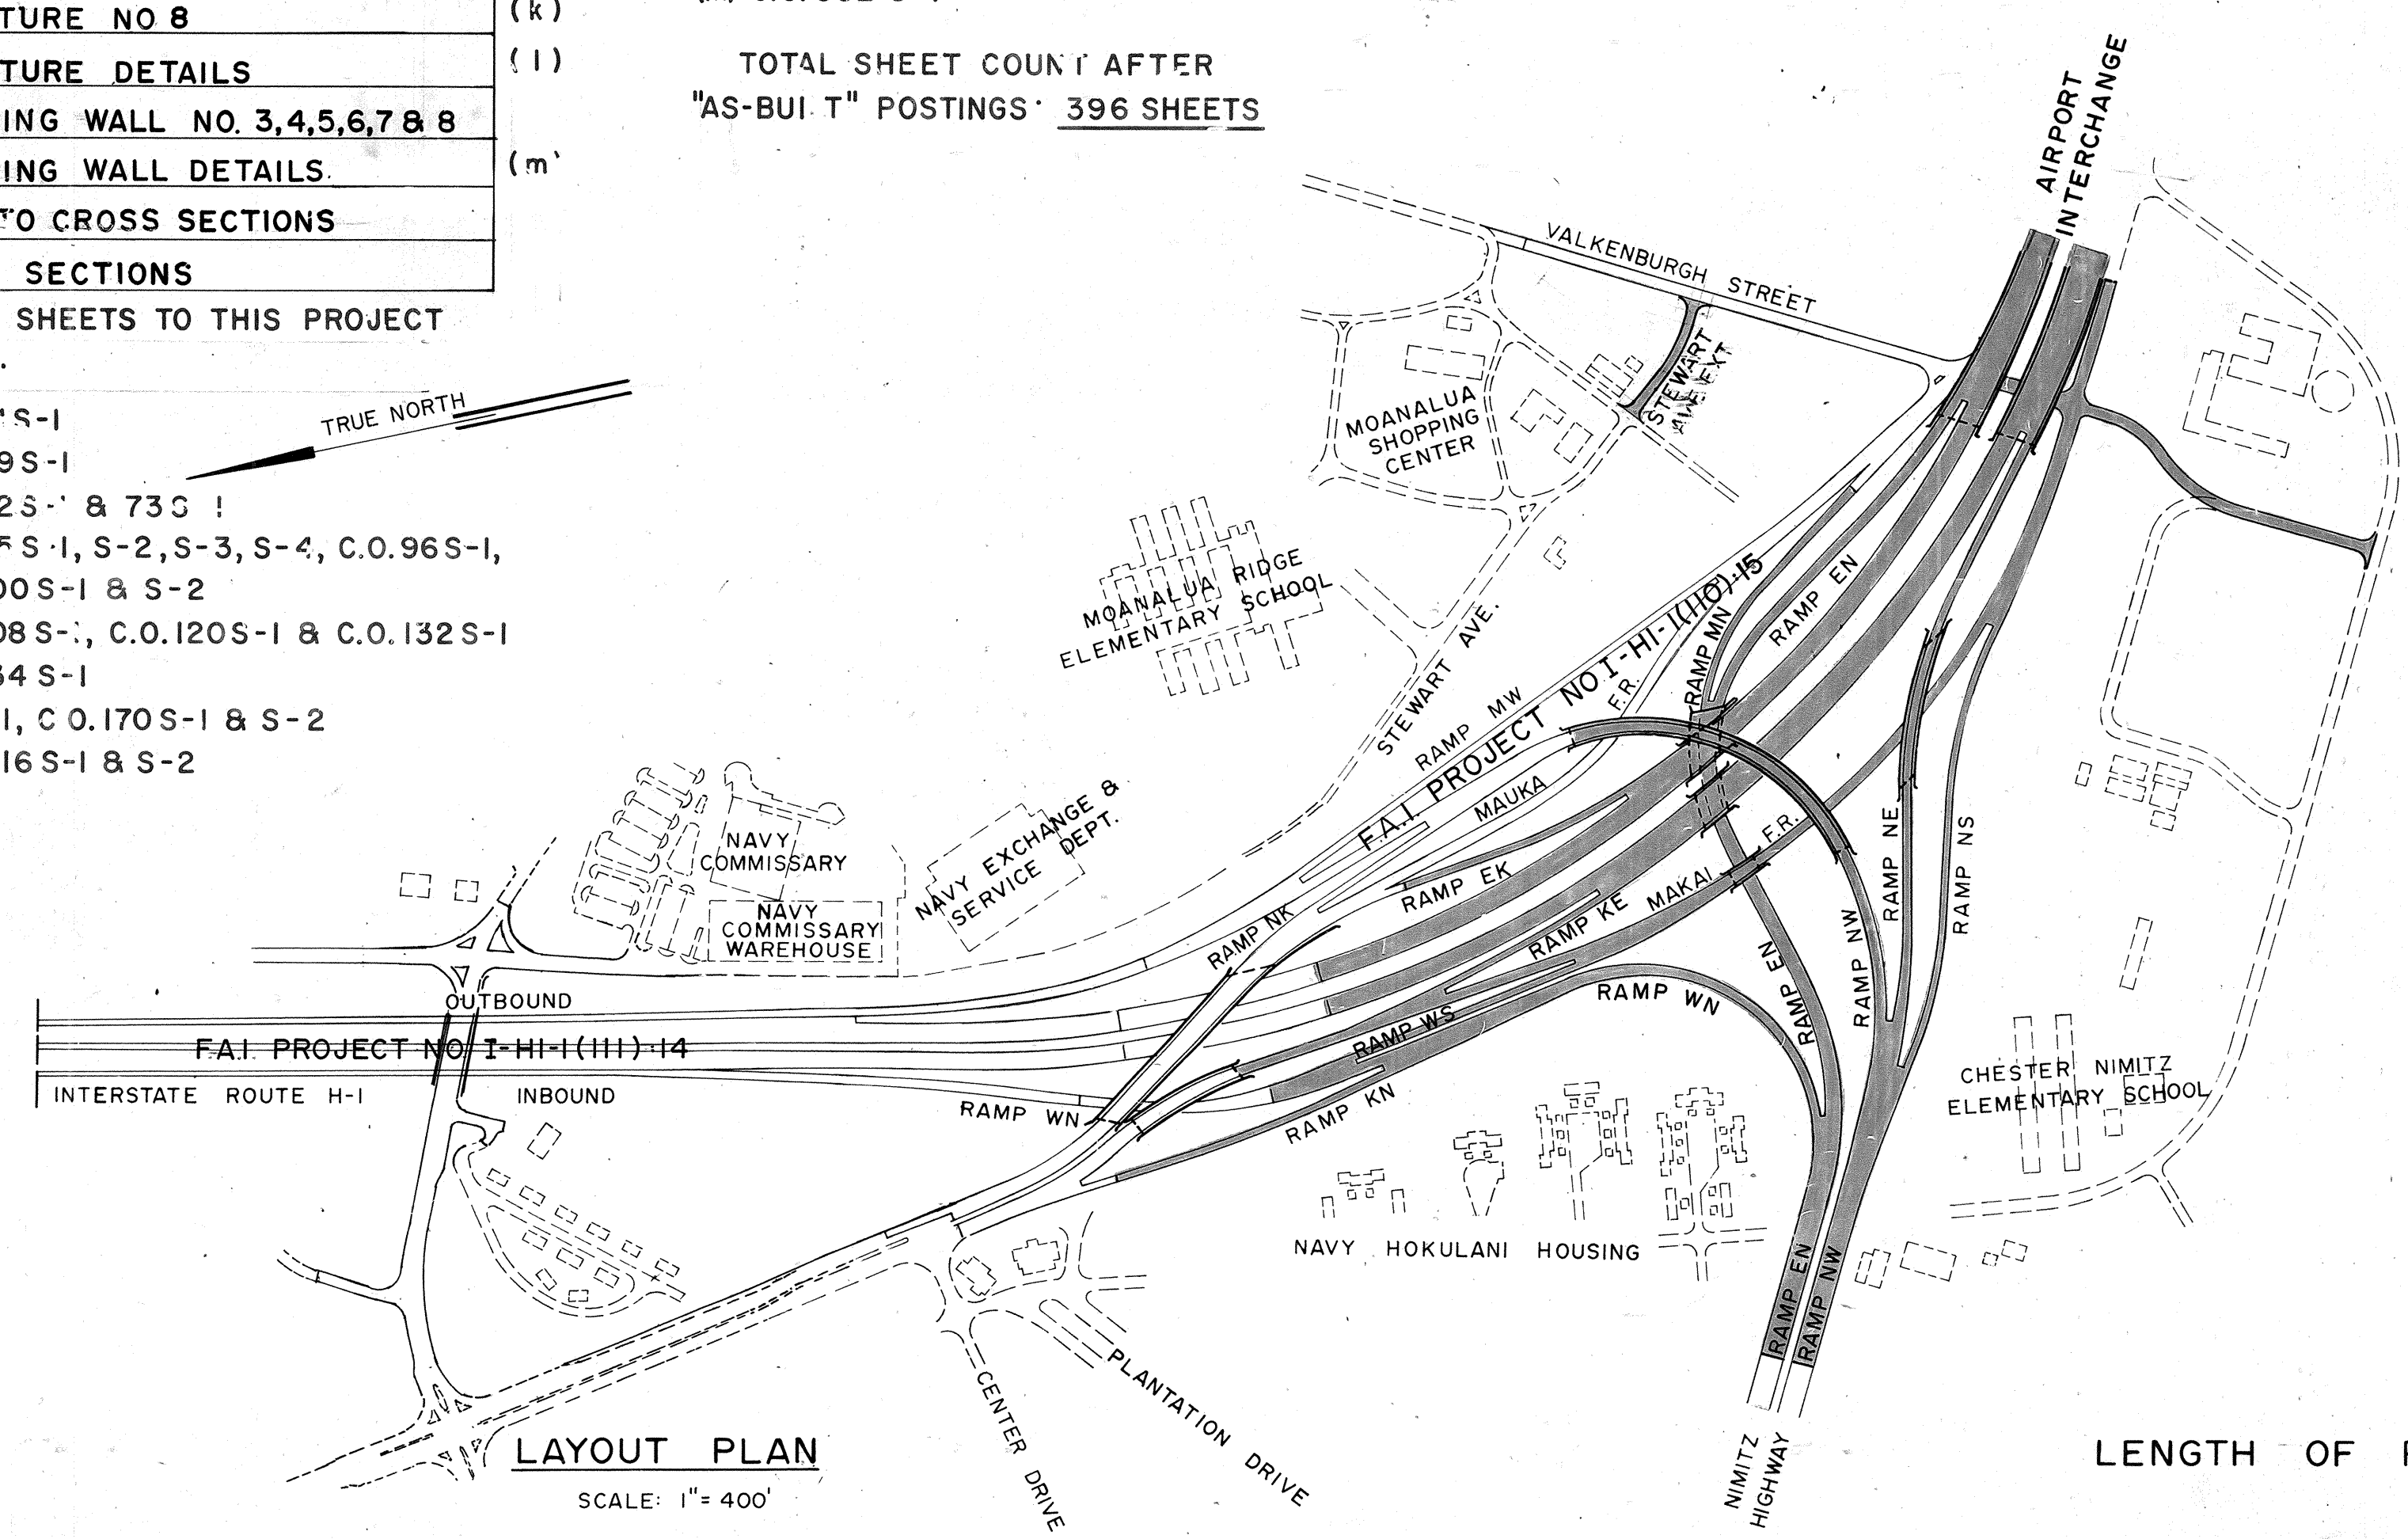

LENGTH OF PROJECT 0.44 MILE

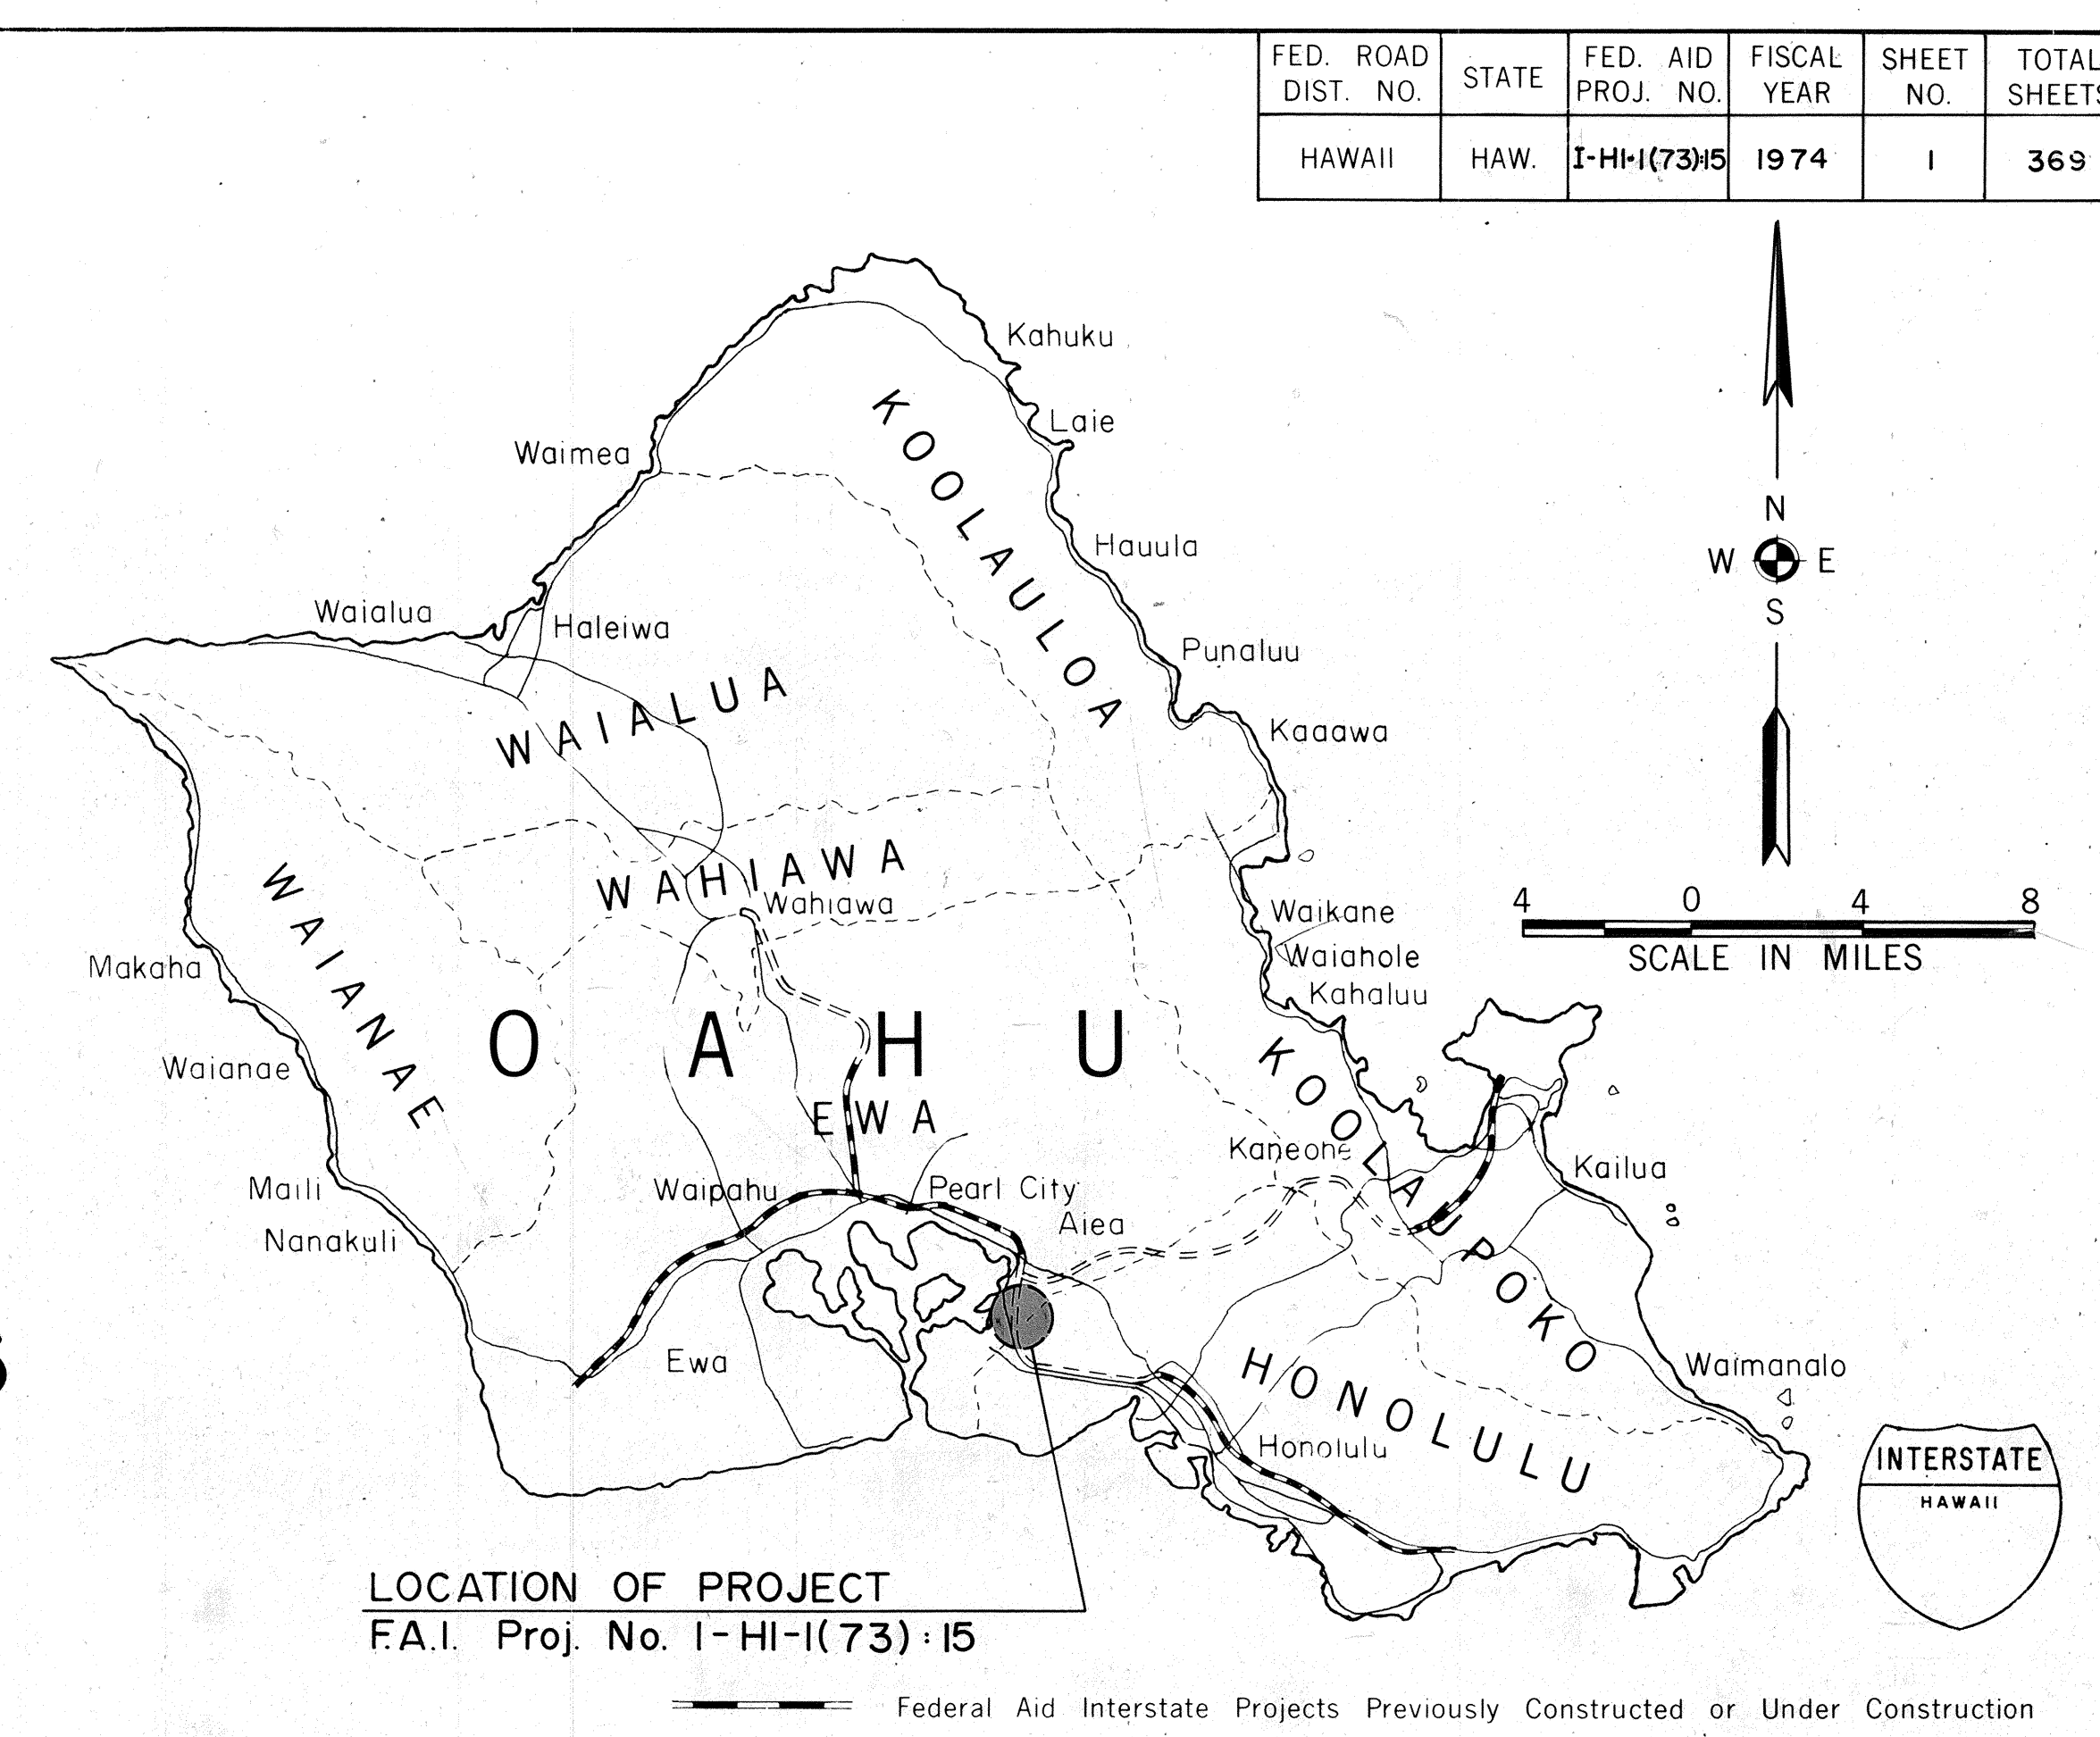

LOCATION OF PROJECT
F.A.I. Proj. No. I-HI-1(73):15

SCALES:

PLANS	HOR.	1" = 50'
PROFILES	HOR.	1" = 50'
	VER.	1" = 10'
DETAIL ROADWAY PLANS	HOR.	1" = 20'
CROSS SECTIONS	HOR.	1" = 10'
	VER.	1" = 10'
CROSS SECTIONS	HOR.	1" = 20'
	VER.	1" = 20'

DESIGN DESIGNATION

CURRENT ADT (1973)	32,800
DESIGN ADT (1994)	102,700
DHV	11,300
D	60/40
T	5 %
V	60 MPH
CONTROL OF ACCESS	FULL

ALL CHANGES MADE DURING CONSTRUCTION HAVE BEEN INCORPORATED ON THESE PLANS IN RED EXCEPT CHANGES IN THE ORIGINAL THEORETICAL QUANTITIES. FOR ACTUAL QUANTITIES, REFER TO PROJECT LEDGER AND/OR COMPUTATION BOOK.

John Chun
RESIDENT ENGINEER
7-28-81
DATE

DEPARTMENT OF TRANSPORTATION
FEDERAL HIGHWAY ADMINISTRATION
APPROVED:
[Signature]
DIVISION ENGINEER
DATE

DEPARTMENT OF TRANSPORTATION
STATE OF HAWAII
APPROVED:
Munny Lee
12/28/73
DIR. OF TRANSPORTATION
DATE