


INDEX TO DRAWINGS	
SHEET NO.	DESCRIPTION
1	TITLE SHEET
2	TYPICAL DETOUR SECTIONS
3-9	DETOUR CONSTRUCTION PLANS AND DETAILS
10-22	STANDARD DETAILS
23-24	CONSTRUCTION SIGNING PLANS
25-28	DETOUR SIGNING PLANS
29-39	SIGNING DETAILS
40-49	ELECTRICAL PLANS & DETAILS
50-52	EXISTING UTILITIES PLANS
53-66	BORING LOCATION PLANS & LOGS
67-69	CROSS SECTION KEY
70-78	CROSS SECTIONS


STATE OF HAWAII
DEPARTMENT OF TRANSPORTATION
HIGHWAYS DIVISION
HONOLULU, HAWAII
"AS BUILT"
PLANS FOR
CONSTRUCTION OF A PORTION OF
INTERSTATE ROUTE H-1
KEEHI INTERCHANGE

FEDERAL AID INTERSTATE PROJECT NO. I-H1-1 (128):17

DISTRICT OF HONOLULU
ISLAND OF OAHU

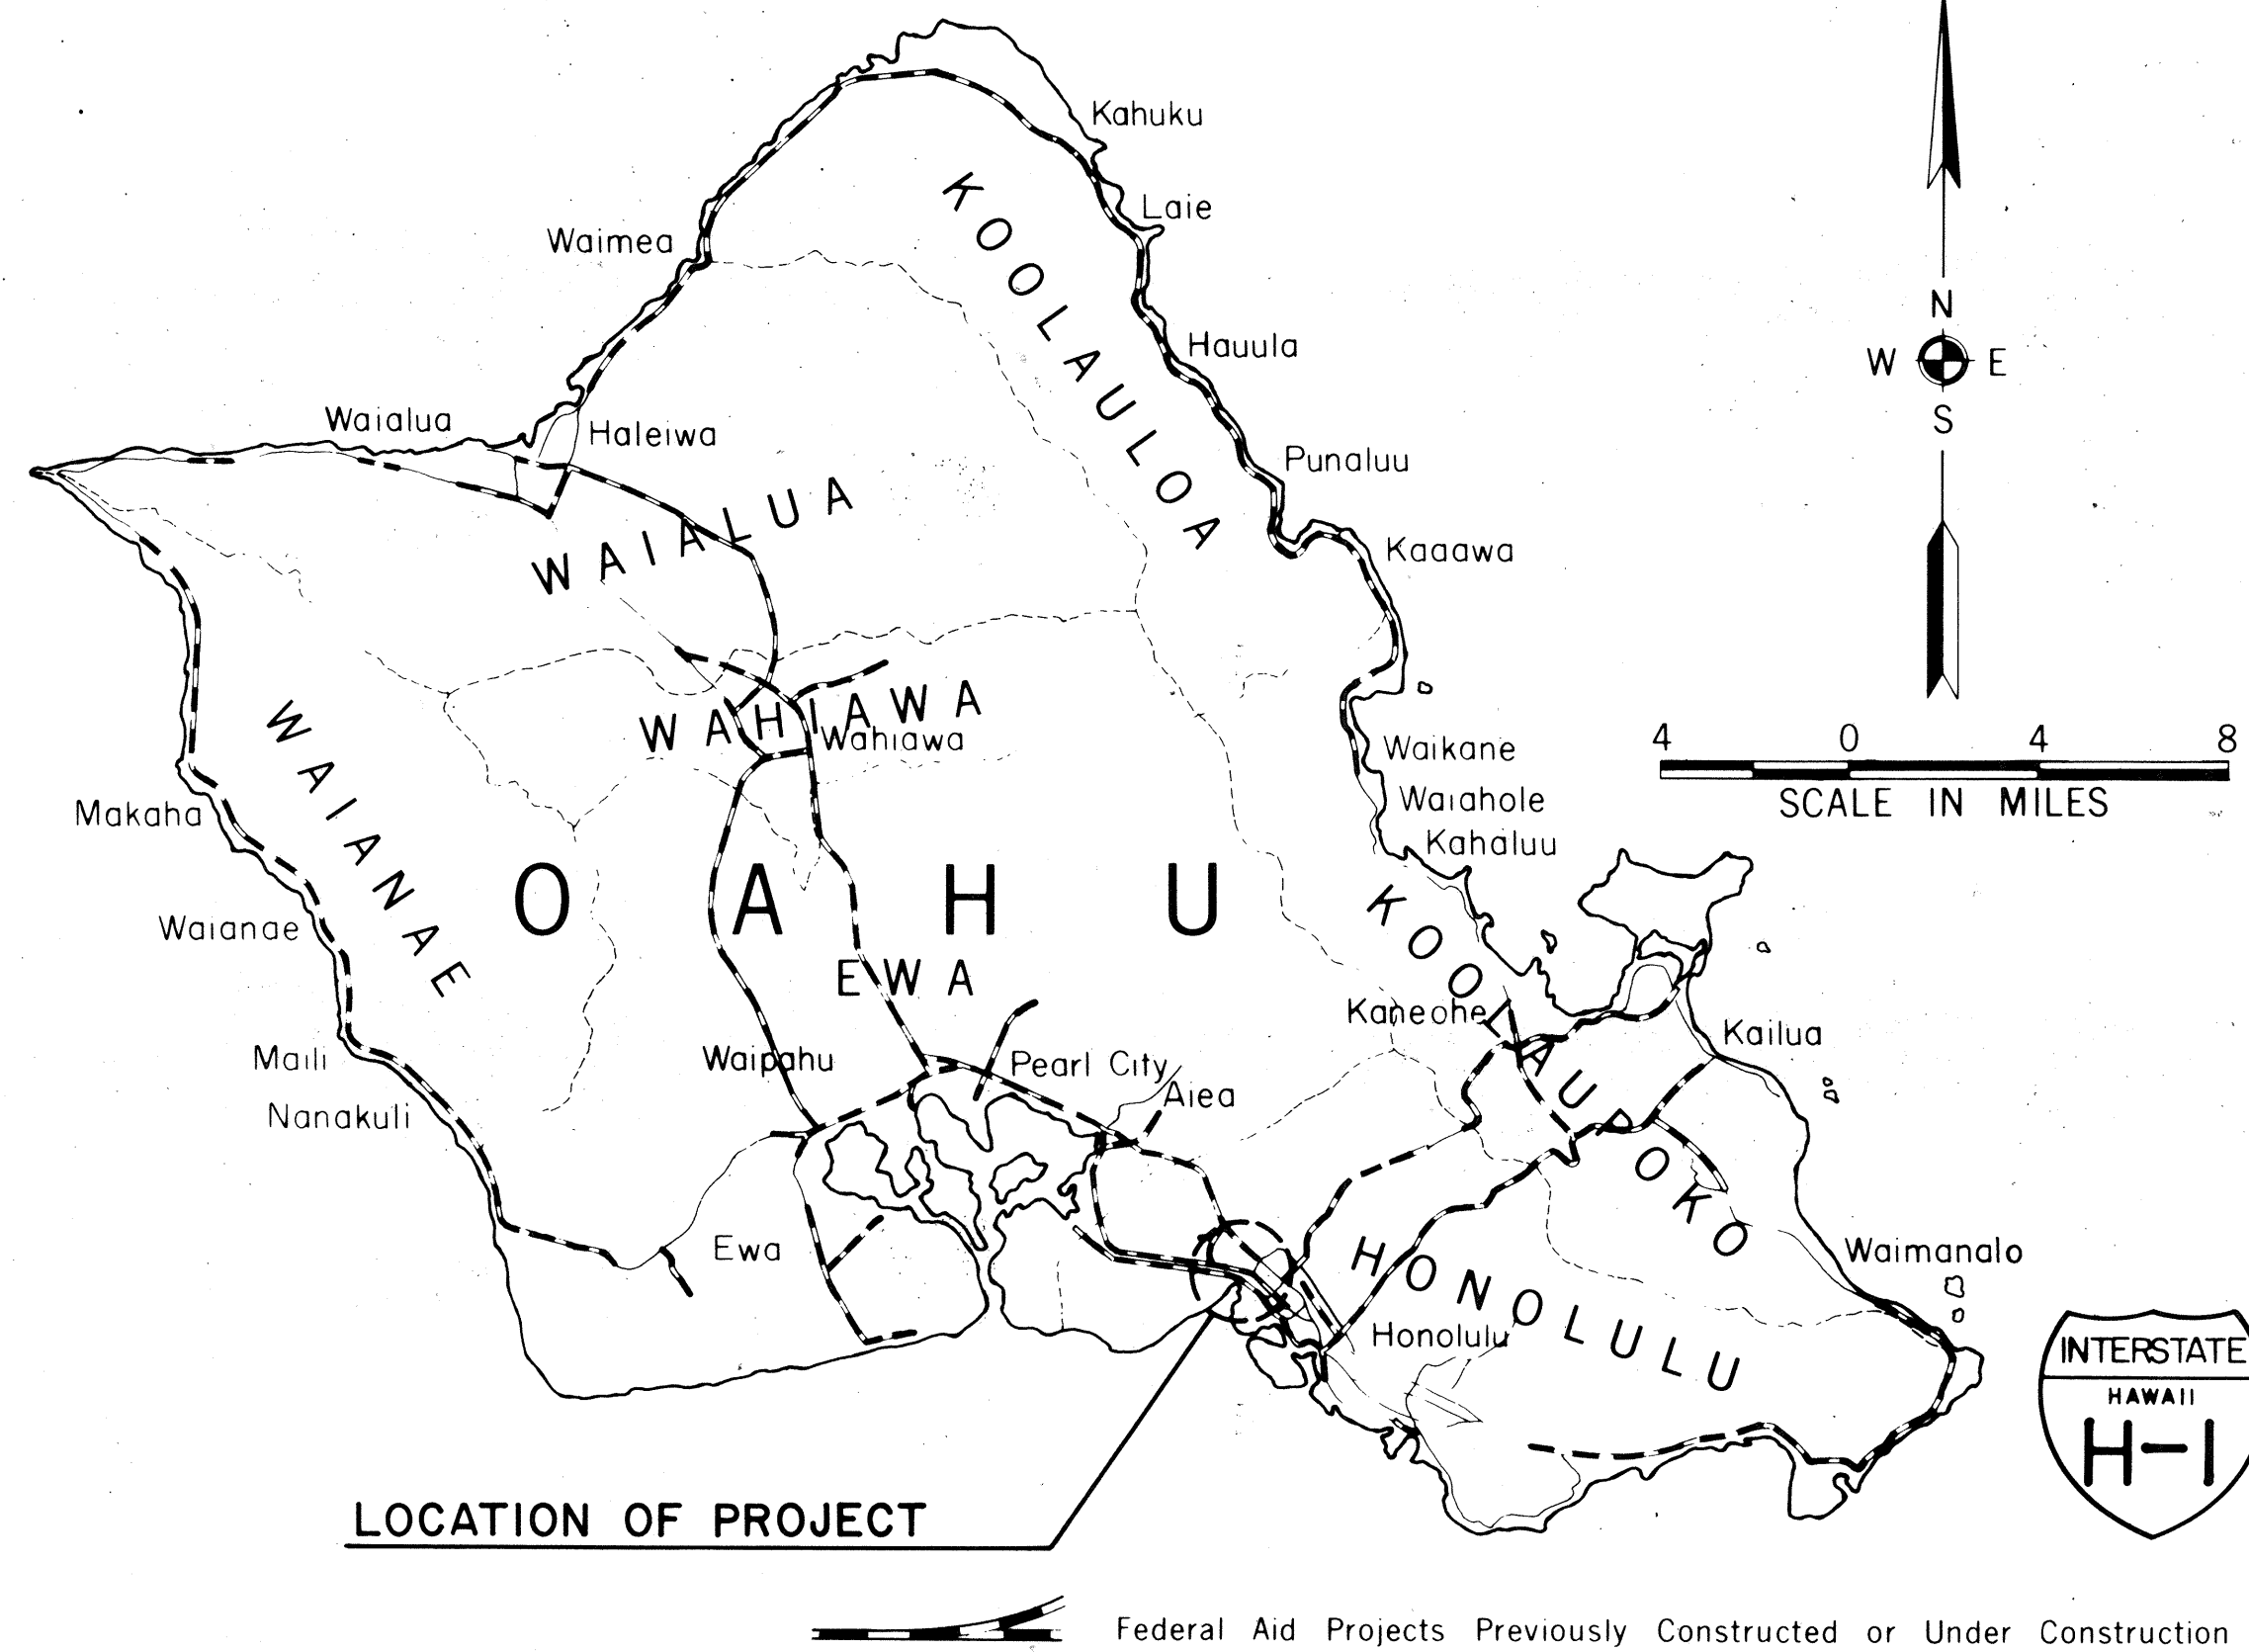

DATE DEC 13, 1974
PHONE 521-3051
BY B. TANAKA
DESIGNED BY PBHA

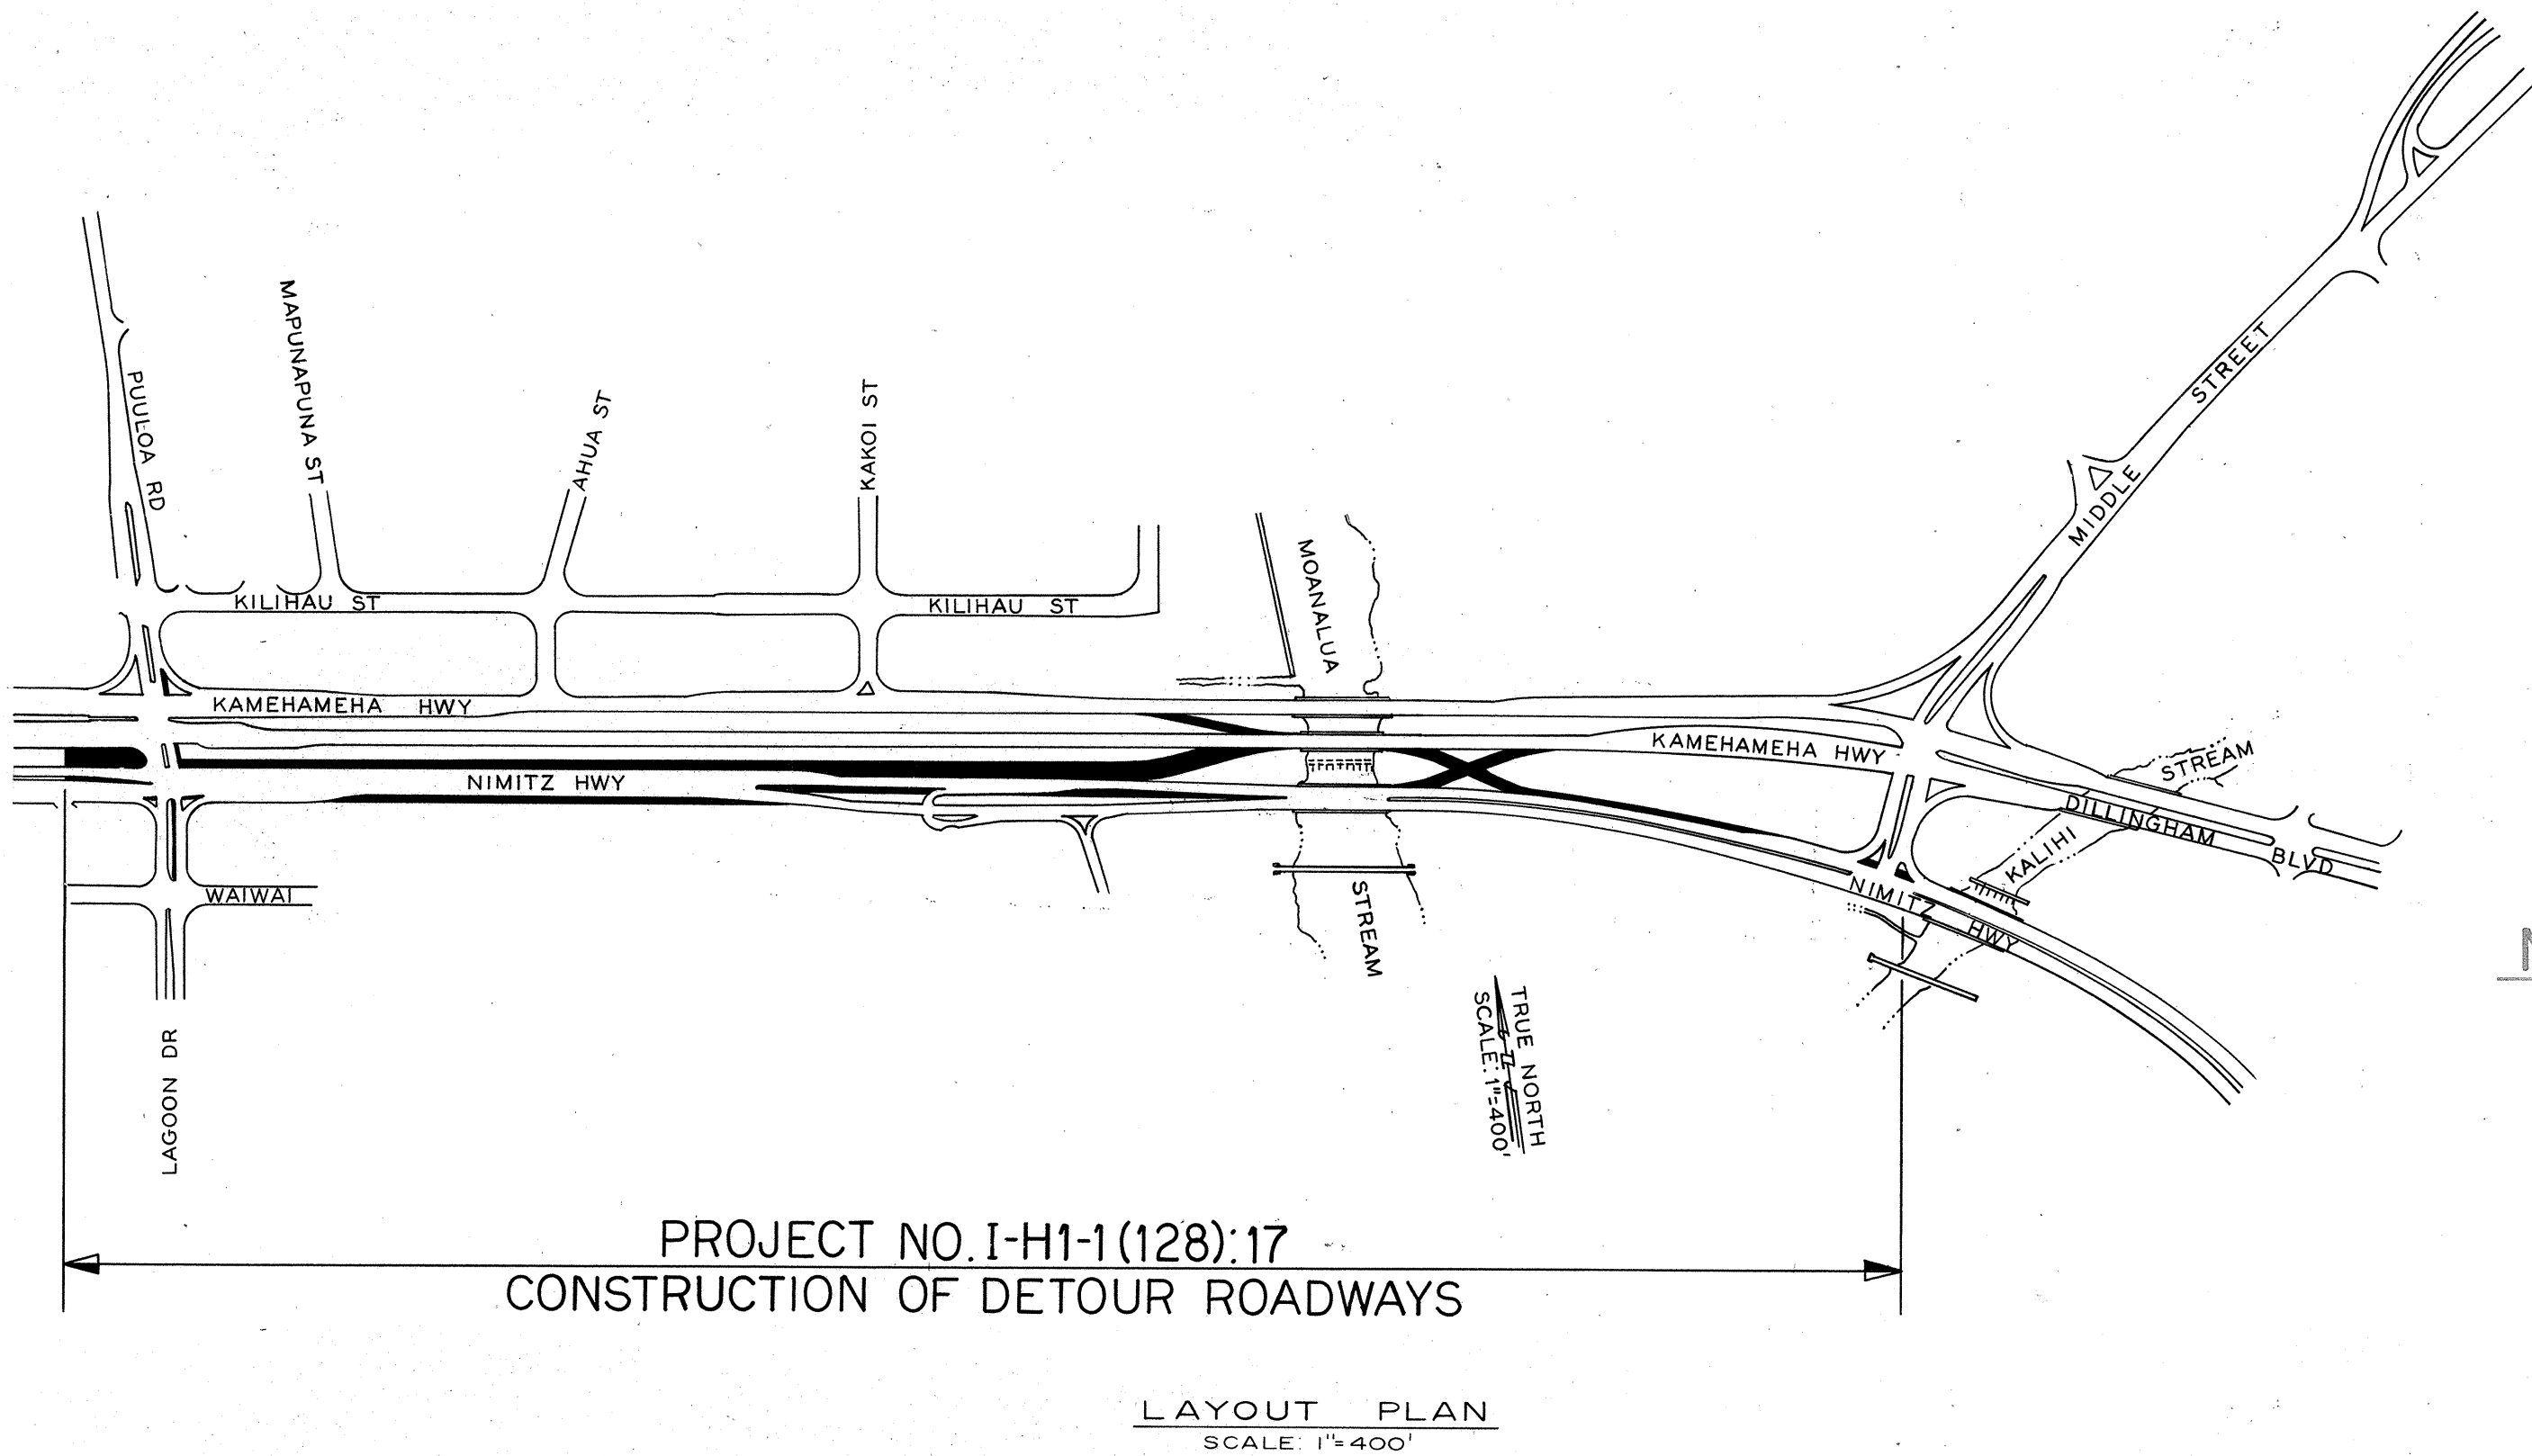

DESIGN CLASSIFICATION

DESIGN ADT (1994).....98,000
DHV.....10,800
D.....60/40
T.....5%
V.....60 MPH

NOTE:

ALL CHANGES MADE DURING CONSTRUCTION
HAVE BEEN NOTED IN RED ON THESE
TRACINGS AND CHECKED BY:

PROJECT ENGINEER

7/7/77
DATE

DEPARTMENT OF TRANSPORTATION
FEDERAL HIGHWAY ADMINISTRATION
APPROVED: [Signature]
DIVISION ENGINEER
DATE 12-31-74

DEPARTMENT OF TRANSPORTATION
STATE OF HAWAII
APPROVED: [Signature]
DIR. OF TRANSPORTATION
DATE 12/30/74