
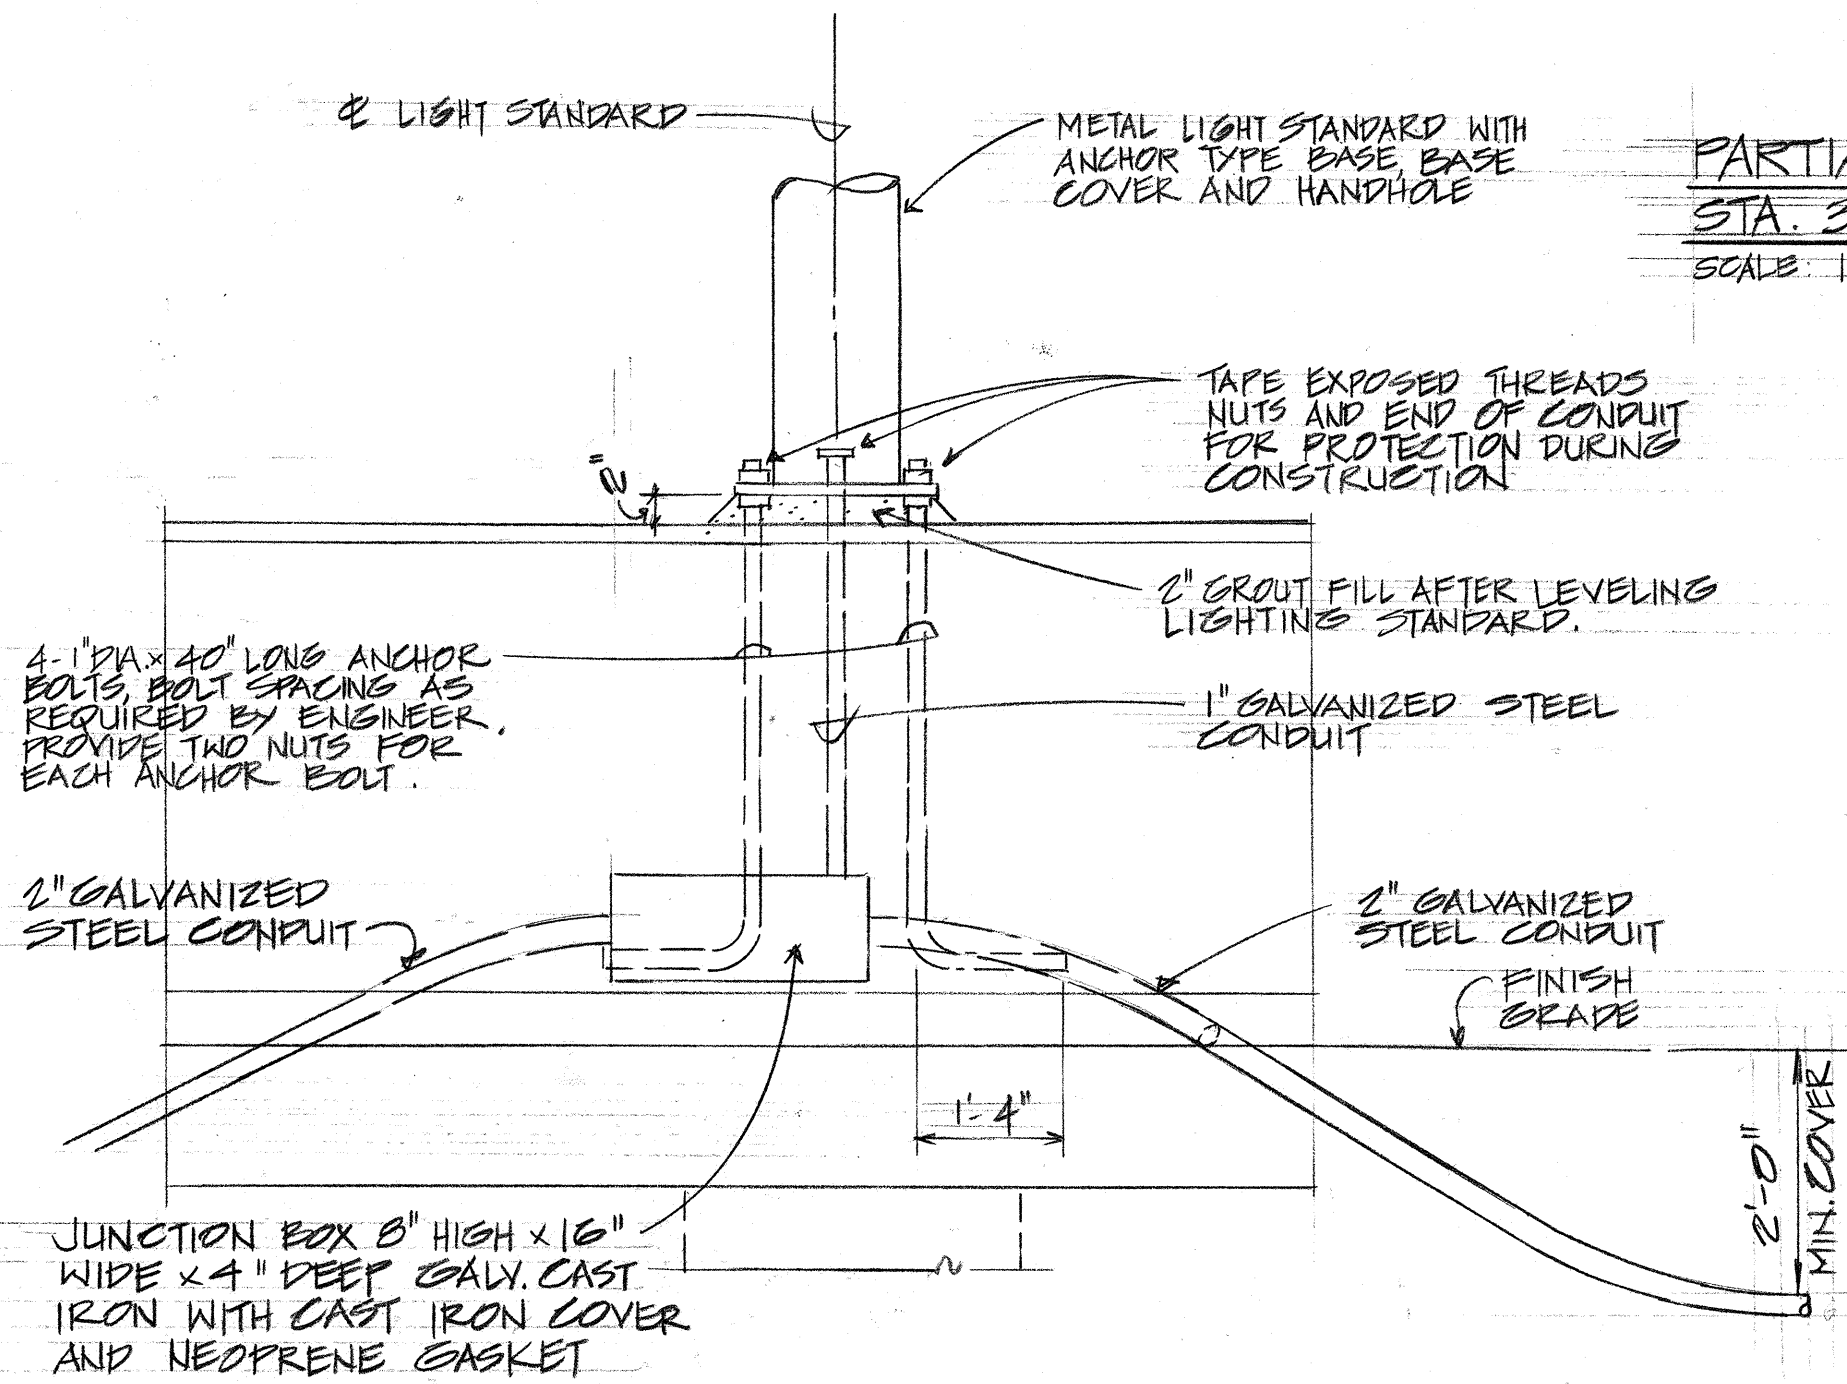
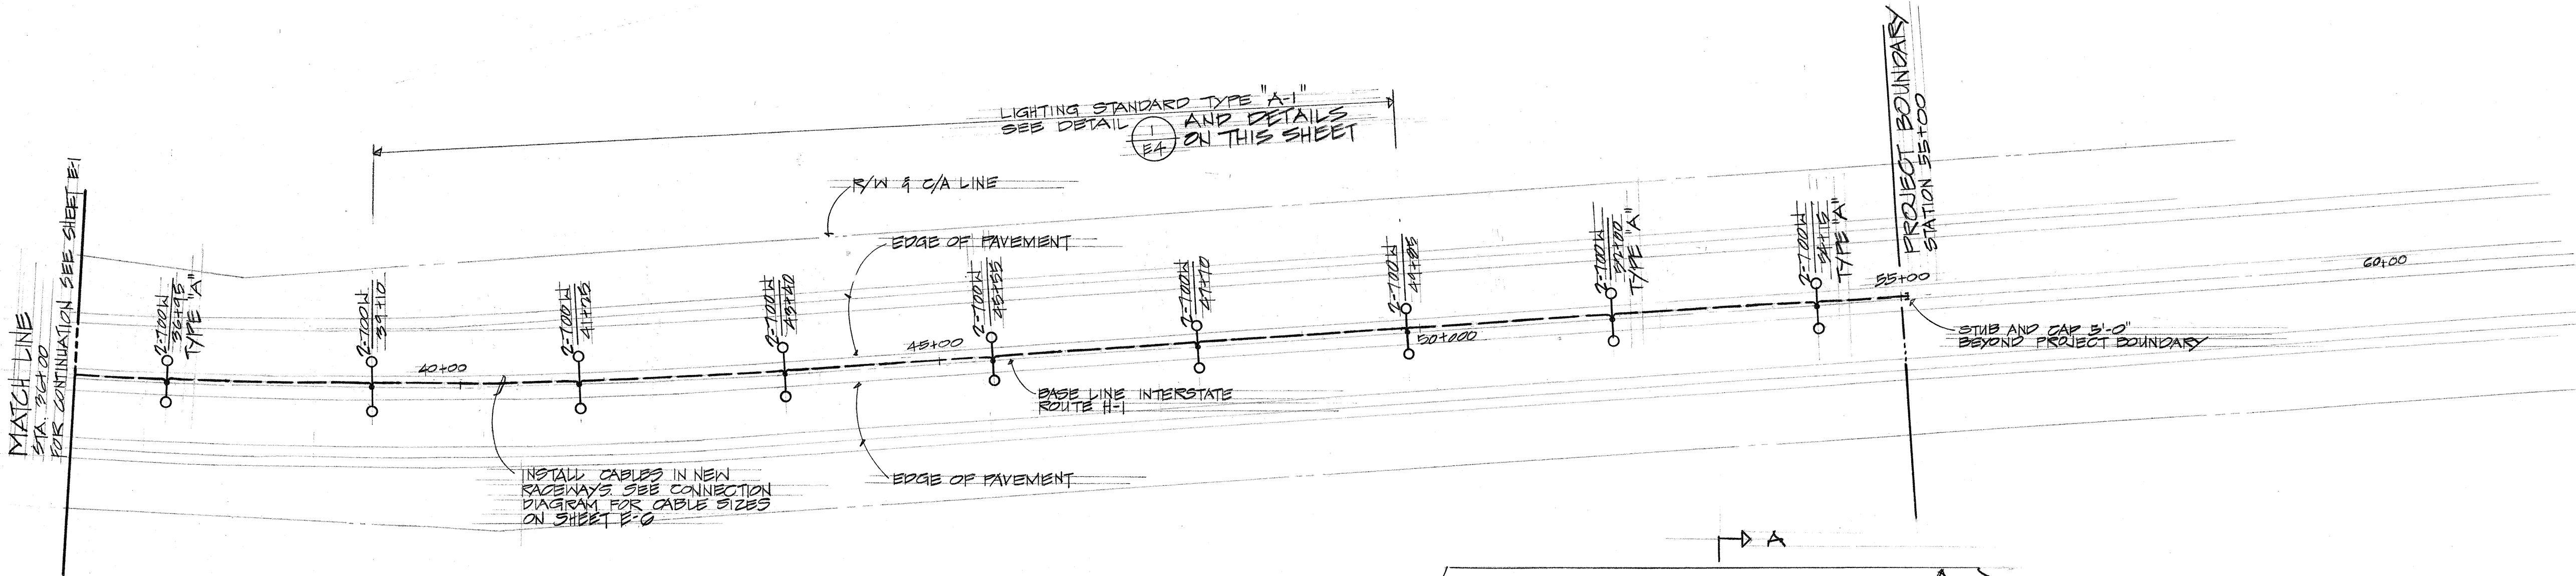



FED. ROAD DIST. NO.	STATE	FED. AID PROJ. NO.	FISCAL YEAR	SHEET NO.	TOTAL SHEETS
HAWAII	HAW.	(71)14	1974	43	61

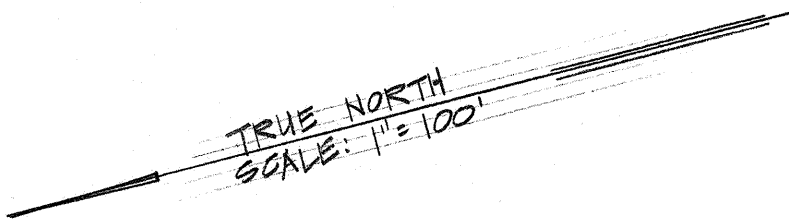


1.1 ELEVATION
E-2 SCALE: 1"=1'-0"

PARTIAL HIGHWAY LIGHTING PLAN, SECTION "B"
STA. 36+00 TO PROJECT BOUNDARY
SCALE: 1"=100'

NOTE:
SECTION "A-A" SAME
AS DETAIL (E2)
E-3

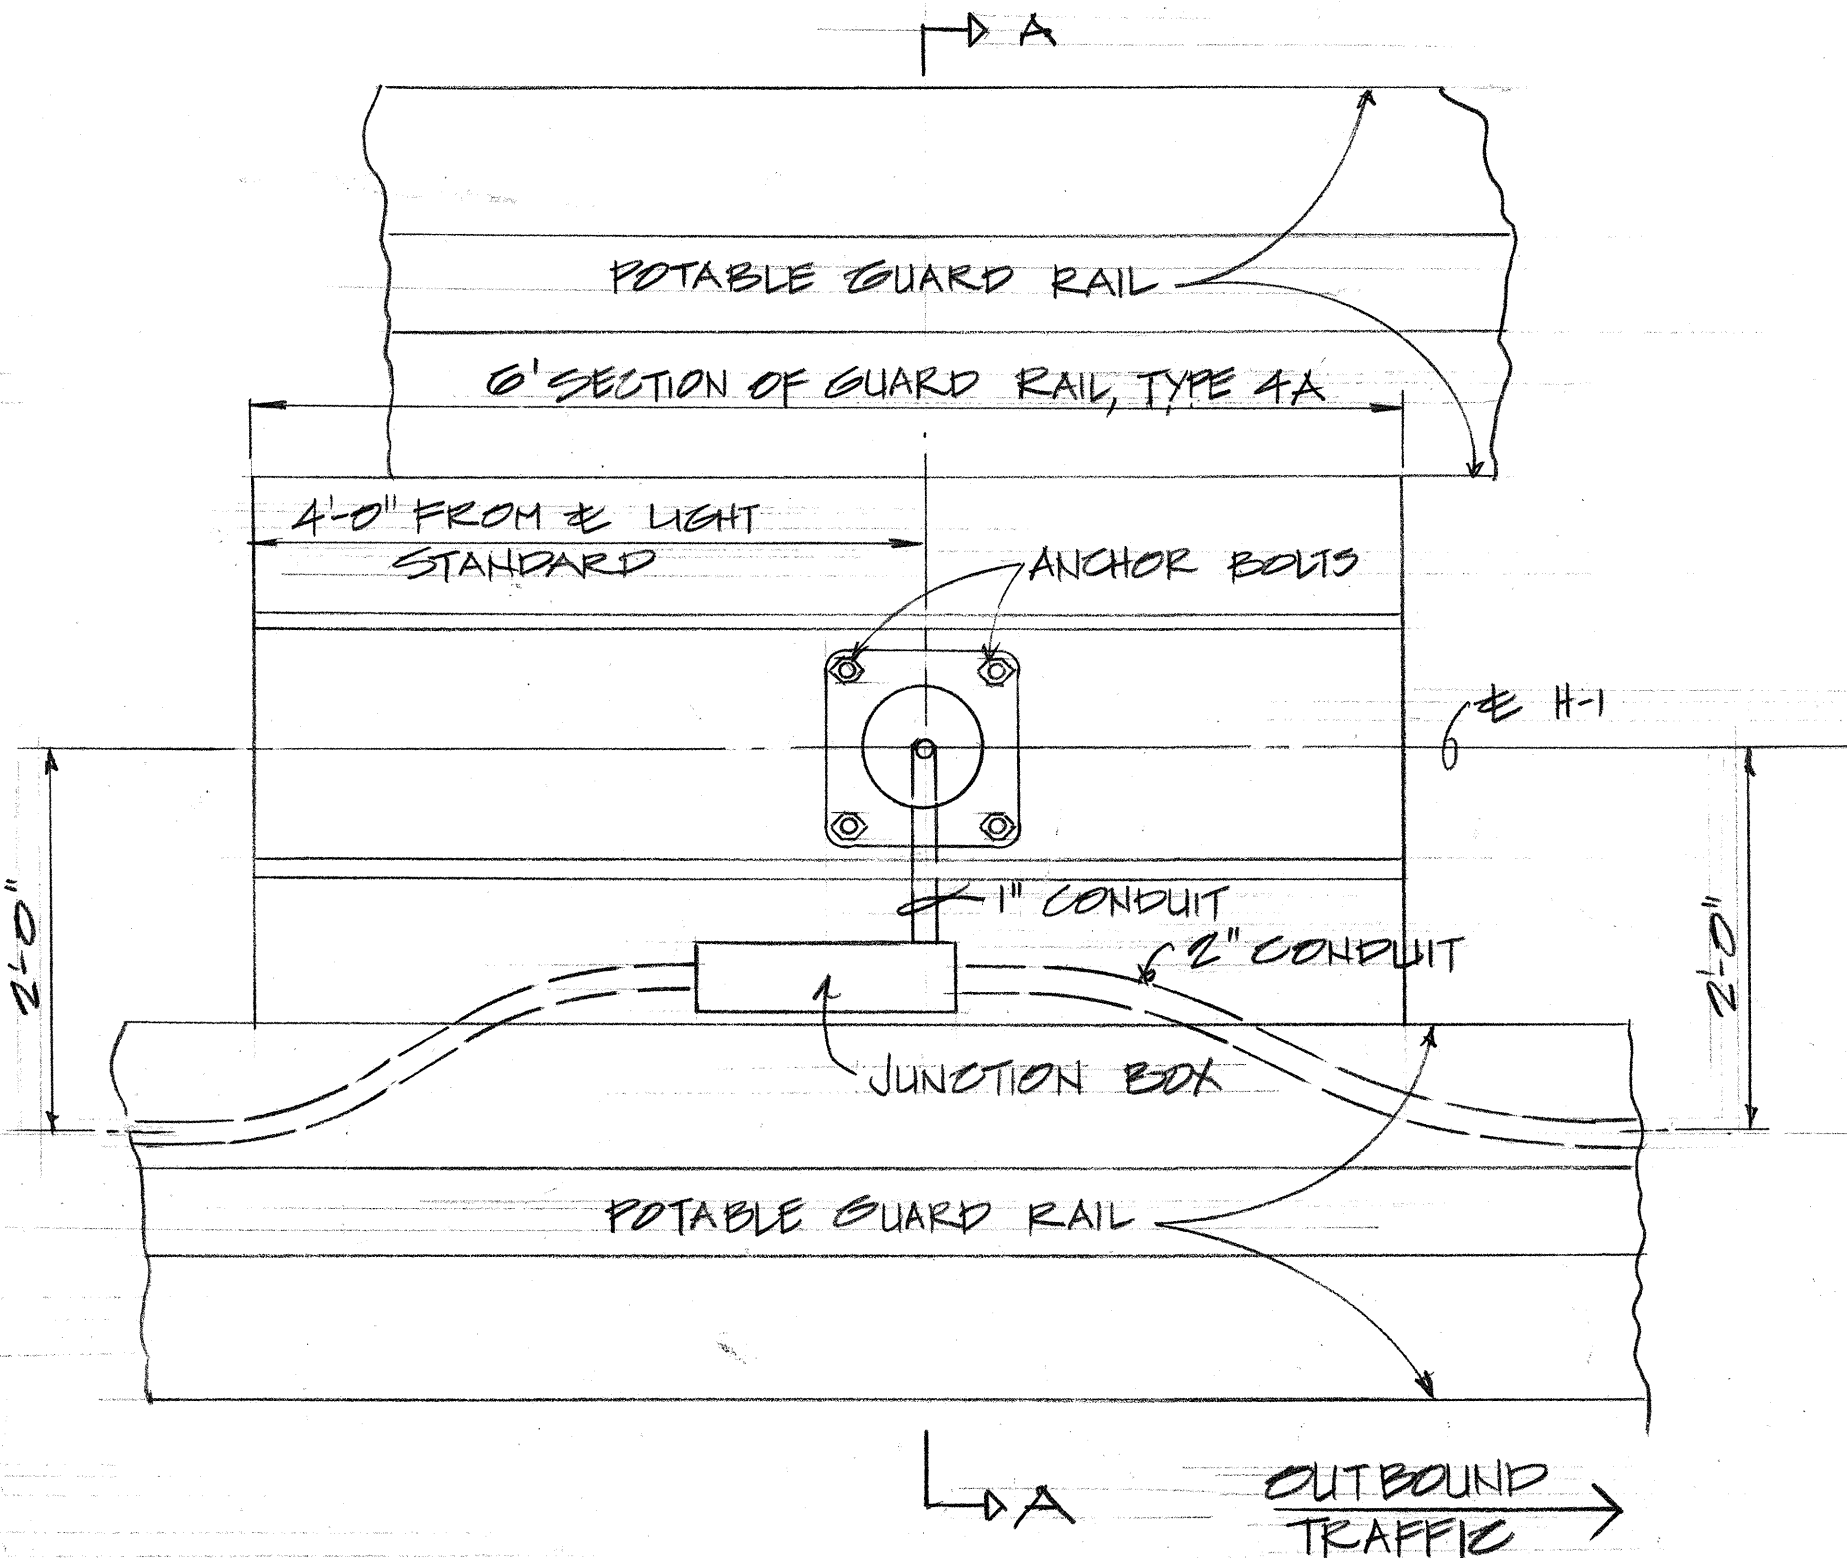

1.2 TYPICAL PLAN
E-2 SCALE: 1"=1'-0"

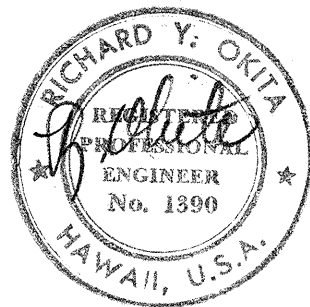




THIS WORK WAS PREPARED BY
HIS OR UNDER HIS SUPERVISION,

STATE OF HAWAII
DEPARTMENT OF TRANSPORTATION
HIGHWAYS DIVISION
INTERSTATE ROUTE H-1
NORTH LEG ROADWAY SECTION (PAYING)
HIGHWAY LIGHTING PLAN
STA. 33+50 TO STA. 55+00
F.A.I. PROJECT NO. I-H-1(71)-14
SCALE: AS SHOWN
DATE: 1/14/74











SHEET No. 43 OF 12 SHEETS
PHASE II

SURVEY PLOTTED BY	DATE
DESIGNED BY	
TRACED BY	
NOTE BOOK	
QUANTITIES BY	
CHECKED BY	


NOTE:
THE CONTRACTOR SHALL VERIFY ALL EXISTING
ANCHOR BOLT SPACING.

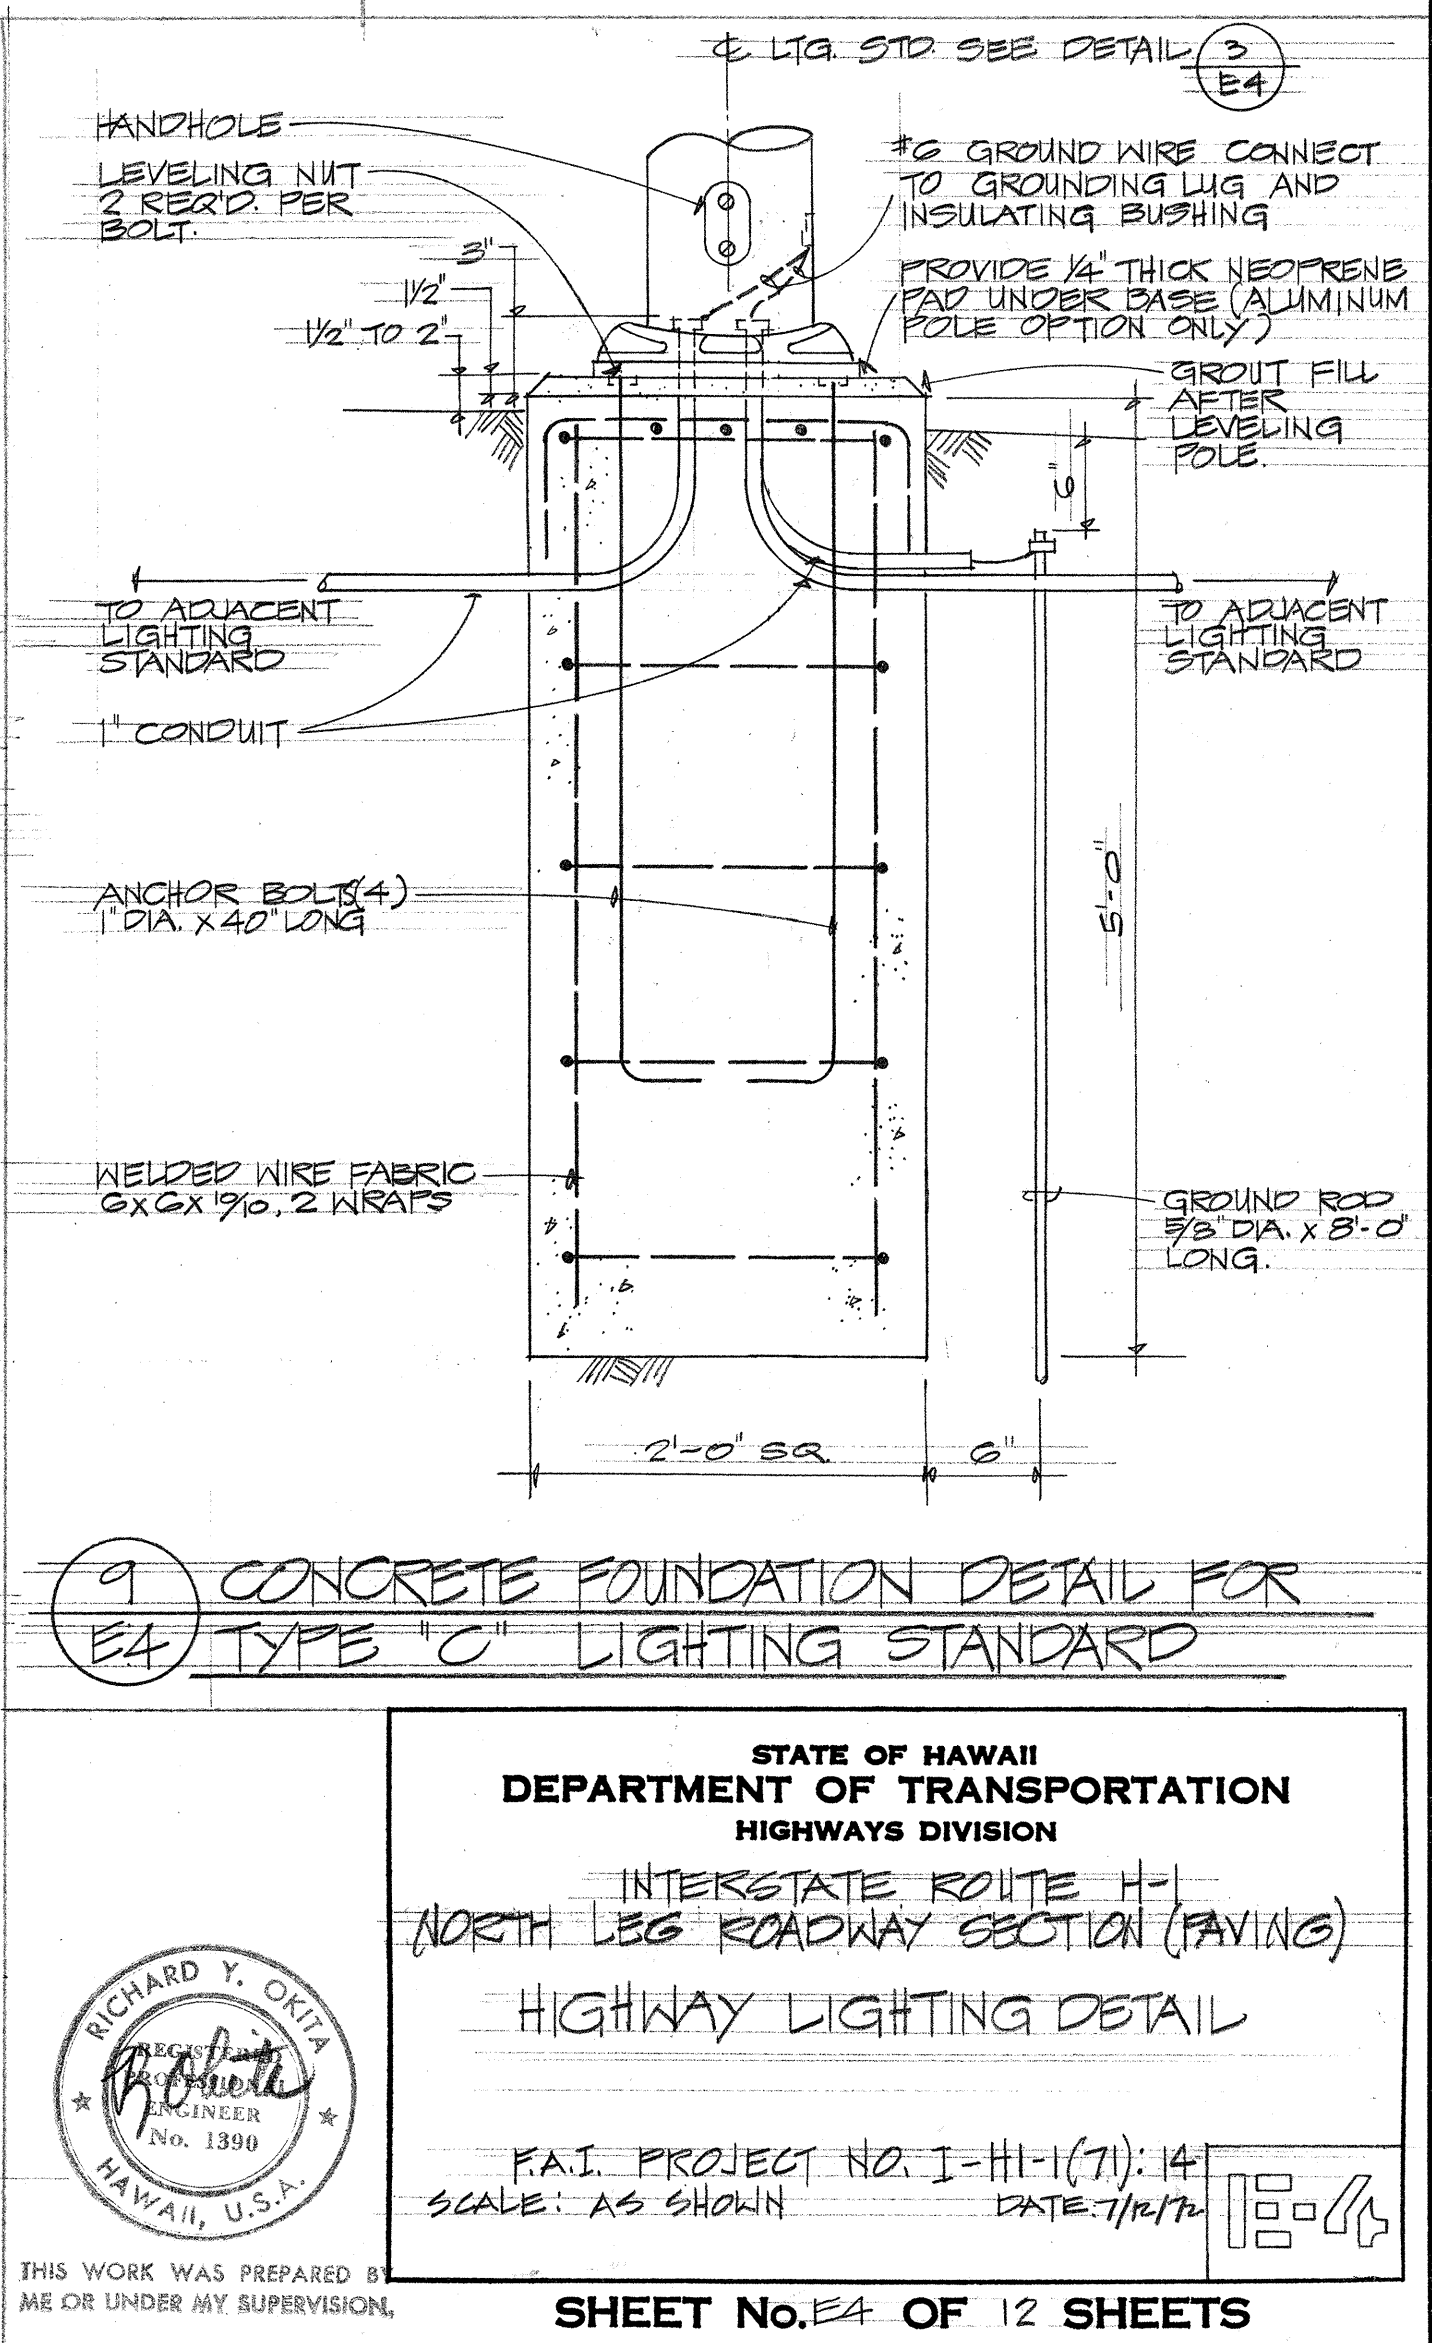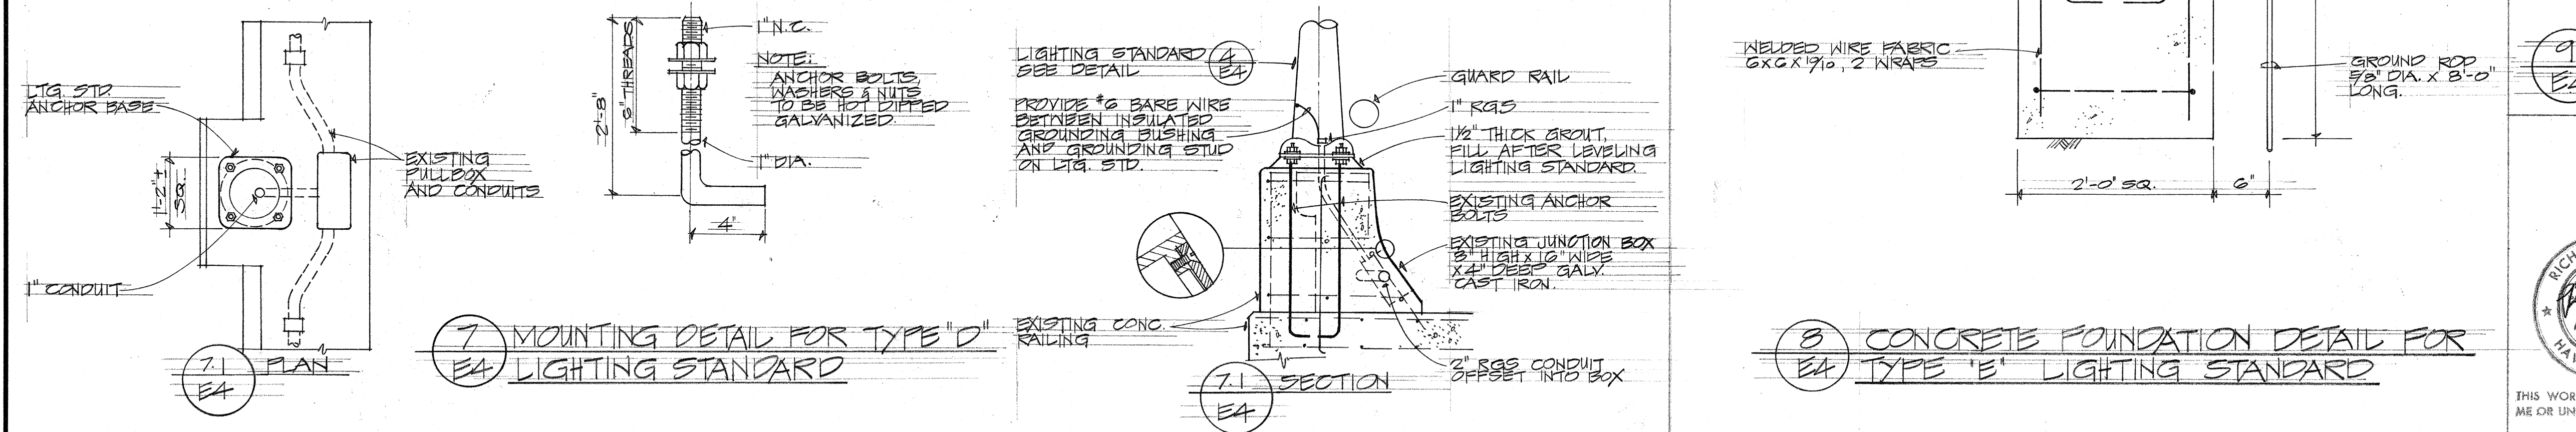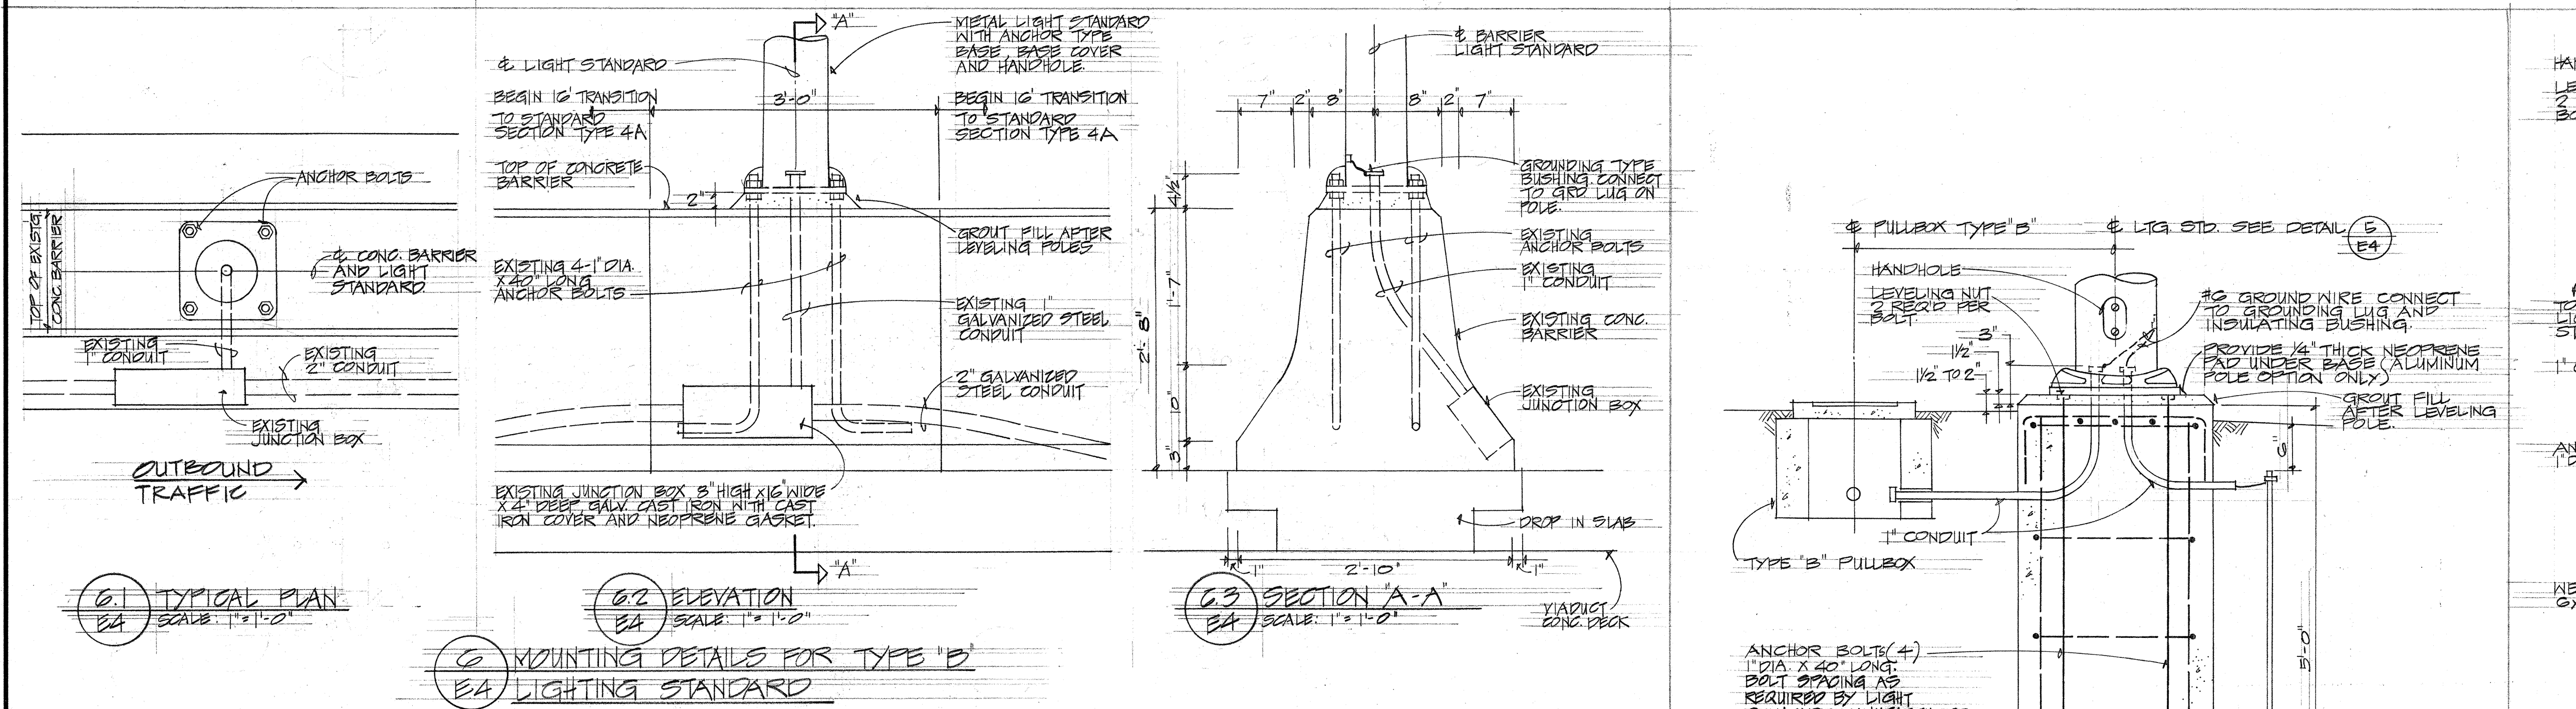

FED. ROAD DIST. NO.	STATE	FED. AID PROJ. NO.	FISCAL YEAR	SHEET NO.	TOTAL SHEETS
HAWAII	HAW.	1-HI-1 (71)-14	1974	46	61

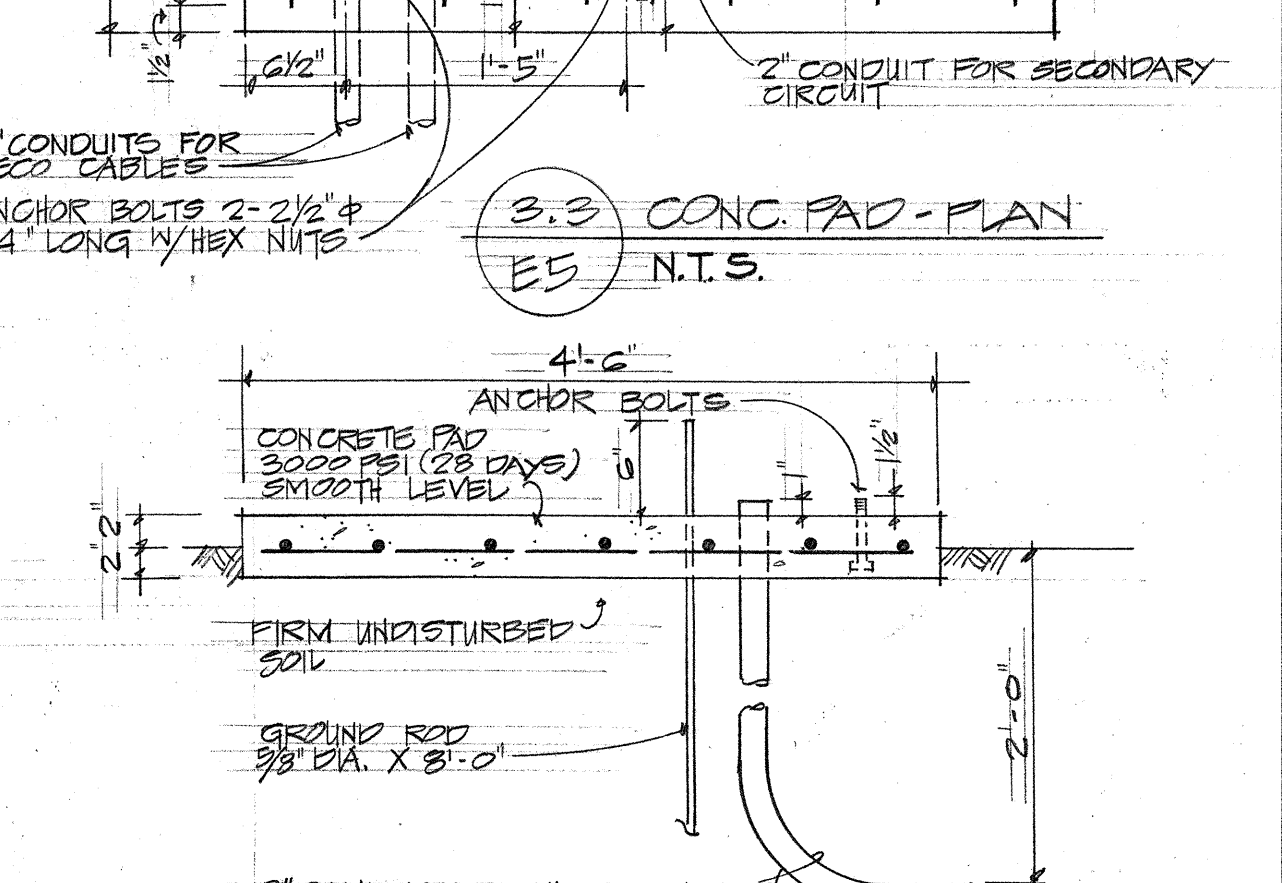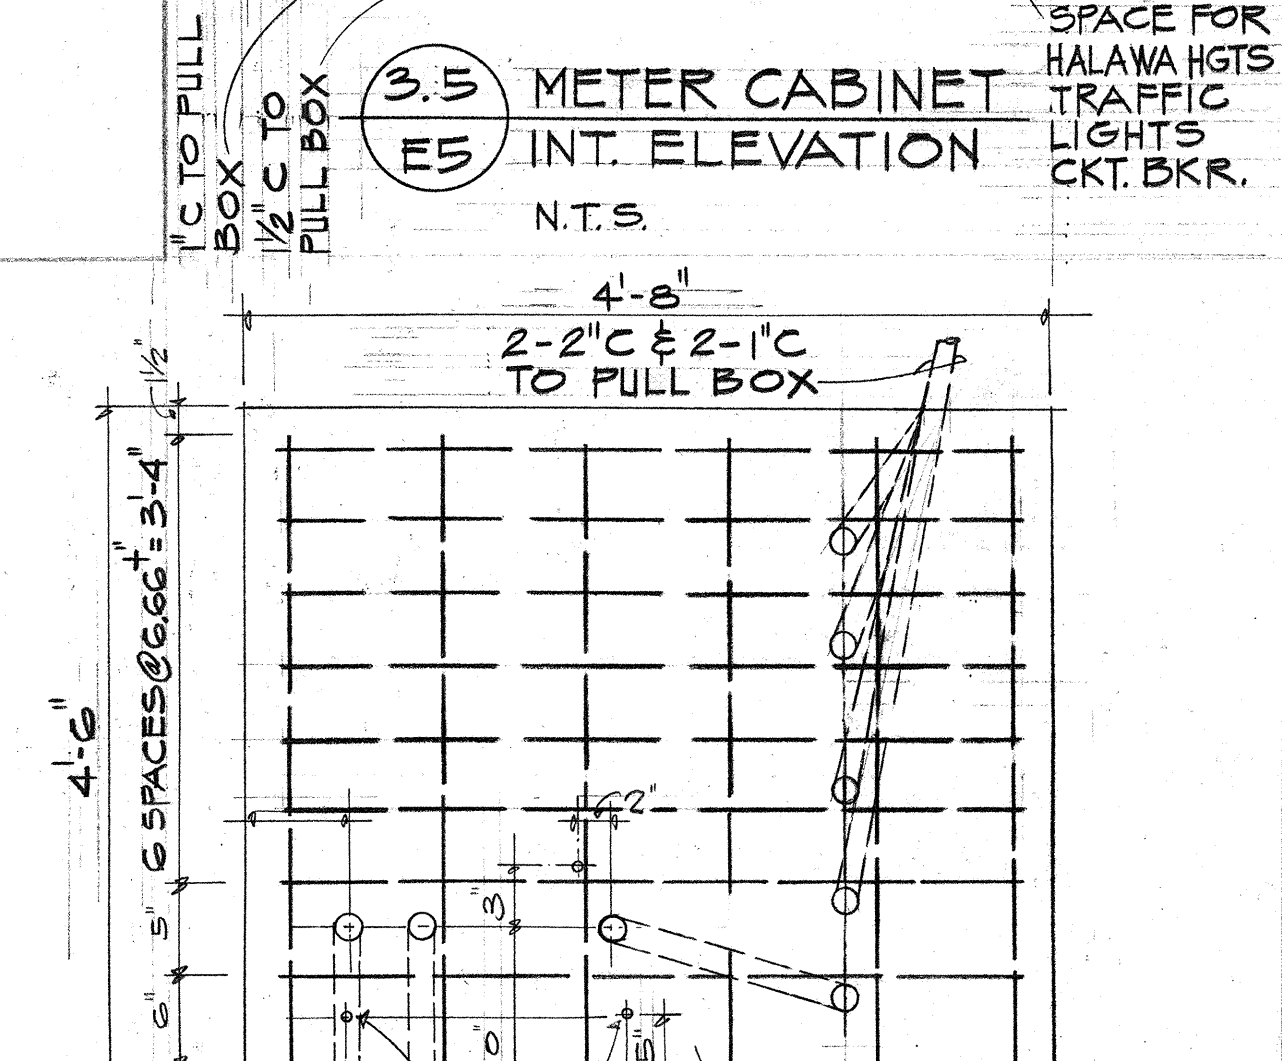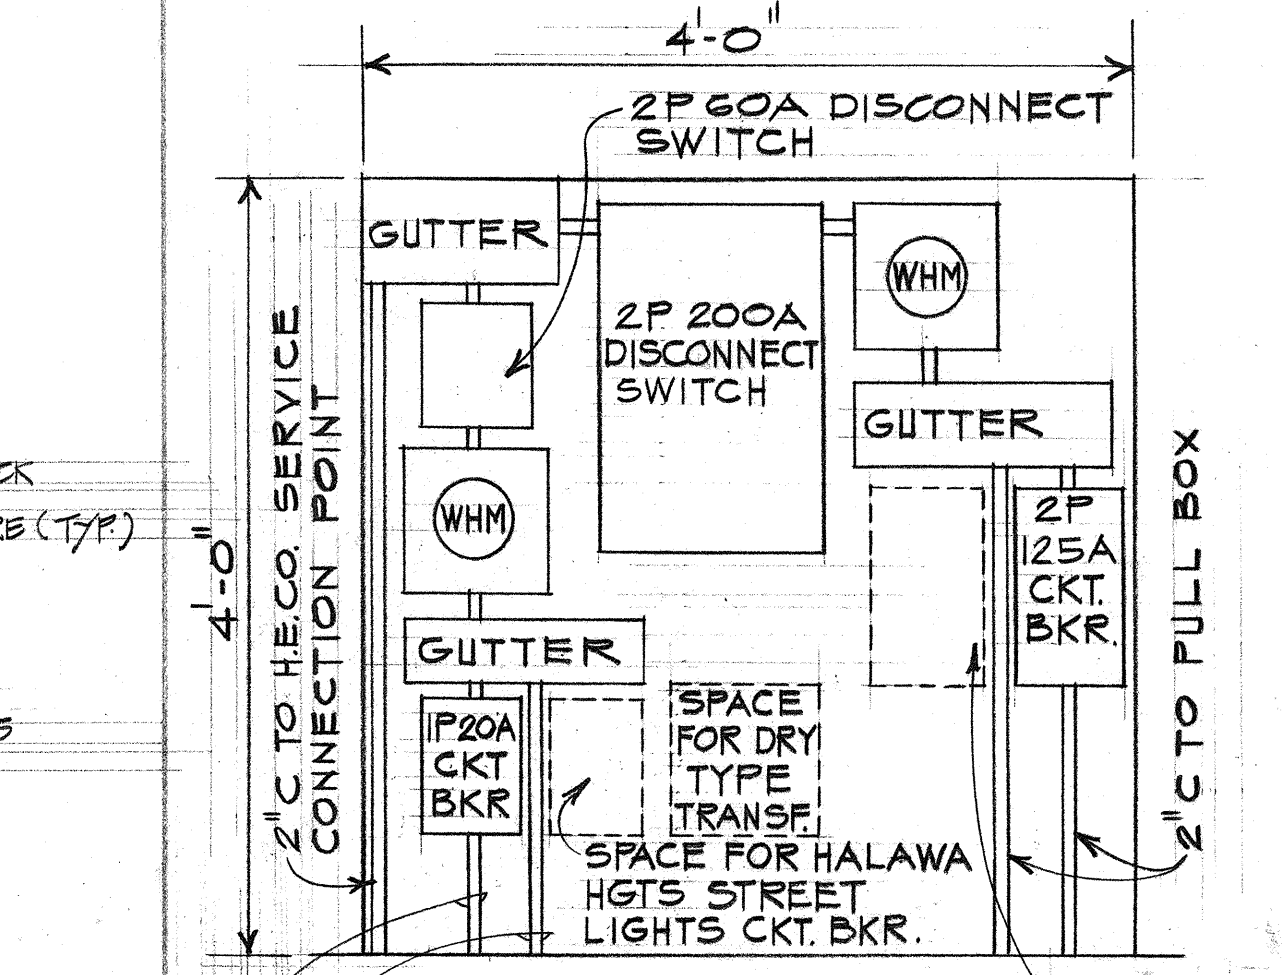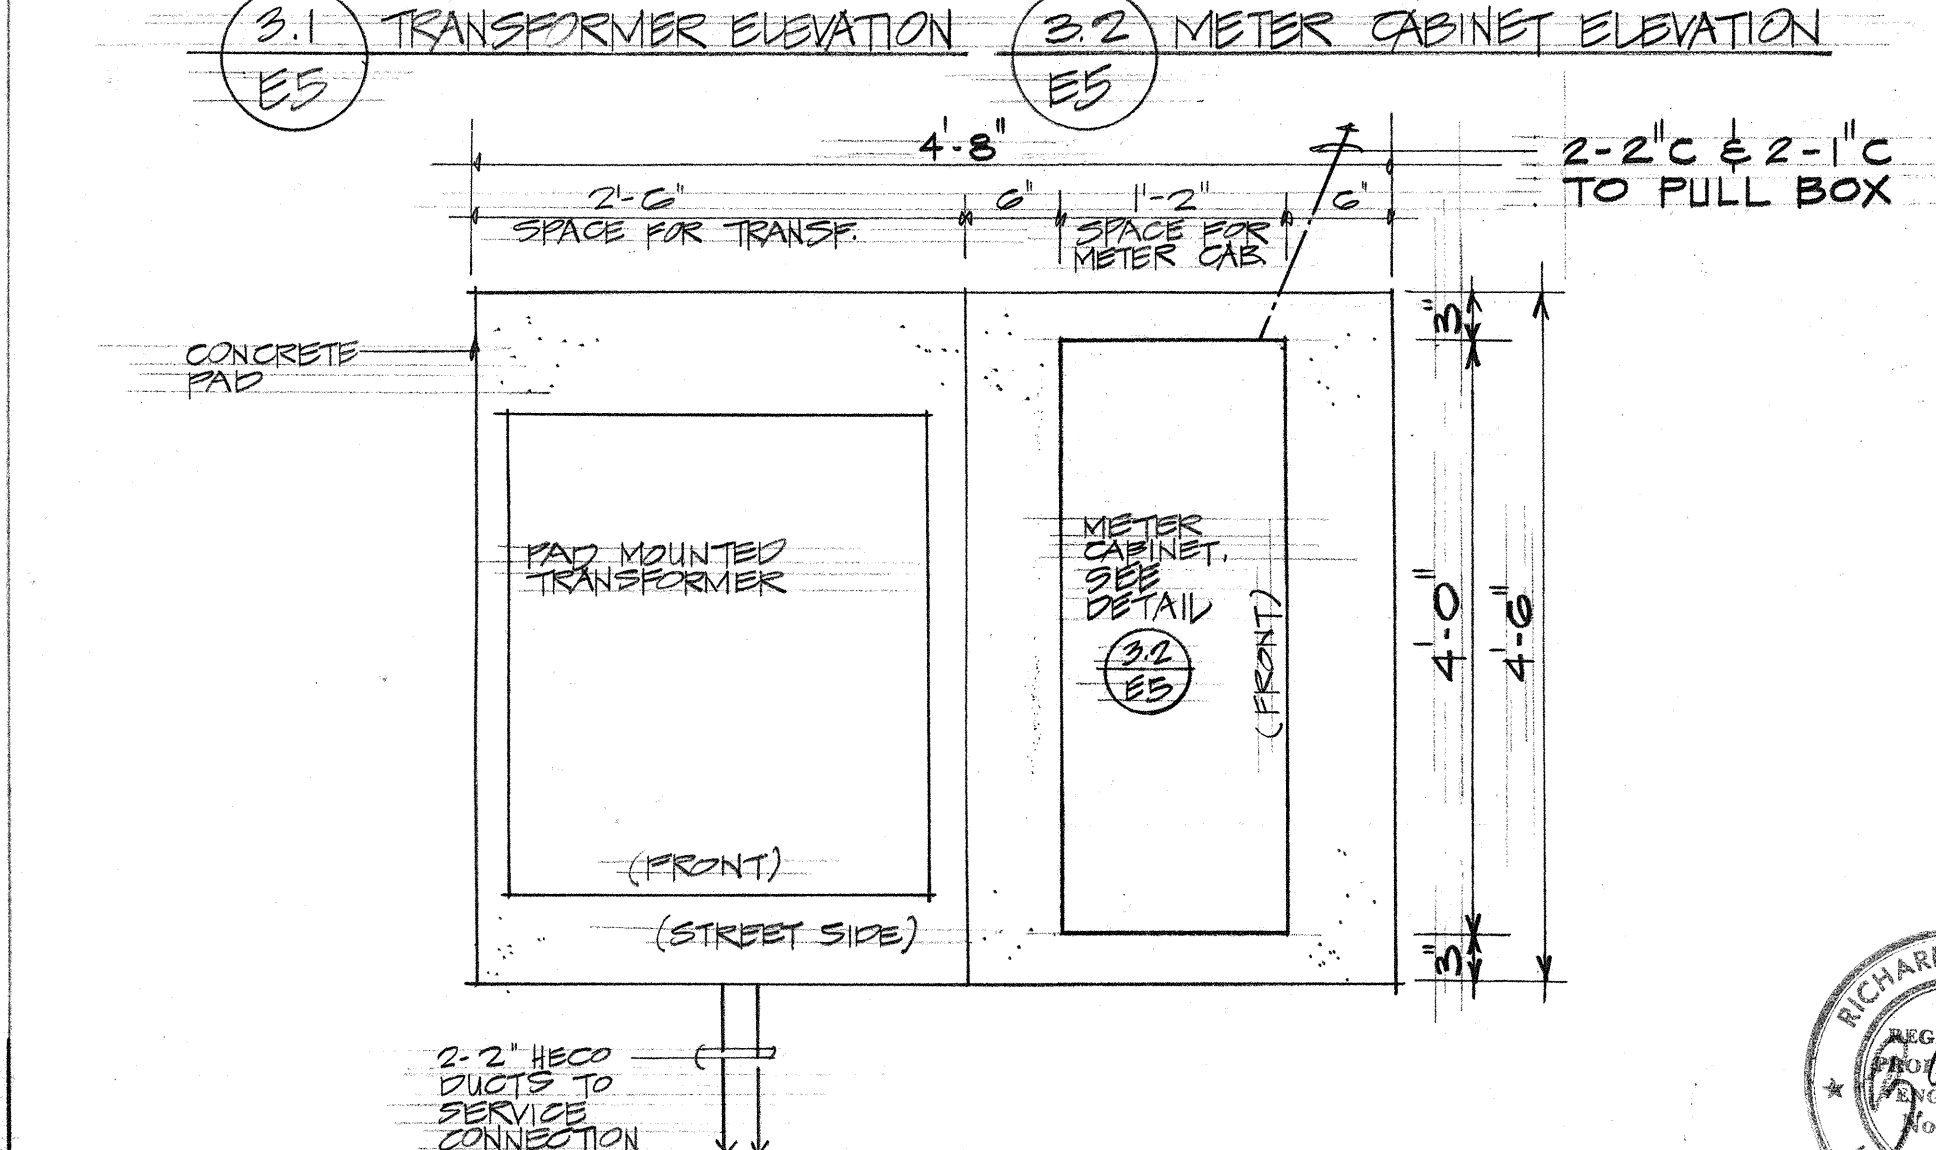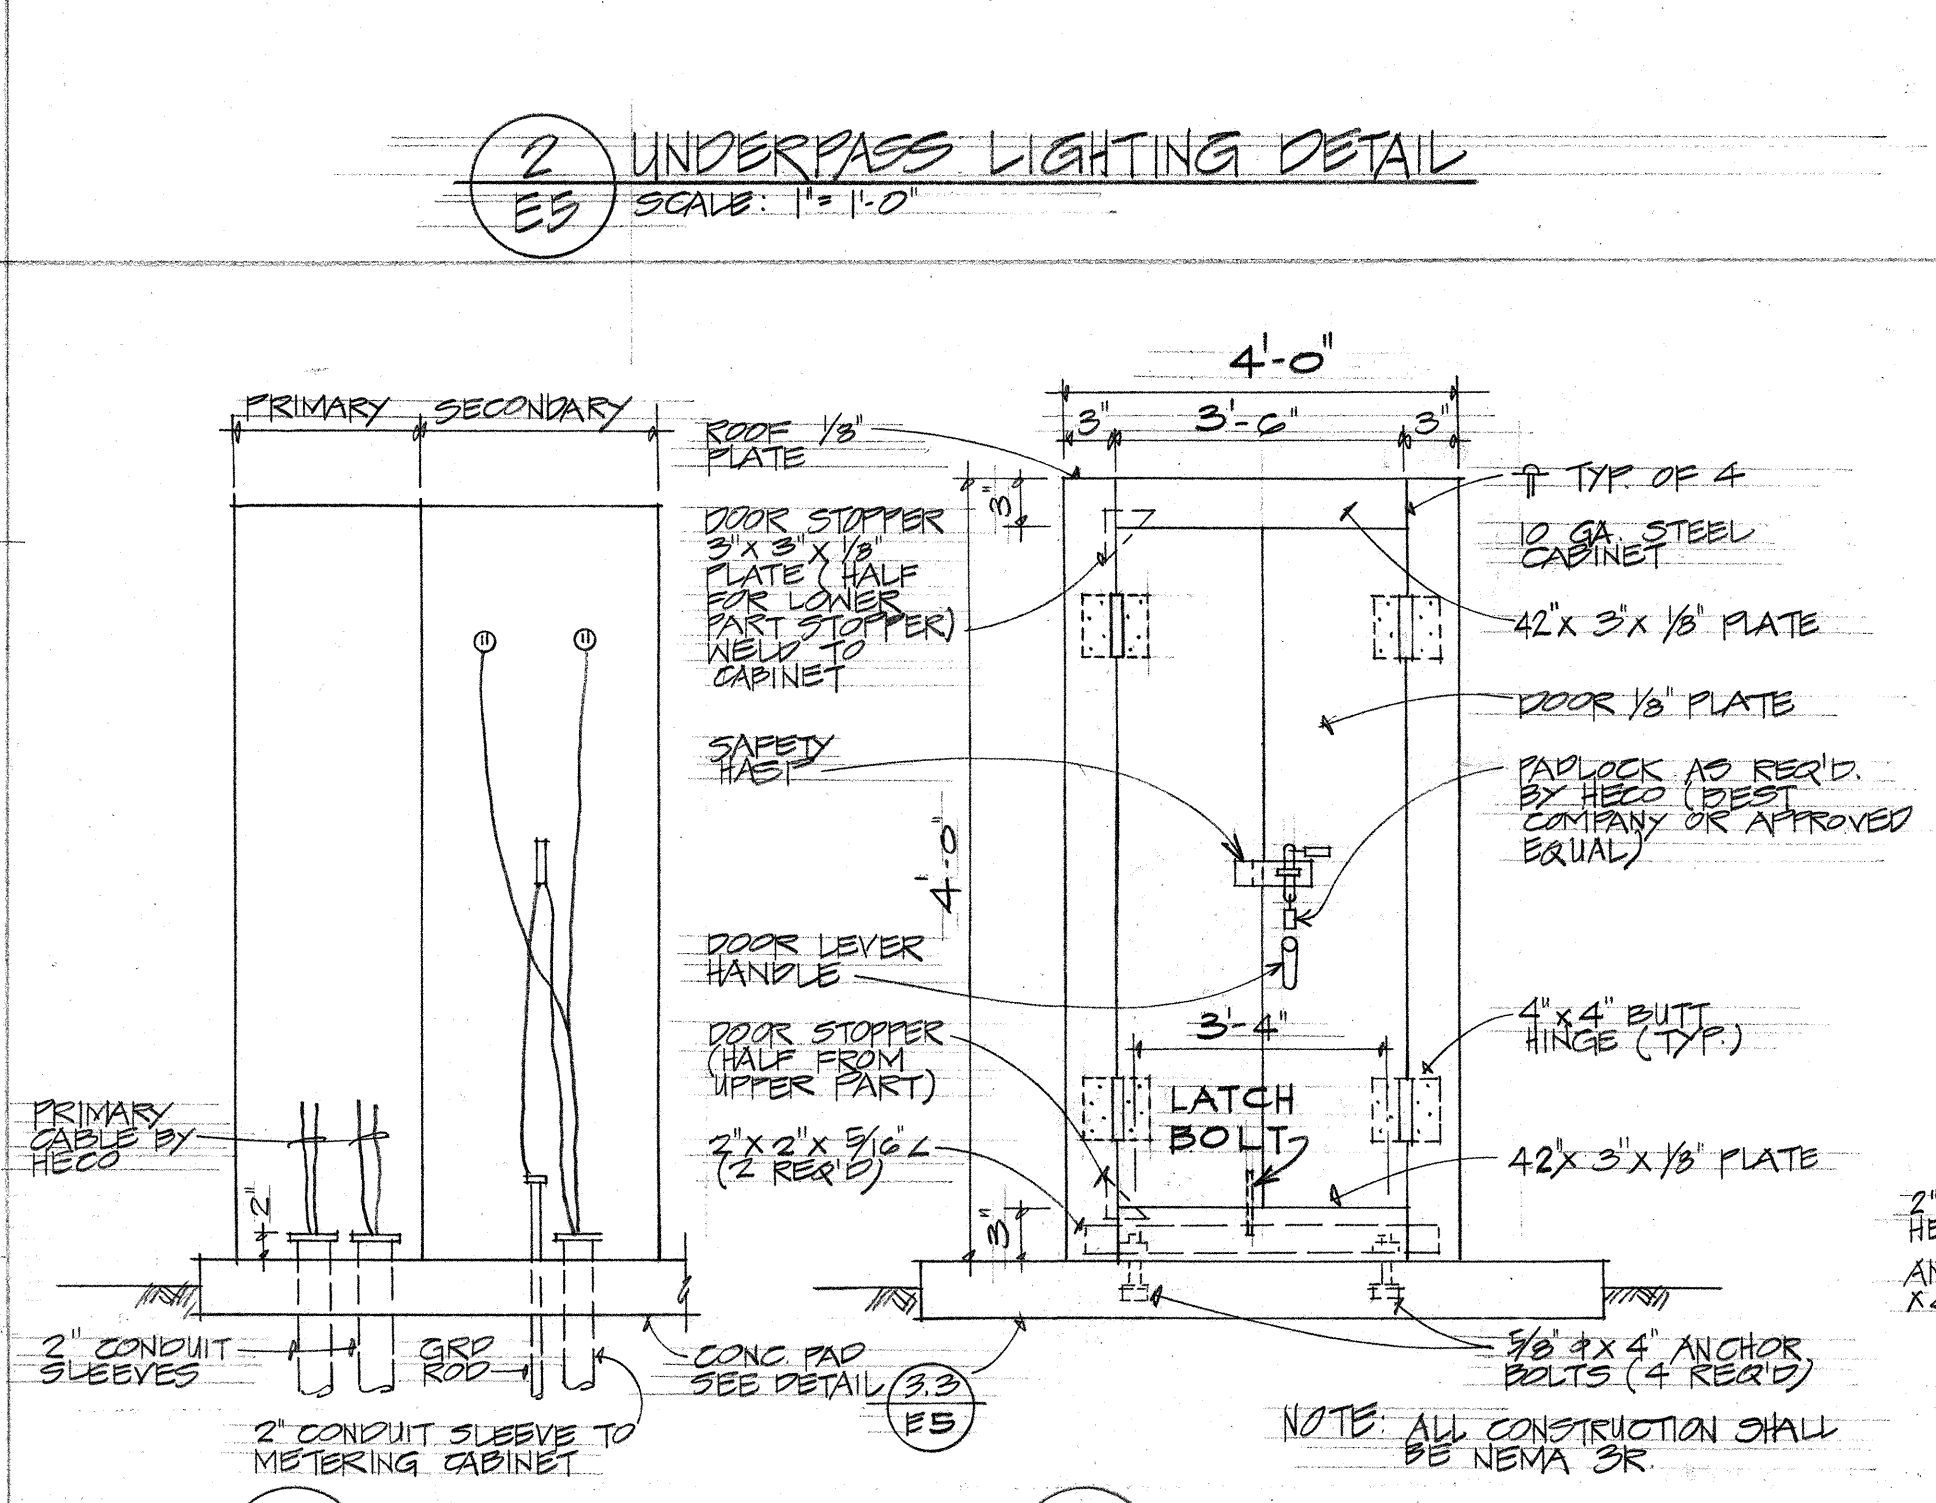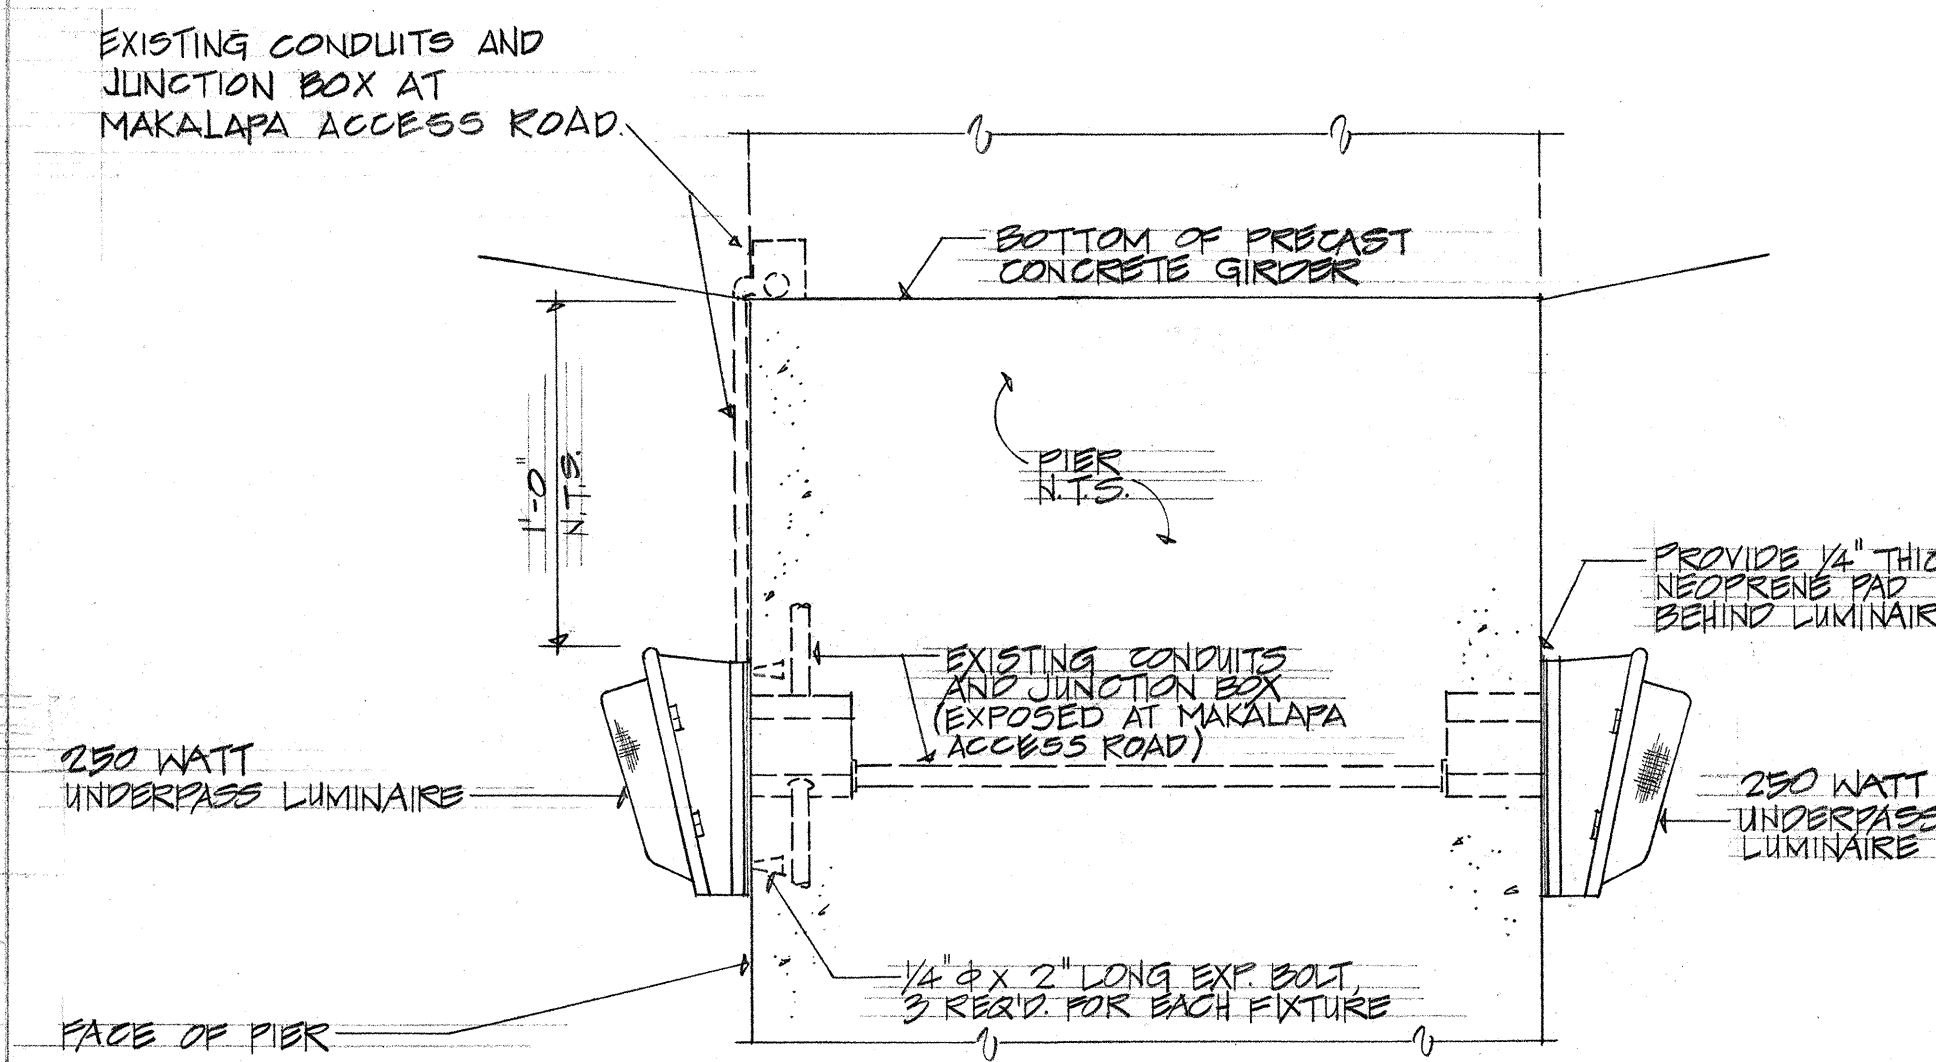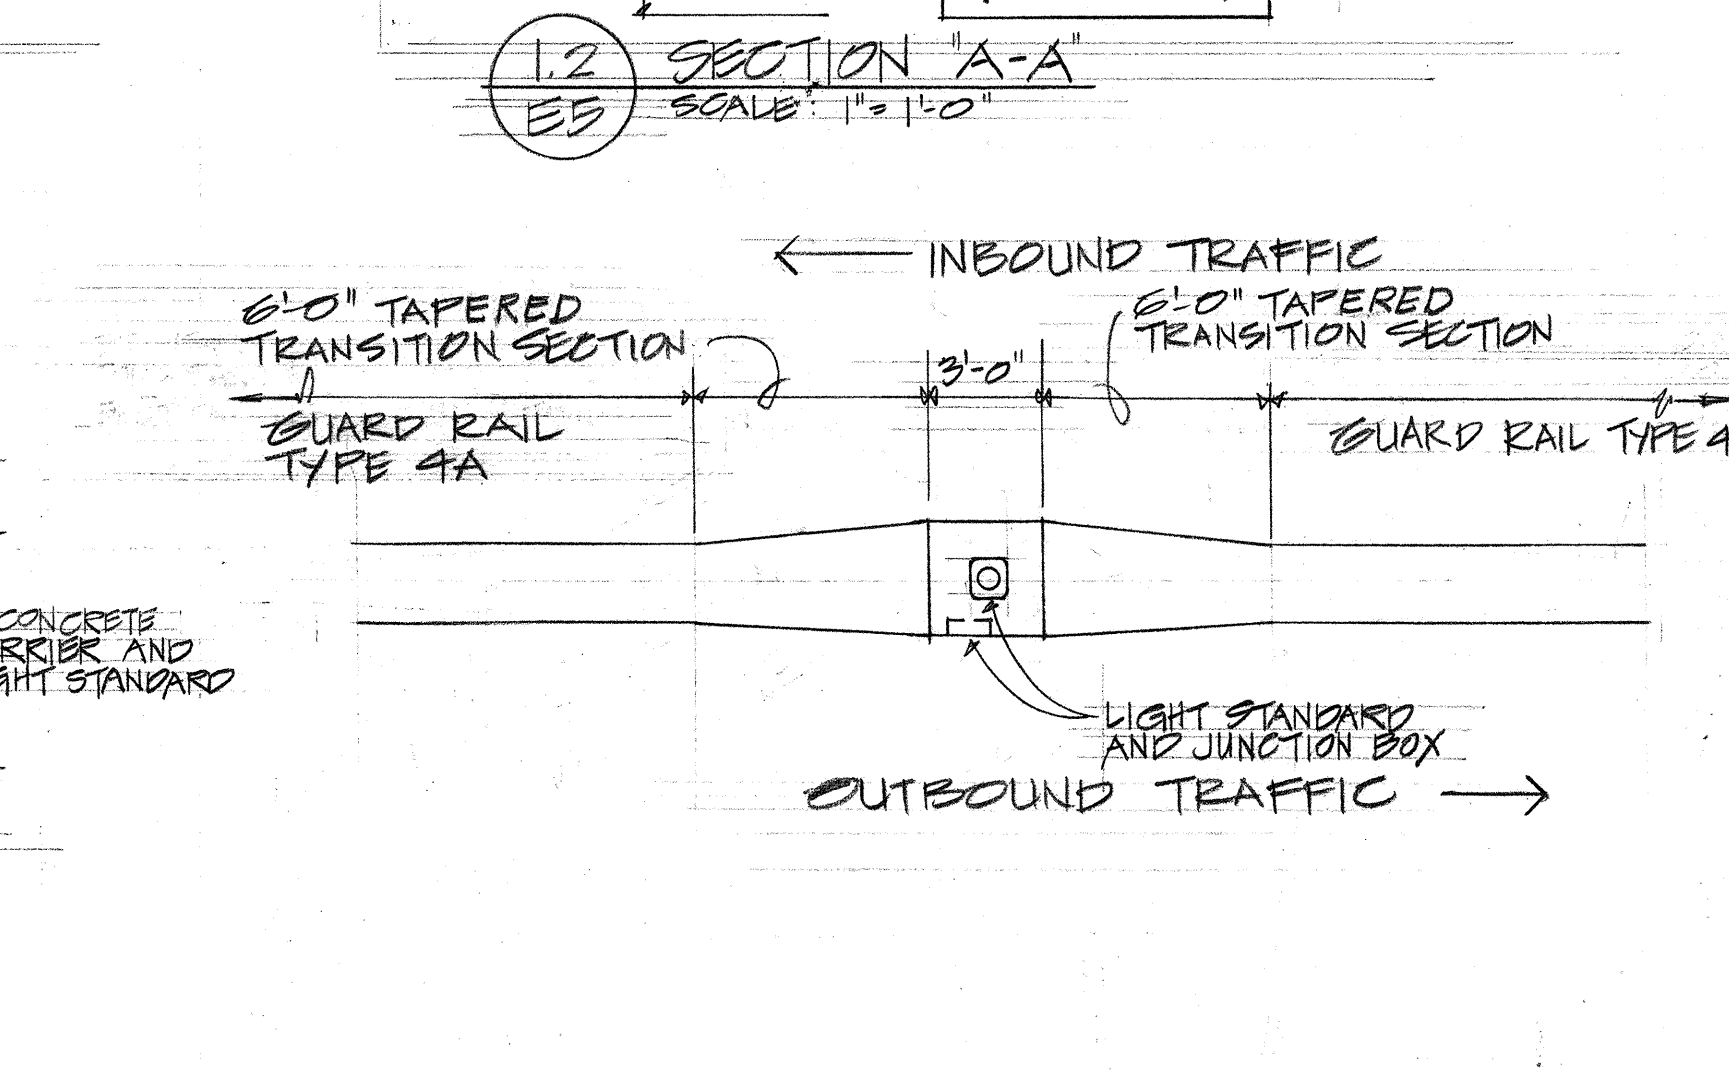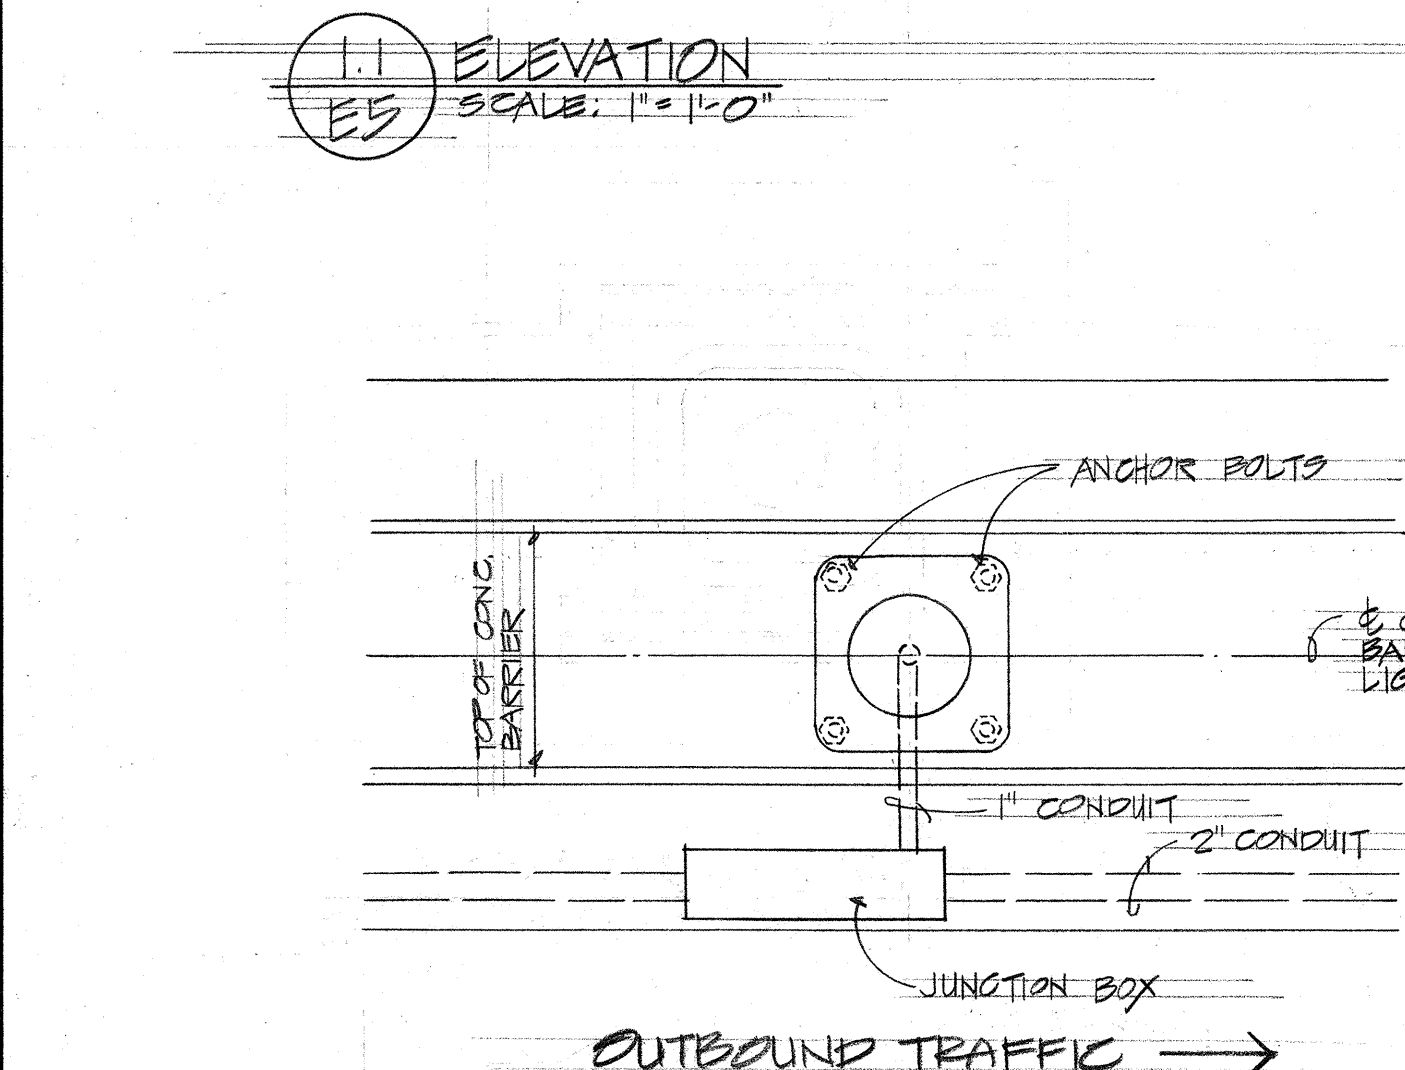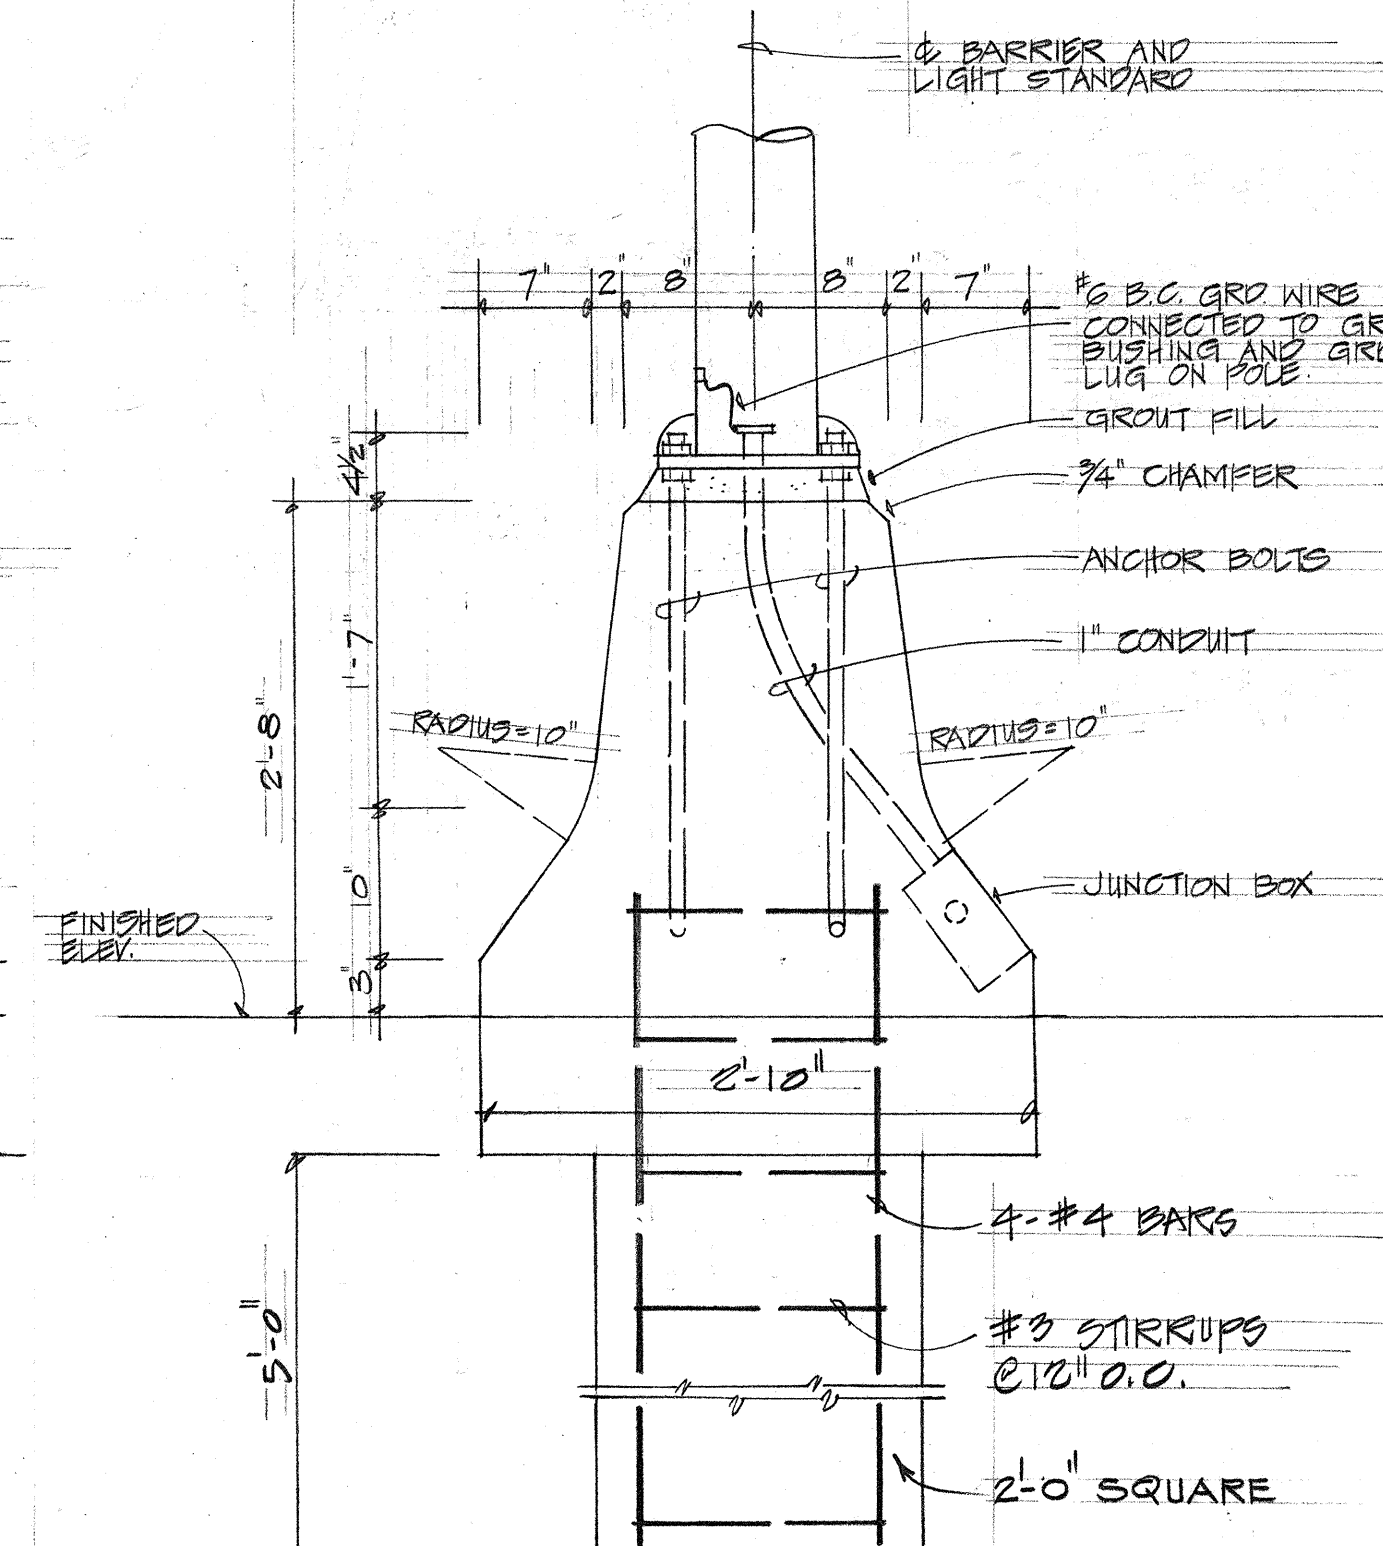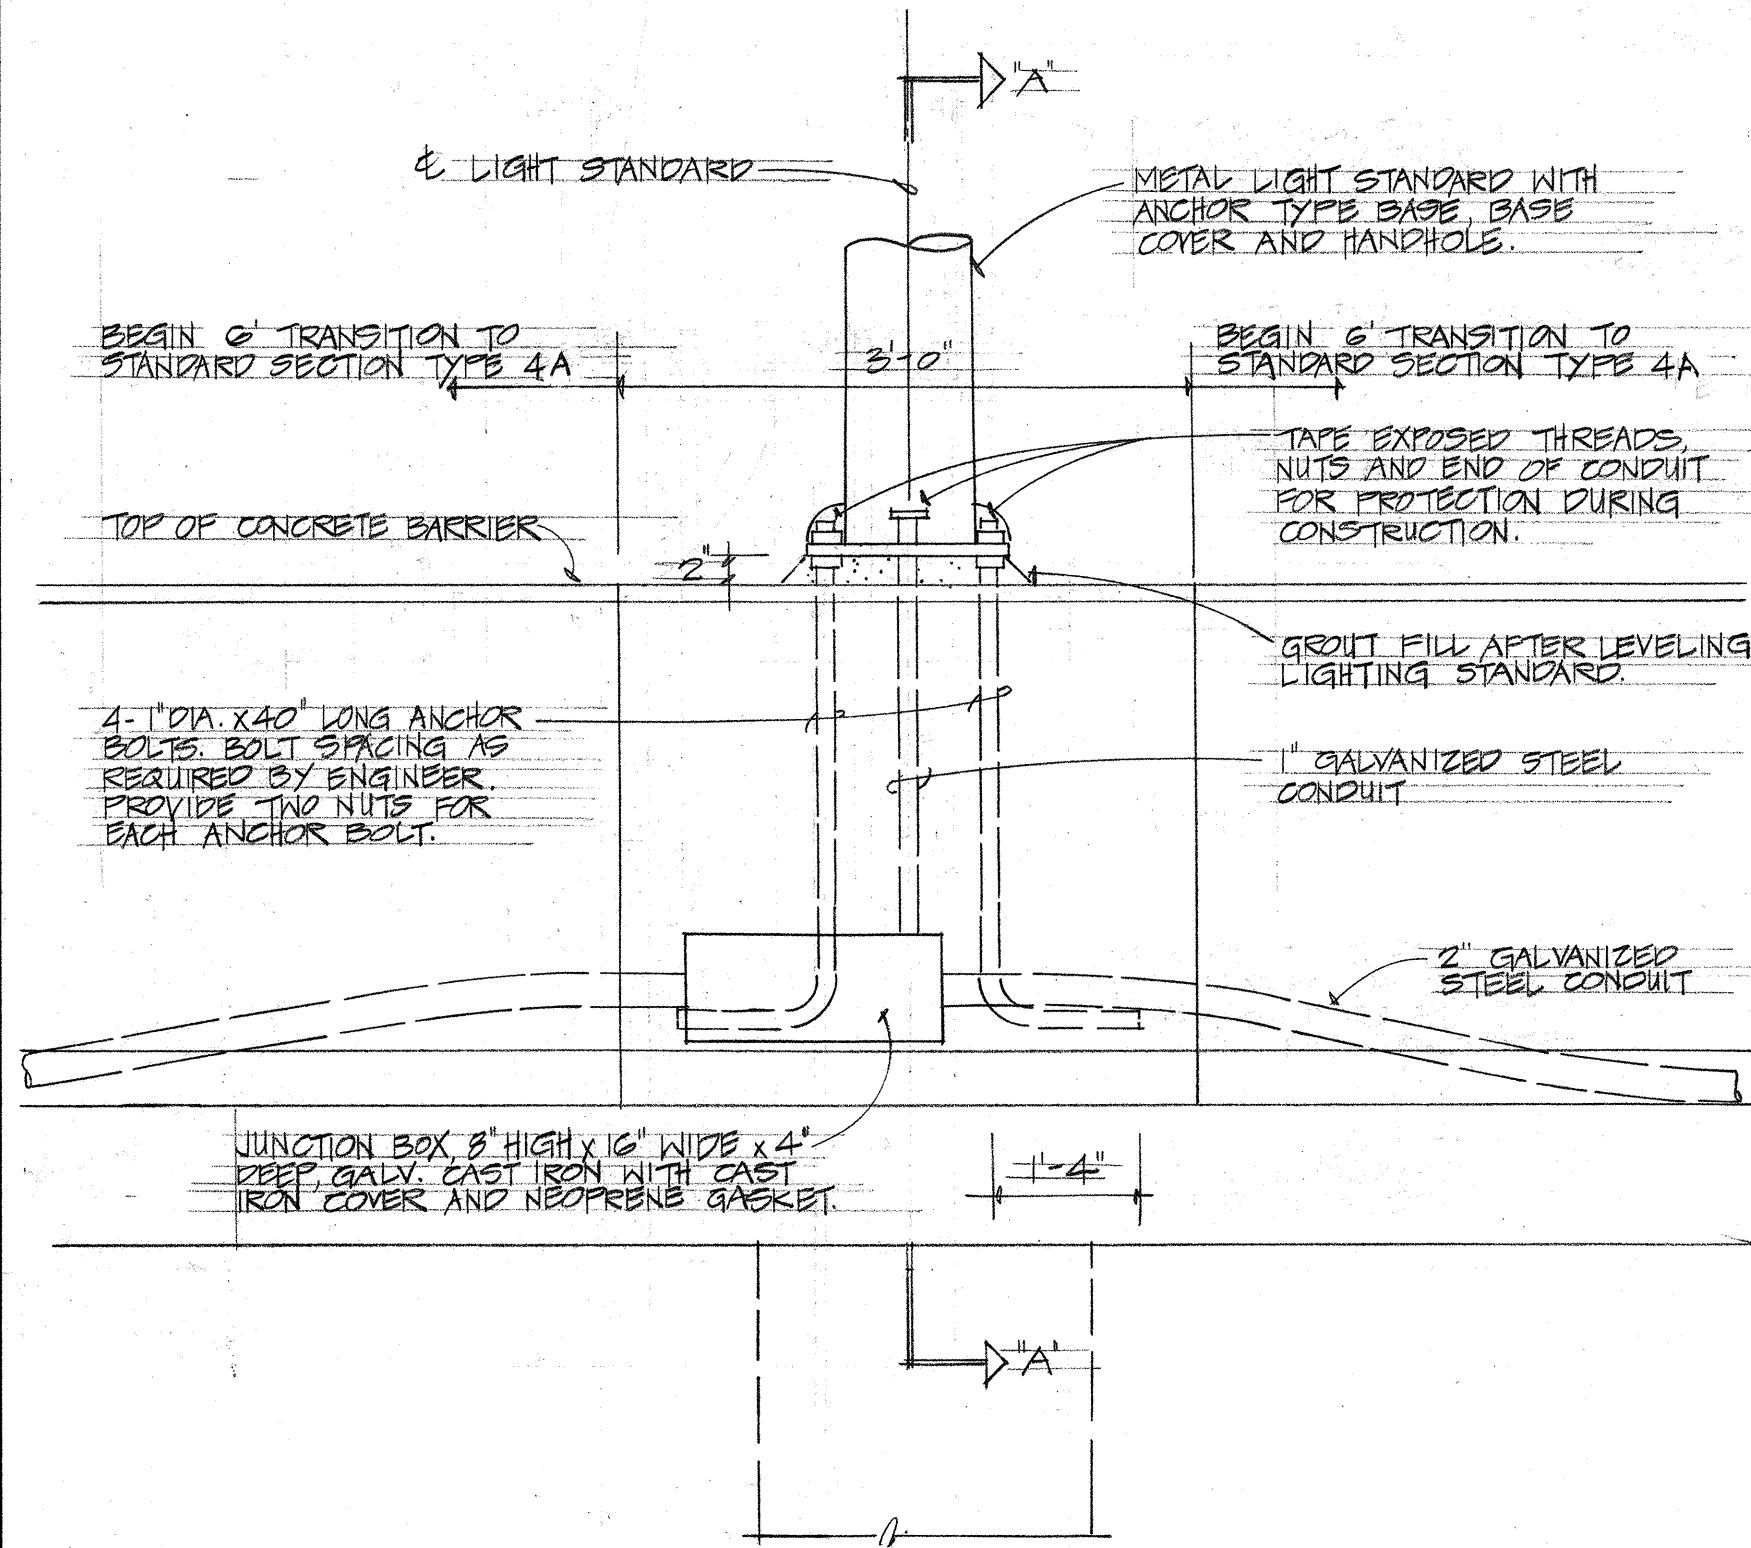

STATE OF HAWAII
DEPARTMENT OF TRANSPORTATION
HIGHWAYS DIVISION
INTERSTATE ROUTE H-1
NORTH LEG ROADWAY SECTION (PAVING)
HIGHWAY LIGHTING DETAILS
F.A.T. PROJECT NO. 1-HI-1(71)-14
SCALE AS SHOWN DATE: 7/14/72

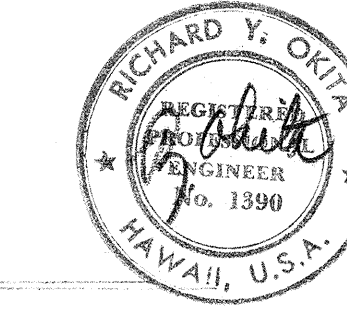

THIS WORK WAS PREPARED BY ME OR UNDER MY SUPERVISION.

SHEET No. 46 OF 12 SHEETS

ADD. 46

ORIGINAL PLAN
DATE
SURVEY PLATTED BY
DRAWN BY
TRACED BY
NOTED BY
CHECKED BY
No.

2/26/75 CHANGED METER CABINET AND CONC. PAD WIDTH. ADDED ELEVATION 3.5/E5, ADDED NOTE ABOVE DETAIL 1.2/E5
DATE REVISION

