


FED. ROAD DIST. NO.	STATE	FED. AID PROJ. NO.	FISCAL YEAR	SHEET NO.	TOTAL SHEETS
HAWAII	HAW.	IM-HI-1(244)R	2019	145	190


DRAWING NAME: \\ACA-DC1\CARRE\H-1 GUARDRAIL\HI-E0001.DWG PLOT TIME: 11-15-21, 1:21 PM

SURVEY PLOTTED BY	DATE
DESIGNED BY	
TRACED BY	
DESIGNED BY	
QUANTITIES BY	
CHECKED BY	


ORIGINAL PLAN	No.
NOTE BOOK	

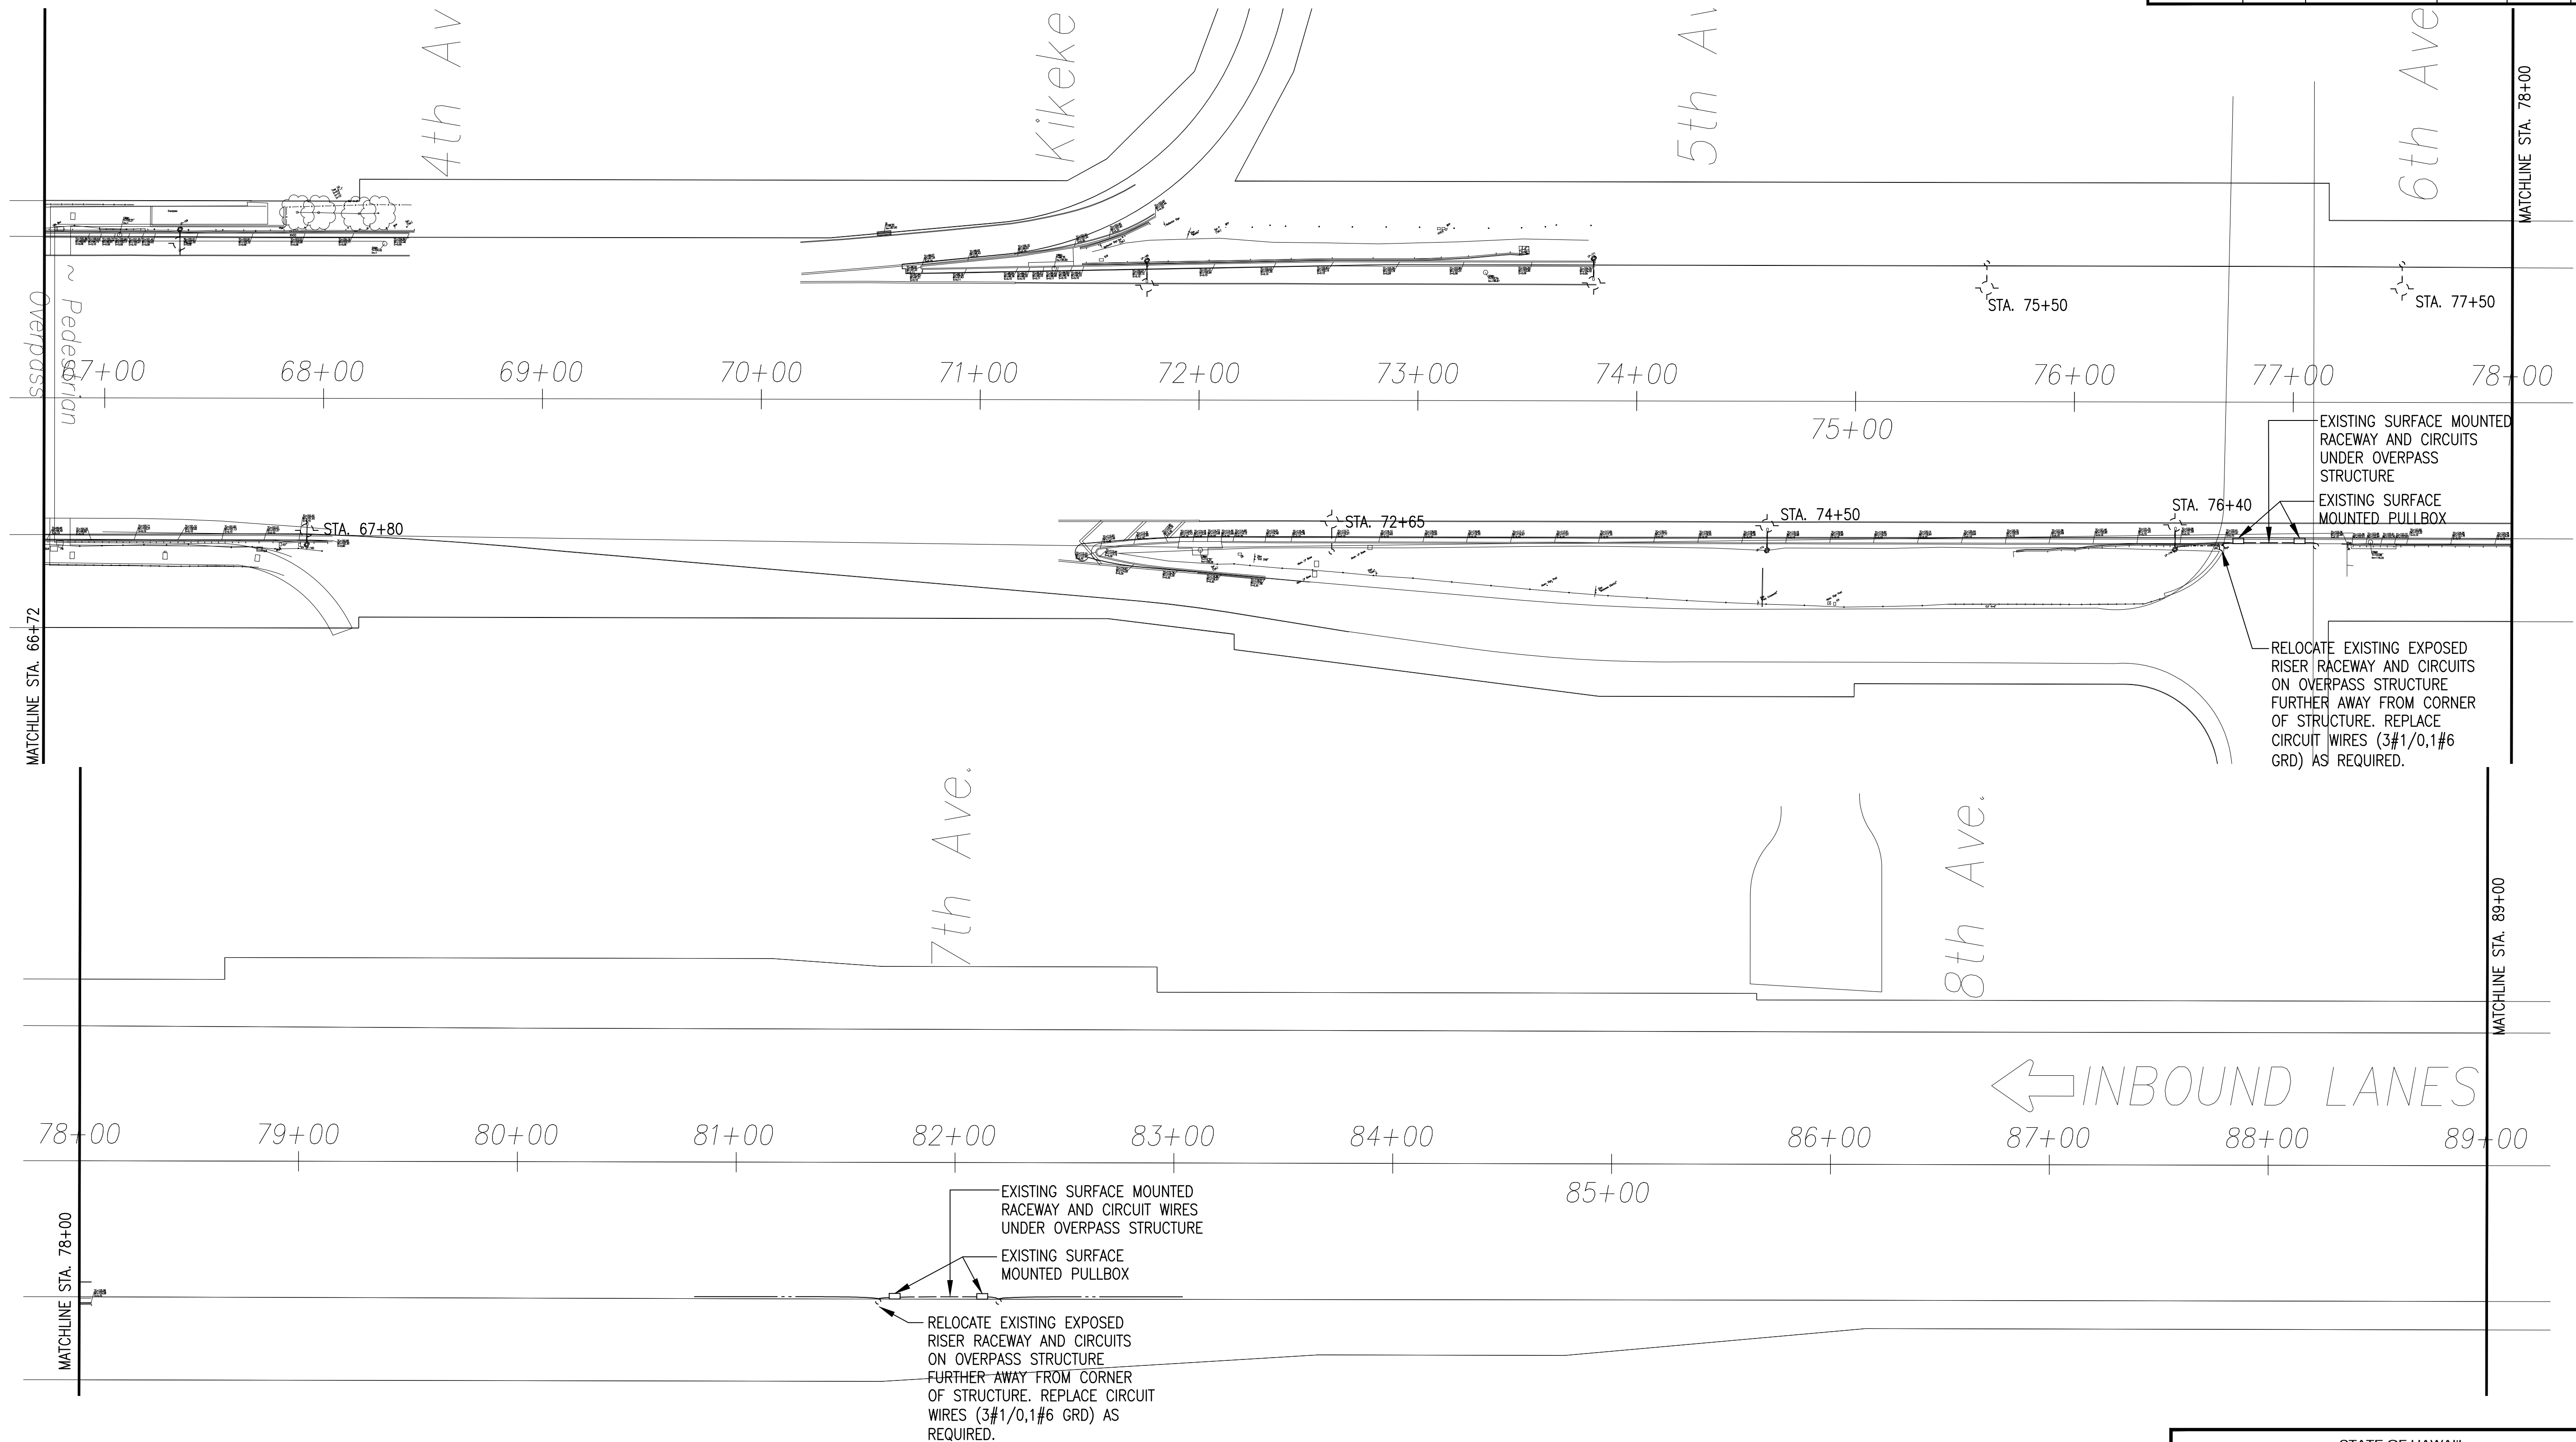

PARTIAL ELECTRICAL PLAN
SCALE: 1" = 40' - 0"

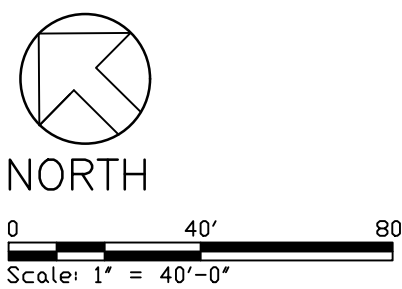

Albert Chong Associates Inc.
Consulting Electrical Engineers
and Lighting Designers
1117 Kapiolani Avenue
Honolulu, Hawaii 96816
Telephone (808) 738-5355

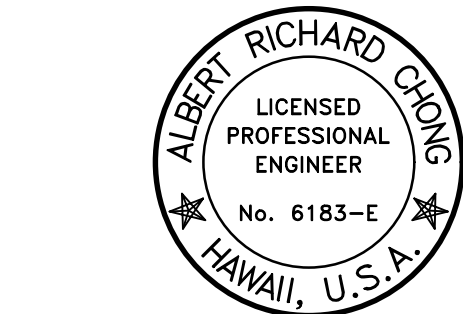

THIS WORK WAS PREPARED BY ME
OR UNDER MY SUPERVISION AND THE
CONSTRUCTION OF THIS PROJECT
WILL BE UNDER MY OBSERVATION.
APRIL 30, 2022
LIC. EXP. DATE


STATE OF HAWAII
DEPARTMENT OF TRANSPORTATION
HIGHWAYS DIVISION

PARTIAL ELECTRICAL PLAN


INTERSTATE ROUTE H-1
Guardrail and Shoulder Improvements,
Kapiolani Interchange to Ainakoa Avenue
Federal-Aid Project No. IM-HI-1(244)R
Scale: As Shown Date: July 2018

SHEET No. *E1* OF 3 SHEETS


FED. ROAD DIST. NO.	STATE	FED. AID PROJ. NO.	FISCAL YEAR	SHEET NO.	TOTAL SHEETS
HAWAII	HAW.	IM-HI-1(244)R	2019	146	190

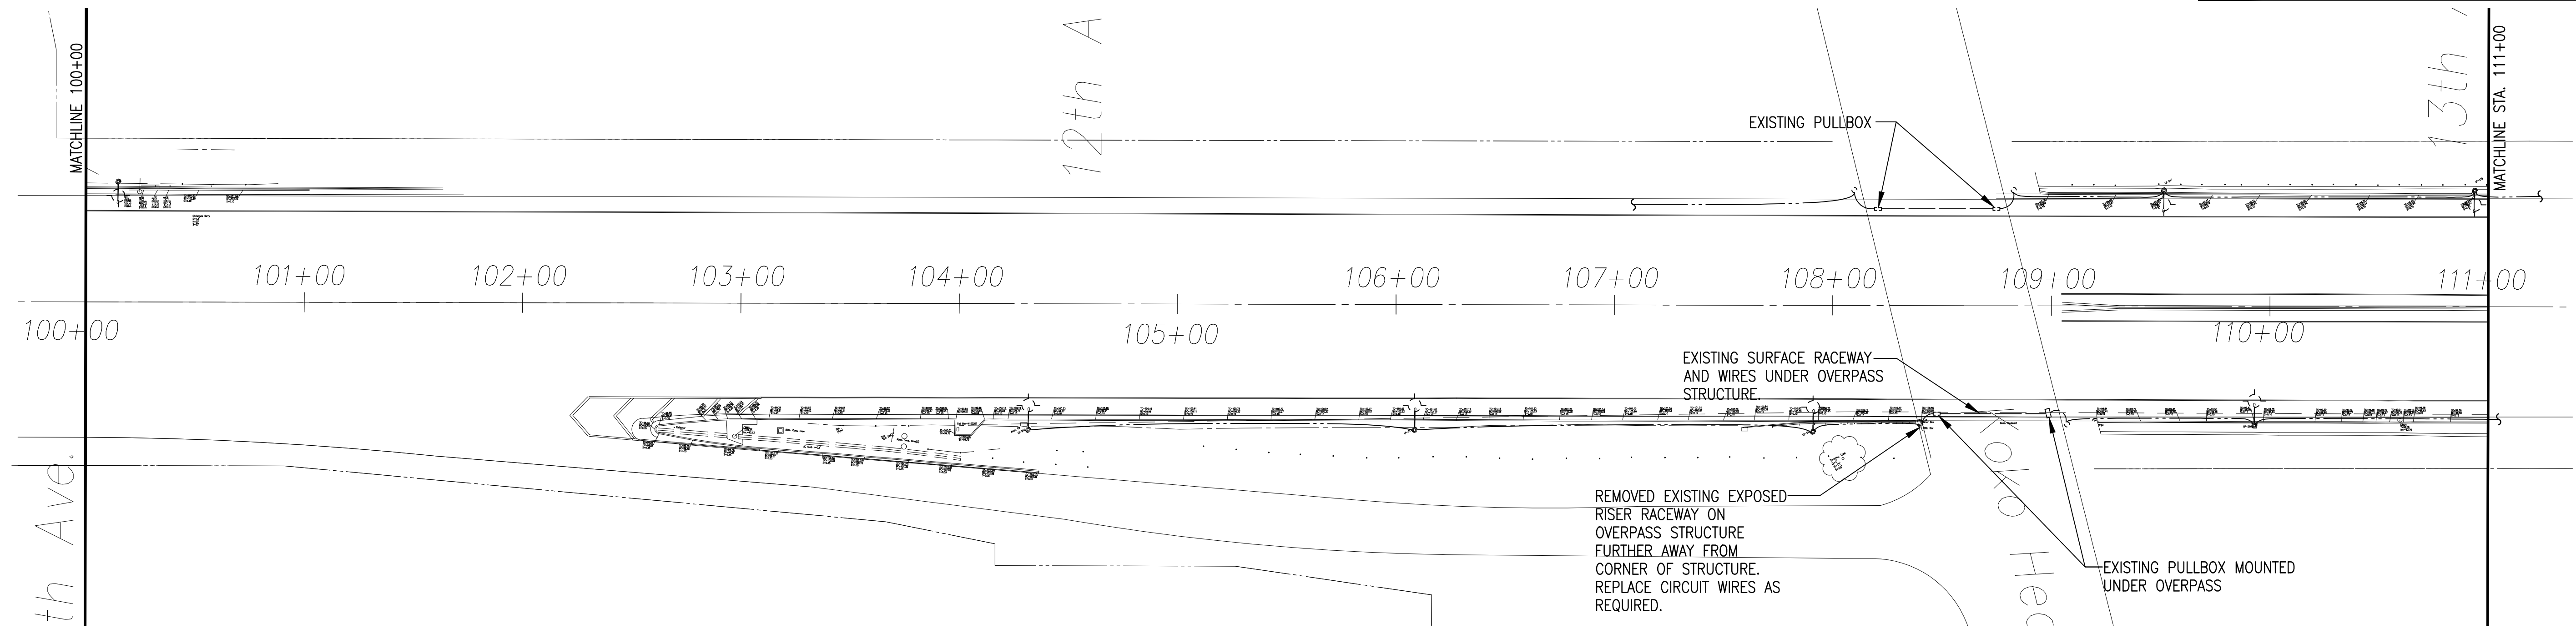

PARTIAL ELECTRICAL PLAN
SCALE: 1" = 40' - 0"

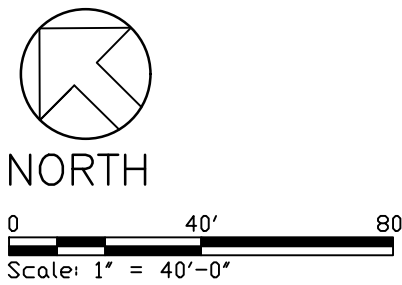

Albert Chong Associates Inc.
Consulting Electrical Engineers
and Lighting Designers
1117 Kapiolani Avenue
Honolulu, Hawaii 96816
Telephone (808) 738-5355

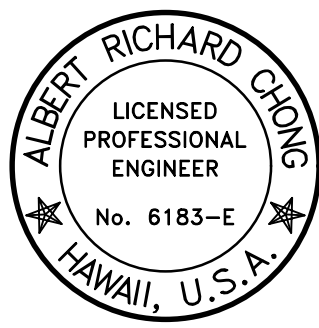

THIS WORK WAS PREPARED BY ME
OR UNDER MY SUPERVISION AND THE
CONSTRUCTION OF THIS PROJECT
WILL BE UNDER MY OBSERVATION.

APRIL 30, 2022
LIC. EXP. DATE


STATE OF HAWAII
DEPARTMENT OF TRANSPORTATION
HIGHWAYS DIVISION

PARTIAL ELECTRICAL PLAN


INTERSTATE ROUTE H-1
Guardrail and Shoulder Improvements,
Kapiolani Interchange to Ainakoa Avenue
Federal-Aid Project No. IM-HI-1(244)R
Scale: As Shown Date: July 2018

SHEET No. E2 OF 3 SHEETS


FED. ROAD DIST. NO.	STATE	FED. AID PROJ. NO.	FISCAL YEAR	SHEET NO.	TOTAL SHEETS
HAWAII	HAW.	IM-HI-1(244)R	2019	147	190

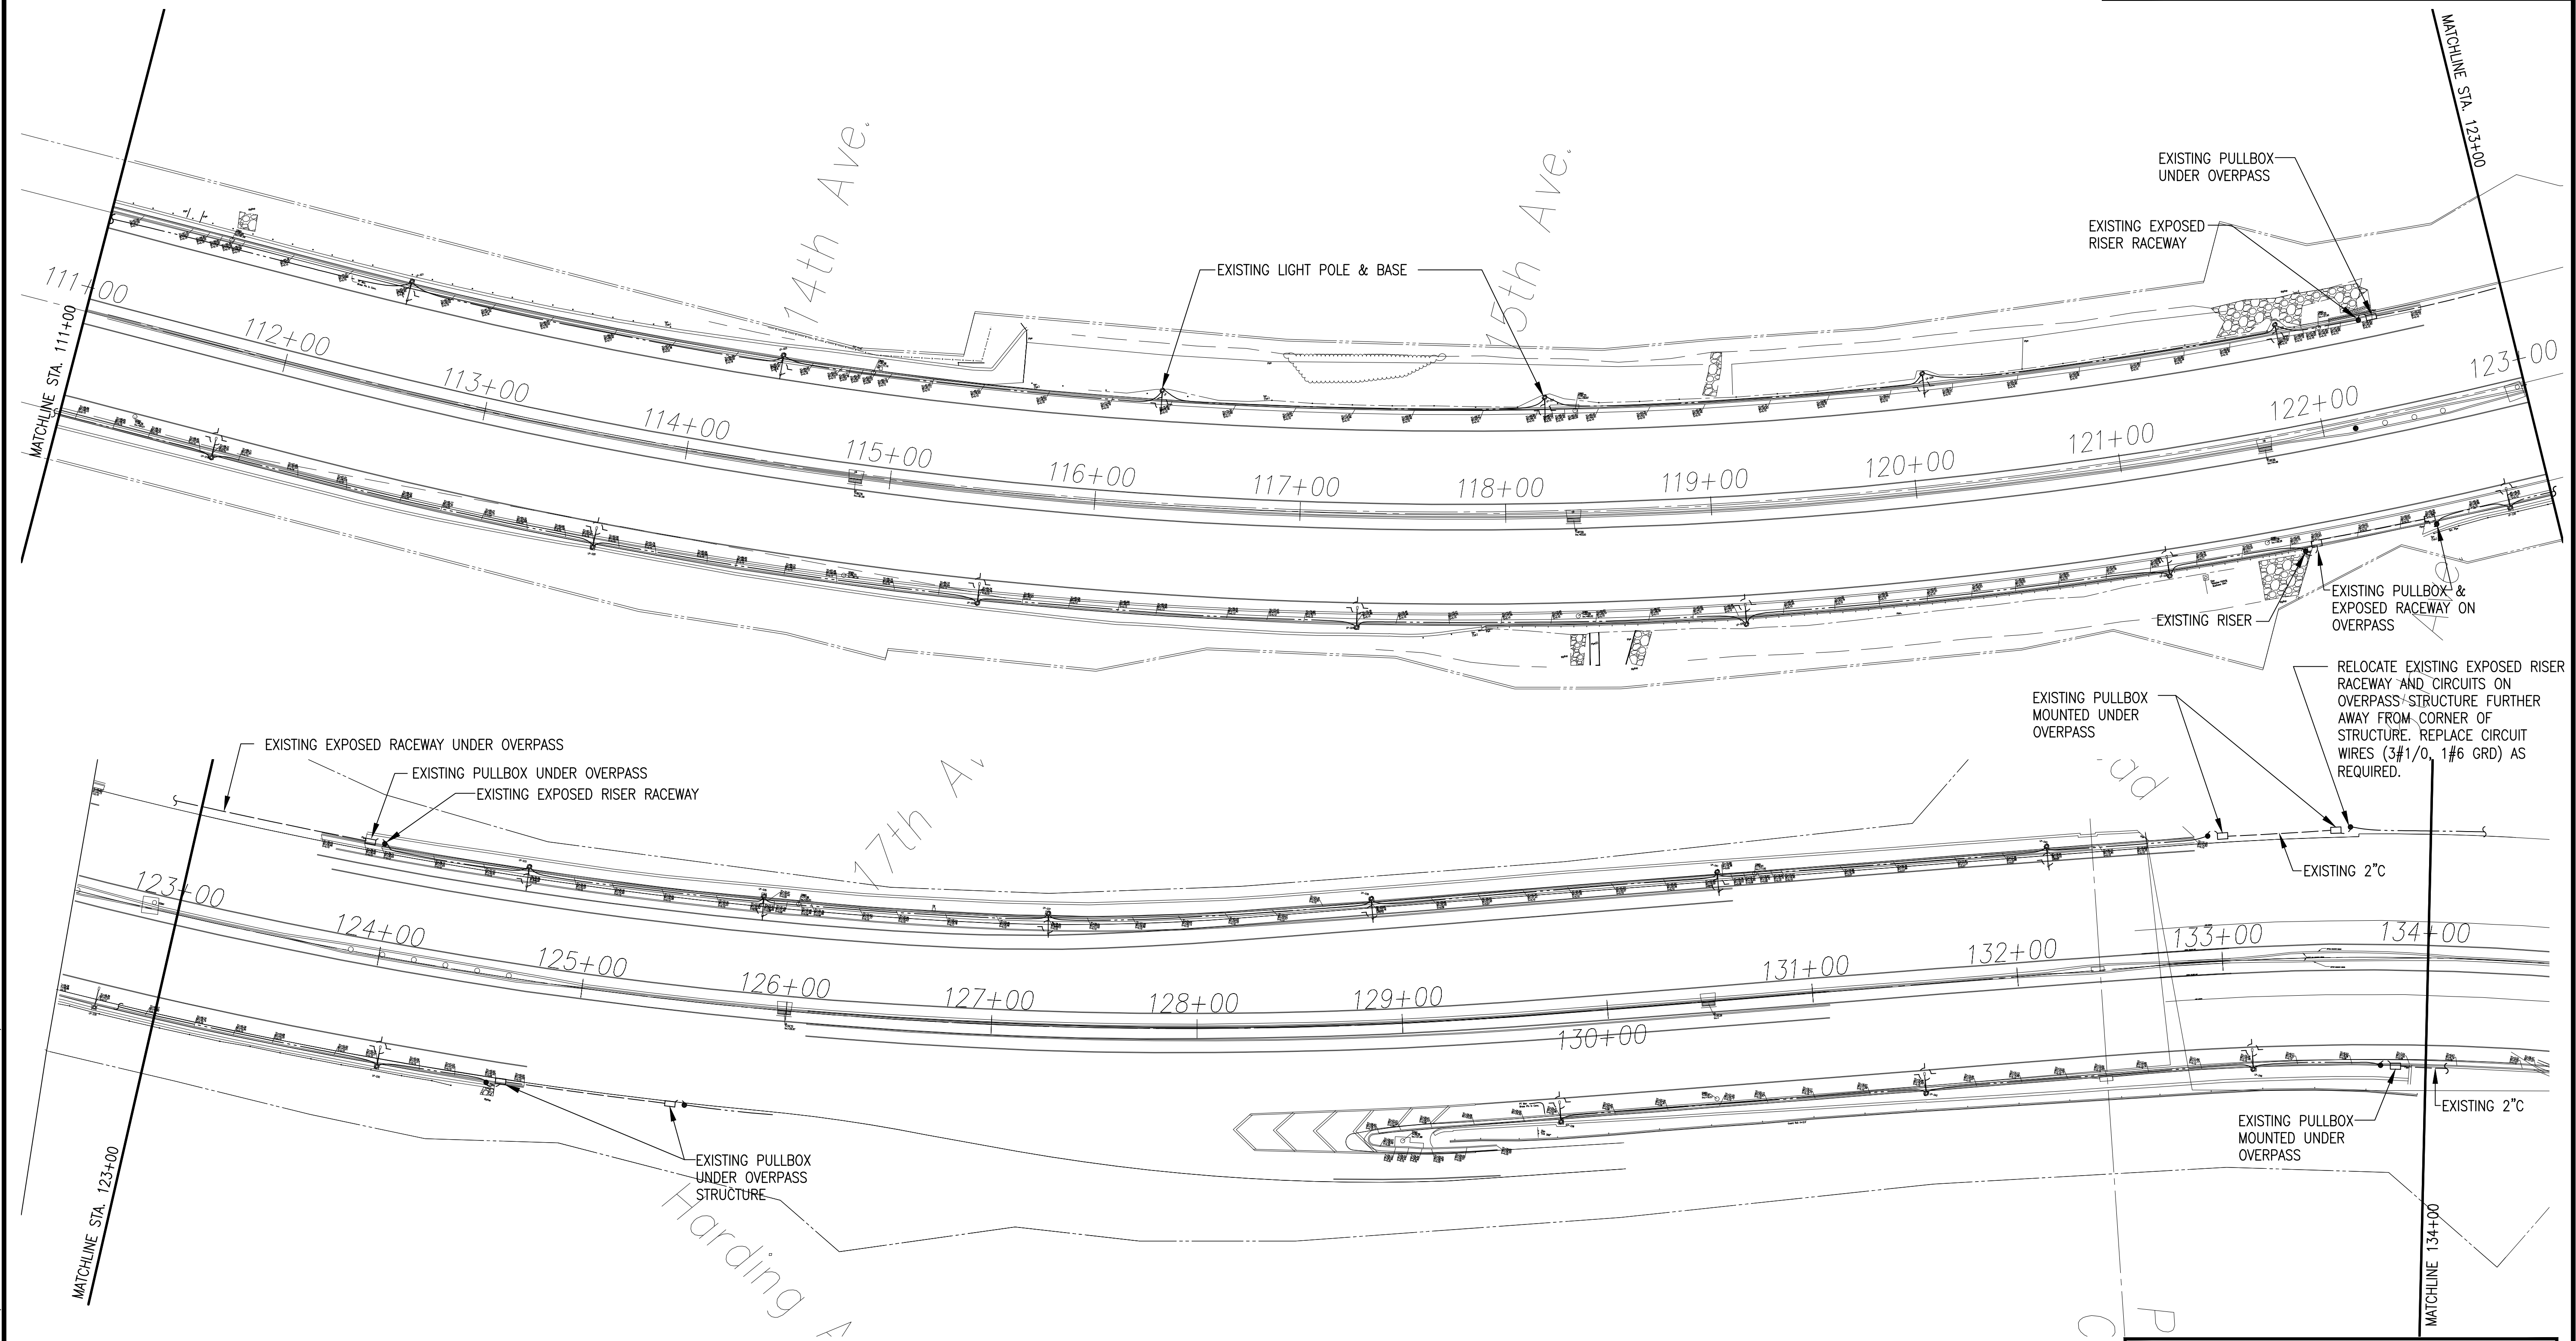

PARTIAL ELECTRICAL PLAN
SCALE: 1" = 40' - 0"

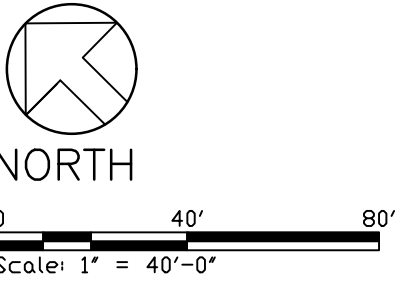

Albert Chong Associates Inc.
Consulting Electrical Engineers
and Lighting Designers
1117 Kapiolani Avenue
Honolulu, Hawaii 96816
Telephone (808) 738-5355

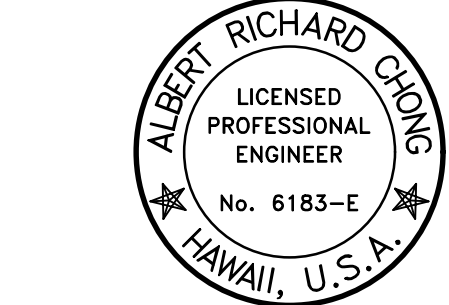

THIS WORK WAS PREPARED BY ME
OR UNDER MY SUPERVISION AND THE
CONSTRUCTION OF THIS PROJECT
WILL BE UNDER MY OBSERVATION.
APRIL 30, 2022
LIC. EXP. DATE

STATE OF HAWAII
DEPARTMENT OF TRANSPORTATION
HIGHWAYS DIVISION

PARTIAL ELECTRICAL PLAN

INTERSTATE ROUTE H-1
Guardrail and Shoulder Improvements,
Kapiolani Interchange to Ainakoa Avenue
Federal-Aid Project No. IM-HI-1(244)R
Scale: As Shown Date: July 2018

SHEET No. **E3** OF **3** SHEETS

ORIGINAL PLAN	SURVEY PLOTTED BY	DATE
	DESIGNED BY	
	QUANTITIES BY	
	CHECKED BY	
NOTE BOOK No.		

DRAWING NAME: \\ACA-DC1\CARBIE\H-1 GUARDRAIL\H1-E0003.DWG PLOT TIME: 11-15-21, 1:21 PM