



FED. ROAD DIST. NO.	STATE	FED. AID PROJ. NO.	FISCAL YEAR	SHEET NO.	TOTAL SHEETS
HAWAII	HAW.	I-H-1(85)	1970	9	35

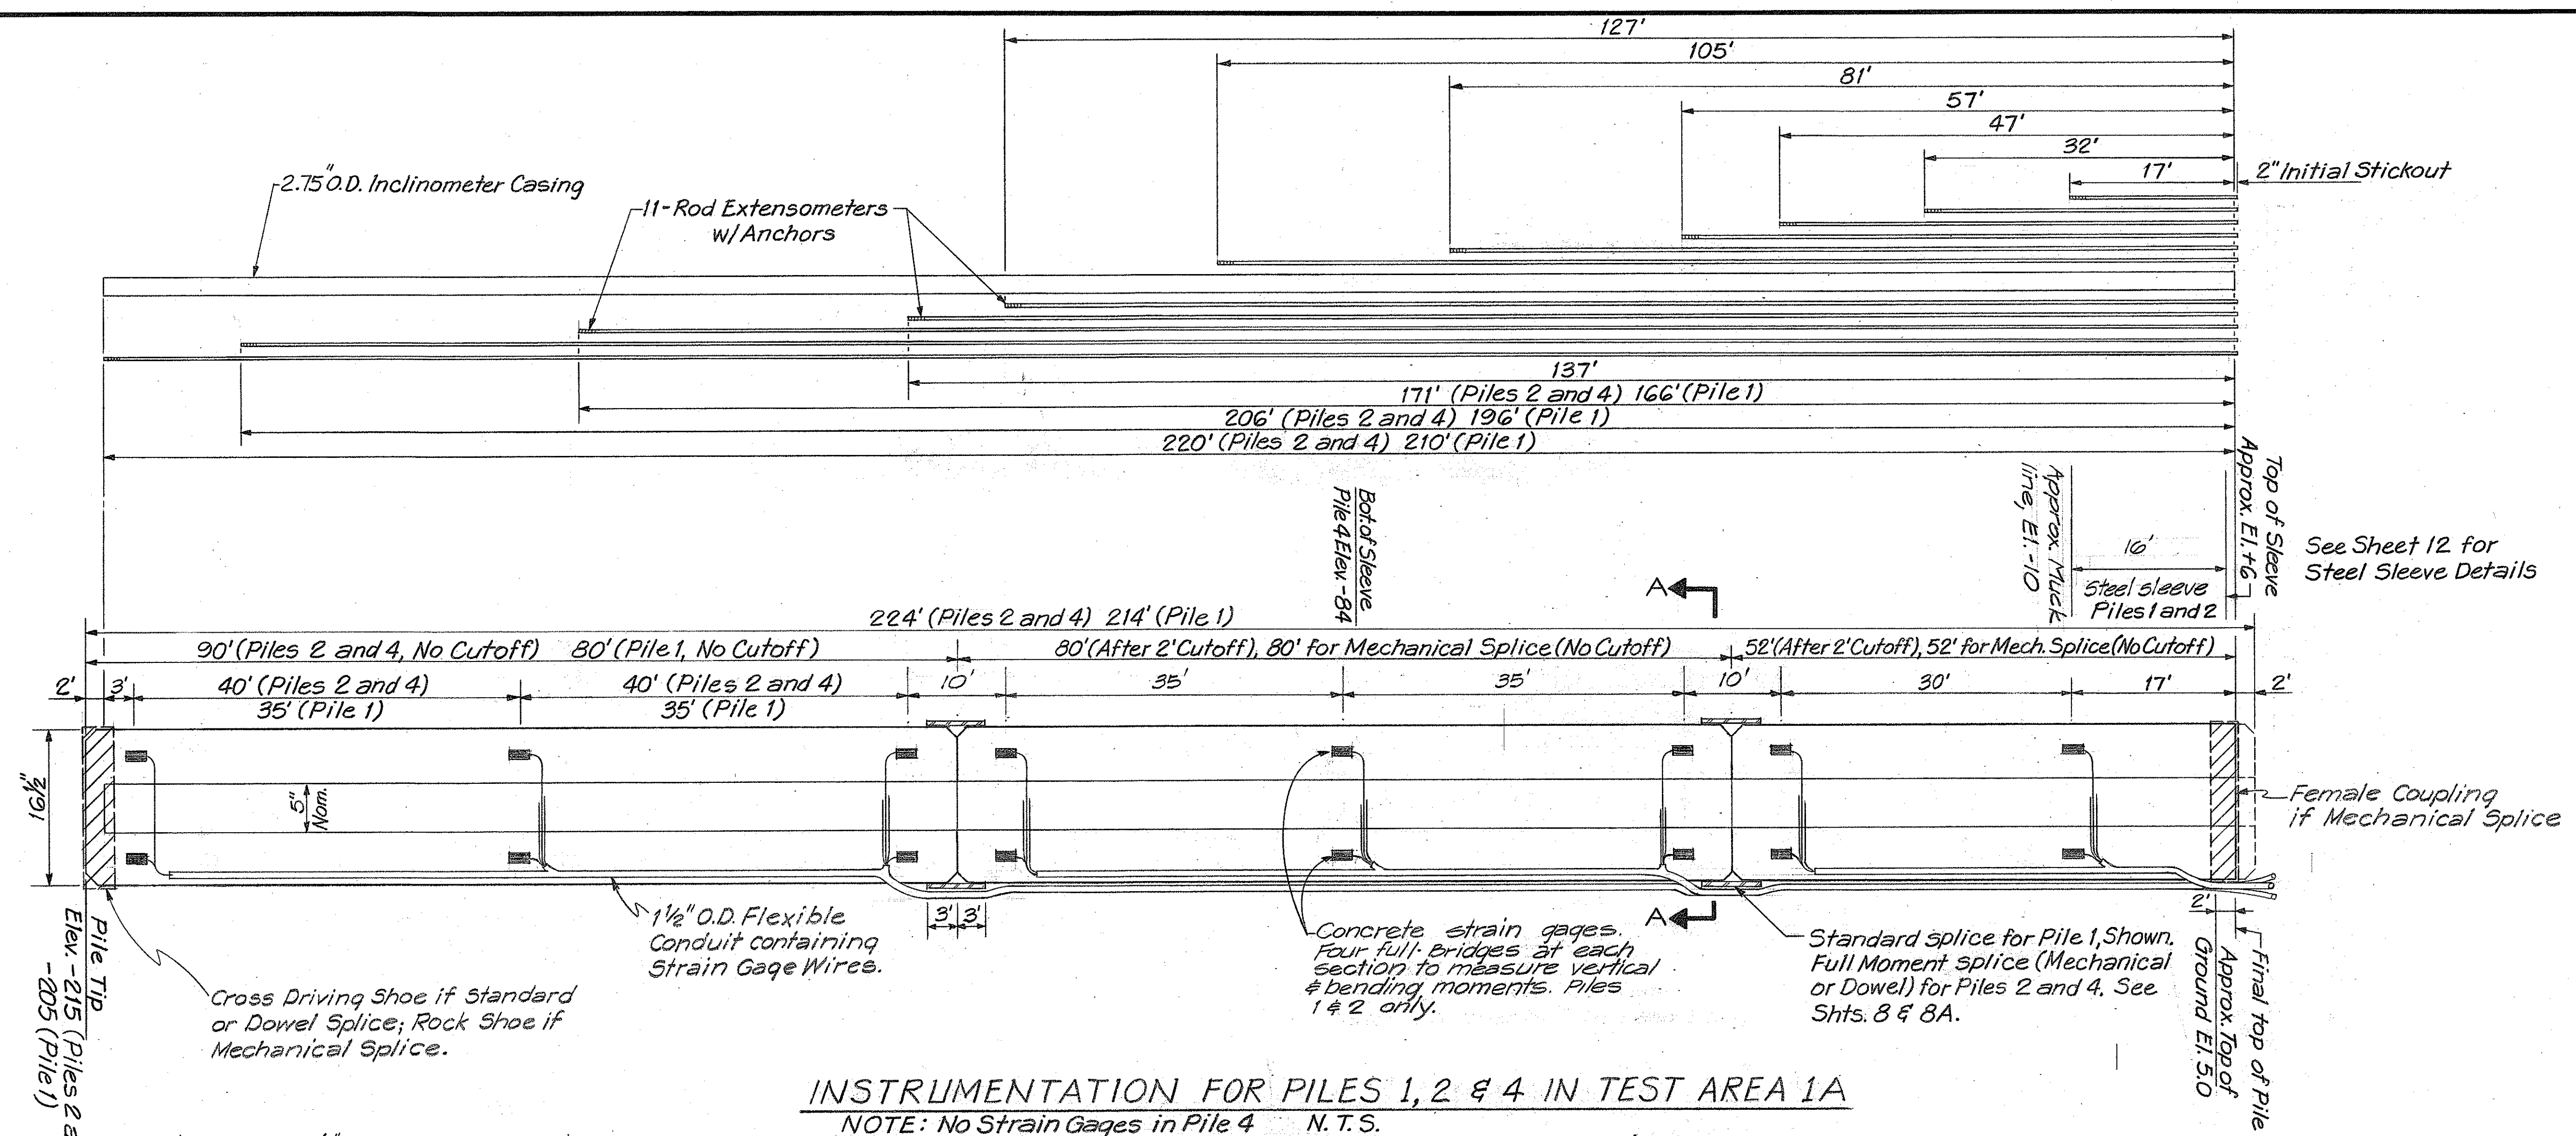


INSTRUMENTATION FOR PILES 1, 2 & 4 IN TEST AREA 1A
 NOTE: No Strain Gages in Pile 4 N.T.S.

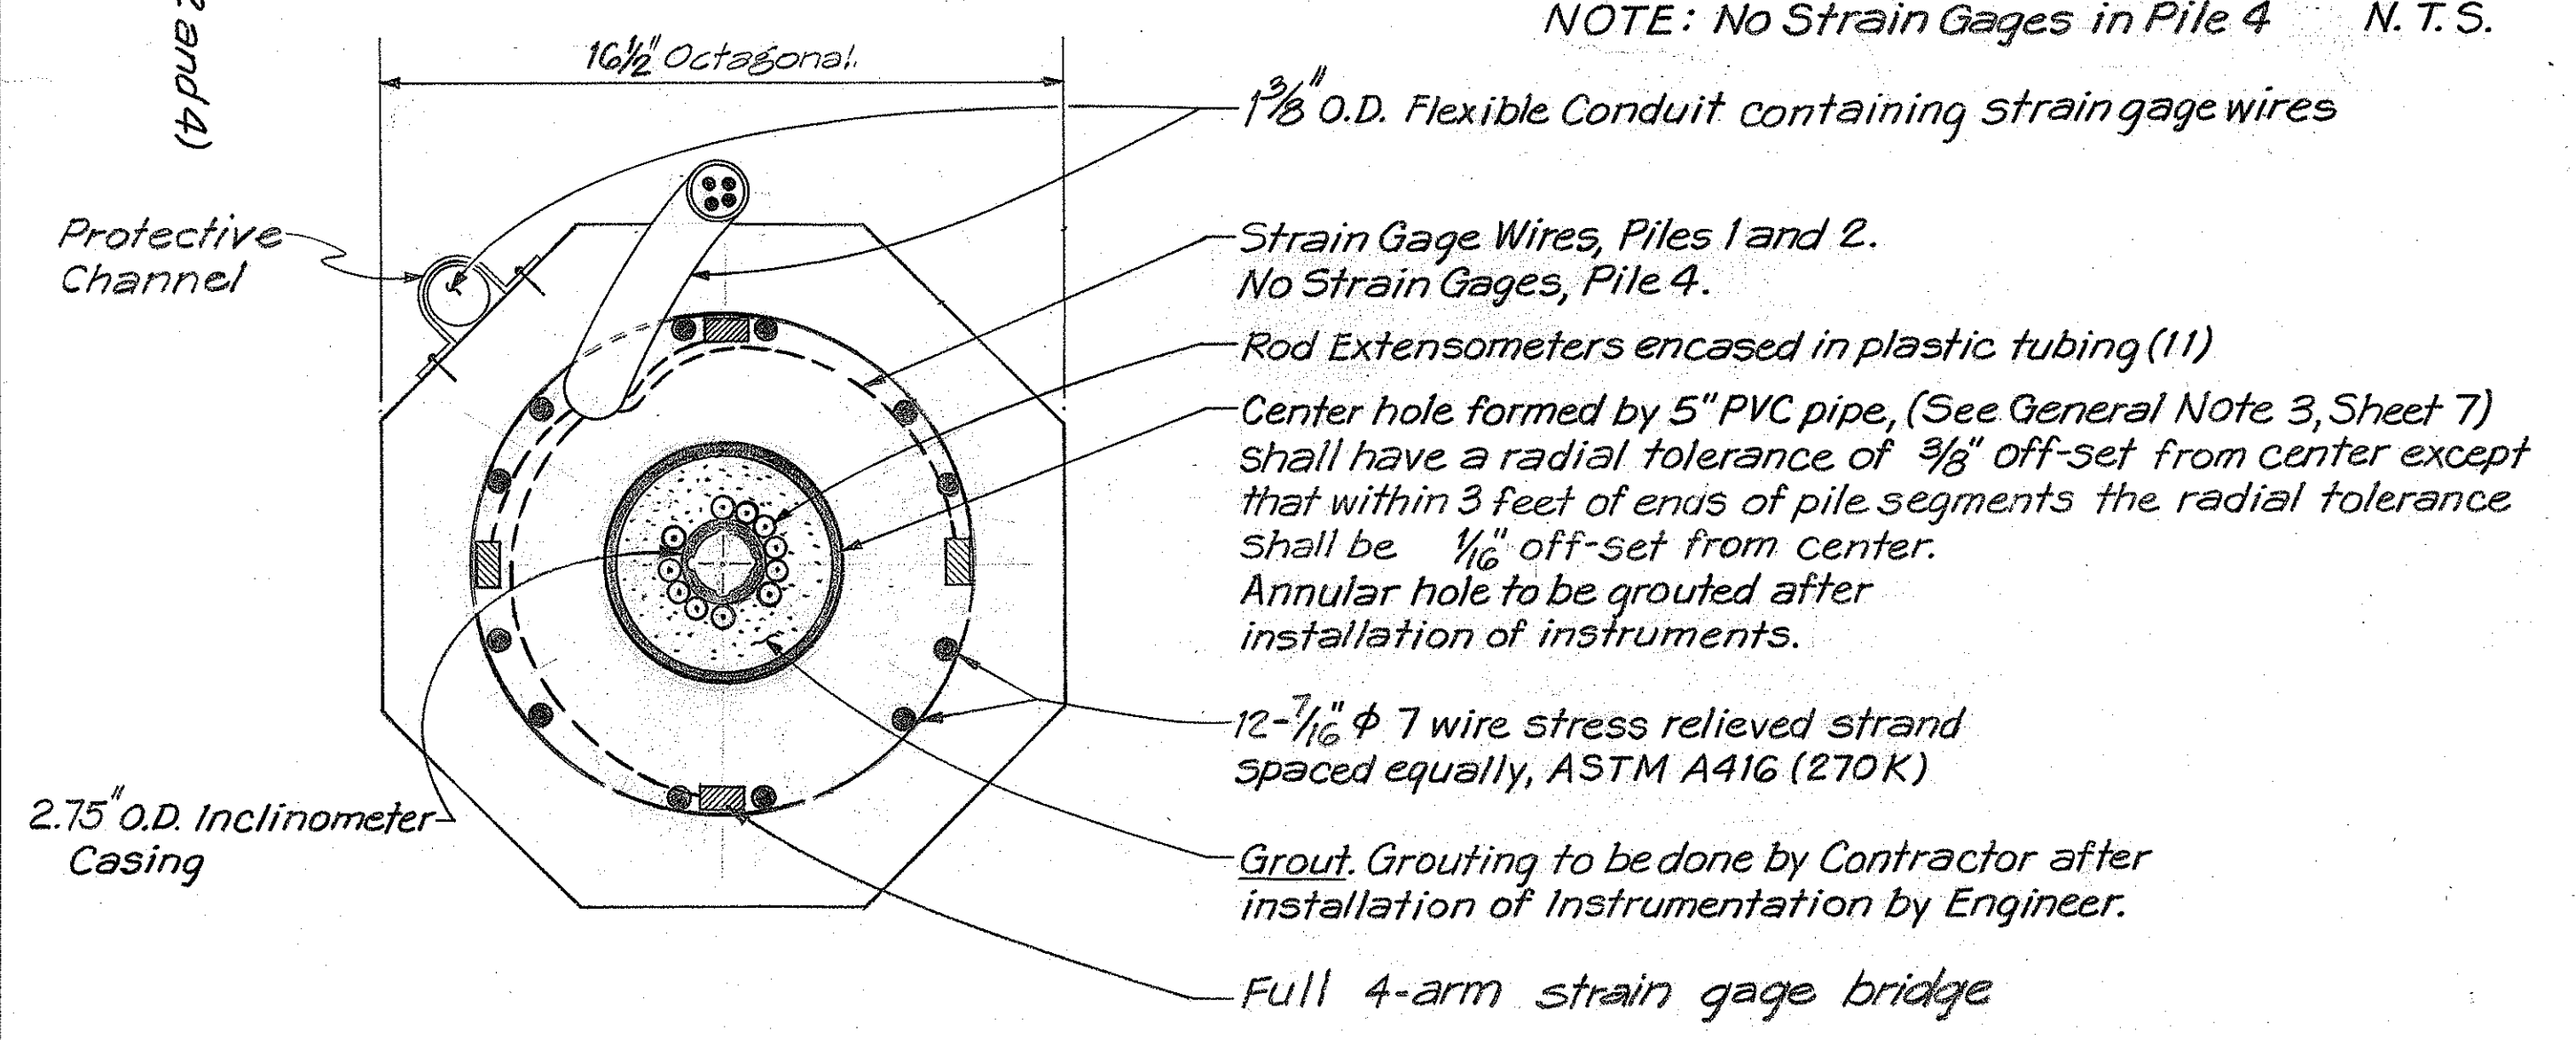

SECTION A-A
 Scale: 3"=1'-0"

Instruments Installed During Casting of Pile: Strain Gauges, See Sheet 20, Sequence of Operations.
 Instruments Installed After Driving of Pile: Inclinator Casing
 Rod Extensometers

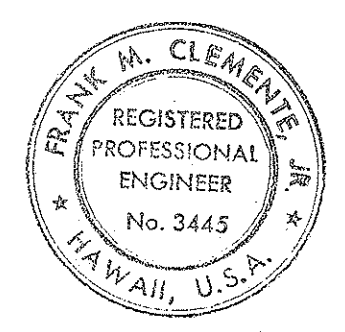

THIS WORK WAS PREPARED BY
 ME OR UNDER MY SUPERVISION.
Frank M. Clemente

STATE OF HAWAII
DEPARTMENT OF TRANSPORTATION
HIGHWAYS DIVISION
KEEHI INTERCHANGE
FIELD TESTING PROGRAM

**PILE INSTRUMENTATION
PILES 1, 2 AND 4**
INTERSTATE ROUTE H-1
PROJECT NO. I-H-1(85)
SCALE: AS SHOWN DATE: 9/31/70
SHEET No. 9 OF 35 SHEETS

SURVEY PLOTTED BY	DATE
DESIGNED BY	
QUANTITIES BY	
CHECKED BY	
ORIGINAL PLAN	
NOTE BOOK	
No.	

