



INDEX TO DRAWINGS	
SHEET NO.	DESCRIPTION
1	TITLE SHEET
2	STANDARD PLANS SUMMARY
3-13	NOTES & LEGENDS
14-16	BORING LOGS
17	GENERAL PLAN
18	EXISTING CONDITIONS
19-29	TYPICAL SECTIONS
30-36	ROADWAY PLAN & PROFILES
37-50	SITE DETAILS
51-58	GUARDRAIL DETAILS
59-63	DEMOLITION PLANS
64-69	EROSION CONTROL PLANS & DETAILS
70-76	GRADING PLANS
77-80	SUPERELEVATION PLANS
81-93	DRAINAGE PLAN & PROFILES
93-98	UTILITY PLAN & PROFILES
99-100	RETAINING WALL PROFILES
101-105	SIGNAGE & STRIPING PLANS
106-118	TRAFFIC CONTROL PLANS
119	LANDSCAPE PLANS
120-136	STRUCTURAL PLANS
137-167	ELECTRICAL PLANS

STATE OF HAWAII
DEPARTMENT OF TRANSPORTATION
HIGHWAYS DIVISION
HONOLULU, HAWAII

PLANS FOR
INTERSTATE ROUTE H-1
ADDITION AND MODIFICATION
OF FREEWAY ACCESS
(KAPOLEI INTERCHANGE COMPLEX), PHASE 3
FEDERAL-AID PROJECT NO. NH-H1-1(271)

DISTRICT OF EWA
ISLAND OF OAHU

FED. ROAD DIST. NO.	STATE	FED. AID PROJ. NO.	FISCAL YEAR	SHEET NO.	TOTAL SHEETS
HAWAII	HAW.	NH-H1-1(271)	2022	1	167

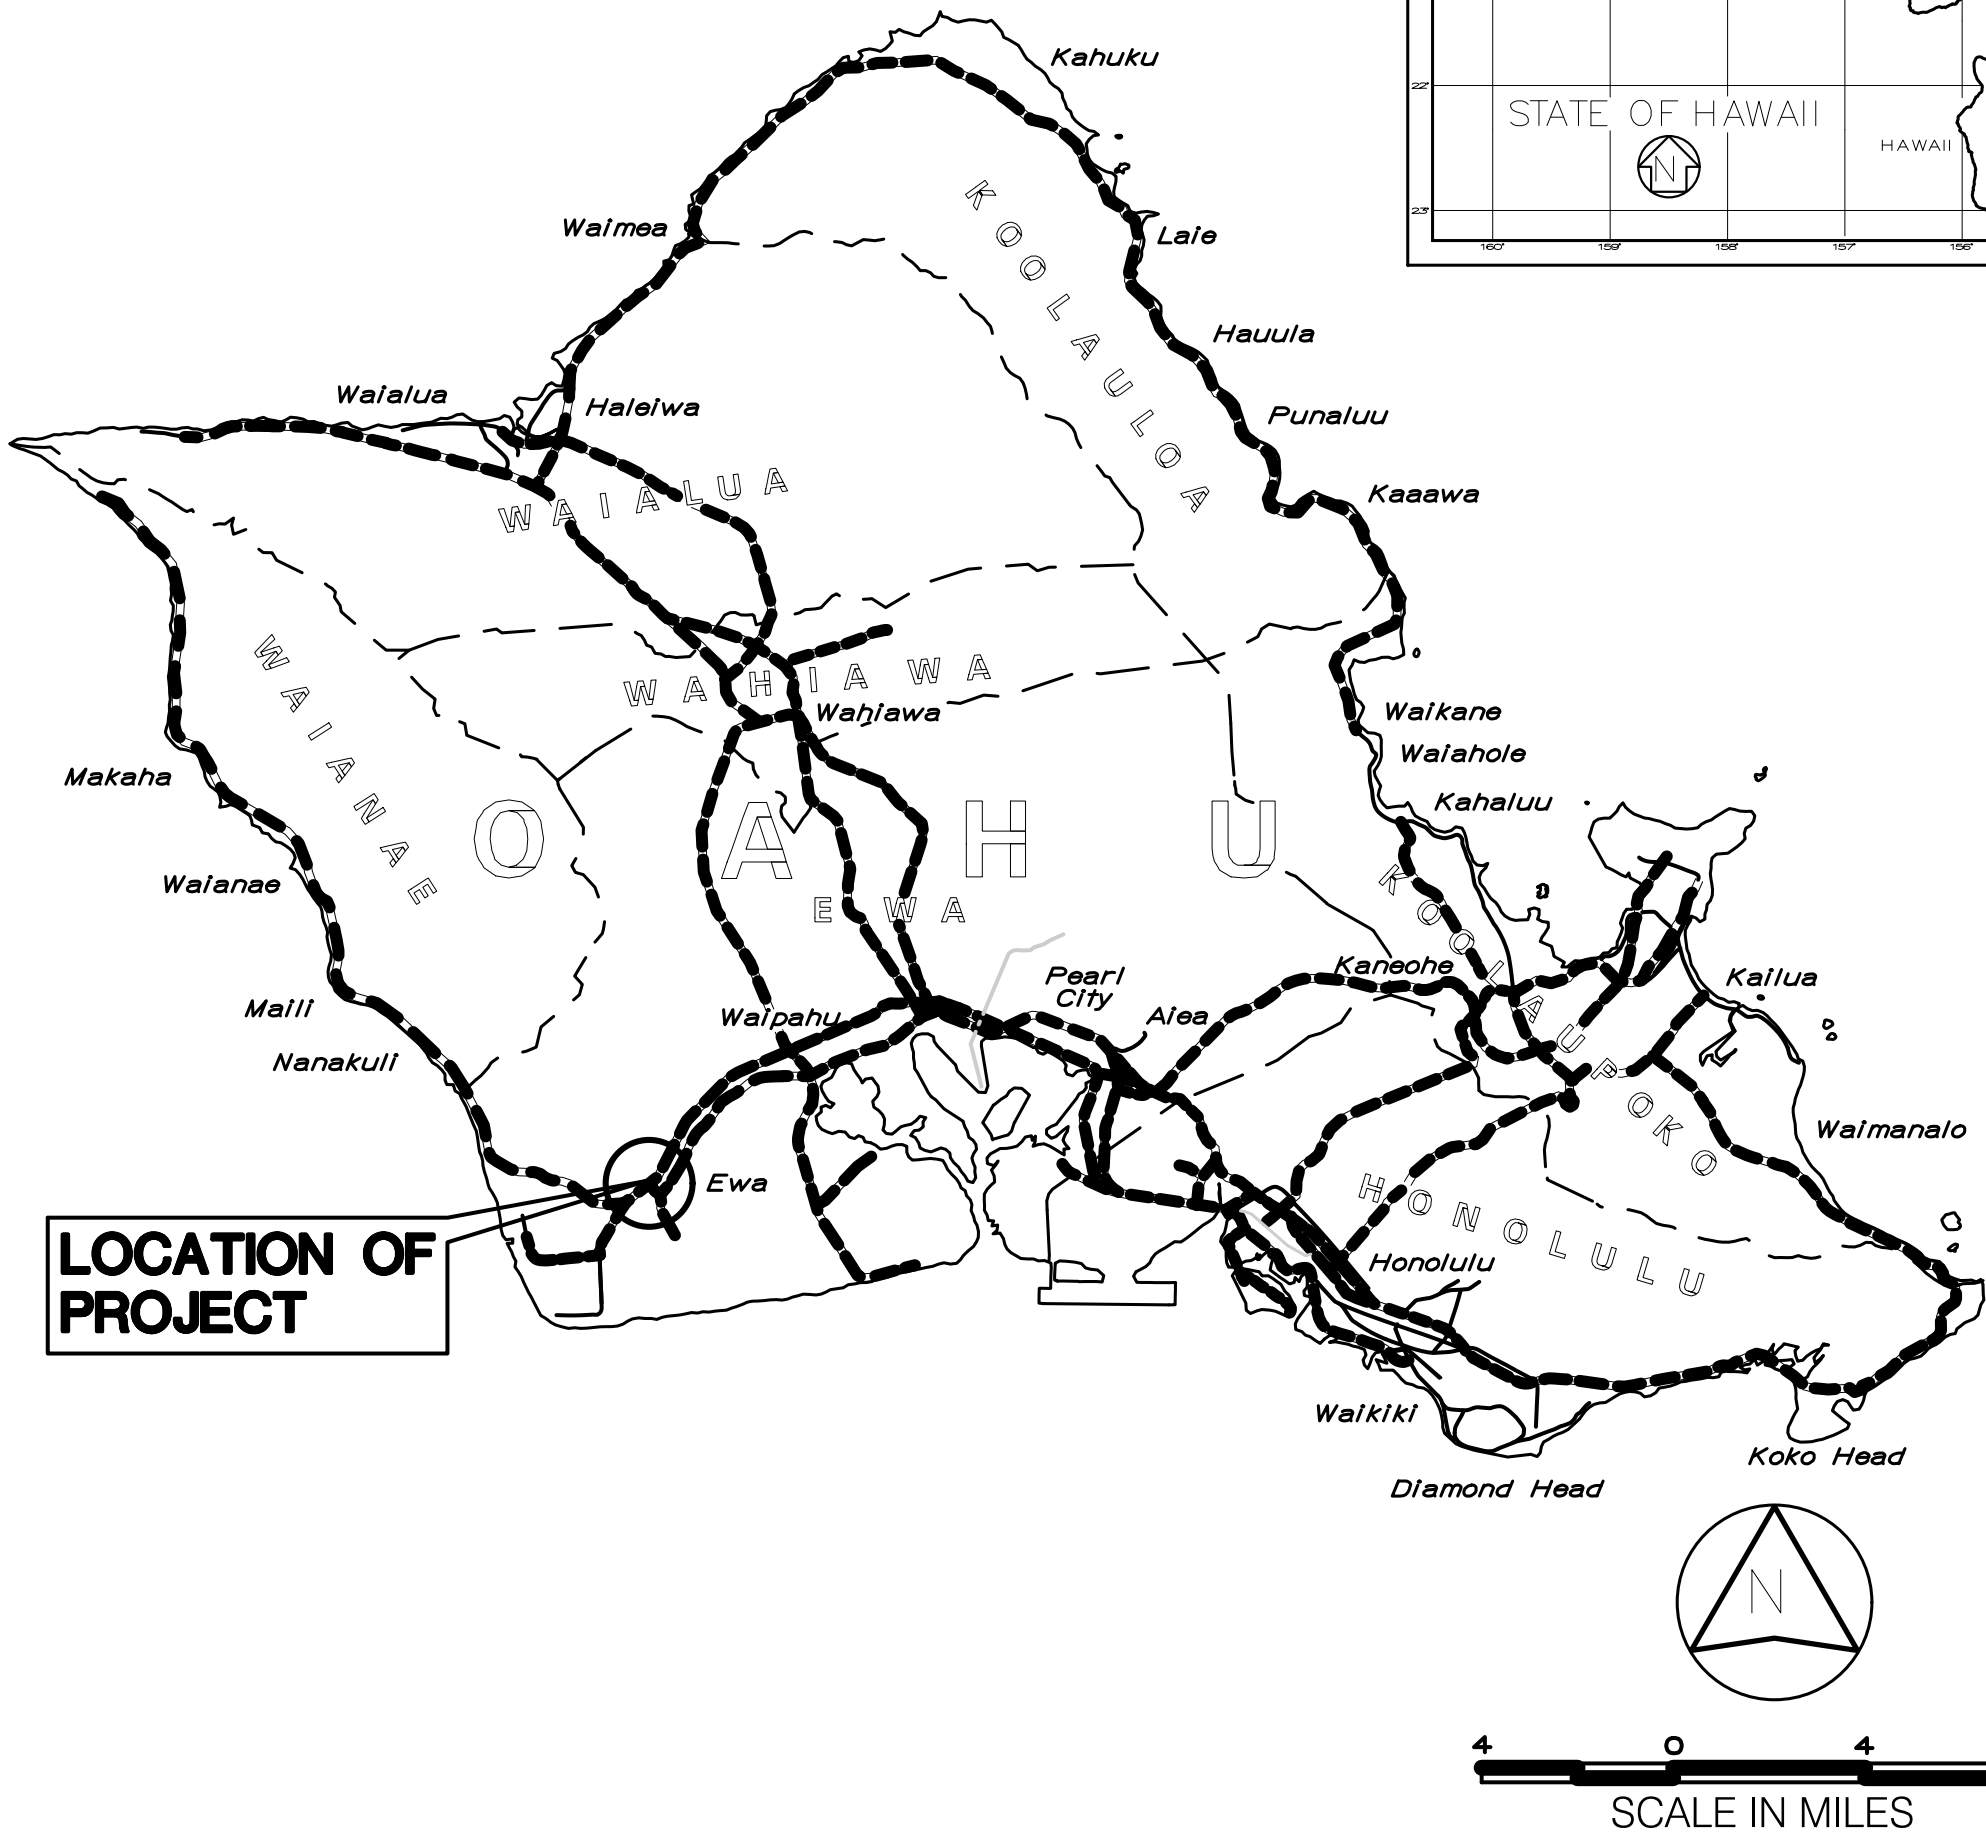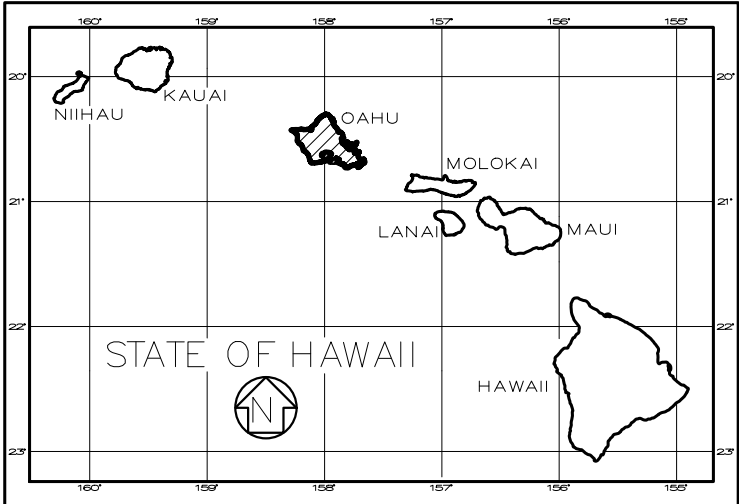

LOCATION OF PROJECT



----- FEDERAL AID PROJECTS PREVIOUSLY CONSTRUCTED OR UNDER CONSTRUCTION

H-1 MILE POST 0.0 TO MILE POST 0.8
FARRINGTON HWY MILE POST 0.0 TO MILE POST 1.8

DESIGN DESIGNATION

NORTH/SOUTH BOUND HARBOR ACCESS ROAD

CURRENT ADT (2016)	3,401
DESIGN ADT (2066)	27,244
DHV	1,435
D	50%
T	10%
T24	17%
V	40 M.P.H.


INSTERTATE H-1 MP 0.00 - 0.80

CURRENT ADT (2020)	72,000
DESIGN ADT (2040)	99,200
DHV	7,930
D	55/45
T	6%
T24	7%
V	45 M.P.H.


FARRINGTON HIGHWAY MP 0.00 - 1.80

CURRENT ADT (2020)	61,100
DESIGN ADT (2040)	70,800
DHV	5,660
D	60/40
T	5.5%
T24	6.5%
V	45 M.P.H.

 DEPARTMENT OF TRANSPORTATION
STATE OF HAWAII

APPROVED: 
Aug 25, 2022
DIR. OF TRANSPORTATION DATE

DATE 2022
PHONE 692-7570
HWY-DD
MANAGED BY
DESIGNED BY MITSUNAGA & ASSOC.

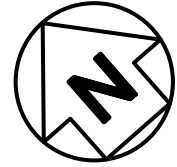

PROJECT LOCATION

NOT TO SCALE

