


FED. ROAD DIST. NO.	STATE	FEDERAL AID PROJ. NO.	FISCAL YEAR	SHEET NO.	TOTAL SHEETS
HAWAII	HAW.	IM-HI-1(245)	2005	141	183

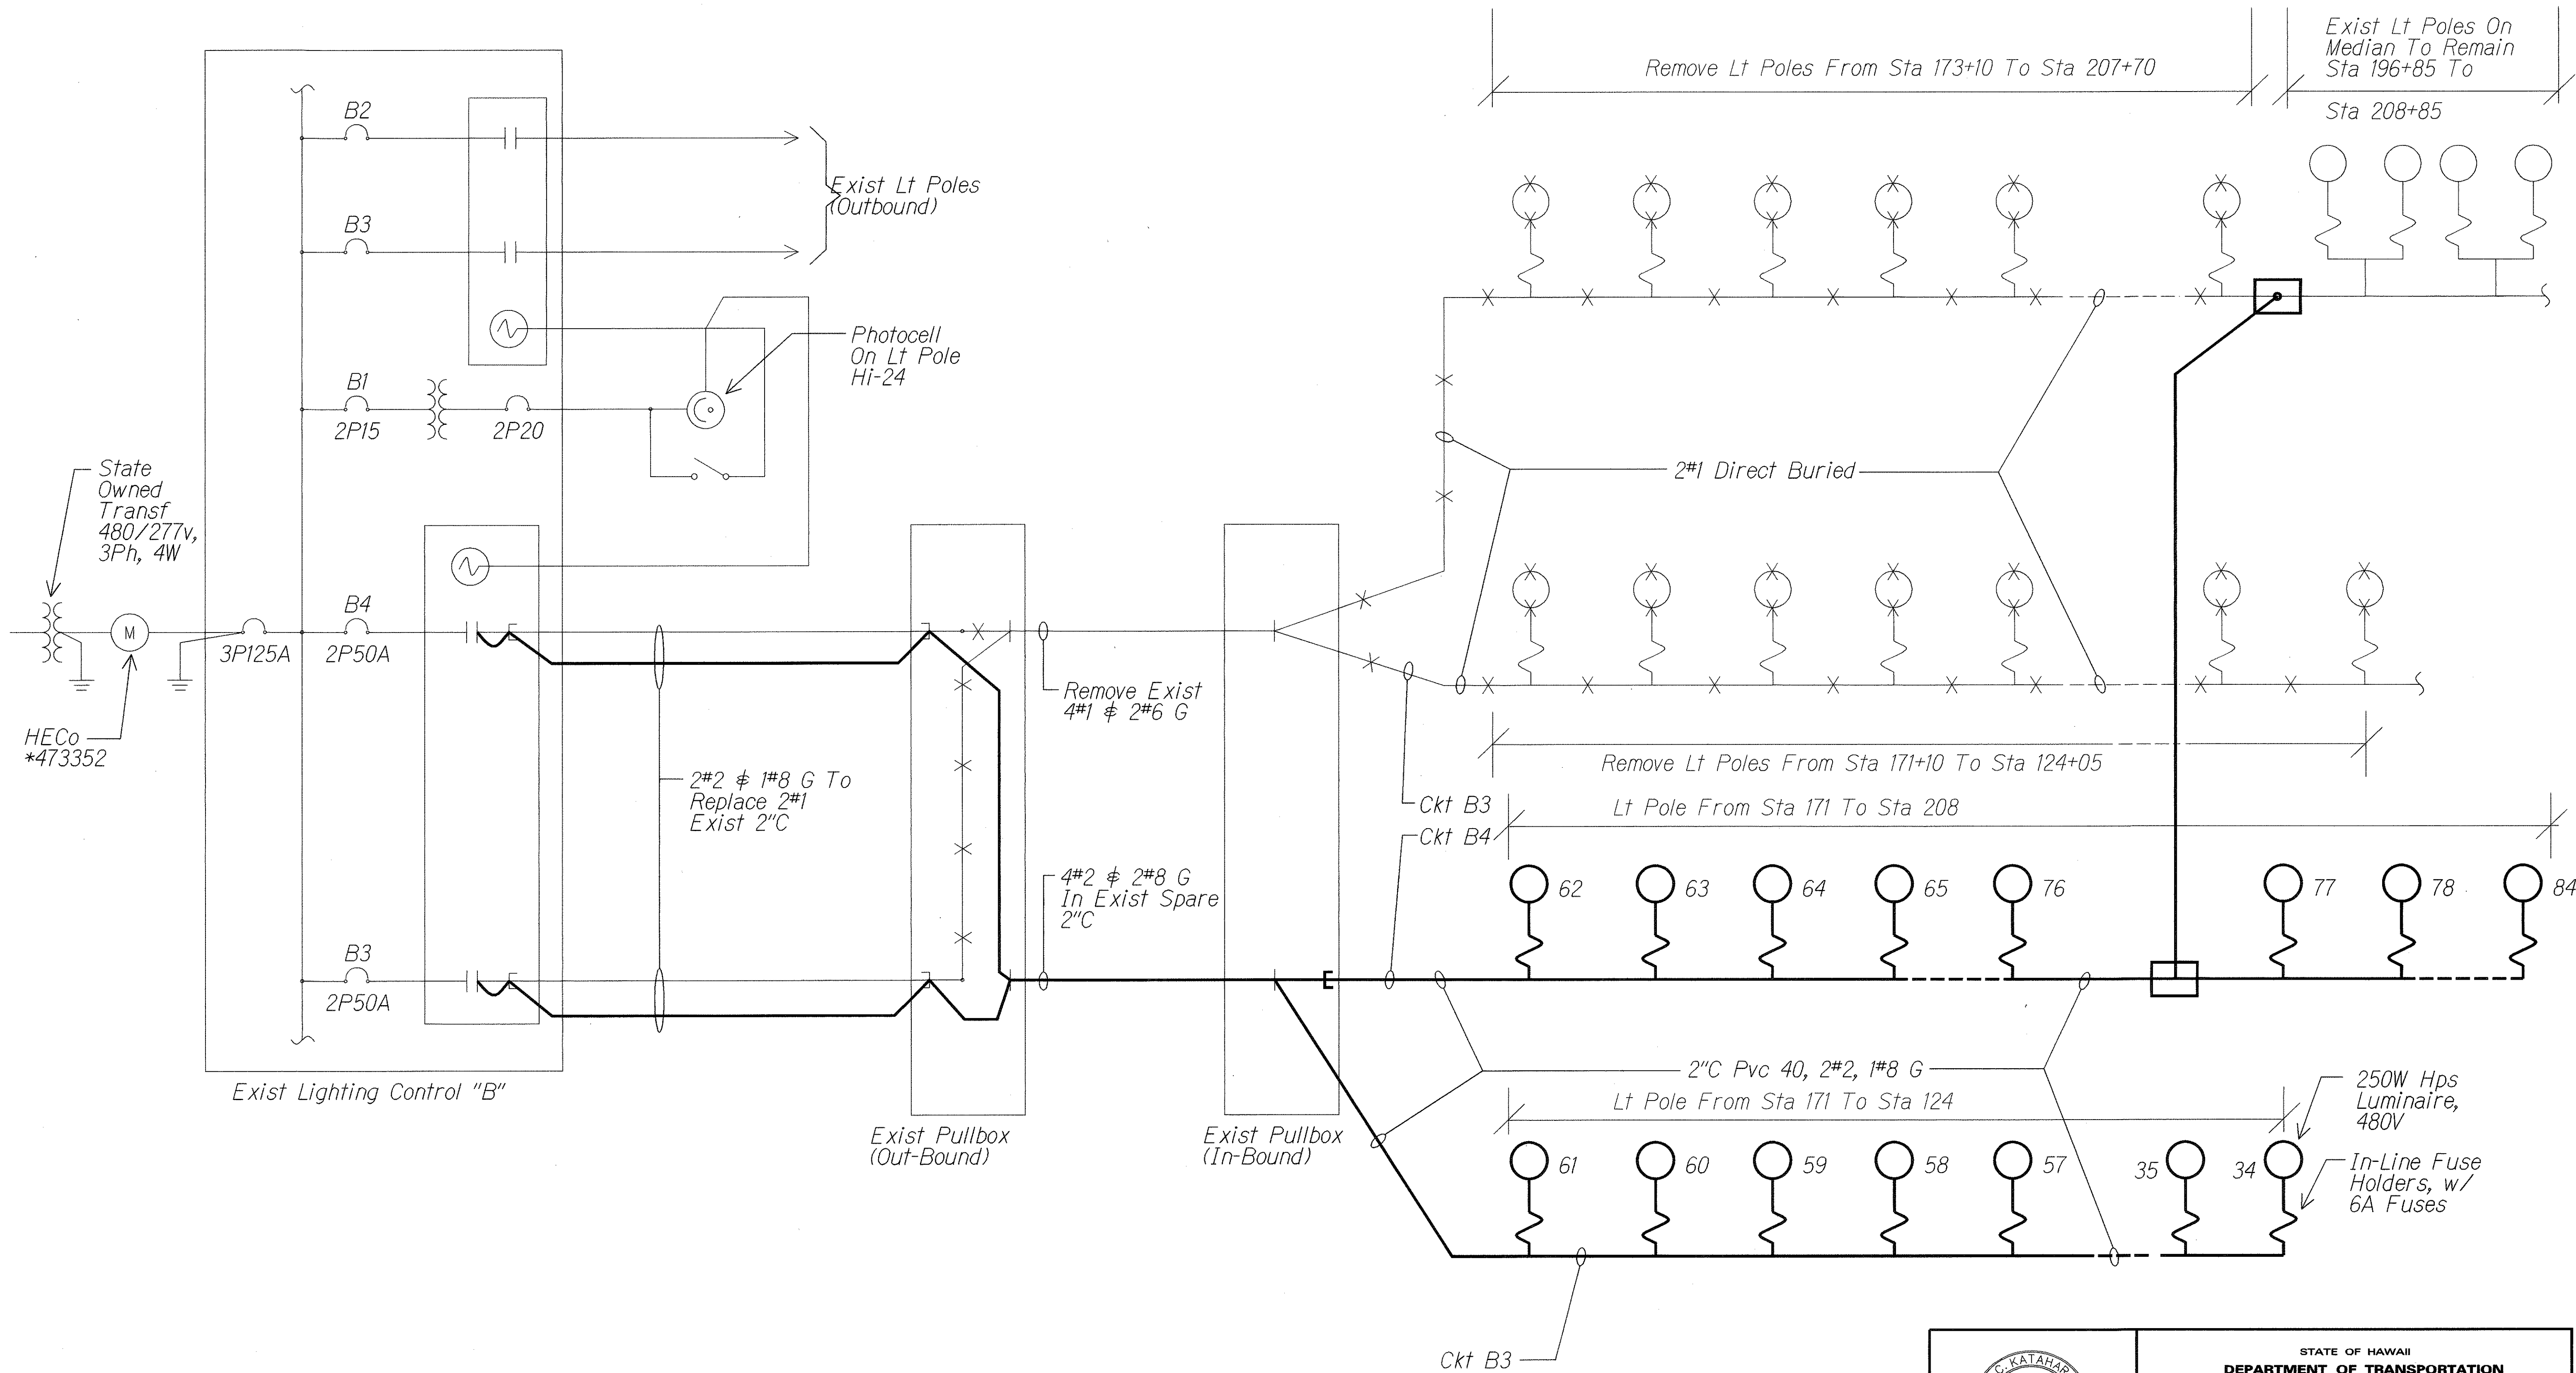

ONE-LINE DIAGRAM - B

No scale 03102-1L

Light Lines Denote Existing Items
Bold Lines Denote New


1/15/06
C. K. KAHARA
REGISTERED PROFESSIONAL ENGINEER
No. 3181-E
HAWAII, USA

STATE OF HAWAII
DEPARTMENT OF TRANSPORTATION
HIGHWAYS DIVISION
ONE-LINE DIAGRAM - B

INTERSTATE ROUTE H-1 REHABILITATION
EASTBOUND LANES
WAI'AU INTERCHANGE TO KAI'IAKANI STREET

Scale: No Scale Date: Jan. 24, 2006

FED. ROAD DIST. NO.	STATE	FEDERAL AID PROJ. NO.	FISCAL YEAR	SHEET NO.	TOTAL SHEETS
HAWAII	HAW.	IM-HI-1(245)	2005	142	183

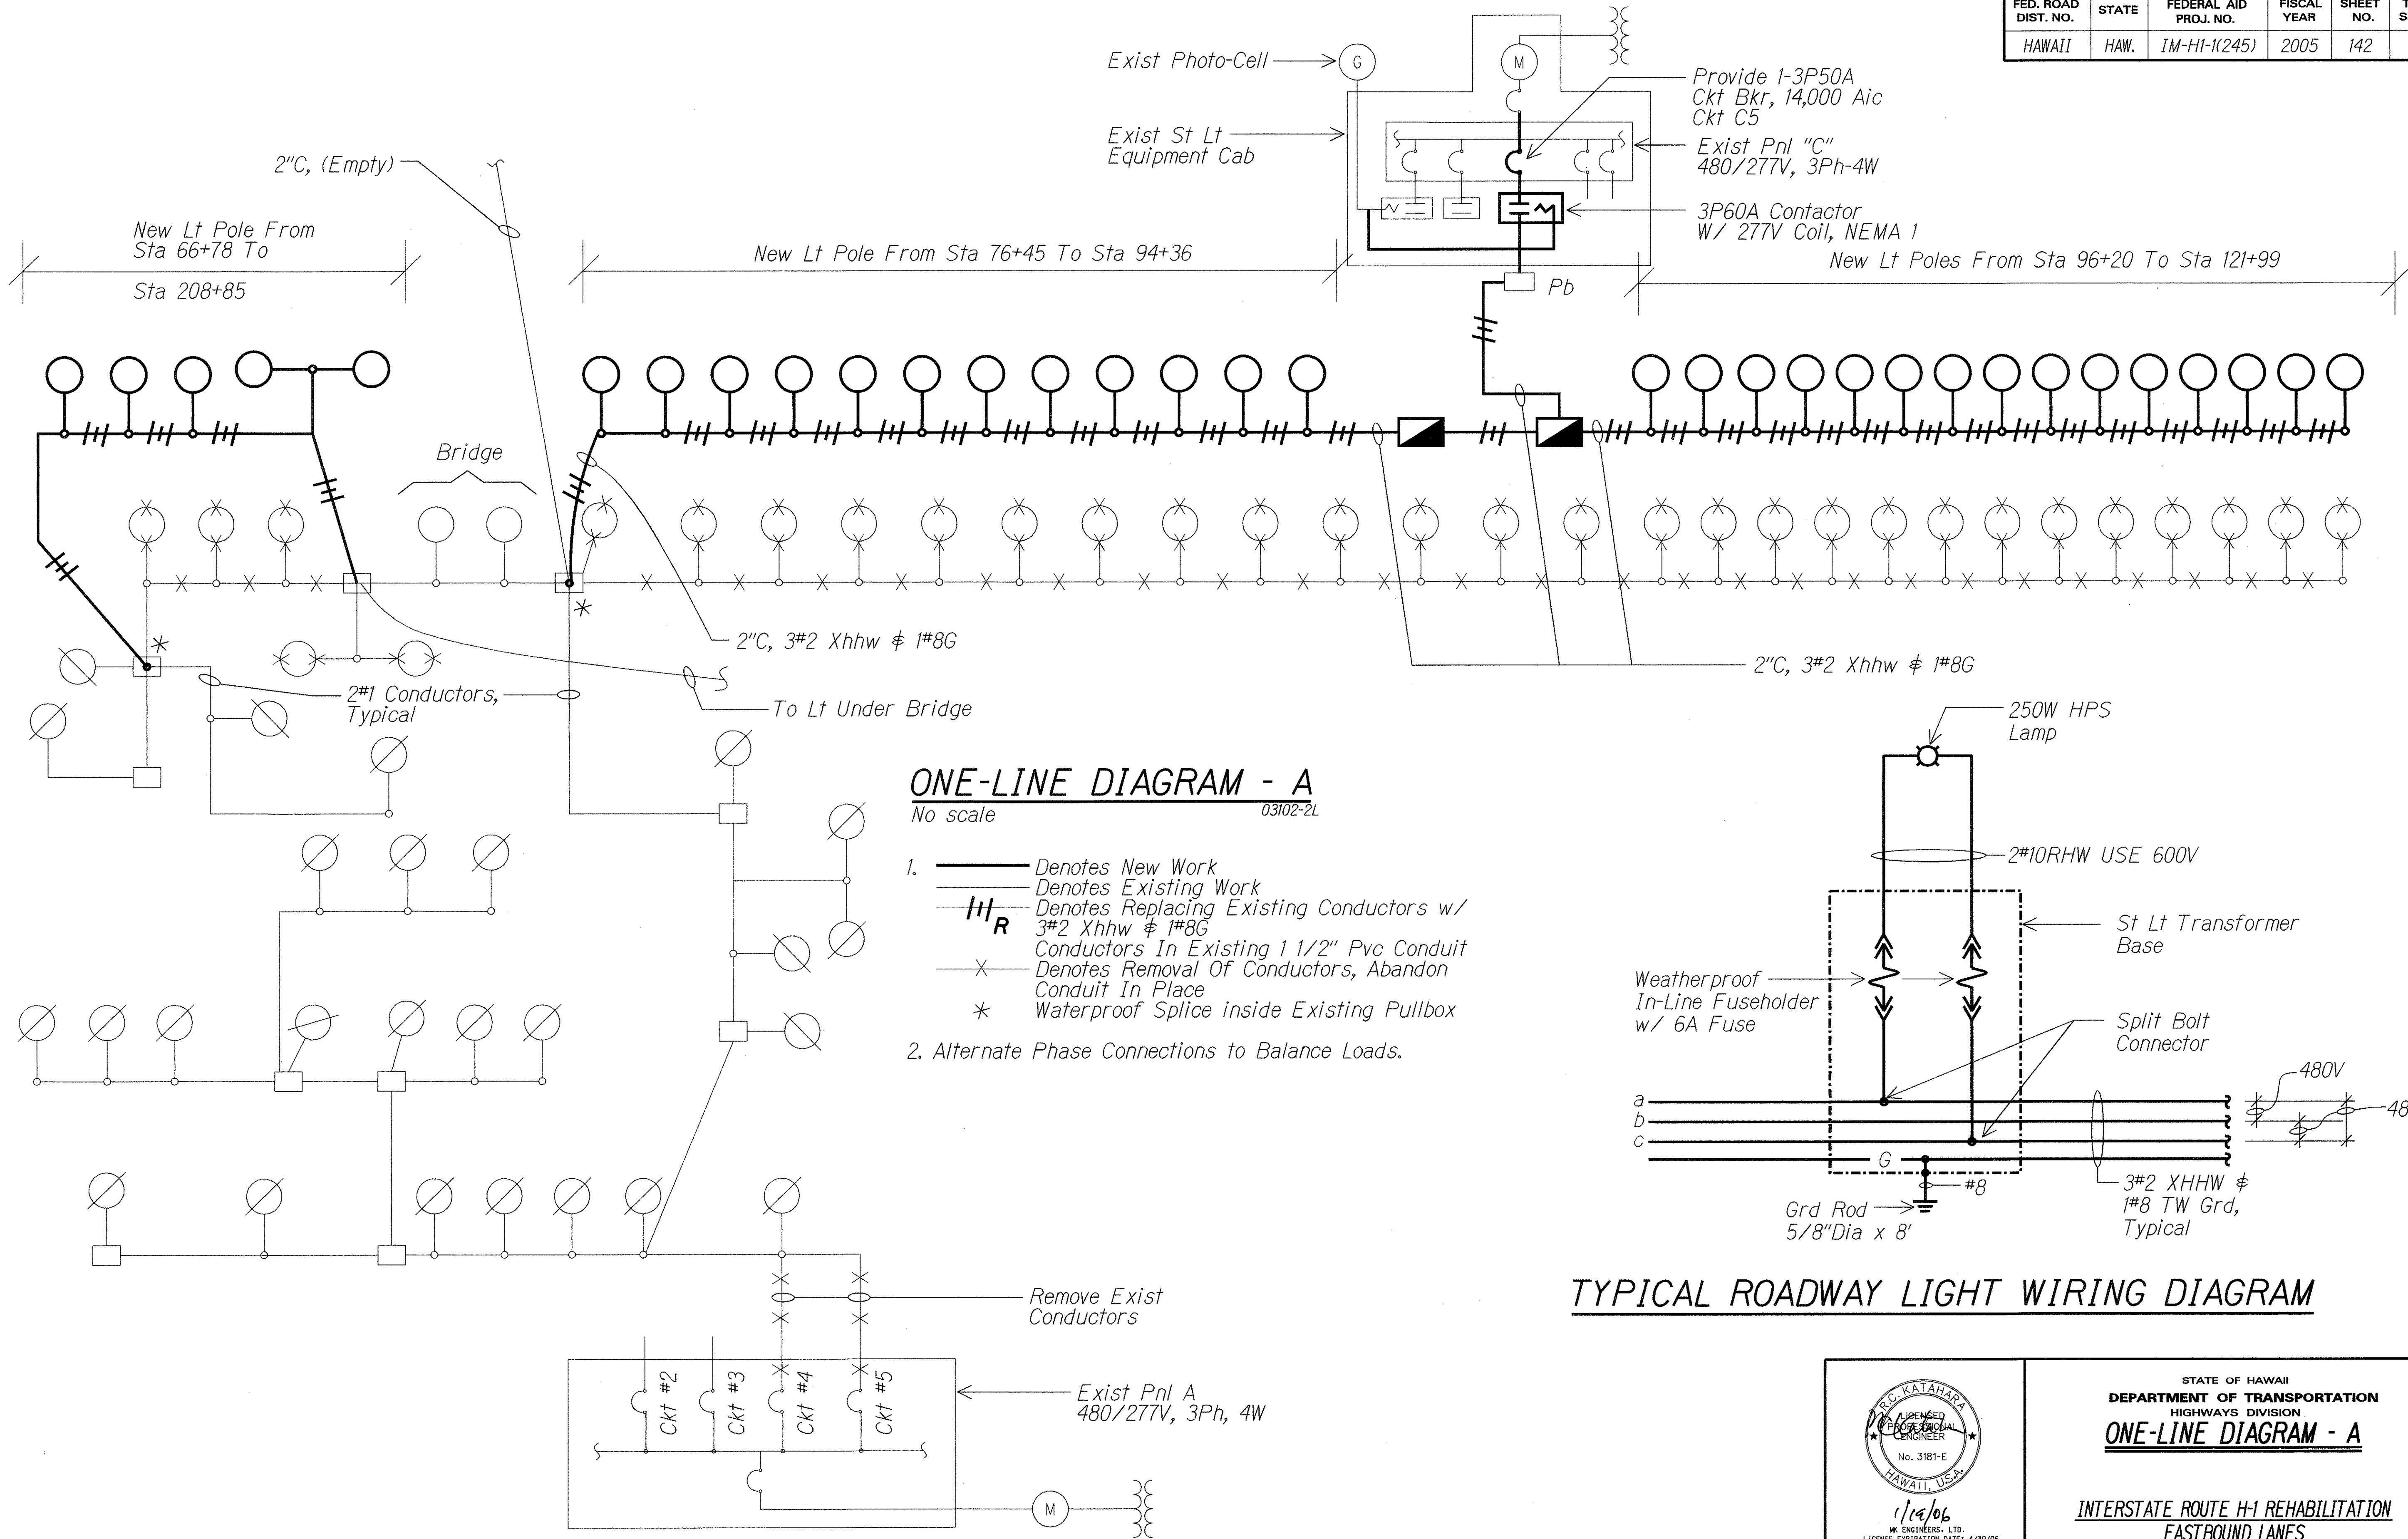

TYPICAL ROADWAY LIGHT WIRING DIAGRAM

1/14/06

WE ENGINEERS, LTD.

LICENSE EXPIRATION DATE: 4/30/06

THIS WORK WAS PREPARED BY ME OR UNDER MY SUPERVISION.

STATE OF HAWAII

DEPARTMENT OF TRANSPORTATION

HIGHWAYS DIVISION

ONE-LINE DIAGRAM - A

INTERSTATE ROUTE H-1 REHABILITATION

EASTBOUND LANES

WAI'AU INTERCHANGE TO KAIMAKANI STREET

Scale: No Scale Date: Jan. 24, 2006

SHEET No. E-15 OF 21 SHEETS