



FED. ROAD DIST. NO.	STATE	FED. AID PROJ. NO.	FISCAL YEAR	SHEET NO.	TOTAL SHEETS
HAWAII	HAW.	I-H1-1(136)17	1976	81	124

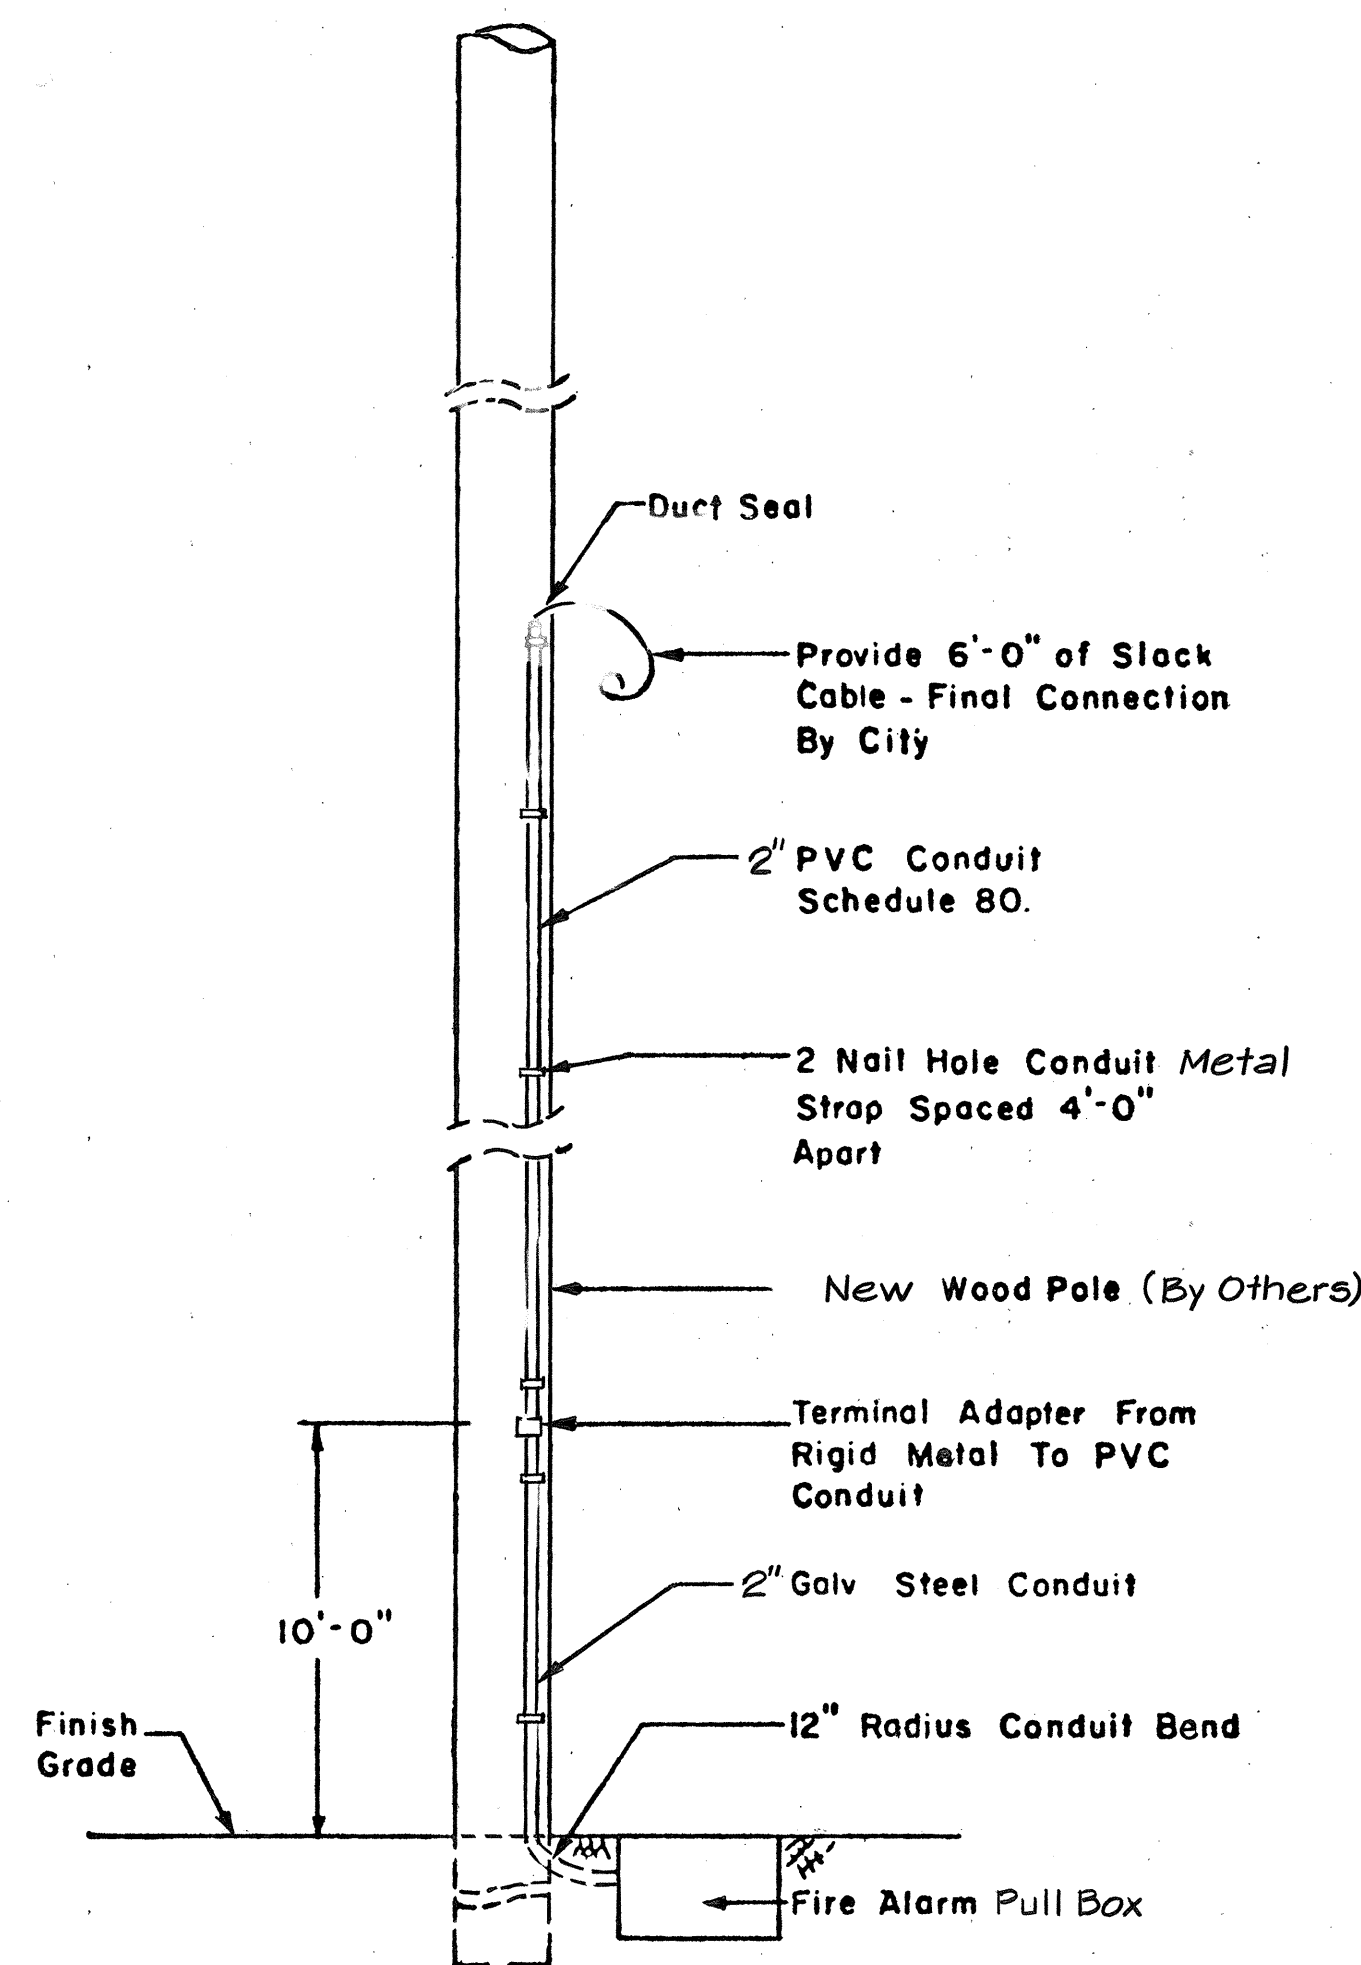


FIRE ALARM CONDUIT RISER DETAIL
(JP-1)
N.T.S.

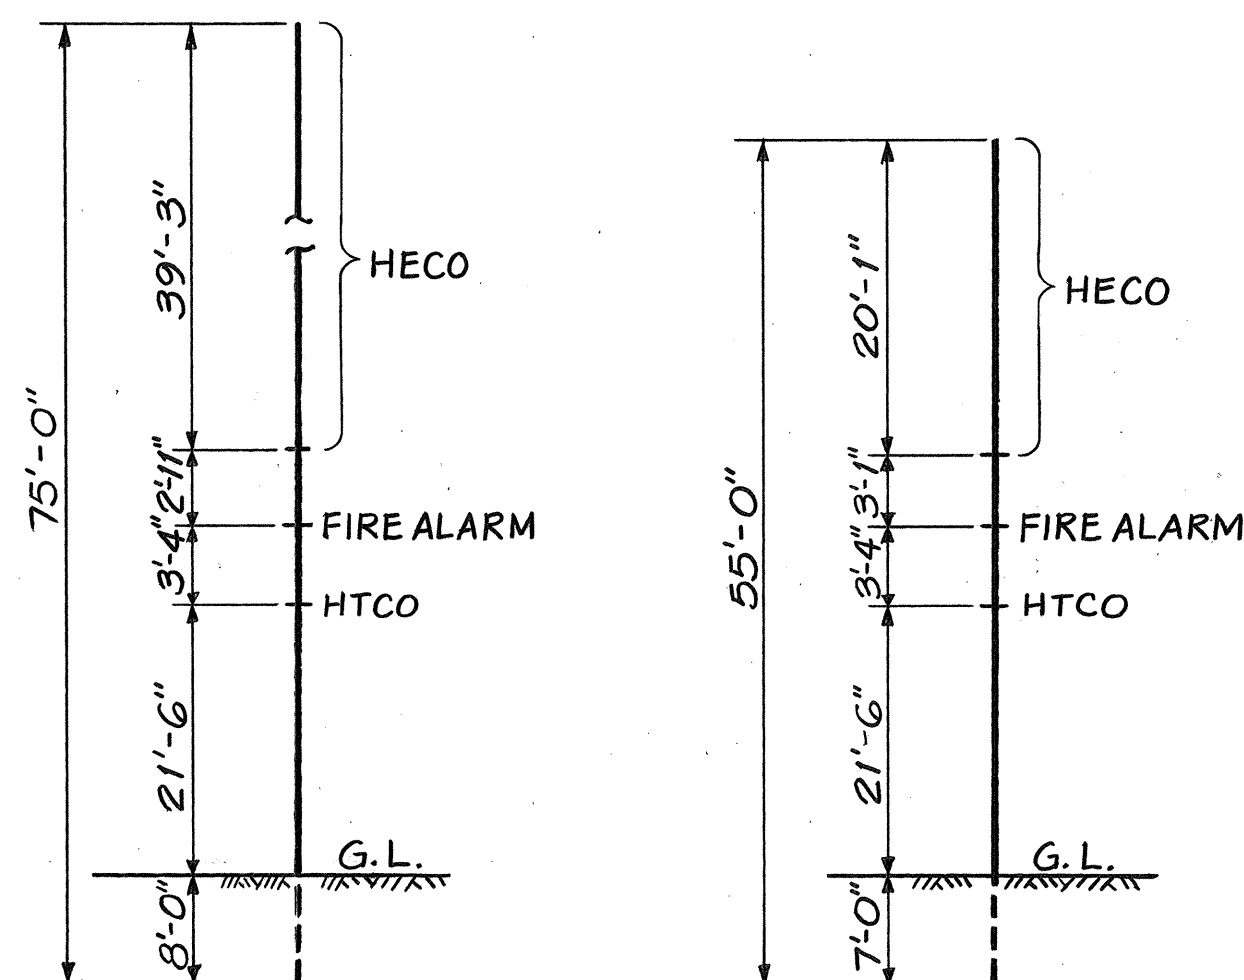


JP-1, 75' POLE
AT PUULOA ROAD
N.T.S.

JP-1, 55' POLE
AT LAGOON DRIVE
N.T.S.

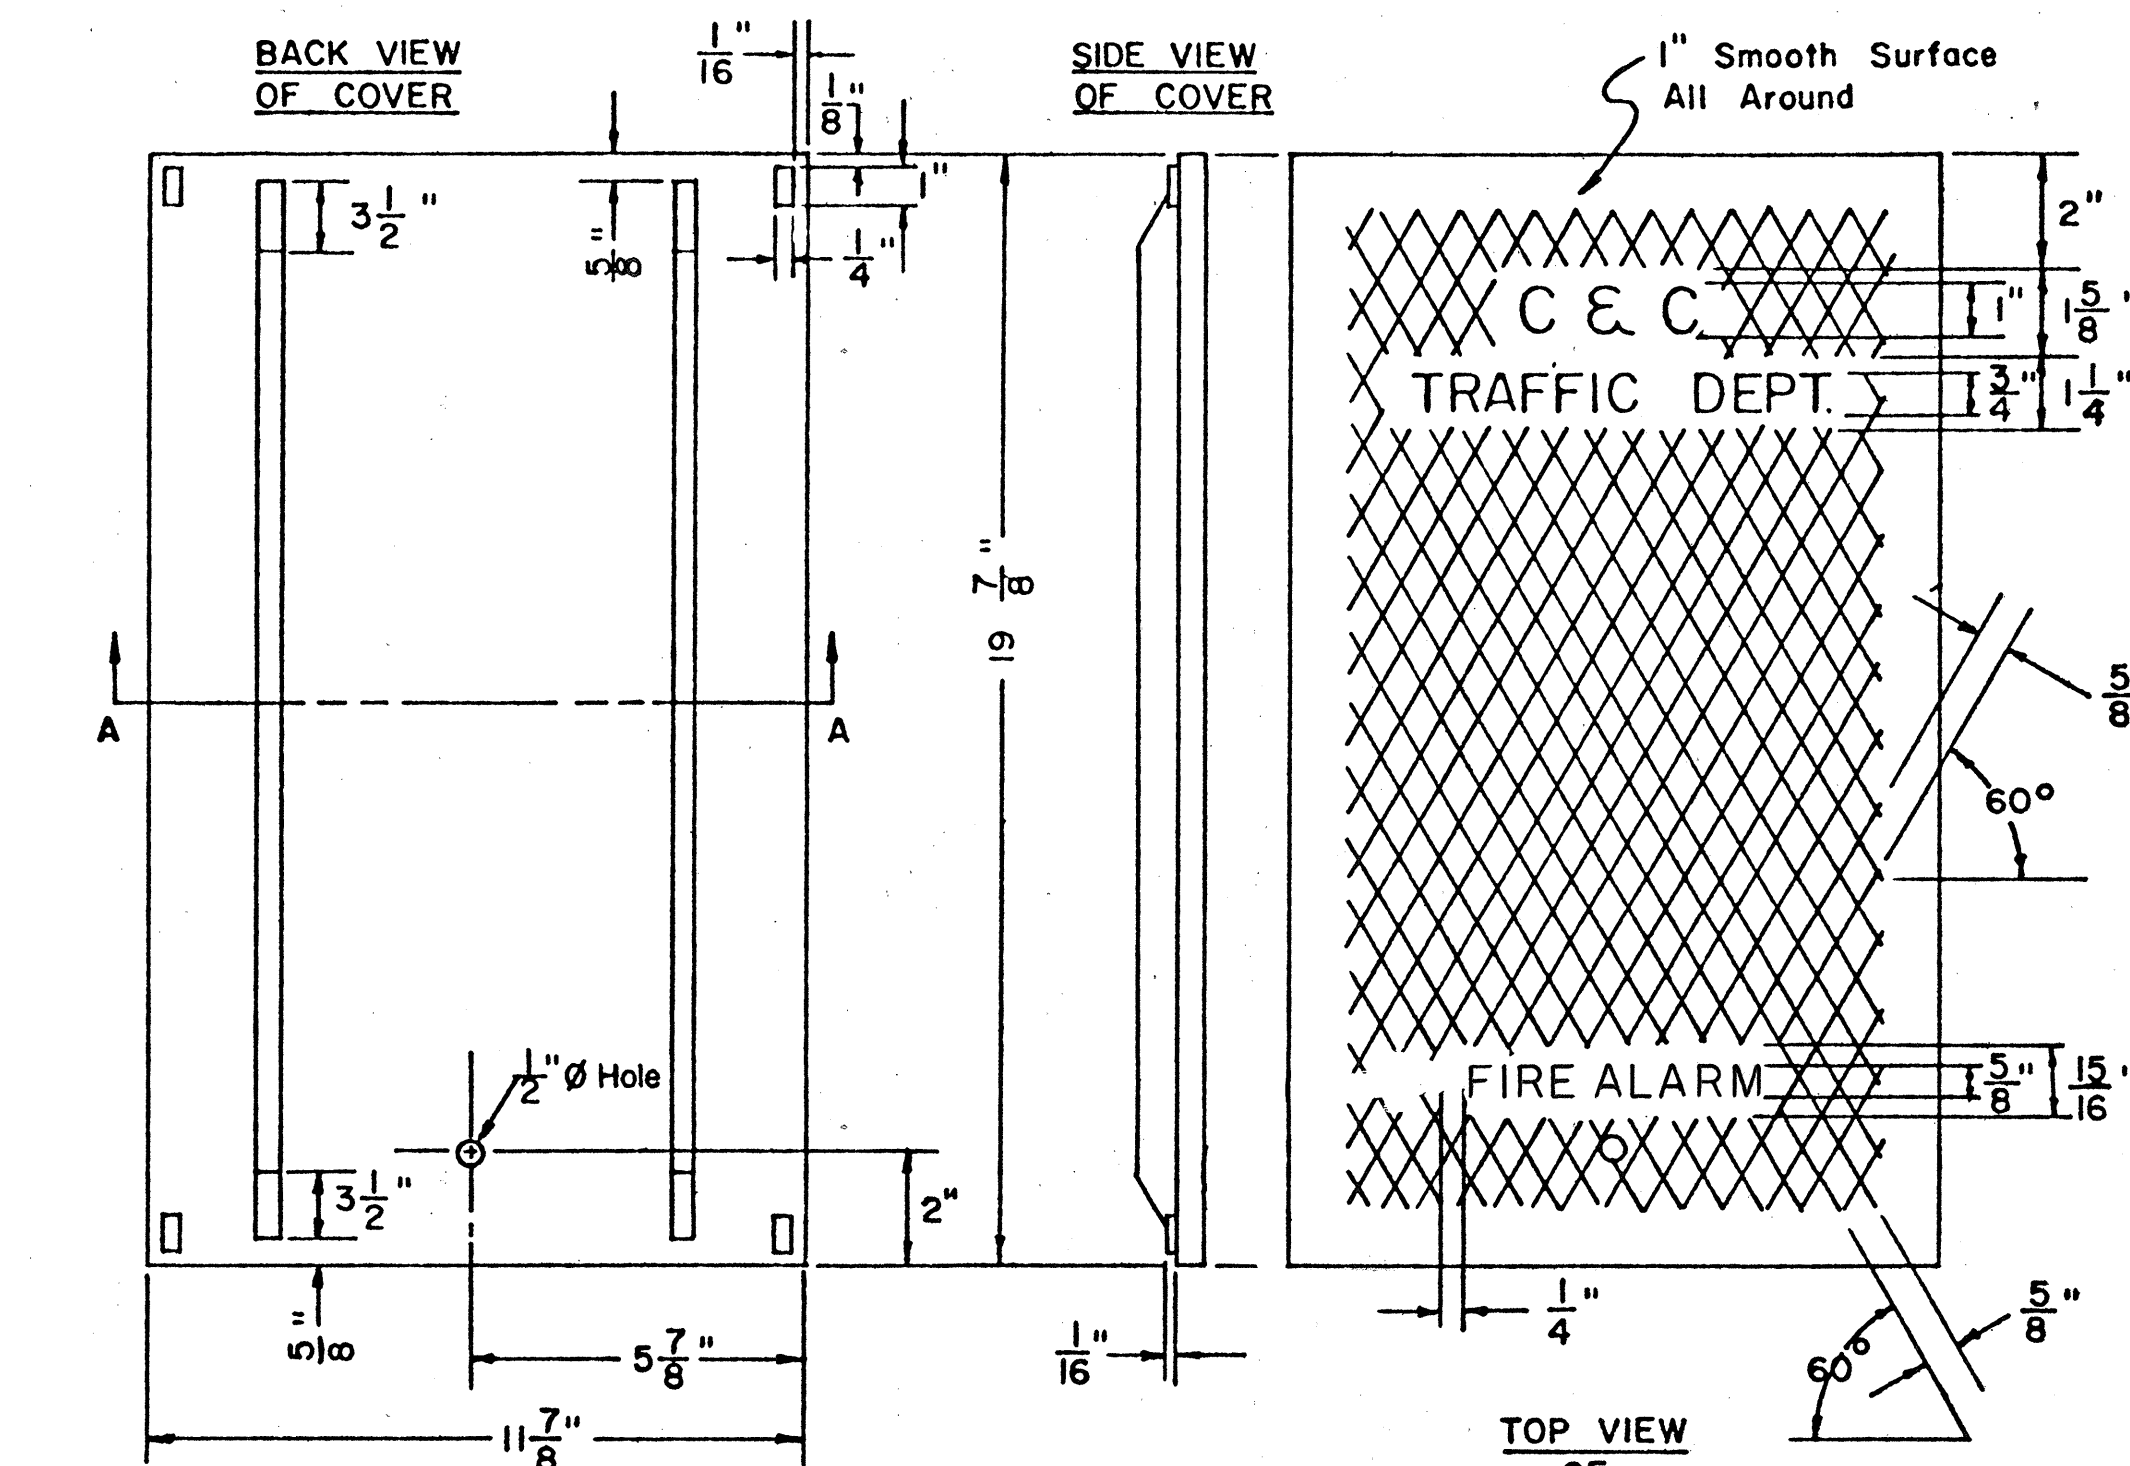


SECTION A-A
N.T.S.


NOTES
1. Sides of cover are slightly beveled to facilitate installation. Bevel is inward from front to back.
2. To be cast from grey iron.

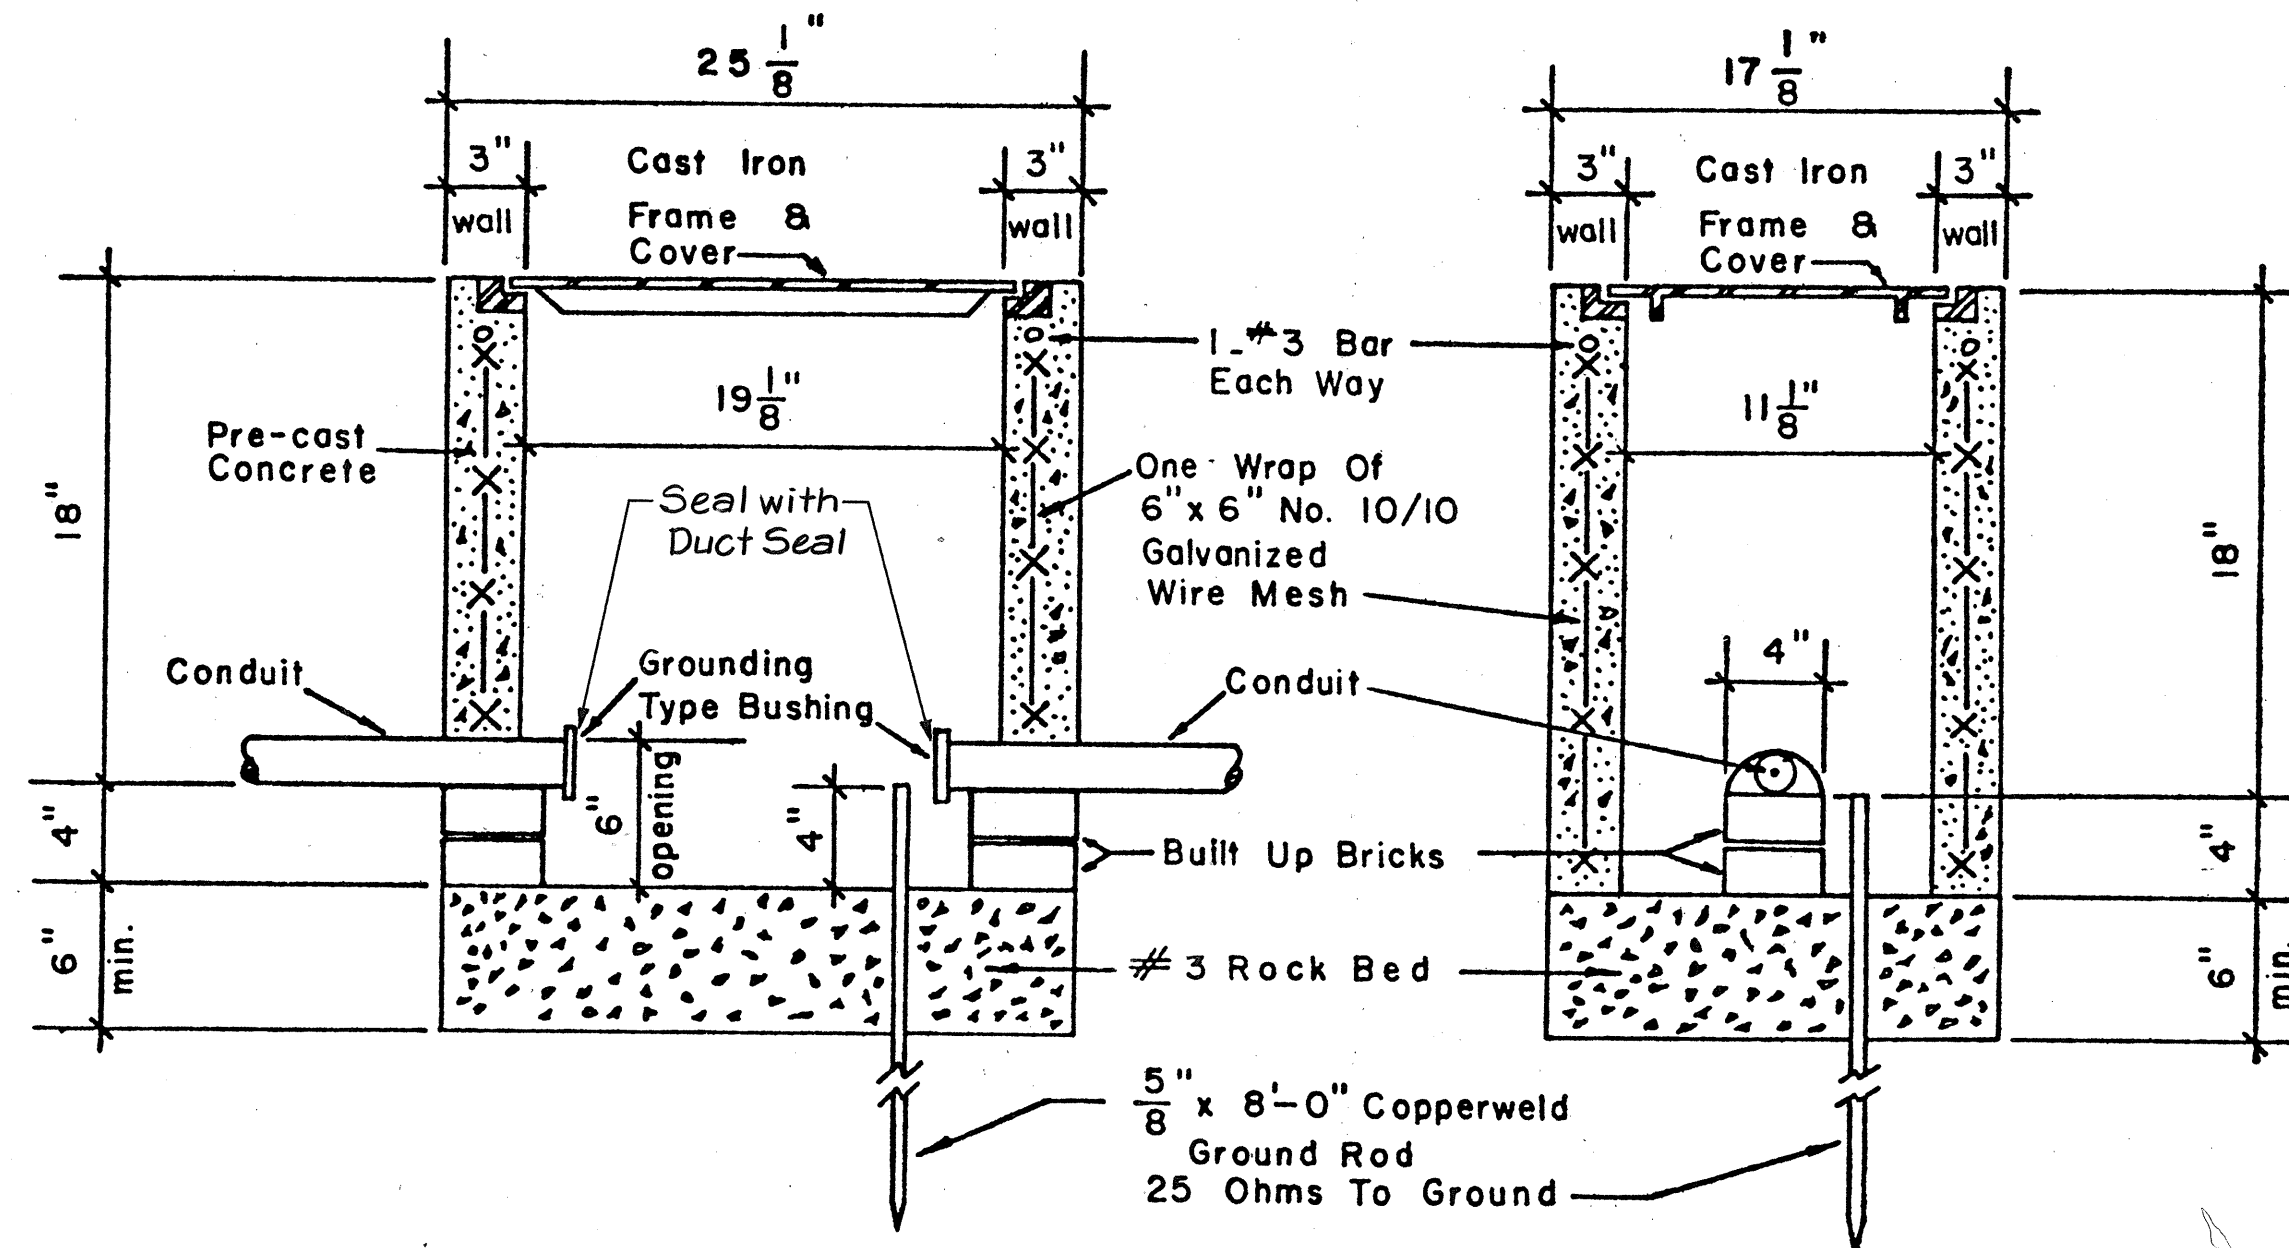


PRECAST PULLBOX
N.T.S.

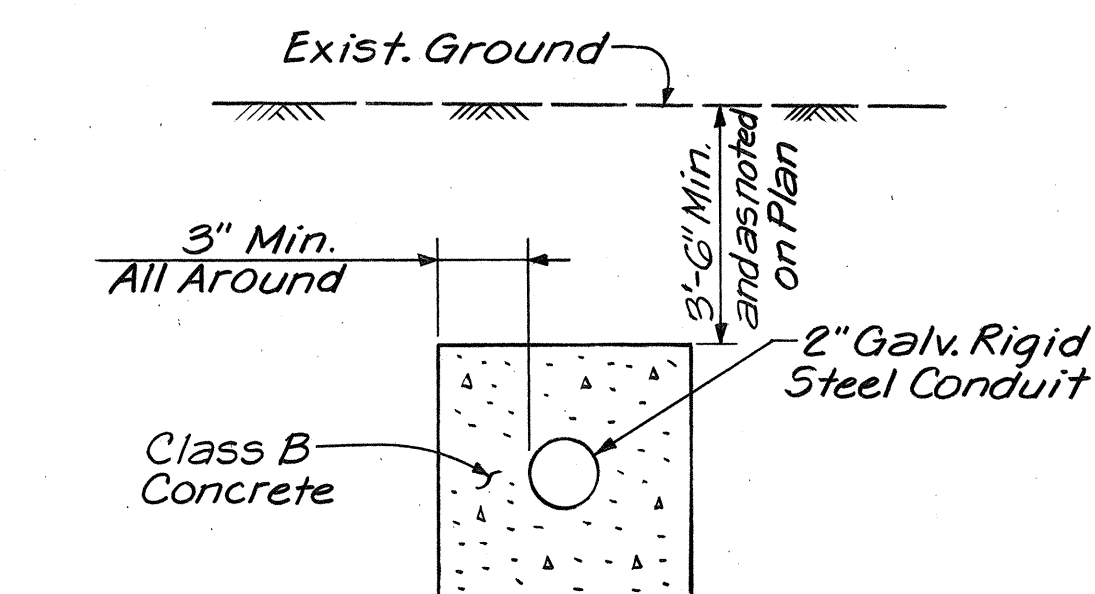


CONDUIT CONCRETE ENCASEMENT
N.T.S.

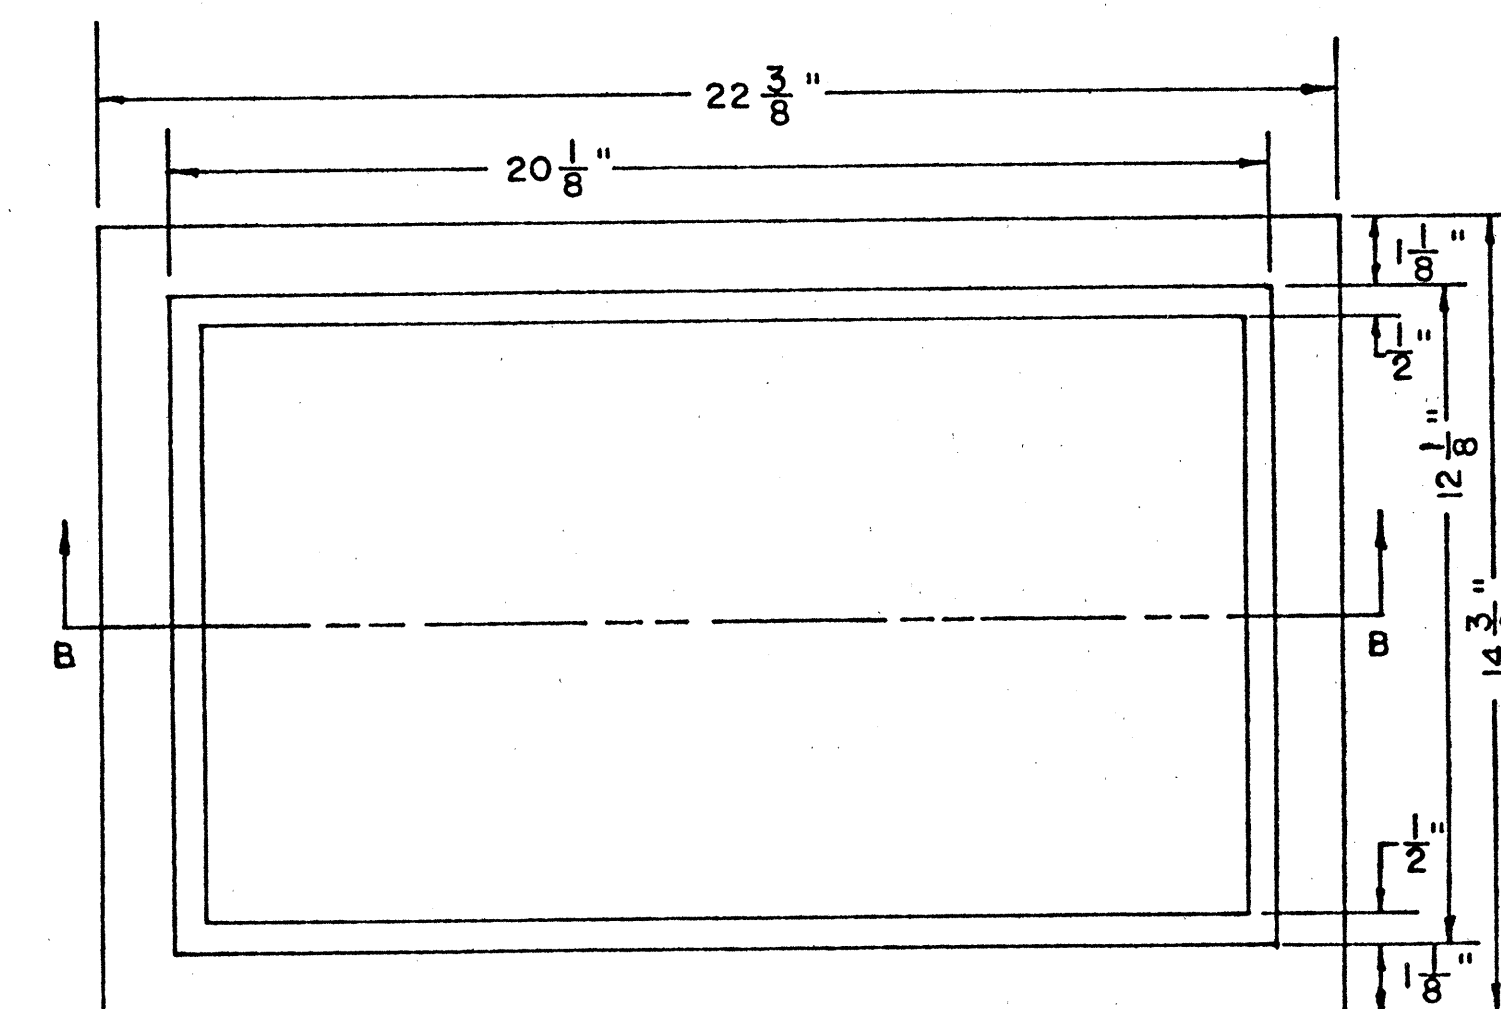

TOP VIEW OF FRAME
N.T.S.

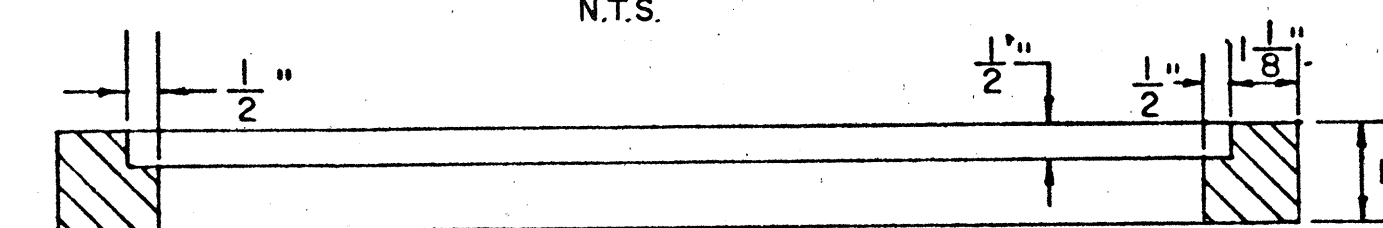

SECTION B-B

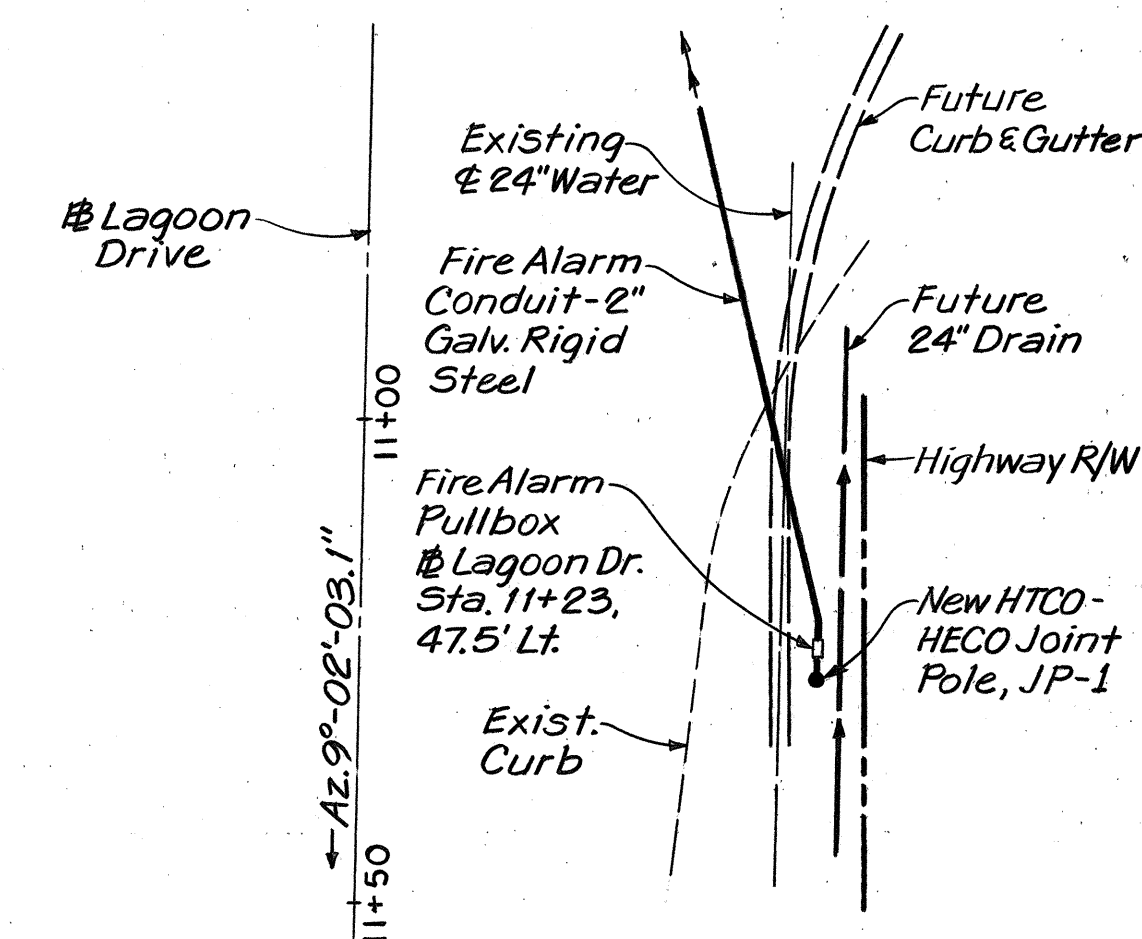

PLAN
FIRE ALARM PULLBOX AT LAGOON DRIVE
SCALE: 1"=20'

APPROVED:


[Signature]
Dept. of Transportation Services, 7/15/76
City and County of Honolulu, Date

STATE OF HAWAII
DEPARTMENT OF TRANSPORTATION
HIGHWAYS DIVISION

FIRE ALARM DETAILS

INTERSTATE ROUTE H-1
PROJECT NO I-H1-1(136)17

SCALE: AS SHOWN DATE: July 15, 1976
SHEET No. 1 OF 1 SHEETS

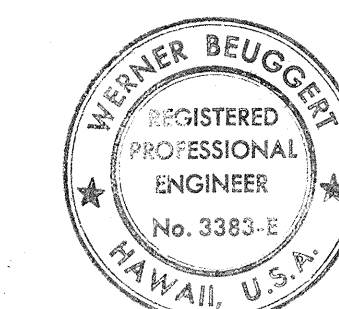

THIS WORK WAS PREPARED BY
ME OR UNDER MY SUPERVISION.
[Signature]

SURVEY PLOTTED BY	DATE
DRAWN BY	
DESIGNED BY	
QUANTITIES BY	
CHECKED BY	
ORIGINAL PLAN	
NOTE BOOK	
NO.	