

INDEX TO DRAWINGS	
SHEET NO.	DESCRIPTION
1	TITLE SHEET
2	STANDARD PLANS SUMMARY
3 - 8	GENERAL NOTES, LEGEND AND ABBREVIATIONS
9 - 11	WATER POLLUTION AND EROSION CONTROL NOTES
12 - 34	DEMOLITION AND EROSION CONTROL PLANS AND DETAILS
35 - 52	TYPICAL SECTIONS
53 - 55	GENERAL PLANS
56 - 78	ROADWAY PLANS
79 - 96	GUARDRAIL DETAILS & SCHEDULE
97 - 120	TRAFFIC COUNTING SYSTEM
121 - 141	PAVEMENT GRADE PLANS
142 - 175	PAVEMENT MARKING AND SIGNING PLANS, NOTES AND SIGN DETAILS
176 - 225	TRAFFIC CONTROL PLANS
226 - 270	ELECTRICAL PLANS
271 - 277	LANDSCAPE PLANS
278 - 304	STRUCTURAL PLANS

STATE OF HAWAII

DEPARTMENT OF TRANSPORTATION

HIGHWAYS DIVISION

HONOLULU, HAWAII

PLANS FOR

INTERSTATE ROUTE H-1 RESURFACING



MILLER PEDESTRIAN OVERPASS TO KAPIOLANI INTERCHANGE

FEDERAL-AID PROJECT NO. NH-H1-1(279)

DISTRICT OF HONOLULU

ISLAND OF OAHU

FED. ROAD DIST. NO.	STATE	FED.-AID PROJ. NO.	FISCAL YEAR	SHEET NO.	TOTAL SHEETS
HAWAII	HAW.	NH-H1-1(279)	2021	1	304

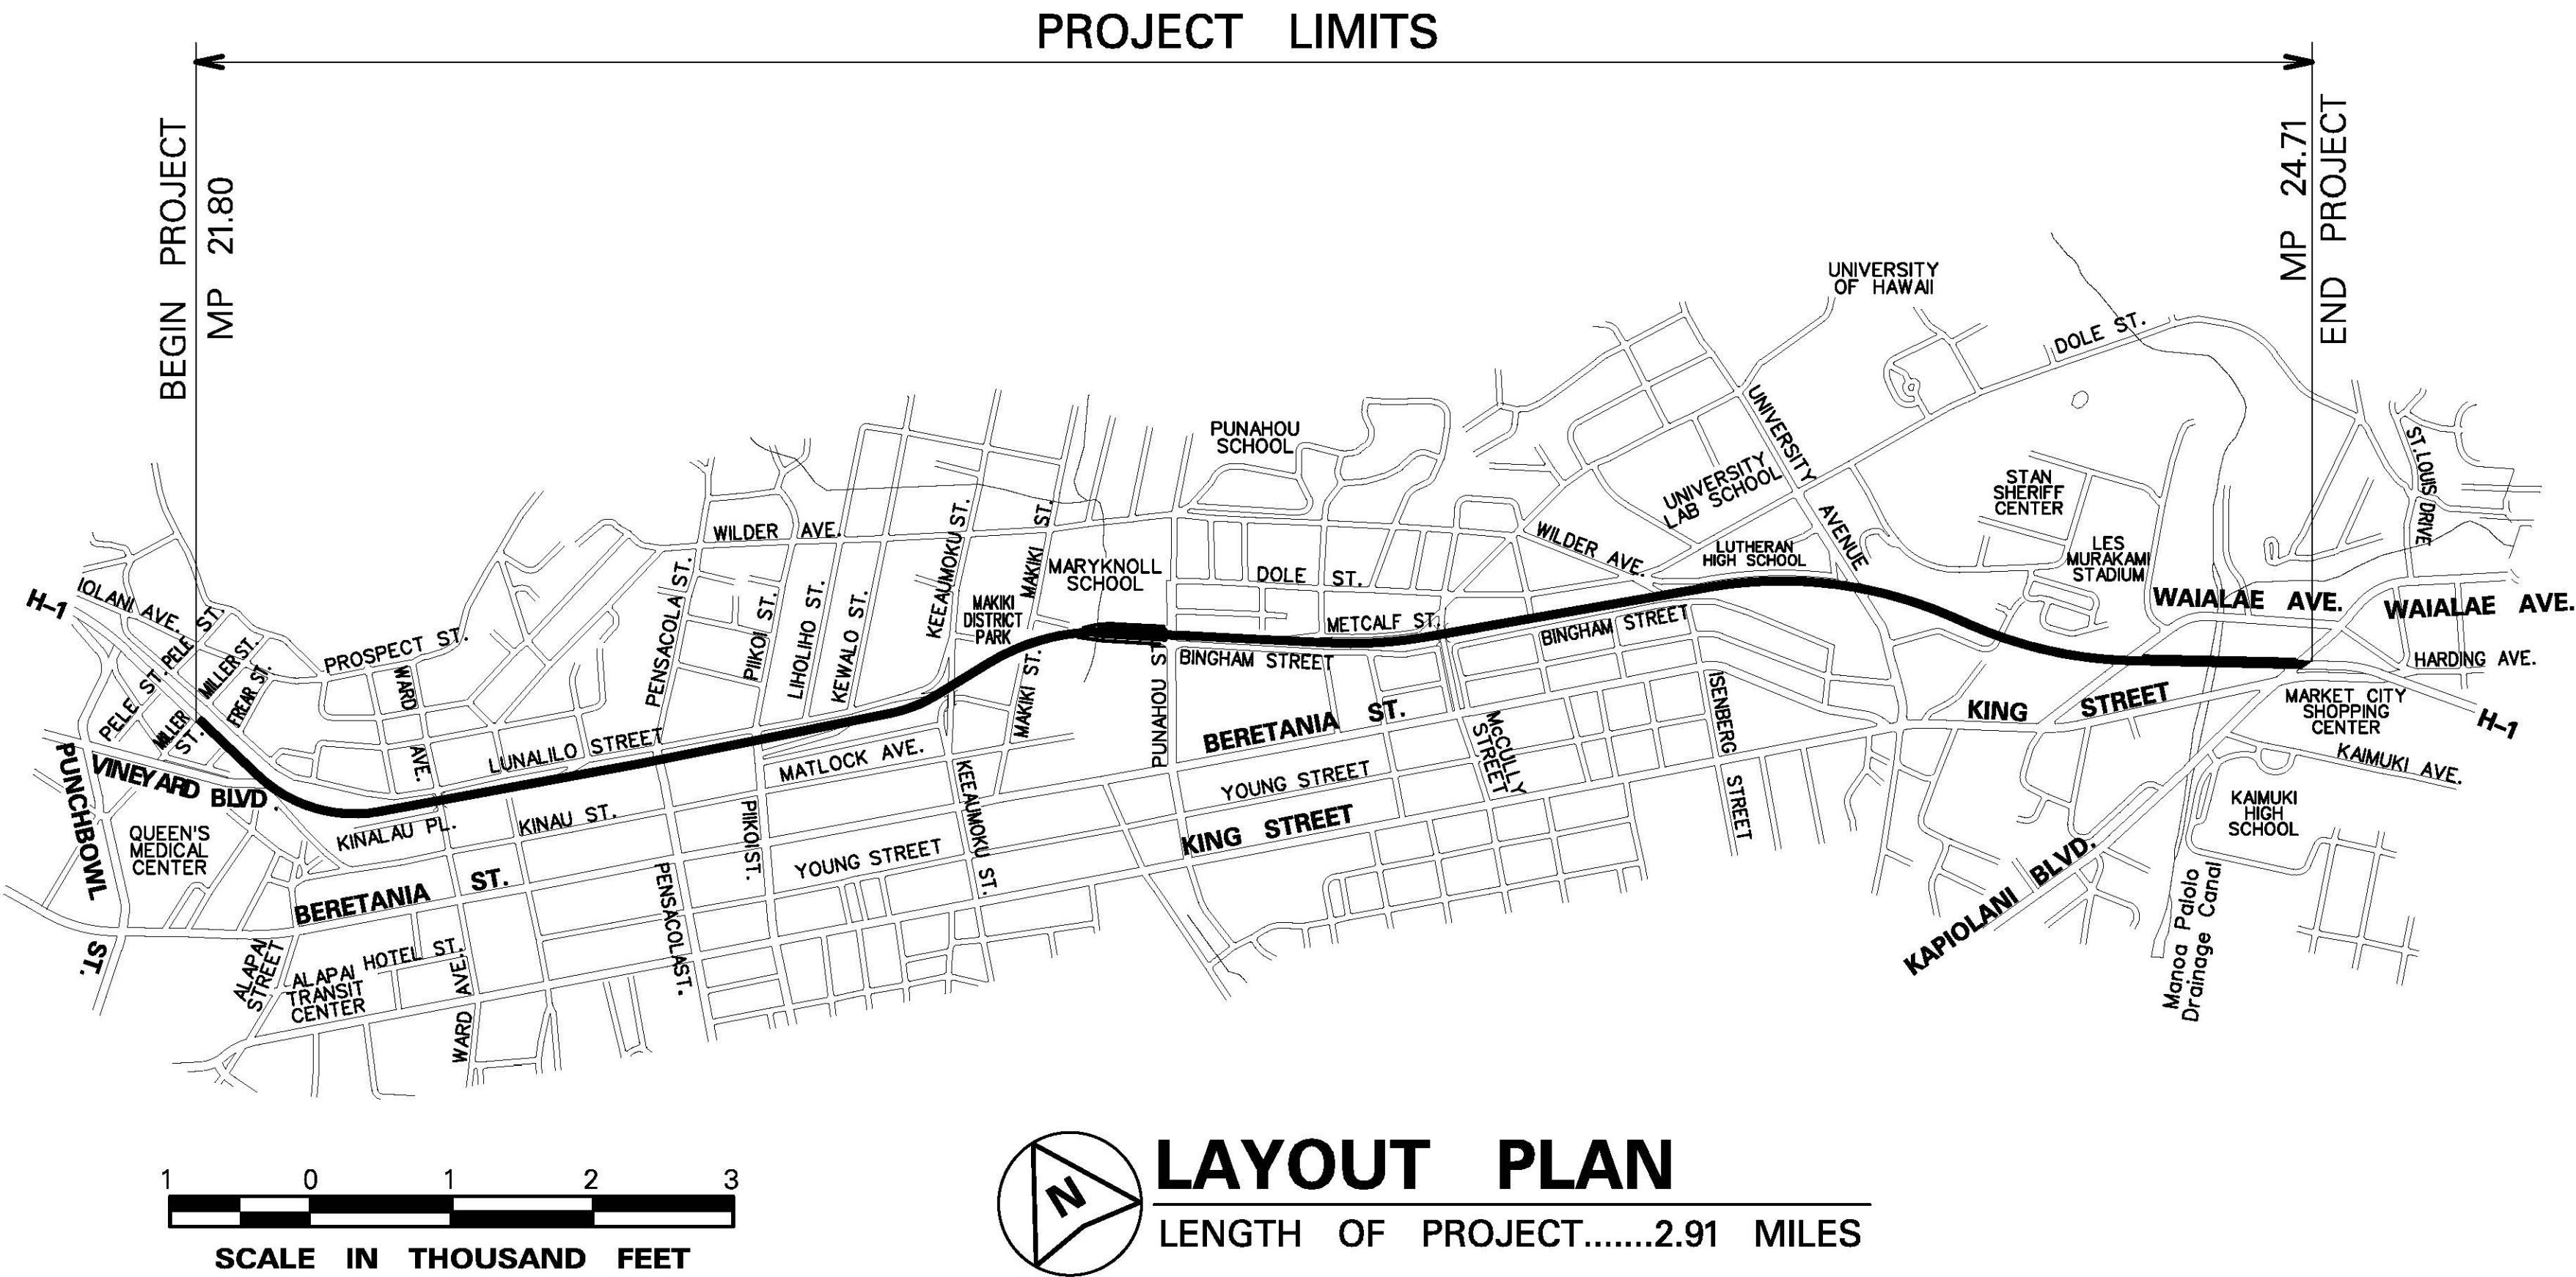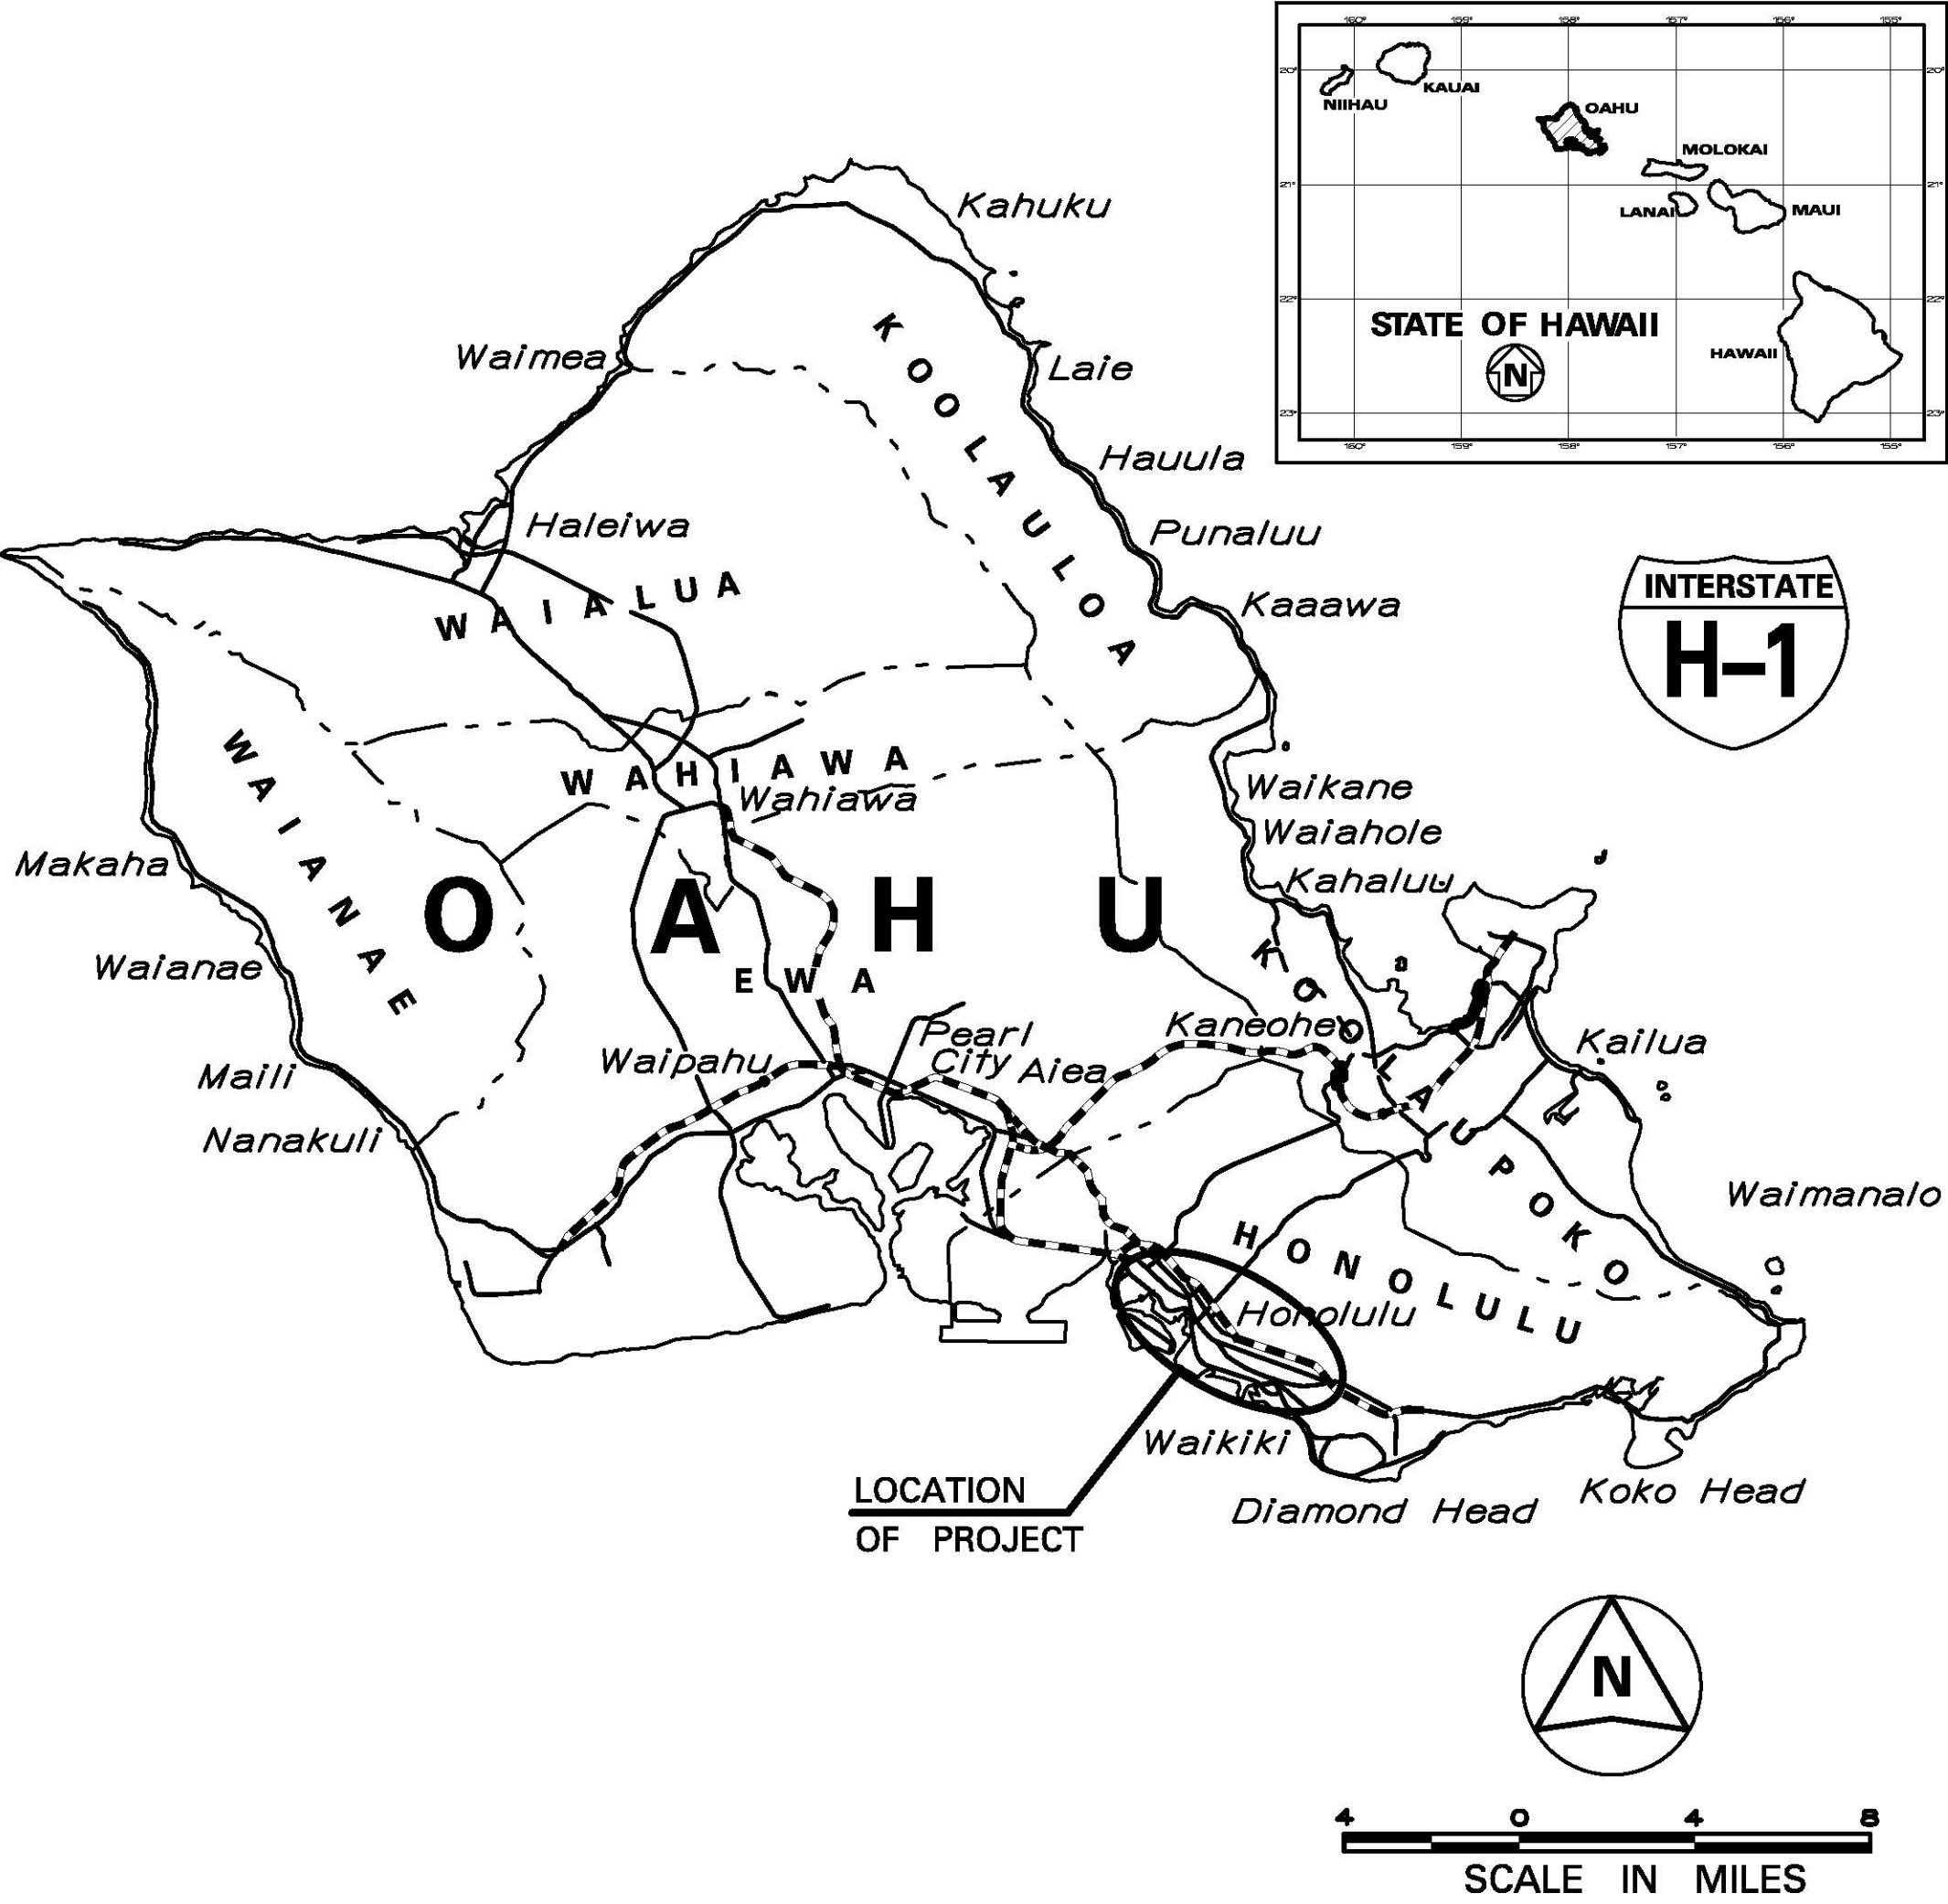

	MP 21.80 - 23.07	MP 23.07 - 24.13	MP 24.13 - 24.41	MP 24.41 - 24.71
ADT (2017)	201,100	147,800	130,200	116,200
ADT (2027)	225,700	167,900	147,800	132,000
DHV	16,930	12,590	11,090	9,900
D	60/40	60/40	60/40	60/40
T	3.5 %	3.5 %	3.5 %	3.5 %
T24	4.0 %	4.0 %	4.0 %	4.0 %

DEPARTMENT OF TRANSPORTATION

STATE OF HAWAII

APPROVED:

Jun 17, 2021

DIR. OF TRANSPORTATION DATE

SSEM INTL.

DESIGNED BY

HVY-DS

Managed By

692-7545

PHONE

AUGUST 2021

DATE

LAYOUT PLAN

LENGTH OF PROJECT.....2.91 MILES