

INDEX TO DRAWINGS	
SHEET NO.	DESCRIPTION
1	TITLE SHEET
2-4	TYPICAL SECTIONS
5	GENERAL NOTES, ABBREVIATIONS AND SYMBOLS
6-21	DETAIL ROADWAY PLANS
22-32	MISC. ROADWAY DETAILS
33-46	MISC. STRUCTURAL DETAILS
47-57	ROADWAY STANDARD DETAILS
58-62	UTILITIES
63-103	DRAINAGE DETAILS
104-120	SPRINKLER PLANS
121-126	SIGNING PLANS
127-133	PAVEMENT MARKINGS
134-169	MISC. SIGNING DETAILS
170-173	LIGHTING PLANS
174-181	RECONSTRUCTION AND RESURFACING PLANS
182	IMPROV. DET. AT VAR. LOCATIONS

- 1 C.O. 5S-1
- 2 C.O. 22S-1, C.O. 22S-2, C.O. 22S-3, C.O. 22S-4, C.O. 32S-1
- 3 C.O. 46S-1, C.O. 46S-2
- 4 C.O. 54S-1
- 5 C.O. 59S-1, C.O. 59S-2, C.O. 59S-3
- 6 C.O. 64S-1
- 7 C.O. 104S-1, C.O. 104S-2, C.O. 104S-3, C.O. 120S-1, C.O. 120S-2
- 8 C.O. 126S-1
- 9 C.O. 133S-1, C.O. 133S-2, C.O. 133S-3
- 10 C.O. 136S-1, C.O. 139S-1, C.O. 147S-1, C.O. 147S-2, C.O. 157S-1, C.O. 168S-1
- 11 C.O. 173S-1, C.O. 173S-2
- 12 C.O. 181S-1, C.O. 181S-2, C.O. 181S-3, C.O. 181S-4, C.O. 181S-5, C.O. 181S-6, C.O. 181S-7, C.O. 181S-8, C.O. 181S-9, C.O. 181S-10

PALI HIGHWAY TO WEST END OF KAPIOLANI VIADUCT  
FEDERAL AID INTERSTATE PROJECT NO. I-HI-1(60):23

DISTRICT OF HONOLULU  
ISLAND OF OAHU

TOTAL SHEET COUNT AFTER  
"AS-BUILT" POSTINGS  
221 SHEETS.


RECONSTRUCTION AND RESURFACING

FED. ROAD DIST. NO.	STATE	FED. AID PROJ. NO.	FISCAL YEAR	SHEET NO.	TOTAL SHEETS
HAWAII	HAW.	I-HI-1(60):23	1976	1	181

STATE OF HAWAII  
DEPARTMENT OF TRANSPORTATION  
HIGHWAYS DIVISION

HONOLULU, HAWAII  
"AS BUILT"  
PLANS FOR

SAFETY IMPROVEMENTS ALONG  
INTERSTATE ROUTE H-1

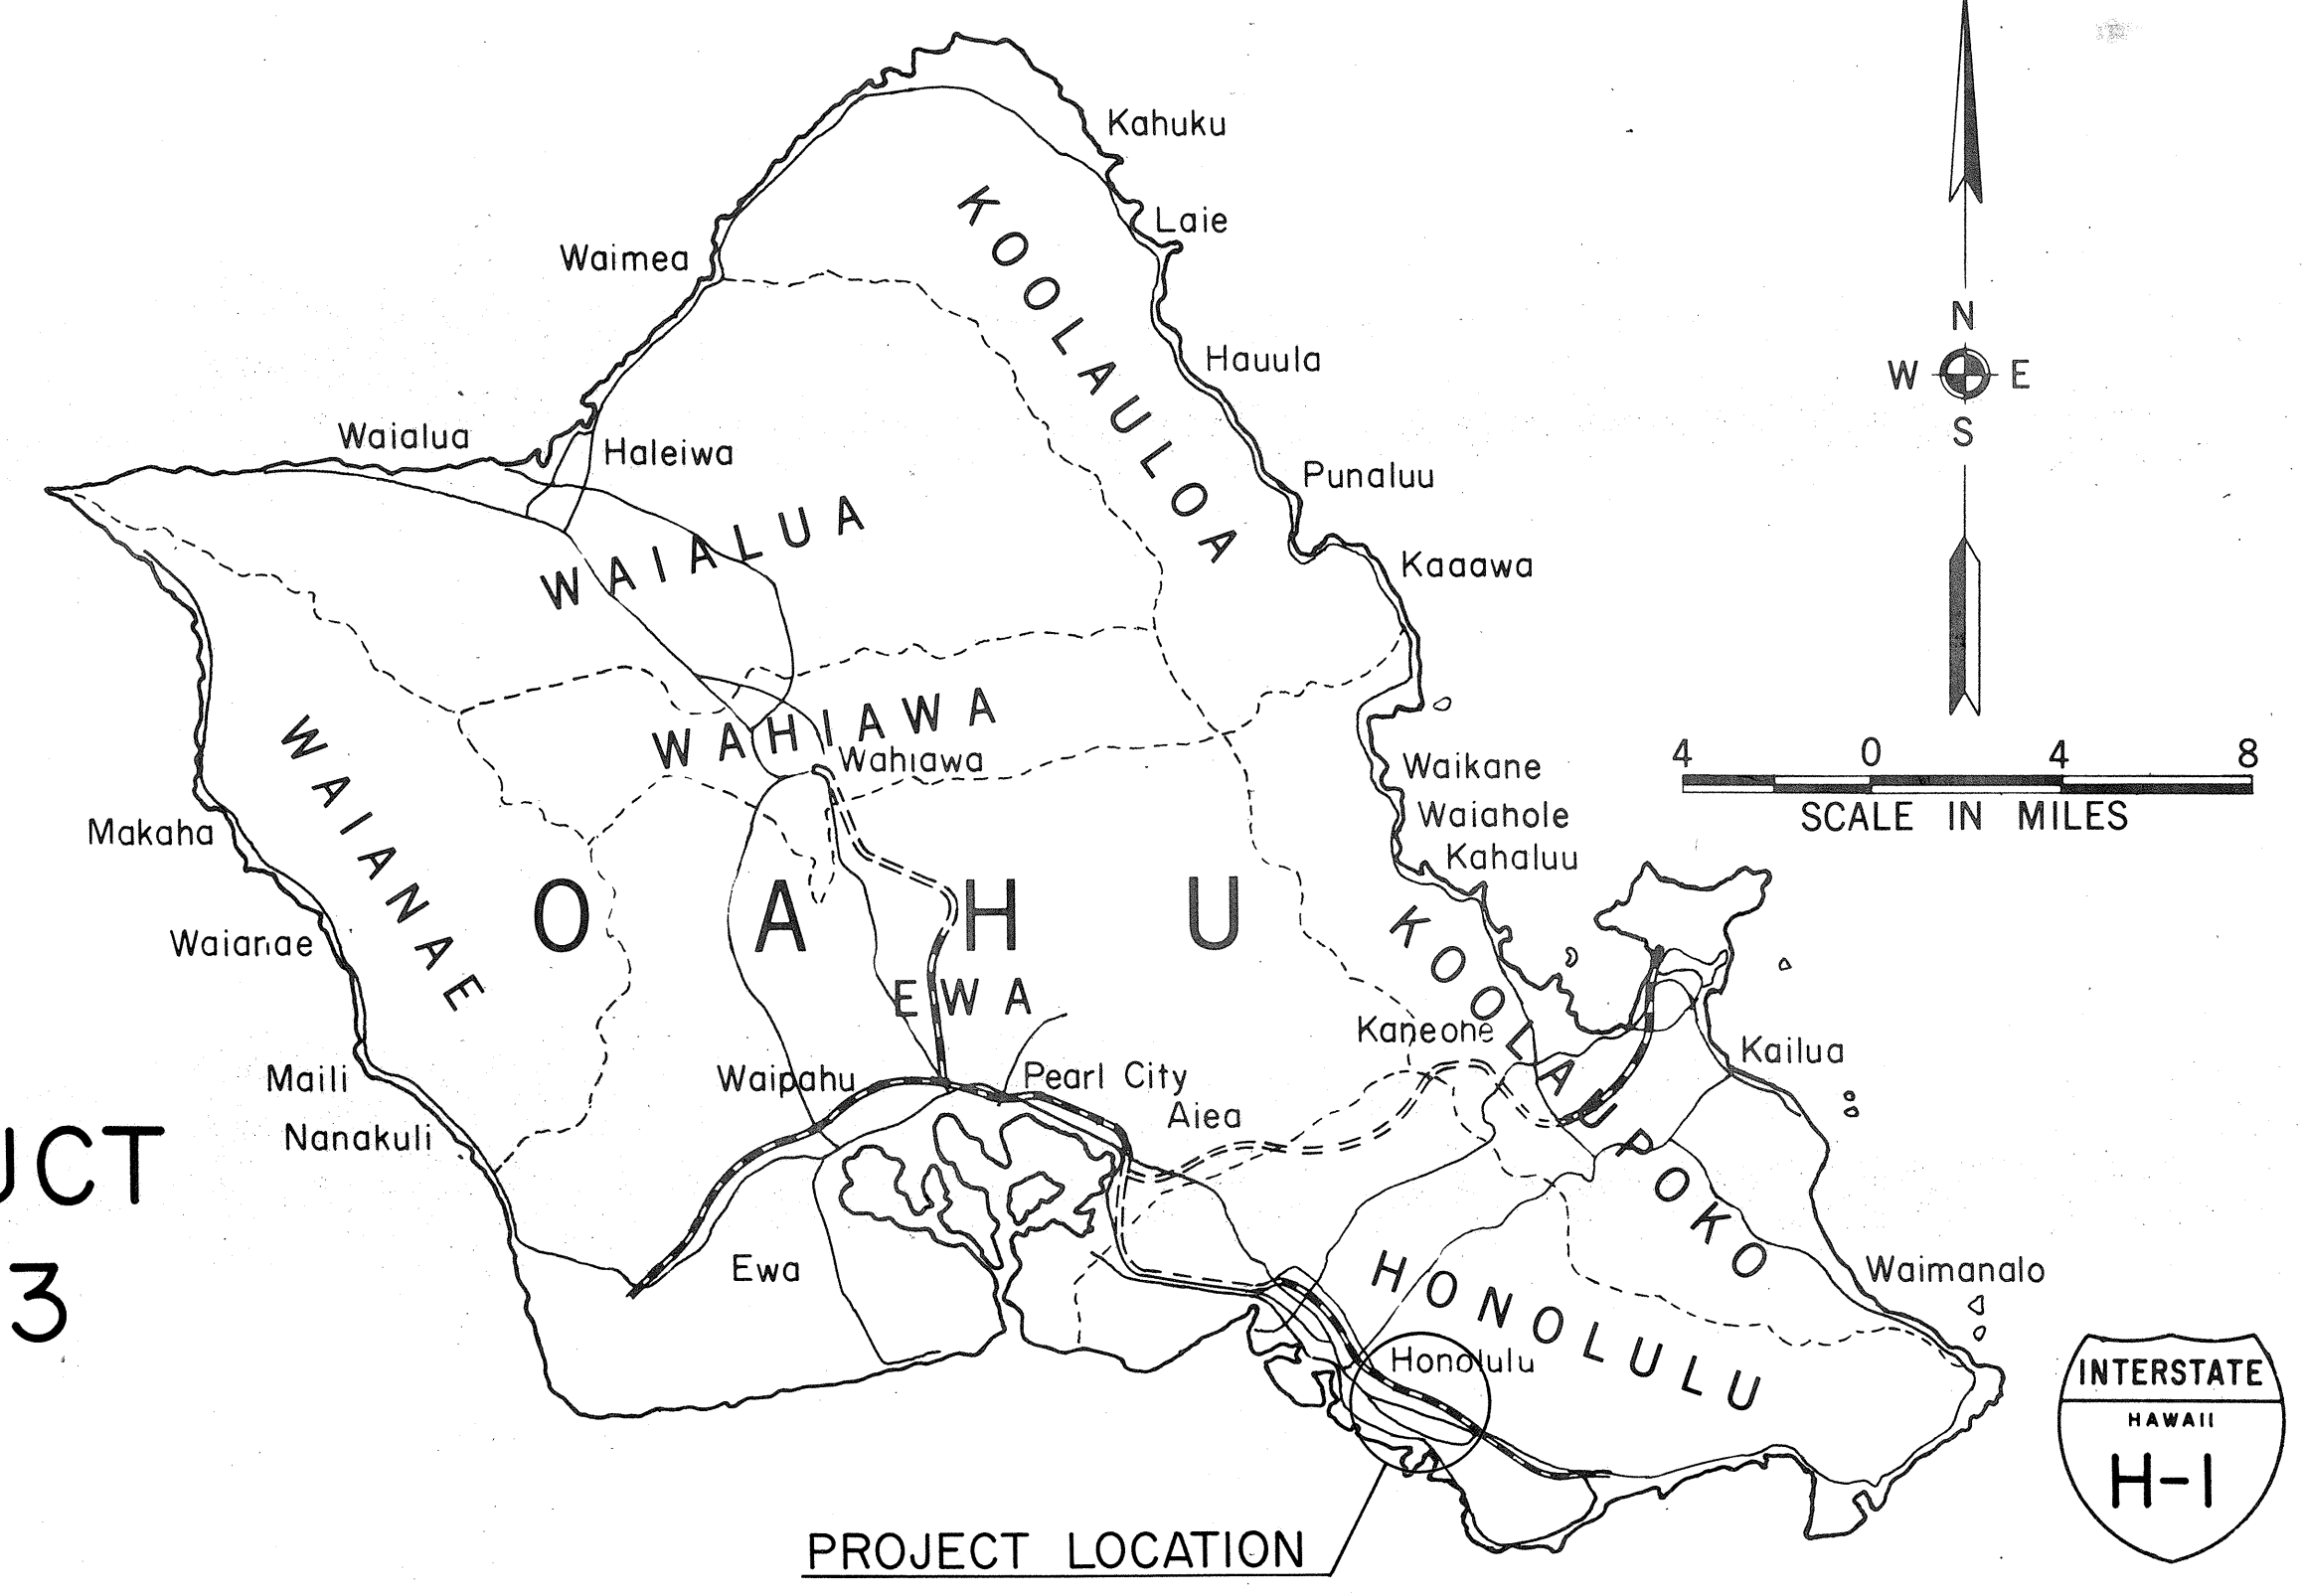

DESIGN DESIGNATION


CURRENT ADT (1976) . . . . . 116,900  
DESIGN ADT (1996) . . . . . 107,300  
DHV . . . . . 10,194  
D . . . . . 75/25  
T . . . . . 2%  
V . . . . . 50 M.P.H.

CHANGES MADE DURING CONSTRUCTION HAVE BEEN  
INCORPORATED ON THESE PLANS EXCEPT CHANGES  
IN THE ORIGINAL THEORETICAL QUANTITIES. FOR  
ACTUAL QUANTITIES, REFER TO PROJECT LEDGER  
AND/OR COMPUTATION BOOK.

*Dennis T. Higa*  
RESIDENT ENGINEER

8/20/84  
DATE

RONALD F. TSUZUKI  
DESIGNED BY  
"B"  
DESIGN UNIT  
548-2456  
PHONE  
548-2456  
DATE  
548-2456  
DATE  
548-2456  
DATE

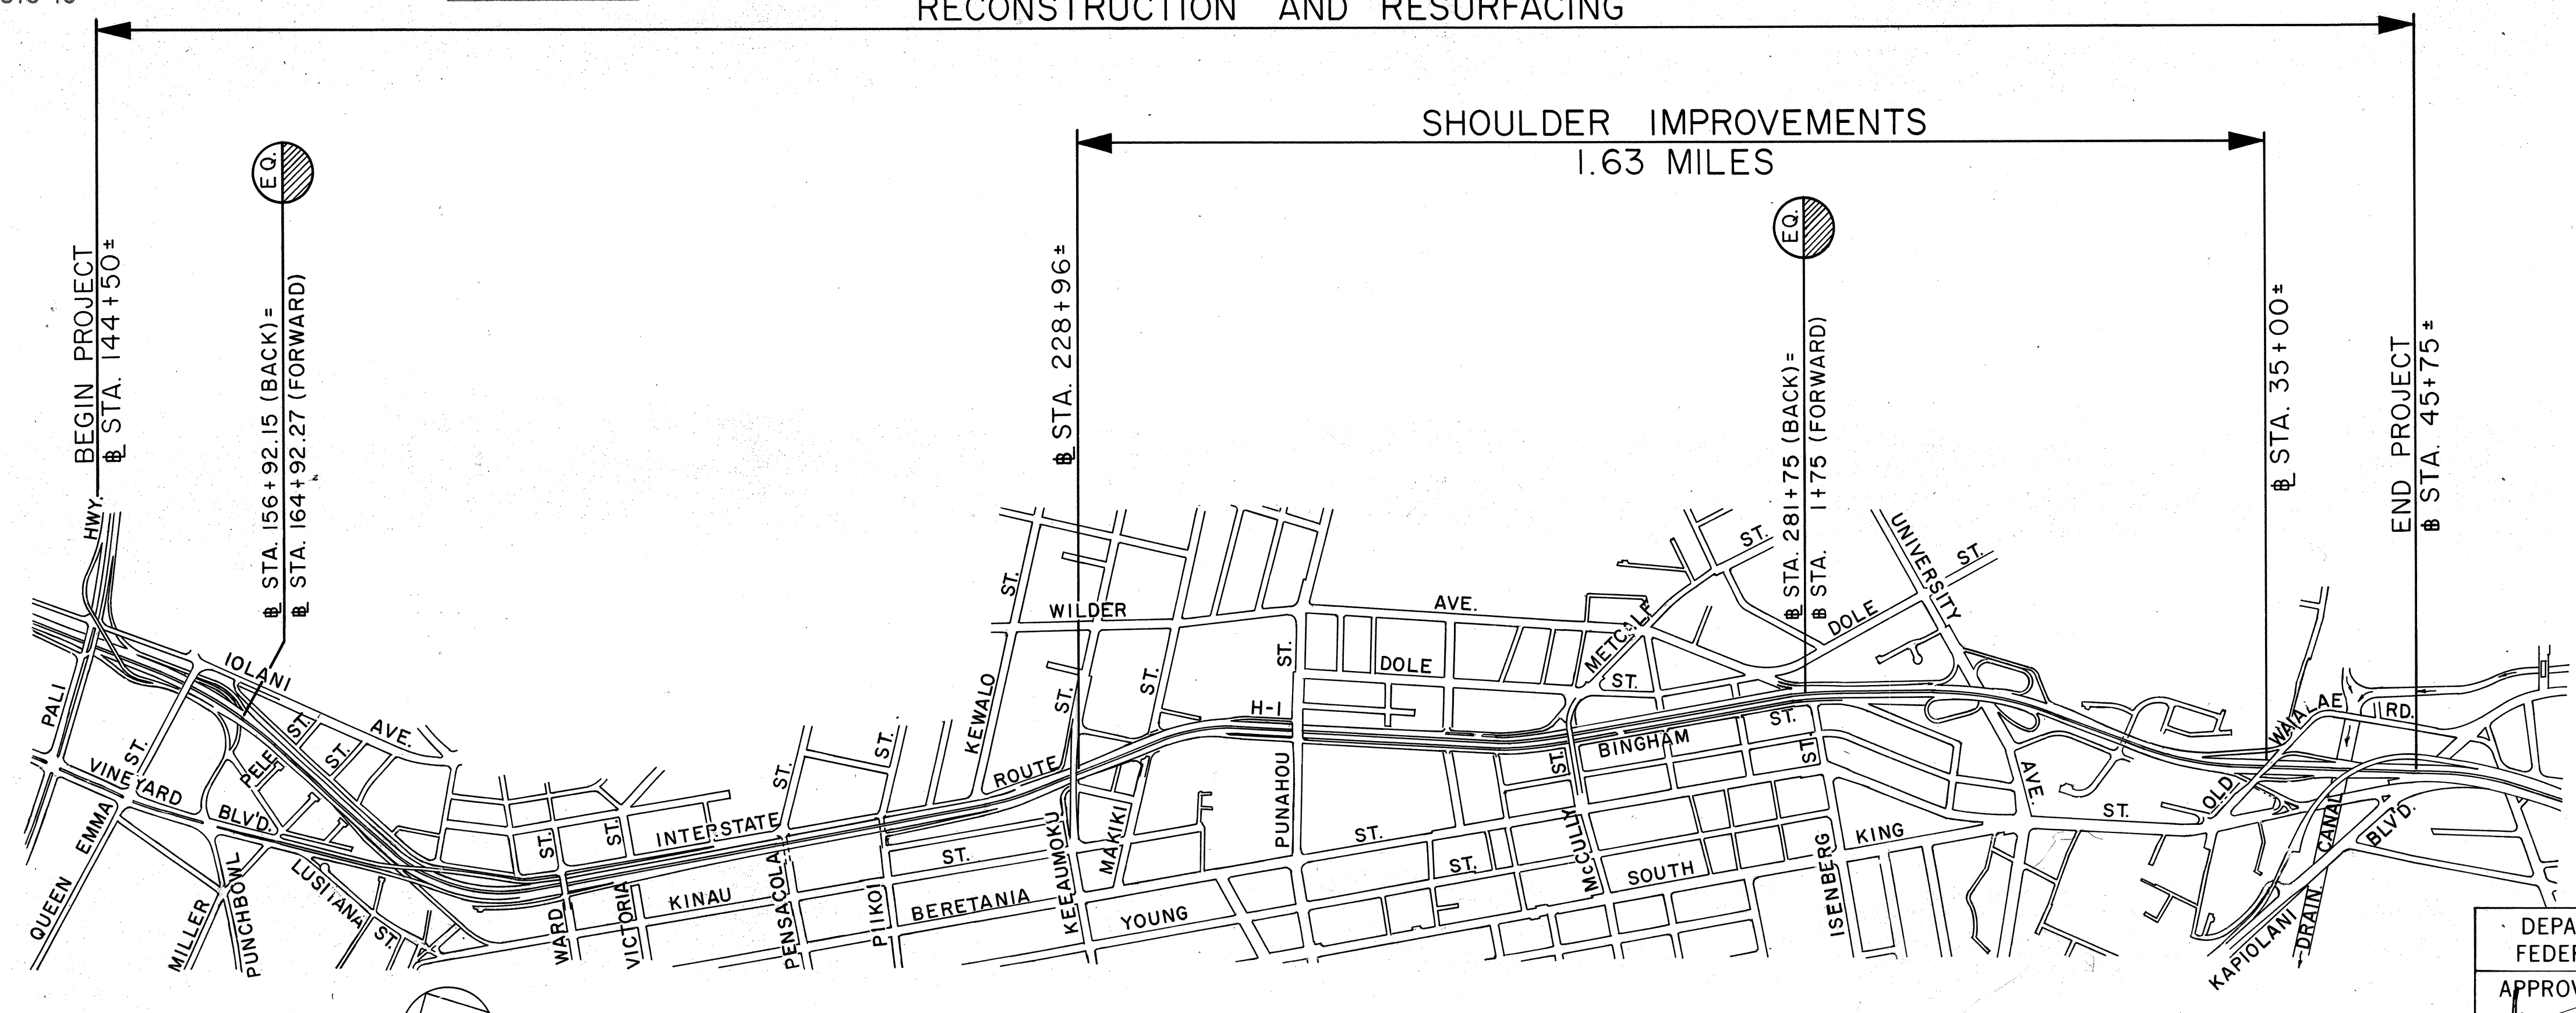

LAYOUT PLAN  
PROJECT LENGTH.....3.28 MILES

8 0 8 16 24  
SCALE IN HUNDRED FEET

DEPARTMENT OF TRANSPORTATION  
FEDERAL HIGHWAY ADMINISTRATION  
APPROVED: *[Signature]*  
DIVISION ADMINISTRATOR  
9-23-76  
DATE

DEPARTMENT OF TRANSPORTATION  
STATE OF HAWAII  
APPROVED: *R. Higashionna*  
DIR. OF TRANSPORTATION  
9-23-76  
DATE