

INDEX TO DRAWINGS	
SHEET NO.	DESCRIPTION
1	TITLE SHEET
2 - 10	TYPICAL ROADWAY SECTIONS
11 - 14	DETAILED ROADWAY PLANS
15 - 19	ROADWAY PROFILES
20 - 23	SUPER ELEVATIONS
24	BORING LOGS
25	TEST PIT LOGS
① 26 - 68	MISC. ROADWAY PLANS & DETAILS
② 69 - 93	DETOUR PHASING PLANS & DTLS
③ 94 - 121	ROADWAY SIGNING PLANS & DTLS
122 - 136	HIGHWAY LIGHTING PLANS & DTLS
④ 137 - 157	DRAINAGE PLANS & DETAILS
158 - 176	WATER, SEWER & GAS PLANS & DETAILS
⑤ 177 - 219	ELECTRICAL & TELEPHONE PLANS & DETAILS
220 - 227	SPRINKLER PLANS & DETAILS
228 - 233	LANDSCAPING
⑥ 234 - 333	STRUCTURAL PLANS & DETAILS
334 - 350	CROSS - SECTIONS
DELETED SHEETS	
64 - 68	MISC. DETAILS
224	STRUCTURAL DETAILS
ADDED SHEETS	
83A - 83F	TEMPORARY PAVEMENT MARKINGS
284A - 284E	STRUCTURAL PLANS & DETAILS

- ① 63A
 ② C.O. 69S-1, C.O. 69S-2, C.O. 73-A, C.O. 82-A, C.O. 82-B
 ③ C.O. 99-A, C.O. 106-A
 ④ C.O. 163-A
 ⑤ C.O. 187-A
 ⑥ C.O. 315-A, 329S-1

SUPPLEMENT SHEETS
 TO THE CONTRACT PLAN

NEW TOTAL = 367 SHEETS



STATE OF HAWAII



DEPARTMENT OF TRANSPORTATION HIGHWAYS DIVISION


HONOLULU, HAWAII

"AS BUILT"
 PLANS FOR

CONSTRUCTION OF A PORTION OF INTERSTATE ROUTE H-1 NIMITZ SPUR

FEDERAL AID INTERSTATE
 PROJECT NUMBER I-H1-1 (99) : 15

DISTRICTS OF HONOLULU AND EWA
 ISLAND OF OAHU

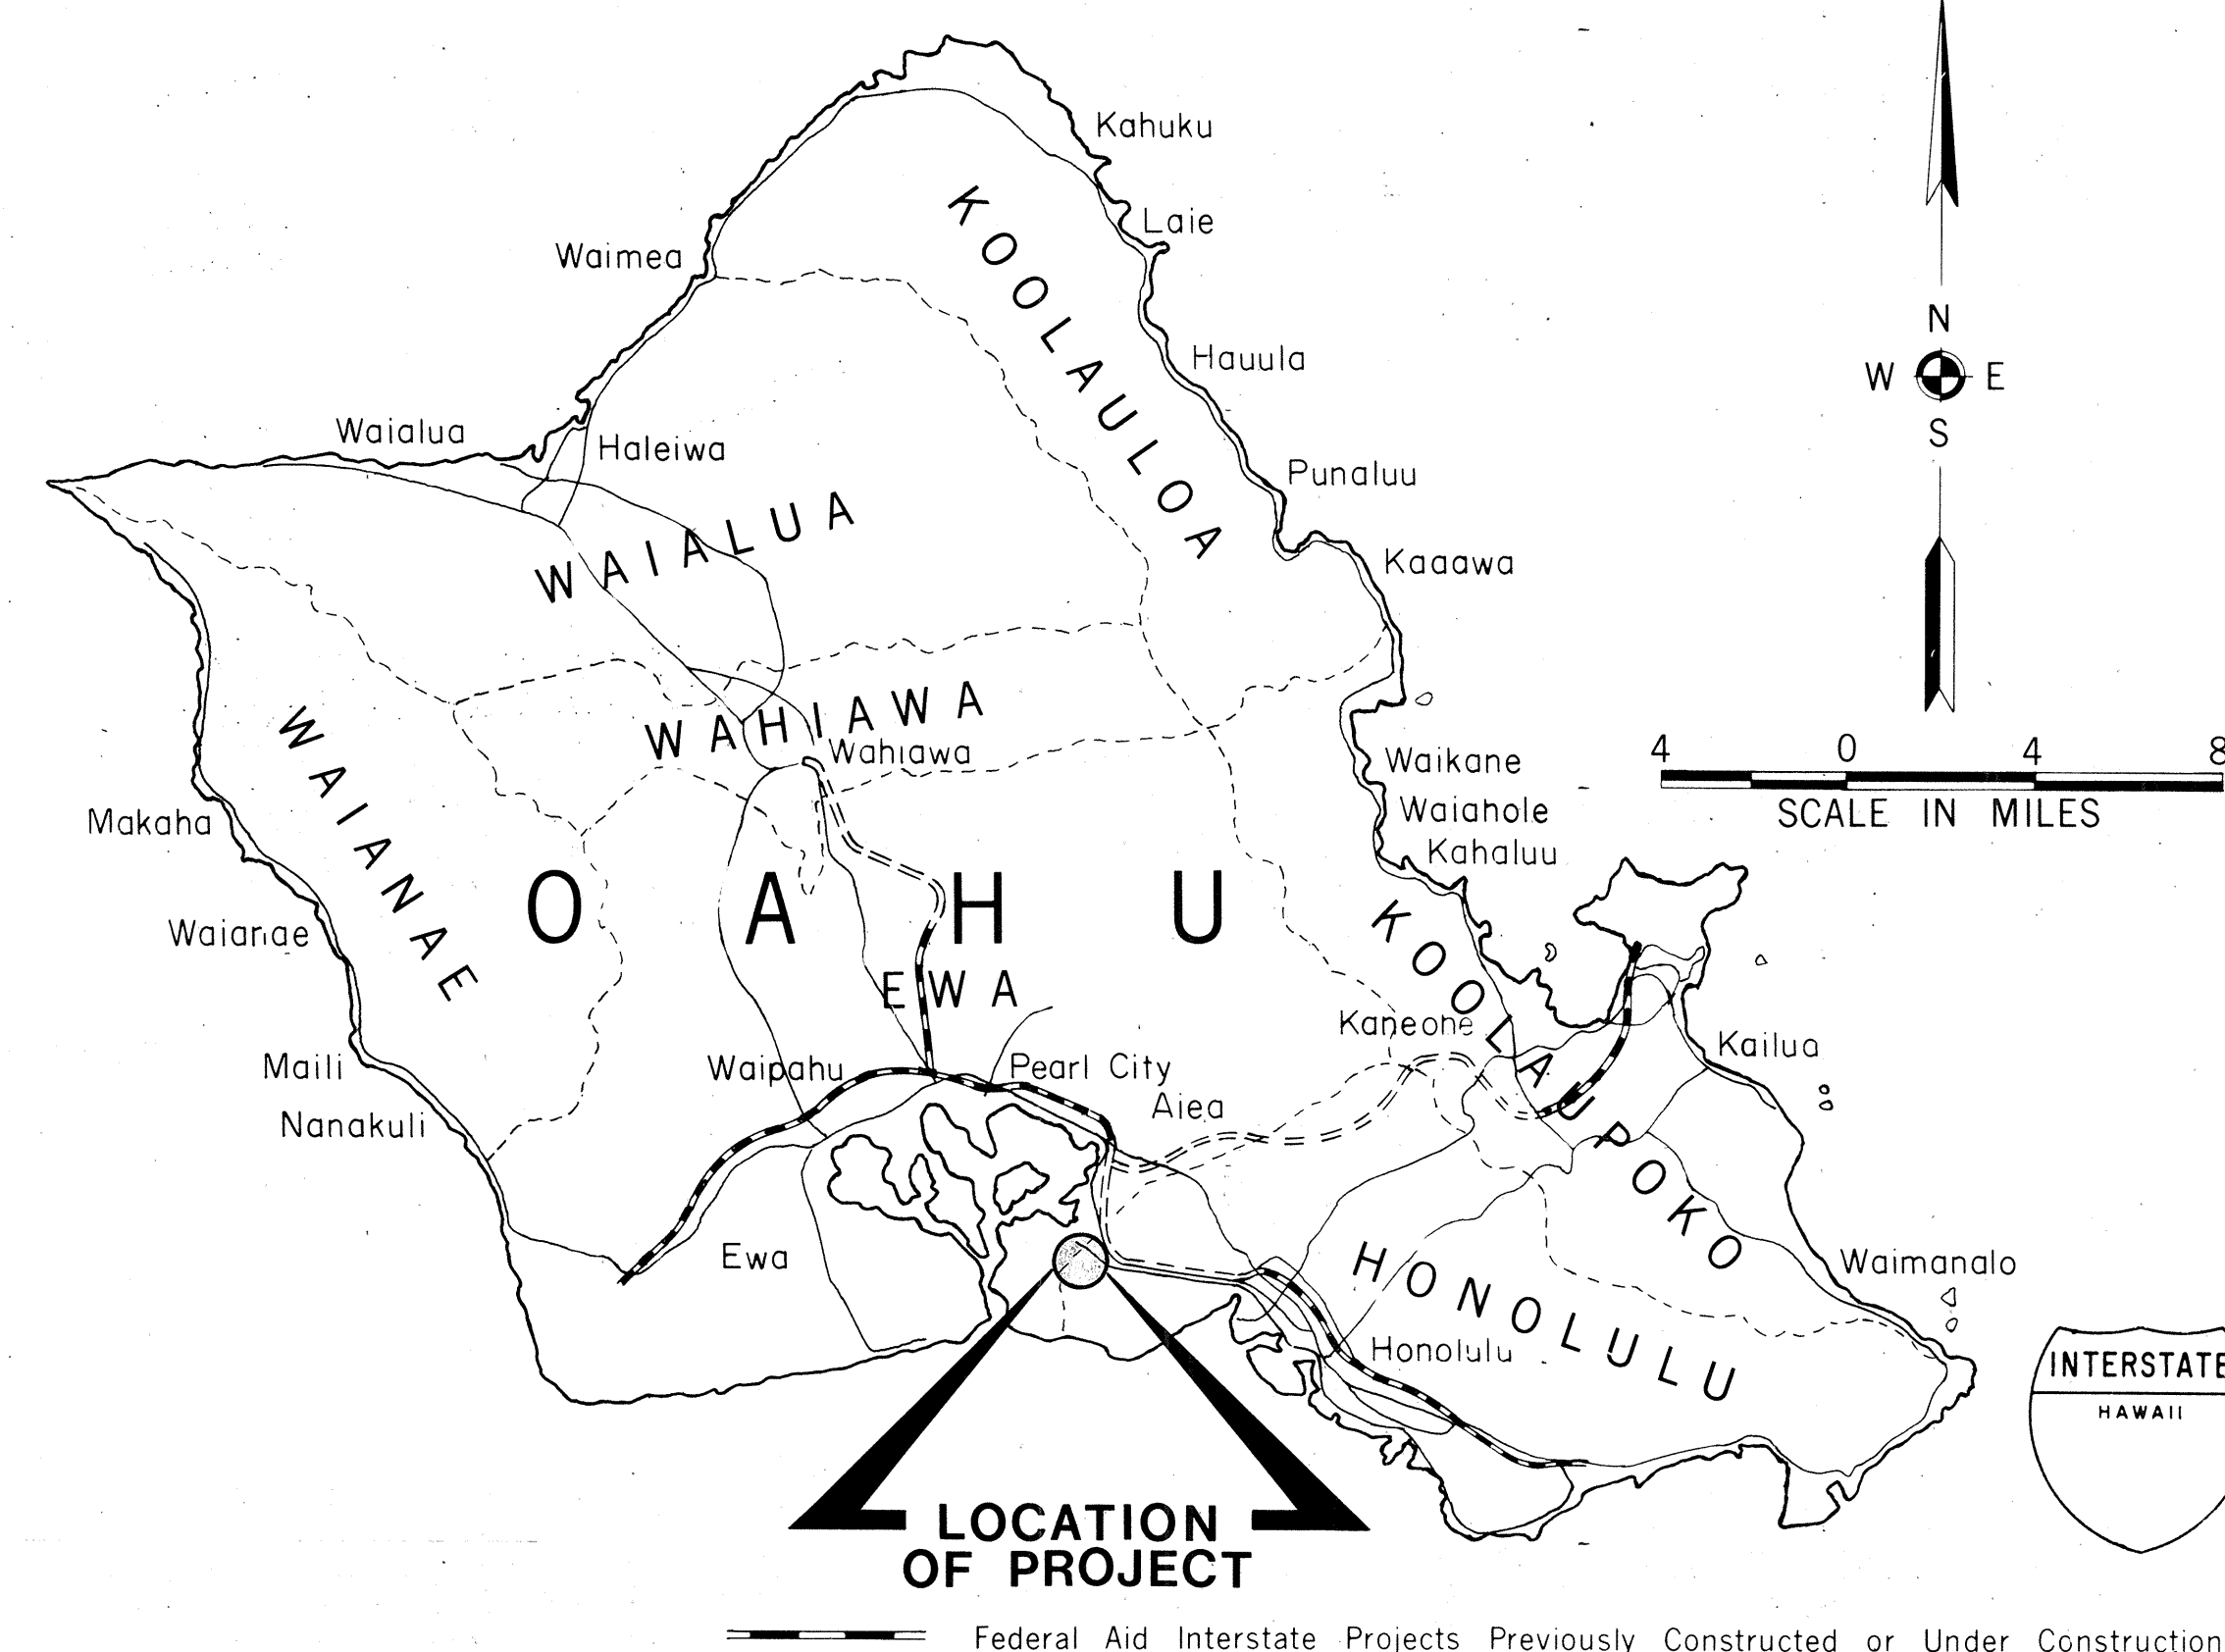

LOCATION
 OF PROJECT

Federal Aid Interstate Projects Previously Constructed or Under Construction

SCALES:

PLANS.....	HOR.	1" = 50'
PROFILES.....	HOR.	1" = 50'
	VER.	1" = 10'
DETAIL ROADWAY PLANS.....	HOR.	1" = 50'
CROSS SECTIONS.....	HOR.	1" = 10'
	VER.	1" = 10'


DESIGN DESIGNATION

DESIGN ADT (1994).....	50,444
DHV.....	7,030
D.....	50/10
T.....	15%
V.....	40 MPH
CONTROL OF ACCESS.....	FULL

CHANGES MADE DURING CONSTRUCTION HAVE
 BEEN INCORPORATED ON THESE PLANS EXCEPT
 CHANGES IN THE ORIGINAL THEORETICAL
 QUANTITIES. FOR ACTUAL QUANTITIES, REFER TO
 PROJECT LEDGER AND/OR COMPUTATION BOOK.

Sam H. Naito
 RESIDENT ENGINEER

1/6/84
 DATE

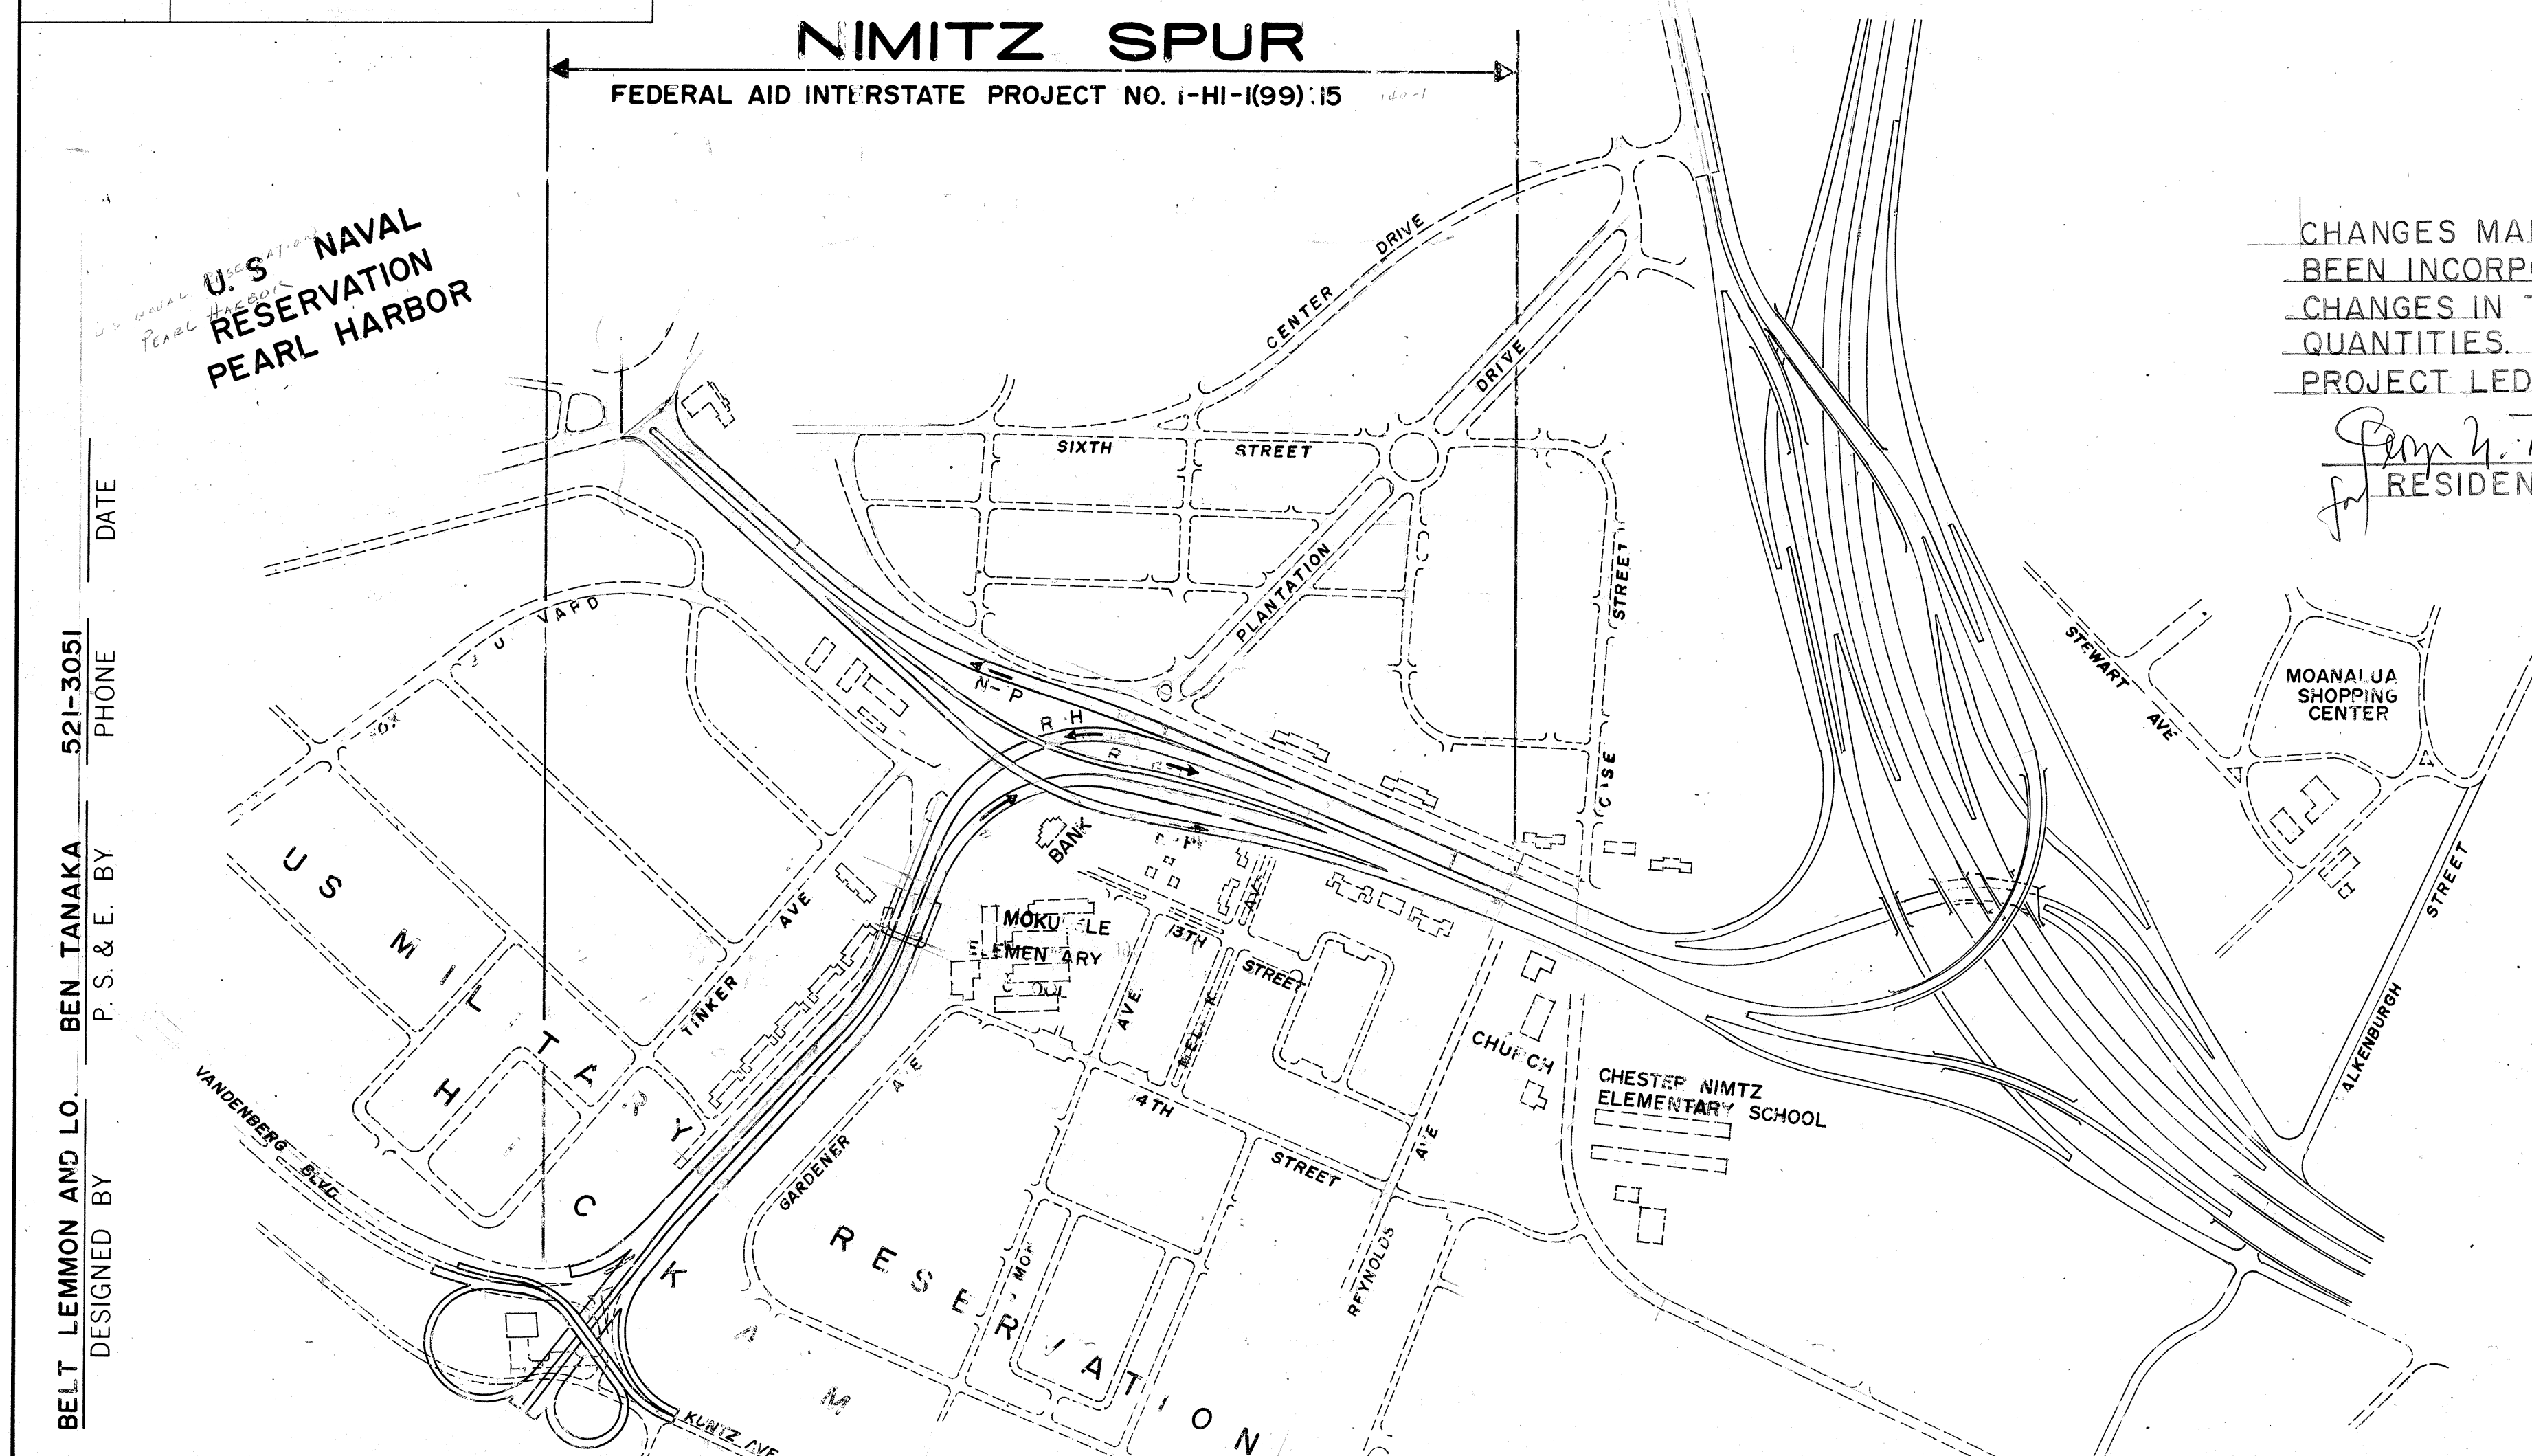

BELT LEMMON AND LO. BEN TANAKA
 DESIGNED BY P.S. & E. BY
 DATE 521-3051 PHONE

DEPARTMENT OF TRANSPORTATION
 FEDERAL HIGHWAY ADMINISTRATION
 APPROVED:
 DIVISION ENGINEER DATE

DEPARTMENT OF TRANSPORTATION
 STATE OF HAWAII
 APPROVED:
 DIR. OF TRANSPORTATION DATE