


FED. ROAD DIST. NO.	STATE	FED. AID PROJ. NO.	FISCAL YEAR	SHEET NO.	TOTAL SHEETS
HAWAII	HAW.	I-HI-1(123)16	1976	107	444

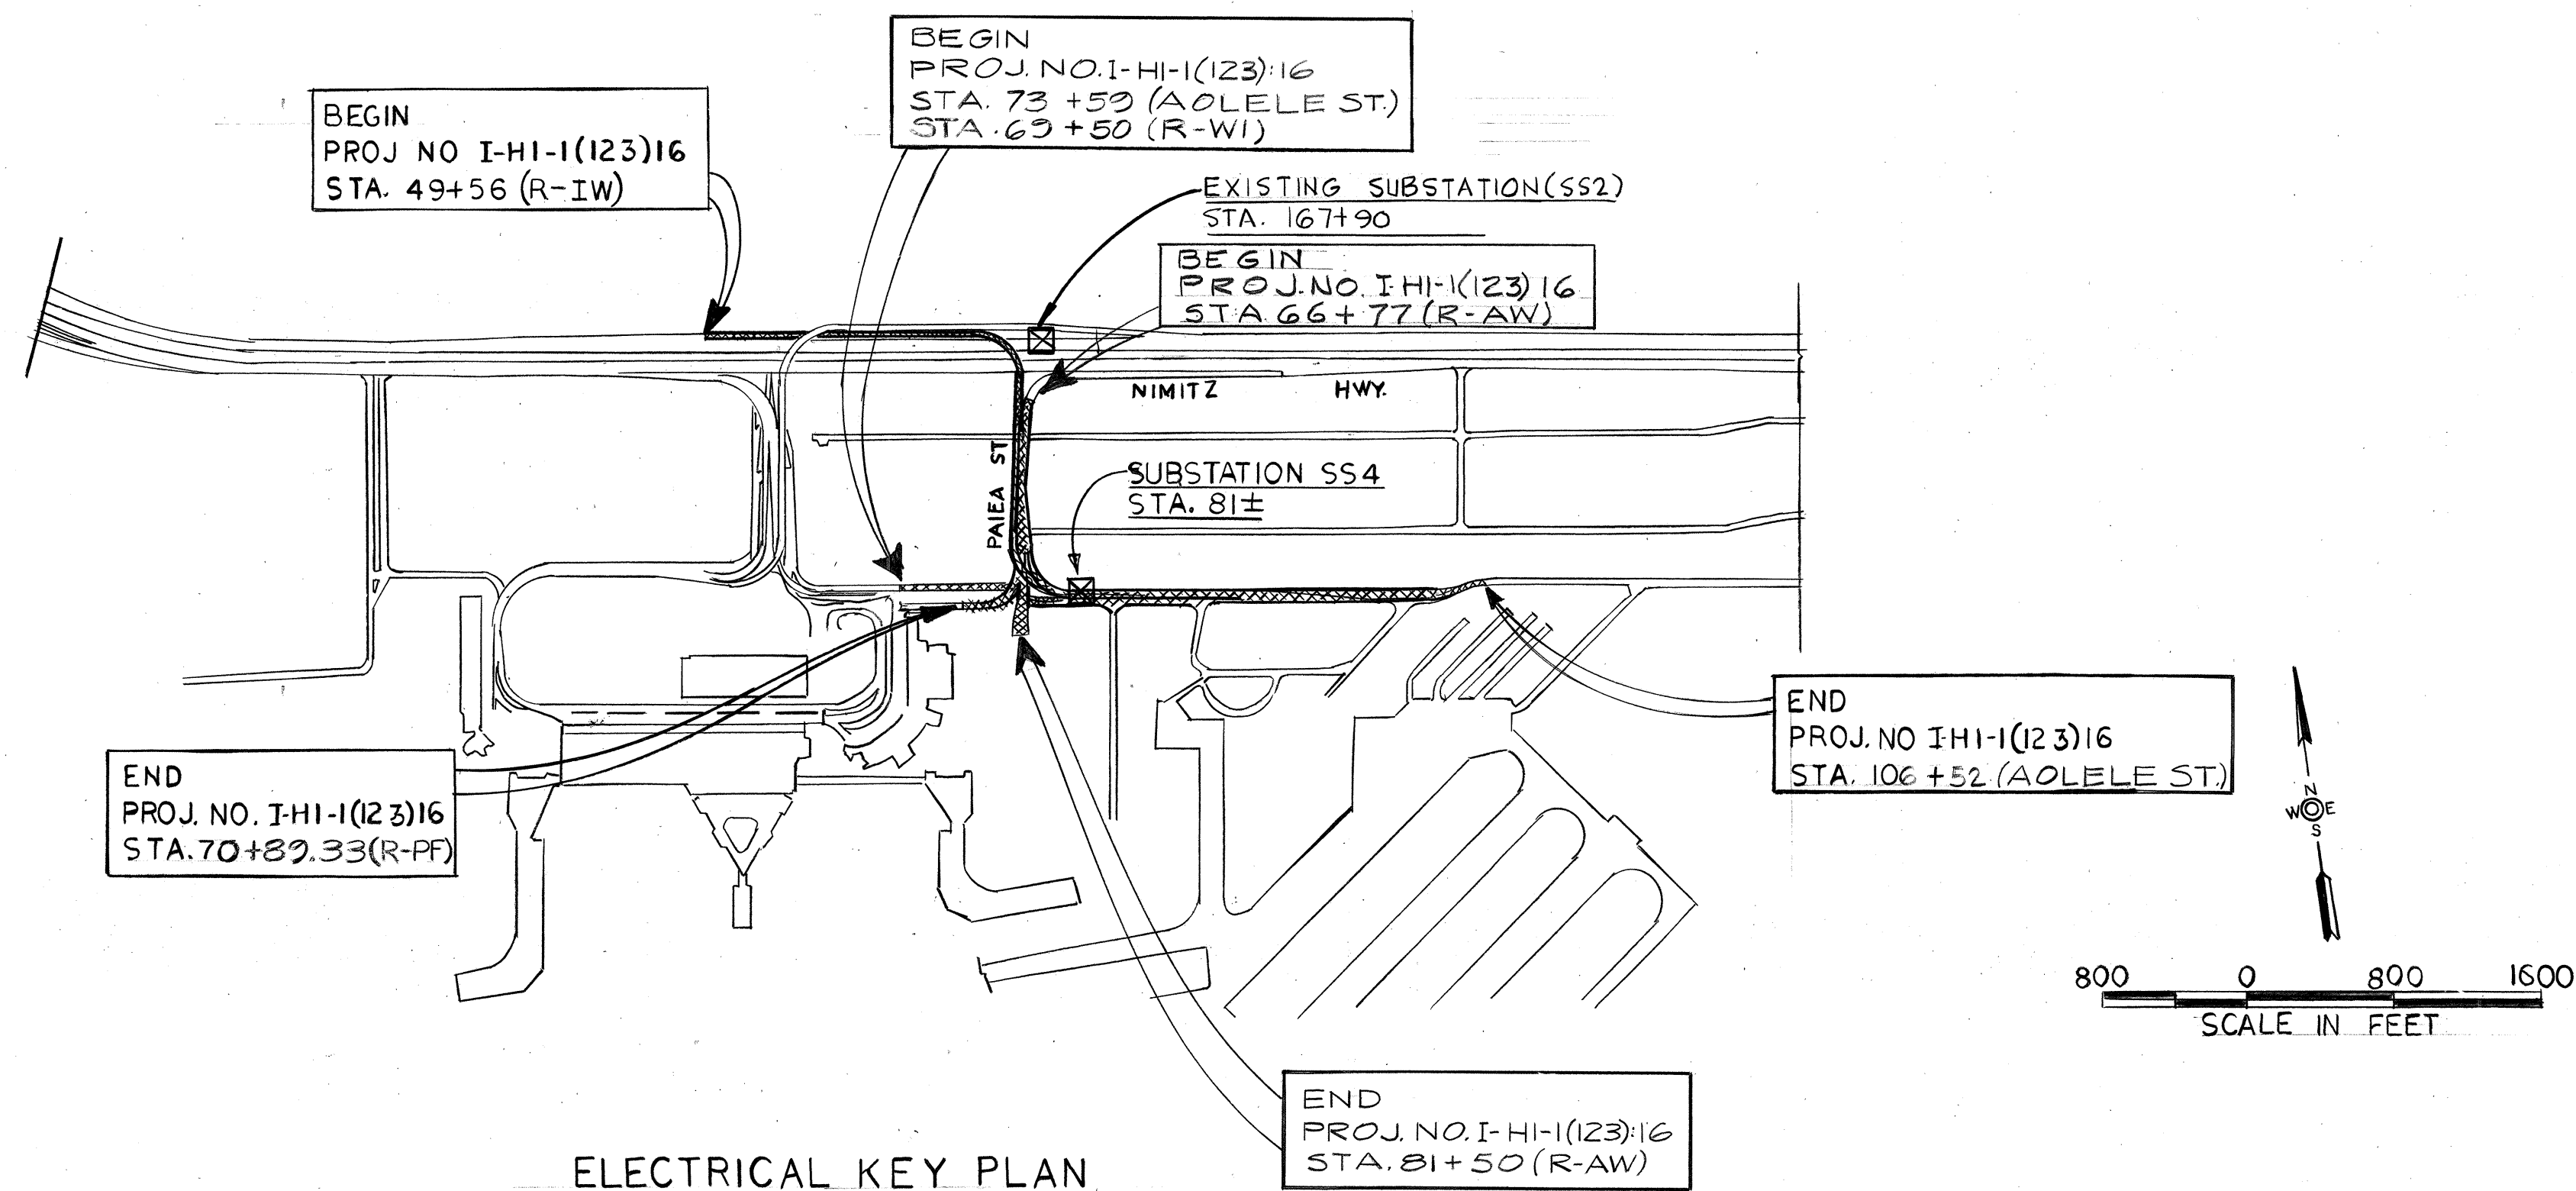

- NOTES:
1. ALL NON-CURRENT CARRYING METALLIC PARTS OF ELECTRICAL EQUIPMENT AND RACEWAYS SHALL BE GROUNDED. ALL NON-METALLIC CONDUIT RUNS SHALL BE PROVIDED WITH A #8 AWG, 600V TW (GREEN) GROUNDING CONDUCTOR.
 2. ALL CONDUITS EMBEDDED IN CONCRETE STRUCTURES AND PASSING THROUGH AN EXPANSION JOINT, SHALL BE INSTALLED WITH EXPANSION COUPLINGS. THE CROSSING OF EXPANSION JOINTS SHALL BE AT A RIGHT ANGLE TO THE JOINT.
 3. THE CONDUIT AND BOX SYSTEM EMBEDDED IN THE CONCRETE STRUCTURE OF RAMP AW-IN FROM STATION 49+56 TO STATION 62+08 IS EXISTING FROM A PREVIOUS CONTRACT. THE LUMINAIRES FOR THIS SECTION OF RAMP SHALL BE FURNISHED AND INSTALLED UNDER THIS CONTRACT.

ELECTRICAL KEY PLAN

LEGEND	
	SUBSTATION
	TRANSFORMER
	METER
	METERING CURRENT TRANSFORMER
	MOLDED CASE CIRCUIT BREAKER
	FUSED DISCONNECT SWITCH
	POLE MOUNTED LUMINAIRE, 30'-0" MTG. HT. 250W. HIGH PRESS. SODIUM LAMP (TYPE R) 480 V.
	WALL MOUNTED LUMINAIRE, 15'-0" MTG. HT. 250W. HIGH PRESSURE SODIUM LAMP (TYPE N) 480 V.
	RAIL MOUNTED LUMINAIRE, CONTINUOUS ROW OF 8'-0" UNITS, 200 MA FLUORESCENT, 277 V.
	RAIL MOUNTED LUMINAIRE, CONTINUOUS ROW OF 8'-0" UNITS 430 MA FLUORESCENT, 277 V.
	JUNCTION BOX
	JUNCTION BOX (EMER. COMM. SYSTEM)
	CONDUIT, DIRECT BURIAL
	CONDUIT, EMBEDDED IN CONCRETE STRUCTURE
	CONDUIT, BELOW GRADE, CONCRETE ENCASED
	EXISTING LIGHTPOLE SUBJECT TO BE RELOCATED FOR TEMPORARY DETOUR LIGHTING.

NO	DATE	REVISION
1	11-11-76	ADD. SYMBOL FOR EXIST. POLE CHANGED AOLELE ST PROJ. LIMITS

STATE OF HAWAII
DEPARTMENT OF TRANSPORTATION
HIGHWAYS DIVISION

ROADWAY LIGHTING ELECTRICAL KEY PLAN AND SYMBOL LIST

AIRPORT INTERCHANGE
F.A.I. PROJ. NO. IHI-1(123) 16
SCALE: AS SHOWN DATE: 8/28/76

SHEET No. E-1 OF 12 SHEETS




THIS WORK WAS PREPARED BY
ME OR UNDER MY SUPERVISION


6-8-78	CHANGED LAMP TYPE FOR WALL MOUNTED LUMINAIRE.
DATE	REVISION

COADD 107

FED. ROAD DIST. NO.	STATE	FED. AID PROJ. NO.	FISCAL YEAR	SHEET NO.	TOTAL SHEETS
HAWAII	HAW.	I-HI-1(123)16	1976	109	444

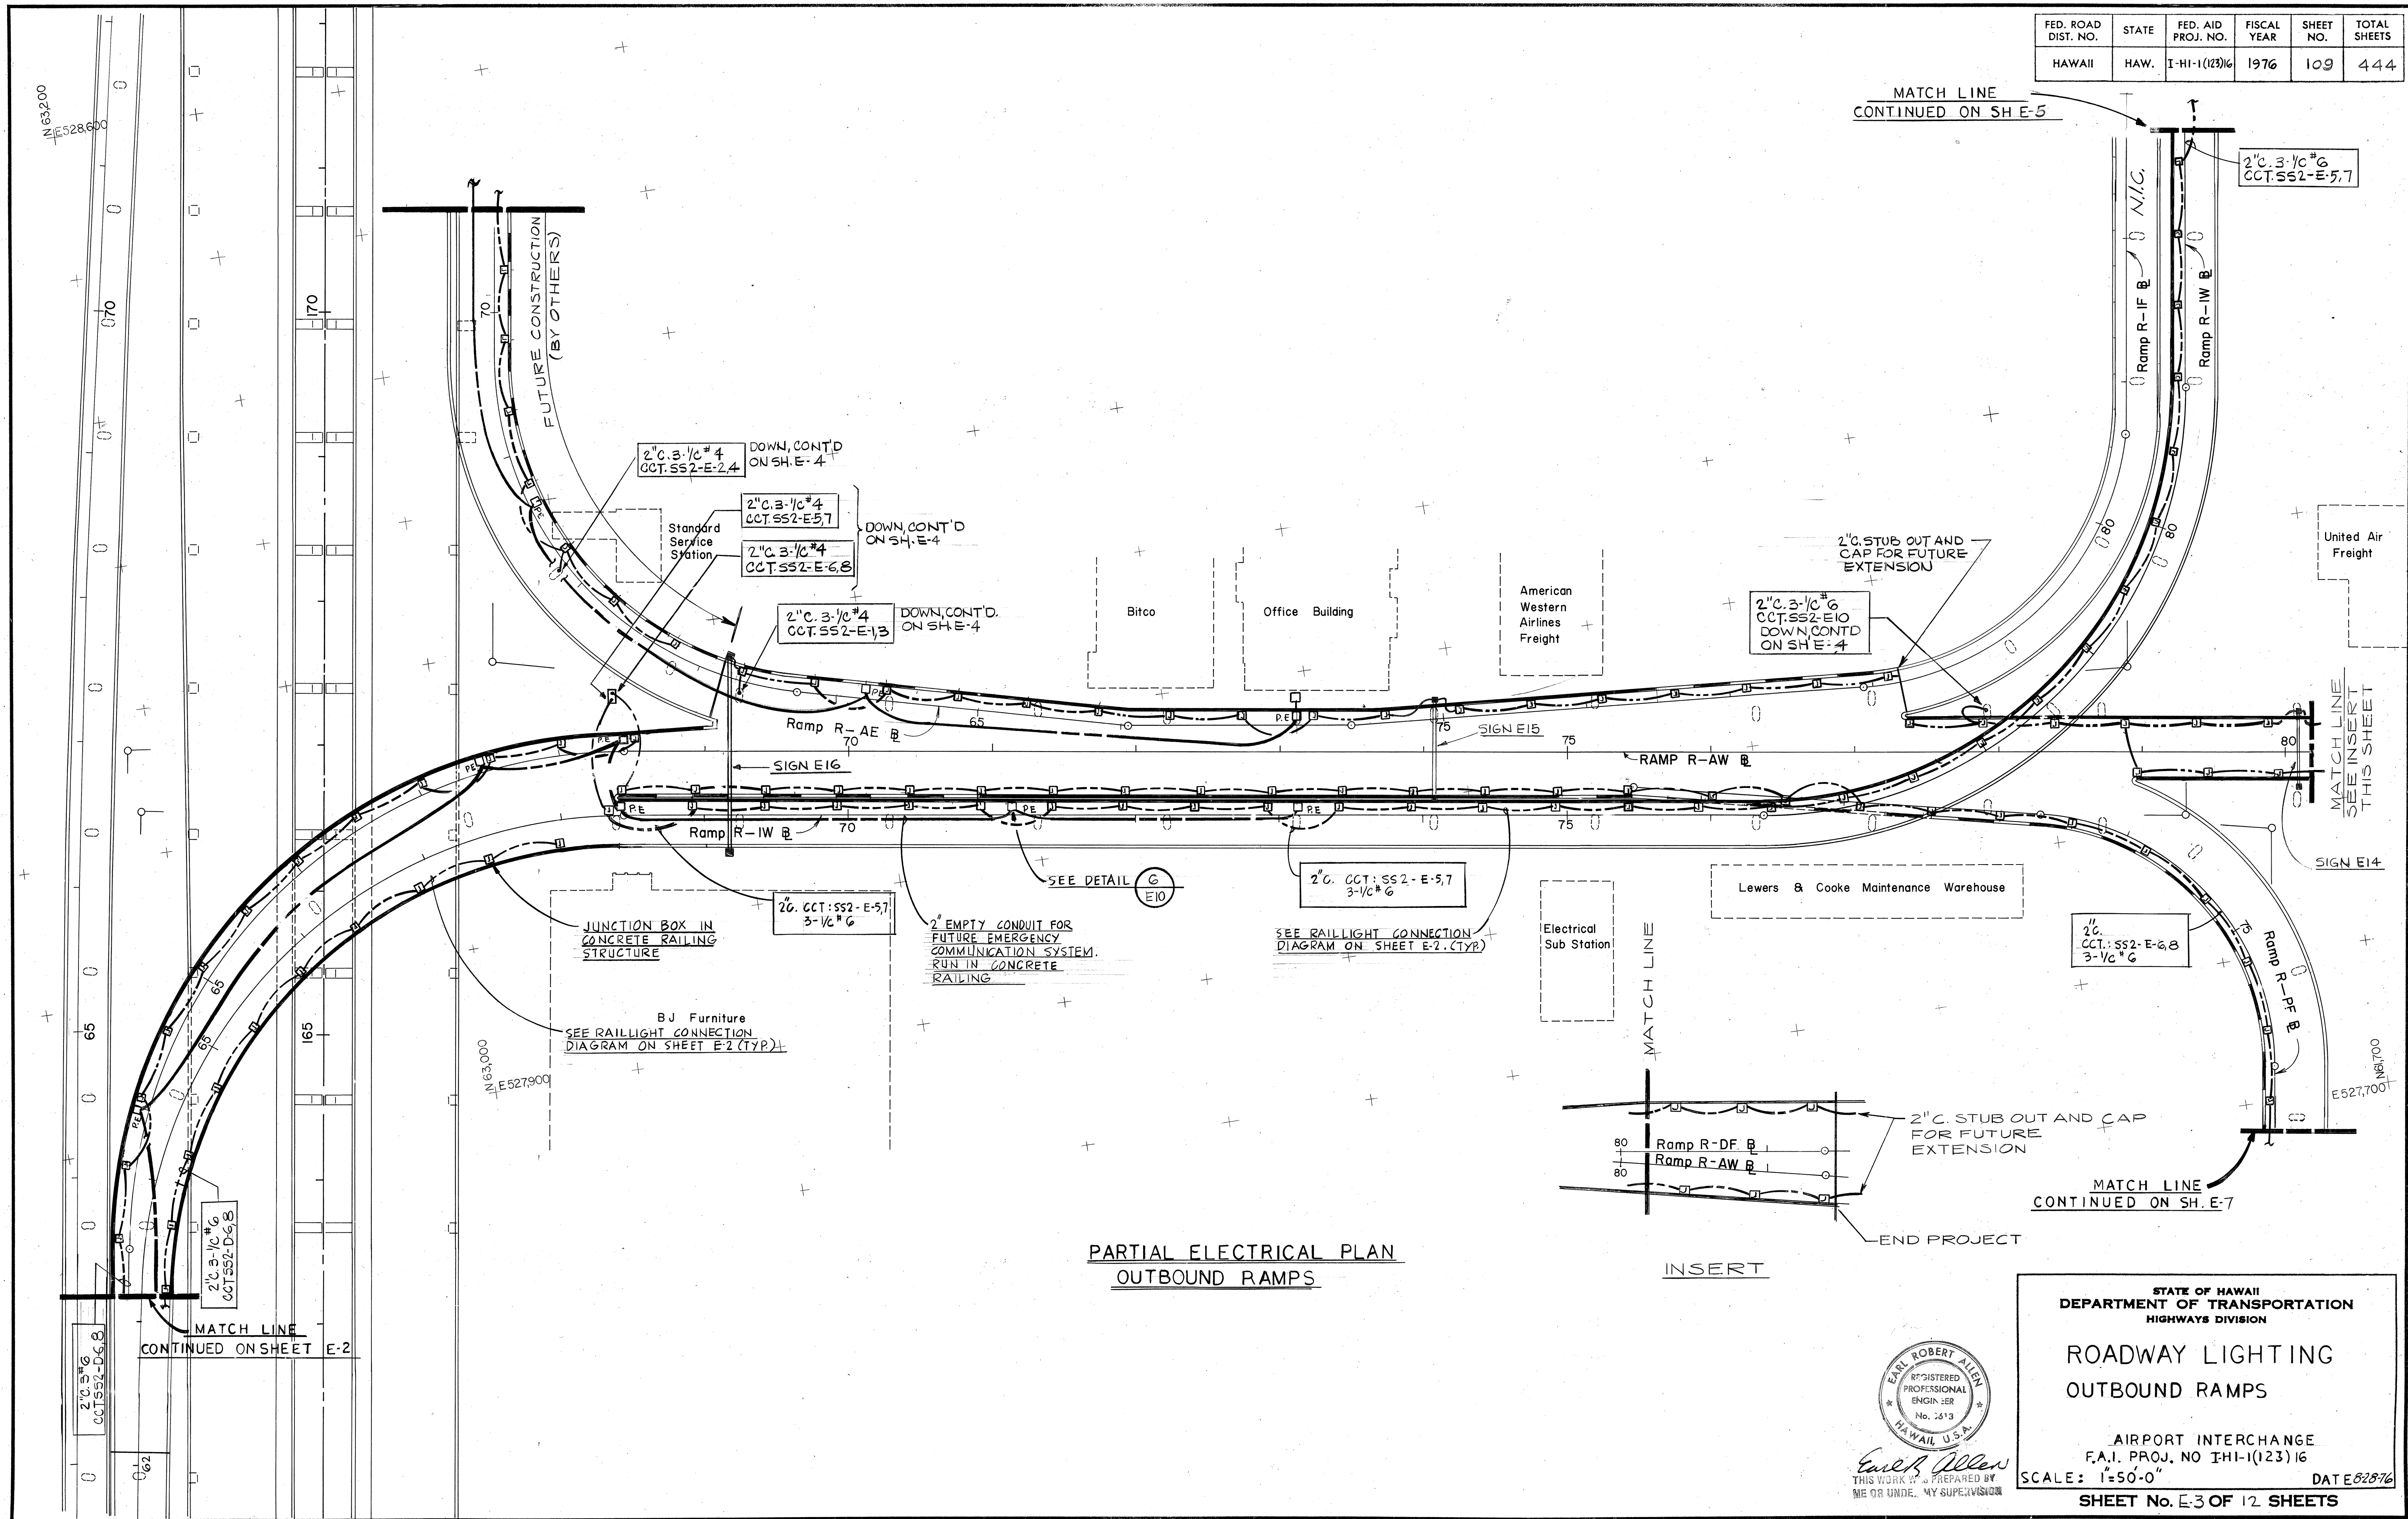


FED. ROAD DIST. NO.	STATE	FED. AID PROJ. NO.	FISCAL YEAR	SHEET NO.	TOTAL SHEETS
HAWAII	HAW.	I-H-1(123)16	1976	110	444

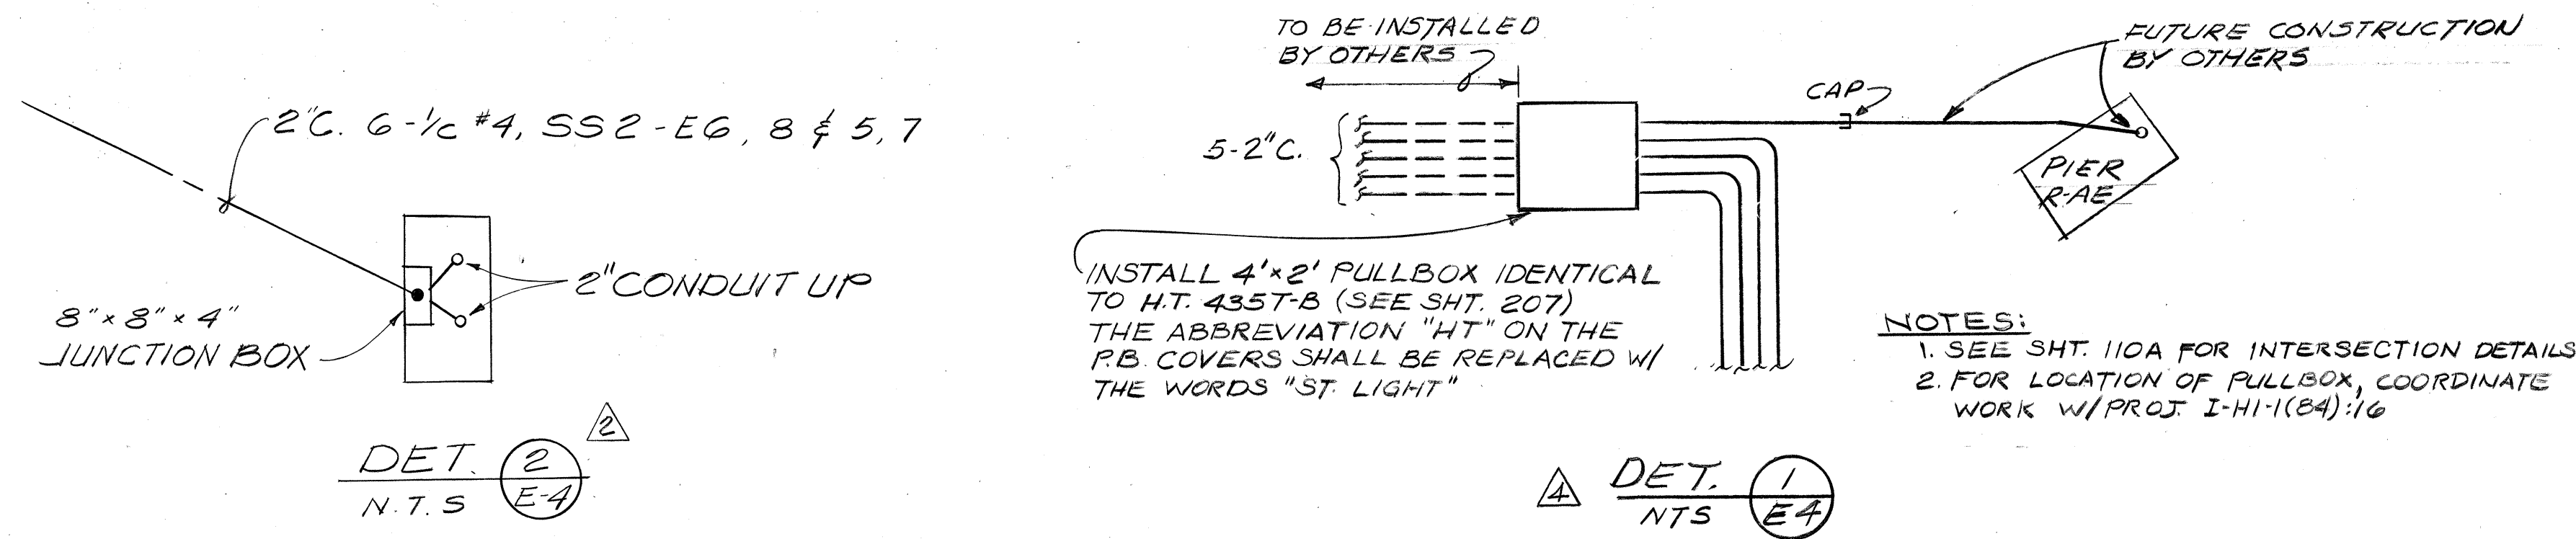


NOTES:
 1. SEE SHT. 110A FOR INTERSECTION DETAILS
 2. FOR LOCATION OF PULLBOX, COORDINATE WORK W/PROJ I-H-1(123)16

PROFILE	DATE
SURVEYED	
GRADES CHECKED	
NOTE BOOK	
NO.	

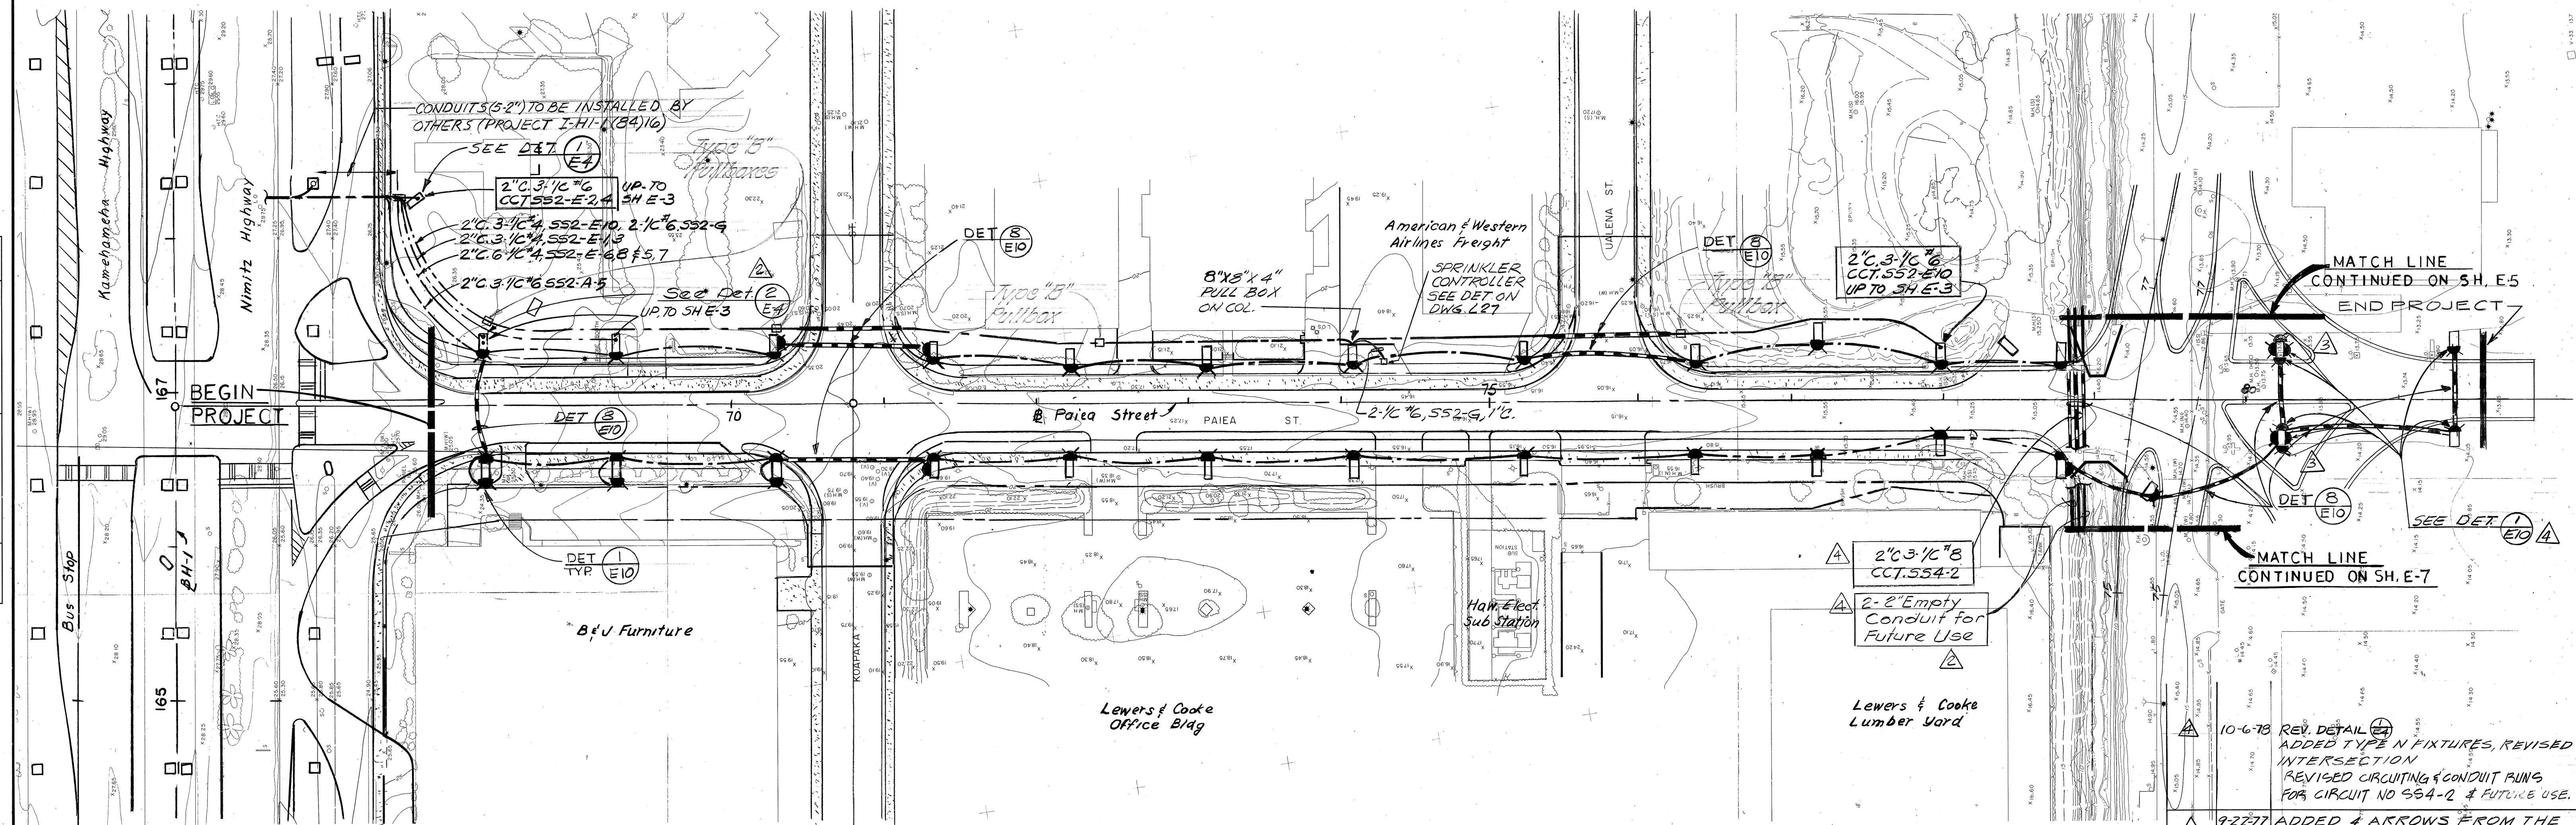

PARTIAL ELECTRICAL PLAN
 PAIEA STREET
 SCALE: 1"=50'

NO.	DATE	REVISION
10-6-78	REV. DETAIL	ADDED TYPE N FIXTURES, REVISED INTERSECTION, REVISED CIRCUITING & CONDUIT RUNS FOR CIRCUIT NO. SS4-2 & FUTURE USE.
9-22-77		ADDED 4 ARROWS FROM THE NOTE "ROUGH-IN ONLY FOR FUTURE TYPE N FIXTURES" TO PIER AT 80+17.
9-9-77		ADDED 2" CONDUIT FOR FUTURE USE AND DET. 2.
11-11-76		REVISED PAIEA-POOLE INTERSECTION

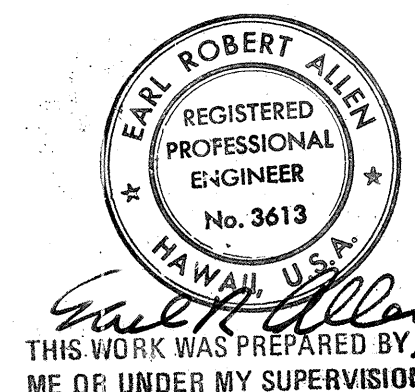

STATE OF HAWAII
 DEPARTMENT OF TRANSPORTATION
 HIGHWAYS DIVISION


ROADWAY LIGHTING
 GRADE

AIRPORT INTERCHANGE
 E.A.I. PROJ. NO. I-H-1(123)16
 SCALE: AS SHOWN DATE: 8-28-76
 SHEET No. E-4 OF 12 SHEETS

CO ADD 110


CONT. 6

FED. ROAD DIST. NO.	STATE	FED. AID PROJ. NO.	FISCAL YEAR	SHEET NO.	TOTAL SHEETS
HAWAII	HAW.	I-H-1(123)6	1976	114	444

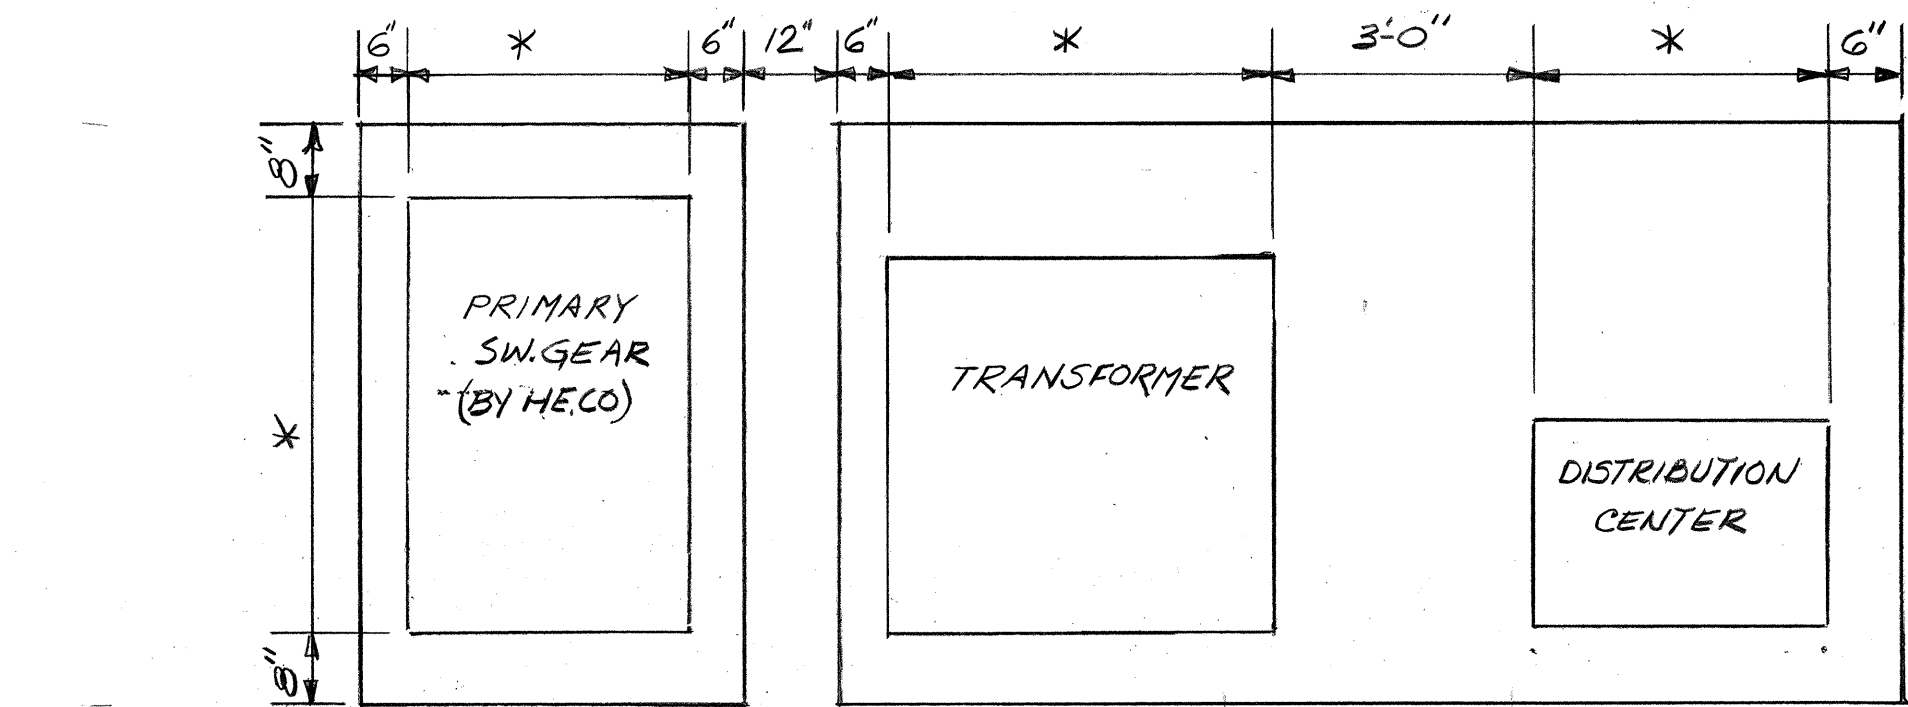

* DIMENSION DETERMINED BY EQUIPMENT DIMENSIONS


PLAN

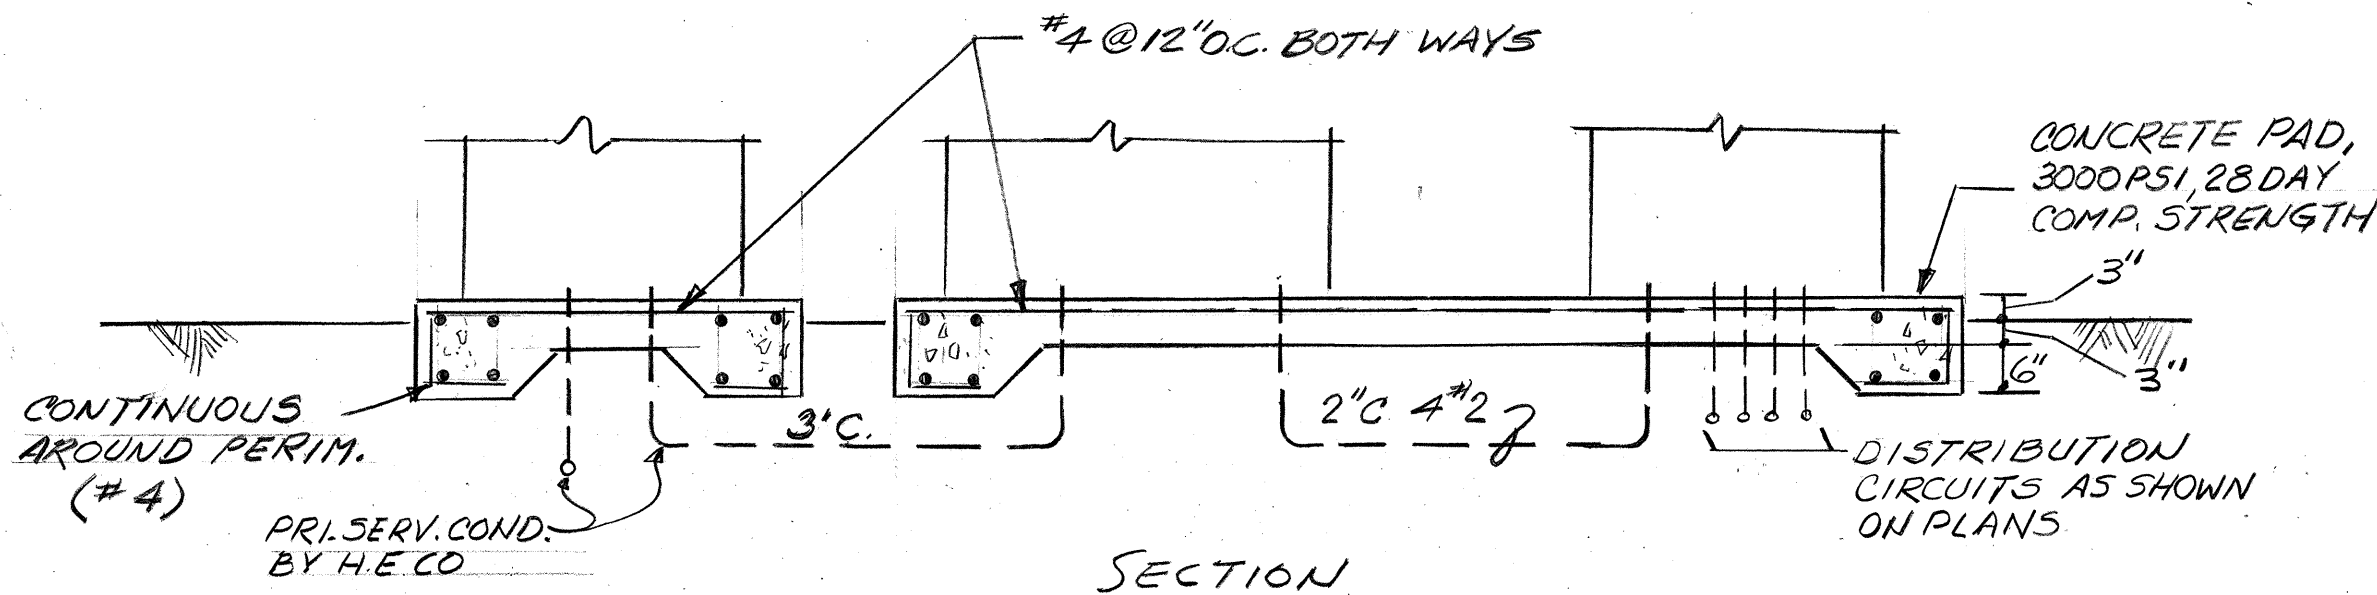


SECTION

NOTES:
1. DISTURBED SOIL SHALL BE COMPACTED TO ORIGINAL DENSITY BEFORE PLACING PAD.

DET. 1
1/2" = 1'-0" E8

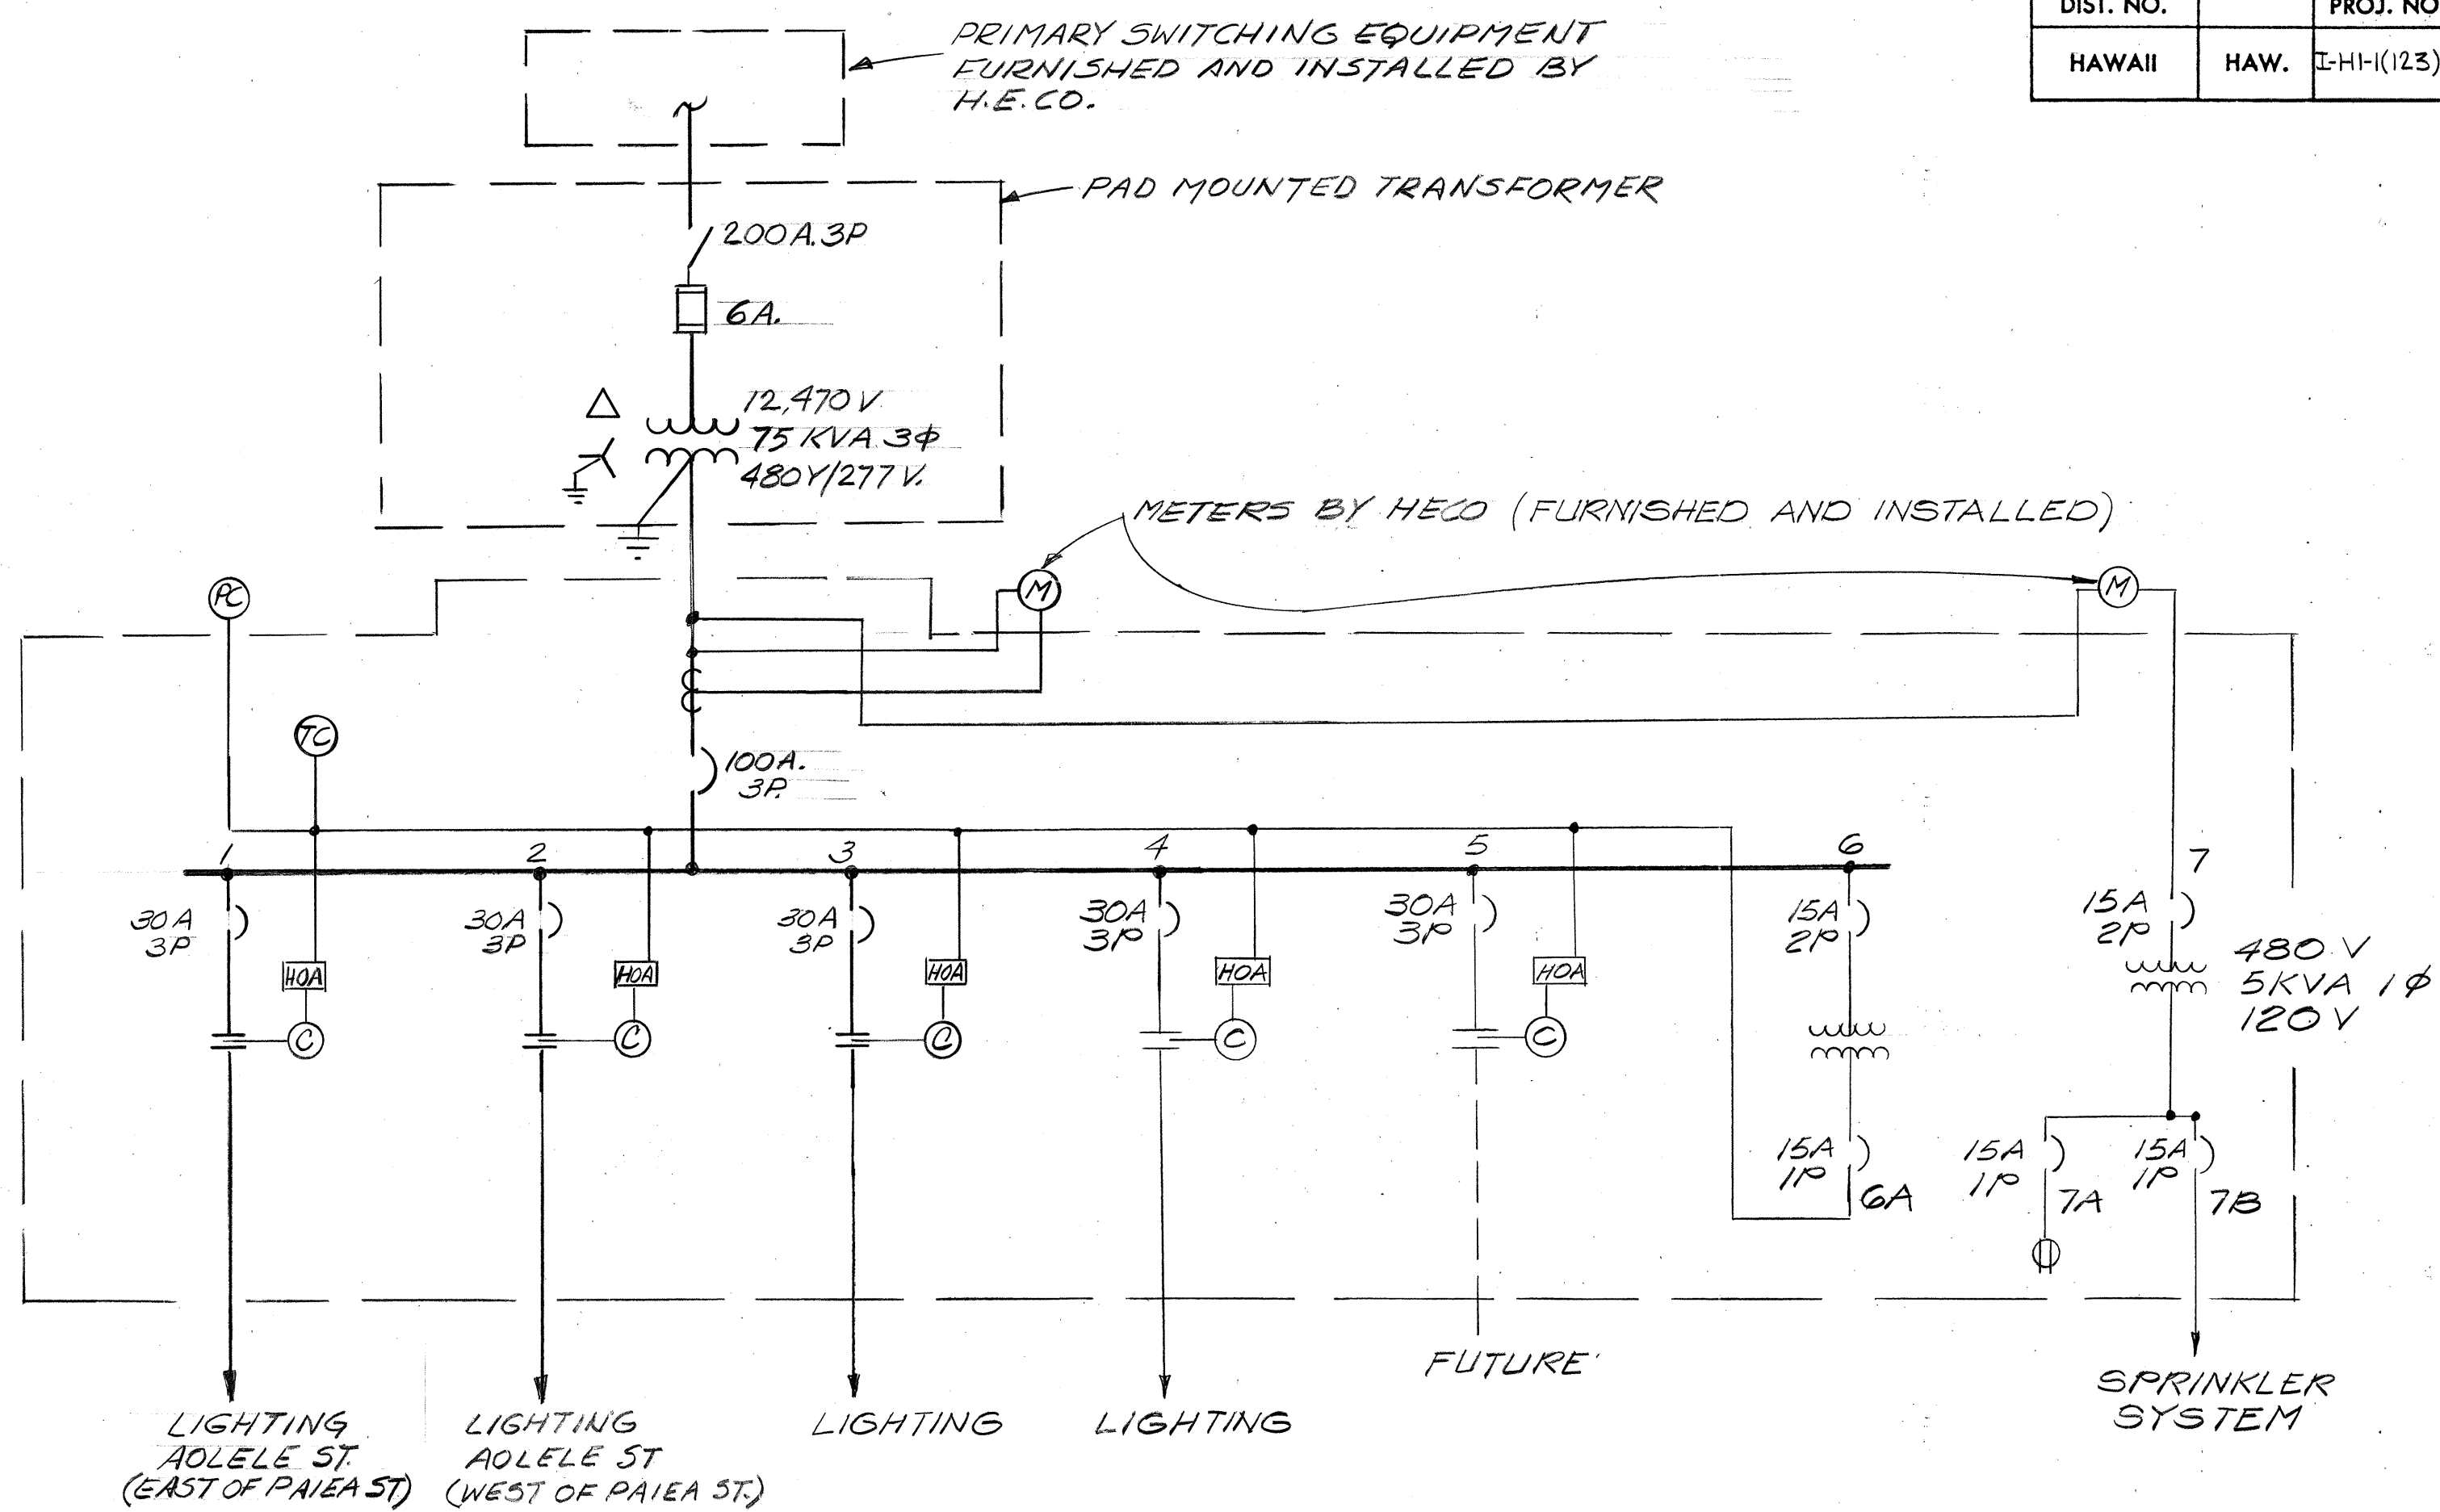

SUBSTATION SS4
SINGLE LINE DIAGRAM
N.T.S.

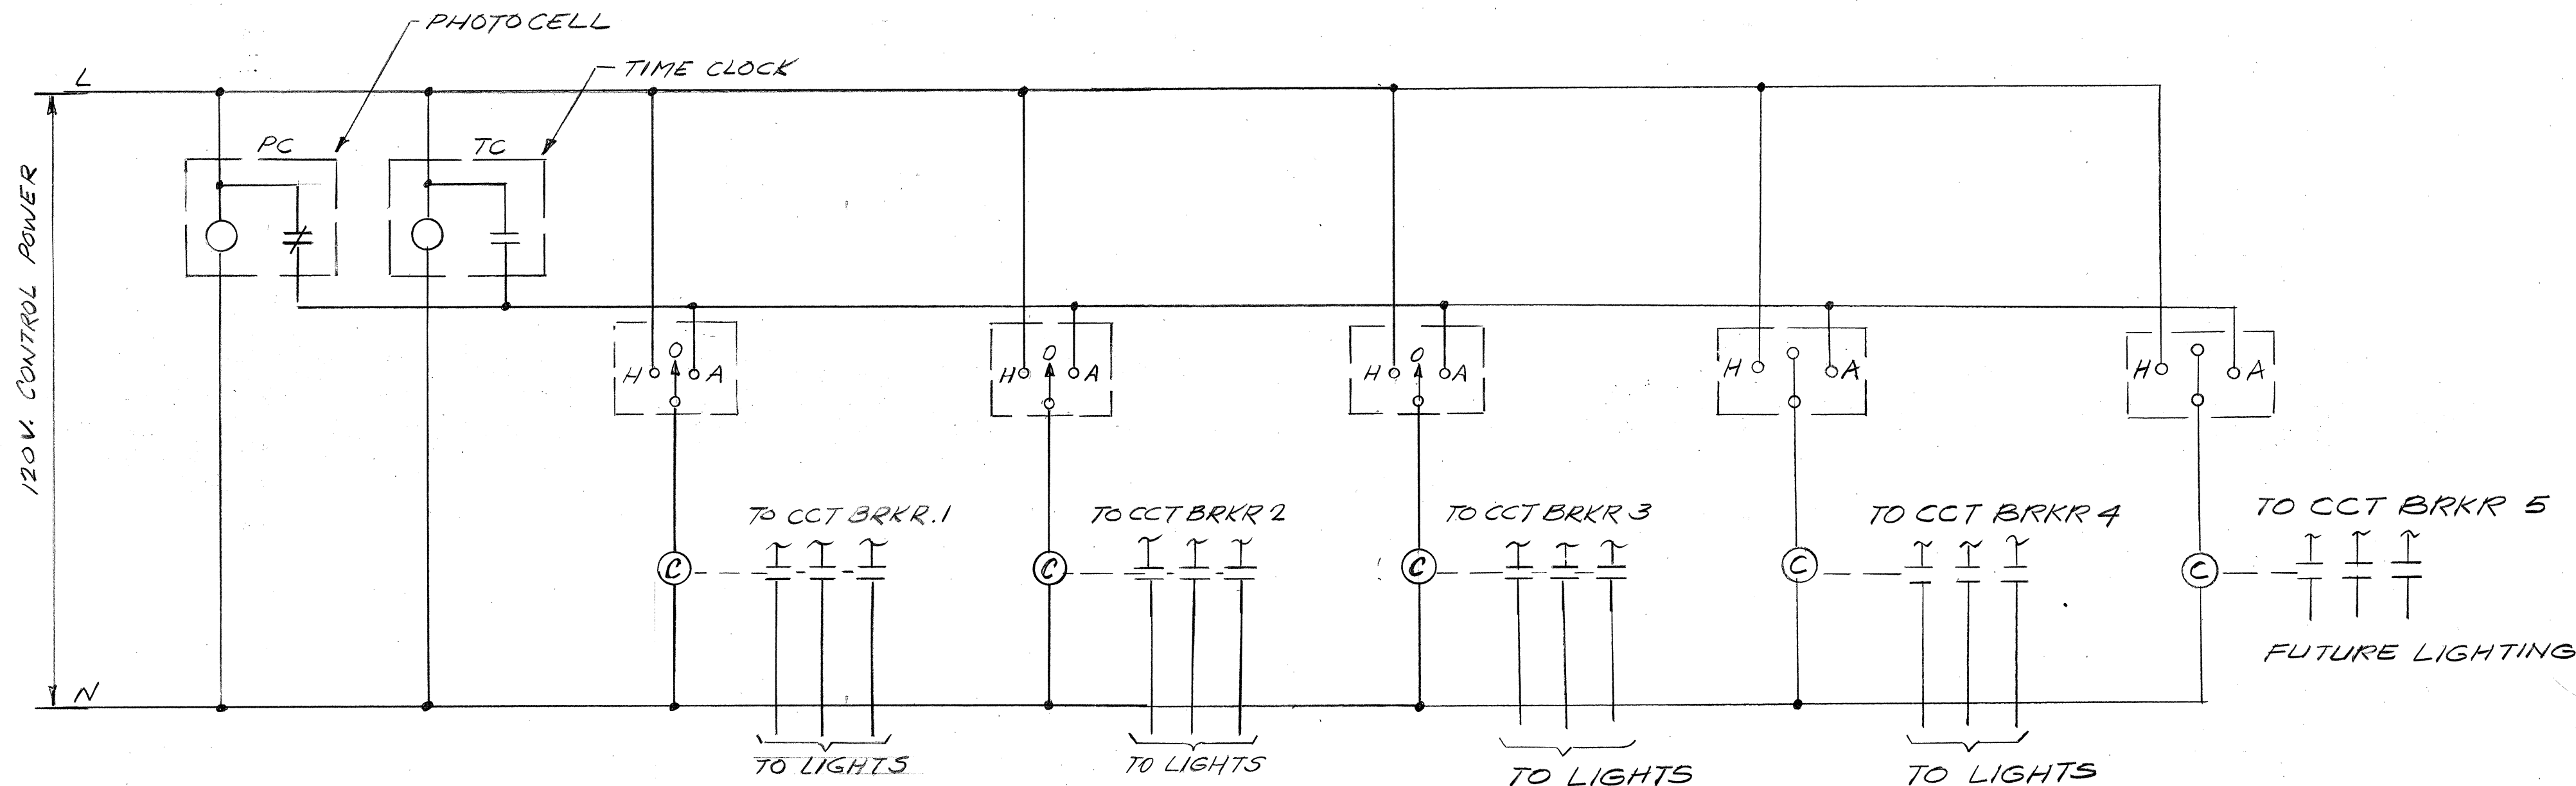

CONTROL SCHEMATIC
N.T.S.

NO.	DATE	REVISION
1	7-7-77	Revised Single Line Diagram and Control Schematic

STATE OF HAWAII

DEPARTMENT OF TRANSPORTATION

HIGHWAYS DIVISION

ROADWAY LIGHTING

SUBSTATION SS4


AIROPOR INTERCHANGE

FAI PROJ NO I-H-1(123)16

SCALE: AS NOTED


DATE: 8-28-76

SHEET No. 13 OF 12 SHEETS

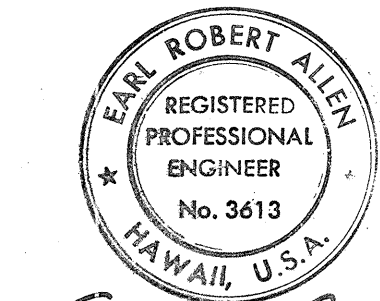


THIS WORK WAS PREPARED BY
ME OR UNDER MY SUPERVISION

FED. ROAD DIST. NO.	STATE	FED. AID PROJ. NO.	FISCAL YEAR	SHEET NO.	TOTAL SHEETS
HAWAII	HAW.	I-HI-1(123)16	1976	115	444

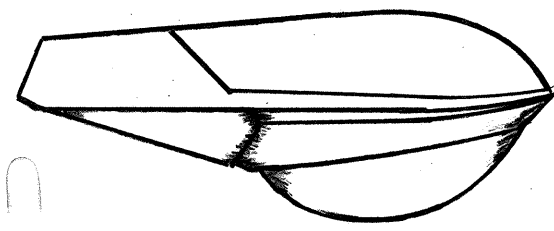


TYPE R FIXTURE

MOUNTING HEIGHT : 30'
WATTAGE : 250W
LAMP : LU 250/BD, E-18 BULB
LUMENS @ INITIAL : 25,500 LUMENS

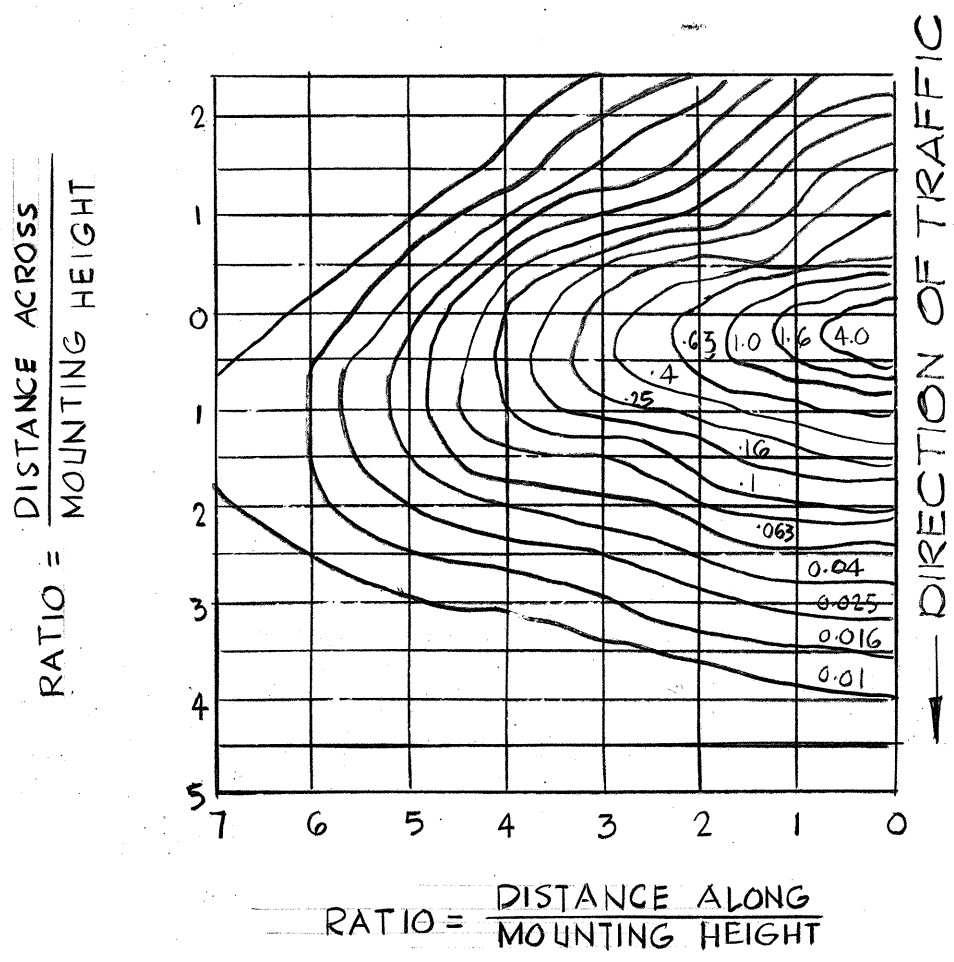


ISOFOOTCANDLE DIAGRAM

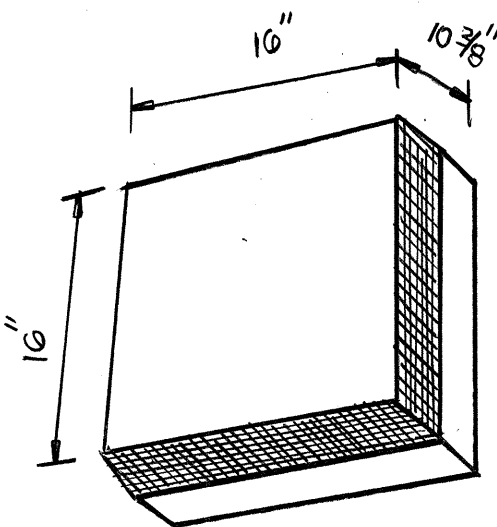


TYPE N FIXTURE

WALL MOUNTED LUMINAIRE
MOUNTING HEIGHT : 15'
WATTAGE : 250W
LAMP : LU-250 (HPS)
LUMENS @ INITIAL : 30,000 LUMENS
SHIELDED ONE SIDE

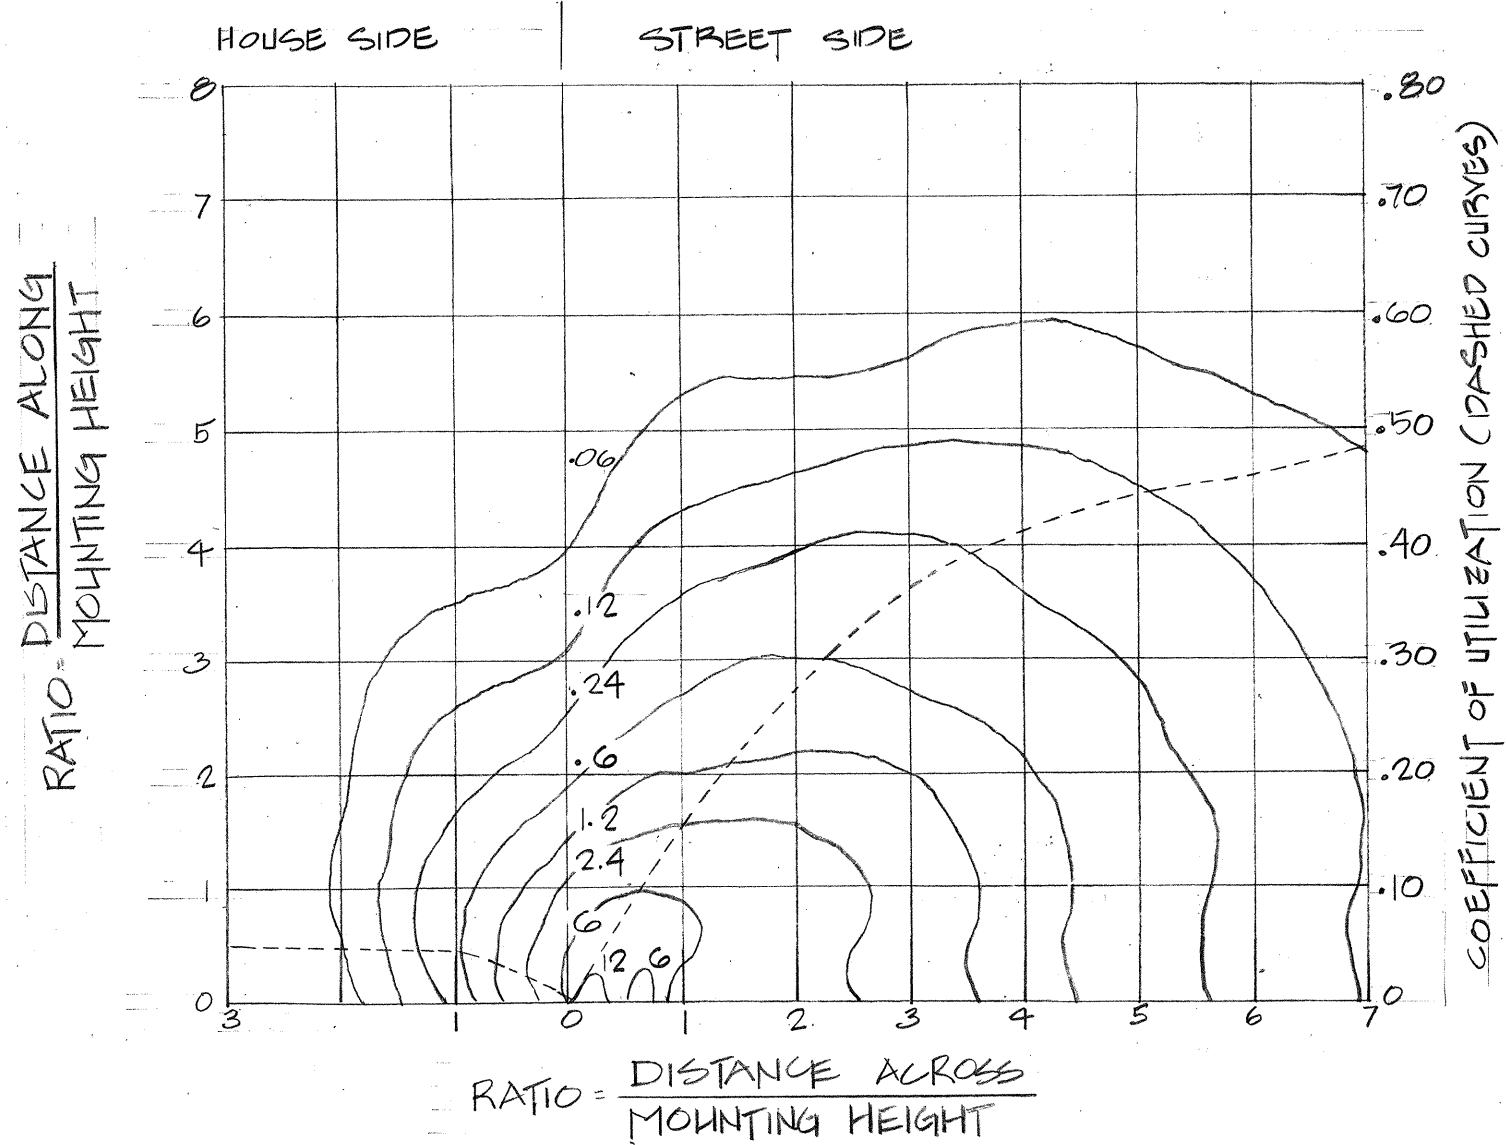


ISOFOOTCANDLE DIAGRAM

- NOTES:
1. CONTRACTOR, AT HIS OPTION, MAY REPLACE EXISTING LUMINAIRES, WITH NEW LUMINAIRES OR REPLACE BALLASTS, OPTICAL ASSEMBLIES AND LAMPS, WHICHEVER IS LESS EXPENSIVE.
 2. IF EXISTING LUMINAIRES ARE REPLACED, RETURN EXISTING LUMINAIRES TO STATE OF HAWAII. IF PARTS ARE REPLACED, RETURN REMOVED PARTS TO STATE OF HAWAII.

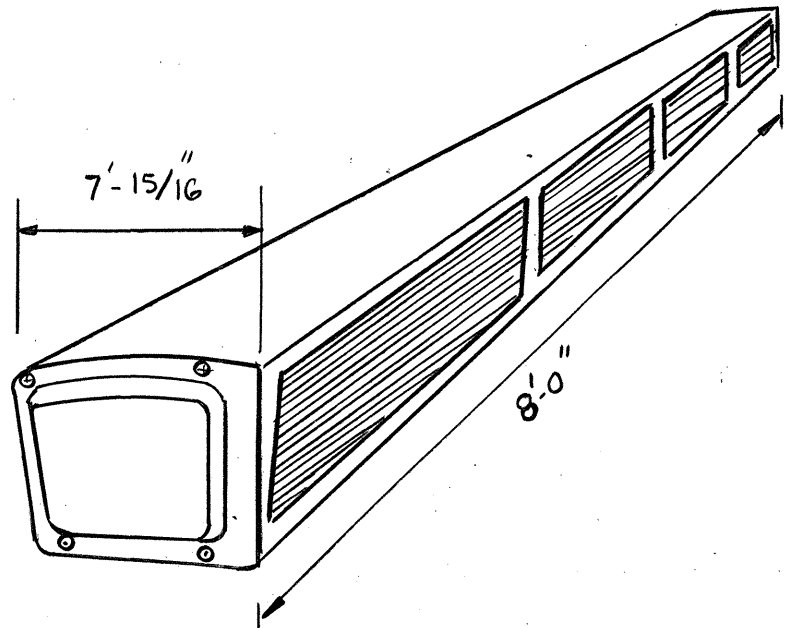


TYPE T2 FIXTURE

GUARDRAIL MOUNTING LUMINAIRE
MOUNTING HEIGHT : 33" TO CENTERLINE
WATTAGE : 430MA-14.0W/FT
LAMP : FA96-T12/CW/HO-30°

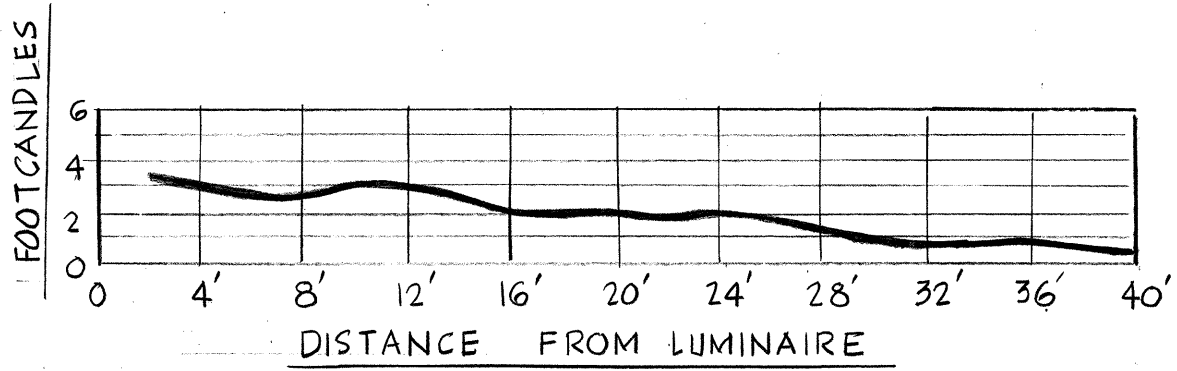


HORIZONTAL FOOTCANDLES ON PAVEMENT
FIXTURE WITH 430 MA BALLAST
CONTINUOUS ROW ON ONE SIDE

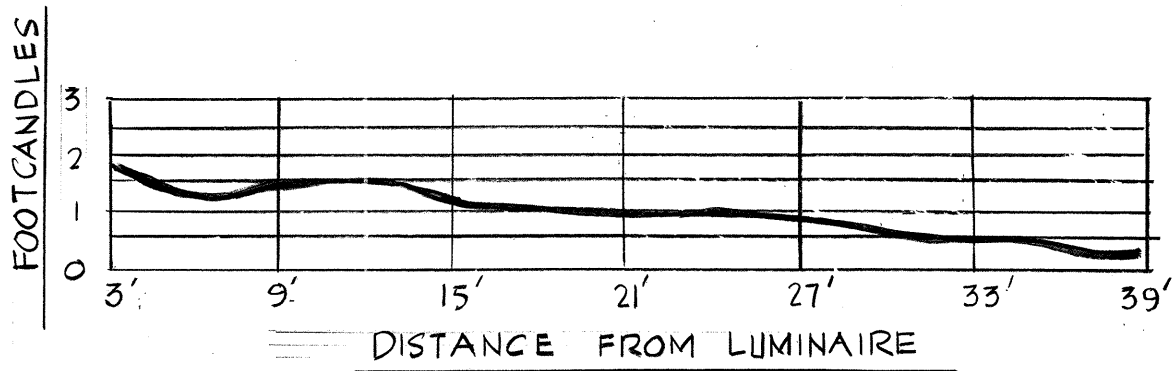

HORIZONTAL FOOTCANDLES ON PAVEMENT
FIXTURES WITH 200MA BALLAST
CONTINUOUS ROW ON ONE SIDE

6-8-78	CHANGED LAMP & ISOCANDLE DIAGRAM FOR LUMINAIRE TYPE 'N' ADDED NOTES
DATE	REVISION

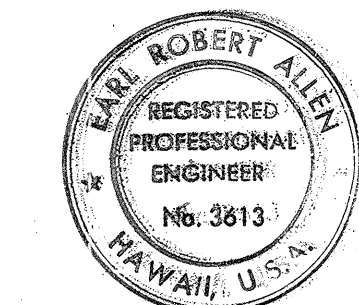

THIS WORK WAS PREPARED BY
ME OR UNDER MY SUPERVISION
ME: EARL ROBERT ALLEN, P.E.
DATE: 6-8-78


STATE OF HAWAII
DEPARTMENT OF TRANSPORTATION
HIGHWAYS DIVISION

ROADWAY LIGHTING
DETAILS











AIRPORT INTERCHANGE
F.A.I. PROJ. NO. IHI-1(123) 16
SCALE: NONE
SHEET No. E-9 OF 12 SHEETS

DATE: 8-28-76


FED. ROAD DIST. NO.	STATE	FED. AID PROJ. NO.	FISCAL YEAR	SHEET NO.	TOTAL SHEETS
HAWAII	HAW.	I-H-1(123)16	1976	116	444

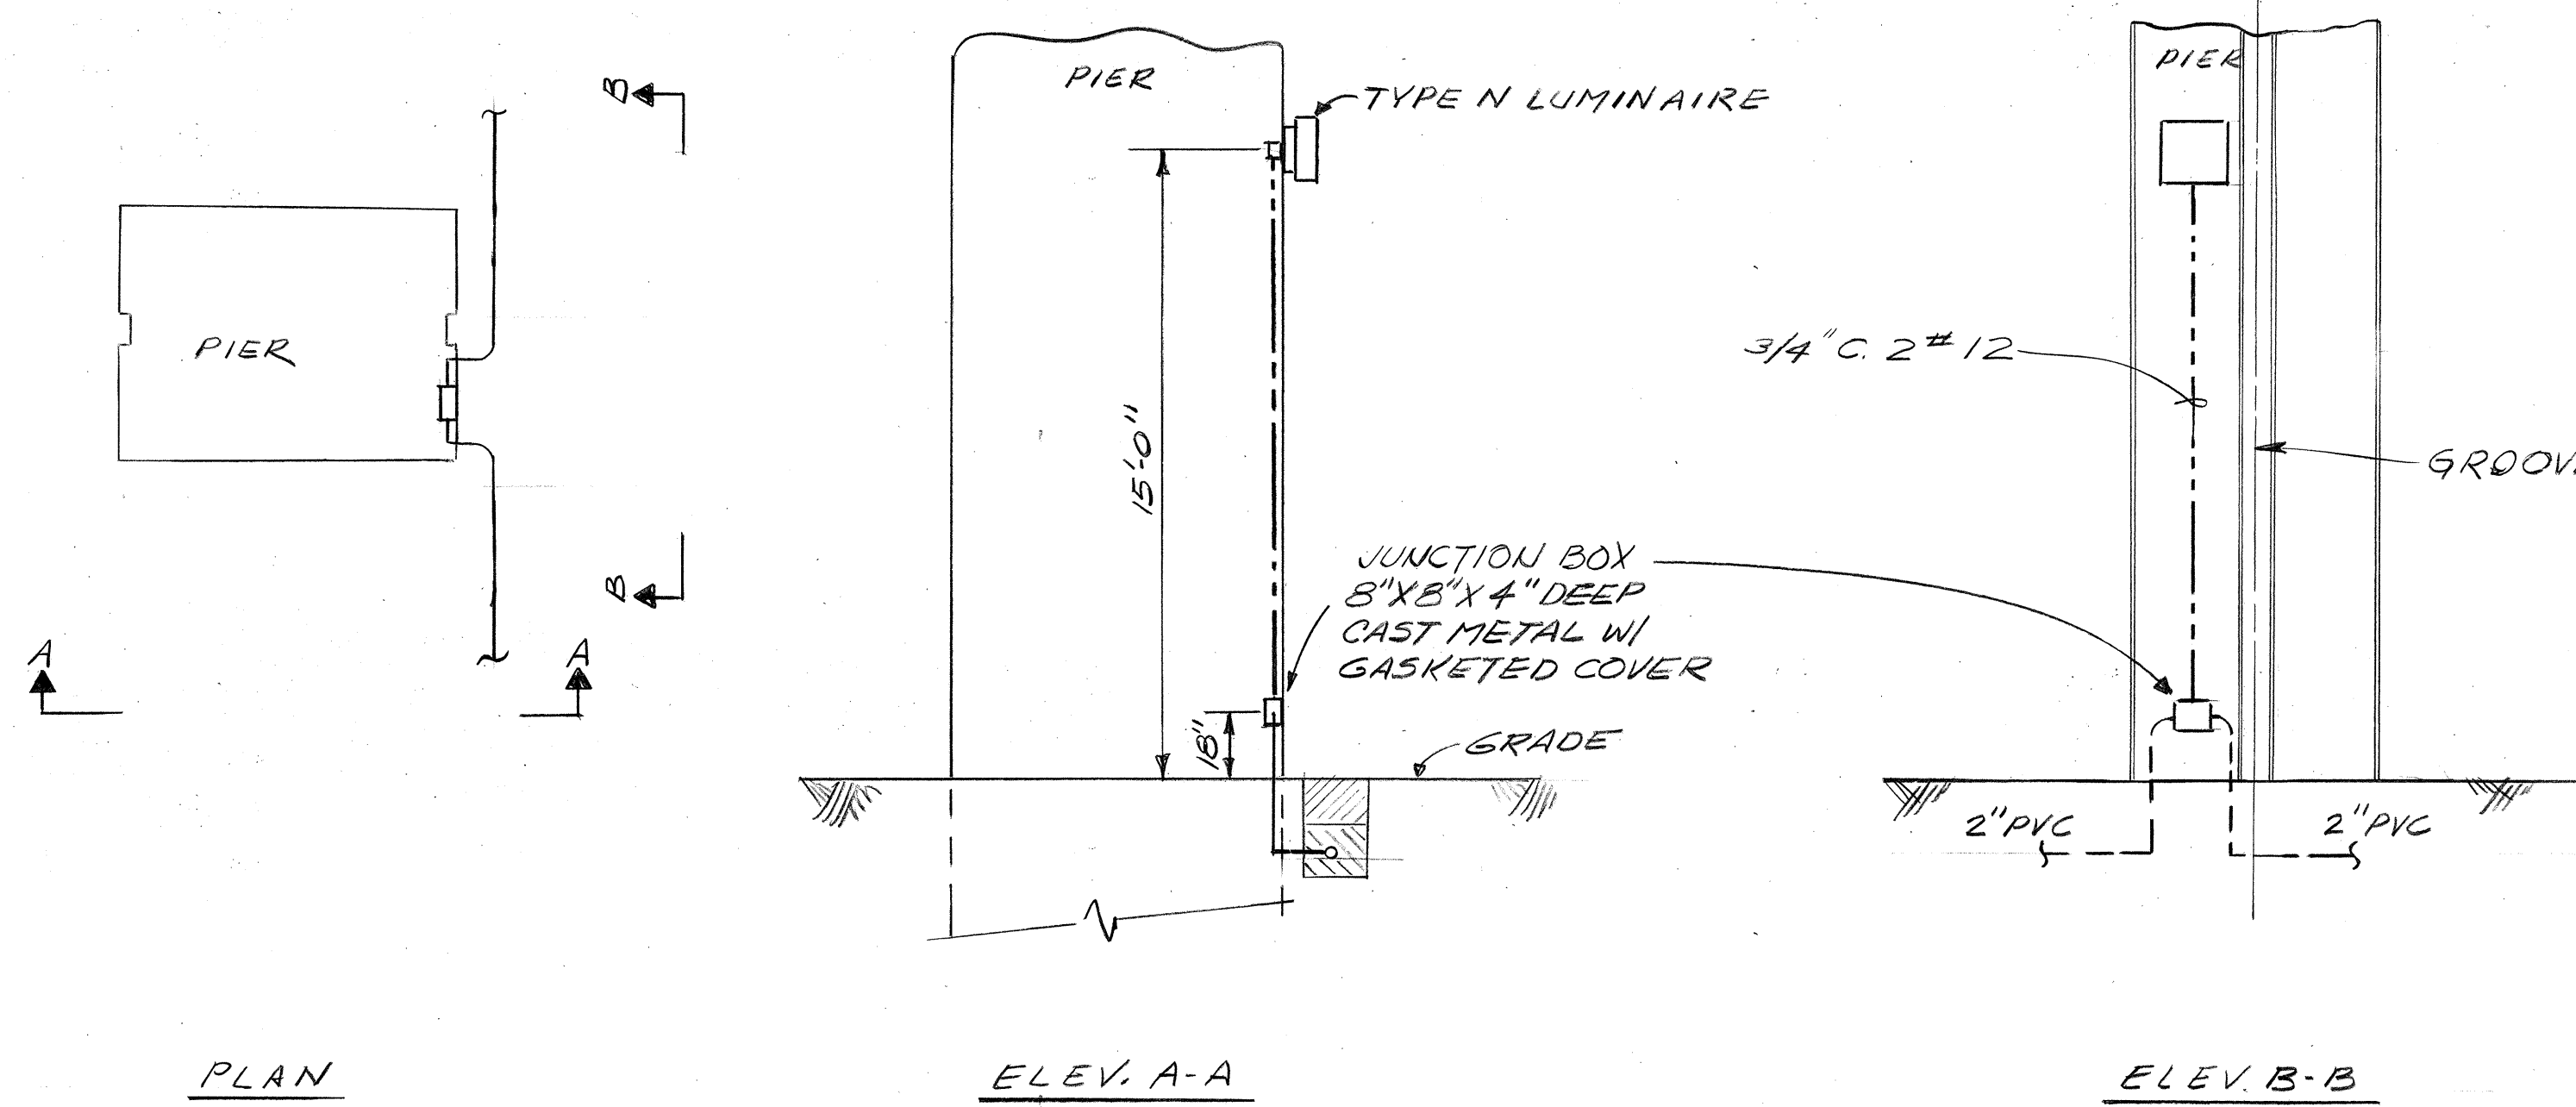

TYPE N FIXTURE MOUNTING DETAIL (1)
1/4" = 1'-0"

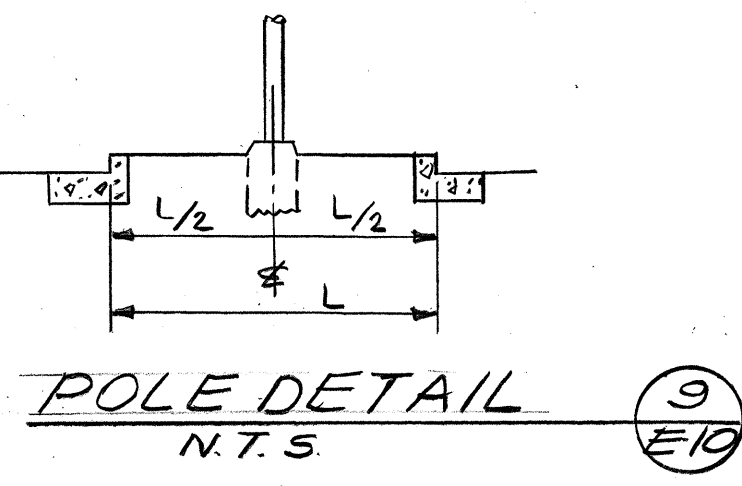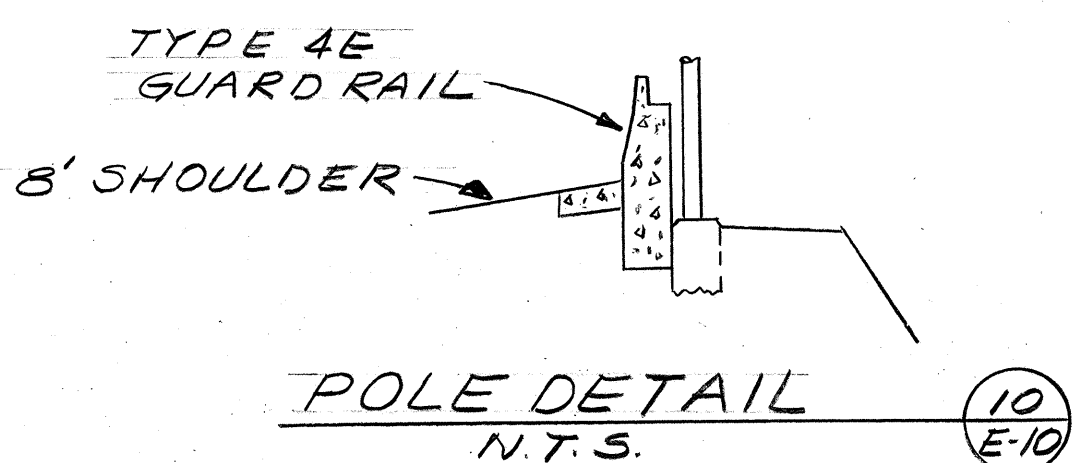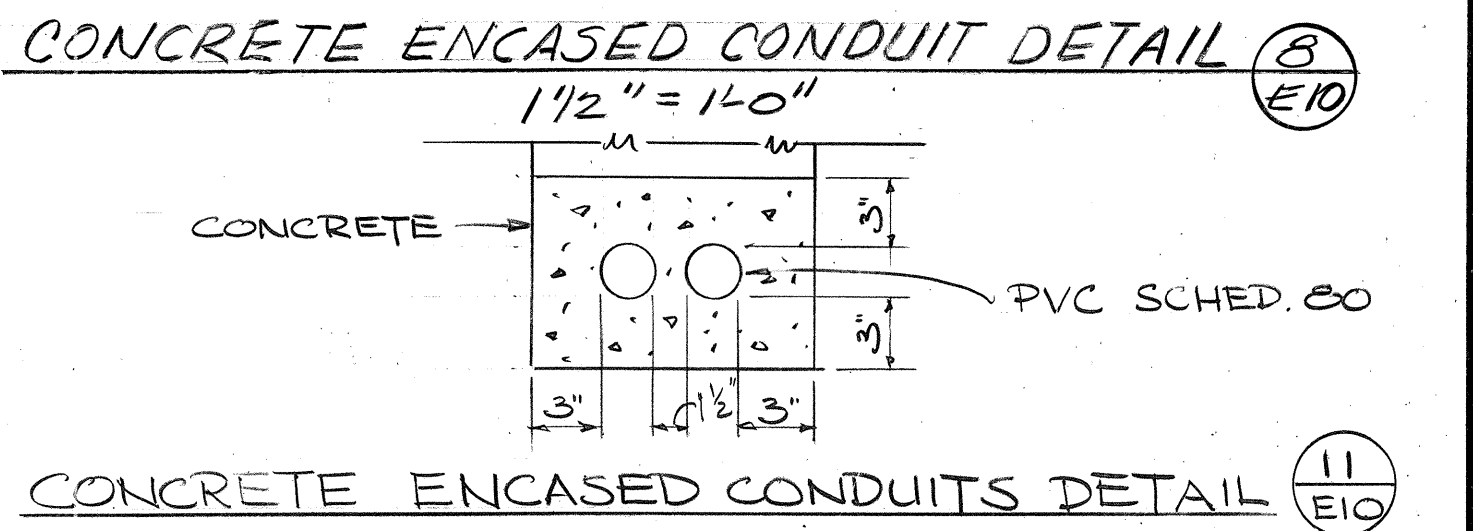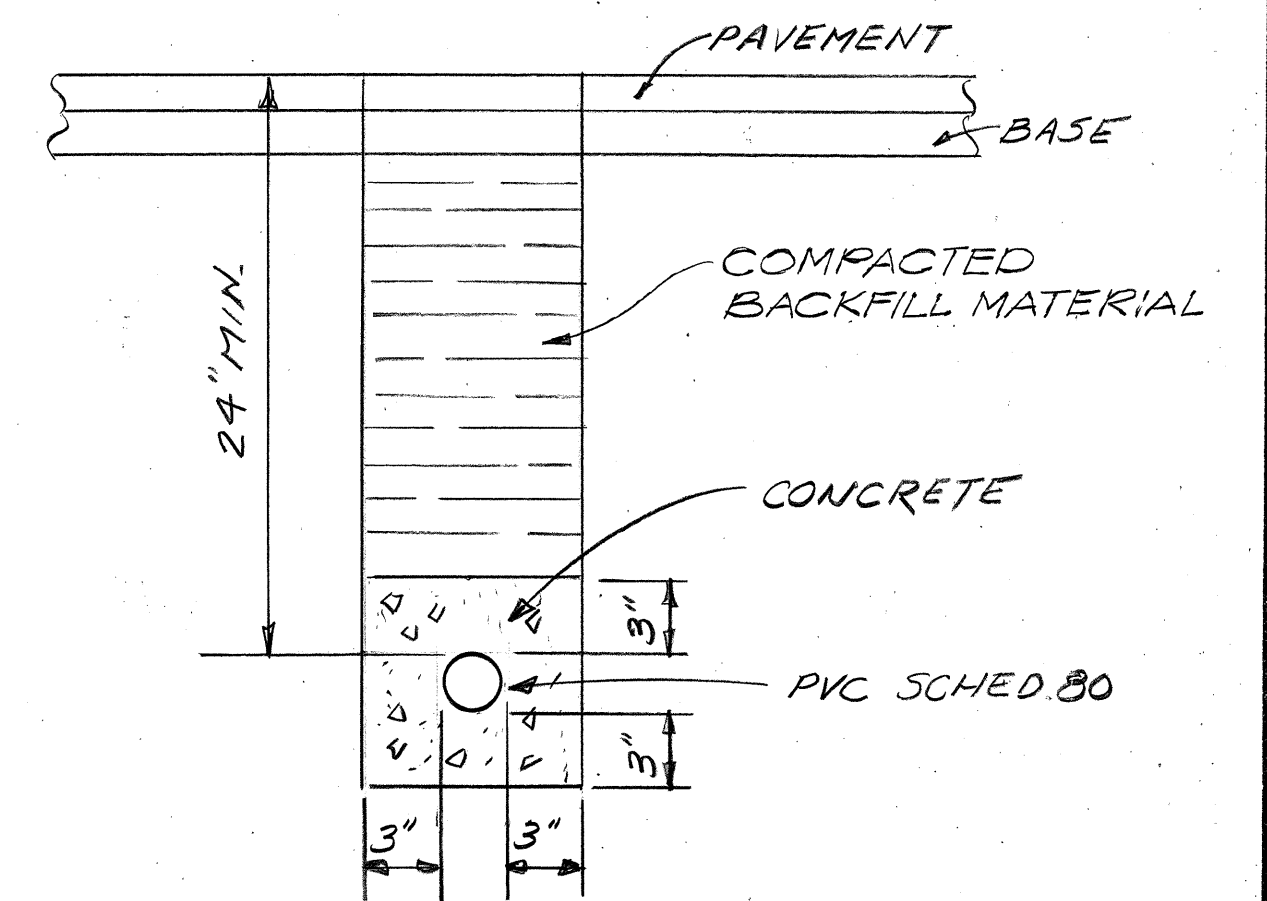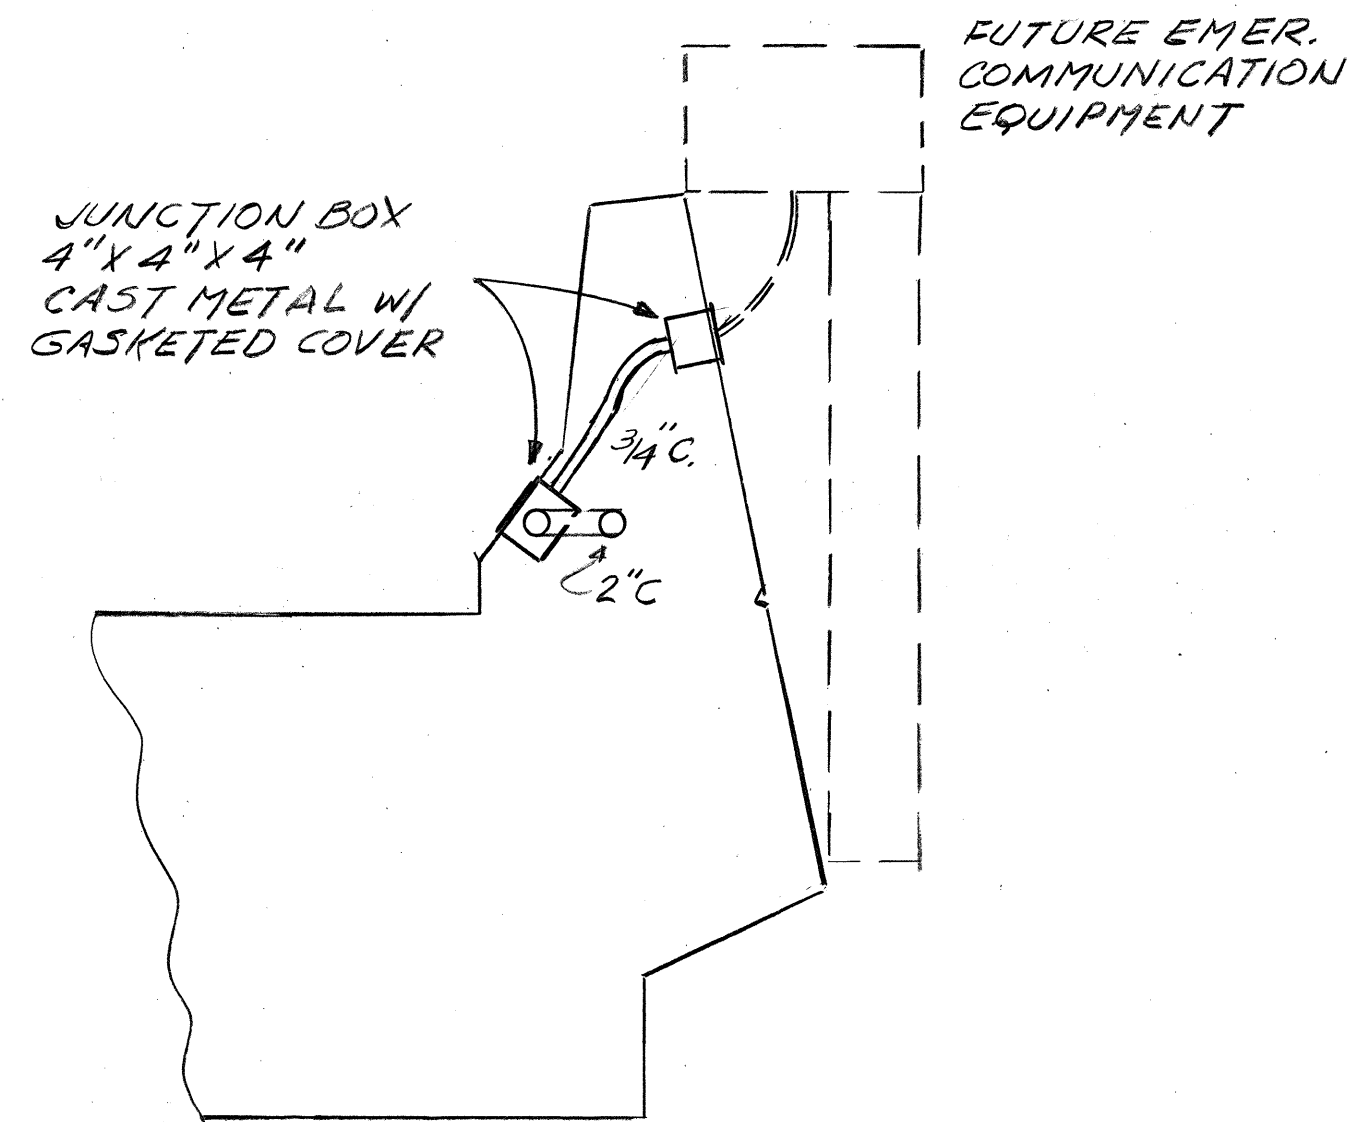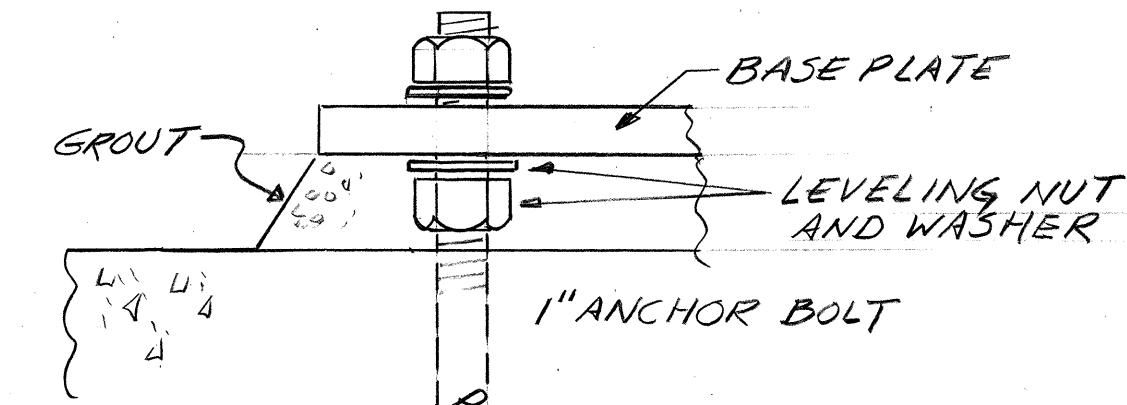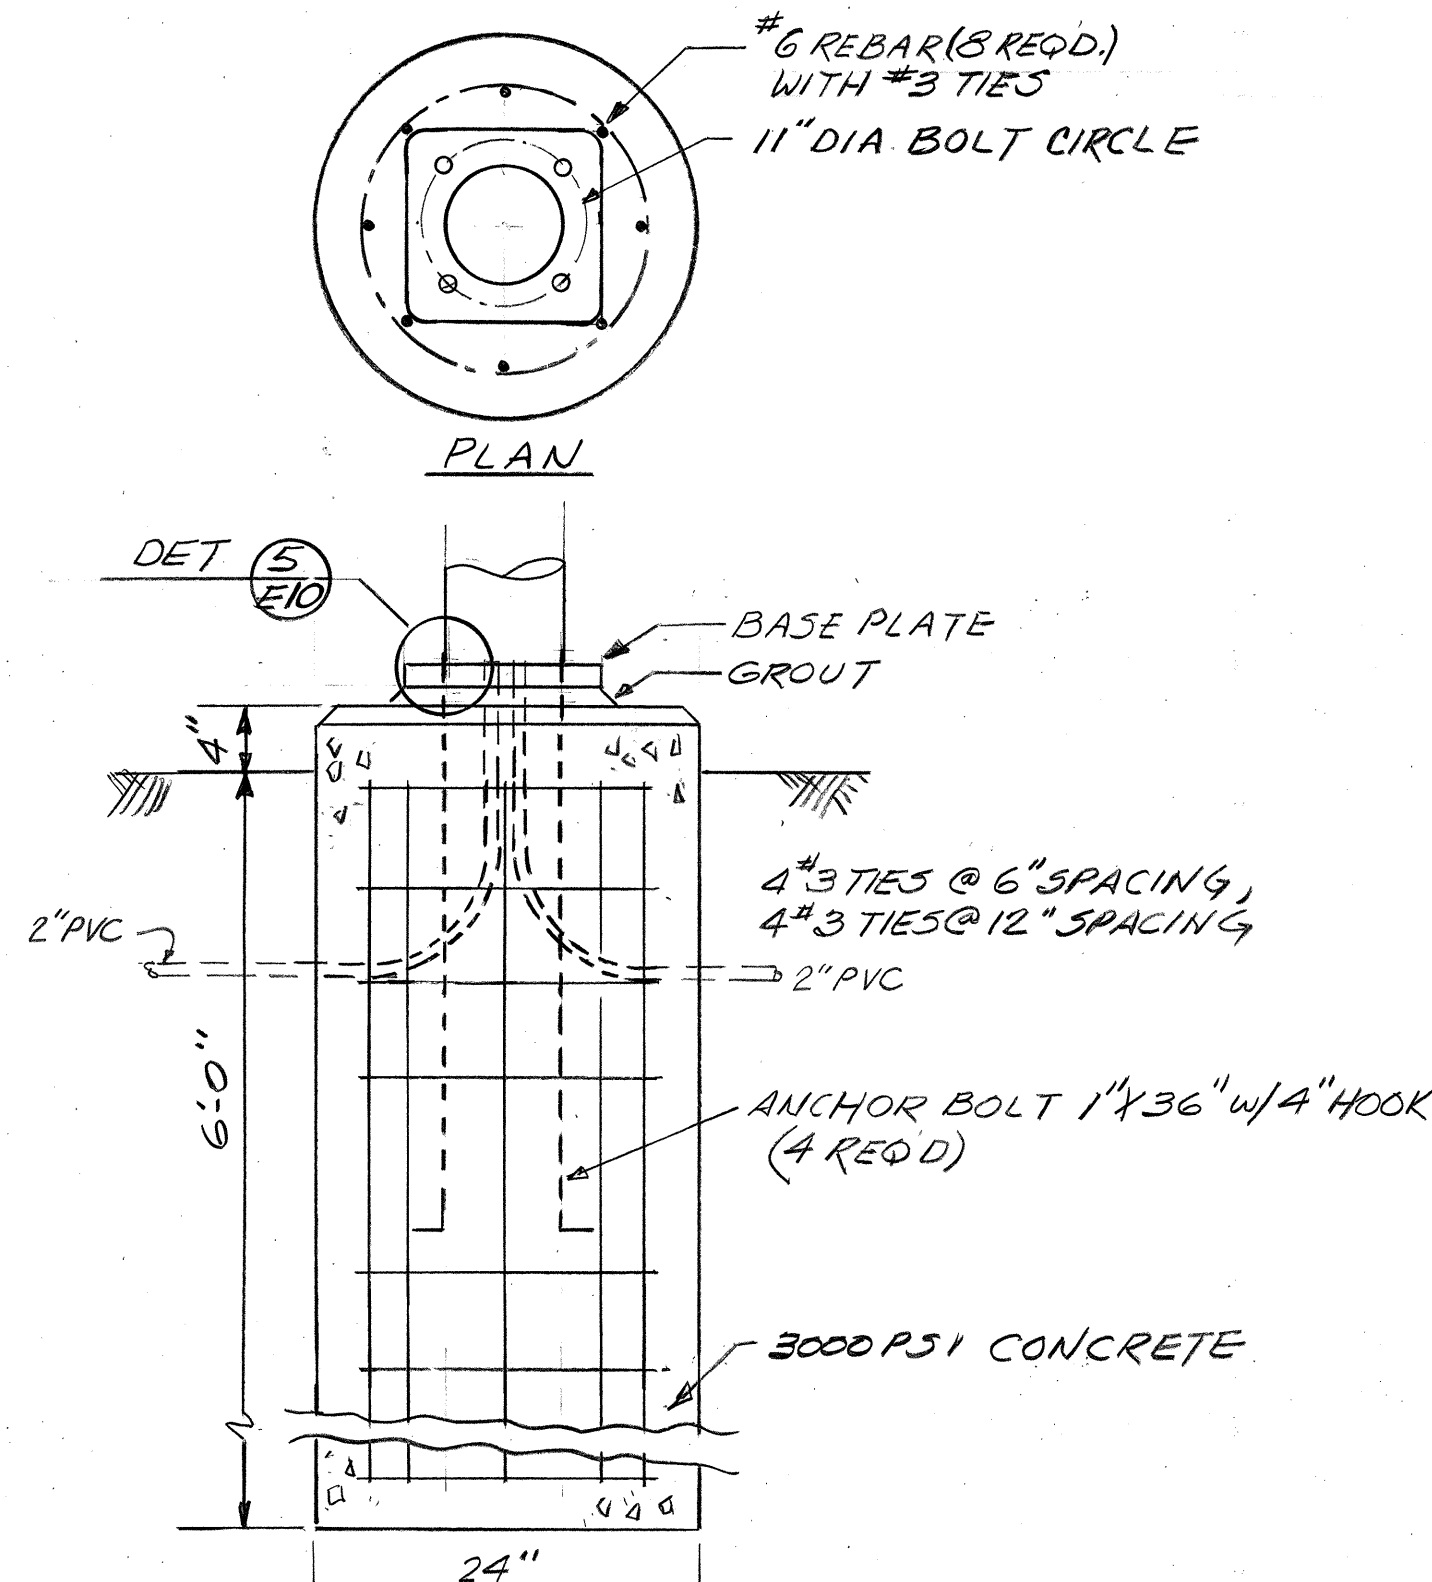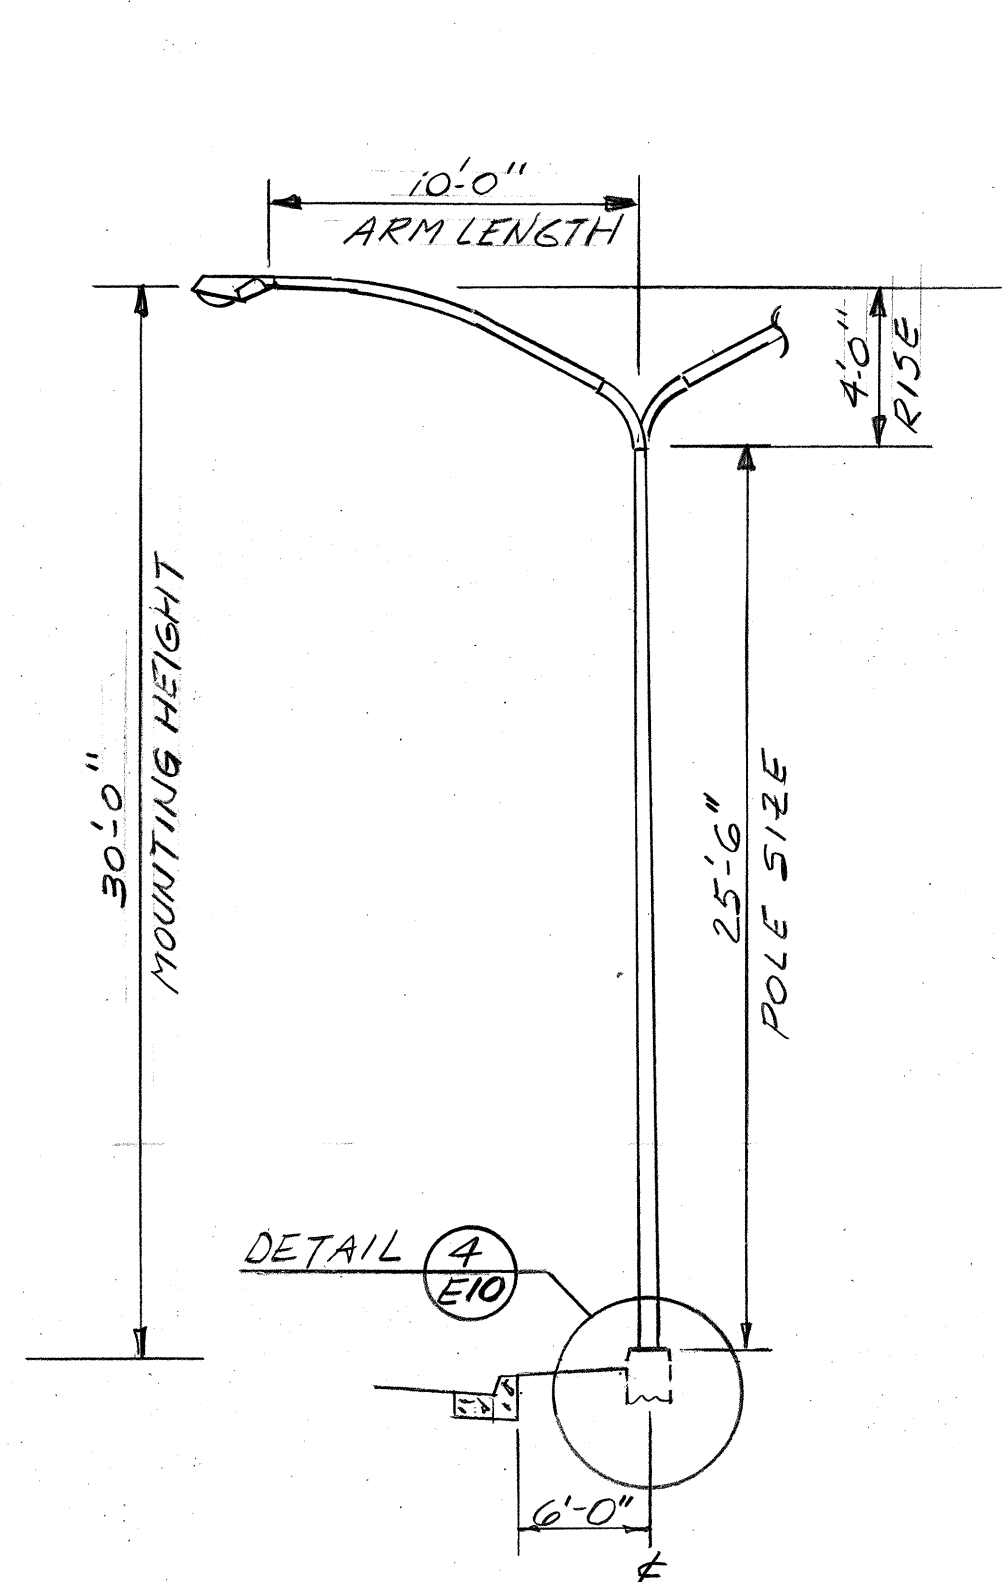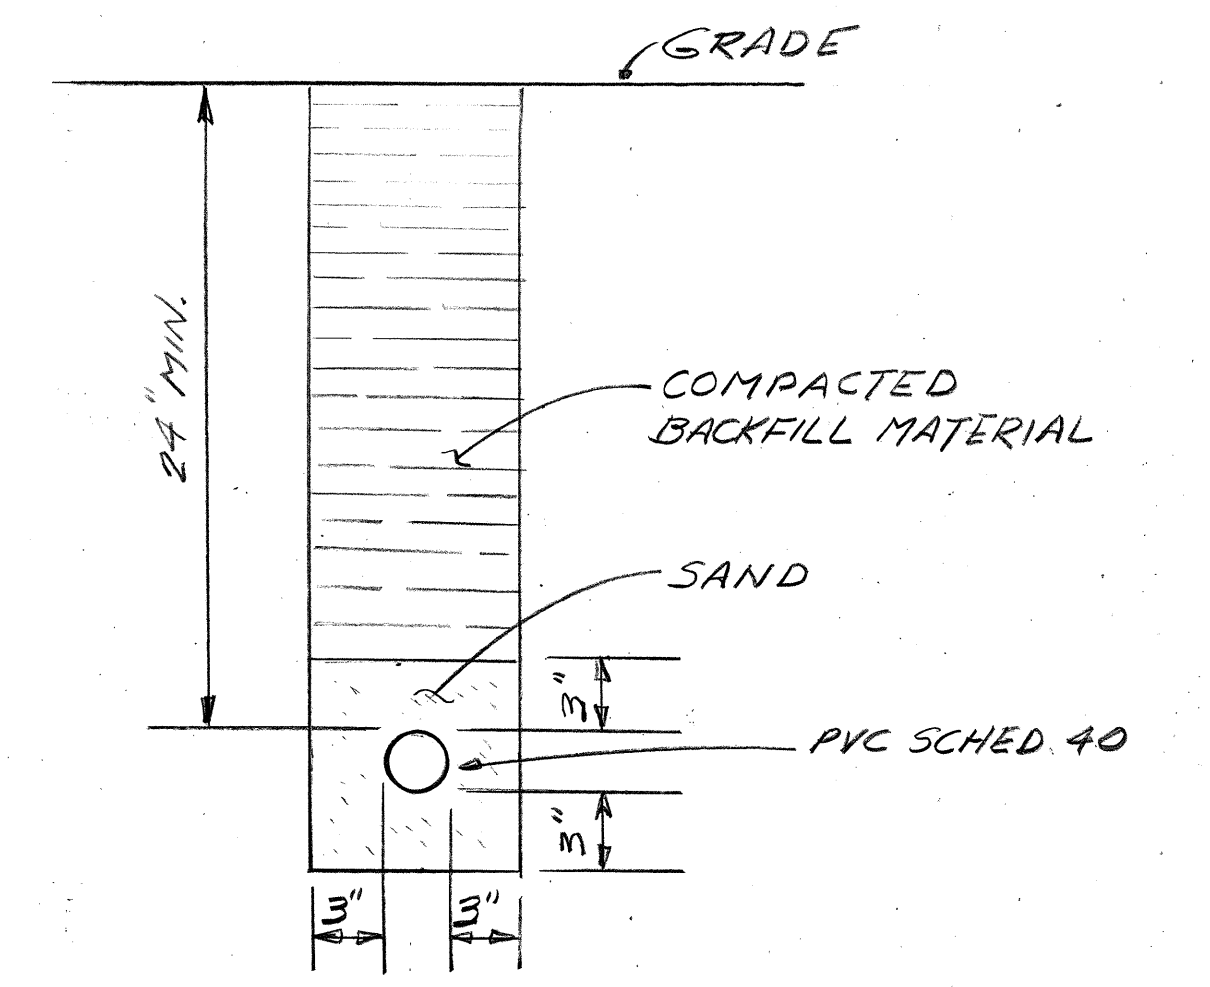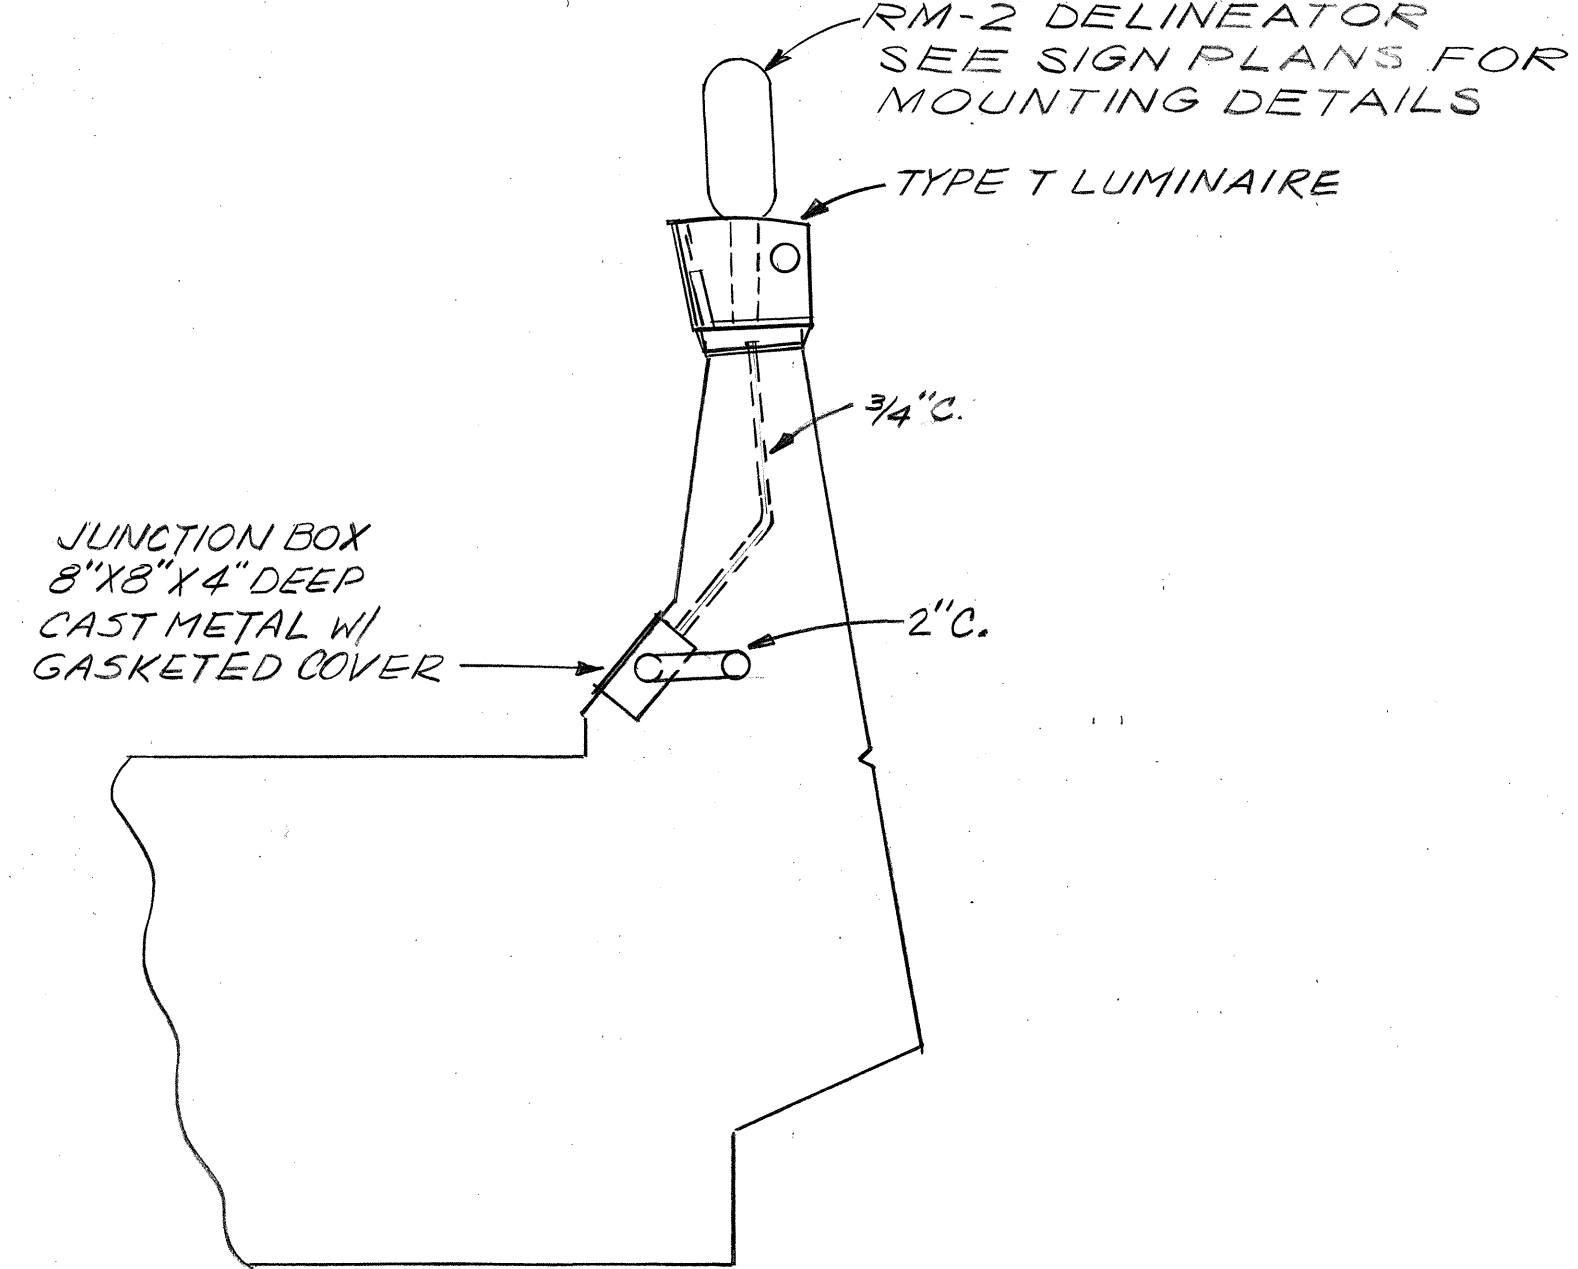

DATE	
SURVEY PLOTTED BY	
DRAWN BY	
DESIGNED BY	
NOTED BY	
CHECKED BY	
NO.	

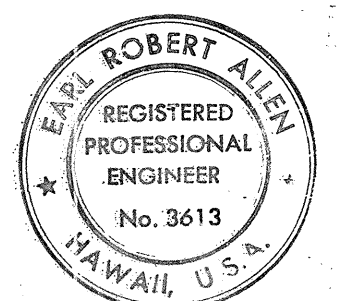

Earl Robert Allen
THIS WORK WAS PREPARED BY
ME OR UNDER MY SUPERVISION

1	10-6-78	Added Detail (11)
		Revised Detail (3)
NO.	DATE	REVISION

STATE OF HAWAII
DEPARTMENT OF TRANSPORTATION
HIGHWAYS DIVISION



ROADWAY LIGHTING
DETAILS

AIRPORT INTERCHANGE
F.A.I. PROJ. NO. I-H-1(123)16



SCALE: AS SHOWN DATE: 8-28-76

SHEET No. E-10 OF 12 SHEETS

FED. ROAD DIST. NO.	STATE	FED. AID PROJ. NO.	FISCAL YEAR	SHEET NO.	TOTAL SHEETS
HAWAII	HAW.	I-H-1(123)16	1976	117	444

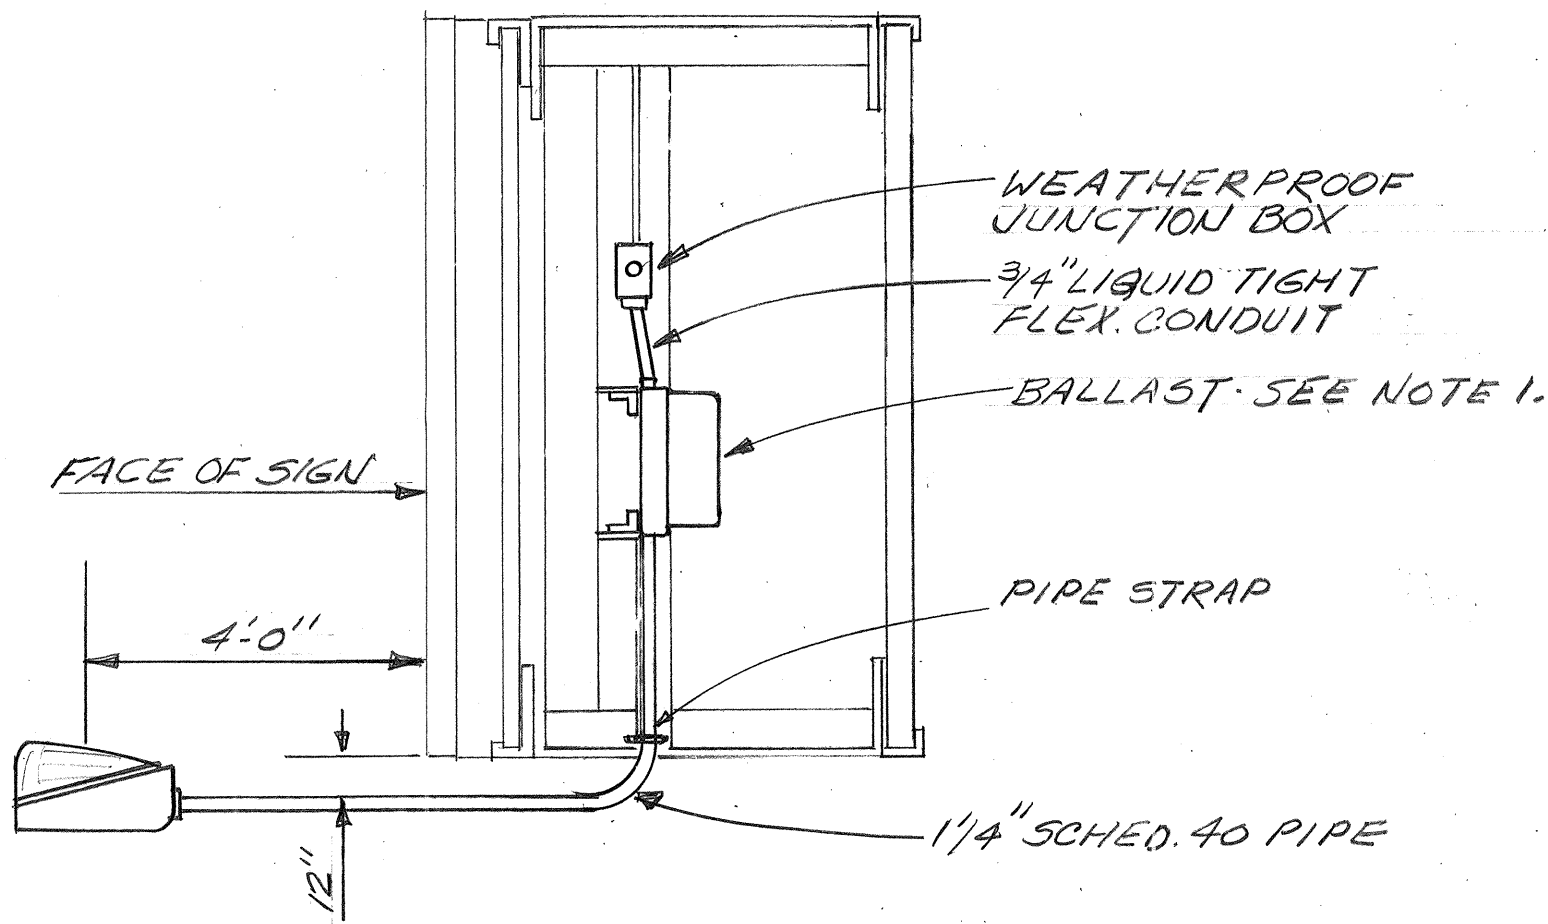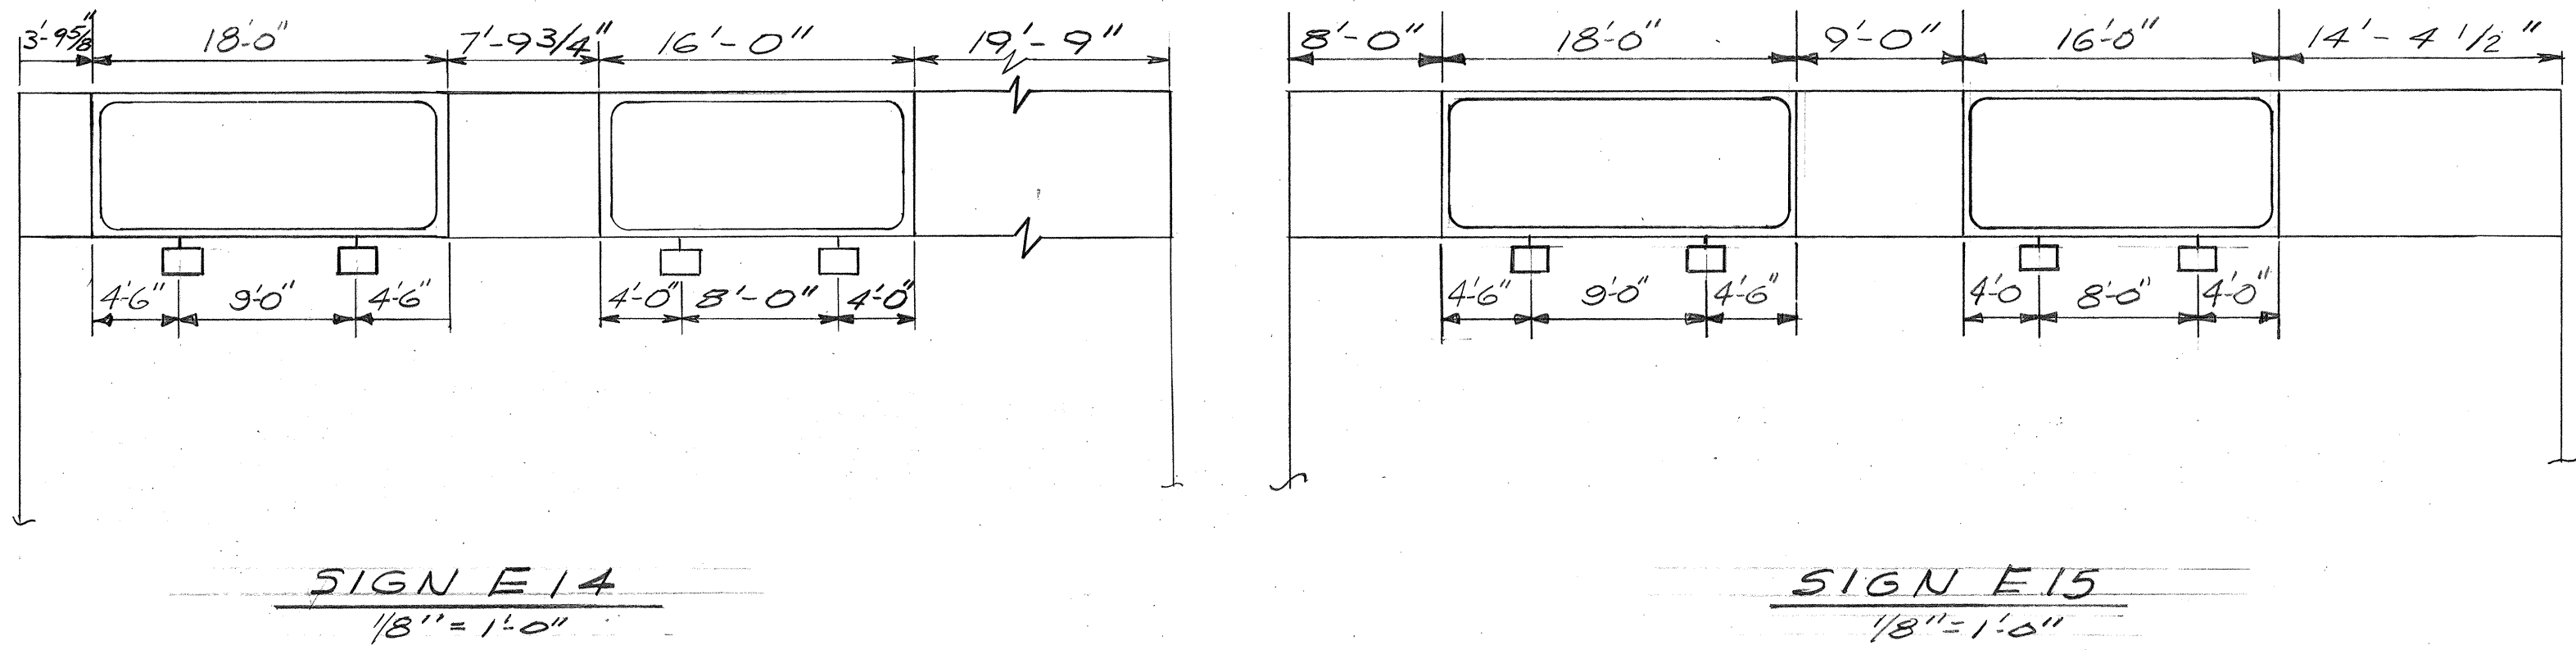


LUMINAIRE MOUNTING
NOT TO SCALE

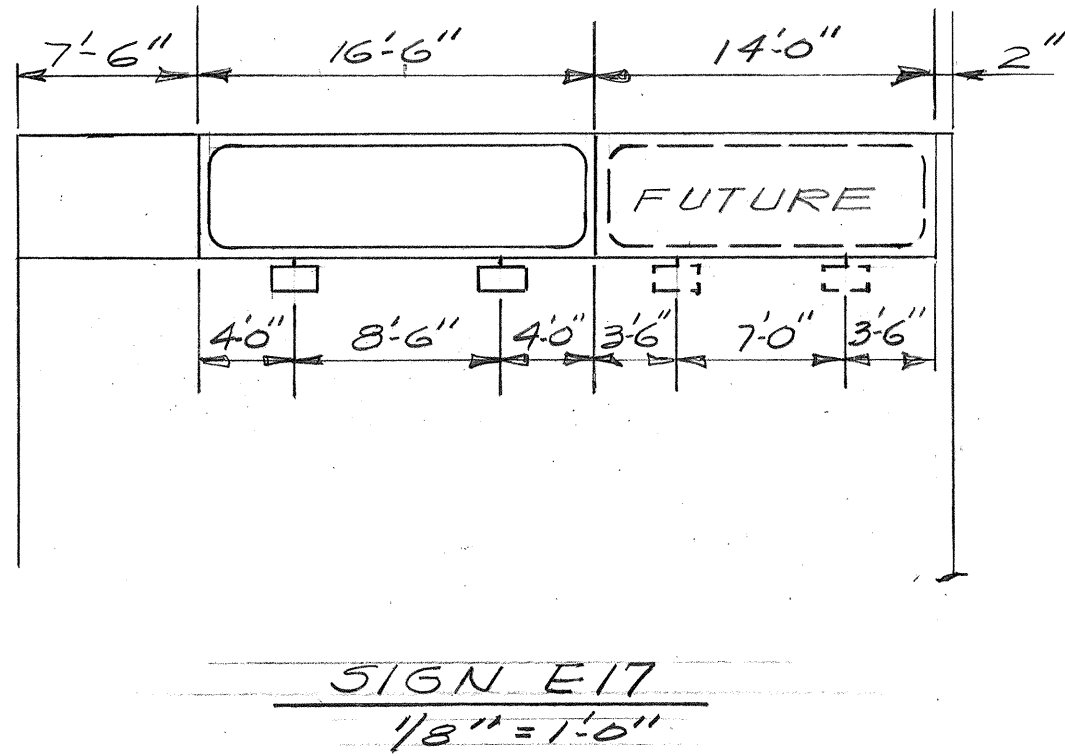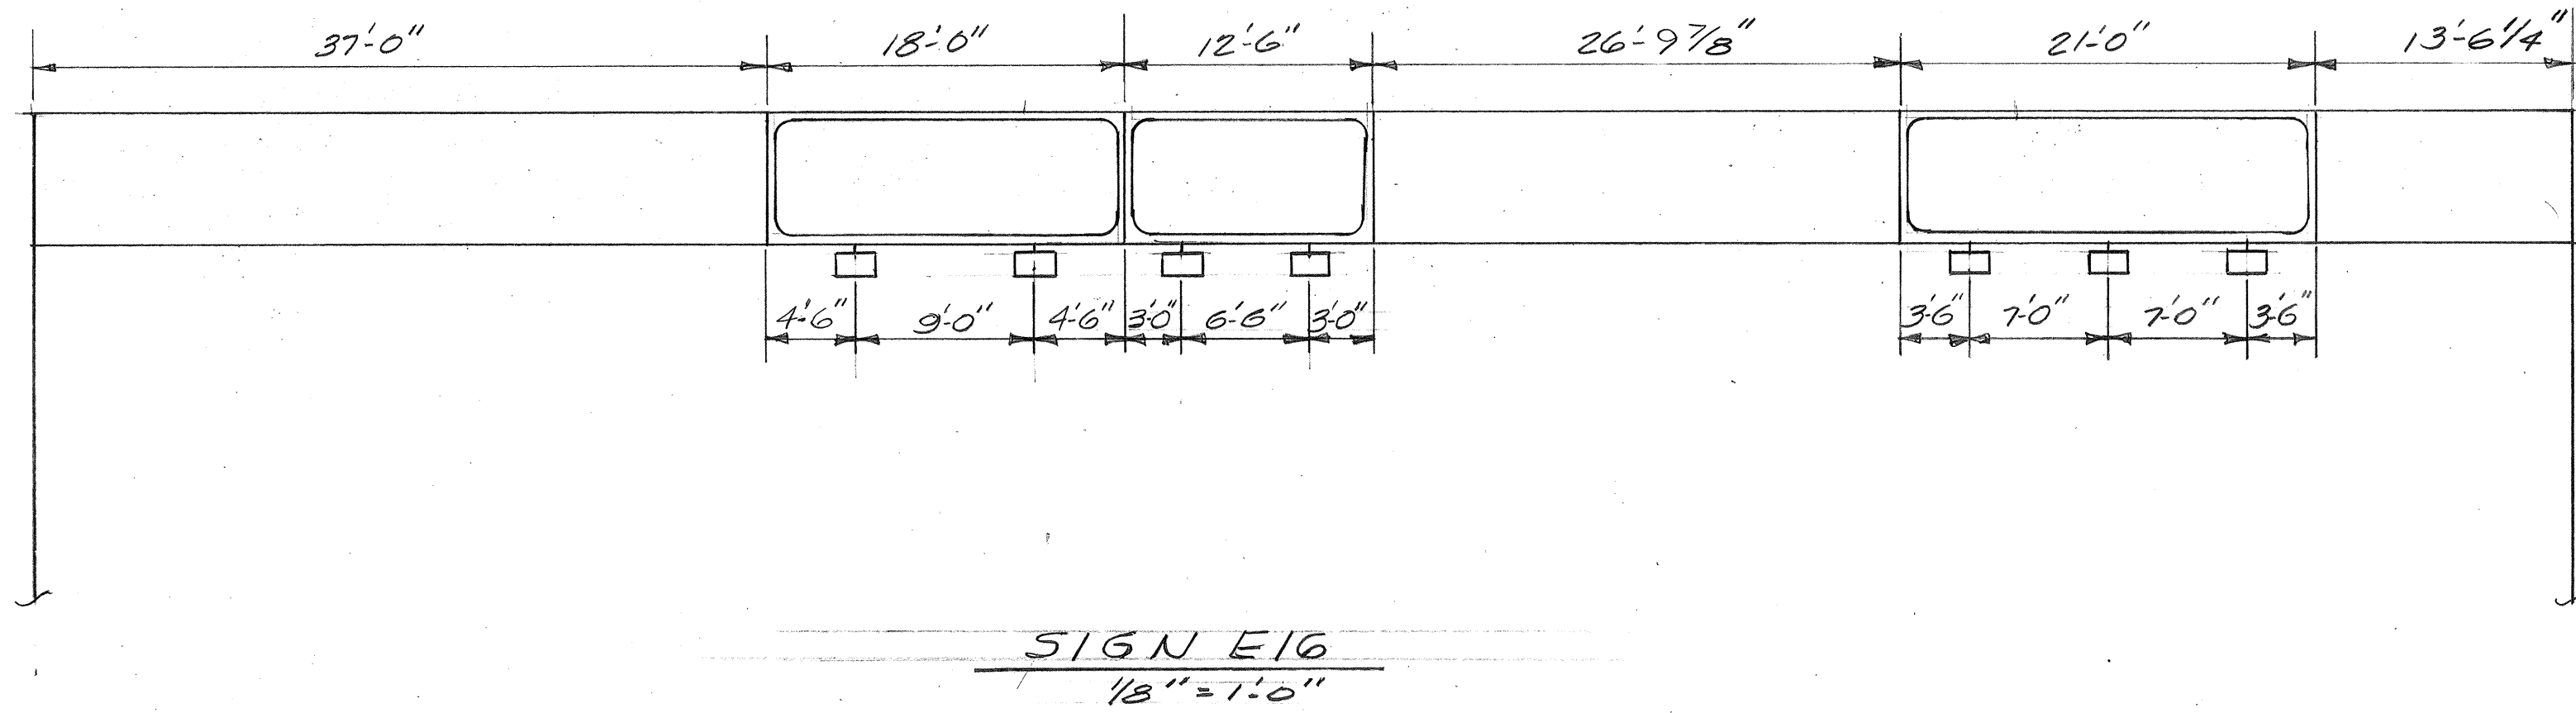

NOTES:
1. BALLASTS FOR SIGNS E14, E15 AND E16 TO BE FOR 277 V.; BALLASTS FOR SIGN E17 TO BE FOR 480 V.

ORIGINAL PLAN	SURVEY PLOTTED BY	DATE
DRAWN BY	DESIGNED BY	
NOTE BOOK	QUANTITIES BY	
CHECKED BY		
No.		

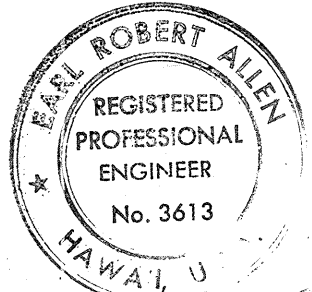

THIS WORK WAS PREPARED BY
ME OR UNDER MY SUPERVISION



STATE OF HAWAII
DEPARTMENT OF TRANSPORTATION
HIGHWAYS DIVISION

SIGN LIGHTING
LAYOUT AND DETAILS

AIRPORT INTERCHANGE
E.A.I. PROJ. NO. I-H-1(123)16


SCALE: AS SHOWN DATE: 8-28-76
SHEET No. E-11 OF 12 SHEETS

FED. ROAD DIST. NO.	STATE	FED. AID PROJ. NO.	FISCAL YEAR	SHEET NO.	TOTAL SHEETS
HAWAII	HAW.	I-H-1(123)16	1976	118	444

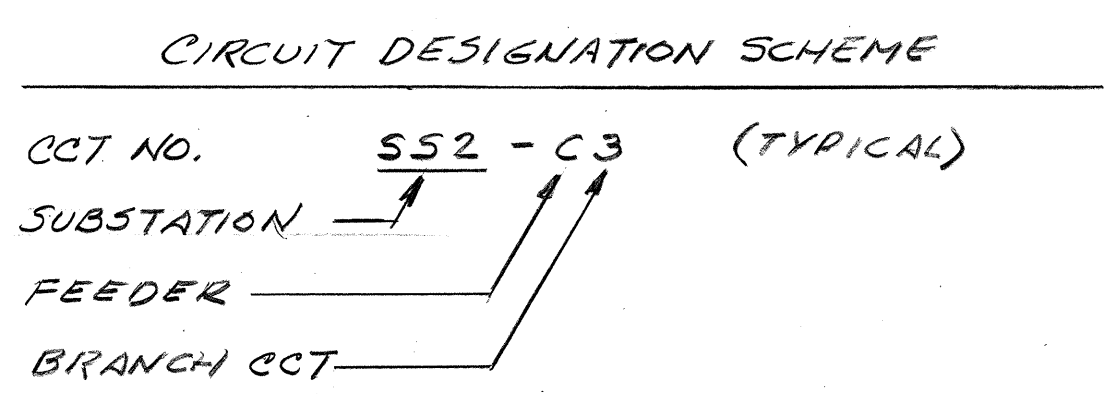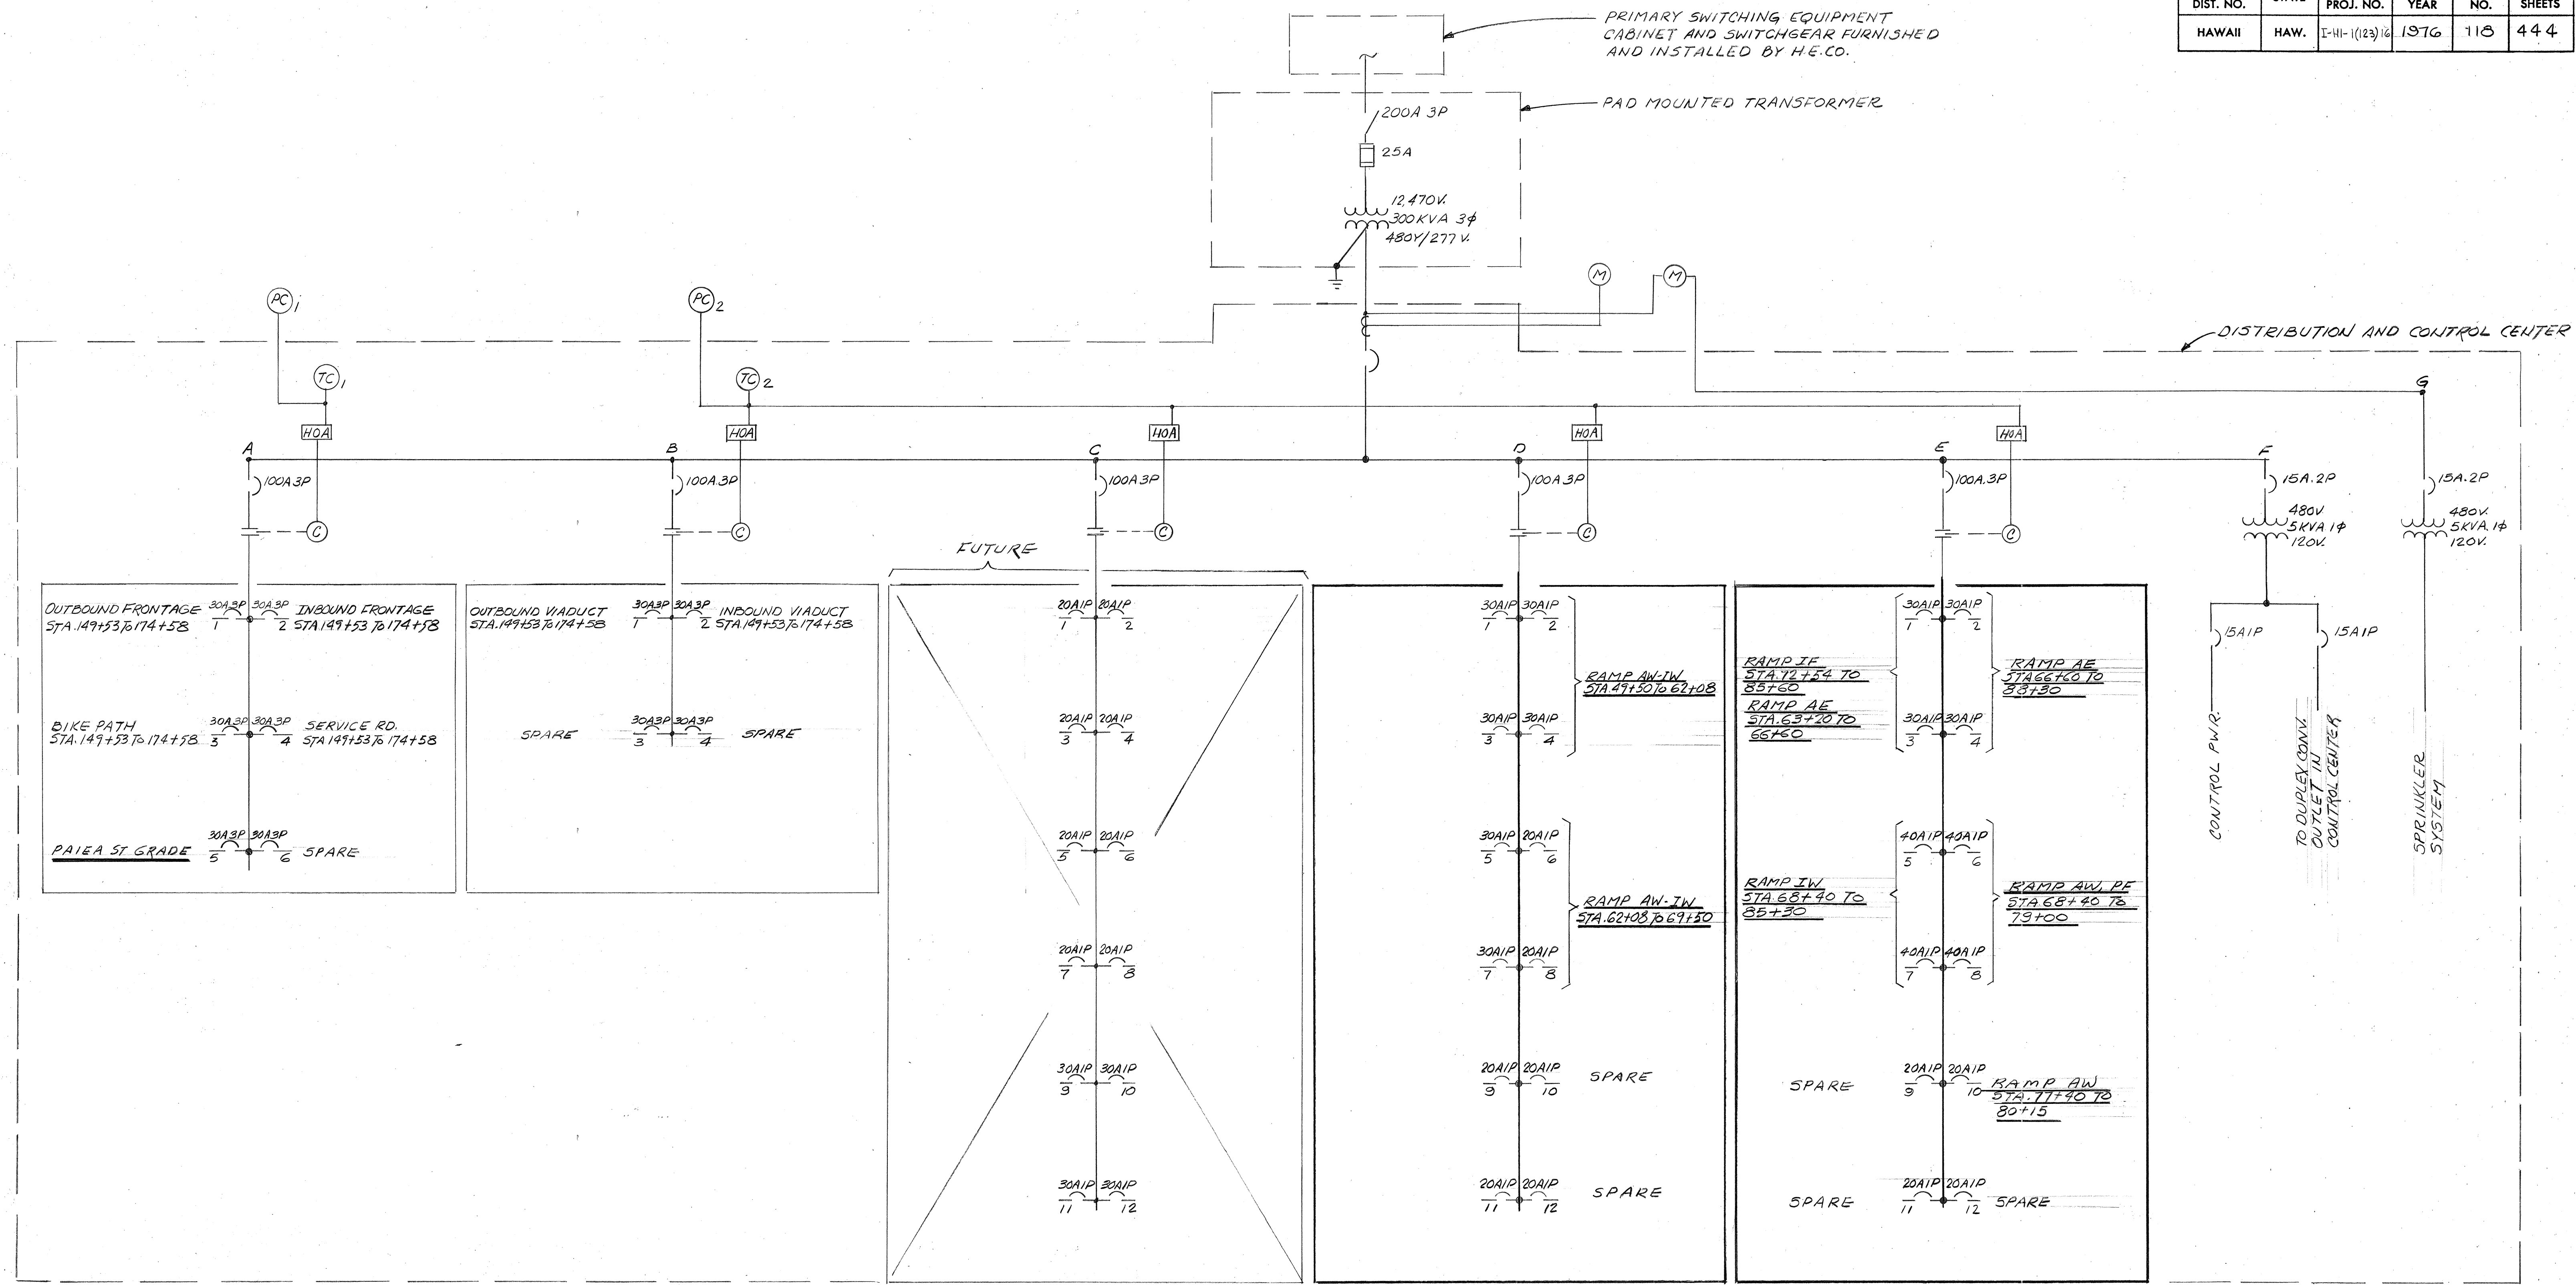

NOTES:

1. SUBSTA. 552 IS EXISTING FROM A PREVIOUS CONTRACT. PANEL 'D' AND PANEL 'E' SHALL BE FURNISHED AND INSTALLED ON THIS CONTRACT. CIRCUITS INDICATED BY UNDERLINING SHALL BE INSTALLED ON THIS CONTRACT AS SHOWN ON THE PLANS.

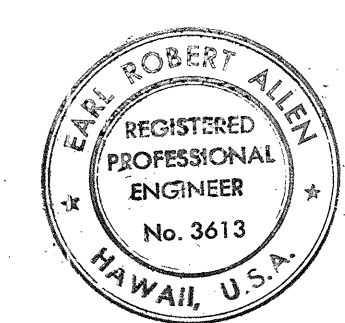

Earl A. Allen

THIS WORK WAS PREPARED BY ME OR UNDER MY SUPERVISION

STATE OF HAWAII
DEPARTMENT OF TRANSPORTATION
HIGHWAYS DIVISION

ROADWAY LIGHTING
SUBSTATION SS2
ONE LINE DIAGRAM

AIRPORT INTERCHANGE
EA PROJ. NO. I-H-1(123)16

SCALE: NONE DATE: 8-28-76

SHEET No. E-12 OF 12 SHEETS