


INDEX TO DRAWINGS	
SHEET NO	DESCRIPTION
1	TITLE SHEET
2	CONSTRUCTION PHASING
① 3 - 8	TYPICAL SECTIONS
② 9 - 18	PAIEA ST./AOELE ST. PLAN
19 - 23	PAIEA ST./AOELE ST. PROFILES
③ 24 - 28	DETAILS - ROADWAY
29 - 30	SCHEDULES - ROADWAY
31 - 34	DRAINAGE PLAN & PROFILE
35 - 53	DRAINAGE STRUCTURES & DETAILS
54 - 57	DRAINAGE SUMMARY
④ 58 - 95	STANDARD DETAILS
⑤ 96 - 97	DETOUR PLANS
98	RIGHT-OF-WAY MAP - PAIEA ST.
⑥ 99 - 105	SIGNING/STRIPING
106-106A	SIGNAL
⑦ 107 - 118	LIGHTING
119 - 120	LANDSCAPING - TREE TRANSPLANT
121 - 129	LANDSCAPING - PLANTING PLAN
130 - 137	LANDSCAPING - GRADING & ROCK WALL
138 - 146	LANDSCAPING - SPRINKLER PLAN
147 - 152	LANDSCAPING - SPRINKLER SUMMARY
153 - 157	LANDSCAPING - SPRINKLER DETAILS
158 - 159	UTILITIES - GENERAL PLAN & NOTES
⑧ 160 - 171	UTILITIES - PAIEA ST./AOELE ST. PLAN
172 - 178	UTILITIES - PROFILES
⑨ 179 - 232	UTILITIES - DETAILS
233-234	RAMPS IW, AW & PF STRUCTURES
235	INDEX TO DRAWING & QUANTITIES
⑩ 236 - 415	GENERAL NOTES
416-420	STRUCTURE PLANS
421	STANDARD DRAWINGS
421	BORING LOGS
⑪ 422-444	CROSS SECTIONS
227-228	DELETED
427-428	DELETED

STATE OF HAWAII
DEPARTMENT OF TRANSPORTATION
HIGHWAYS DIVISION
HONOLULU, HAWAII
"AS BUILT"
PLANS FOR
CONSTRUCTION OF A PORTION OF
INTERSTATE ROUTE H-1
AIRPORT INTERCHANGE,
PAIEA STREET RAMP,
FEDERAL AID INTERSTATE PROJECT I-HI-1(123):16
DISTRICT OF HONOLULU
ISLAND OF OAHU

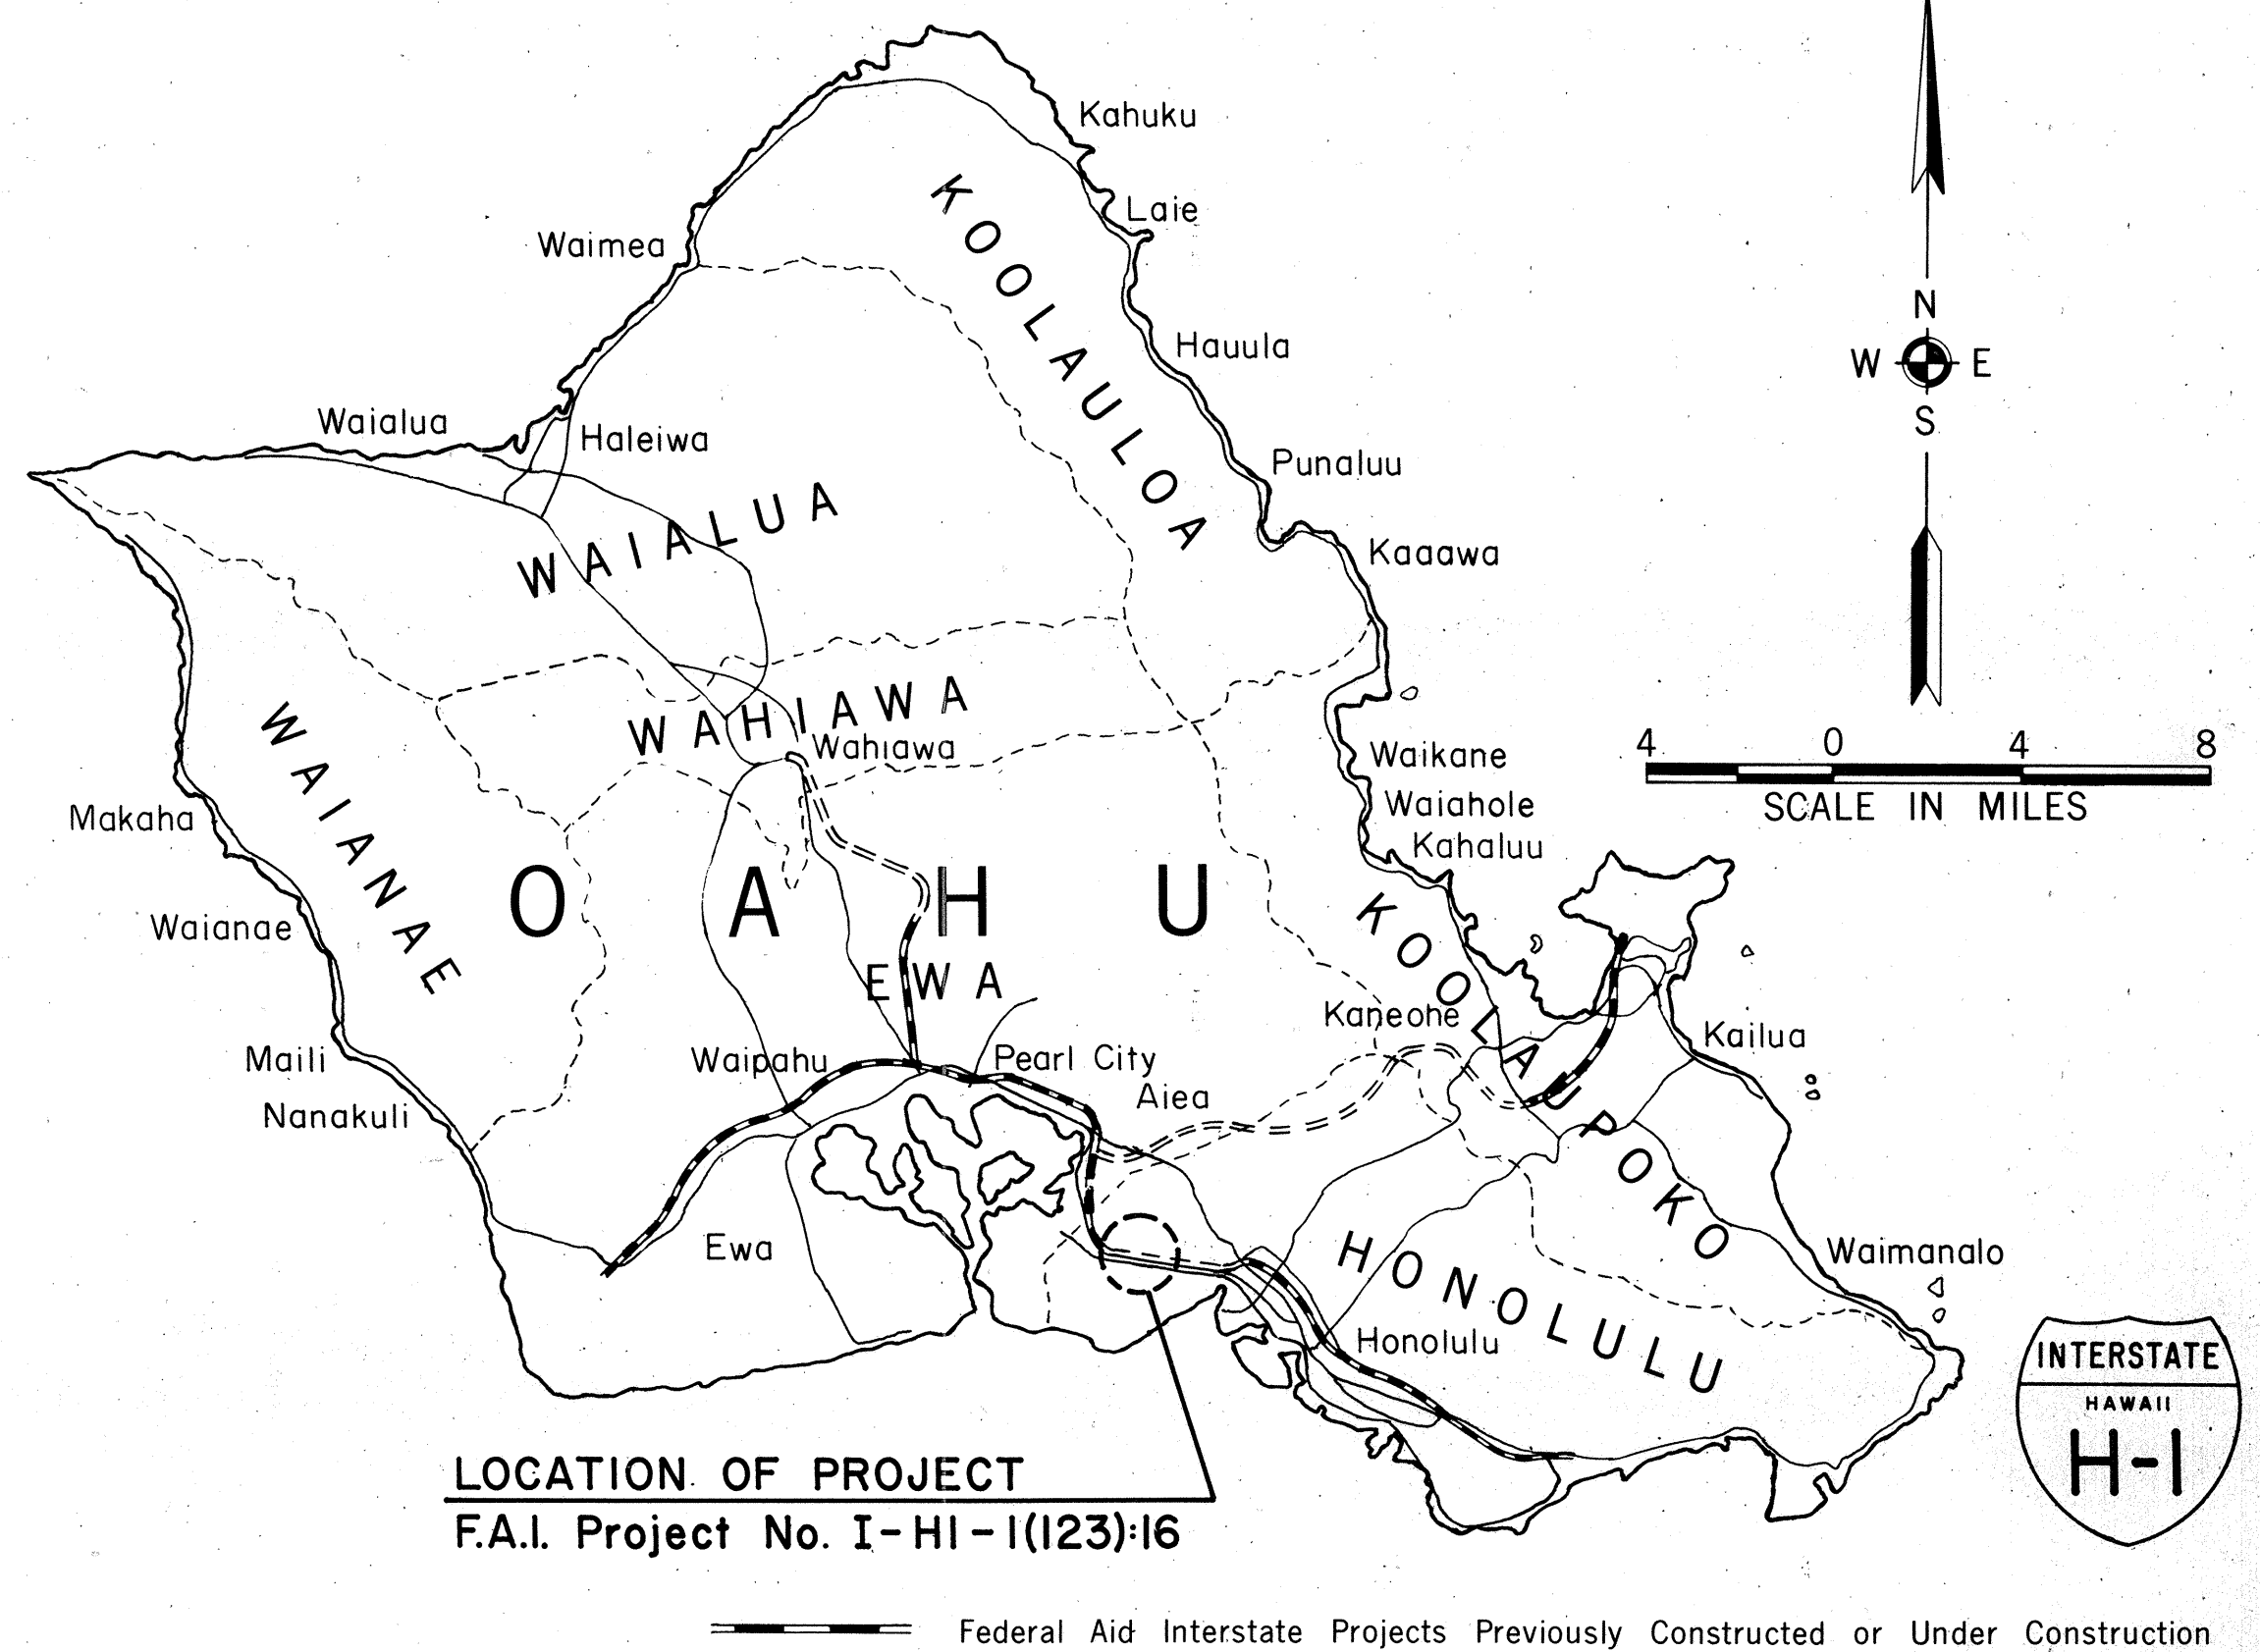


DESIGN CLASSIFICATION

DESIGN ADT (1994) 102,675
DHV 11 %
D 60/40
T 5 %
V 60 M.P.H.

SCALES:

PLANS HOR. 1" = 50'
PROFILES HOR. 1" = 50'
VER. 1" = 10'
DETAIL ROADWAY PLANS HOR. 1" = 20'
CROSS SECTIONS HOR. 1" = 10'
VER. 1" = 5'

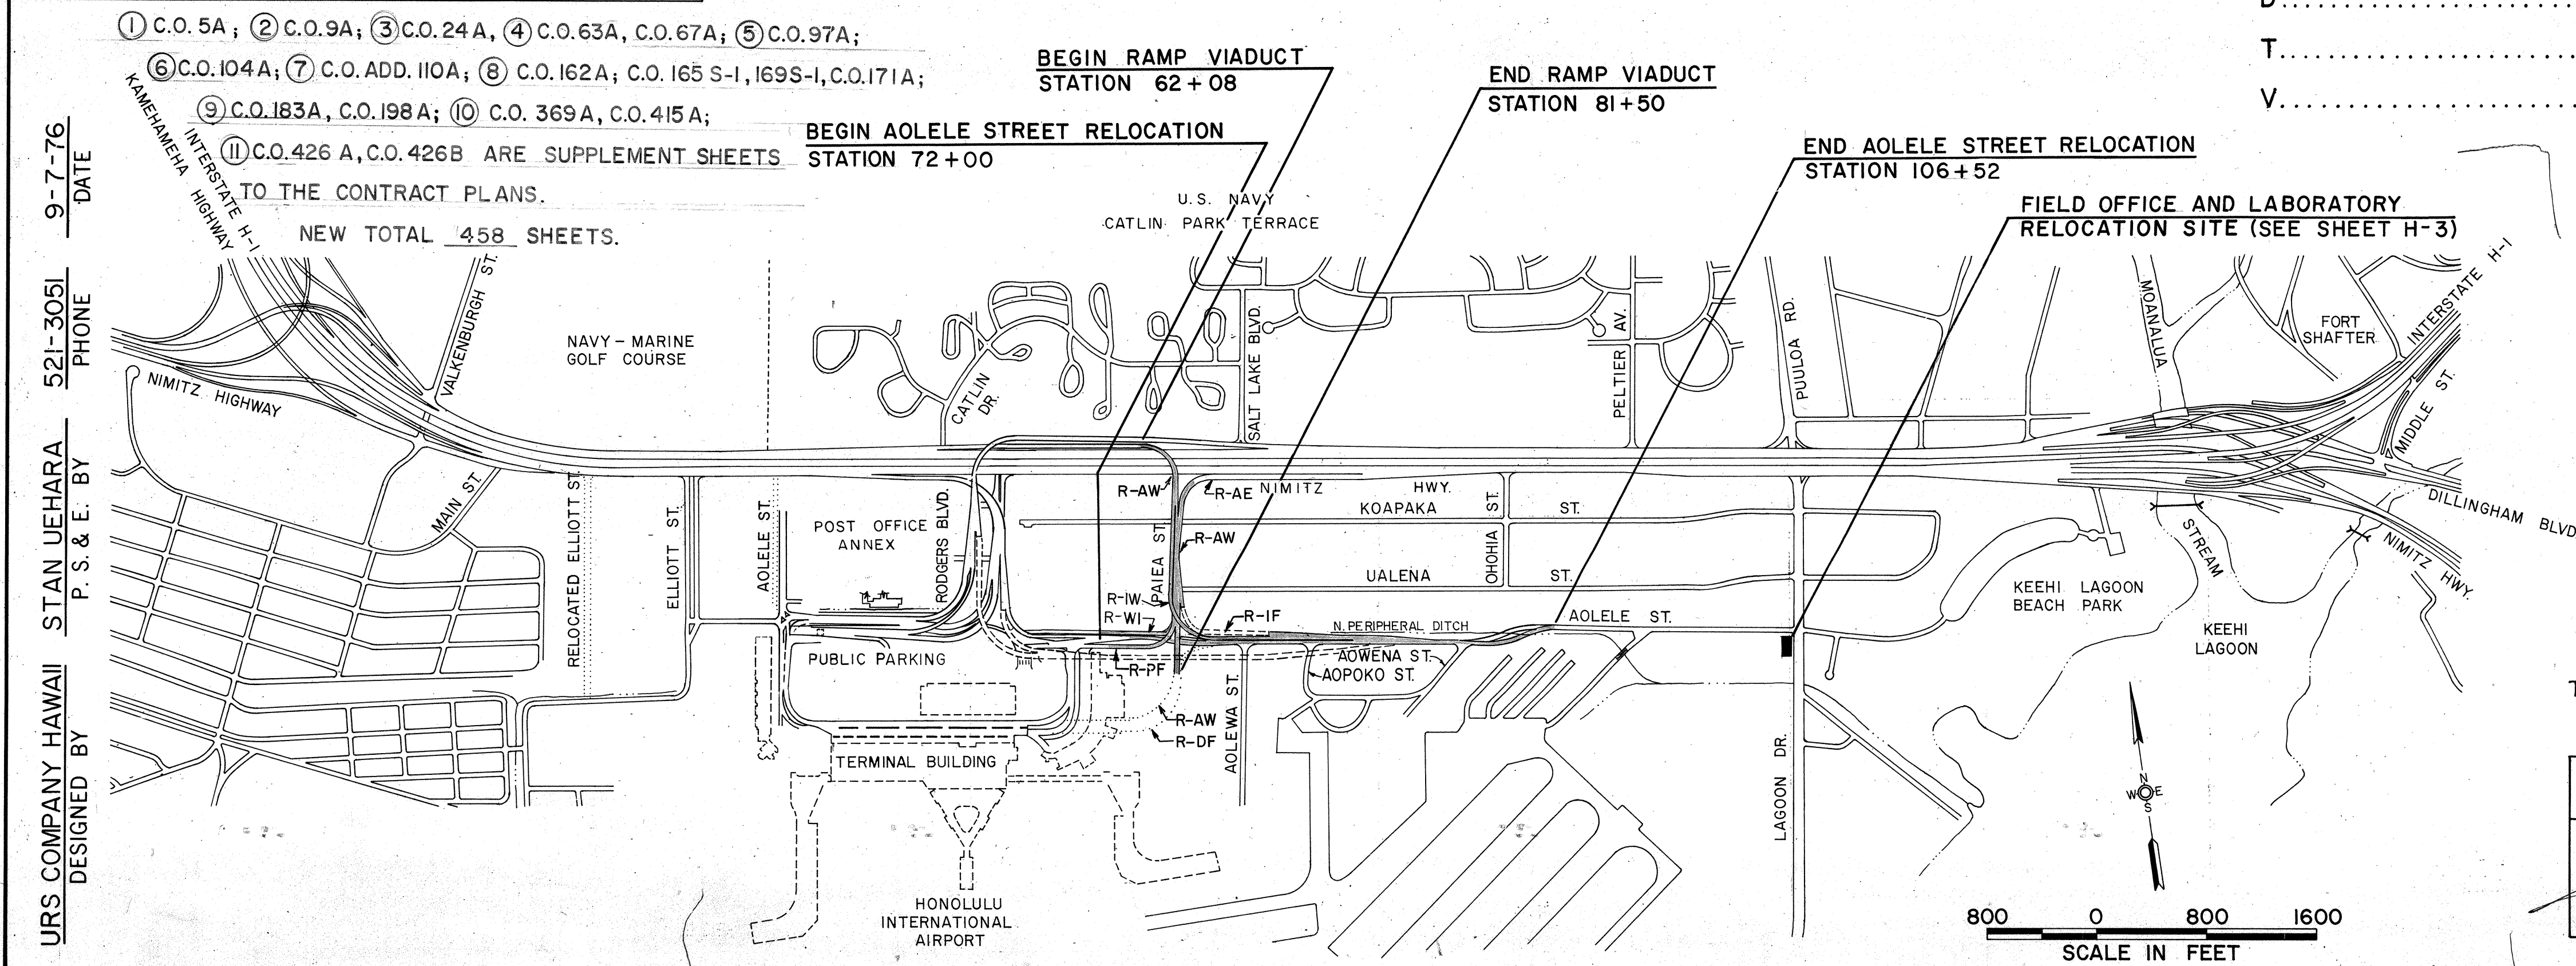

CHANGES MADE DURING CONSTRUCTION HAVE BEEN INCORPORATED ON THESE PLANS EXCEPT CHANGES IN THE ORIGINAL THEORETICAL QUANTITIES. FOR ACTUAL QUANTITIES, REFER TO PROJECT LEDGER AND/OR COMPUTATION BOOK.

TAX MAP KEY 1-1-3
1-1-15

DEPARTMENT OF TRANSPORTATION
FEDERAL HIGHWAY ADMINISTRATION

APPROVED:
DIVISION ENGINEER

Robert Y. Muroaka
RESIDENT ENGINEER

12-19-83
DATE

DEPARTMENT OF TRANSPORTATION
STATE OF HAWAII

APPROVED:
for **R. Higashionna**
DIR. OF TRANSPORTATION 9-24-76
DATE

ADD 1