


INDEX TO DRAWINGS	
SHEET NO.	DESCRIPTION
1	TITLE SHEET
2-5	TYPICAL ROADWAY SECTIONS
6-8	PLAN & PROFILE AND SUPERELEVATION DIAGRAMS
9-14	DETAIL ROADWAY PLANS
15-18	UTILITIES & TREE PLANTING PLANS
19-21	CONSTRUCTION PHASING, SIGNING, AND DETOUR PLANS
22-27	FALSEWORK & FIELD OFFICE
28	CONSTRUCTION NOTES
29-31	DRIVEWAY AND CURB & GUTTER DETAILS
32-35	WATER AND SEWER PLANS AND DETAILS
36-49	DRAINAGE SUMMARY, GRADING, PROFILES, AND DETAILS
50-65	SIGNING, STRIPING & MISC. DETAILS
66-67	SOIL BORINGS LOCATION & LOGS
68-114	STRUCTURAL PLANS
115-118	NEW AND EXISTING RAMP MISC. DETAILS
119-126	SPRINKLER, IRRIGATION AND PLANTING DETAILS
127	DUCT PLAN - STEPS DETAILS
128-144	ELECTRICAL PLANS
145-146	CROSS SECTIONS

Supplementary Sheets to this Project are Sht. Nos.:

- ① C.O.14S-1
- ② 89S-1, C.O.107S-1 & 108 S-1
- ③ C.O.114S-1 to C.O.114S-12

Total Sheet Count After "As-Built" Postings:
162 Sheets.

VTN Pacific, Inc.
DESIGNED BY
H. Iwai
P. S. & E. BY
548-5812
May 1980
DATE
PHONE

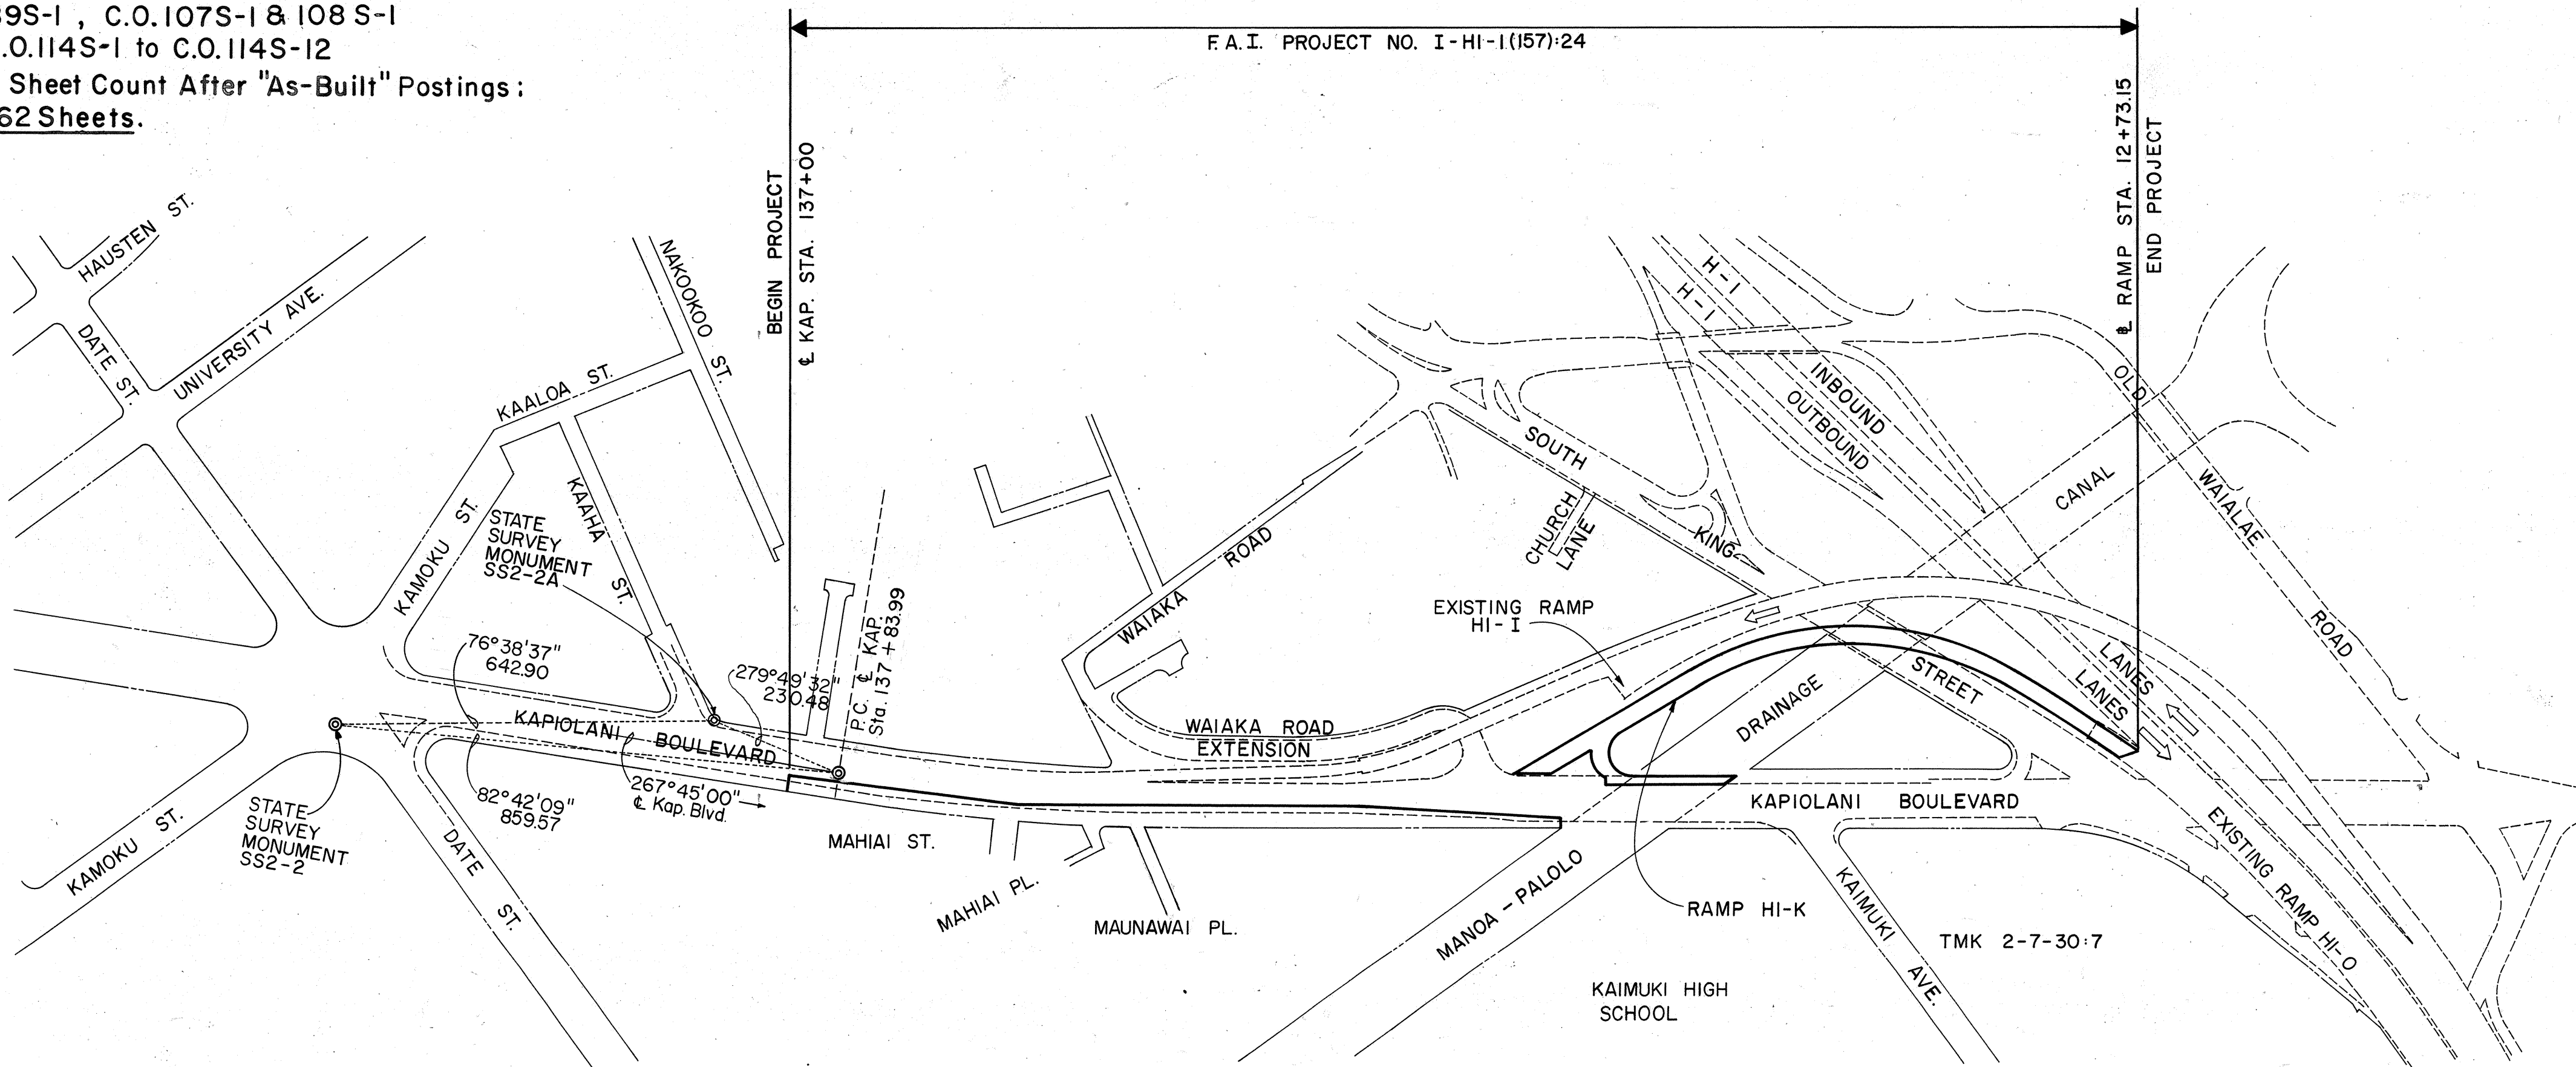

LAYOUT PLAN

GROSS LENGTH OF PROJECT 530 MI.
BRIDGES OVER 20.00' SPAN 154 MI.
NET LENGTH OF ROADWAY 376 MI.


STATE OF HAWAII
DEPARTMENT OF TRANSPORTATION
HIGHWAYS DIVISION

HONOLULU, HAWAII
"AS-BUILT"
PLANS OF

INTERSTATE ROUTE H-1
KAPIOLANI INTERCHANGE ON-RAMP
FEDERAL AID INTERSTATE PROJECT NO. I-HI-1(157):24
DISTRICT OF HONOLULU
ISLAND OF OAHU

Notes:
All references herein made to Land Transportation Facilities Division, are hereby construed to mean or refer to the Highways Division, Department of Transportation.

FED. ROAD DIST. NO.	STATE	FED. AID PROJ. NO.	FISCAL YEAR	SHEET NO.	TOTAL SHEETS
HAWAII	HAW.	I-HI-1(157):24	1979	1	146

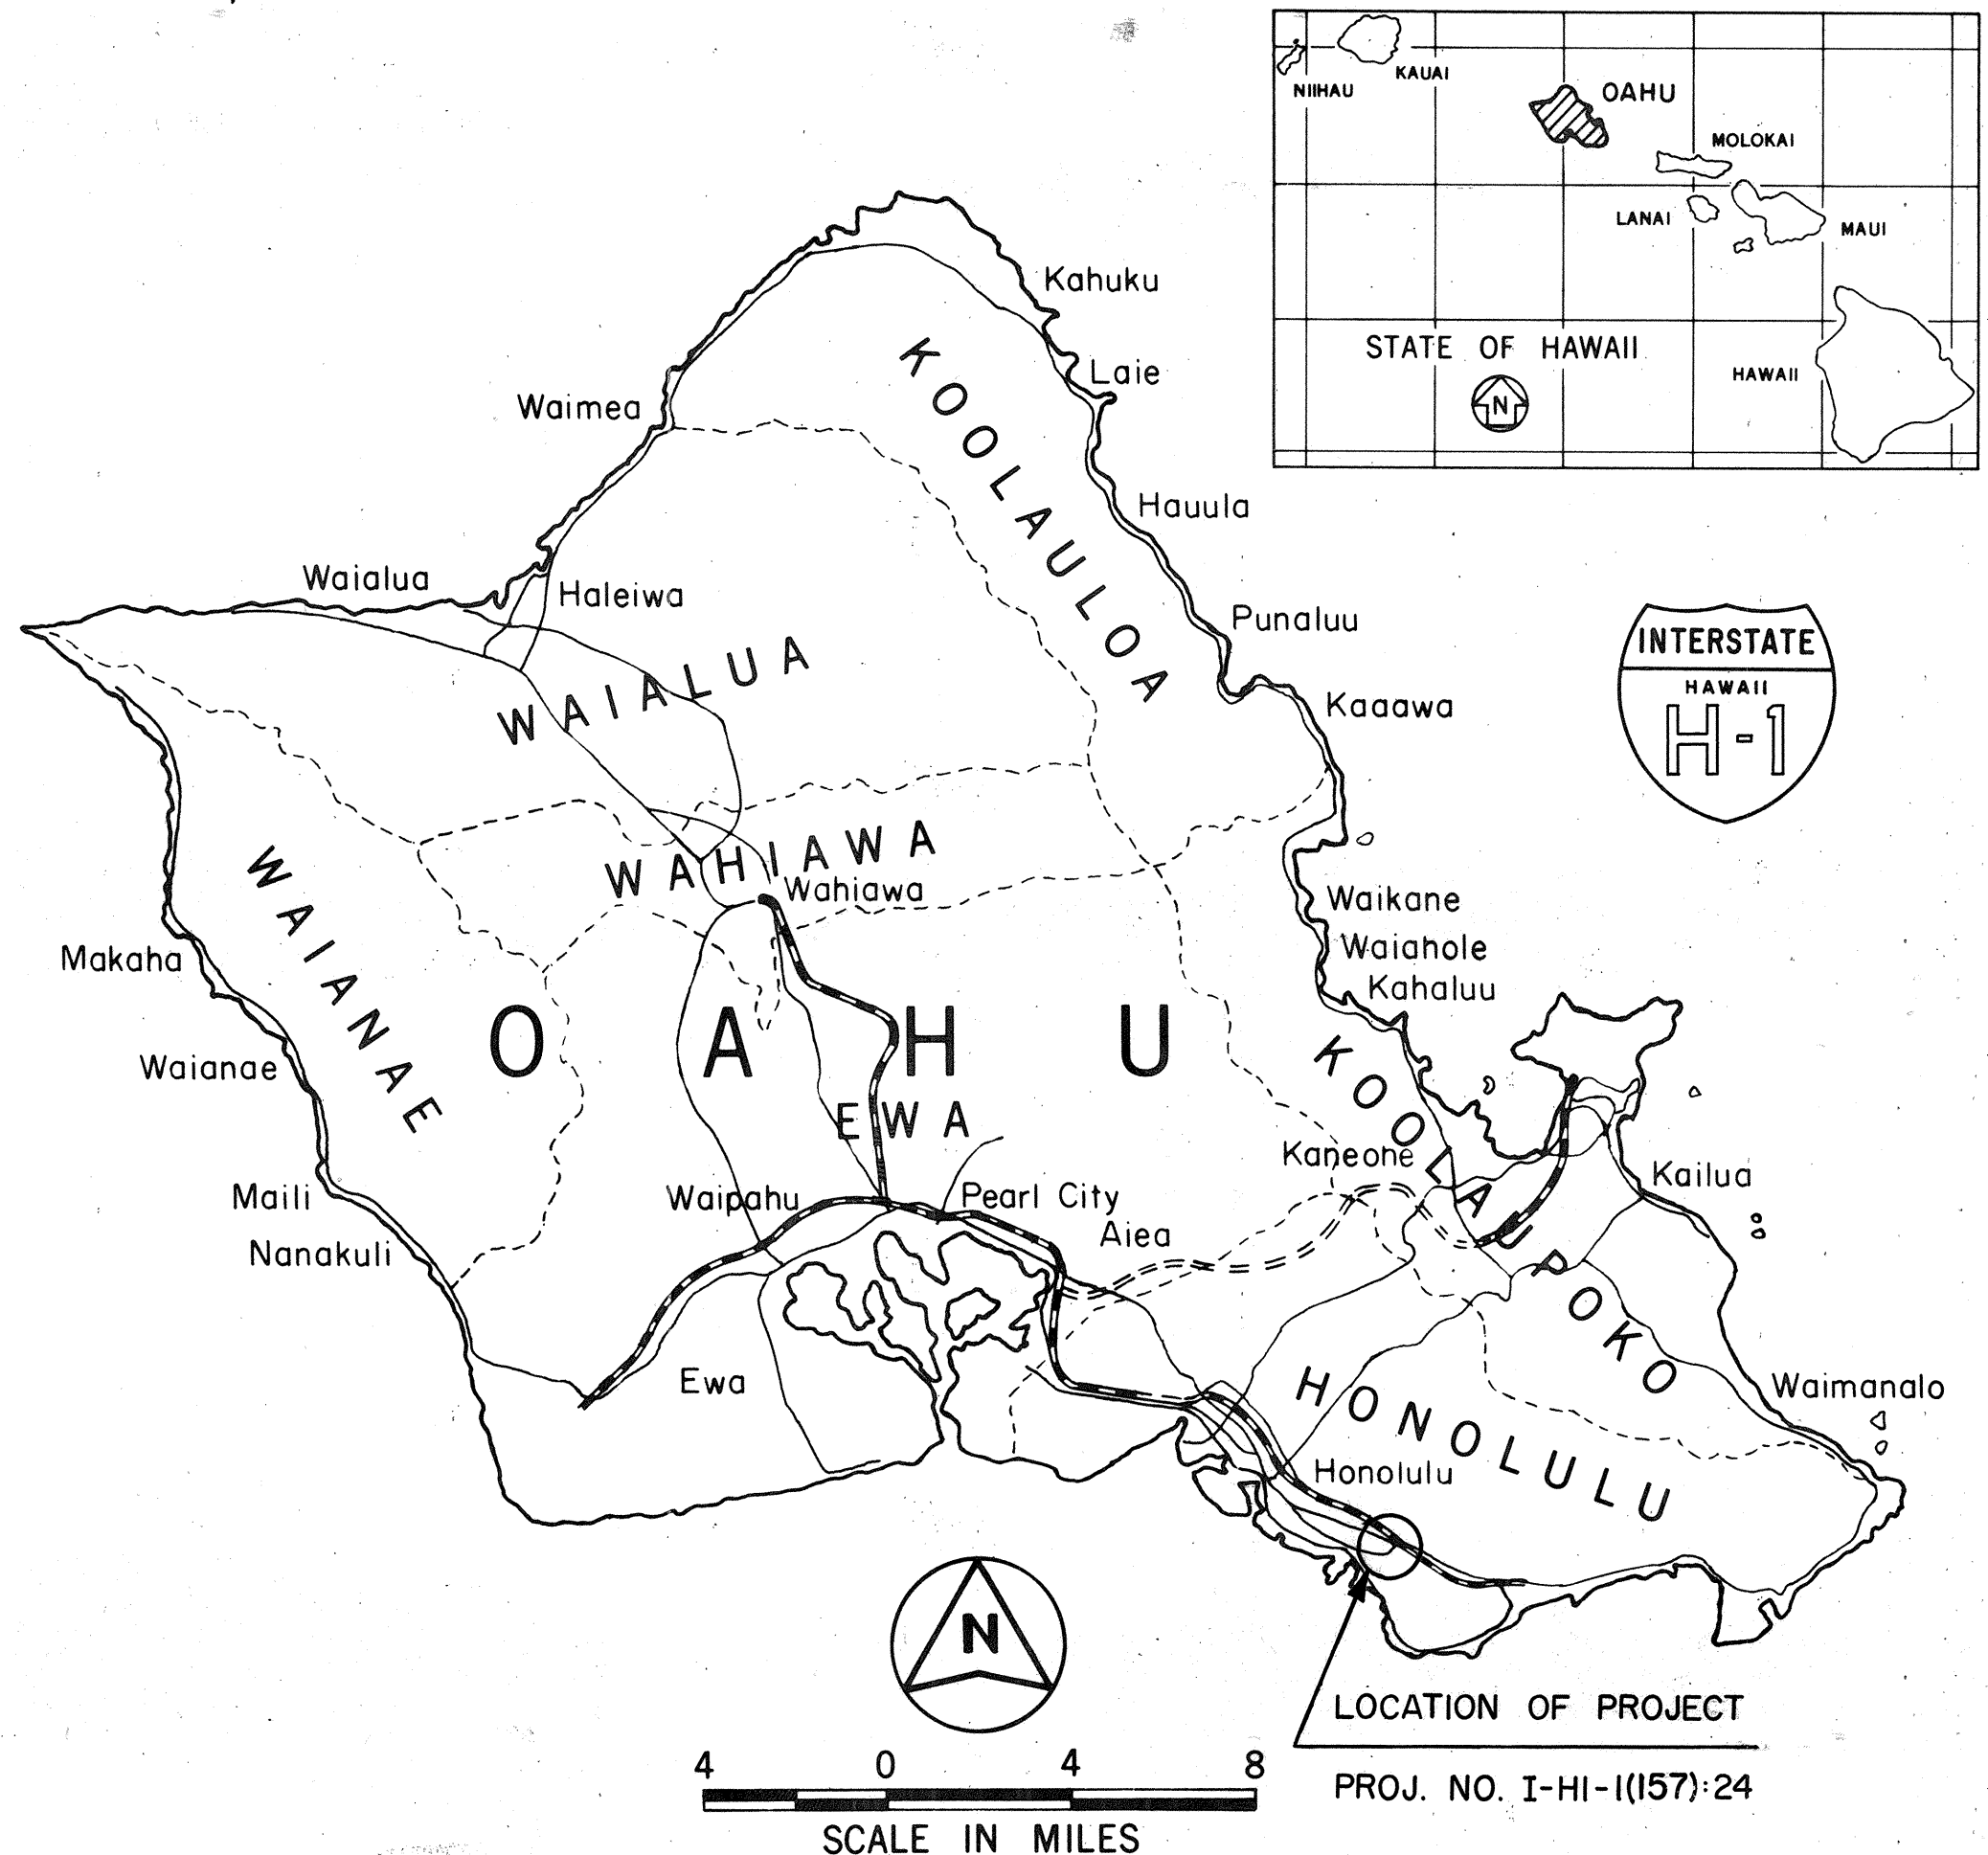

FEDERAL AID INTERSTATE PROJECTS PREVIOUSLY CONSTRUCTED OR UNDER CONSTRUCTION
CHANGES MADE DURING CONSTRUCTION HAVE BEEN INCORPORATED ON THESE PLANS EXCEPT CHANGES IN THE ORIGINAL THEORETICAL QUANTITIES. FOR ACTUAL QUANTITIES, REFER TO PROJECT LEDGER AND/OR COMPUTATION BOOK.

W. S. Miyahara
RESIDENT ENGINEER
1-28-91
DATE

DESIGN CLASSIFICATION

CURRENT ADT (1979) 12,450
DESIGN ADT (2000) 12,450
DHV 1,600
D 100%
T 2.0%
V 25 M.P.H.
CONTROL OF ACCESS = FULL

DEPARTMENT OF TRANSPORTATION
FEDERAL HIGHWAY ADMINISTRATION
APPROVED:
DIVISION ADMINISTRATOR
5-13-80
DATE

DEPARTMENT OF TRANSPORTATION
STATE OF HAWAII
APPROVED:
DIR. OF TRANSPORTATION
SHEET NO. 1 OF 1 SHEETS