

INDEX TO DRAWINGS	
SHEET NO.	DESCRIPTION
1	TITLE SHEET
2-5	TYPICAL SECTIONS
6-9	PLAN AND PROFILE
10-16	DETAIL ROADWAY PLANS
17-20	PAVEMENT GRADE PLANS
21-22	SIDEWALK PLAN & TYPICAL SECTIONS
*23-34	MISC., TYPICAL AND STANDARD ROADWAY DETAILS
35-36	UTILITY PLANS AND DETAILS
37-58	DRAINAGE PLANS AND DETAILS
59-61	IRRIGATION PLANS AND DETAILS
62-63	LANDSCAPING PLANS
64-71	CONSTRUCTION PHASING PLANS
72-77	SIGNING AND PAVEMENT MARKINGS PLAN AND DETAILS
78-80	TRAFFIC SIGNAL PLANS & DETAILS
81-85	HIGHWAY LIGHTING PLANS & DETAILS
86-100	CONSTRUCTION PHASING, SIGNING & PAVEMENT MARKINGS, TRAFFIC SIGNAL AND HIGHWAY LIGHTING STANDARD DETAILS
101-117	CROSS SECTIONS

* NOTE: PLAN SHT. NOS. 28, 29, 30, 31 & 32 HAS BEEN DELETED AND IS NOT PART OF THE CONTRACT PLANS.

SUPPLEMENTARY SHEETS TO THIS PROJECT ARE SHEET NOS.



- (a) C.O. 5S-1 & C.O. 5S-2
- (b) C.O. 16S-1 & C.O. 16S-2
- (c) C.O. 49 S-1
- (d) C.O. ADD. 59S-1
- (e) C.O. 74S-1R
- (f) 117S-1

TOTAL SHEET COUNT AFTER "AS-BUILT" POSTINGS: 120

DESIGNED BY
Ronald F. Tsuzuki
B
548-2456
April, 1981
DATE
PHONE
HIGHWAY DESIGN UNIT



STATE OF HAWAII
DEPARTMENT OF TRANSPORTATION
HIGHWAYS DIVISION
HONOLULU, HAWAII
"AS - BUILT"
PLANS FOR
CONSTRUCTION OF A PORTION OF
INTERSTATE ROUTE H-1
HALAWA INTERCHANGE
KAHUAPAANI STREET
HALAWA STREAM TO SALT LAKE BOULEVARD
FEDERAL AID INTERSTATE PROJ. NO. I-HI-1(96):13
DISTRICT OF EWA
ISLAND OF OAHU

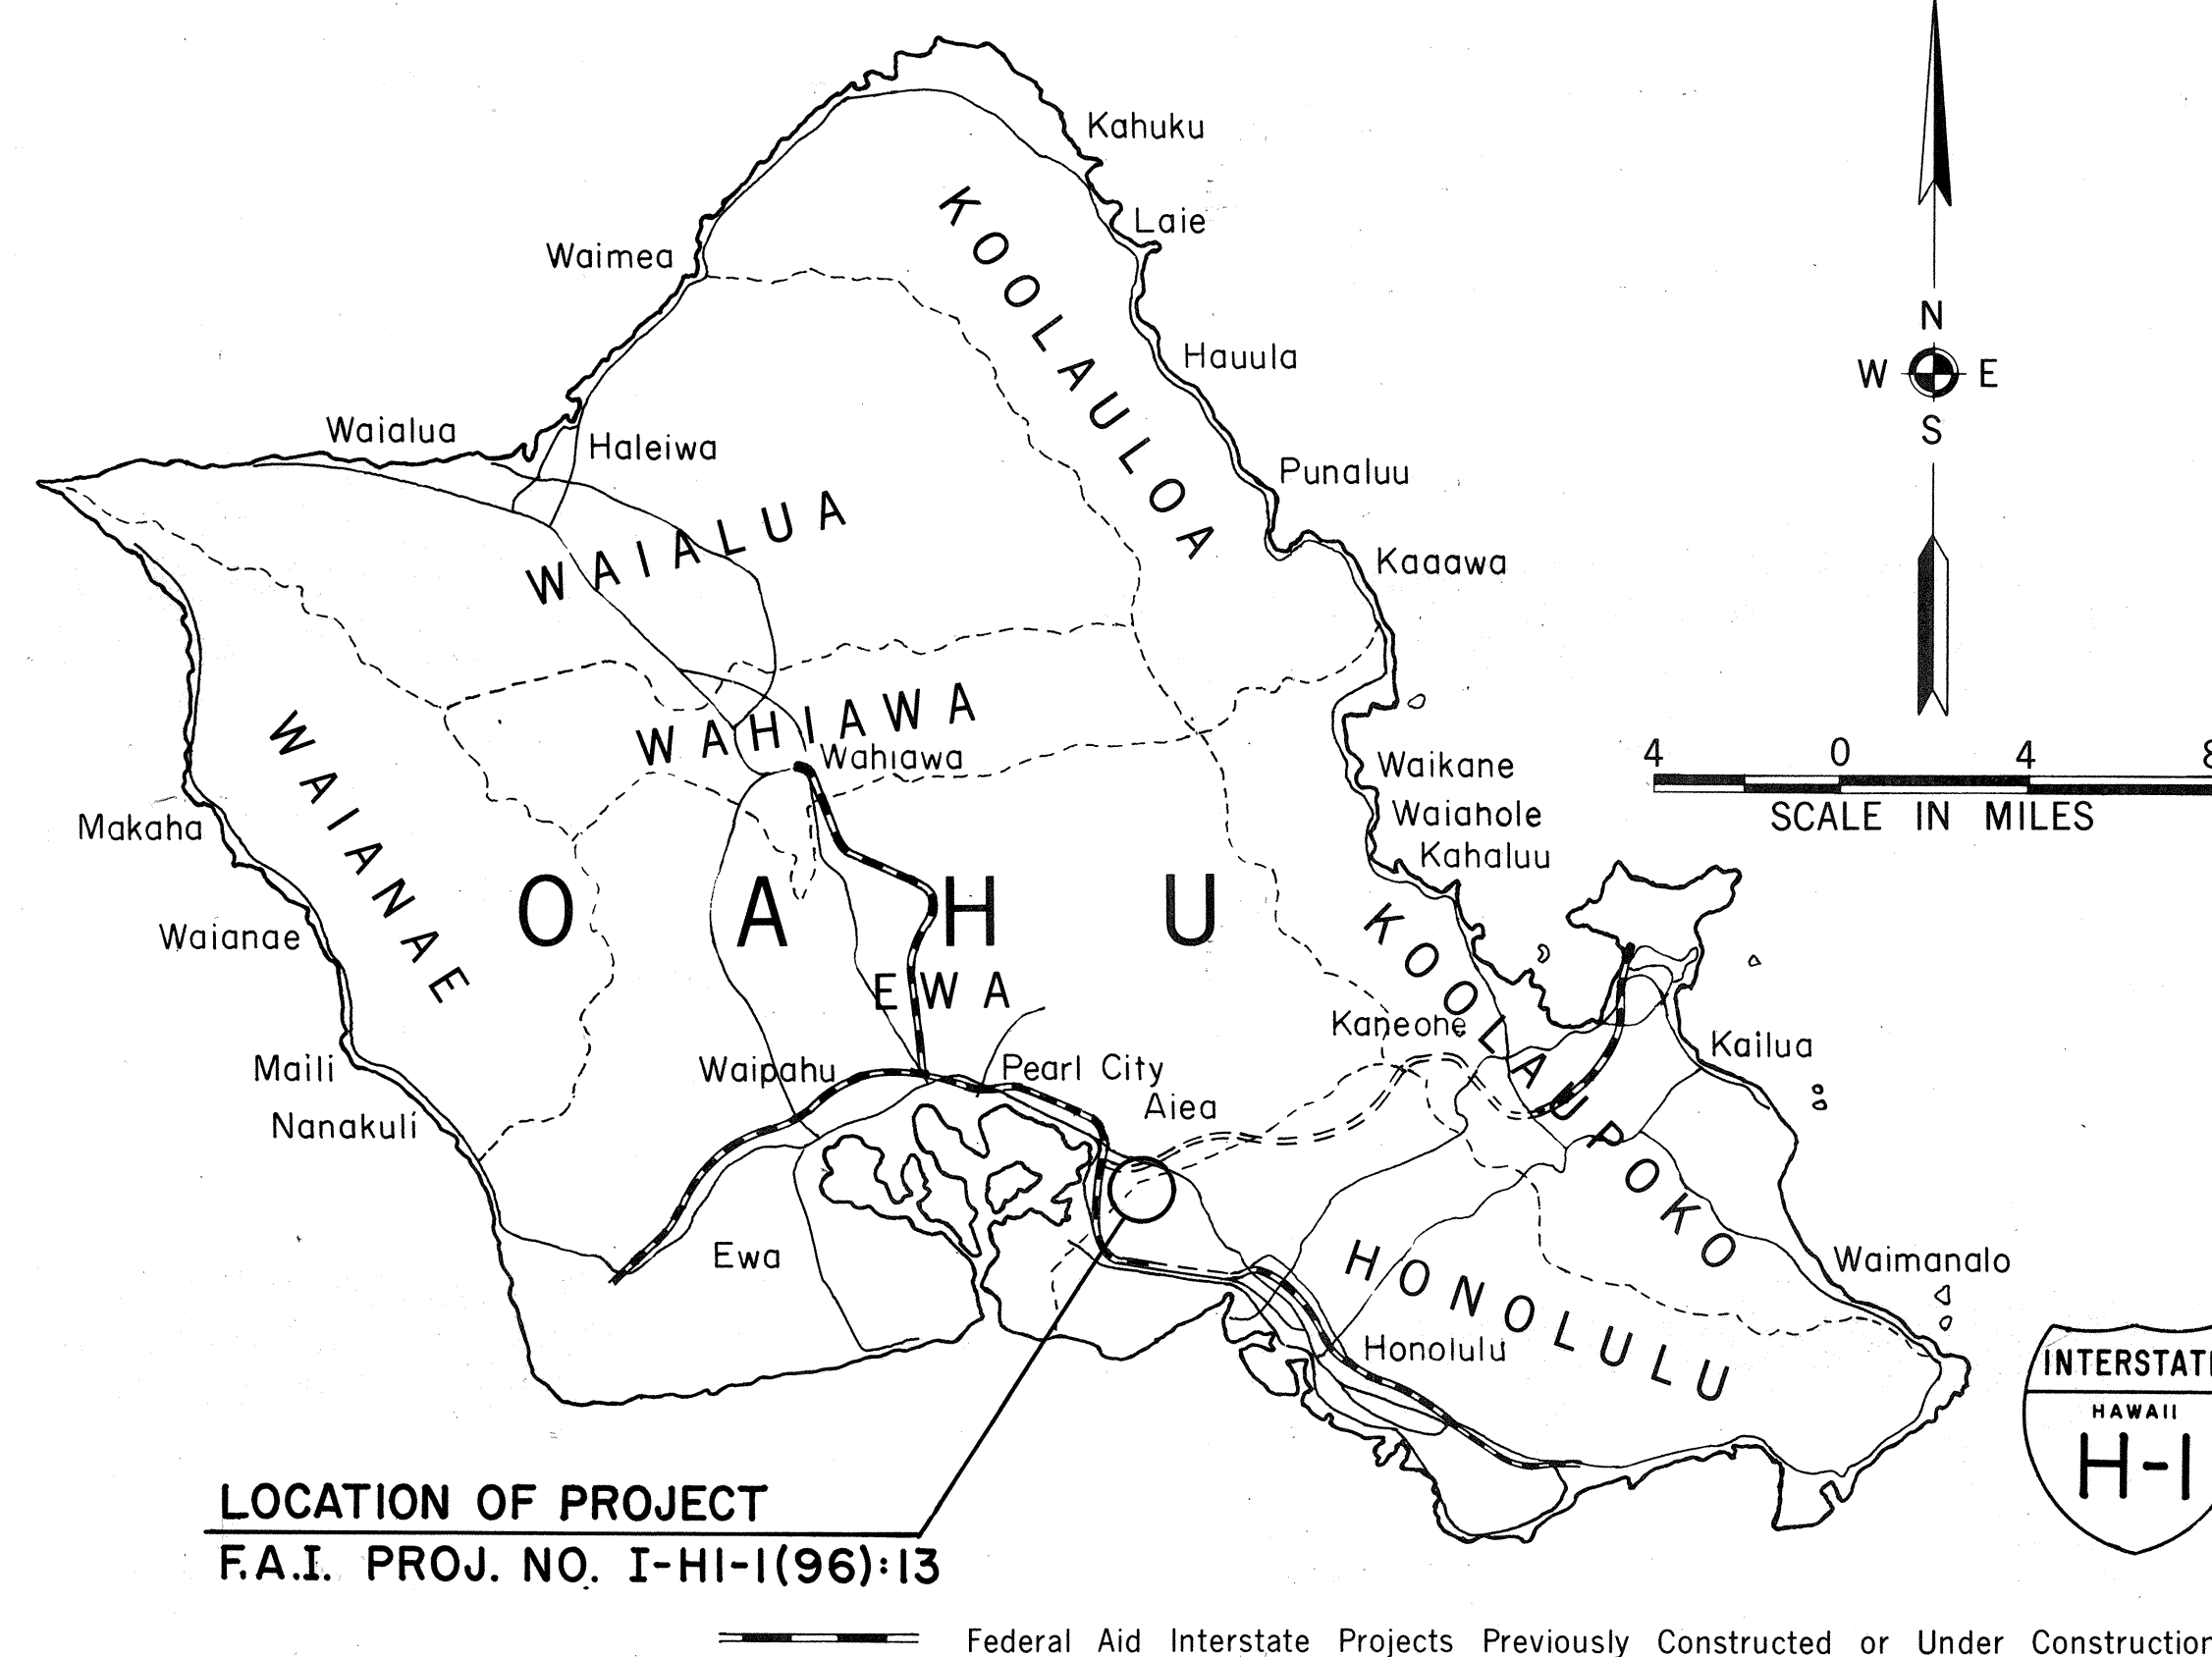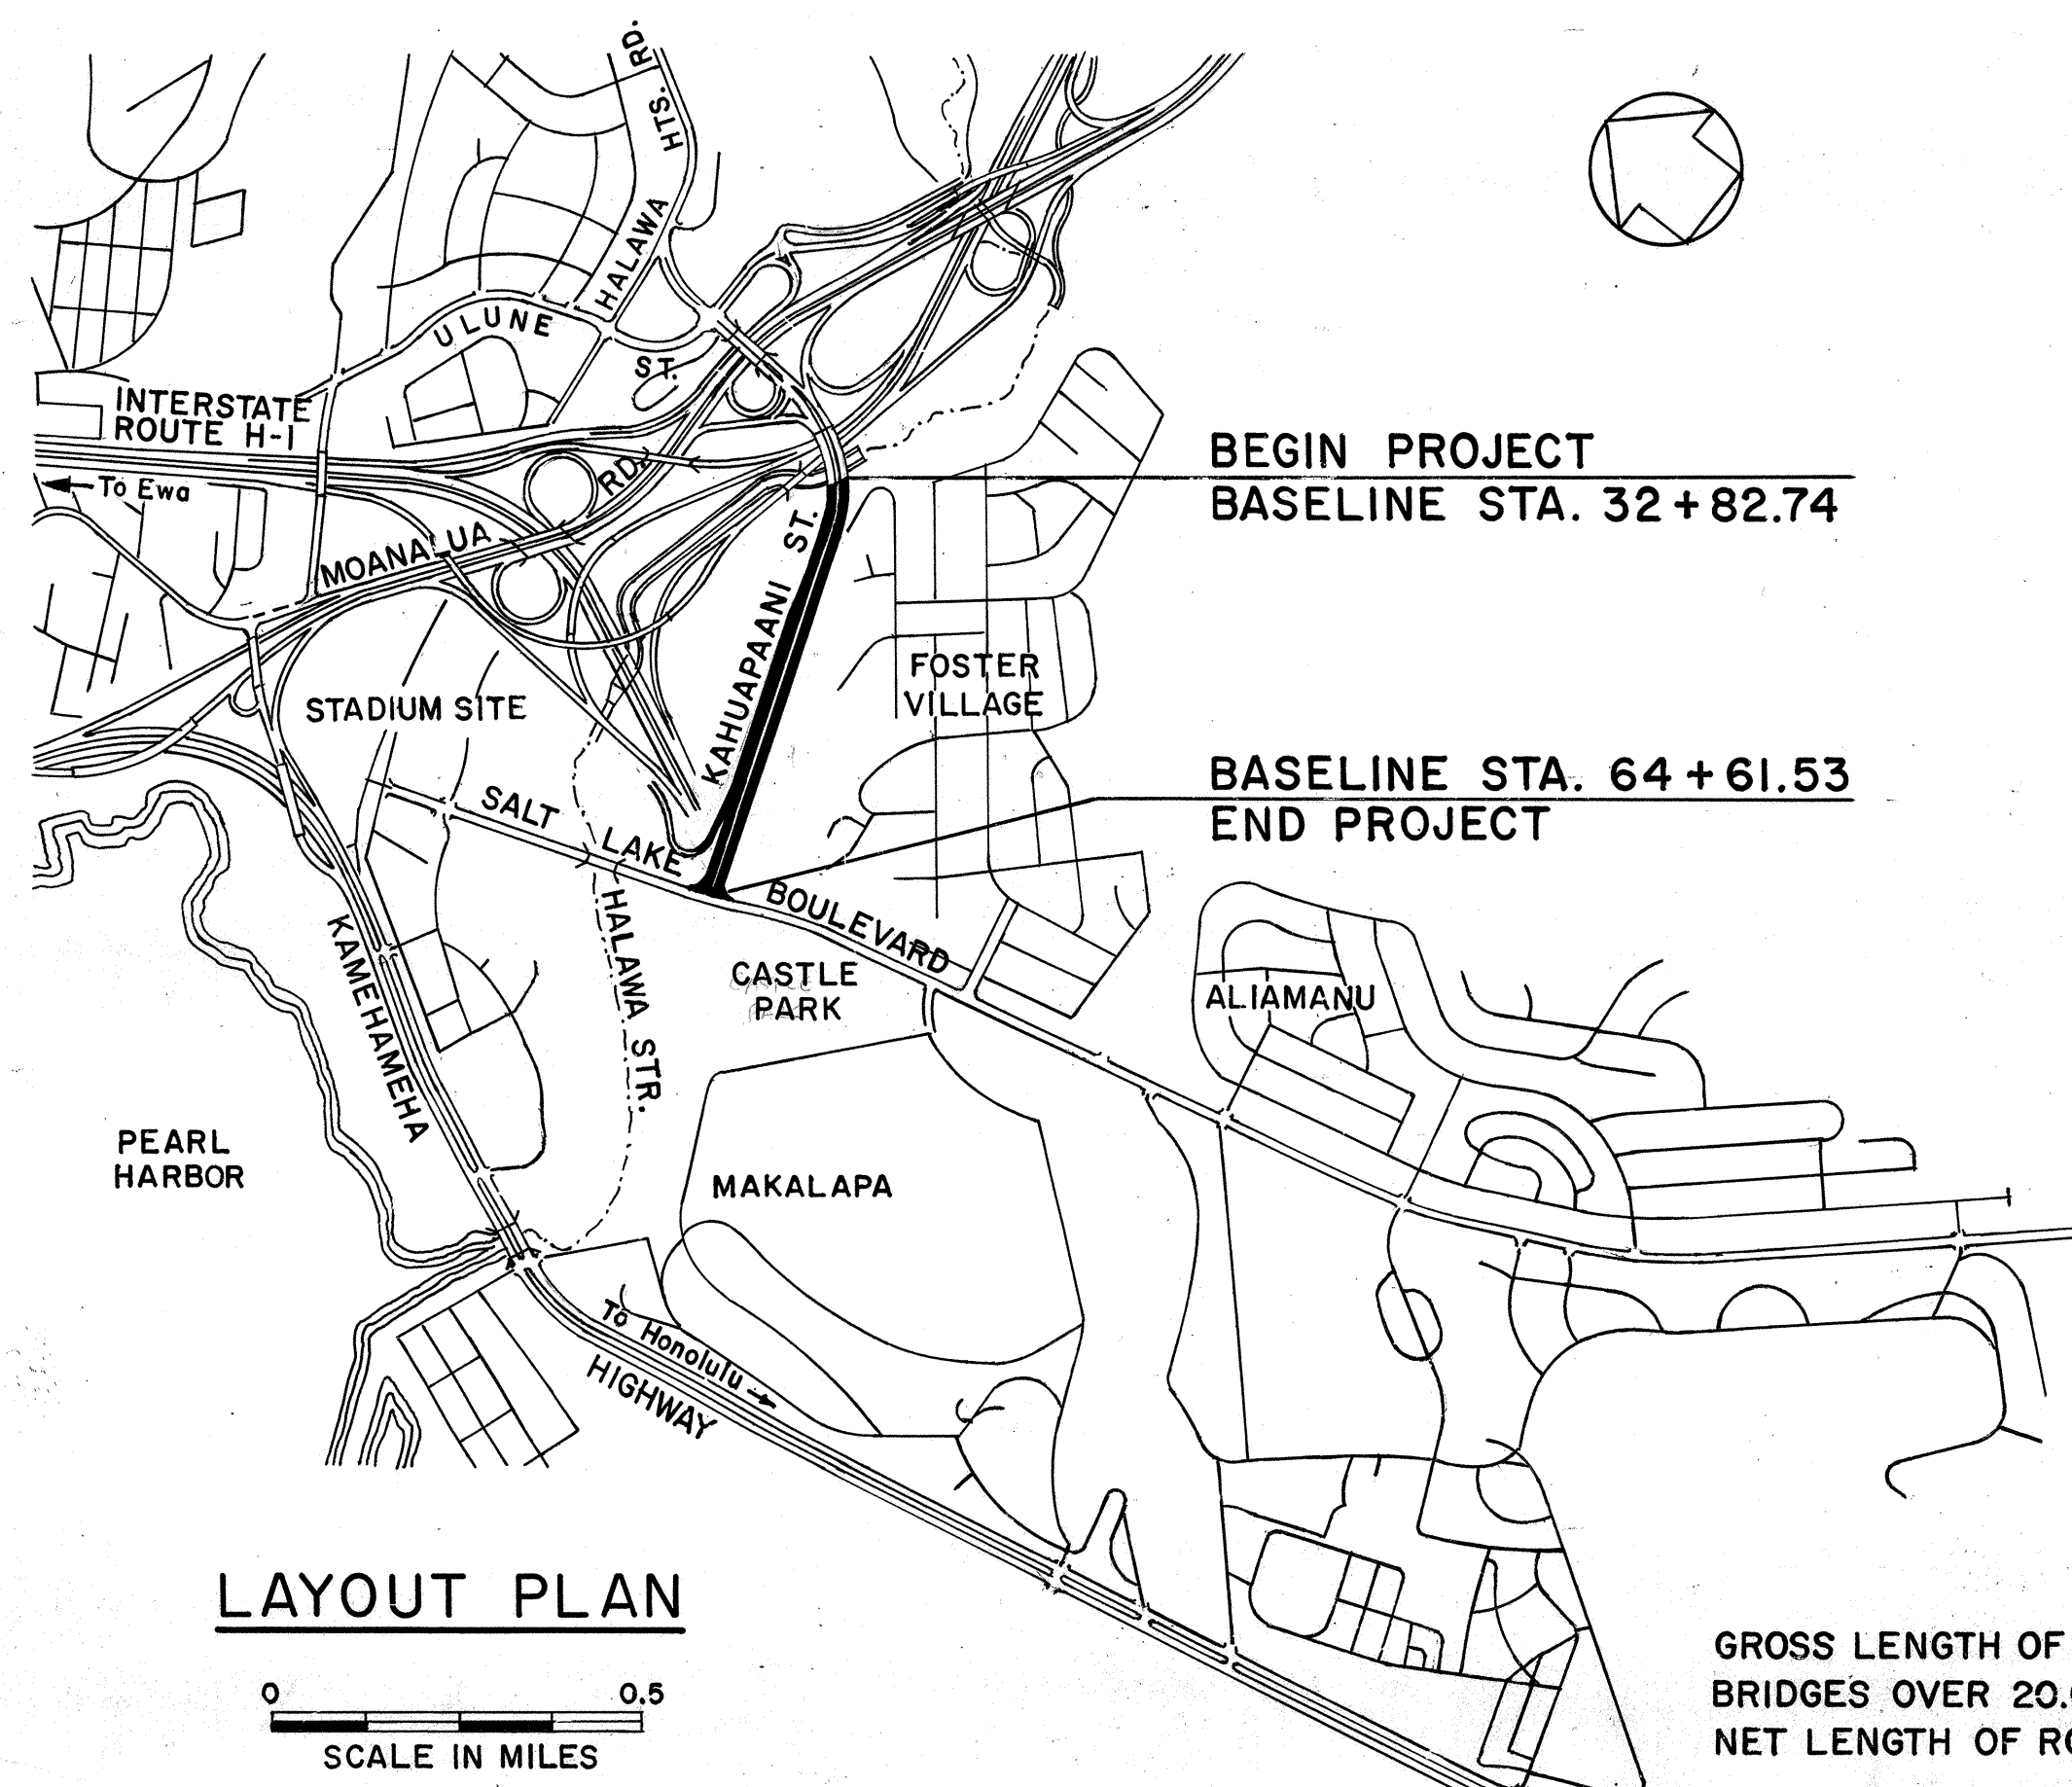

CHANGES MADE DURING CONSTRUCTION HAVE BEEN INCORPORATED ON THESE PLANS EXCEPT CHANGES IN THE ORIGINAL THEORETICAL QUANTITIES. FOR ACTUAL QUANTITIES, REFER TO PROJECT LEDGER AND/OR COMPUTATION BOOK.

RESIDENT ENGINEER

DATE

DESIGN DESIGNATION

CURRENT ADT 10,400
DESIGN ADT (2,000) 13,790
DHV 870
D 57/43
T 1.5%
V 50 M.P.H.

DEPARTMENT OF TRANSPORTATION
FEDERAL HIGHWAY ADMINISTRATION
APPROVED:
DIVISION ENGINEER
DATE

DEPARTMENT OF TRANSPORTATION
STATE OF HAWAII
APPROVED:
DIR. OF TRANSPORTATION
DATE

GROSS LENGTH OF PROJECT 0.602 MI.
BRIDGES OVER 20.00' SPAN 0.000 MI.
NET LENGTH OF ROADWAY 0.602 MI.