 
 
 
 
 
 


FED. ROAD DIST. NO.	STATE	FED. AID PROJ. NO.	FISCAL YEAR	SHEET NO.	TOTAL SHEETS
HAWAII	HAW.	I-HI-1(133)17	1981	51	159

NOTE: ESTIMATED QUANTITY FOR LUMP SUM ITEMS WILL BE USED TO DETERMINE THE THEORETICAL UNIT PRICE AS DEFINED IN SUB-SECTION 104.02(B) OF THE STANDARD SPEC.

LEGEND			
SYMBOLS	REPRESENTS	REFERENCE	
		DETAIL	NOTE
	EXISTING WOOD OR METAL LTG. STD. WITH LUMINAIRE I.D. N2.		
	METAL LTG. STD. ON STRUCTURE (W/ANCHORAGE AND 250W. H.P.S. LUMINAIRE TYPE L2-W)	3/E4 4/E4 1/E6	
	METAL LTG. STD. ON GRADE (W/FND. AND 250 W. H.P.S. LUMINAIRE TYPE L2-W)	3/E4, 4/E4, 2/E7 1/E5, 1/E6	
	RACEWAY RUN UNDERGROUND; LIGHTING SYSTEM, EXCEPT AS INDICATED		3/E1 9/E1
	RACEWAY RUN IN PARAPET; LIGHTING SYSTEM, EXCEPT AS SHOWN	2/E4	3/E1 THRU 6/E1
	COMMUNICATIONS SYSTEM RACEWAY		3/E1 THRU 6/E1
	CAP AND MARK RACEWAY; END RACEWAY	3/E7	
	PULL BOX TYPE CCI, FOR LIGHTING SYSTEM	5/E4	
	PULL BOX TYPE CC4, FOR LIGHTING SYSTEM	5/E4	
	PULL BOX CAST IRON (SIZE B, ETC.)	1/E1	
	METAL LTG. STD. ON STRUCTURE, TWIN (W/ANCHORAGE AND 250W. H.P.S. LUMINAIRES W/ SHIELD, TYPE L2-W-S)	4/E4 1/E6 1/E6	

ELECTRICAL				
ITEM NO	ITEM	UNIT	QUANTITIES	
			HIGHWAY	BRIDGE
622.7001	METAL LIGHTING STANDARD ON STRUCTURE	EA		7
622.7002	METAL LIGHTING STANDARD ON GRADE	EA	3	
622.7005	UNDERGROUND RACEWAY, LTG. SYSTEM	LS	2250'	
622.7008	WIRE, 600 VOLT, 1/C, #6	LS	4500'	2700'
622.7009	WIRE, 600 VOLT, 1/C, #4	LS	900'	2700'
622.7013	PULL BOX, CAST IRON	LS		12
622.7016	PULL BOX, TYPE CC, LIGHTING SYSTEM	EA	7	
622.7024	RACEWAY ON STRUCTURE	LS		2000'
622.7028	METAL LIGHTING STANDARD ON STR., TWIN	EA		2
622.7029	MISCELLANEOUS ELECTRICAL APPURTENANCES	LS	1	

GENERAL NOTES APPLYING TO ALL ELECTRICAL SHEETS

- 1/E1. ON PLAN SHEETS EXISTING FACILITIES ARE DESIGNATED BY NOTATION OR BY THE LETTER (E) IN CONJUNCTION WITH THE SYMBOL.
- 2/E1. DETAIL AND NOTES ARE NUMBERED AS FOLLOWS:
1/E3 ← DETAIL OR NOTE NUMBER WHICH ELECTRICAL SHEET ON WHICH DETAIL OR NOTE APPEARS.
- 3/E1. PROVIDE UNDERGROUND RACEWAYS AND RACEWAYS RUN IN STRUCTURE IN 2" SIZE, EXCEPT AS NOTED, AND OF TYPE NMR, EXCEPT AS NOTED, PROVIDE 1 INCH AND SMALLER SIZE RACEWAYS OF TYPE RGS.
- 4/E1. FOR A DISTANCE OF 10 FEET ON BOTH SIDES OF C OF BEARING AT STRUCTURE ABUTMENTS PROVIDE RACEWAYS OF TYPE RGS.
- 5/E1. PROVIDE AN EXPANSION-DEFLECTION FITTING IN ALL RACEWAYS AT BRIDGE EXPANSION JOINTS.
- 6/E1. IN TYPE NMR RACEWAY RUN IN STRUCTURE, PROVIDE A#6 BARE COPPER CABLE AND BOND ALL LTG. STANDARDS, PULL BOXES, AND METAL RACEWAY SEGMENTS TO IT. CONNECT CABLE TO GND ROD IN PULLBOX NOTED ON PLAN.
- 7/E1. EXTEND ALL PHASES OF FEEDER TERMINATION TO POINT INDICATED ON PLAN.
- 8/E1. NONE
- 9/E1. PROVIDE UNDERGROUND RACEWAYS WHICH RUN ABOVE PIER FOOTINGS IN TYPE RGS TO POINTS 5 FEET BEYOND FOOTING.

CAST IRON PULLBOXES IN STRUCTURE		
PLAN SYMBOL	SIZE (INCHES) L X W X D	GENERAL APPLICATION
A	16 X 6 X 4	#4 LTG. FEEDERS
B	8 X 6 X 4	#6 LTG. FEEDERS, COMM. LATERALS

NOTE: PROVIDE ALL BOXES WITH INSIDE RECESSED FLANGE.

DETAIL 1/E1 - PULLBOX SCHEDULE

LIST OF ABBREVIATIONS


C	RACEWAY (TYPE AND SIZE AS INDICATED)
NMR	NON-METALLIC RACEWAY (TYPE PVC OR CAD)
RGS	RIGID GALVANIZED STEEL CONDUIT
RAL	RIGID ALUMINUM CONDUIT
PVC	POLYVINYLCHLORIDE CONDUIT
CAD	CEMENT ASBESTOS DUCT
LTG	LIGHTING
LTG STD	LIGHTING STANDARD
BKT	BRACKET ARM
FND	FOUNDATION
CKT	CIRCUIT
FDR	FEEDER (OR BRANCH THEREOF)
GND	GROUND
N.T.S.	NOT TO SCALE
N.I.C.	NOT IN CONTACT
FUT.	FUTURE
(E)	EXISTING
CONC.	CONCRETE
H.P.S.	HIGH PRESSURE SODIUM LAMP
HG	MERCURY VAPOR LAMP
E.T.W.	EDGE OF TRAVELED WAY
P.B.	PULL BOX
A.N.S.I.	AMERICAN NATIONAL STANDARDS INSTITUTE

STATE OF HAWAII
DEPARTMENT OF TRANSPORTATION
HIGHWAYS DIVISION






ELECTRICAL PLAN
LEGEND, NOTES, DETAILS
INTERSTATE ROUTE H-1
PROJECT NO. 1 - HI-1 (133) :17

SCALE: NONE DATE: 4/30/81
SHEET No. E1 OF E7 SHEETS

FED. ROAD DIST. NO.	STATE	FED. AID PROJ. NO.	FISCAL YEAR	SHEET NO.	TOTAL SHEETS
HAWAII	HAW.	I-HI-1(133):17	1981	53	159

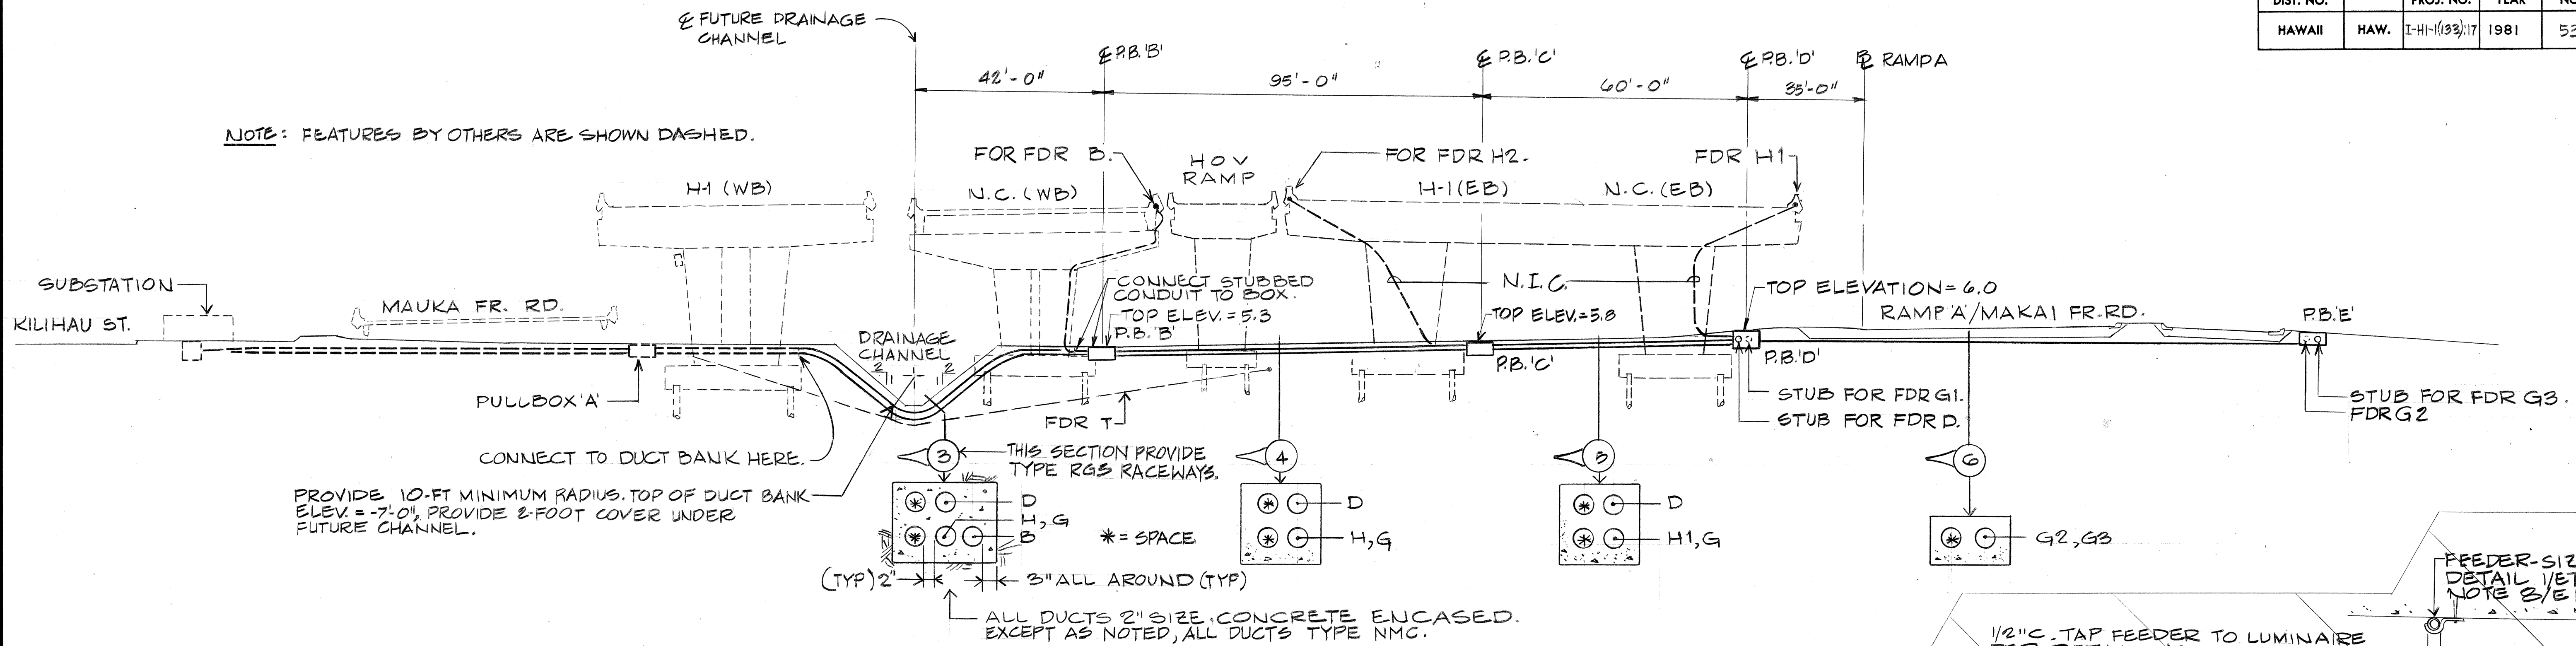

DETAIL 1/E3 - SECTION AT PIER LINE 27 LOOKING EAST 1" = 20'

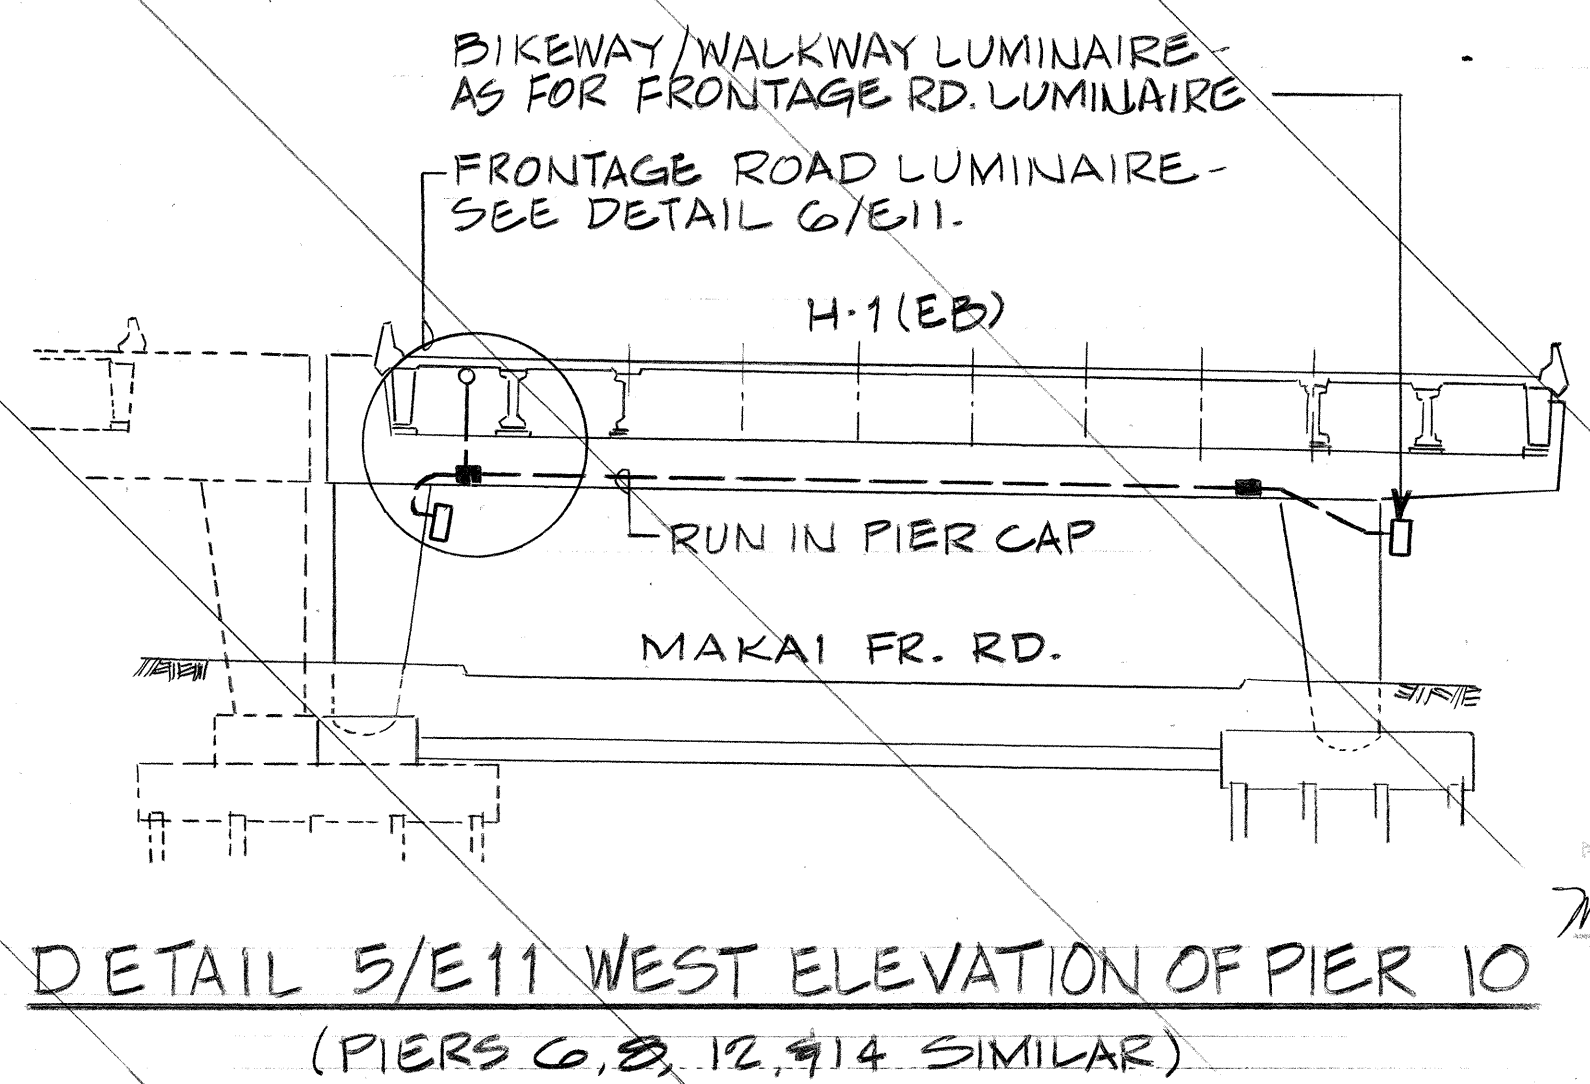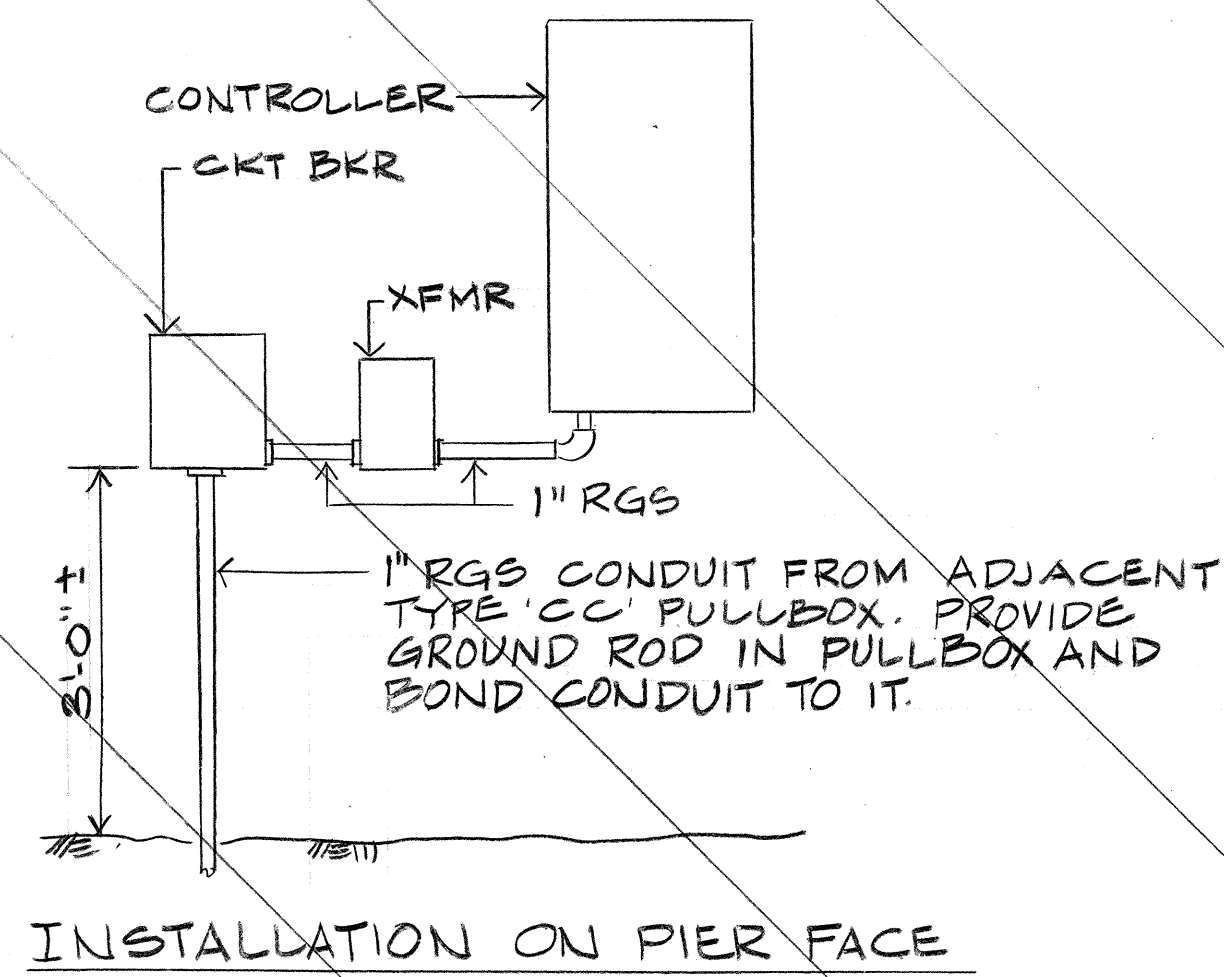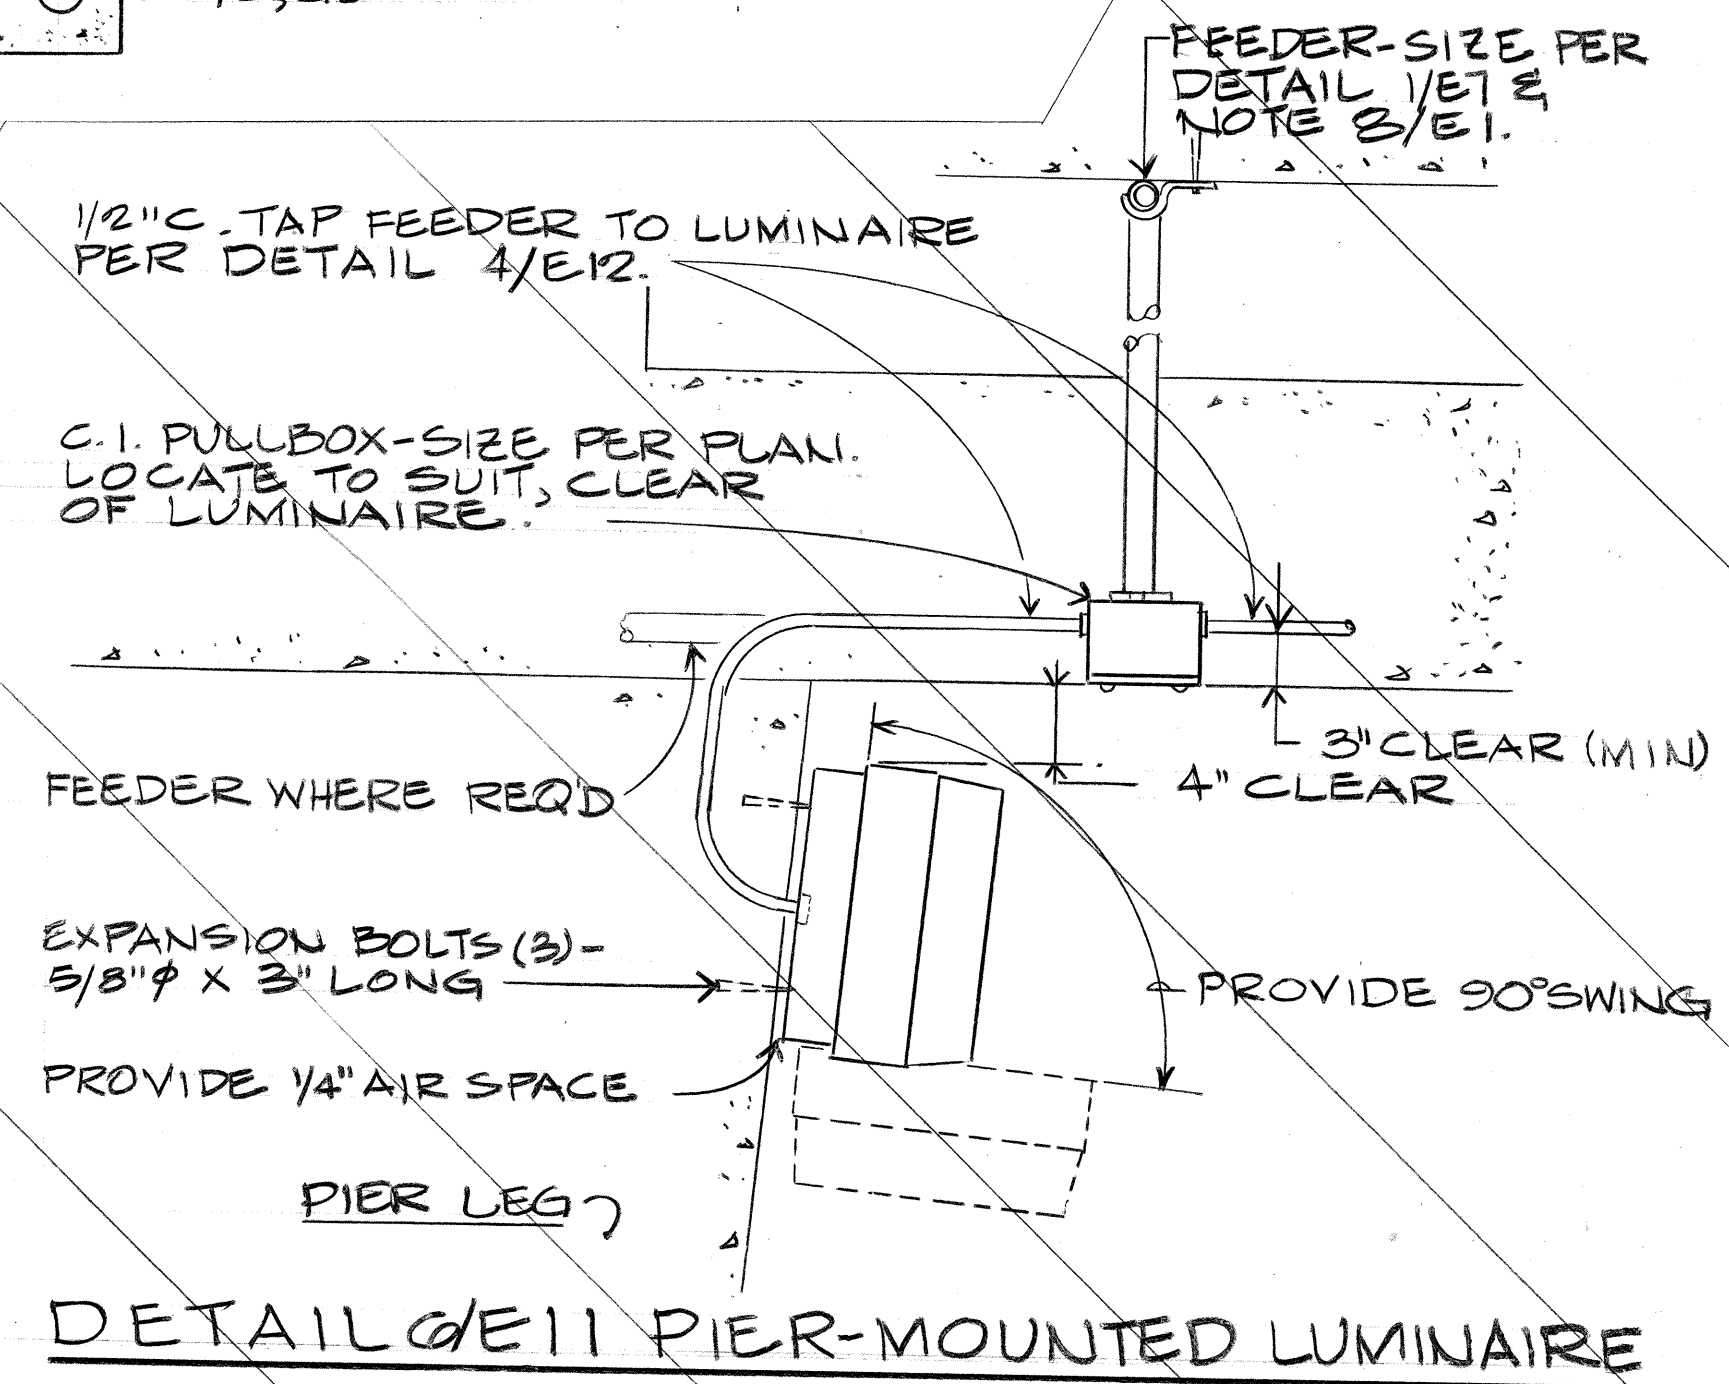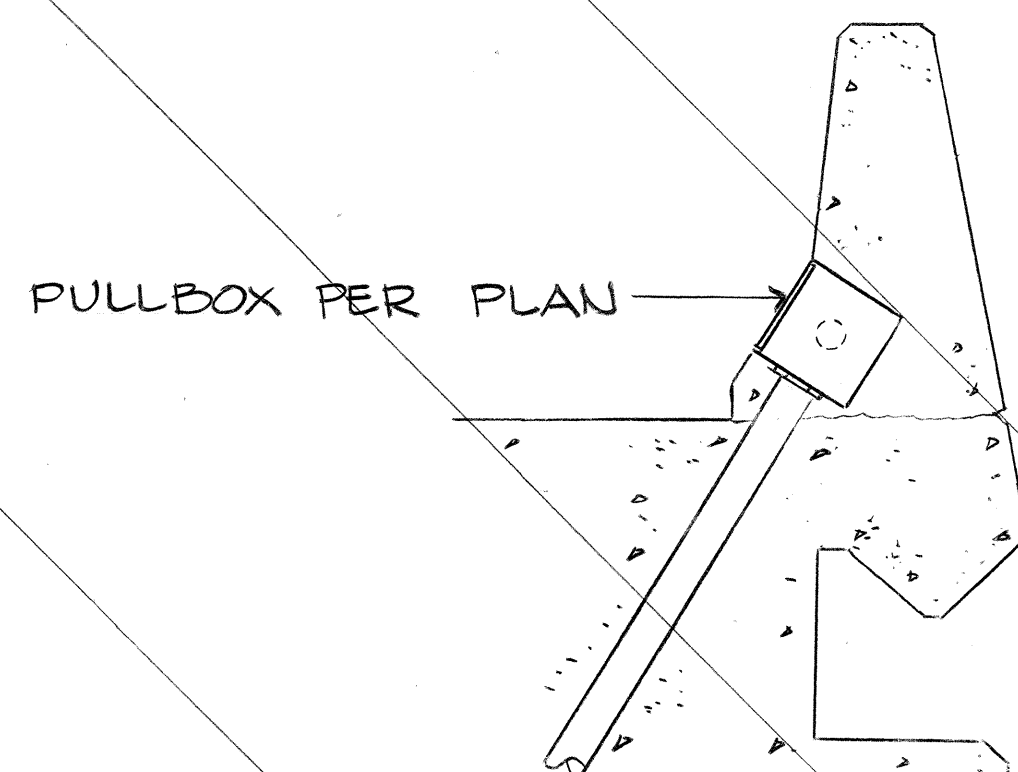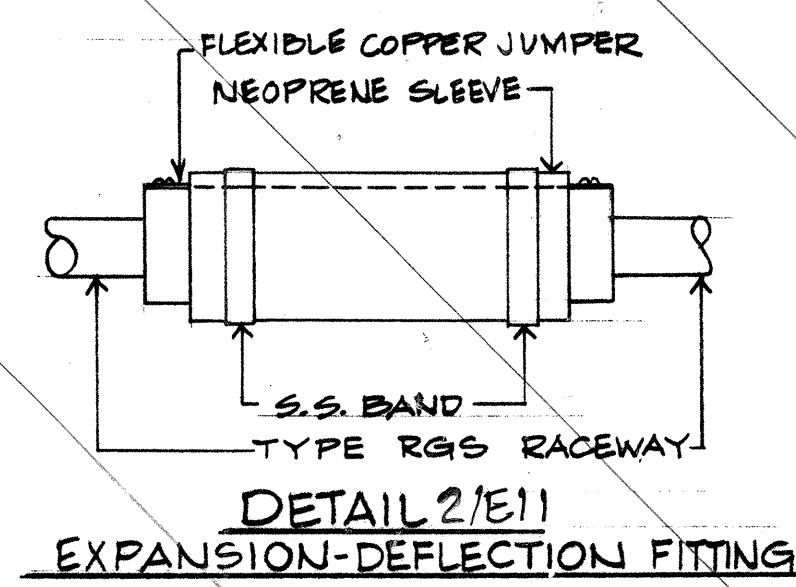

STATE OF HAWAII
DEPARTMENT OF TRANSPORTATION
HIGHWAYS DIVISION


ELECTRICAL PLAN
DETAILS - PART III

INTERSTATE ROUTE H-1
PROJECT NO. I-HI-1 (133):17

SCALE: AS NOTED DATE: 4/30/81
SHEET No. 53 OF 7 SHEETS








DATE	_____
SURVEY PLOTTED BY	_____
DRAWN BY	_____
DESIGNED BY	_____
QUANTITIES BY	_____
CHECKED BY	_____
ORIGINAL PLAN	_____
NOTE BOOK	_____
No.	_____

FED. ROAD DIST. NO.	STATE	FED. AID PROJ. NO.	FISCAL YEAR	SHEET NO.	TOTAL SHEETS
HAWAII	HAW.	I-HI-1(133)-17	1981	55	159

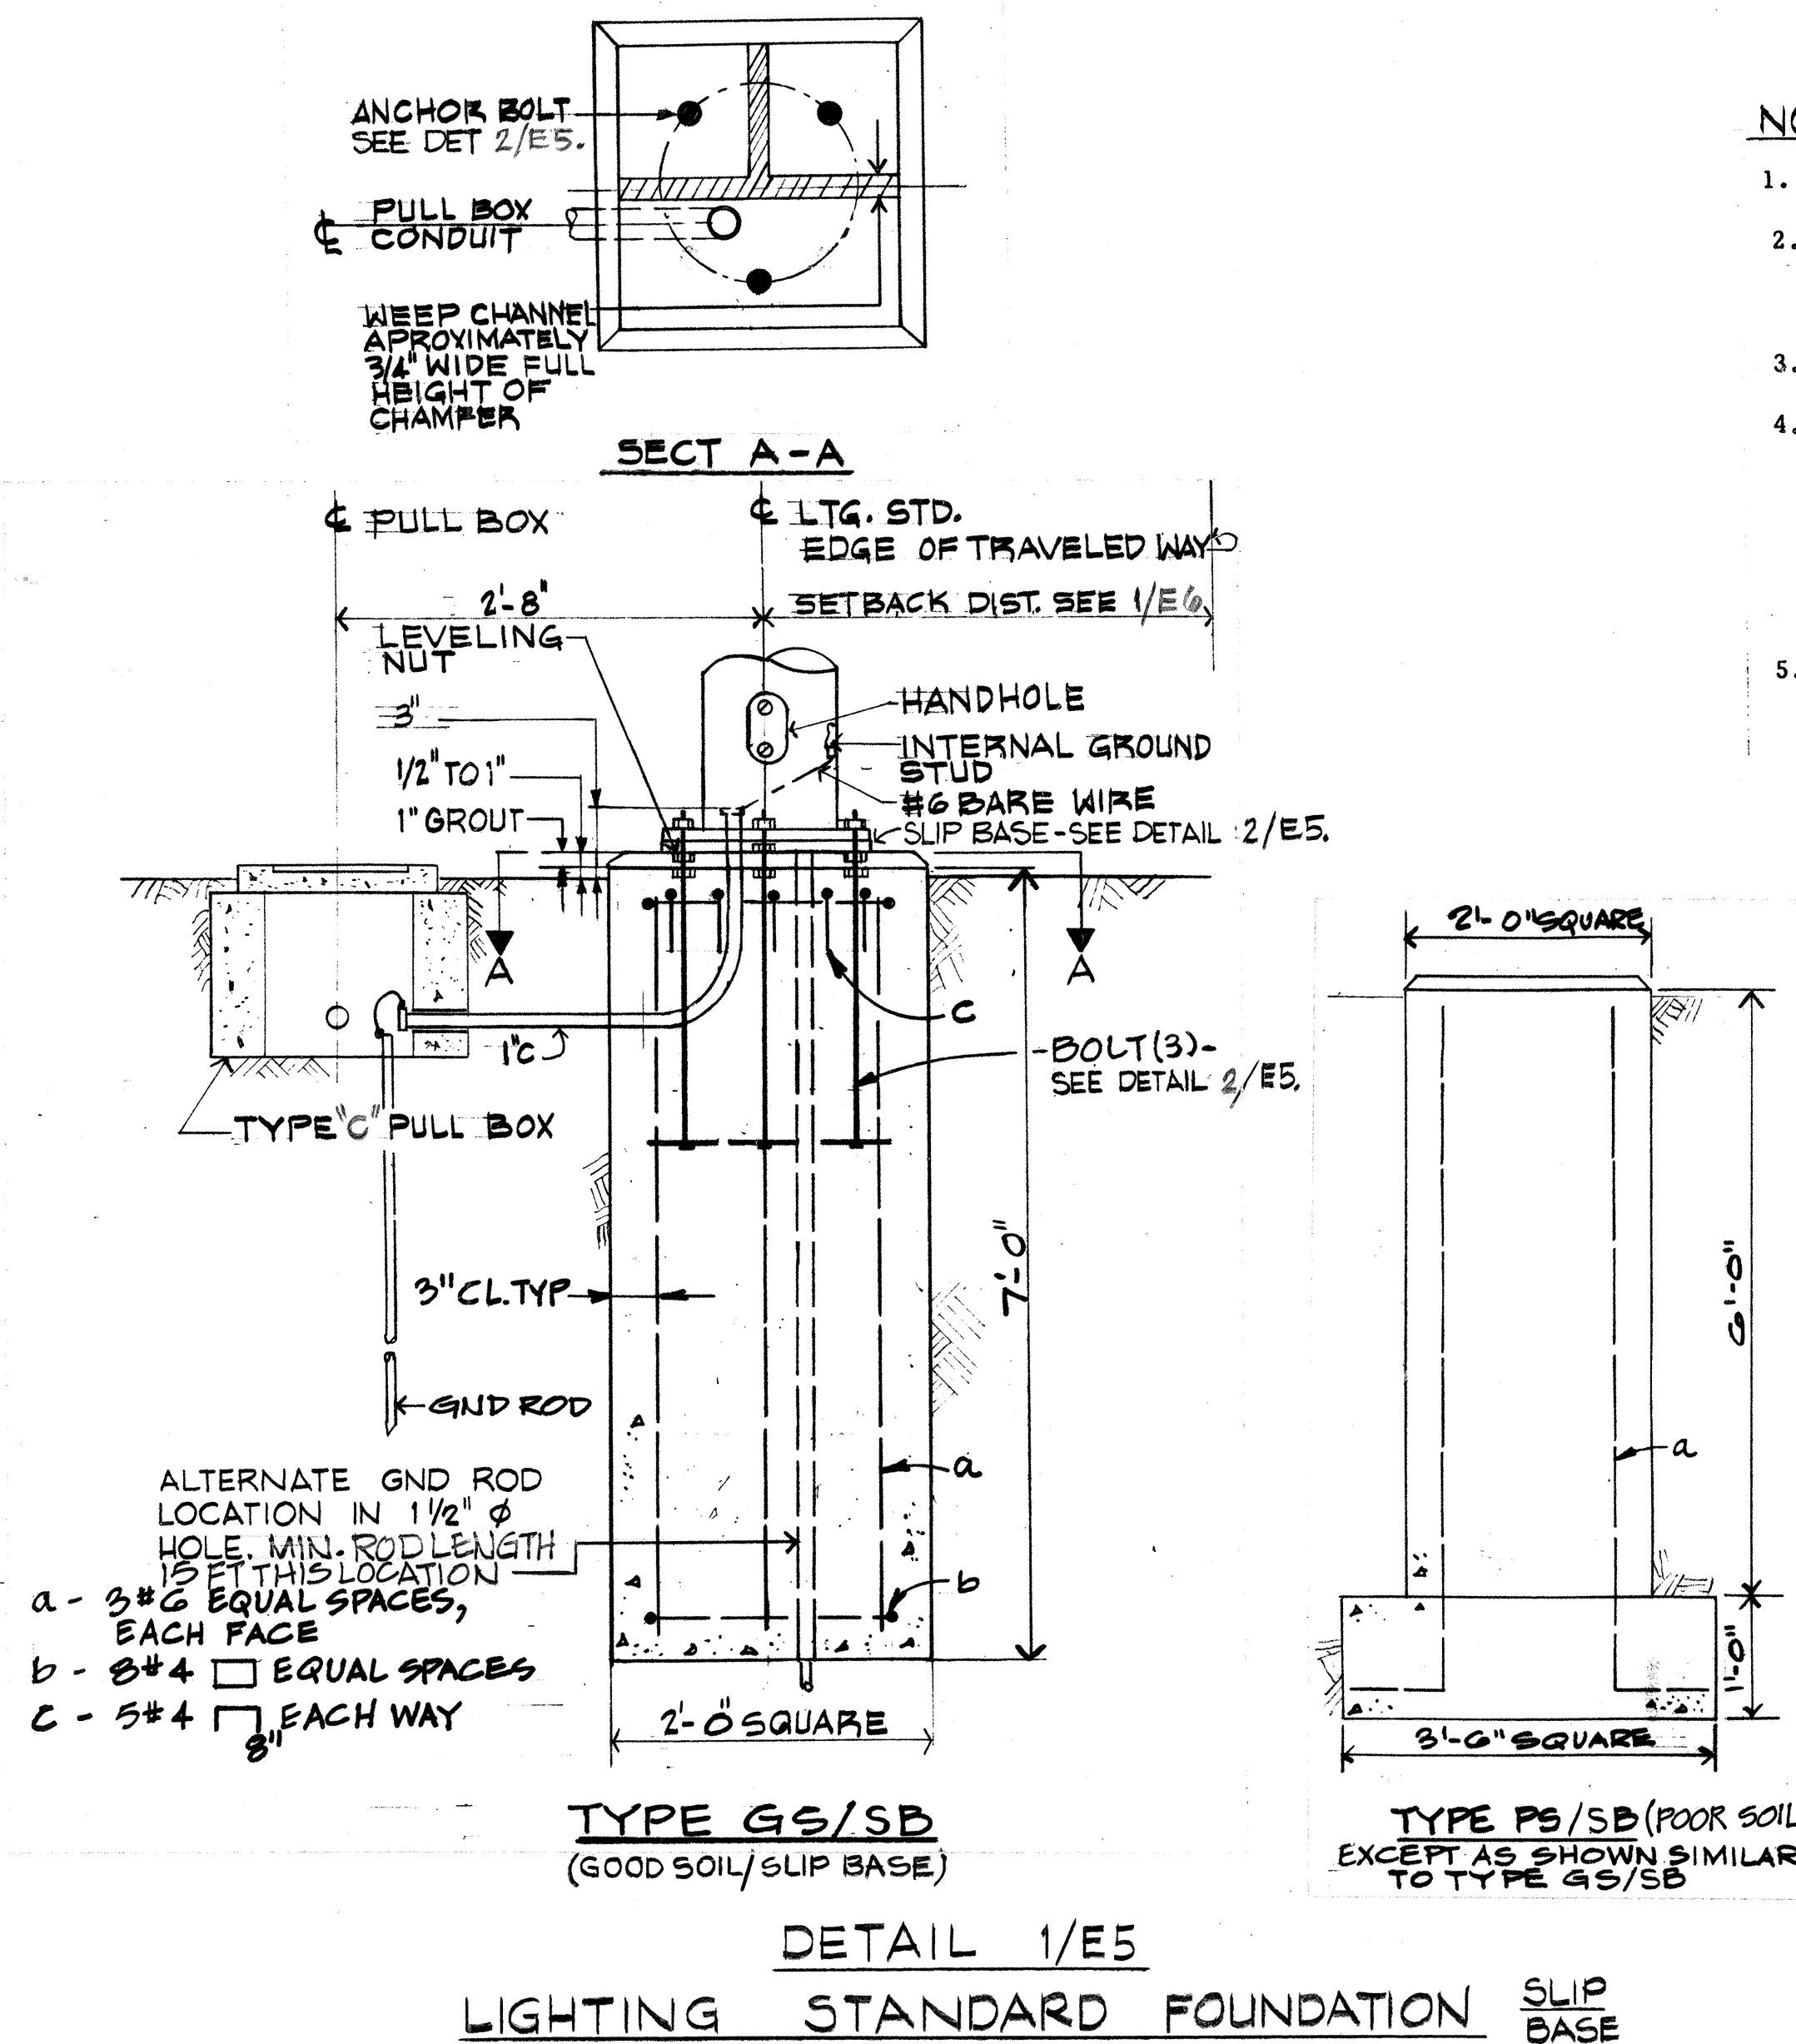

NOTES:

1. PLATES SHALL CONFORM TO A.S.T.M. A-36, EXCEPT AS NOTED.
2. CAST OPTION SHALL CONFORM TO A.S.T.M. A-27 GRADE 70-40. ALTERNATIVE DETAILS APPROVED BY THE ENGINEER MAY BE SUBSTITUTED FOR THE ARM CONNECTIONS SHOWN.
3. TORQUE 7/8" H.S. BOLTS TO 84 FOOT-POUNDS.
4. 7/8" HIGH STRENGTH ANCHOR BARS, WRENCH TIGHTEN, TORQUE REQUIREMENT WAIVED. FABRICATORS ELECTING TO USE LARGER MINIMUM ARM DIAMETERS MUST ADJUST THE DETAILS AS REQUIRED TO PERMIT SOLID SEATING OF CAP SCREWS. IN LIEU OF THE TORQUE REQUIREMENTS FOR H.S. BOLTS, CAP SCREWS SHALL BE TIGHTENED BY THE TURN-OF-NUT METHOD 1/6 TURN FROM SNUG TIGHT CONDITION. NO WASHER WILL BE REQUIRED.
5. H.S. BOLTS, FLAT WASHERS AND NUTS AND WASHERS FOR H.S. ANCHOR BARS SHALL CONFORM TO A.S.T.M. A-325.

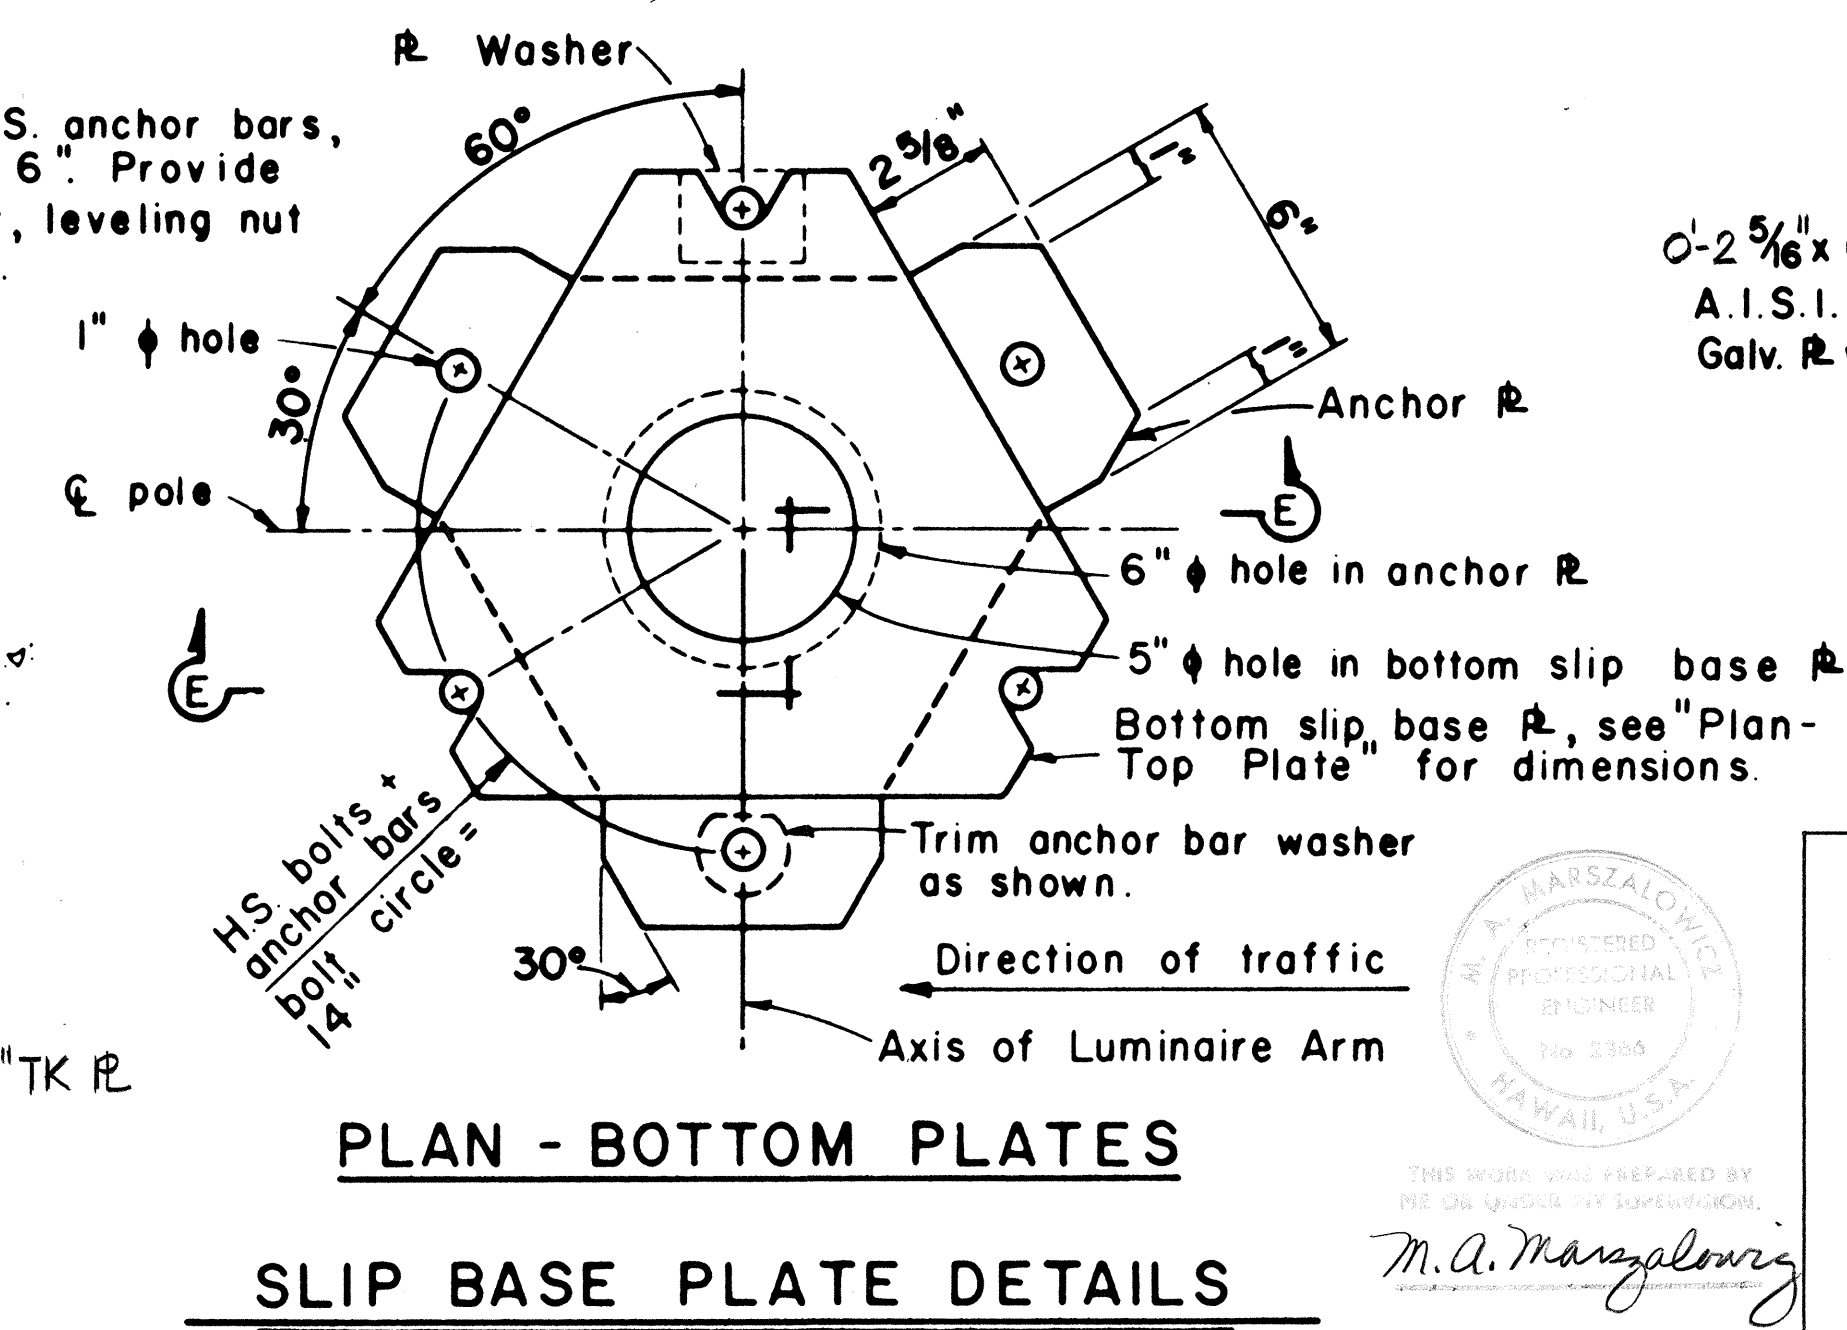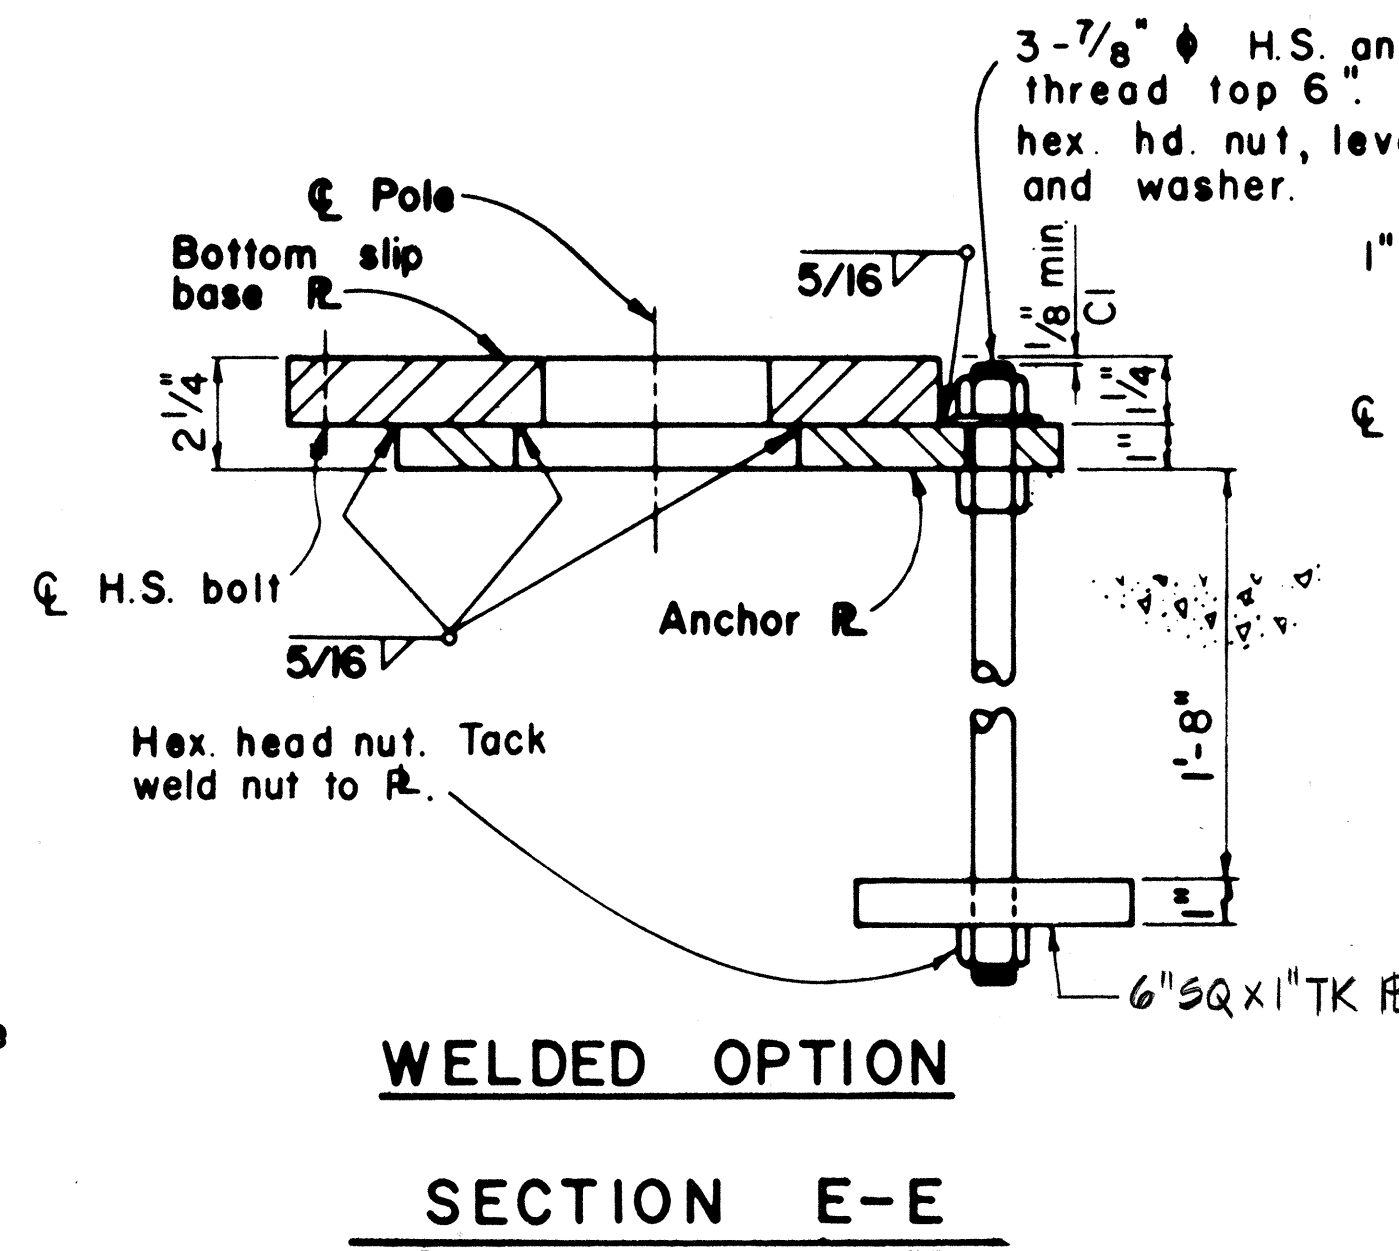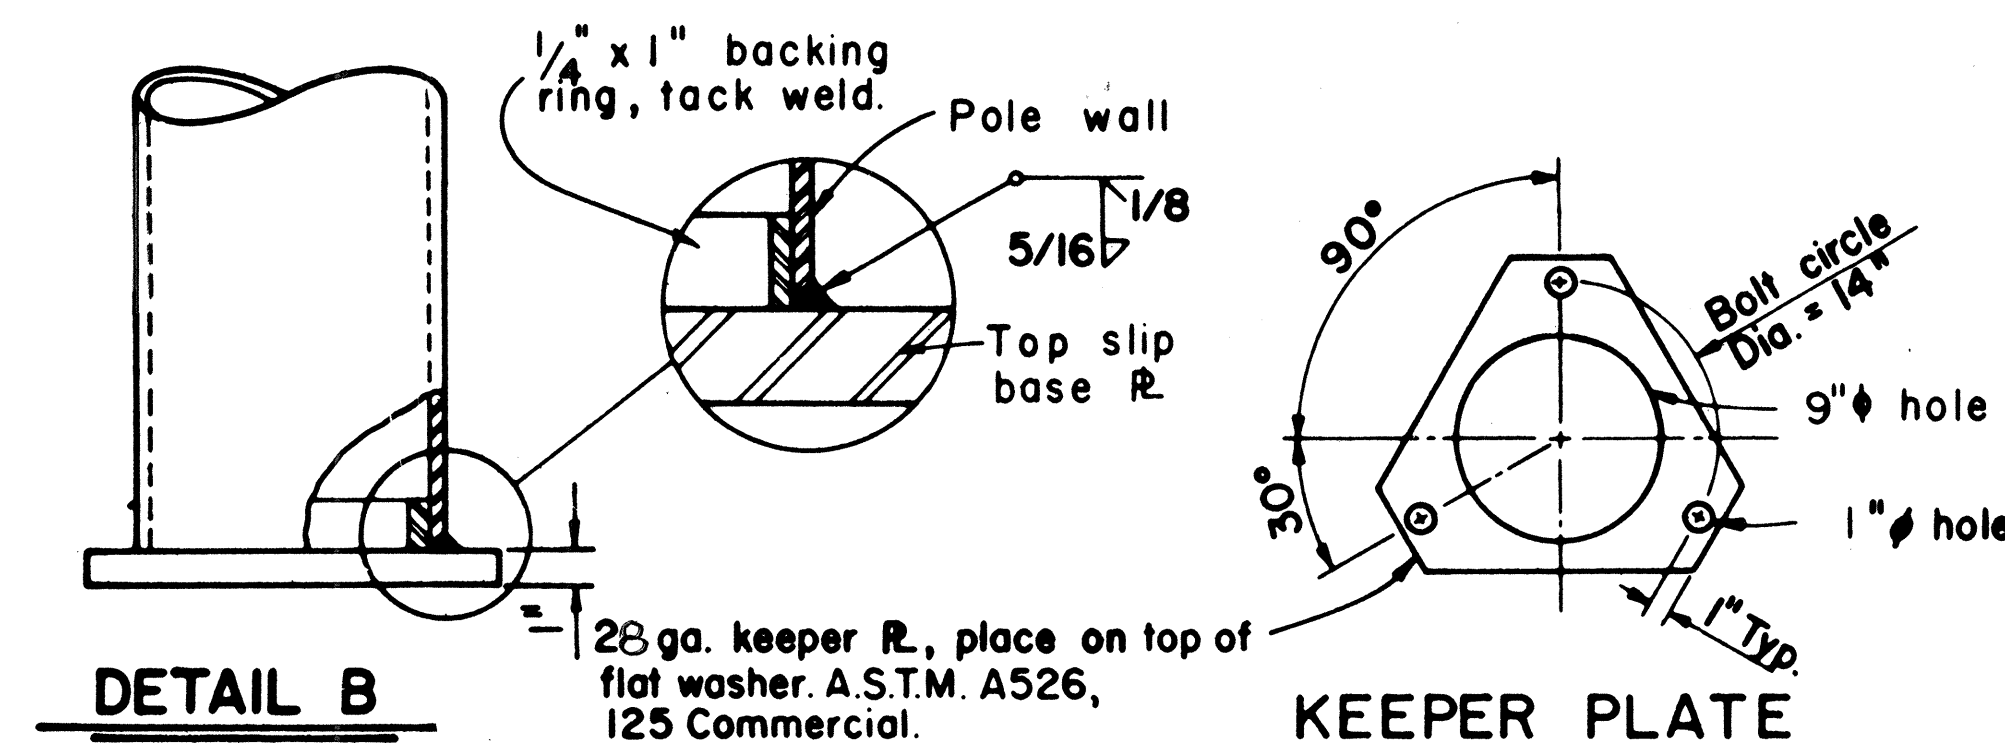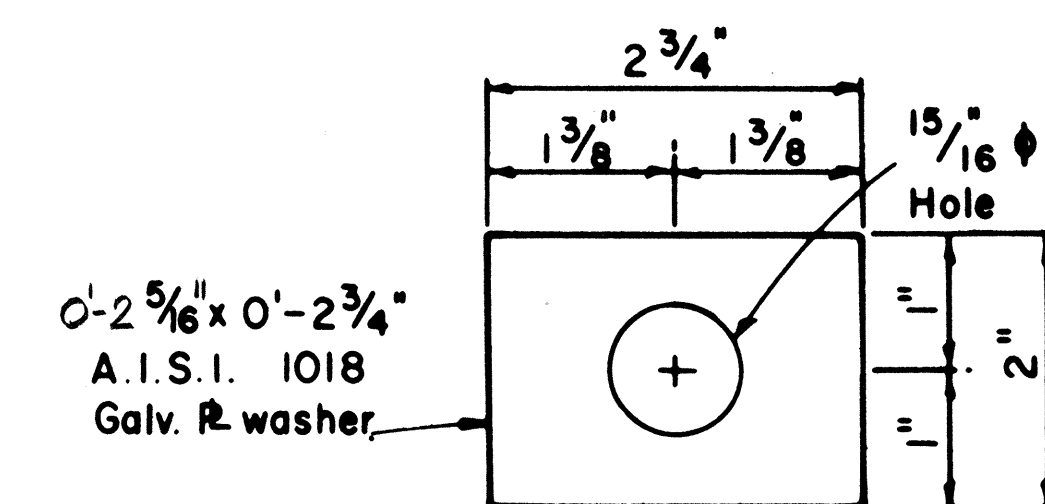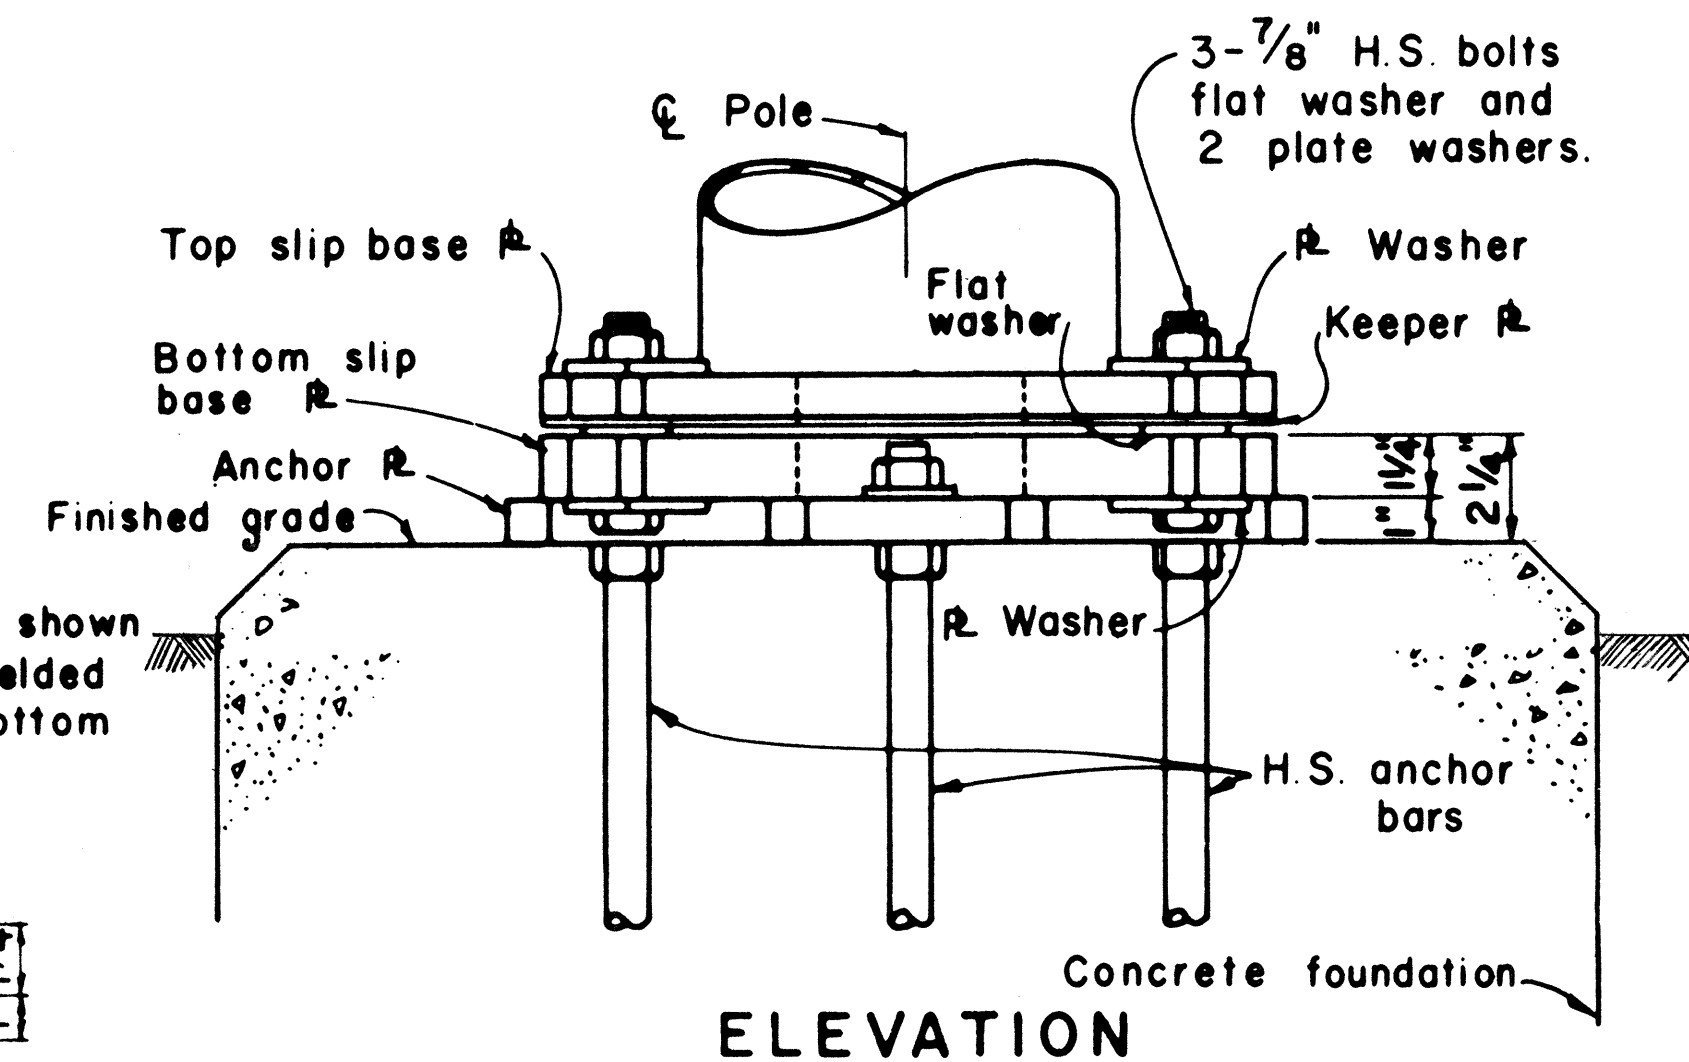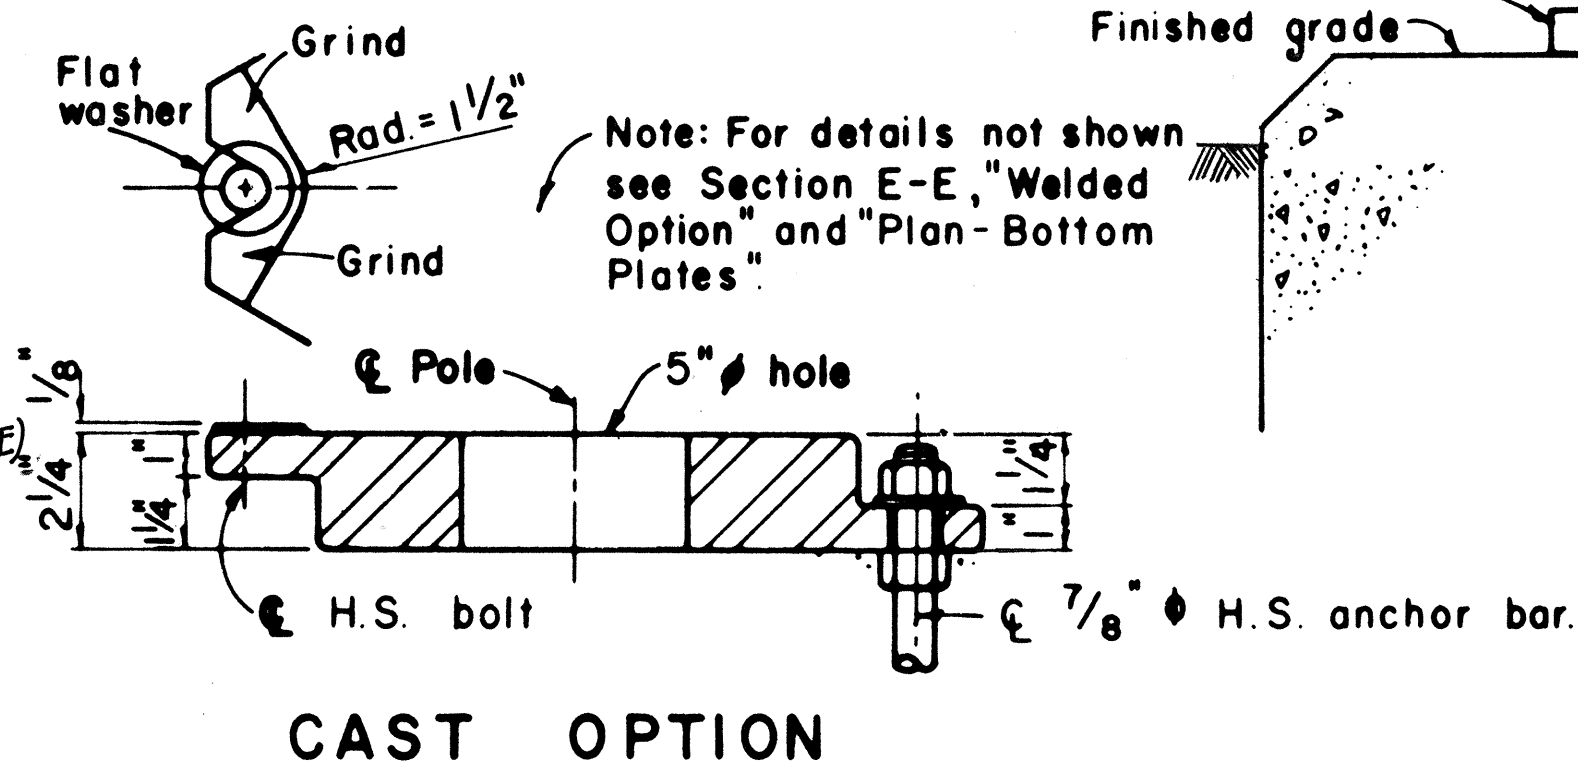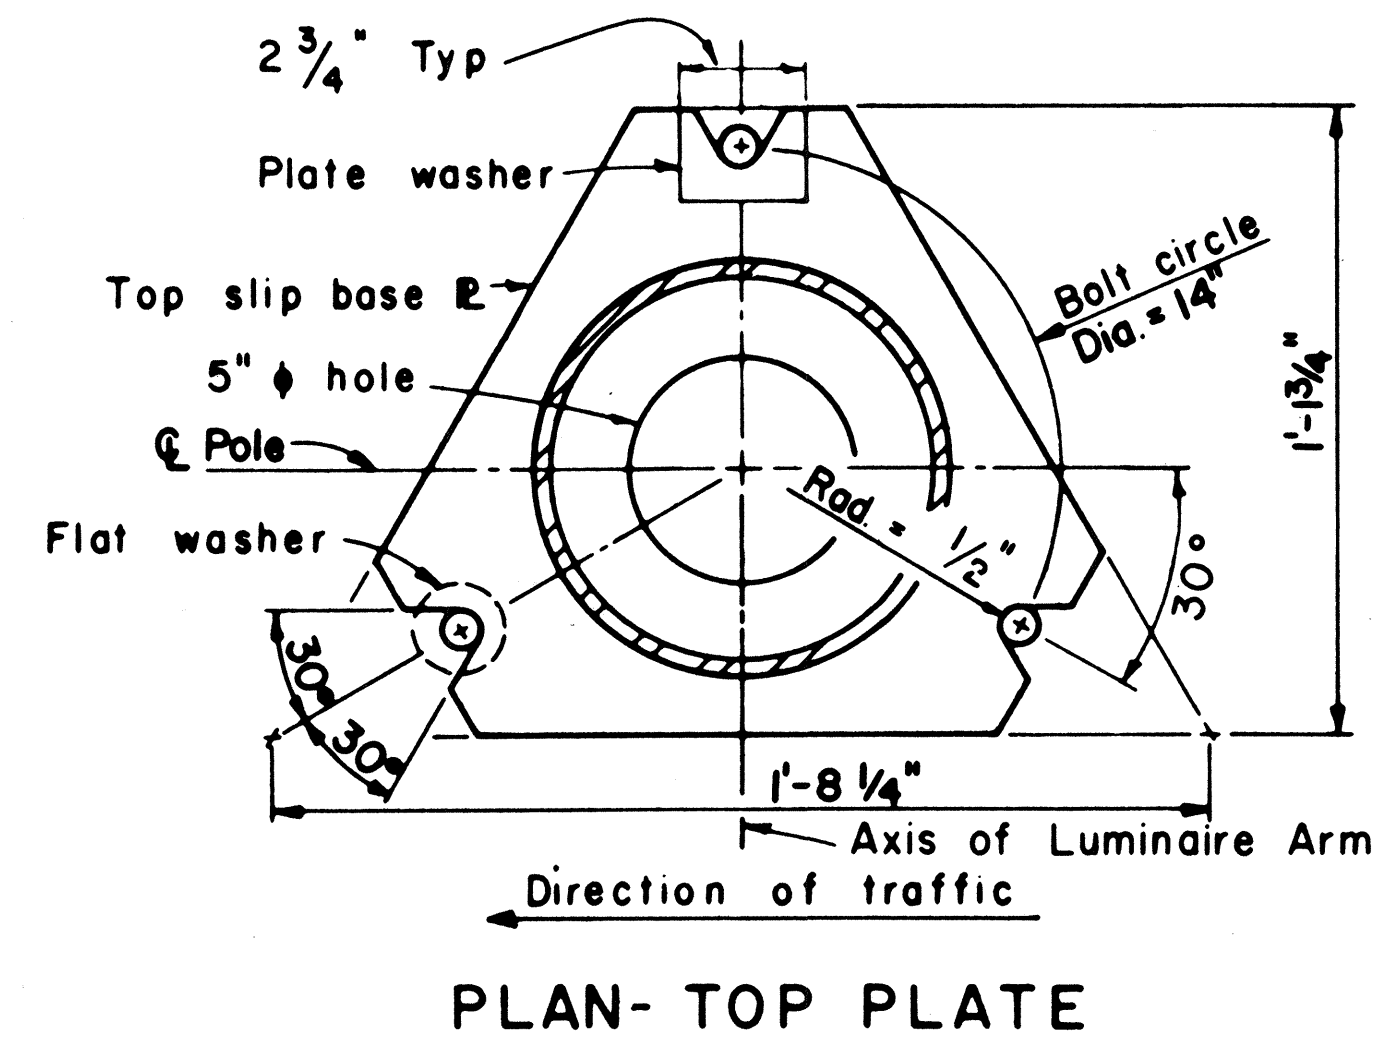


DETAIL 2/E5 - LIGHTING STANDARD SLIP BASE DETAILS

STATE OF HAWAII
DEPARTMENT OF TRANSPORTATION
HIGHWAYS DIVISION


ELECTRICAL PLAN
DETAILS - PART II
INTERSTATE ROUTE H-1
PROJECT NO. I-HI-1 (133)-17

SCALE: AS NOTED DATE: 4/30/81
SHEET NO. 55 OF 7 SHEETS


FED. ROAD DIST. NO.	STATE	FED. AID PROJ. NO.	FISCAL YEAR	SHEET NO.	TOTAL SHEETS
HAWAII	HAW.	I-HI-1(133):17	1981	57	159

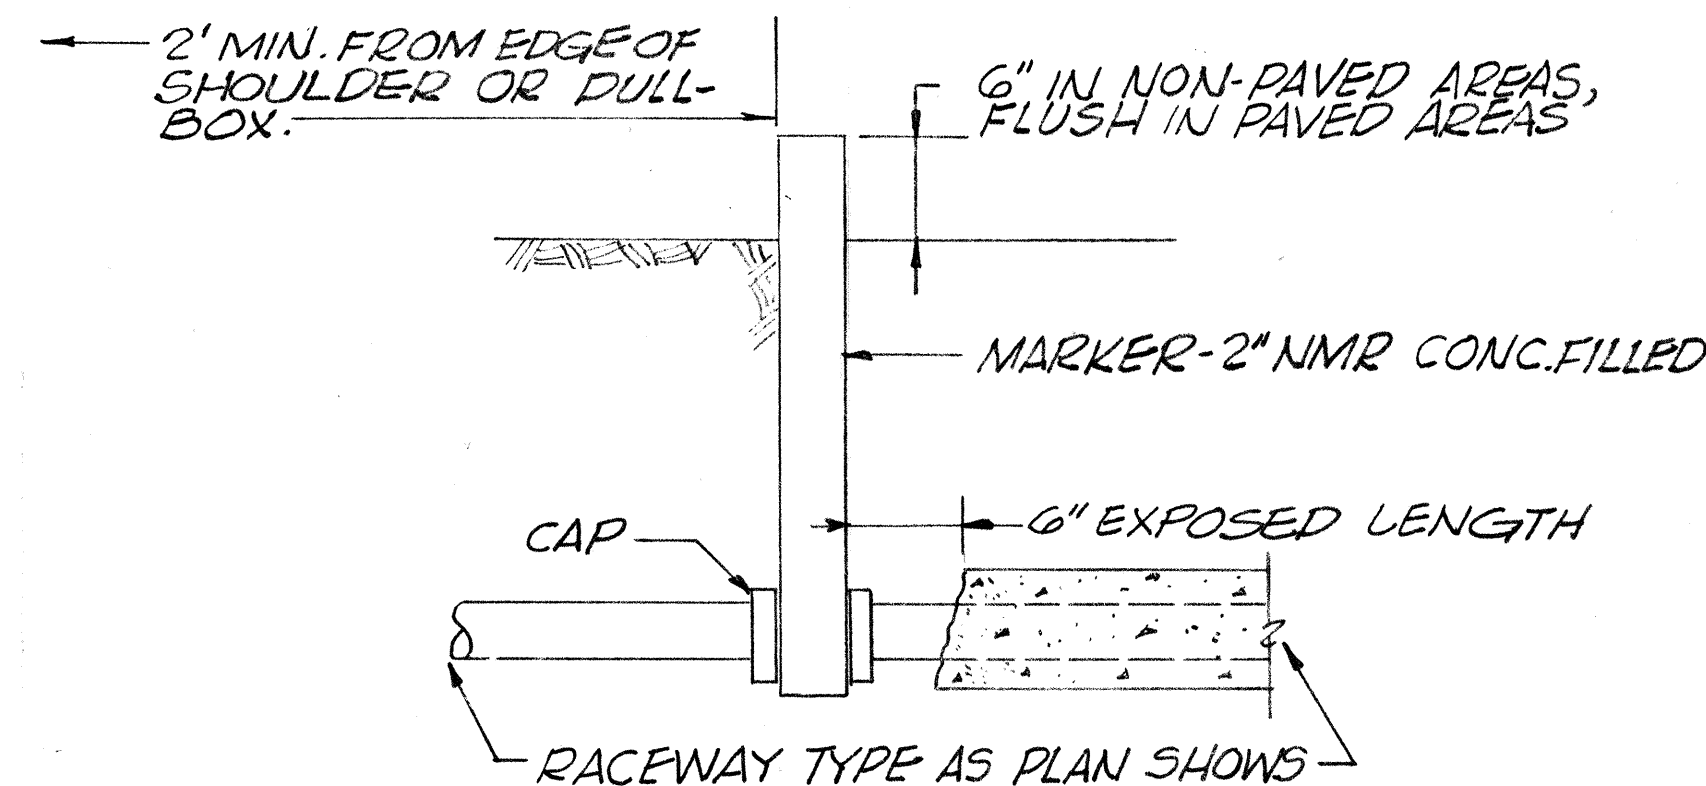


DETAIL 3/E7
CAP & MARK RACEWAY

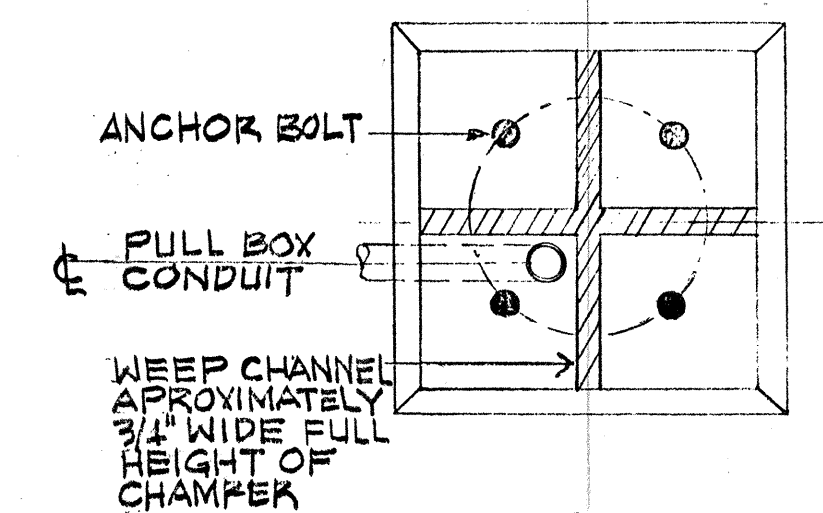


SECTION A-A
FOUNDATION PLAN

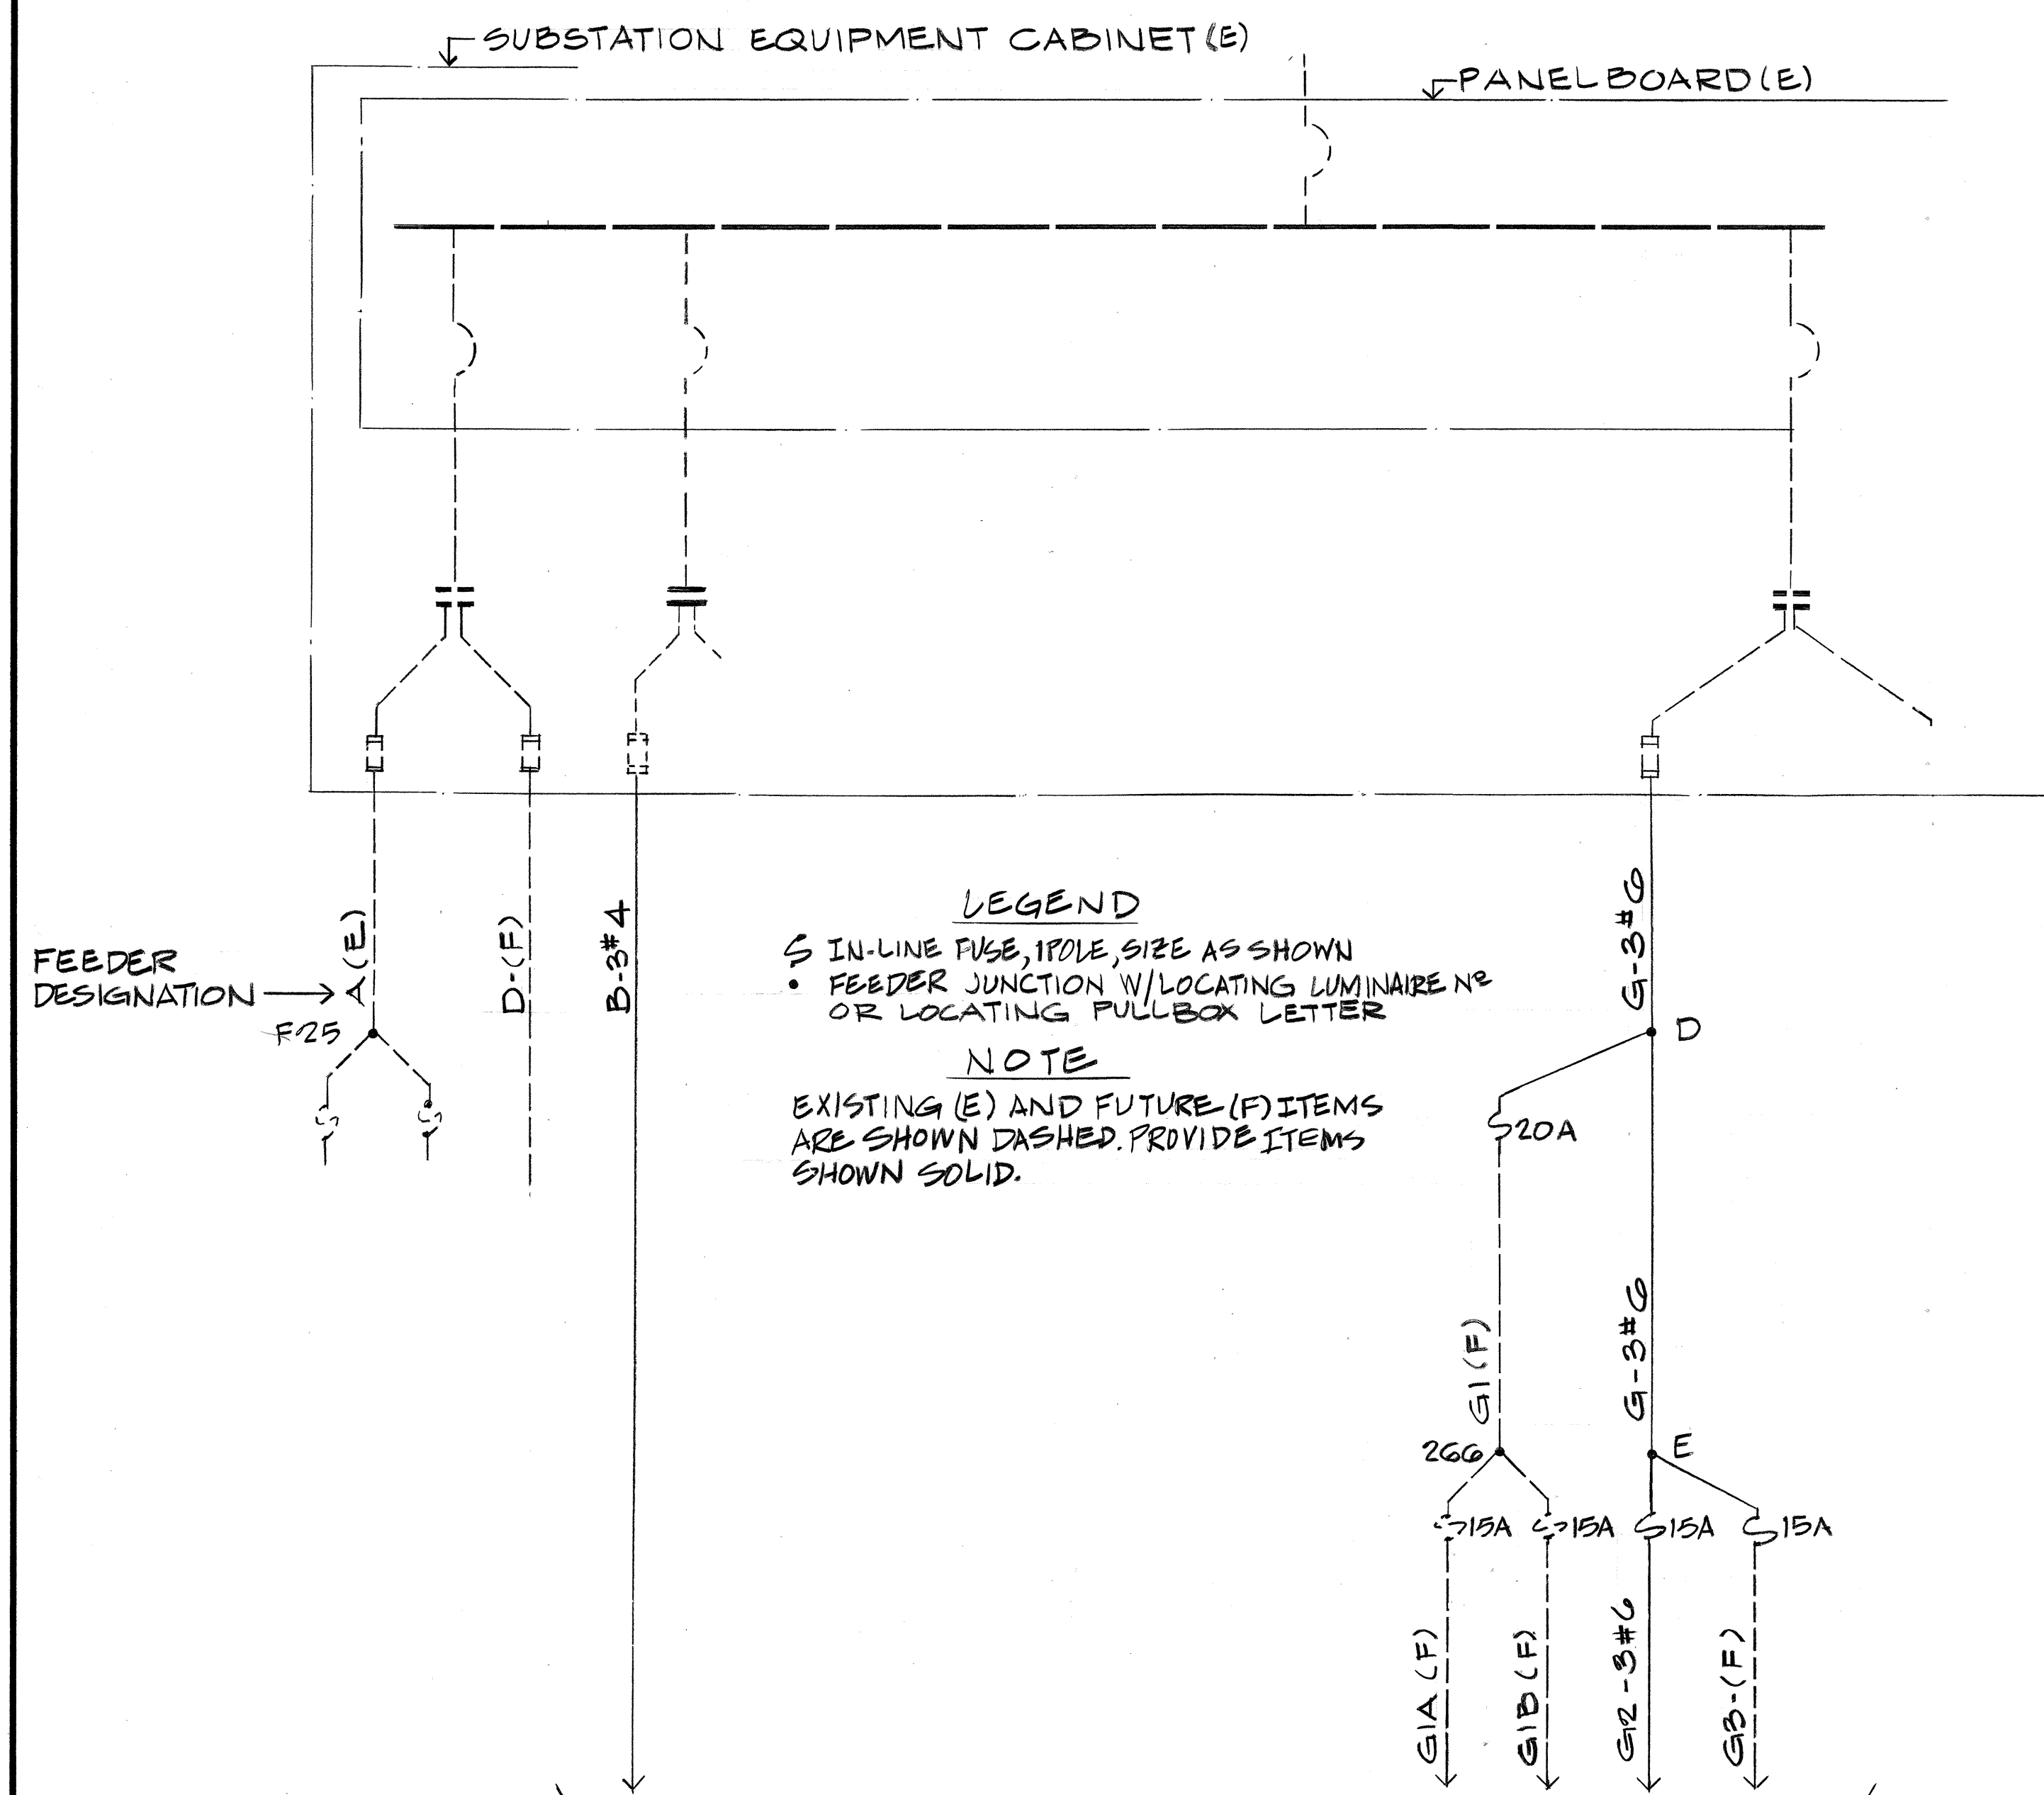


DETAIL 1/E7
HIGHWAY LIGHTING
ONE LINE DIAGRAM

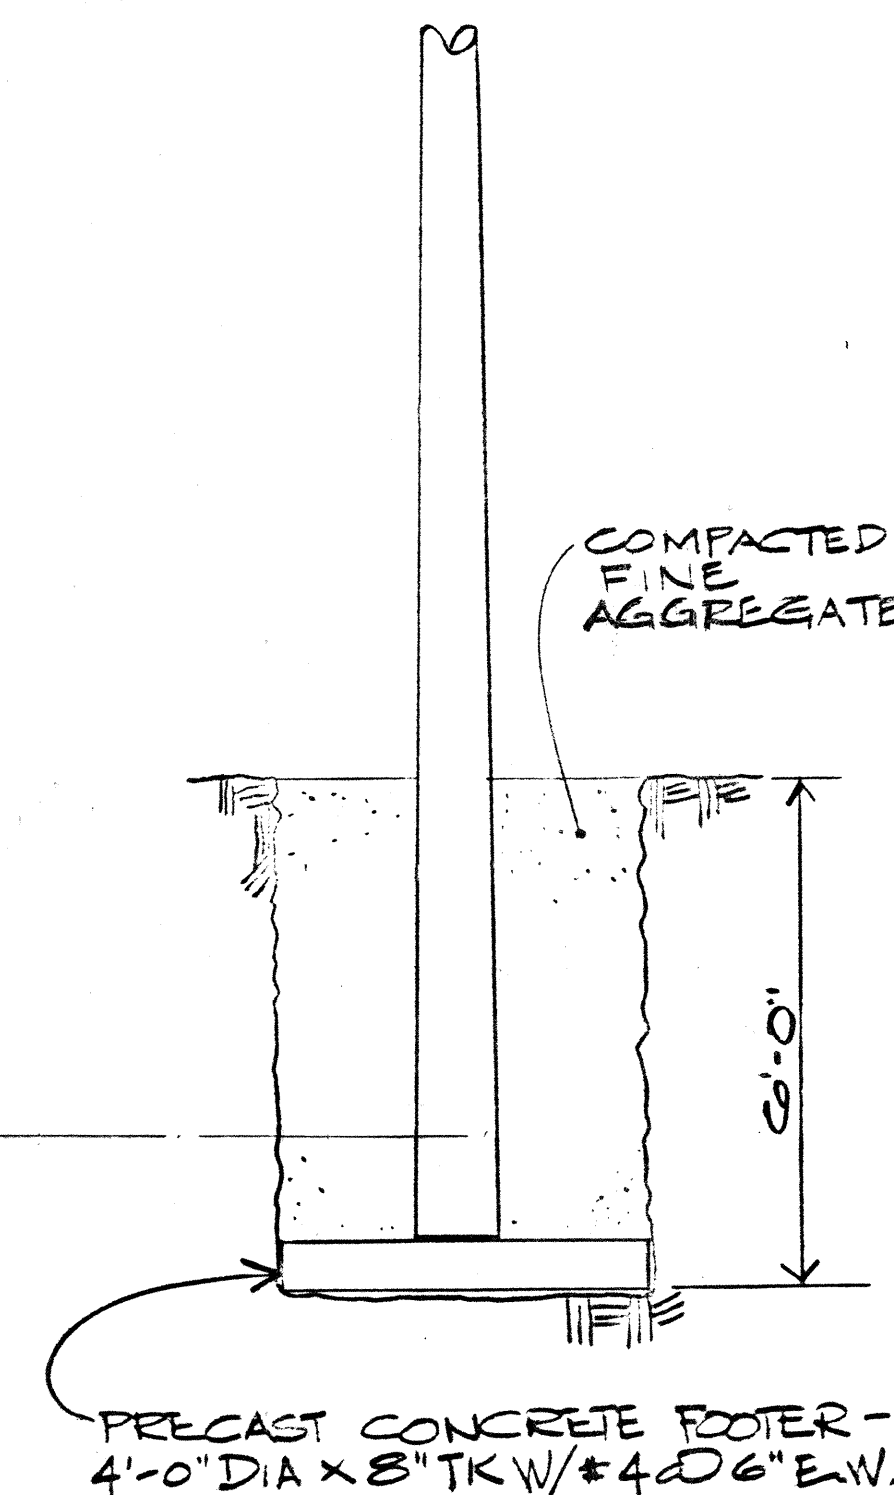

DETAIL 4/E7
WOOD LG. STD. INSTALLATION

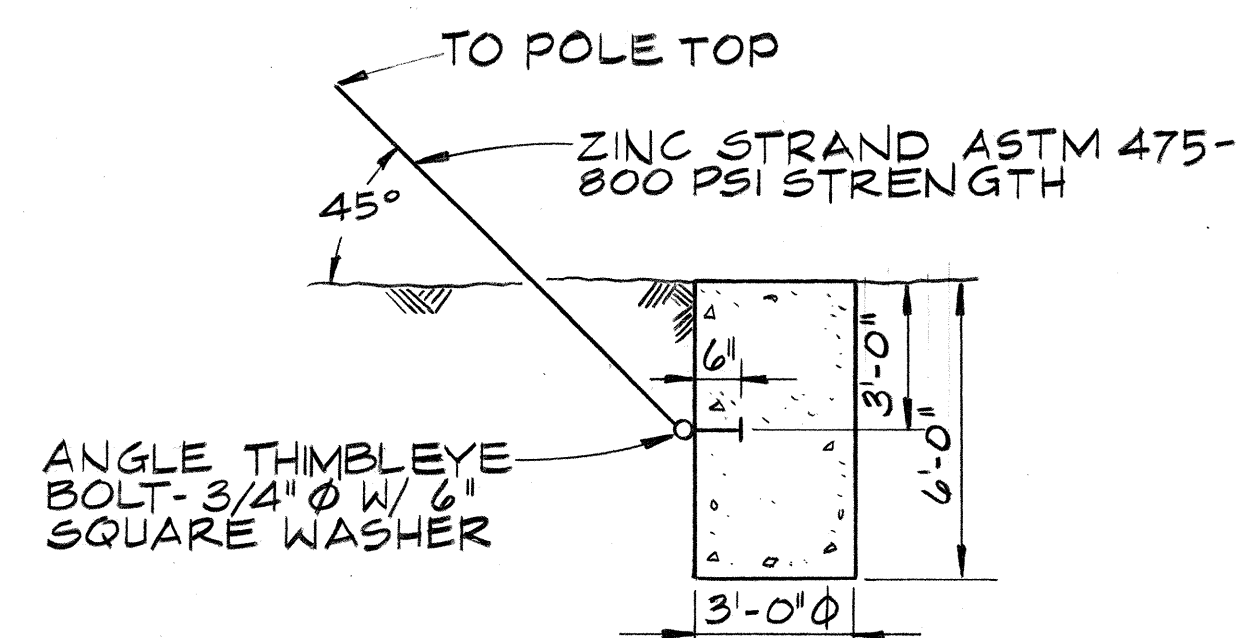

DETAIL 5/E7
WOOD POLE DOWN GUY

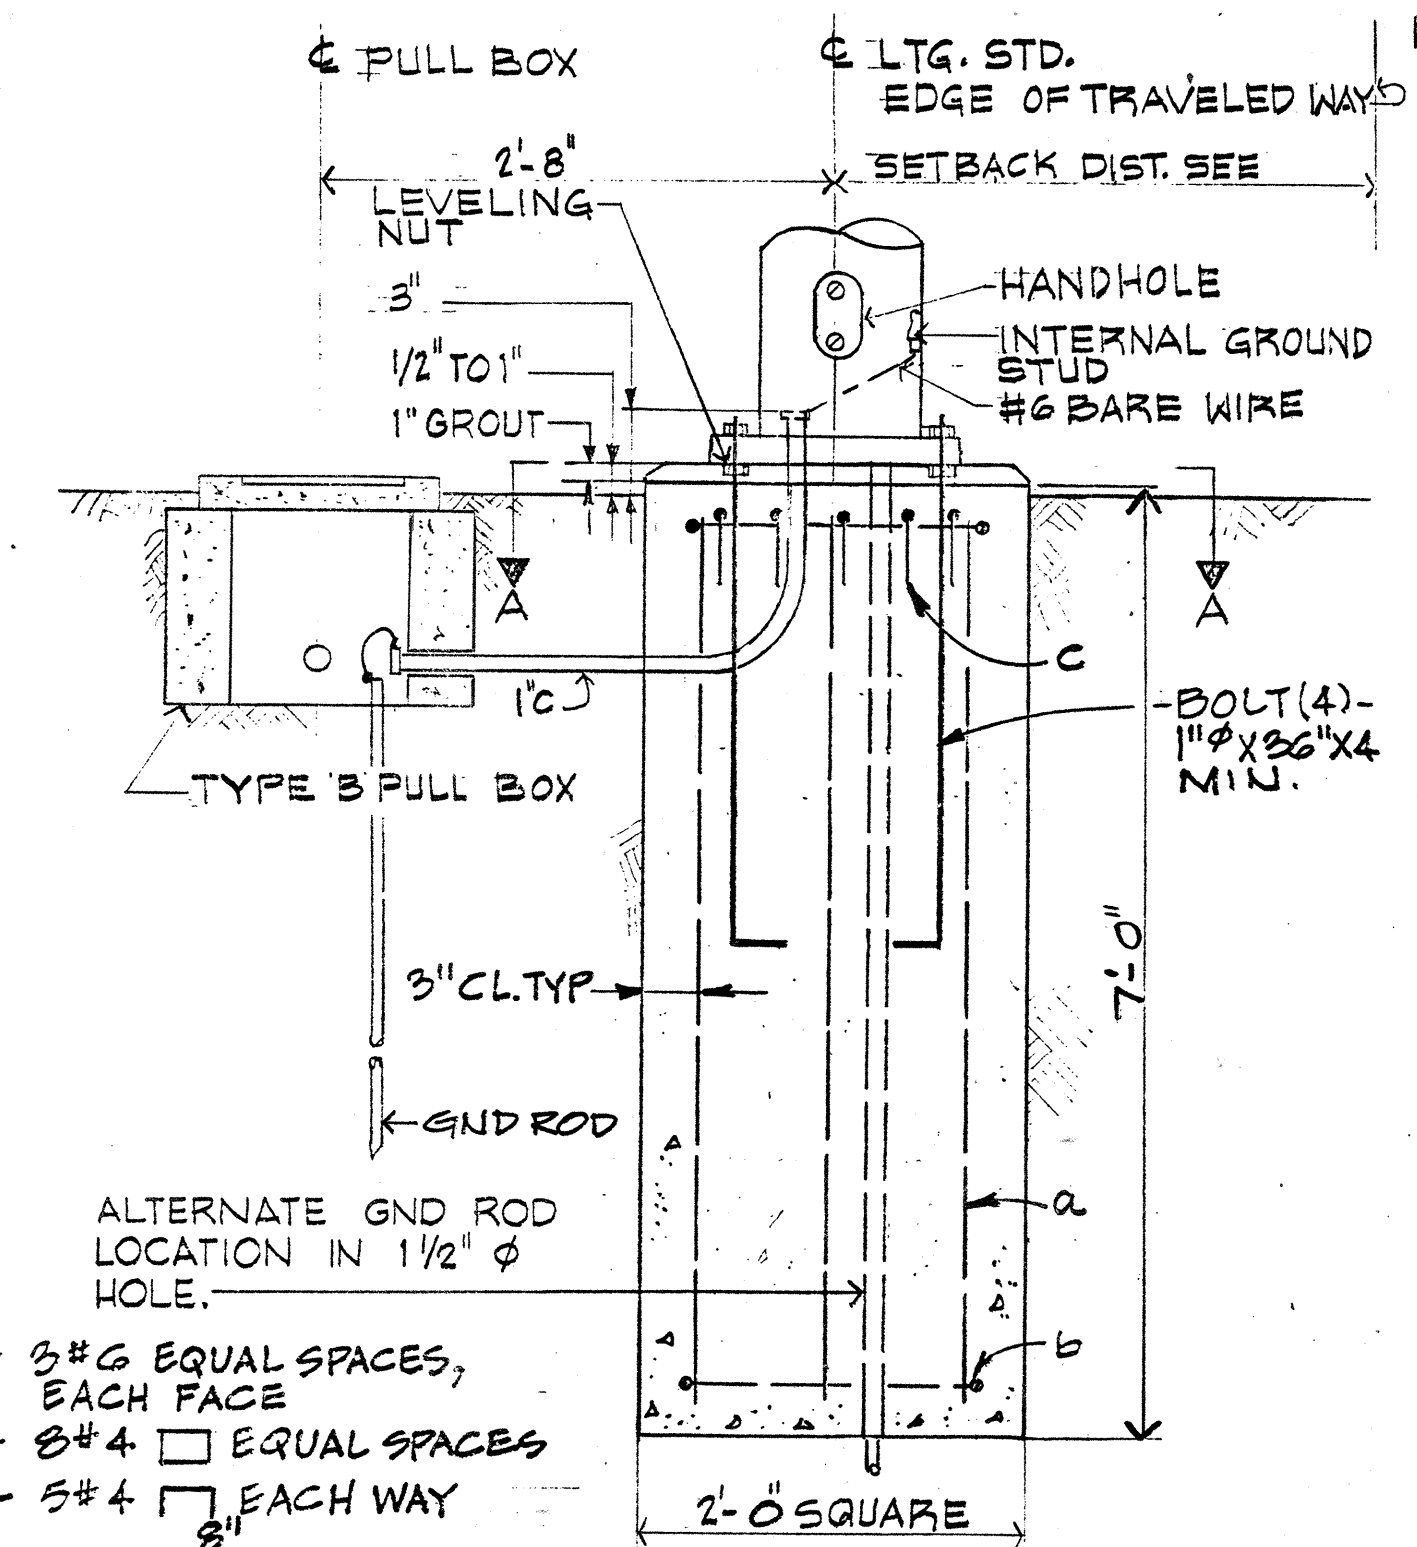

DETAIL 2/E7
LIGHTING STANDARD FOUNDATION
PLAIN BASE

STATE OF HAWAII DEPARTMENT OF TRANSPORTATION HIGHWAYS DIVISION
ELECTRICAL PLAN
FEEDER DIAGRAM
INTERSTATE ROUTE H-1 PROJECT NO. I-HI-1 (133):17
SCALE: NONE DATE: 4/30/81
SHEET No. E7 OF E7 SHEETS