


FED. ROAD DIST. NO.	STATE	FED. AID PROJ. NO.	FISCAL YEAR	SHEET NO.	TOTAL SHEETS
HAWAII	HAW.	IR-HI-1(160)	1983	003951	30

LEGEND

- Sprinkler system at relocated position
- Existing sprinkler system to be relocated or abandoned
- — — Existing sprinkler system to remain
 - Lawn pop-up sprinkler, new or relocated, 3-3.4 gpm, R=12', 20-25 psi, 1/2" ips, 2" or 3" pop-up, plastic or brass constructed.
 - Existing Rotary Pop-up Sprinkler, Thompson #187
 - Lawn Pop-up Sprinkler, new, 1 gpm, 4'x30', 15 psi, 1/2" ips, 2" or 3" pop-up, plastic or brass constructed.
 - ⊗ Existing Remote Control Valve

GENERAL NOTES:

1. Minimum cover for pipes shall be 12 inches.
2. Pipe shall be Class 200 PVC unless otherwise noted.
3. The contractor shall verify in the field the locations of existing sprinkler system, utilities and structures.
4. The contractor shall be responsible and shall pay for all damages to existing structures and utilities affected by this work.

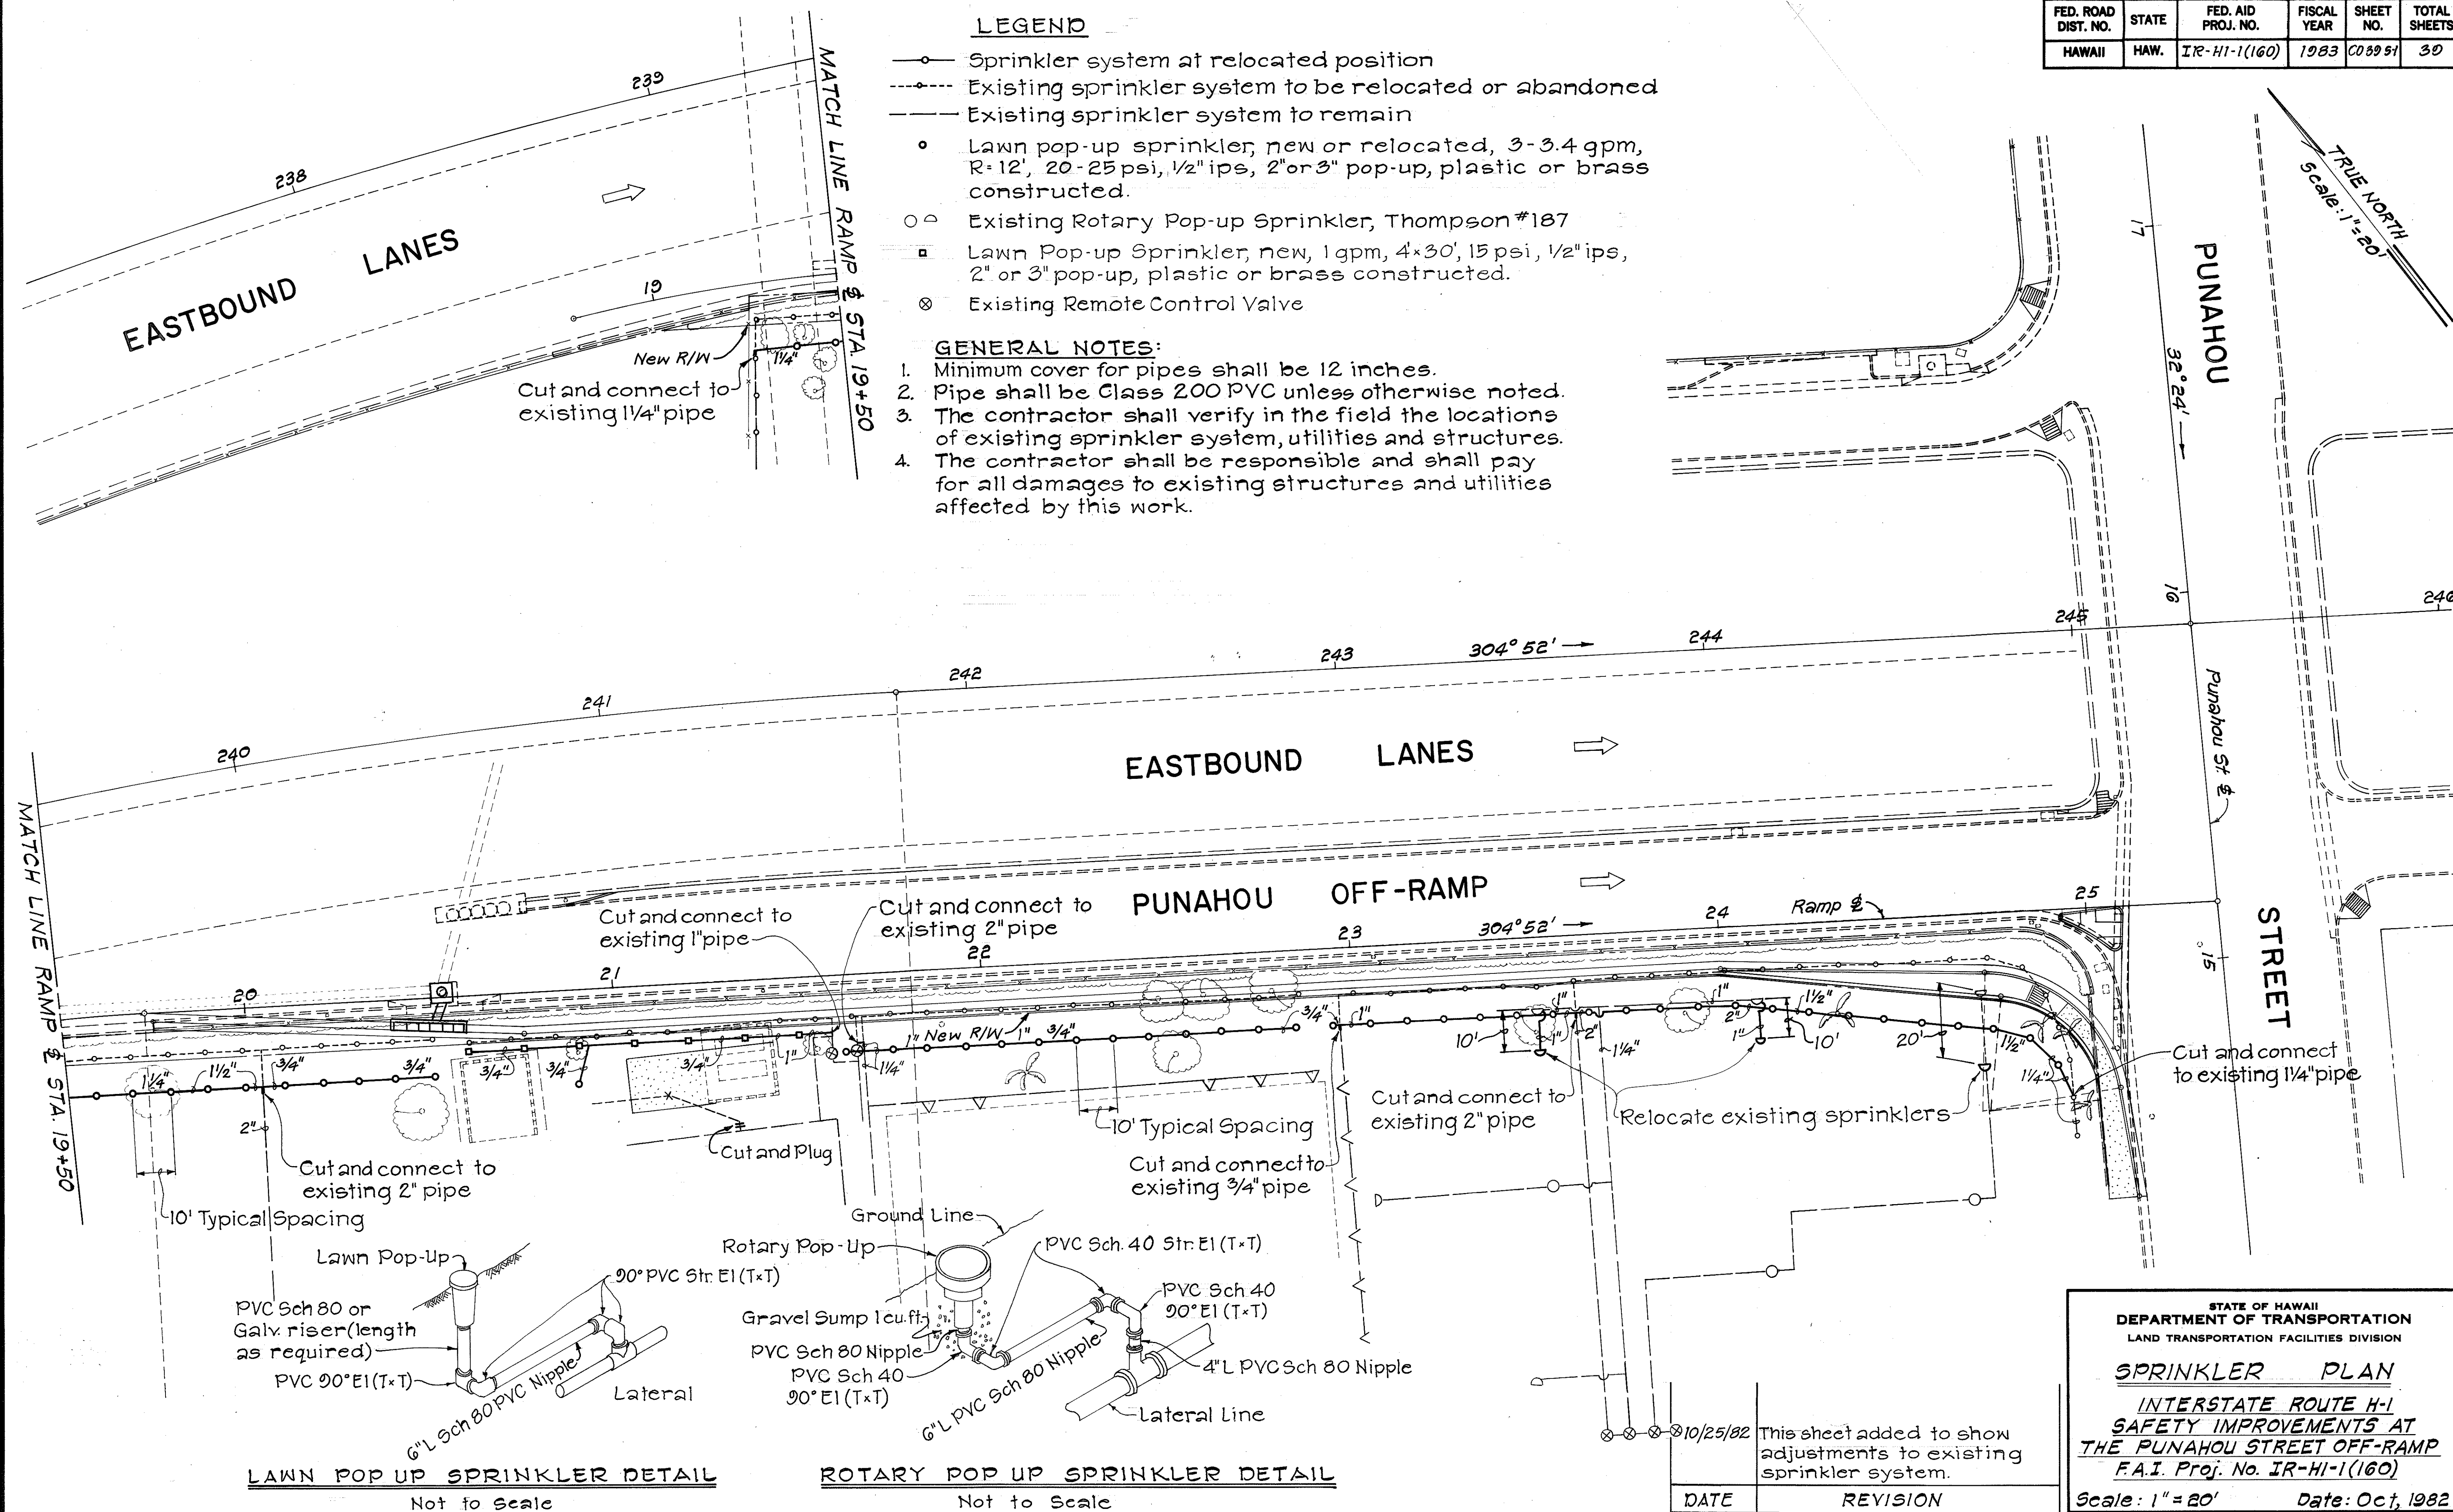

ORIGINAL PLAN	SURVEY PLOTTED BY _____	DATE _____
	DRAWN BY _____	" _____
	TRACED BY _____	" _____
NOTE BOOK	DESIGNED BY _____	" _____
	QUANTITIES BY _____	" _____
No. _____	CHECKED BY _____	" _____

STATE OF HAWAII
DEPARTMENT OF TRANSPORTATION
LAND TRANSPORTATION FACILITIES DIVISION

SPRINKLER PLAN

INTERSTATE ROUTE H-1
SAFETY IMPROVEMENTS AT
THE PUNAHOU STREET OFF-RAMP
F.A.I. Proj. No. IR-HI-1(160)

Scale: 1" = 20' Date: Oct, 1982

SHEET NO. 1 OF 1 SHEETS