

INDEX TO DRAWINGS	
SHEET NO.	DESCRIPTION
1	TITLE SHEET
2	CONSTRUCTION PHASING
3	ALIGNMENT PLAN
4-5	RAMP TERMINAL DETAILS
6-9	ROADWAY PROFILES & SUPERELEVATION DIAGRAMS
10-12	GRADING & STREAM WIDENING PLAN AND DETAILS
13	EROSION CONTROL NOTES & DETAILS
14-16	TRAFFIC PATTERNS B & C
17-24	OVERHEAD SIGNS E-33 & E-34
25-39	MISCELLANEOUS DETAILS
40-43	HIGHWAY LIGHTING PLANS & DETAILS
44-45	EXISTING UTILITY PLANS
46-59	BORING LOCATION PLAN AND LOGS
60-82	H-1 (EB) RAMP C AND HOV RAMP STRUCTURES
83-131	NIMITZ CONN. (EB), RAMP A & B STRUCTURES
132-142	STRUCTURAL STANDARD DETAILS
143-145	CROSS SECTIONS

STATE OF HAWAII

DEPARTMENT OF TRANSPORTATION

HIGHWAYS DIVISION

HONOLULU, HAWAII

"AS-BUILT"

PLANS FOR

CONSTRUCTION OF A PORTION OF



INTERSTATE ROUTE H-1

KEEHI INTERCHANGE

FEDERAL AID INTERSTATE PROJECT NO. I-HI-1 (168):17

DISTRICT OF HONOLULU

ISLAND OF OAHU

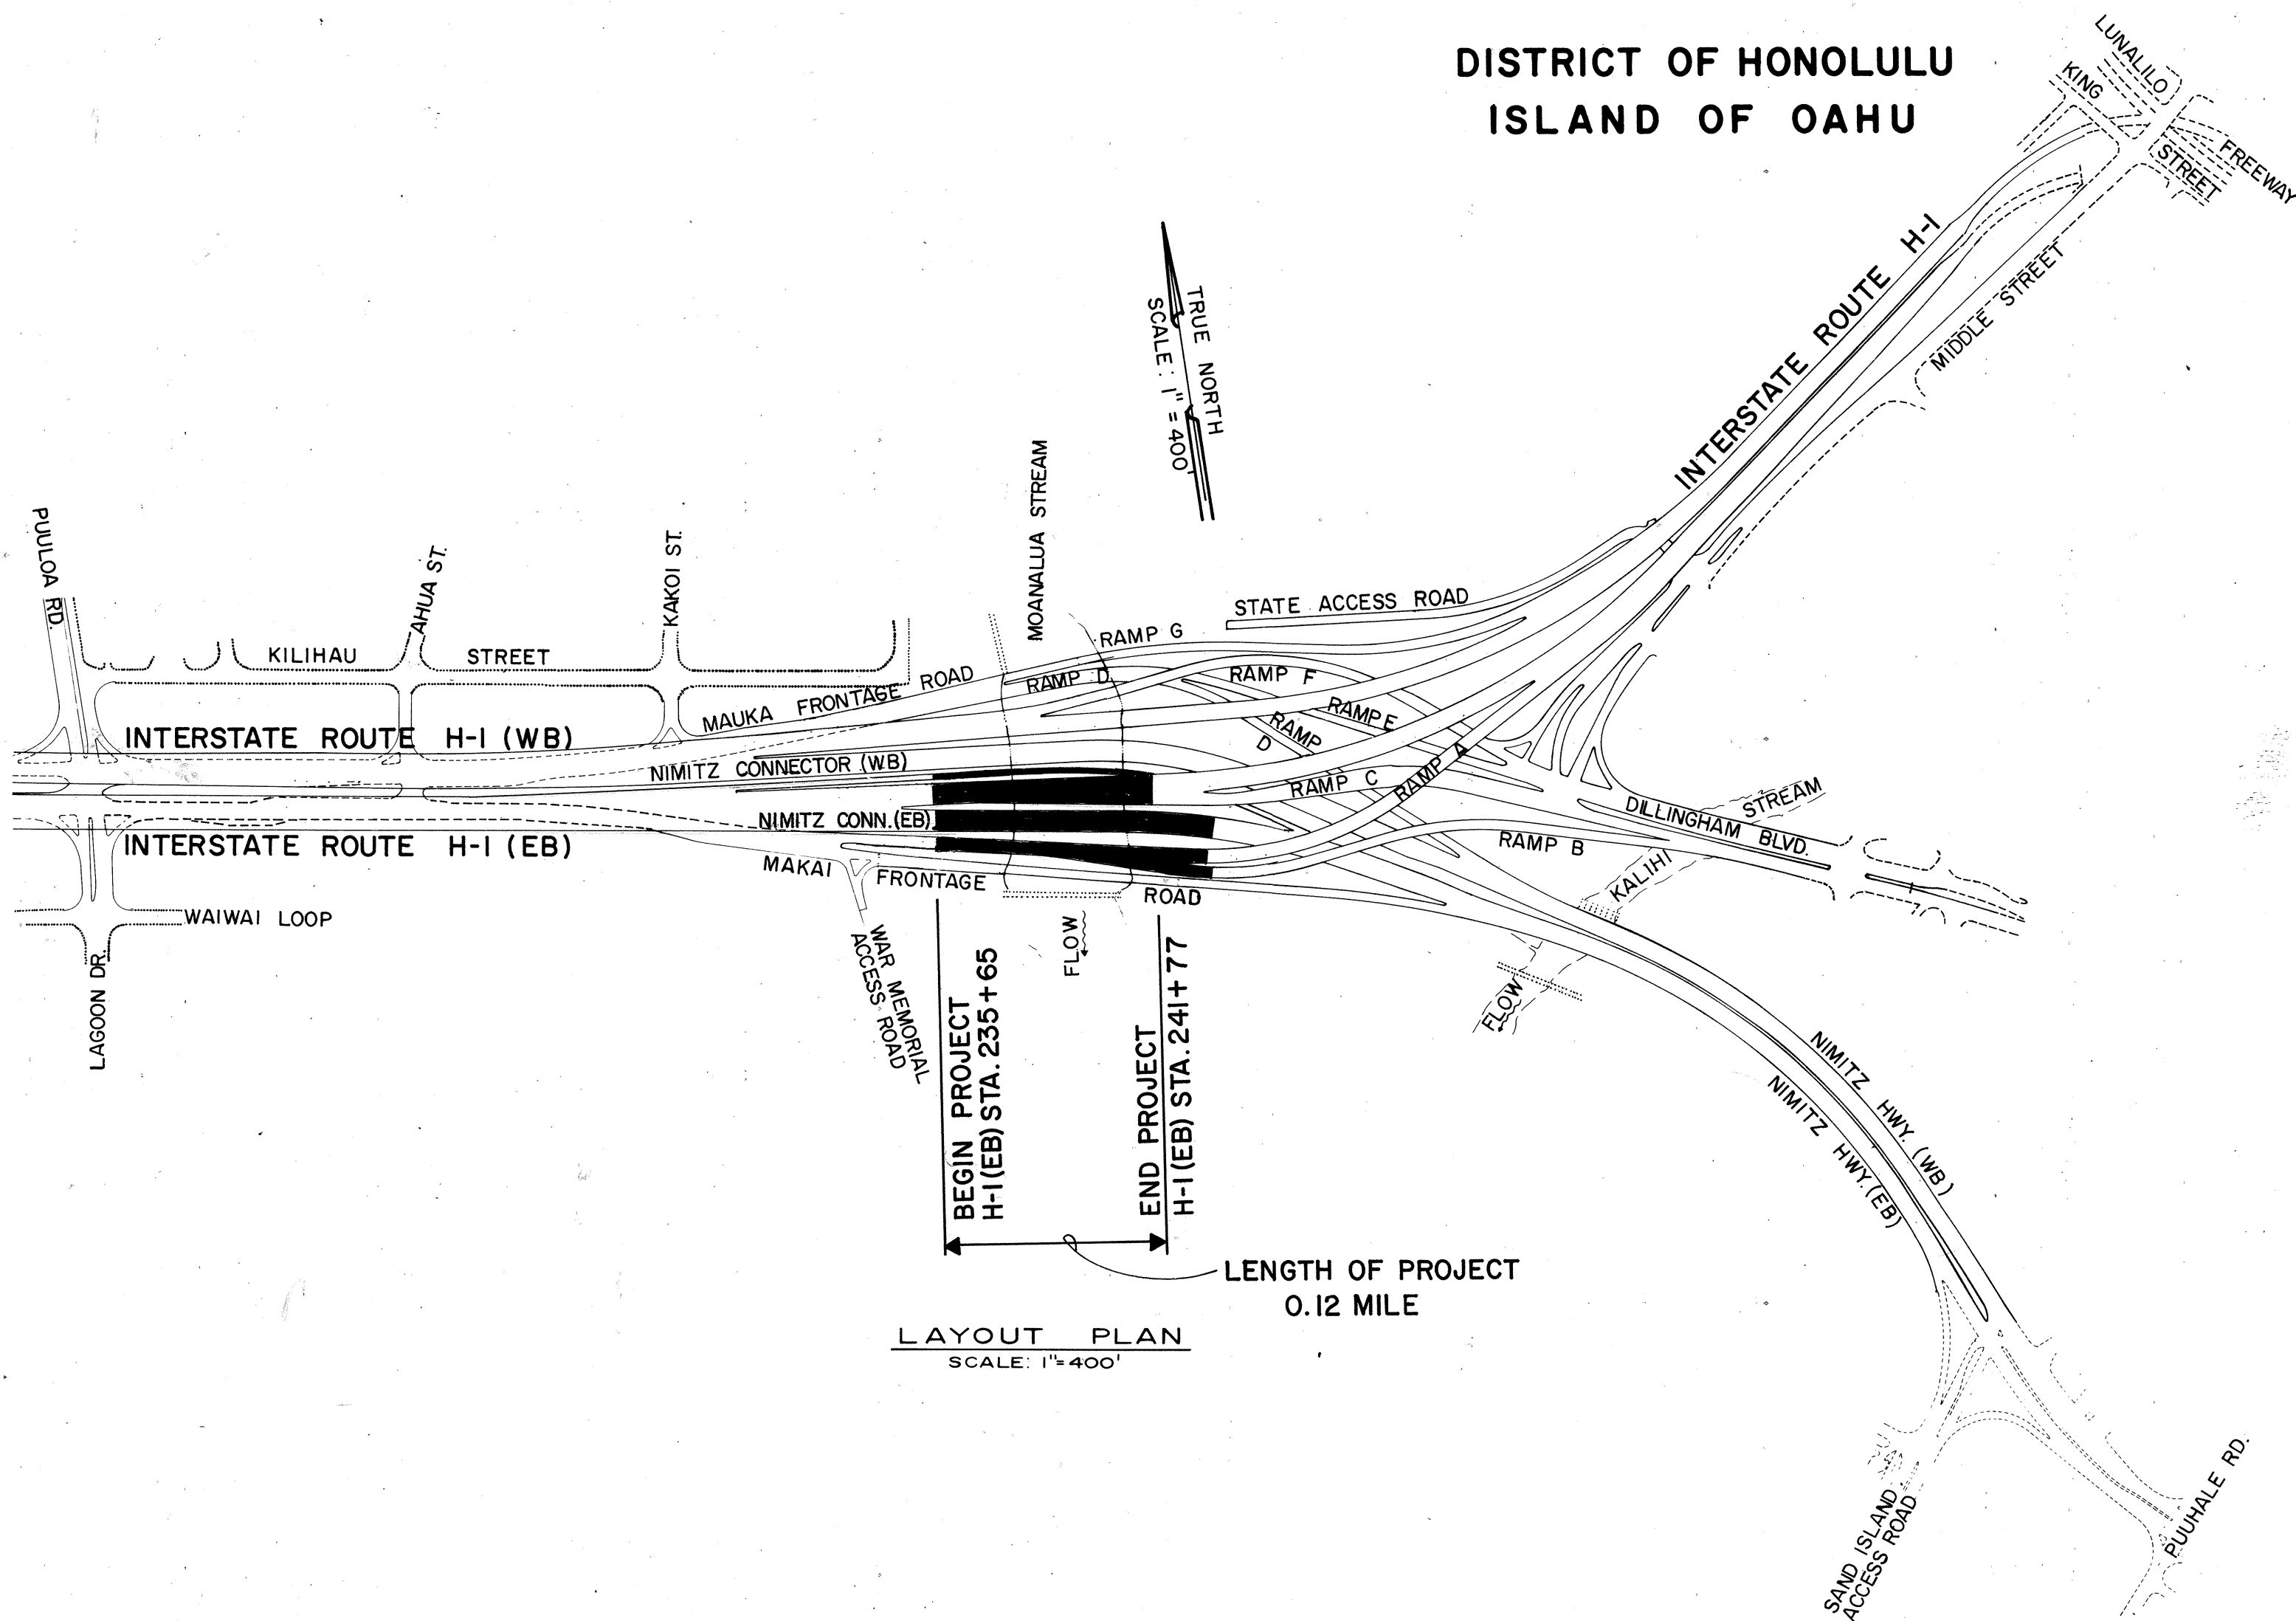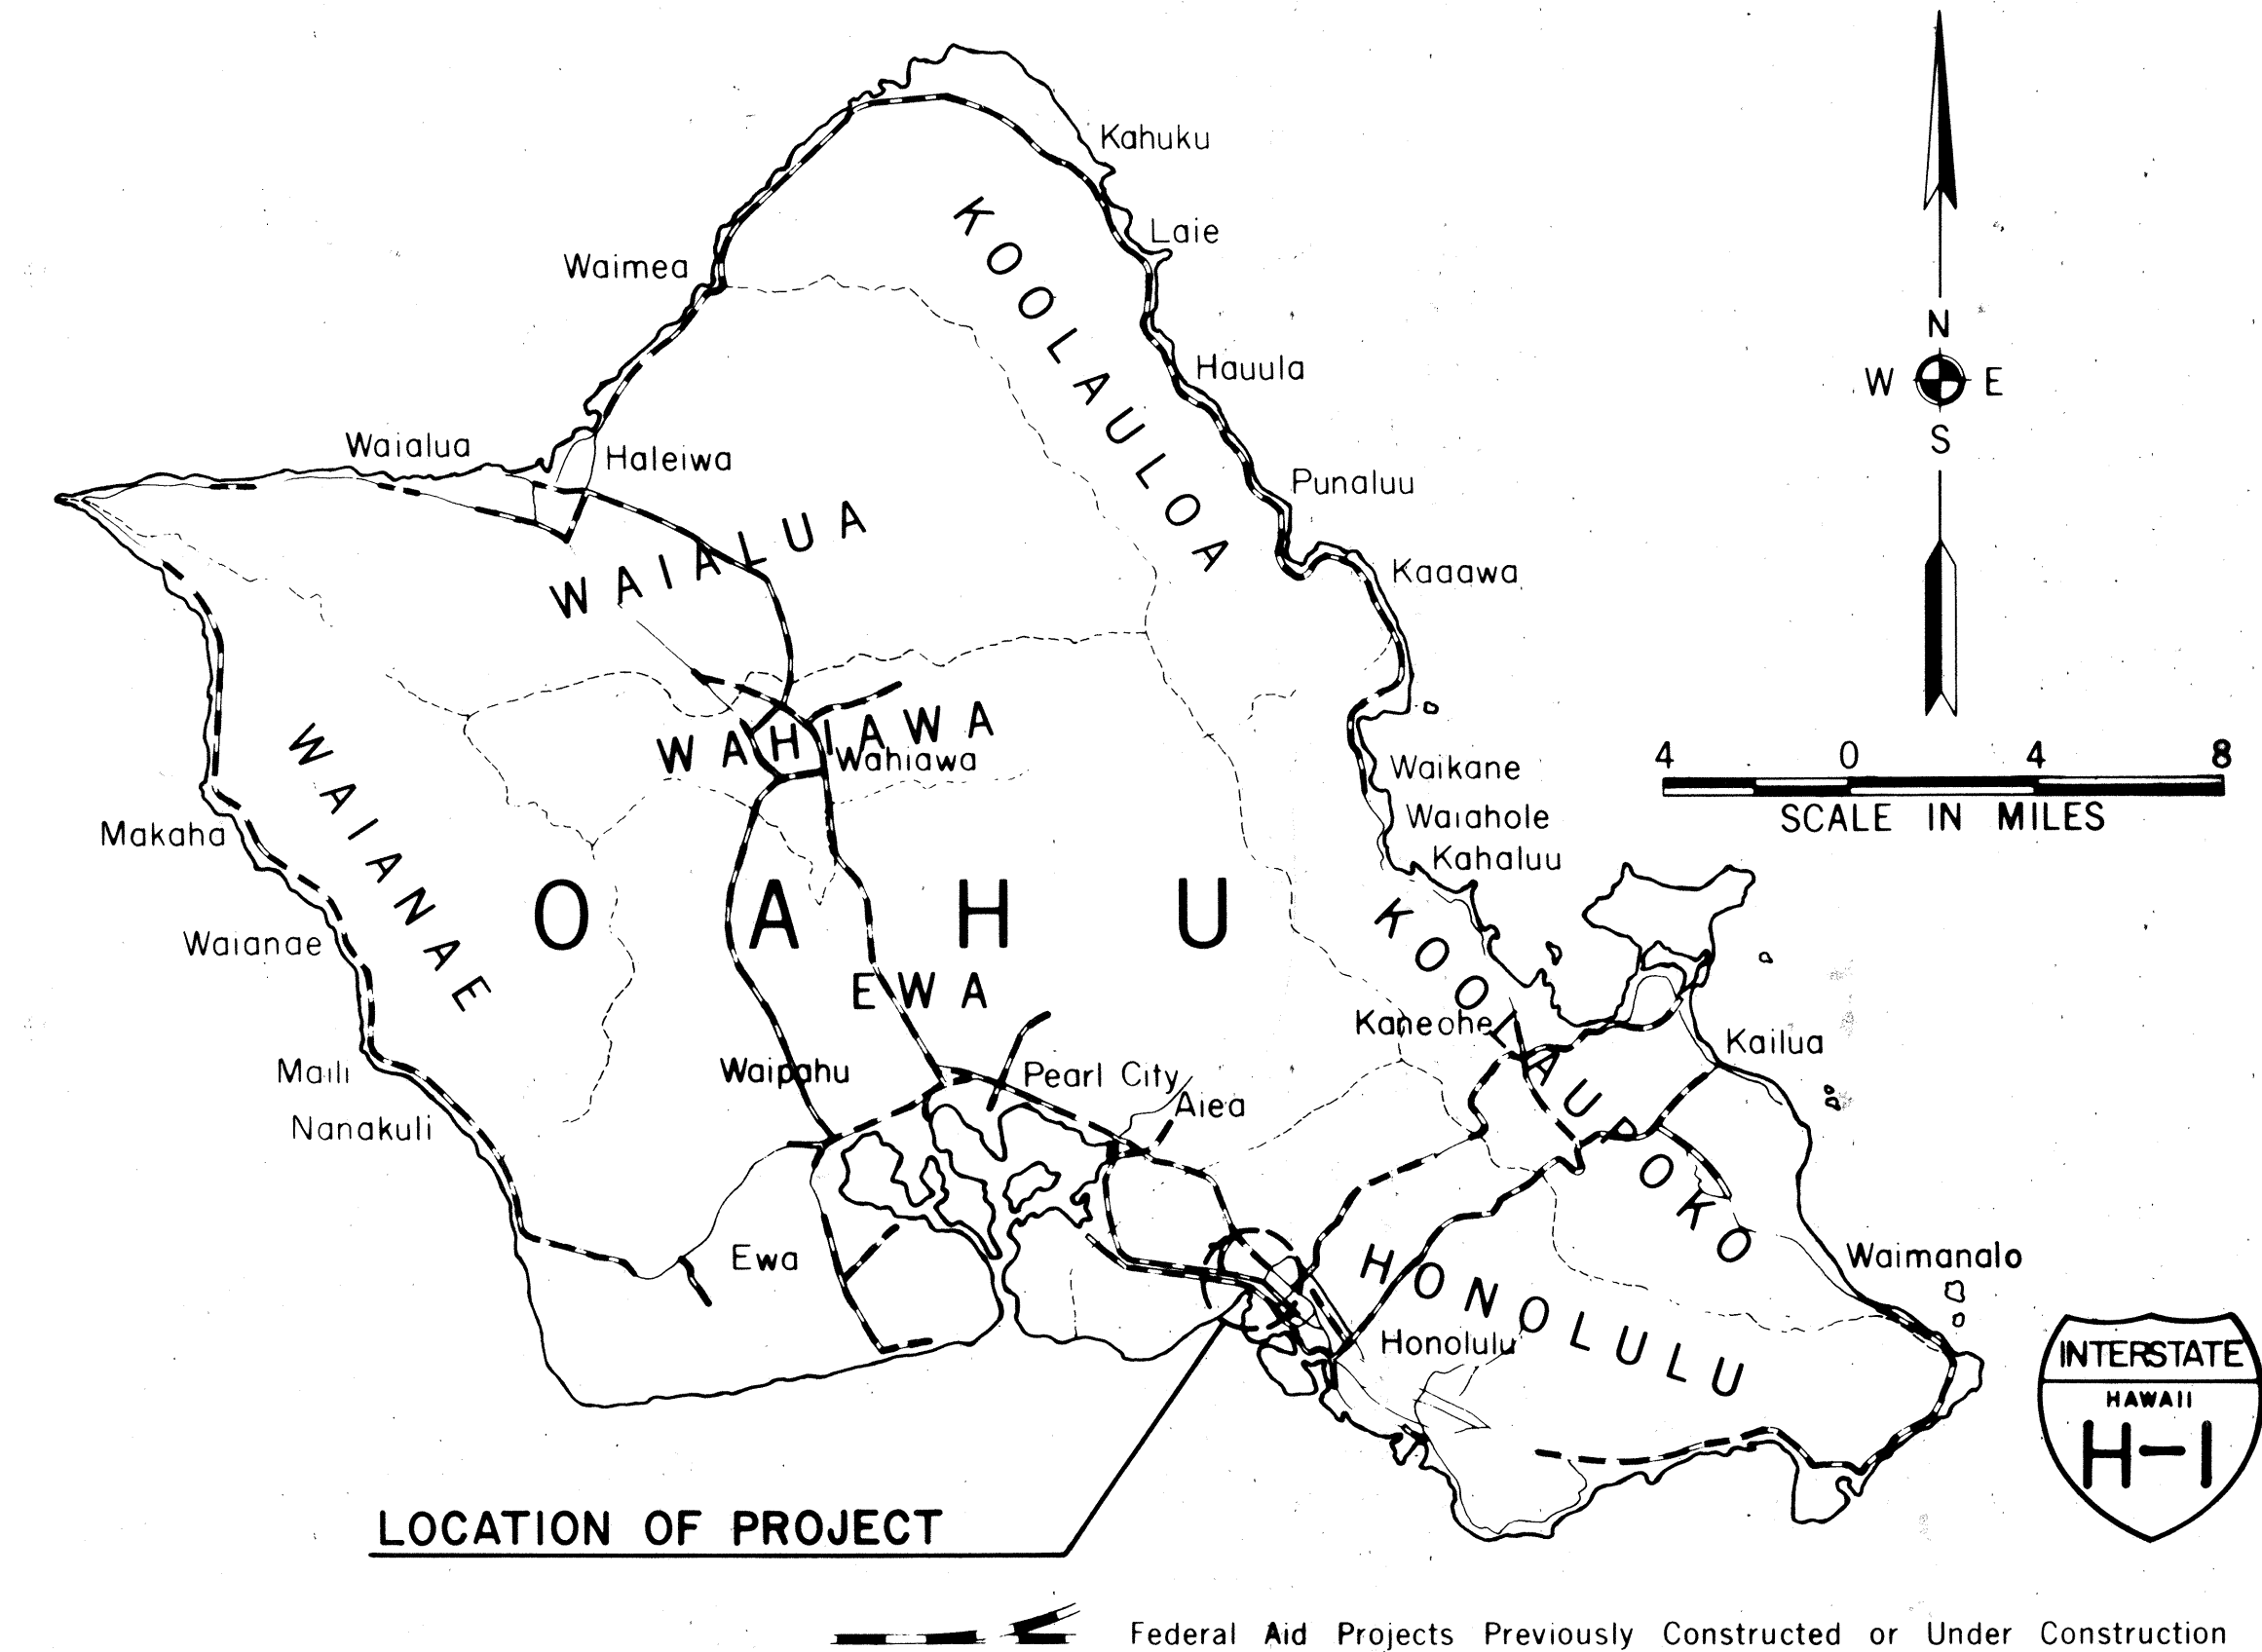

DESIGN CLASSIFICATION

DESIGN ADT (1994).....98,000
 DHV.....10,800
 D.....60/40
 T.....5%
 V.....60 MPH

CHANGES MADE DURING CONSTRUCTION HAVE BEEN INCORPORATED ON THESE PLANS EXCEPT CHANGES IN THE ORIGINAL THEORETICAL QUANTITIES. FOR ACTUAL QUANTITIES, REFER TO PROJECT LEDGER AND/OR COMPUTATION BOOK.

Resident Engineer Signature
 RESIDENT ENGINEER

Date
 DATE

DEPARTMENT OF TRANSPORTATION
 FEDERAL HIGHWAY ADMINISTRATION
 APPROVED:
Division Administrator Signature
 DIVISION ADMINISTRATOR

Date
 DATE

DEPARTMENT OF TRANSPORTATION
 STATE OF HAWAII
 APPROVED:
Director Signature
 DIR. OF TRANSPORTATION

Date
 DATE