


INDEX TO DRAWINGS	
SHEET NO.	DESCRIPTION
1	TITLE SHEET
2-4	TYPICAL SECTION
① 5-7	PLAN
8-9	DETAIL RDWY. PLAN & GENERAL NOTES
② 10	BARRIER WALL SECTION, PLAN & DETAILS
11	OPEN-GRADED PLANT MIX SEAL PLAN
12-19	TYPICAL & STANDARD ROADWAY DETAILS
③ 20-22	DRAINAGE DETAILS
④ 23-27	HIGHWAY LIGHTING PLAN & DETAILS
⑤ 28-32	SIGNING & PAV'T. MARKING PLAN & DETAIL
⑥ 33-36	TRAFFIC SIGNAL PLAN & DETAILS
37-64	TYPICAL & STANDARD DETAILS FOR PAV'T. MARKINGS, TRAFFIC SIGNALS AND BARRICADES


① ADD 7, ② ADD 10, ADD 10 S-1, ③ ADD 21,
 ④ ADD 23, C.O. ADD 23, ⑤ ADD 29, C.O. ADD 29,
 C.O. 30 ⑥ ADD 34, C.O. ADD 34, C.O. 35 & C.O. 36
 ARE SUPPLEMENT SHEETS TO THE CONTRACT PLANS.
 NEW TOTAL 65 SHEETS.

UNIT "B"
 DESIGNED BY
 R. TSUZUKI
 P. S. & E. BY
 548-2456
 PHONE
 MARCH 1983
 DATE

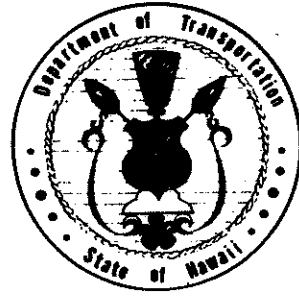

STATE OF HAWAII
 DEPARTMENT OF TRANSPORTATION
 HIGHWAYS DIVISION
 HONOLULU, HAWAII
 "AS BUILT"
 PLANS FOR
 INTERSTATE ROUTE H-1
 PEARL CITY OFF-RAMP IMPROVEMENTS
 FEDERAL AID INTERSTATE PROJECT NO. I-IR-HI-1(165):10

DISTRICT OF EWA
 ISLAND OF OAHU

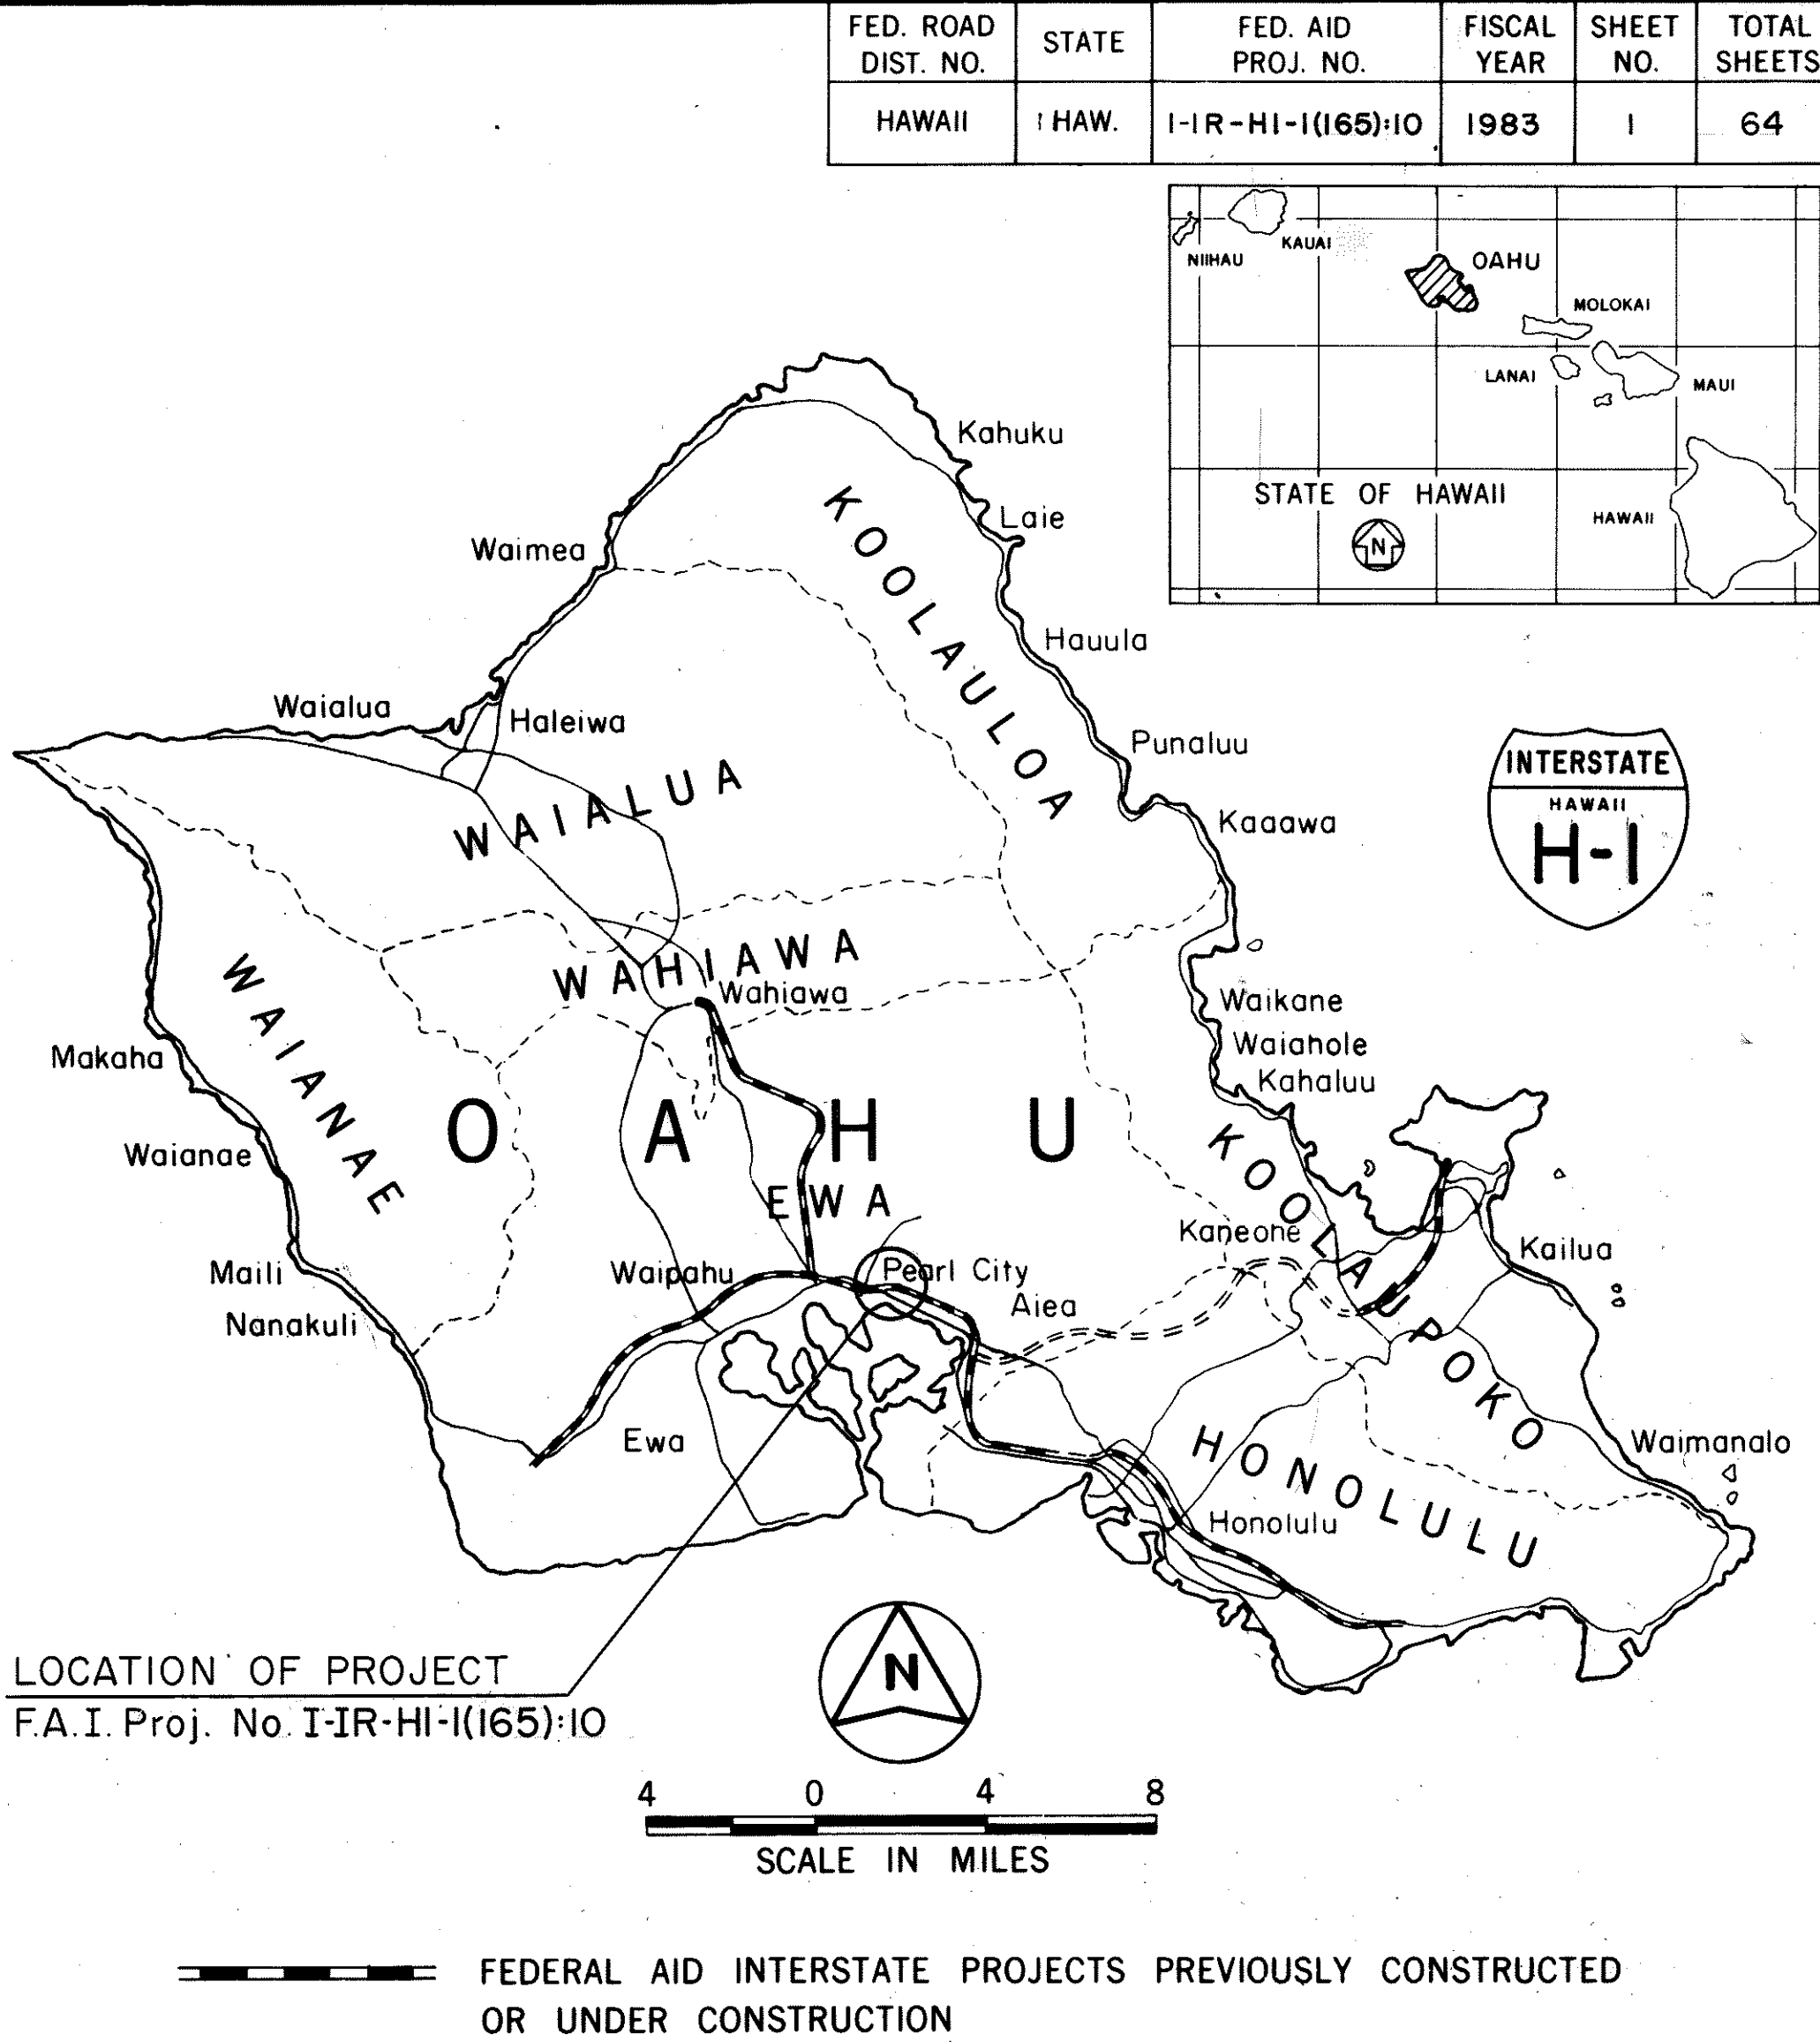

DESIGN DESIGNATION

CURRENT ADT (1983)	16,600
DESIGN ADT (2003)	21,500
DHV	2,900
K	13.5%
T	2.0%
T ₂₄	4.5%

GROSS LENGTH OF PROJECT... 0.905 MILES
 BRIDGES OVER 20 FEET SPAN... 0.000 MILES
 NET LENGTH OF ROADWAYS... 0.905 MILES

CHANGES MADE DURING CONSTRUCTION HAVE BEEN INCORPORATED ON THESE PLANS EXCEPT CHANGES IN THE ORIGINAL THEORETICAL QUANTITIES.

Ronald M. Kan
 PROJECT ENGINEER

8/29/84
 DATE

DEPARTMENT OF TRANSPORTATION
 FEDERAL HIGHWAY ADMINISTRATION
 APPROVED:
 [Signature]
 DIVISION ADMINISTRATOR
 3/28/83
 DATE

DEPARTMENT OF TRANSPORTATION
 STATE OF HAWAII
 APPROVED:
 Ryohichi Higashimura
 DIR. OF TRANSPORTATION
 3/23/83
 DATE

