

INDEX TO DRAWINGS	
SHEET NO.	DESCRIPTION
1	TITLE SHEET
2	CONSTRUCTION PHASING
3	GENERAL PLAN
4	TYPICAL ROADWAY SECTIONS
5-6	SITE CONDITIONS
7-10	ROADWAY PLAN & PROFILES
11	ROADWAY DETAILS & SCHEDULES
12-13	STANDARD ROADWAY DETAILS
14-15	DRAINAGE & GRADING PLAN
16-21	DRAINAGE DETAILS
22	DRAINAGE SUMMARY
23-24	SIGNING & PAVEMENT MARKING PLAN
25-26	SIGN PANELS & SIGN FRAME LAYOUT
27	SIGNING DETAILS
28-29	DETOUR PLAN
30	DETOUR DETAILS & SIGNING SUMMARY
31-32	CONC. GUARDRAIL & CUSHION BARRIER
33-44	STANDARD SIGNING DETAILS
45	UTILITY RELOCATION NOTES
46	UTILITY RELOCATION PLAN & PROFILES
47-50	UTILITY RELOCATION DETAILS
51-52	ROADWAY LIGHTING PLAN
53-55	ROADWAY LIGHTING DETAILS
56-64	IRRIGATION PLAN & DETAILS
65-68	LANDSCAPING PLAN & DETAILS
69-70	CROSS SECTIONS
71-72	INDEX TO DRAWINGS - RAMP STRUCTURES
73	GENERAL NOTES, SYMBOLS AND ABBREVIATIONS
74	KEY TO DRAWINGS
75-115	PART I
116-168	PART II
169-189	STRUCTURAL DETAILS
190-191	SOIL BORING LOGS

STATE OF HAWAII

DEPARTMENT OF TRANSPORTATION
HIGHWAYS DIVISION

HONOLULU, HAWAII

"AS BUILT"

PLANS FOR

CONSTRUCTION OF A PORTION OF


INTERSTATE ROUTE H-1

AIRPORT INTERCHANGE

AOLELE STREET RAMPS EA/WA

FEDERAL AID INTERSTATE PROJECT I-HI-1(175)16

DISTRICT OF HONOLULU
ISLAND OF OAHU

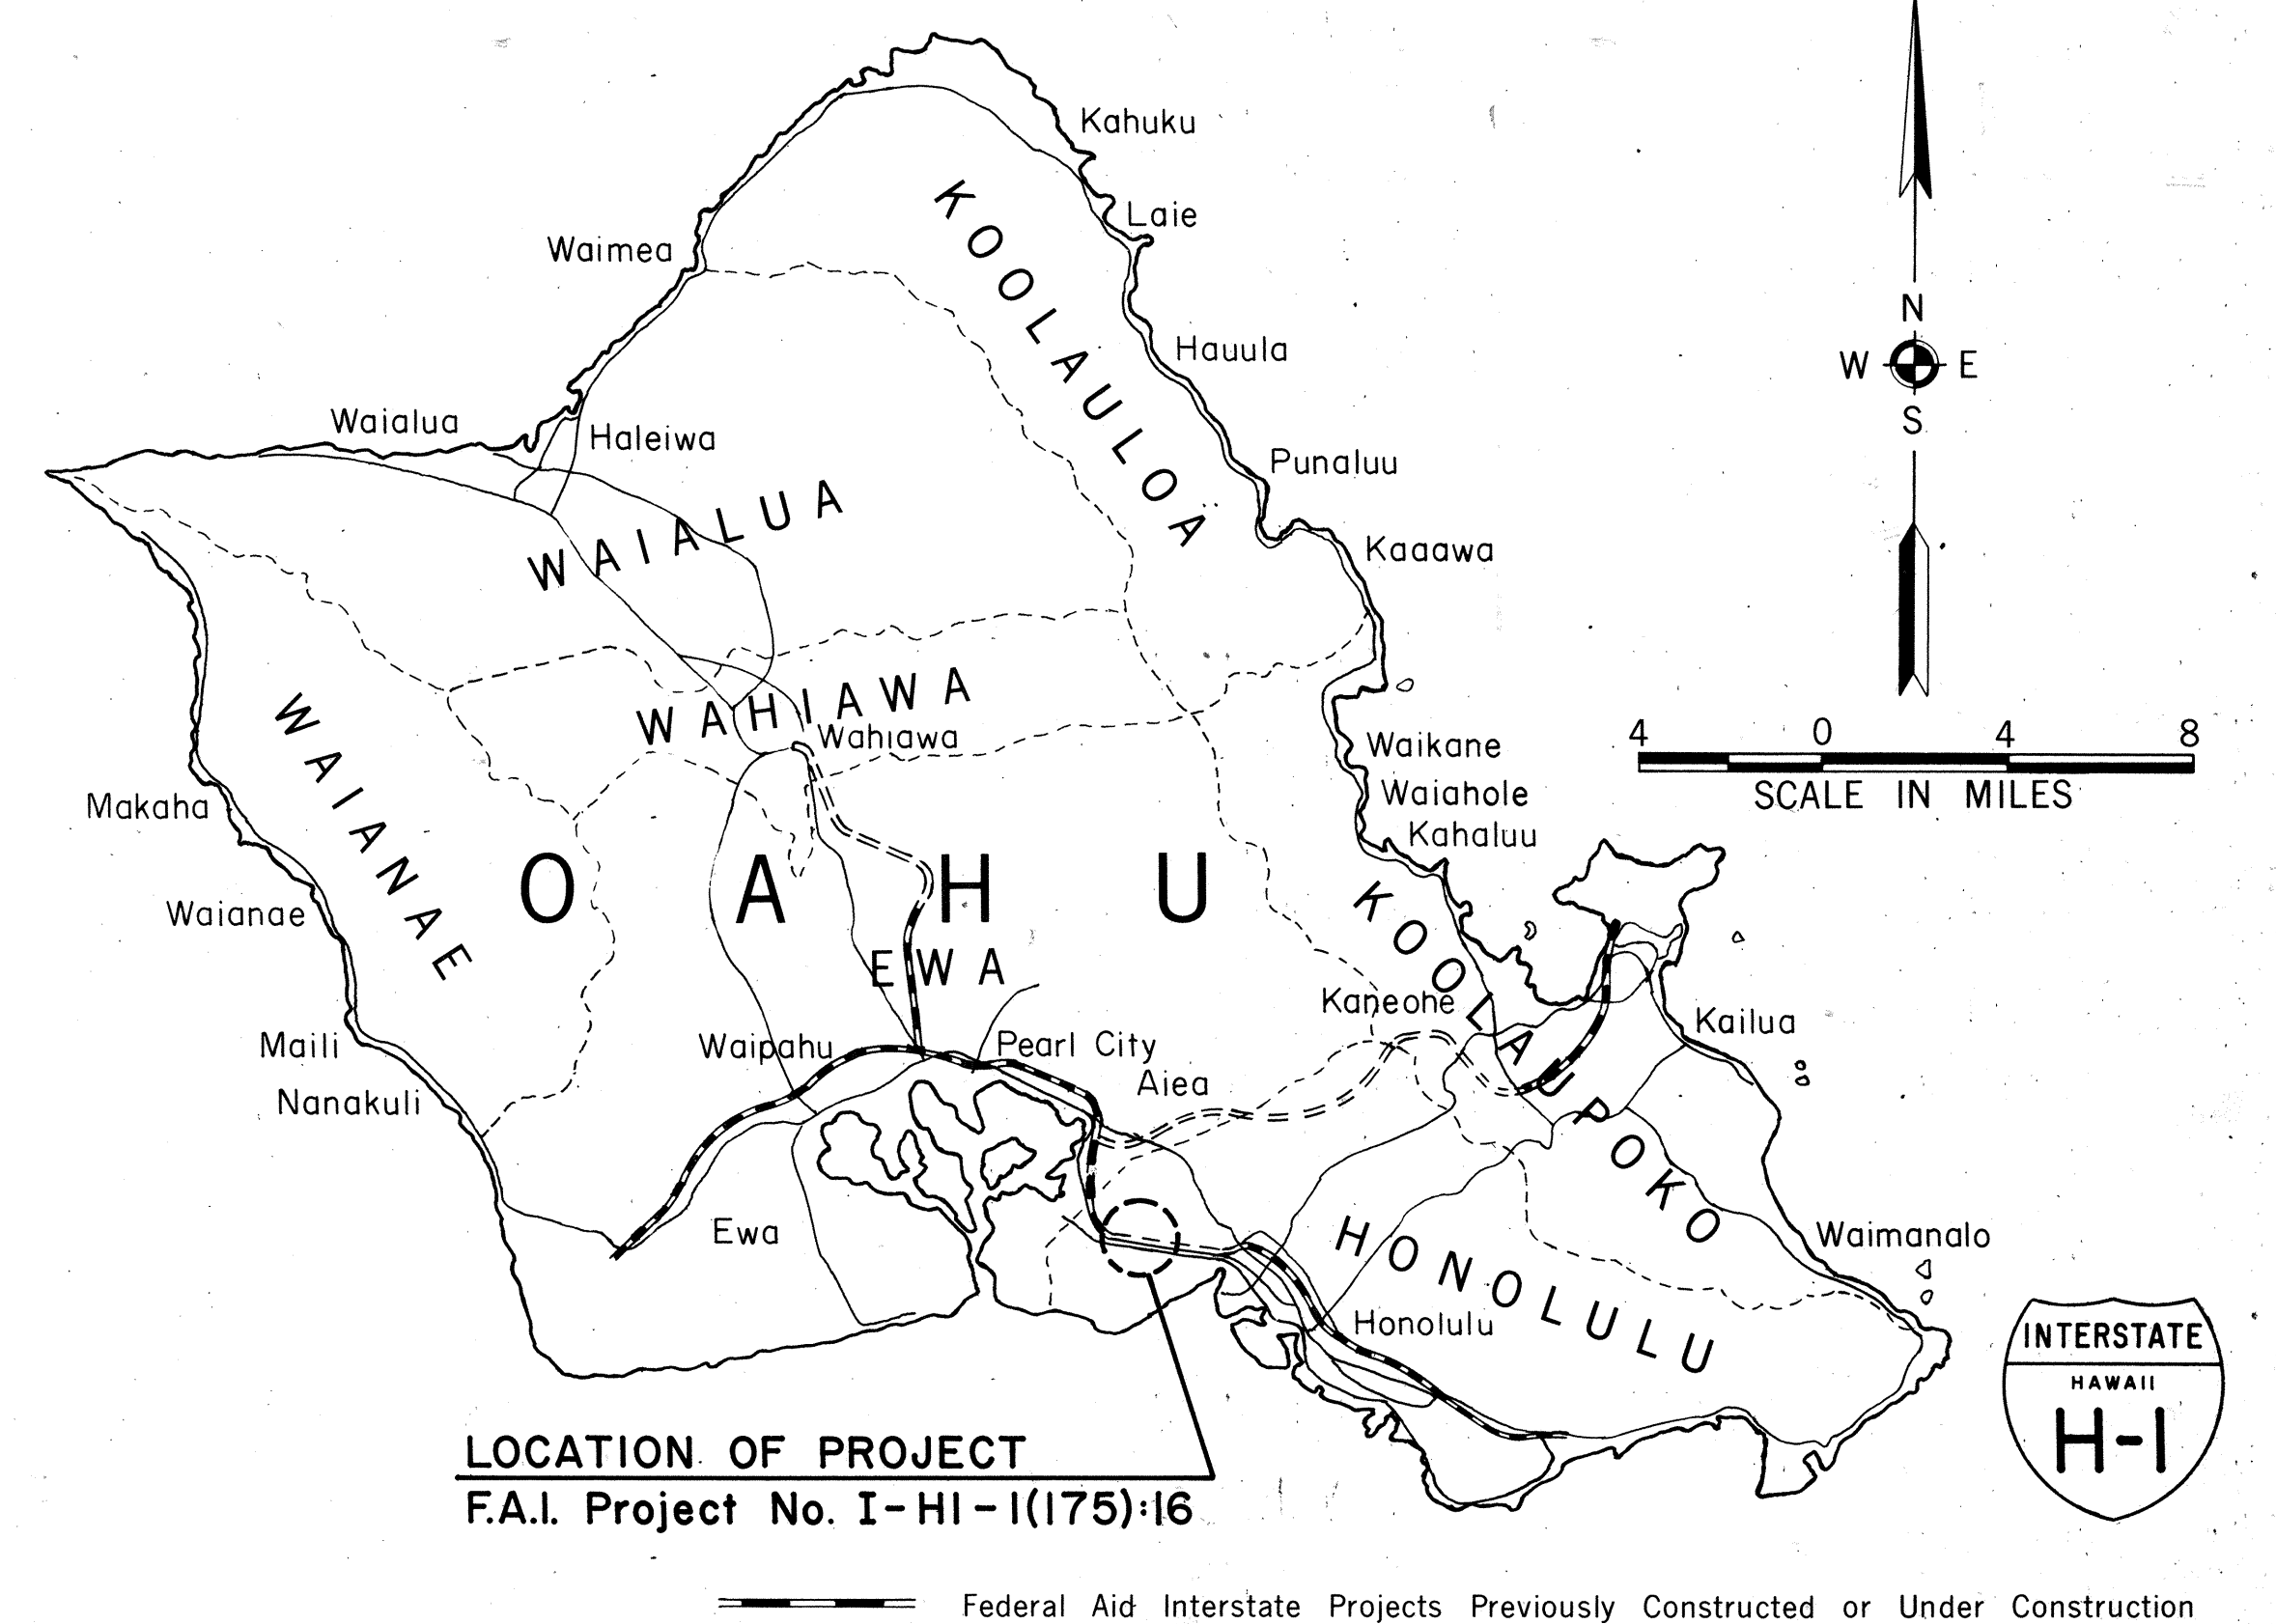


DESIGN CLASSIFICATION

DESIGN ADT (1994) 102,675
DHV 11%
D 60/40
T 5%
V 60 M.P.H.

SCALES:

PLANS HOR. 1" = 50'
PROFILES HOR. 1" = 50'
VER. 1" = 10'
DETAIL ROADWAY PLANS HOR. 1" = 20'
CROSS SECTIONS HOR. 1" = 10'
VER. 1" = 5'

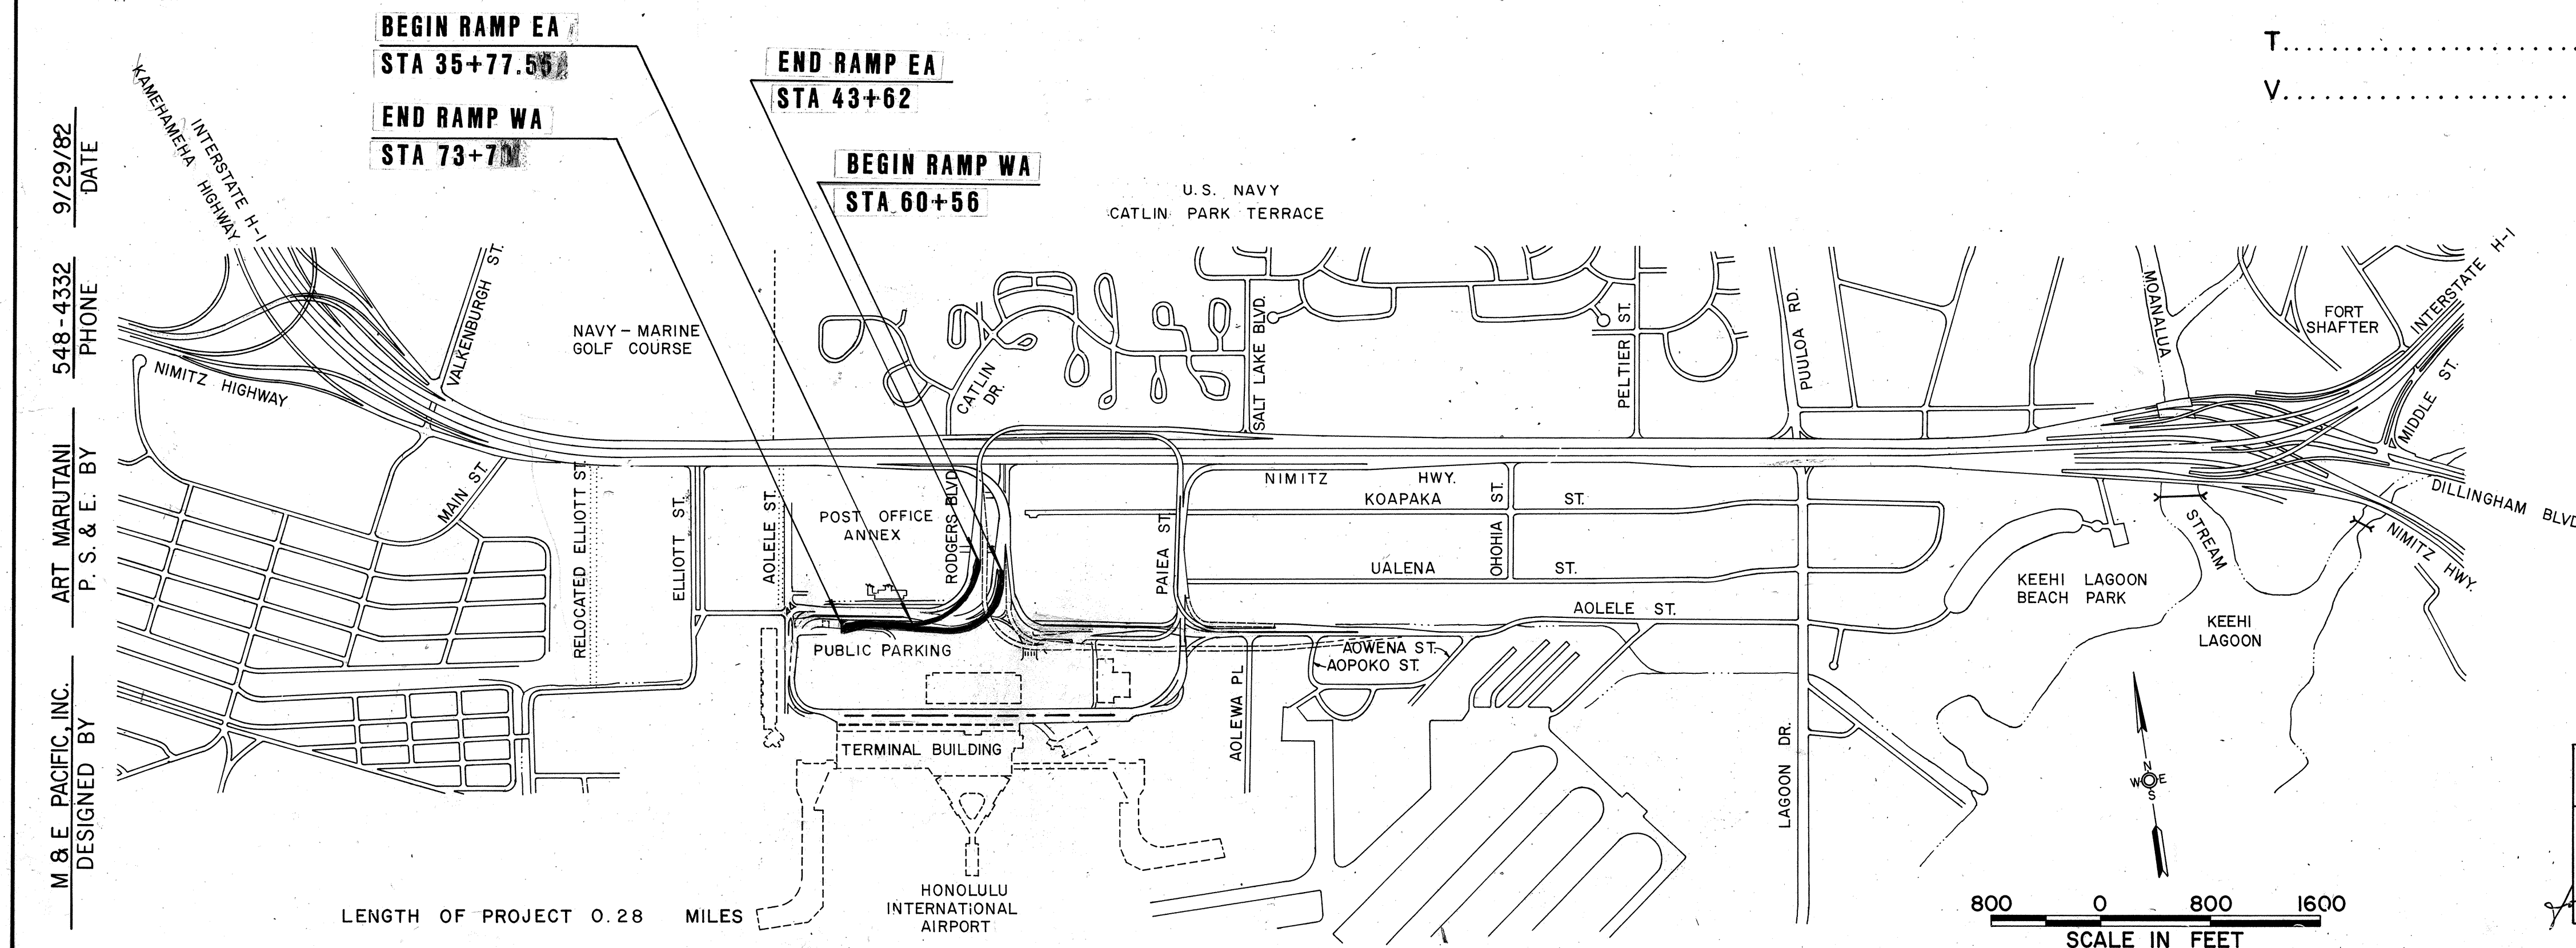

CHANGES MADE DURING CONSTRUCTION HAVE BEEN INCORPORATED ON THESE PLANS EXCEPT CHANGES IN THE ORIGINAL THEORETICAL QUANTITIES. FOR ACTUAL QUANTITIES, REFER TO PROJECT LEDGER AND/OR COMPUTATION BOOK.

Michael D. Dwyer 7/6/88
RESIDENT ENGINEER DATE

DEPARTMENT OF TRANSPORTATION
FEDERAL HIGHWAY ADMINISTRATION

APPROVED: *[Signature]* 9/28/82
DIVISION ENGINEER DATE

DEPARTMENT OF TRANSPORTATION
STATE OF HAWAII

APPROVED: *Ryohichi Higashimura* 9/28/82
DIR. OF TRANSPORTATION DATE