
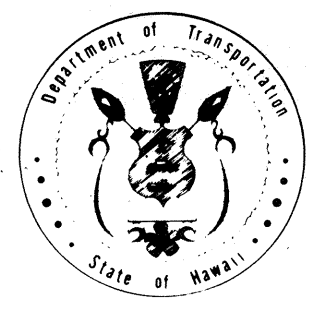




INDEX TO DRAWINGS	
SHEET NO.	DESCRIPTION
1	TITLE SHEET
2	CONSTRUCTION PHASING
3-5	ALIGNMENT PLANS
6	RAMP TERMINAL DETAIL
7-10	ROADWAY PROFILES & SUPERELEVATION DIAGRAMS
11-19	DRAINAGE AND GRADING PLANS & DETAILS
20	EROSION CONTROL NOTES & DETAILS
21-27	MISCELLANEOUS DETAILS
28-35	SIGNING AND PAVEMENT MARKING PLANS & DETAILS
36-42	OVERHEAD SIGN STRUCTURES
43-45, 45A, 45B, 46-56	SIGNING AND PAVEMENT MARKING STANDARD DETAILS
57-64	HIGHWAY LIGHTING PLANS & DETAILS
65-67	UTILITY PLANS
68-81	BORING LOCATION PLAN & LOGS
82-171	H-1 (EB) VIADUCT AND MAKAI FRONTAGE ROAD STRUCTURE
172-188	STRUCTURAL STANDARD DETAILS
189	CROSS SECTIONS
190	AIRPORT I/C PORTION: SIGNING & PAVEMENT MARKINGS

① C.O. 65-1, ② ADD 52 S-1,
③ 76 S-1, ④ 191, 192 ARE
SUPPLEMENT SHEETS TO
THE CONTRACT PLANS
TOTAL = 197 SHEETS

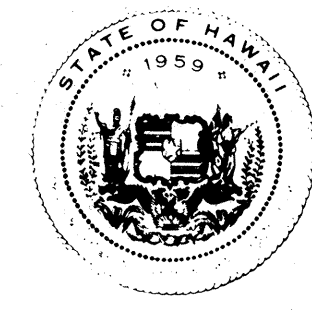

STATE OF HAWAII
DEPARTMENT OF TRANSPORTATION
HIGHWAYS DIVISION
HONOLULU, HAWAII
"AS-BUILT"
PLANS FOR
CONSTRUCTION OF A PORTION OF
INTERSTATE ROUTE H-1
KEEHI INTERCHANGE
AHUA STREET TO MOANALUA STREAM
FEDERAL AID INTERSTATE PROJECT NO. I-HI-1 (I32): 17

DISTRICT OF HONOLULU
ISLAND OF OAHU

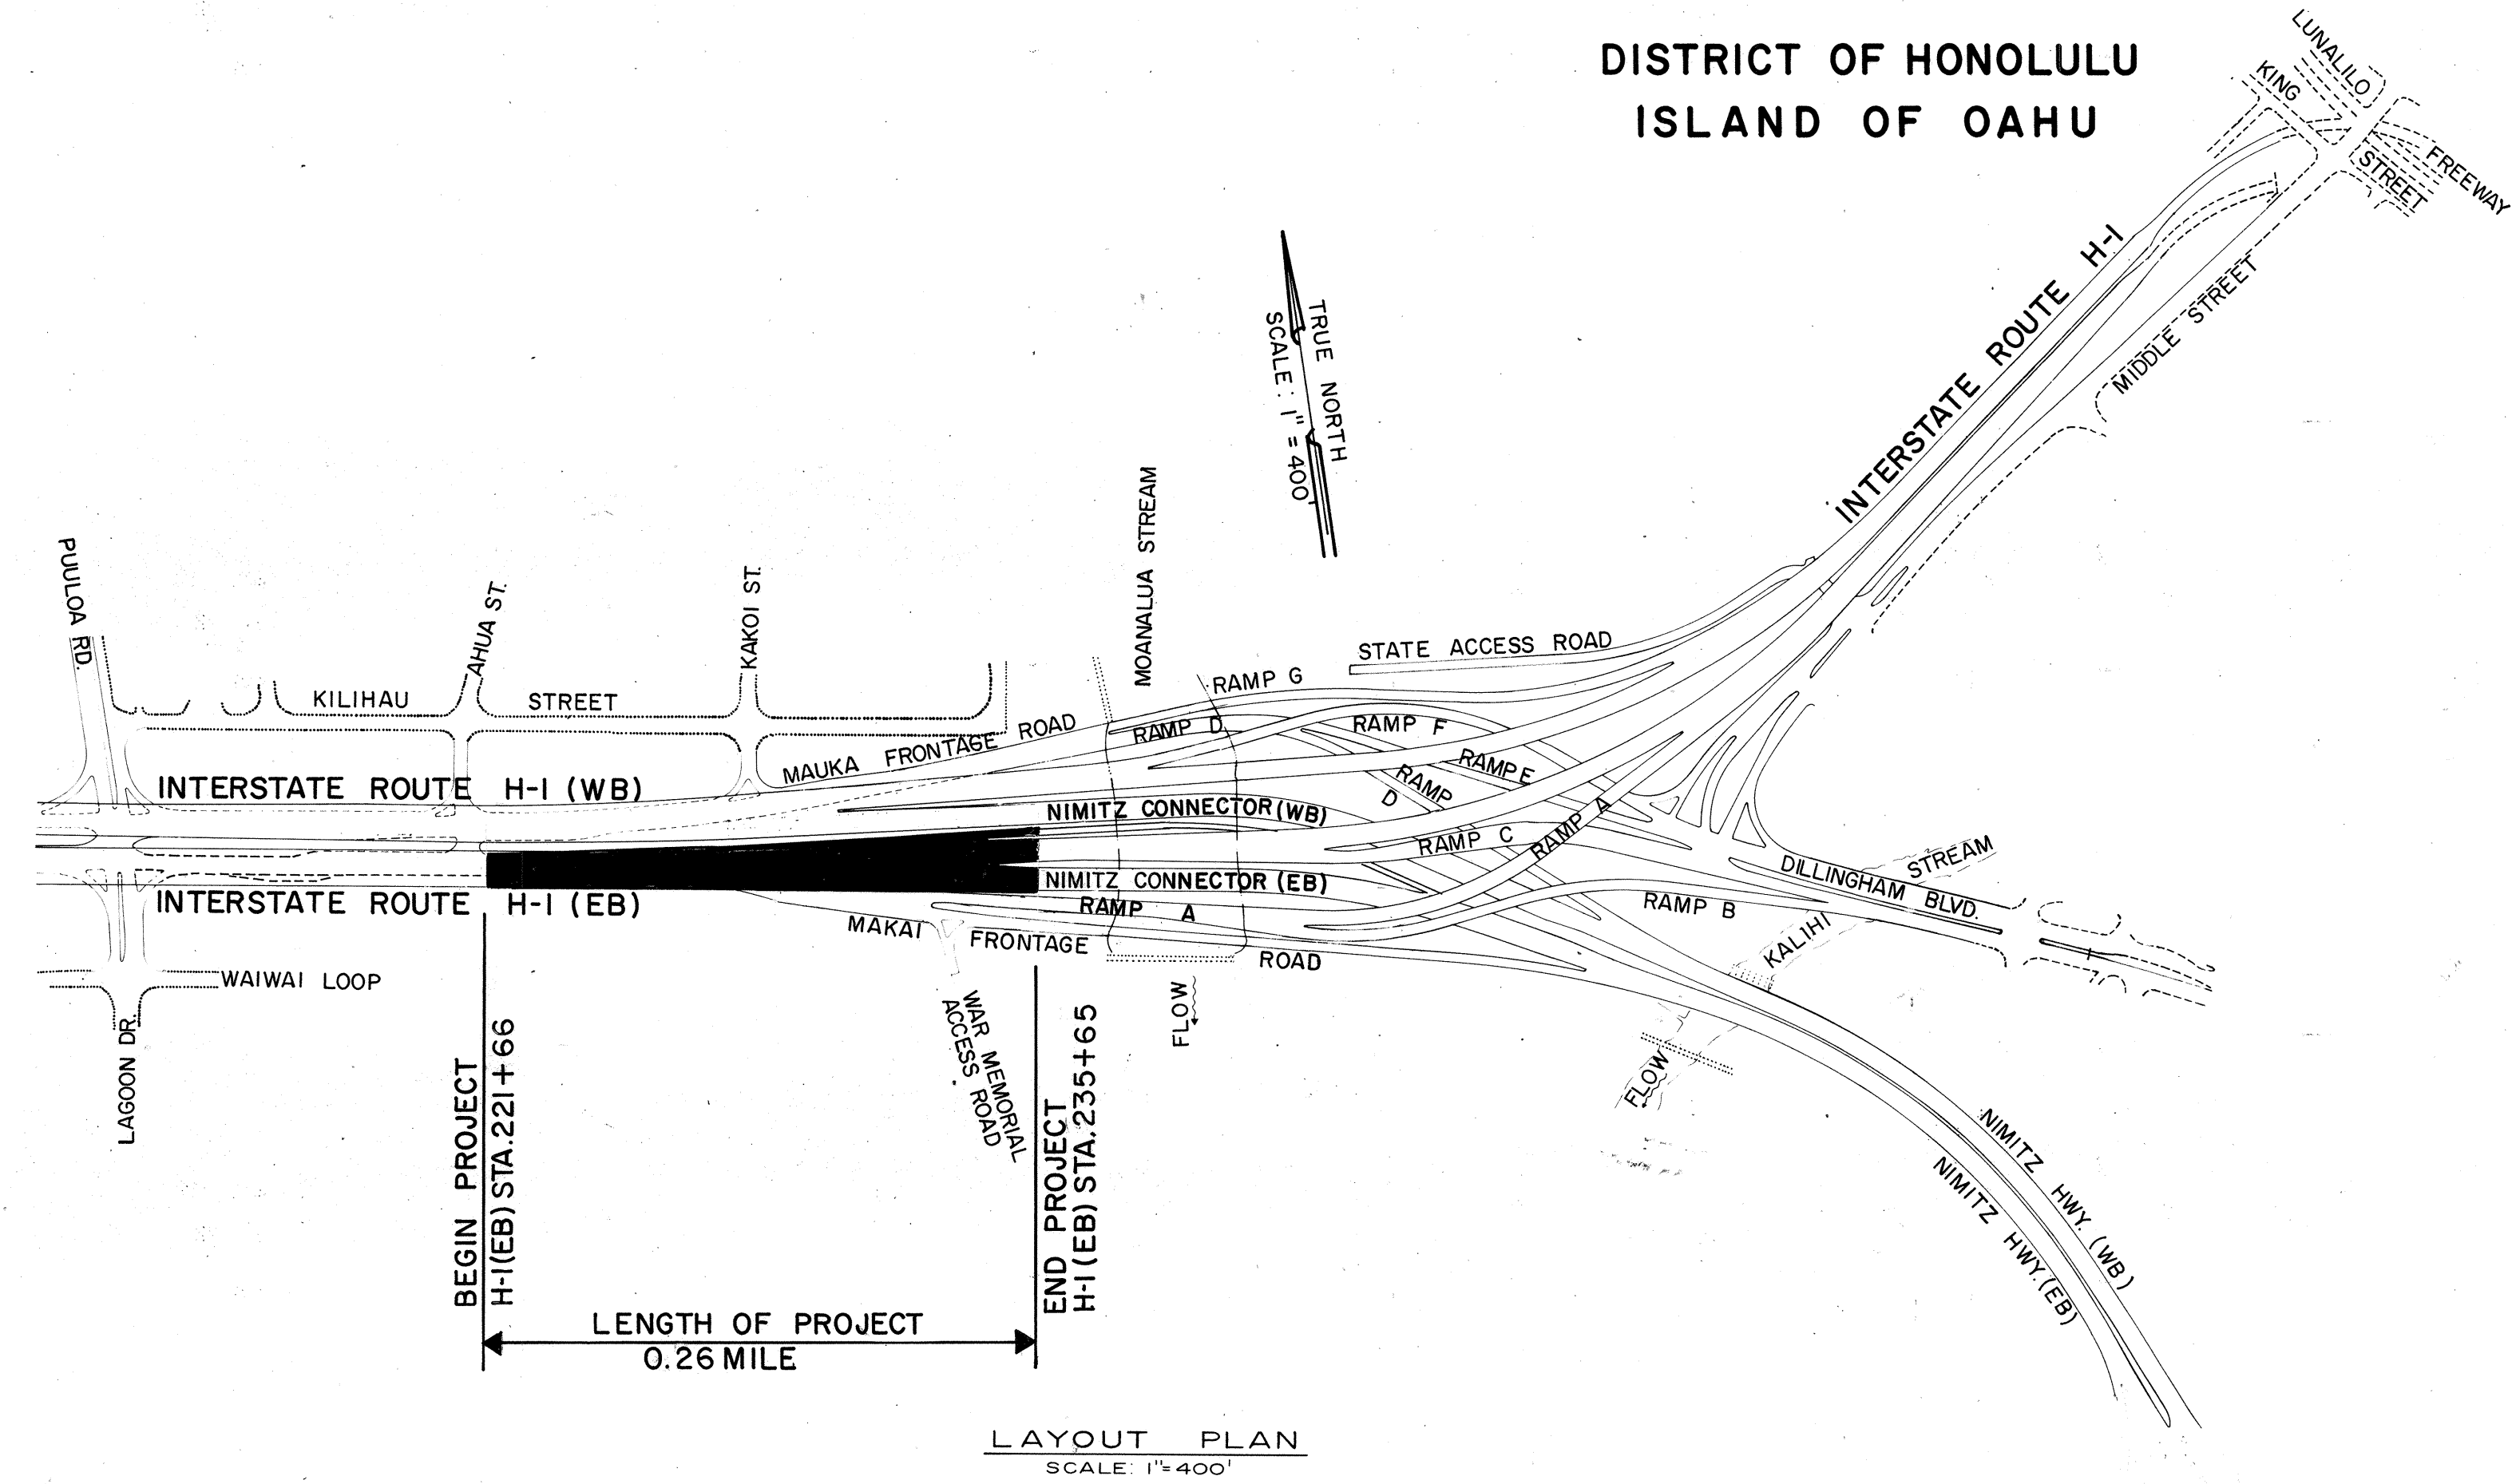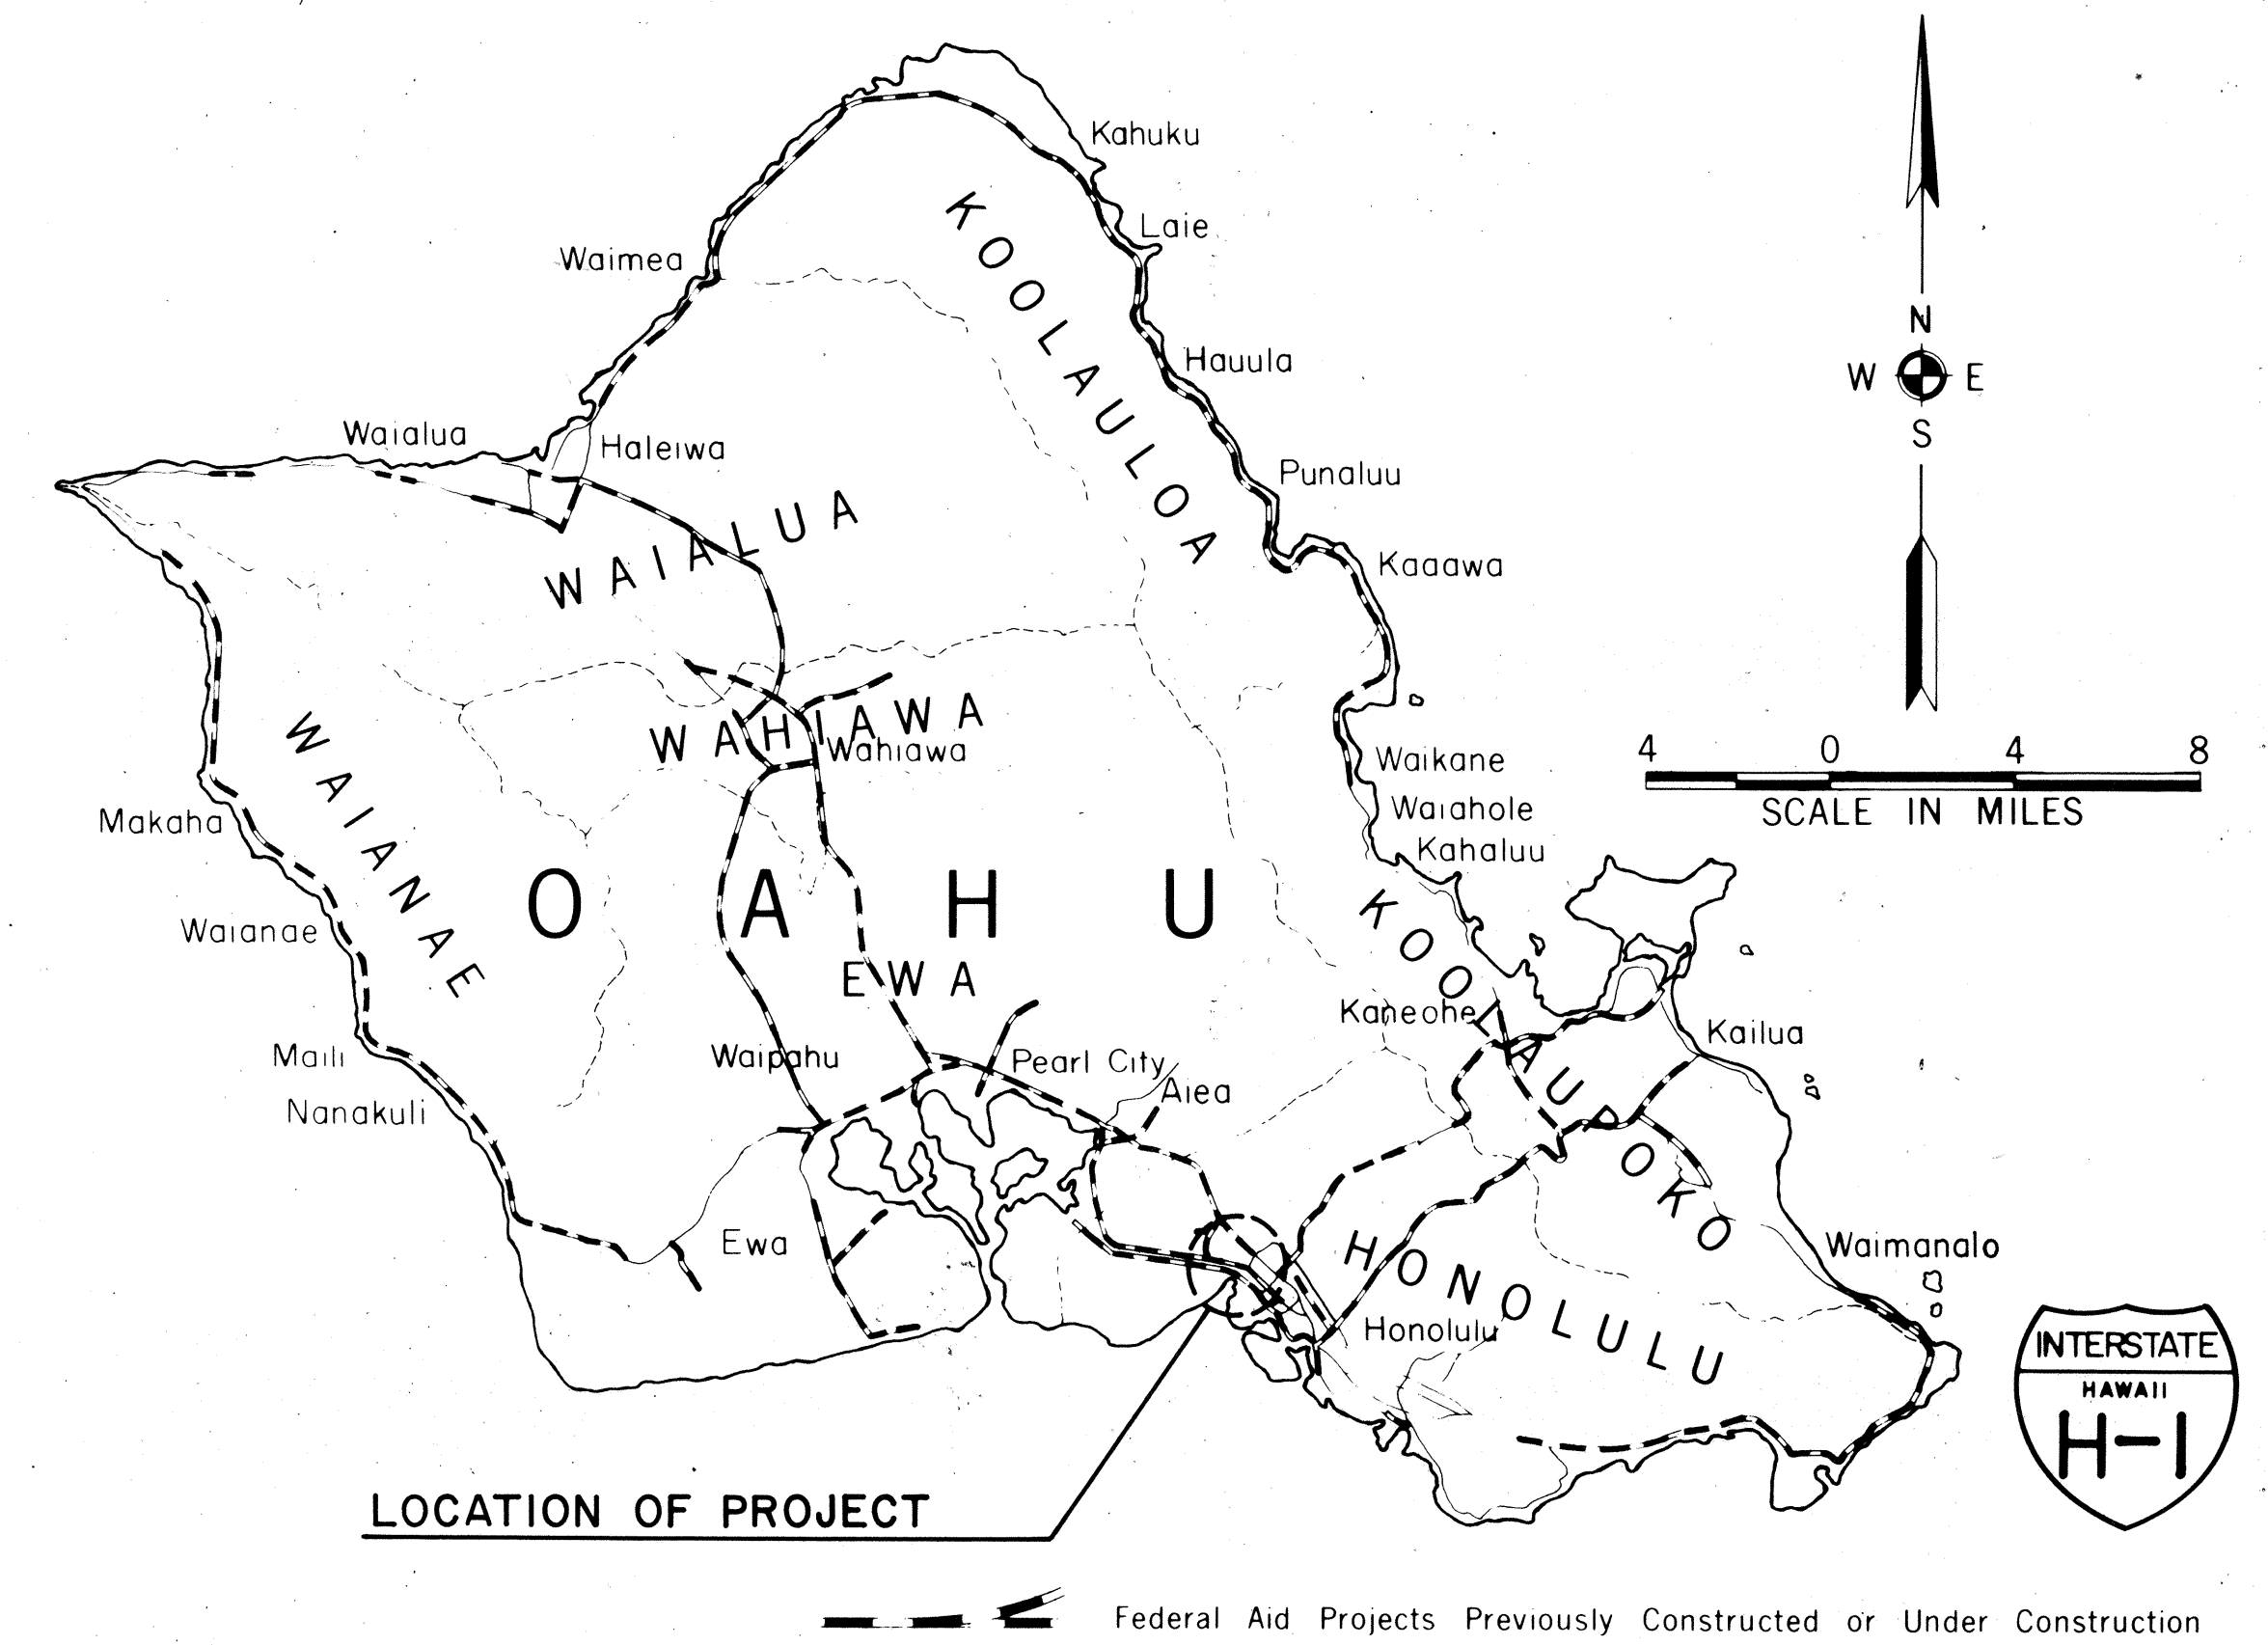

DESIGN CLASSIFICATION

DESIGN ADT (1994).....98,000
DHV.....10,800
D.....60/40
T.....5 %
V.....60 MPH

CHANGES MADE DURING CONSTRUCTION HAVE BEEN INCORPORATED ON THESE PLANS EXCEPT CHANGES IN THE ORIGINAL THEORETICAL QUANTITIES. FOR ACTUAL QUANTITIES, REFER TO PROJECT LEDGER AND/OR COMPUTATION BOOK.

[Signature] 10/20/83
RESIDENT ENGINEER DATE

DD-C-3-7
PAUL WOLF 521-3051 11-16-81
P S & E BY DATE
DESIGNED BY
PARSONS BRINCKERHOFF-HIROTA ASSOCIATES

DEPARTMENT OF TRANSPORTATION
FEDERAL HIGHWAY ADMINISTRATION
APPROVED:
[Signature] 5/26/83
DIVISION ADMINISTRATOR DATE

DEPARTMENT OF TRANSPORTATION
STATE OF HAWAII
APPROVED:
[Signature] May 9, 83
DIR. OF TRANSPORTATION DATE